



Utility Installation Request

To the Commissioner's Court of Walker County

Date 09/02/2025

Application is hereby made by Guadalupe Tobon-Horner

to place FIBER OPTIC CABLE

and/or perform the following described work _____ within the Right of Way of that Walker County road known as DARRELL WHITE RD at the following approximate coordinates (lat/long) N 30.677026, W -95.570450

The exact location and extent of the proposed work shall be as shown on the attached specifications and drawings.

We will construct and maintain the line on the road right of way as shown on the attached drawing and in accordance with the rules, regulations and policies of Walker County, the Texas Department of Transportation (TXDOT), and all governing laws, including, but not limited to, the "Texas Engineering Practice Act," "Federal Clean Water Act," the "National Endangered Species Act," "Americans with Disabilities Act," and the "Federal Historic Preservation Act." Upon request by Walker County, we will submit to Walker County proof of compliance with all governing laws, rules and regulations before commencement of construction. Plans shall include the design, proposed location, vertical elevations, and horizontal alignments of the facility based on the department's survey datum, the relationship to existing highway facilities and the right of way line, traffic safety and access procedures, and location of existing utilities that may be affected by the proposed utility facility. The location and description of the proposed line and appurtenances is more fully shown by a complete set of drawings attached to this Utility Installation Request. We will give plans to Walker County for each future proposed modification or expansion to our facility and all Walker County to review and approve submittals prior to commencement of the work.

A new request may be required as a condition of approval.

Our organization will use Best Management Practices to minimize erosion and sedimentation resulting from the proposed installation, and we will re-vegetate the project area as indicated under "Re-vegetation Special Provisions."

Our organization will ensure that traffic control measures complying with applicable portions of the *Texas Manual on Uniform Traffic Control Devices* will be installed and maintained for the duration of this installation.

When installing our utility on controlled access facilities, we shall conform to the Texas Transportation Code, Title 6 Roadways, Chapter 203, Subchapter C, Control of Access, §203.031. We shall limit access for servicing this installation to access via (a) frontage roads where provided, (b) nearby or adjacent public roads or streets, (c) trails along or near the highway right of way lines, connecting only to an intersecting road; from any one or all of which entry may be made to the outer portion of the highway right of way for normal service and maintenance operations. Our rights of access to the through traffic roadways and ramps shall be subject to the same rules and regulations that apply to the general public.

It is expressly understood that Walker County does not purport, hereby, to grant any right, claim, title or easement in or upon this road; and it is further understood that Walker County may require us to relocate this line and any associated infrastructure, at the total expense of the applicant/utility owner, by giving thirty (30) days written notice prior to the date that the relocation shall be completed. We understand that a new Request will be required for the relocation.

We will notify Walker County prior to commencement of any routine or periodic maintenance which requires pruning of trees within the highway right of way, so that Walker County may provide specifications for the extent and methods to govern in, but not limited to, trimming, topping, tree balance, type of cuts, painting cuts and clean up.

Our installation shall not damage any part of the roadway structure or associated appurtenances and we will make adequate provisions to minimize inconveniences to the traveling public, and adjacent property owners. In the event we fail to comply with any or all of the requirements as set forth herein, the County may take such action as it deems appropriate to compel our compliance.

SEP 02 2025
NY

Following approval, we will begin construction on or after 11/03/2025 (month/day/yr)

Additional Provisions and Requirements (for TxDOT input only)

General Special Provisions:

- ☒ Are attached.
☐ Are not attached

As-built Plans/Certifications of Construction:

- ☐ Are required and shall be certified as accurate by an authorized representative of the company.
☒ Are required and shall be signed and sealed by a State of Texas Licensed Professional Engineer.
☒ Certification that utility was installed as approved
☐ Are not required

Re-vegetation Special Provisions: In order to minimize erosion and sedimentation resulting from the proposed installation, the project area will be re-vegetated:

- ☒ In accordance with TxDOT's Standard Specification Item 164 which specifies the appropriate grass seed mix to be used, or:
☐ As indicated on the attachment.

The Precinct Commissioner or his/her representative is to be notified 48 hours prior to beginning construction.

If approved, we understand that we will assume all risks associated with this installation within the Walker County right of way. These risks include, but are not limited to, injuries to our workers, damage to contiguous utility lines that may be in the area, injuries or damage resulting from our failure to properly install and maintain the line as shown on plans.

We understand Walker County may place additional provisions and requirements as listed above, based upon, but not limited to, the type of utility being installed, local site conditions, soil types and traffic.

We acknowledge that this Utility Installation Request approval **expires** on the **91st** calendar day from the date of issuance, unless otherwise approved, if we do not begin our installation by this date. If we do not begin our installation within this time frame and still wish to continue, we will resubmit our request in accordance with the prevailing governing laws, rules, regulations and policies at the time of resubmission.

By signing as/for the requestor below, I certify that I am authorized to represent the requestor, that I agree to the provisions and requirements included in this Utility Installation Request, and our commencement of construction will further attest to our review and acceptance of said additional provisions and requirements

Requestor:

Approved By:

Date: 09/02/2025

Date: _____

By: Guadalupe Tobon-Horner

By: _____

Signature: Guadalupe Tobon-Horner

Signature: _____

Title: Permit Coordinator


Title: _____

Address: 36502 HEMPSTEAD RD.,
HOCKLEY, TX. 77447

Address: _____

Telephone: 346-471-2612

Telephone: _____

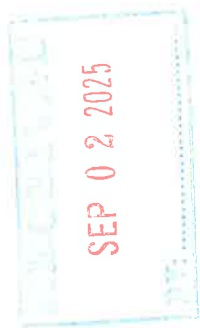

**General Special Provisions
Walker County Utility Installation Request**

1. Effective Period of Permit Approval. All approvals are void if installation does not begin within 3 months from the date of approval.
2. ALL UTILITY INSTALLATIONS SHALL CONFORM WITH THE STANDARDS DESCRIBED IN TITLE 43, PART 1, CHAPTER 21, SUBCHAPTER C, OF THE TEXAS ADMINISTRATIVE CODE (UTILITY ACCOMODATIONS)
3. A FINAL AS-BUILT SET OF PLANS SHALL BE SUBMITTED AND CERTIFIED BY A PROFESSIONAL ENGINEER, INCLUDING A CERTIFICATION THAT THE INSTALLATION WAS COMPLETED IN CONFORMANCE AND COMPLIANCE WITH THE ABOVE DESCRIBED SECTIONS OF THE TEXAS ADMINISTRATIVE CODE AND TEXAS DEPARTMENT OF TRANSPORTATION MINIMUM SPECIFICATIONS. A statement must be included certifying that any pipe/casing installed is properly designed for the application and the installation meets the minimum standards for TxDOT and Title 43 of the Texas Administrative Code.
4. Minimum Depth of Cover. The minimum depth of cover for any underground utility line shall be as shown on the "Minimum Depth of Cover Table" for the TxDOT District or attached schematic whichever is deeper.
5. Locating Utilities. Applicant shall take all reasonable and necessary steps to locate existing utilities and address them in accordance with all state, local, and or federal requirements.
6. Aerial Electric Lines. Aerial electric power lines crossing over the highway shall be installed and maintained a minimum of twenty-two (22) feet above the surface of the traffic lanes. For electric power lines with greater than 50,000 volts, the clearance shall be increased in accordance with National Electric Safety Code as published in the National Bureau of Standards, Handbook 30.
7. Aerial Communication Lines. Aerial communication lines crossing over the highway shall be installed and maintained a minimum of eighteen (18) feet above the surface of the traffic lanes.
8. Open Trenching or Boring Operations for Utility Work. To insure that disturbed areas are restored and revegetated properly and in a reasonable period as the utility work progresses, the following requirements shall apply:

Unless otherwise approved or directed by Walker County, the length of "active utility work" shall not exceed one mile in length. "Active utility work" shall be defined as the total disturbed area measured from the beginning of open trenching to the point where backfill has been compacted, the right of way has been restored to its original line and grade, any structures damaged by the utility work have been repaired, erosion control measures have been placed and are being properly maintained, approved topsoil seed and compost has been placed uniformly, and watering for revegetation has begun. "Active utility work" also includes areas of bore pits and receiving pits; however, it does not include the underground boring length. When any area of "active utility work" is substantially complete (i.e., watering of seeded areas has begun), that area is no longer considered to be "active utility work", and "active utility work" can proceed further within the right of way as long as it does not exceed the above appropriate limits. Areas where Walker County determines that the "active utility work" is substantially complete does not mean that Walker County considers that area totally acceptable and complete.

9. Backfill, Erosion Control, and Re-vegetation. All excavations within the right-of-way (ROW) and not under pavement shall be backfilled by tamping in six (6) inch horizontal layers to the density of the surrounding soil or as directed by the Walker County. All surplus material shall be removed and the ROW shall be reshaped to



**General Special Provisions
Walker County Utility Installation Request**

its original condition or better. This work shall be done in accordance with Item 164 of the Texas Department of Transportation (TxDOT) "Standard Specifications for Construction and Maintenance of Highways, Streets, and Bridges." Erosion control measures such as soil retention blankets, rock berms, and silt fences shall be installed and maintained until permanent perennial vegetation is established over 70% of the disturbed area. The amount of revegetation is considered acceptable when it resembles the amount of existing vegetation in the surrounding undisturbed area. **If erosion control and/or storm water run-off requirements of other State, Federal, or Local Jurisdictions exceed these requirements then the more stringent requirements would prevail.**

8. Boring and Jacking. Boring and jacking of utility lines shall be provided as specified below.

- a. Under Paved County Roads. Utility lines to be constructed under an existing paved (asphalt pavement or concrete pavement) county road shall be installed by boring and jacking with casing.
- b. Under Paved Driveways. Utility lines to be constructed under existing paved (asphalt pavement or concrete pavement) driveways shall be installed by boring and jacking methods, unless the utility company furnishes Walker County with a "Letter of No Objection" signed by the driveway owner to allow open cutting of their driveway.
- c. Under Unpaved County Roads or Driveways. Utility lines to be constructed under an existing unpaved county road or under existing unpaved driveways may be open cut only when approved in advance by Walker County, and after the driveway owner is notified. Any open cuts should be repaired and restored to a minimum of pre-cut conditions as quickly as possible so as not to impact road and/or driveway traffic. Applicant shall take all necessary precautions to insure safety as site of open cut.
- d. Under Desirable Trees. To preserve the natural environment and protect wildlife habitat, boring may be required when underground utility lines are to be placed within the "protected root area" of "desirable trees" located within road ROW or on adjacent property. The "protected root area" is defined as the area between the tree trunk and five (5) feet from the tree trunk or 2/3 the actual distance from the tree trunk to the dripline, whichever is greater. "Desirable trees" include (but are not limited to) any tree with a trunk diameter of six (6) inches or more that Walker County or the Owner of the tree determines to be of environmental and aesthetic value. Boring under all "desirable trees" will be required with the following exceptions: (1) in areas where planned highway construction/maintenance work would require tree removal, or (2) when the Walker County approves of open trenching for the utility installation or removal of the tree.

9. Manhole Covers. All manhole covers shall be installed flush with the ground surface.

10. Traffic Control. Traffic control in utility work zones shall conform to applicable requirements of the "Texas Manual on Uniform Traffic Control Devices for Streets and Highways, Part VI". Adequate signs, barricades, flag personnel, etc. shall be erected and maintained in complete compliance with the Texas Manual on Uniform Traffic Control Devices. Any travel lane closures are only permitted after a traffic control plan is approved by Walker County prior to beginning any construction activities.

11. Sunday or Holiday Work. Sunday or Holiday work will not be permitted for the installation of any utility line unless directed or approved by Walker County.



**General Special Provisions
Walker County Utility Installation Request**

12. The approval of this utility installation request shall in no way be taken as a waiver or variance to any other existing local, state, or federal permits or requirements that may be required by the applicant.
13. Please note that Walker County will be making no verification through this process of the actual location of the public right of way as to width or location. The responsibility to locate the bounds of any public right of way that your project will utilize is the responsibility of your company. Walker County's approval of the request is not an agreement as to location of the public right of way, nor does it confer any easement, right of way, or property right for the project area.
14. Protection of Trees and Landscaping. Existing trees and landscaping within the ROW shall be protected as specified below. Removal of trees from the ROW will require prior Walker County approval.
- a. Tree Pruning. All tree pruning within the ROW will require prior TxDOT approval. All oak trees that are damaged or pruned shall be treated with an approved tree wound dressing within 20 minutes of causing the damage or making the pruning cut.
- b. Landscaping. When existing landscaping is located near the proposed utility alignment, the utility contractor shall notify Walker County and the owner of the landscaping prior to the proposed utility installation. Walker County may require underground utilities to be installed by: (1) boring under such landscaping or (2) by replacement of specific landscape items. Landscaping is defined as, but not limited to, trees, shrubs, grass, irrigation lines, landscape pavers, sidewalks, and other ROW improvements.





JB1767579 - 26 DARRELL WHITE RD, HUNTSVILLE, TX 77340/PRECINCT 2
COMCAST PROPOSES TO PLACE DIRECTIONAL BORE 976 FT TO INSTALL FIBER OPTIC CABLE
TO PROVIDE SERVICE TO 26 DARRELL WHITE RD, HUNTSVILLE, TX 77340,
INSIDE THE ROW OF THE WALKER COUNTY, TX.



NOT TO SCALE



ASPEN UTILITY IS RESPONSIBLE FOR PLACING THE CONDUIT IN
THE WALKER COUNTY ROW

ACCORDING TO MAP NO. 48471C0365D OF THE FEDERAL
EMERGENCY MANAGEMENT AGENCY'S FLOOD INSURANCE RATE
MAPS FOR WALKER COUNTY UNINCORPORATED AREAS, DATED
8/19/2011, THE SUBJECT TRACT IS SITUATED WITHIN: FLOOD
PLAIN ZONE X, UNSHADED

LEGEND

- PROPOSED BORE PIT
- EX. HAND HOLE
- EX. PEDESTAL
- PROPOSED PEDESTAL
- EX. CIRCULAR PEDESTAL
- PROPOSED CIRCULAR PEDESTAL
- EX. CATV VAULT
- PROPOSED CATV VAULT
- ANCHOR
- CATV TRENCH ROUTE
- WATER METER
- CATV BORE ROUTE
- STORM DRAINAGE
- WATER
- SEWER
- STORM SEWER
- CATV AERIAL ROUTE
- PRIVATE FENCE
- STORM DRAIN INLET
- CATCH BASIN
- STORM MANHOLE
- JOINT USE POLE
- EX. JOINT USE POLE
- JOINT USE POLE WITH TRANSFORMER
- BACK OF CURB
- EOP
- EDGE OF PAVEMENT
- DRIVEWAY
- RIGHT OF WAY
- AERIAL RISER

WORK AREA

VICINITY MAP
KEY MAP : 33M
LAMBERT : N/A
GIMS: N/A

DESCRIPTION	QUANTITY	UNIT
DIRECTIONAL BORE	976	FT
TRENCH	0	FT
OVERALL EXISTING CONDUIT	0	FT
BORE PITS	1	EA
NEW VAULTS	0	EA
EXISTING VAULTS	0	EA
EX. CIRCULAR PEDESTAL	0	EA
PROPOSED CIRCULAR PEDESTAL	2	EA
AERIAL RISER	0	FT
NEW STAND	0	FT
OVERLASH	0	FT
ANCHORS	0	EA
PROPOSED MANHOLES	0	EA
EXISTING MANHOLES	0	EA
EXISTING POLES	0	EA
EXISTING Poles (TYP)	0	EA
TOTAL PROJECT FOOTAGE	976	FT

SHEET INDEX

- COVER PAGE
- PLAN OVERVIEW
- 3-25. PLAN VIEWS (1-23)
26. GENERAL NOTES
- 27-28. TRAFFIC CONTROL PLAN

NO.	DATE	REVISION	APP.

Kenn P. Lacey, PE
The Aspen Utility Company, LLC
Suite No. 2300
2601 West Highway
Hockley, TX 77447
+1 (702) 693-5899




WALKER COUNTY
PUBLIC WORKS DEPARTMENT

FOR THE USE OF THE WALKER COUNTY
ENGINEERING DEPARTMENT

SHEET NO: 1 OF 28 DATE : 08/19/2025

SEP 02 2025

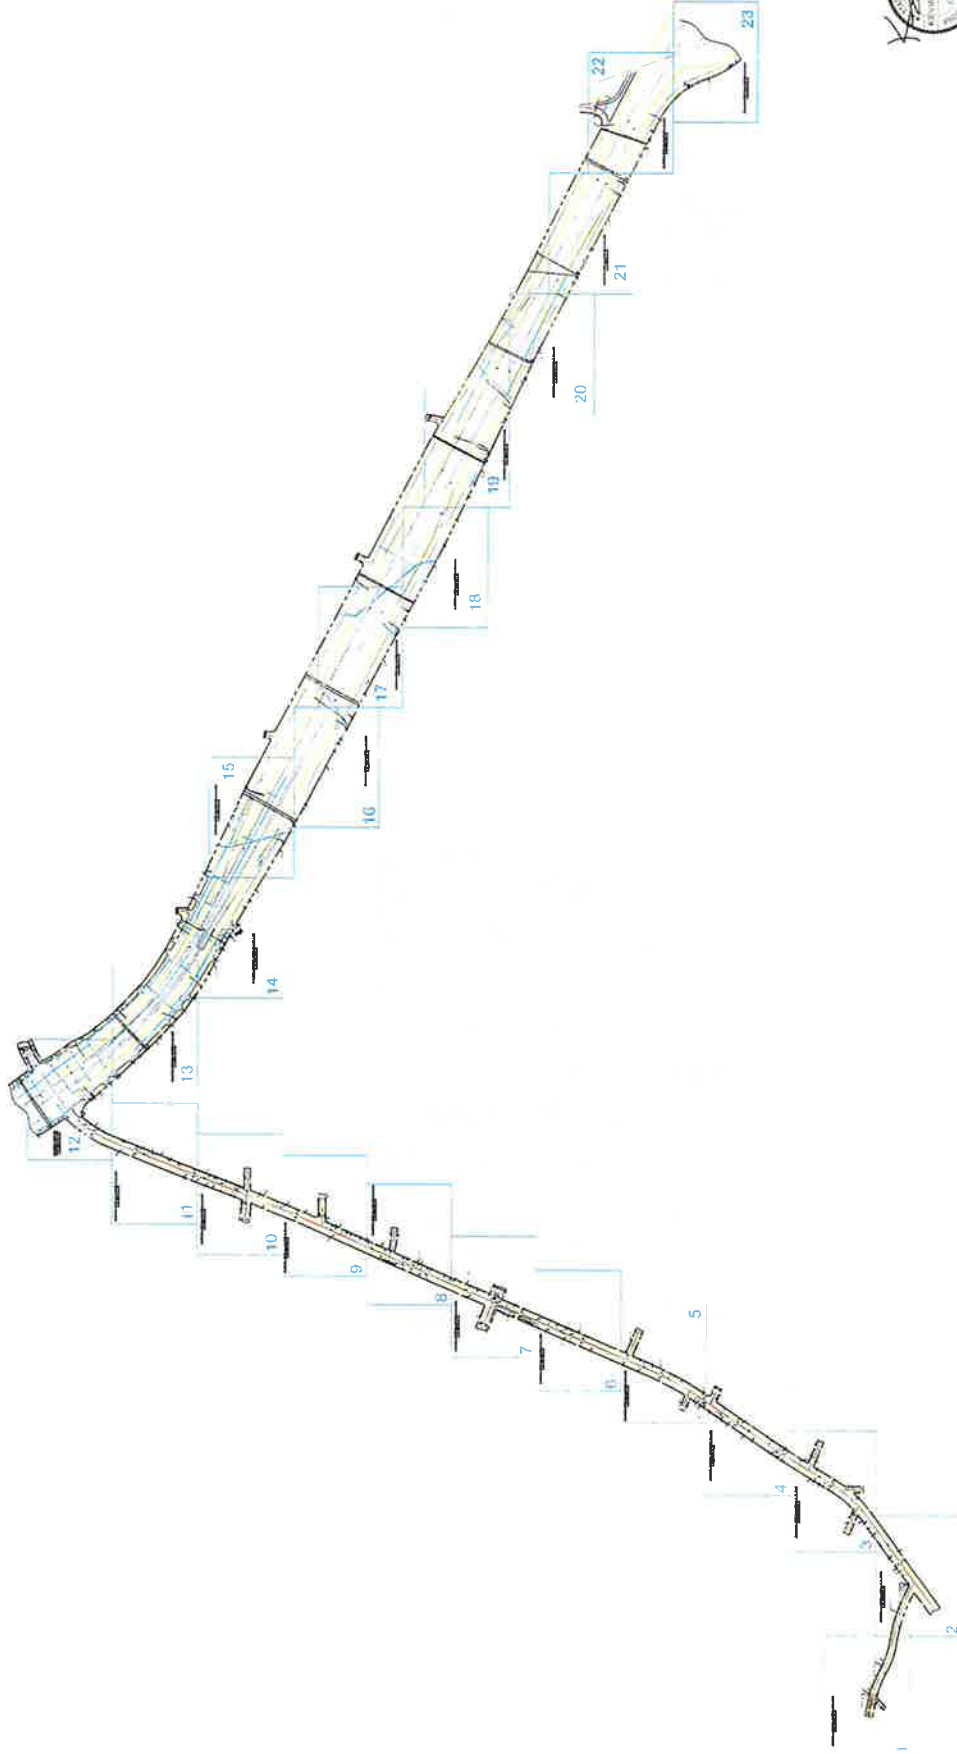


 #HOUSTON, LLC 8595 W. TIDWELL RD., HOUSTON, TEXAS 77060		PLAN OVERVIEW	JB1767579 - 28 DARRELL WHITE RD, HUNTSVILLE, TX 77340	 36502 HEMPSTEAD HWY, HOCKLEY, TX 77447	DESIGNED BY: QUANTA TELECOM SERVICES DWG. NO. SHEET NO. 2 OF 28	LAURENT N/A DATE: 11/02/2024 KEY MAP NO. 33M SCALE: 1" = 100'
---	---	---------------	--	--	--	--

26 DARRELL WHITE RD, HUNTSVILLE, TX 77340

PLAN VIEW 01 OF 23



DRIVEWAY BORE DETAIL

SCALE: NTS

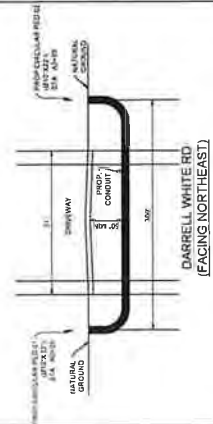

DIRECTIONAL BORE DETAIL

SCALE: NTS

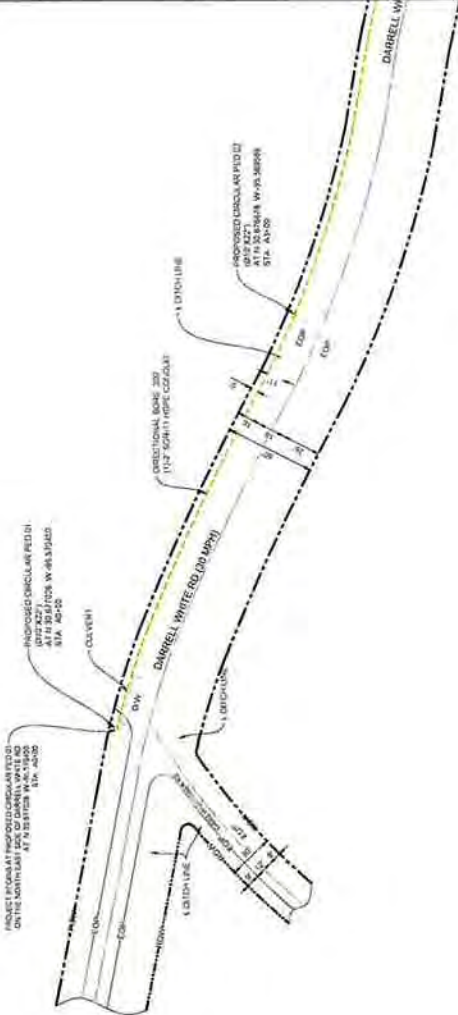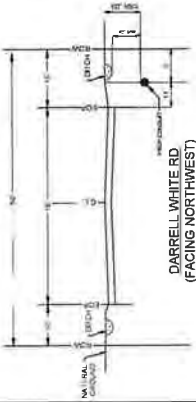

NOTES

1. THE WALKER COUNTY WILL BE NOTIFIED IN WRITING 48 HOURS PRIOR TO COMMENCING WORK.
2. THE WALKER COUNTY UTILITIES DEPARTMENT AND PUBLIC WORKS DEPARTMENT WILL BE NOTIFIED FOR LINE LOCATES AT (936) 438-4339.
3. THE CONTRACTOR SHALL CONTACT TEXAS ONE CALL SYSTEM AT 1-800-4-A-55-55 48 HOURS BEFORE BEGINNING WORK.
4. THE CONTRACTOR SHALL DETERMINE THE EXACT LOCATION OF ALL UNDERGROUND UTILITIES PRIOR TO CONSTRUCTION. THE CONTRACTOR SHALL BE FULLY RESPONSIBLE FOR ALL DAMAGES CAUSED BY HIS FAILURE TO EXACTLY LOCATE AND PRESERVE ALL UNDERGROUND FACILITIES.
5. NO MORE TRENCH OPENED AT ONE TIME THAN CAN BE BACKFILLED AND COMPACTED IN 10 LIFTS AT THE END OF EACH DAY. (NO TRENCH LEFT OPENED OVERNIGHT).
6. ALL EXCESS EXCAVATION TO BE REMOVED FROM THE ROAD RIGHT-OF-WAY AT THE END OF EACH DAY.
7. DITCHES TO BE OPENED AT THE END OF EACH DAY TO ASSURE ADEQUATE DRAINAGE.
8. ROAD MUST BE KEPT OPEN TO TRAFFIC AND CONTRACTOR MUST MAINTAIN ADEQUATE TRAFFIC CONTROL, SIGNALS, ETC., TO PROVIDE COMPLETE SAFETY TO THE PUBLIC.
9. IF IT BECOMES NECESSARY FOR EQUIPMENT TO OPERATE ON A PORTION OF THE PAVED SURFACE, THE CONTRACTOR SHALL BE TAKEN TO PREVENT ANY DAMAGE WHATSOEVER TO THE PAVEMENT.
10. CONDITION OF ROAD UPON COMPLETION OF JOB SHALL BE AS GOOD OR BETTER THAN PRIOR TO STARTING.
11. CONTRACTOR SHALL COMPLY WITH ALL APPLICABLE NATIONAL, STATE, AND LOCAL REQUIREMENTS FOR CONSTRUCTION. THE CONTRACTOR SHALL BE RESPONSIBLE FOR OBTAINING ALL NECESSARY PERMITS. ALL APPLICABLE LOCAL REQUIREMENTS AND REGULATIONS FOR PLACEMENT OF AERIAL CABLE FACILITIES: 18" MIN. VERTICAL CLEARANCE.
12. ALL UTILITIES WILL BE IDENTIFIED BY POTHOLE BEFORE ANY CONSTRUCTION.
13. COMCAST WILL MAINTAIN (2FT) HORIZONTAL & VERTICAL SEPARATION FROM ANY EXISTING UTILITIES.
14. THE CONTRACTOR TO CONTACT WALKER COUNTY PRECINCT 2 AT LEAST 48 HOURS PRIOR TO CONSTRUCTION.

Kurt P. Lark, PE
The Lark Company, LLC
30502 Hempstead Highway
Huntsville, TX 77340
(936) 438-4339



COMCAST PROPOSES TO INSTALL FIBER OPTIC CABLE
COMCAST PROPOSES TO PLACE DIRECTIONAL BORE 176 FT TO INSTALL FIBER OPTIC CABLE TO PROVIDE SERVICE TO 26 DARRELL WHITE RD HUNTSVILLE TX 77340 INSIDE THE ROW OF THE WALKER COUNTY TX.
TOTAL PROJECT FOOTAGE: 575'


JB1767579 - 26 DARRELL WHITE RD,
HUNTSVILLE, TX 77340




DESIGNED BY:
QUANTA TELECOM SERVICES
DWG. NO.
SHEET NO. 3 OF 28

LAMBERT: N/A
DATE: 08/19/2025
KEY MAP NO. 33M
SCALE: 1:40

 PLAN VIEW 02 OF 23



SCALE: NTS

 

DIRECTIONAL BORE DETAIL

SCALE: NTS



COMCAST PROPOSES TO INSTALL FIBER OPTIC CABLE
COMCAST PROPOSES TO PLACE DIRECTIONAL BORE 976 FT TO INSTALL FIBER
OPTIC CABLE TO PROVIDE SERVICE TO 28 DARRELL WHITE RD HUNTSVILLE TX
77340. INSIDE THE ROW OF THE WALKER COUNTY, TX.

TOTAL PROJECT FOOTAGE 976'

JB1767579 - 26 DARRELL WHITE RD,
HUNTSVILLE, TX 77340



36502 HEMPSTEAD HWY., HOCKLEY
TX 77447

DESIGNED BY:
QUANTA TELECOM SERVICES

DWG. NO.
SHEET NO. 4 OF 28

LAMBERT: N/A

DATE: 08/19/2023

NEW MATERIALS 3311


1000



NOTES:

1. THE WALKER CULVERT WILL BE NOTIFIED IN WRITING 48 HOURS PRIOR TO COMMENCING WORK.
2. THE WALKER COUNTY UTILITIES DEPARTMENT AND PUBLIC WORKS DEPARTMENT WILL BE NOTIFIED FOR LINE LOCATES AT (336) 426-4339.
3. THE CONTRACTOR SHALL CONTACT TEXAS ONE CALL SYSTEM AT 1-800-255-4545 (N) AT FOUR BUSINESS DAYS BEFORE BEGINNING.
4. THE CONTRACTOR SHALL DETERMINE THE EXACT LOCATION OF ALL UTILITIES AND BE FULLY RESPONSIBLE FOR ALL DAMAGES CAUSED BY HIS FAILURE TO EXACTLY LOCATE AND PRESERVE ALL UNDERGROUND FACILITIES.
5. NO MORE TRENCH DEPTHS AT ONE TIME THAN CAN BE BACKFILLED AND COMPACTED IN 10' LIFTS AT THE END OF EACH DAY (NO TRENCH LEFT OPENED OVERNIGHT)
6. ALL EXCESS EXCAVATION TO BE REMOVED FROM THE ROAD RIGHT-OF-WAY AT THE END OF EACH DAY.
7. DITCHES TO BE OPENED AT THE END OF EACH DAY TO ASSURE ADEQUATE DRAINAGE.
8. ROAD MUST BE KEPT OPEN TO TRAFFIC AND CONTRACTOR MUST PROVIDE ADEQUATE FLAGMEN, SIGNALS, ETC., TO PROVIDE COMPLETE SAFETY TO THE PUBLIC.
9. IF IT BECOMES NECESSARY FOR EQUIPMENT TO OPERATE ON A PORTION OF THE PAVEMENT, PRECAUTIONS MUST BE TAKEN TO PREVENT ANY DAMAGE WHATSOEVER TO THE PAVEMENT.
10. CONDITION OF ROAD UPON COMPLETION OF JOB SHALL BE AS GOOD OR BETTER THAN PRIOR TO STARTING.
1. CONTRACTOR SHALL COMPLY WITH ALL APPLICABLE NATIONAL ELECTRICAL SAFCO CODE (NEC) REQUIREMENTS. CENTERPOINT ENERGY ELCTRIC POLE ATTACHMENT GUIDELINES & PROCEDURES AND CENTERPOINT ENERGY CABLE ATTACHMENT GUIDELINES & PROCEDURES. PLACEMENT OF AERIAL CABLE FACILITIES: 18" MIN. VERTICAL CLEARANCE.
2. ALL UTILITIES WILL BE IDENTIFIED BY POTHOLE BEFORE ANY CONSTRUCTION.
3. COMCAST WILL MAINTAIN (2FT) HORIZONTAL & VERTICAL SEPARATION FROM ANY EXISTING UTILITIES.
4. THE CONTRACTOR TO CONTACT WALKER COUNTY PRECINCT 2 AT LEAST 48 HOURS PRIOR TO CONSTRUCTION.

26 DARRELL WHITE RD, HUNTSVILLE, TX 77340 PLAN VIEW 03 OF 23

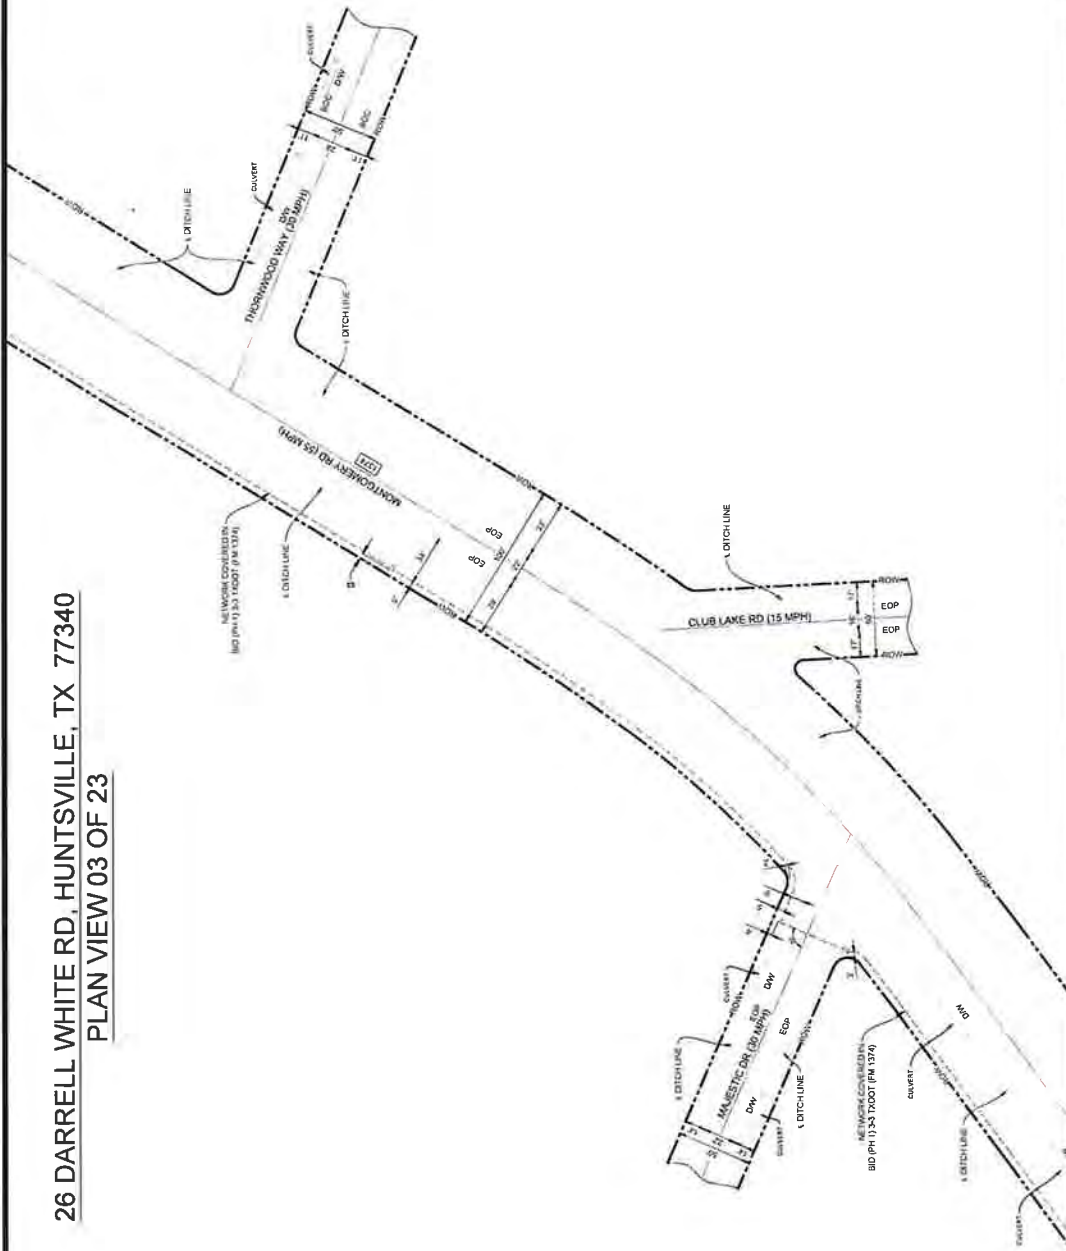

NOTES:

1. THE WALKER COUNTY WILL BE NOTIFIED IN WRITING 48 HOURS PRIOR TO COMMENCING WORK.
2. THE WALKER COUNTY UTILITIES DEPARTMENT AND PUBLIC WORKS DEPARTMENT WILL BE NOTIFIED FOR LINE LOCATES AT (830) 436-4039.
3. THE CONTRACTOR SHALL CONTACT TEXAS ONE CALL SYSTEM AT 1-800-245-4545 MIN. 48 HOURS BEFORE DIGGING.
4. THE CONTRACTOR SHALL DETERMINE THE EXACT LOCATION OF ALL UTILITIES PRIOR TO COMMENCING WORK. THE CONTRACTOR SHALL BE FULLY RESPONSIBLE FOR ALL DAMAGES CAUSED BY HIS FAILURE TO EXACTLY LOCATE AND PRESERVE ALL UNDERGROUND UTILITIES.
5. NO MORE TRENCH OPENED AT ONE TIME THAN CAN BE BACKFILLED AND COMPACTED IN 10' LIFTS AT THE END OF EACH DAY (NO TRENCH LEFT OPENED OVERNIGHT).
6. ALL EXCESS EXCAVATION TO BE REMOVED FROM THE ROAD RIGHT-OF-WAY AT THE END OF EACH DAY.
7. DITCHES TO BE OPENED AT THE END OF EACH DAY TO ASSURE ADEQUATE DRAINAGE.
8. ROAD MUST BE KEPT OPEN TO TRAFFIC AND CONTRACTOR MUST MAINTAIN ADEQUATE TRAFFIC CONTROL SIGNALS, ETC., TO PROVIDE COMPLETE SAFETY TO THE PUBLIC.
9. IF IT BECOMES NECESSARY FOR EQUIPMENT TO OPERATE ON A PORTION OF THE PAVEMENT PRECAUTIONS MUST BE TAKEN TO PREVENT ANY DAMAGE WHATSOEVER TO THE PAVEMENT.
10. CONDITION OF ROAD UPON COMPLETION OF JOB SHALL BE AS GOOD OR BETTER THAN PRIOR TO STARTING.
11. CONTRACTOR SHALL COMPLY WITH ALL APPLICABLE NATIONAL ELECTRICAL CODES AND REGULATIONS AND ALL APPLICABLE LOCAL REQUIREMENTS AND PROCEDURES AND ALL APPLICABLE LOCAL REQUIREMENTS AND REGULATIONS FOR PLACEMENT OF AERIAL CABLE FACILITIES 18" MIN VERTICAL CLEARANCE.
12. ALL UTILITIES WILL BE IDENTIFIED BY POT HOLE BEFORE ANY CONSTRUCTION.
13. COMCAST WILL MAINTAIN (2FT) HORIZONTAL & VERTICAL SEPARATION FROM ANY EXISTING UTILITIES.
14. THE CONTRACTOR TO CONTACT WALKER COUNTY PRECINCT 2 AT LEAST 48 HOURS PRIOR TO CONSTRUCTION.

Kenn P. Luby, PE
The Aspen Utility Company, LLC
P.O. Box 23230
Houston, Texas 77202
Huntsville, TX 77340
+1 (702) 453-1891



DESIGNED BY:
QUANTA TELECOM SERVICES
DATE: 08/19/2025
KEY MAP NO. 33M
SCALE: 1/4"
DWG. NO.
SHEET NO. 5 OF 28



JB1767579 - 26 DARRELL WHITE RD,
HUNTSVILLE, TX 77340

COMCAST PROPOSES TO INSTALL FIBER OPTIC CABLE
COMCAST PROPOSES TO PLACE DIRECTIONAL BORE 3/8" TO INSTALL FIBER
OPTIC CABLE TO PROVIDE SERVICE TO 26 DARRELL WHITE RD, HUNTSVILLE, TX
77340, INSIDE THE ROW OF THE WALKER COUNTY, TX.
TOTAL PROJECT FOOTAGE: 816'



100



1. THE WALKER COUNTY WILL BE NOTIFIED IN WRITING 48 HOURS PRIOR TO COMMENCING WORK
2. THE WALKER COUNTY UTILITIES DEPARTMENT AND PUBLIC WORKS DEPARTMENT WILL BE NOTIFIED FOR LINE LOCATES AT (936) 434-0938
3. THE CONTRACTOR SHALL CONTACT TEXAS ONE CALL SYSTEM AT 1-800-327-4645 MIN 30 DAYS BEFORE ANY DUGGING
4. THE CONTRACTOR SHALL DETERMINE THE EXACT LOCATION OF ALL EXISTING UTILITIES AND BE FULLY RESPONSIBLE FOR ALL DAMAGES CAUSED BY HIS FAILURE TO EXACTLY LOCATE AND PRESERVE ALL UNDERGROUND FACILITIES
5. NO MORE TRENCH OPENED AT ONE TIME THAN CAN BE BACKFILLED AND COMPACTED IN 10 LIFTS AT THE END OF EACH DAY AND TRENCH LEFT OPENED OVERNIGHT)
6. ALL EXCESS EXCAVATION TO BE REMOVED FROM THE ROAD RIGHT-OF-WAY AT THE END OF EACH DAY
7. DITCHES TO BE OPENED AT THE END OF EACH DAY TO ASSURE ADEQUATE DRAINAGE
8. ROAD MUST BE KEPT OPEN TO TRAFFIC AND CONTRACTOR MUST PROVIDE ADEQUATE FLAGMEN, SIGNALS, ETC. TO PROVIDE COMPLETE SAFETY TO THE PUBLIC
9. IF IT BECOMES NECESSARY FOR EQUIPMENT TO OPERATE ON A PORTION OF THE PAVEMENT PRECAUTIONS MUST BE TAKEN TO PREVENT THE DAMAGE WHATSOEVER TO THE PAVEMENT
10. CONDITION OF ROAD UPON COMPLETION OF JOB SHALL BE AS GOOD OR BETTER THAN PRIOR TO STARTING
11. CONTRACTOR SHALL COMPLY WITH ALL APPLICABLE NATIONAL ELECTRICAL, SAFETY CODE & NEC REQUIREMENTS. CENTERPOINT ENERGY ELECTRIC POLE ATTACHMENT GUIDELINES + PERPENDICULARITY OF POLES TO THE ROADWAY. MINIMUM 18" MIN VERTICAL PLACEMENT OF AERIAL CABLE FACILITIES. 18" MIN VERTICAL CLEARANCE
12. ALL UTILITIES WILL BE IDENTIFIED BY POT HOLE BEFORE ANY CONSTRUCTION
13. COMCAST WILL MAINTAIN 5FT) HORIZONTAL & VERTICAL SEPARATION FROM ANY EXISTING UTILITIES
14. THE CONTRACTOR TO CONTRACT WALKER COUNTY PROJECT 2 AT THE EAST WALKER BRIDGE PRIOR TO CONSTRUCTION

ENGINEERING SEAL



at HOUSTON, LLC
8000 W. TIDWELL RD. HOUSTON, TEXAS 77060



COMCAST PROPOSES TO INSTALL FIBER OPTIC CABLE
COMCAST PROPOSES TO PLACE DIRECTIONAL BORE #18 IN TO INSTALL FIBER
OPTIC CABLE TO PROVIDE SERVICE TO 36 CARRELL WHITE RD. HUNTSVILLE, TX
17349, INSIDE THE NOW OF THE WALKER COUNTY, TX

JB1767579 - 26 DARRELL WHITE RD,
HUNTSVILLE, TX 77340




DESIGNED BY:
QUANTA TELECOM SERVICES

DWG NO.
SHEET NO. 6 OF 28

LAMBERT: N/A
DATE: 08/19/2
KEY MAP NO 3
SCALE 1:40



26 DARRELL WHITE RD, HUNTSVILLE, TX 77340 PLAN VIEW 05 OF 23

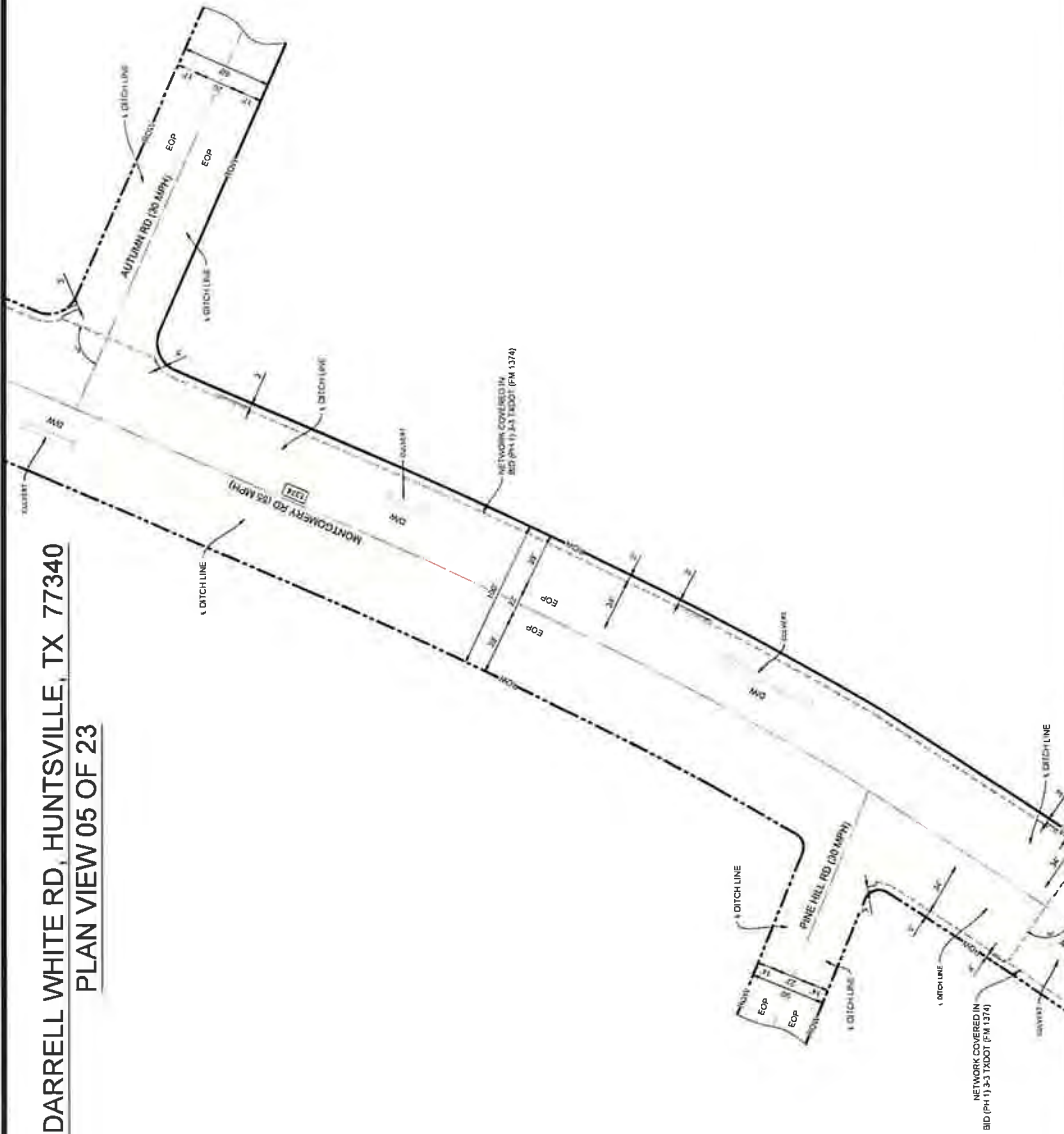

NOTES

1. THE WALKER COUNTY WILL BE NOTIFIED IN WRITING 48 HOURS PRIOR TO COMMENCING WORK
2. THE WALKER COUNTY UTILITIES DEPARTMENT AND PUBLIC WORKS DEPARTMENT WILL BE NOTIFIED FOR LINE LOCATES AT 80% 426-4978.
3. THE CONTRACTOR SHALL CONTACT TEXAS ONE CALL SYSTEM AT 1-800-4-A-CALL (426-2255) FOR ALL UTILITIES BEFORE BEGINNING WORK.
4. THE CONTRACTOR SHALL DETERMINE THE EXACT LOCATION OF ALL EXISTING UTILITIES AND MARK THEM WITH FLAGGING. THE CONTRACTOR SHALL BE FULLY RESPONSIBLE FOR ALL DAMAGES CAUSED BY HIS FAILURE TO EXACTLY LOCATE AND PRESERVE ALL UNDERGROUND FACILITIES.
5. NO MORE TRENCH OPENED AT ONE TIME THAN CAN BE BACKFILLED AND COMPACTED IN 10' LIFTS AT THE END OF EACH DAY (NO TRENCH LEFT OPENED OVERNIGHT).
6. ALL EXCESS EXCAVATION TO BE REMOVED FROM THE ROAD RIGHT-OF-WAY AT THE END OF EACH DAY.
7. DITCHES TO BE OPENED AT THE END OF EACH DAY TO ASSURE ADEQUATE DRAINAGE.
8. ROAD MUST BE KEPT OPEN TO TRAFFIC AND CONTRACTOR MUST PROVIDE ADEQUATE TRAFFIC CONTROL, SIGNALS, ETC., TO PROVIDE COMPLETE SAFETY TO THE PUBLIC.
9. IF IT BECOMES NECESSARY FOR EQUIPMENT TO OPERATE ON A PORTION OF THE ROAD, THE CONTRACTOR SHALL TAKE ALL NECESSARY PRECAUTIONS TO PREVENT ANY DAMAGE WHEN ACCESS TO THE PAVEMENT.
10. CONDITION OF ROAD UPON COMPLETION OF JOB SHALL BE AS GOOD OR BETTER THAN PRIOR TO STARTING.
11. CONTRACTOR SHALL COMPLY WITH ALL APPLICABLE NATIONAL, STATE, AND LOCAL REQUIREMENTS FOR THE PROPOSED CONSTRUCTION. ALL APPLICABLE LOCAL REQUIREMENTS AND REGULATIONS FOR PLACEMENT OF AERIAL CABLE FACILITIES: 18" MIN VERTICAL CLEARANCE.
12. ALL UTILITIES WILL BE IDENTIFIED BY POT-HOLE BEFORE ANY CONSTRUCTION.
13. COMCAST WILL MAINTAIN (DFT) HORIZONTAL & VERTICAL SEPARATION FROM ANY EXISTING UTILITIES.
14. THE CONTRACTOR TO CONTACT WALKER COUNTY PRECINCT 2 AT LEAST 48 HOURS PRIOR TO CONSTRUCTION.

Kenneth P. Lasky, PE
The Aspen Group, LLC
Firm No. 233-06
35002 Hempstead Highway
Huntsville, TX 77340
(409) 639-3881



LAMBERT: N/A
DATE: 06/19/2025
KEY MAP NO. 33M
SCALE: 1" = 40'

DESIGNED BY:
QUANTA TELECOM SERVICES
DWG. NO. 28
SHEET NO. 7 OF 28

ASPEN
35002 HEMPSTEAD HWY, HOCKLEY, TX 77447

JB1767579 - 26 DARRELL WHITE RD,
HUNTSVILLE, TX 77340

COMCAST PROPOSES TO INSTALL FIBER OPTIC CABLE
COMCAST PROPOSES TO PLACE DIRECTIONAL BORE 978 FT TO INSTALL FIBER
OPTIC CABLE TO PROVIDE SERVICE TO 26 DARRELL WHITE RD HUNTSVILLE TX
77340 INSIDE THE ROW OF THE WALKER COUNTY TX
TOTAL PROJECT FOOTAGE 978'



PLAN VIEW 06 OF 23



1. THE WALKER COUNTY WILL BE NOTIFIED IN WRITING 48 HOURS PRIOR TO COMMENCING WORK.
2. THE WALKER COUNTY UTILITIES DEPARTMENT AND PUBLIC WORKS DEPARTMENT WILL BE NOTIFIED FOR ANY LOCATES AT (202) 465-4338
3. THE CONTRACTOR SHALL CONTACT TEXAS ONE CALL SYSTEM AT 1-800-224-6245 MIN. 48 HOURS BEFORE DIGGING
4. THE CONTRACTOR SHALL DETERMINE THE EXACT LOCATION OF ALL EXISTING UTILITIES AND RECORD THE LOCATION OF ALL UTILITIES. THE CONTRACTOR SHALL BE RESPONSIBLE FOR MARKING AND ADHERE TO THE MARKING. THE CONTRACTOR SHALL BE RESPONSIBLE FOR MARKING EXISTING UTILITIES AND PRESERVE ALL UNDERGROUND FACILITIES.
5. NO MORE TREBUSH OFFERED AT ONE TIME THAN CAN BE BACKFILLED AND COMPACTED IN 10' LIFTS AT THE END OF EACH DAY. (NO TREBUSH OPENED OVERNIGHT)
6. ALL EXCESS EXCAVATION TO BE REMOVED FROM THE ROAD RIGHT-OF-WAY AT THE END OF EACH DAY
7. DITCHES TO BE OPENED AT THE END OF EACH DAY TO ASSURE ADEQUATE DRAINAGE
8. ROAD MUST BE KEPT OPEN TO TRAFFIC AND CONTRACTOR MUST PROVIDE ADEQUATE FLAGMEN SIGNALS, ETC. TO PROVIDE COMPLETE SAFETY TO THE PUBLIC
9. IF IT BECOMES NECESSARY FOR EQUIPMENT TO OPERATE ON A PORTION OF THE PAVEMENT, PRECAUTIONS MUST BE TAKEN TO PREVENT ANY DAMAGE WHATSOEVER TO THE PAVEMENT
10. CONDITION OF ROAD UPON COMPLETION OF JOB SHALL BE AS GOOD OR BETTER THAN PRIOR TO STARTING
11. CONTRACTOR SHALL COMPLY WITH ALL APPLICABLE NATIONAL ELECTRICAL SAFETY CODE (NEC) REQUIREMENTS, CENTERPOINT ENERGY ELECTRIC POLE ATTACHMENT GUIDELINES & PROCEDURES AND ALL OTHER APPLICABLE REGULATIONS. ALL WORK SHALL BE PLACED ON ADEQUATELY CLEARANCE OF AERIAL CABLE FACILITIES. 18" MIN. VERTICAL CLEARANCE
12. ALL UTILITIES WILL BE IDENTIFIED BY POTHOLE BEFORE ANY CONSTRUCTION
13. COMPACT WILL MAINTAIN (2FT) HORIZONTAL & VERTICAL SEPARATION FROM ANY EXISTING UTILITIES
14. AT LEAST 48 HOURS PRIOR TO CONSTRUCTION

Kevin P. Lash, PE
The Aspen Valley Co.
Firm No. 23536
36502 Hempstead H
Hockley TX 77447
• (702) 493-3691



at HOUSTON, LLC
8550 W. TIDWELL RD. HOUSTON, TEXAS 77060



COMCAST PROPOSES TO INSTALL FIBER OPTIC CABLE
COMCAST PROPOSES TO PLACE DIRECTIONAL BORE 078 FT TO INSTALL FIBER
OPTIC CABLE TO PROVIDE SERVICE TO 36 DARRELL WHITE RD HUNTSVILLE TX
77340 INSIDE THE ROW OF THE WALKER COUNTY TX

JB1767579 - 26 DARRELL WHITE RD,
HUNTSVILLE, TX 77340



DESIGNED BY:
QUANTA TELECOM SERVICES

DWG. NO.
SHEET NO. 8 OF 28

LAMBERT: N/A


DATE: 05/19/2009

KEY MAP NO. 2311

SCALE : 1:40



26 DARRELL WHITE RD, HUNTSVILLE, TX 77340 PLAN VIEW 07 OF 23

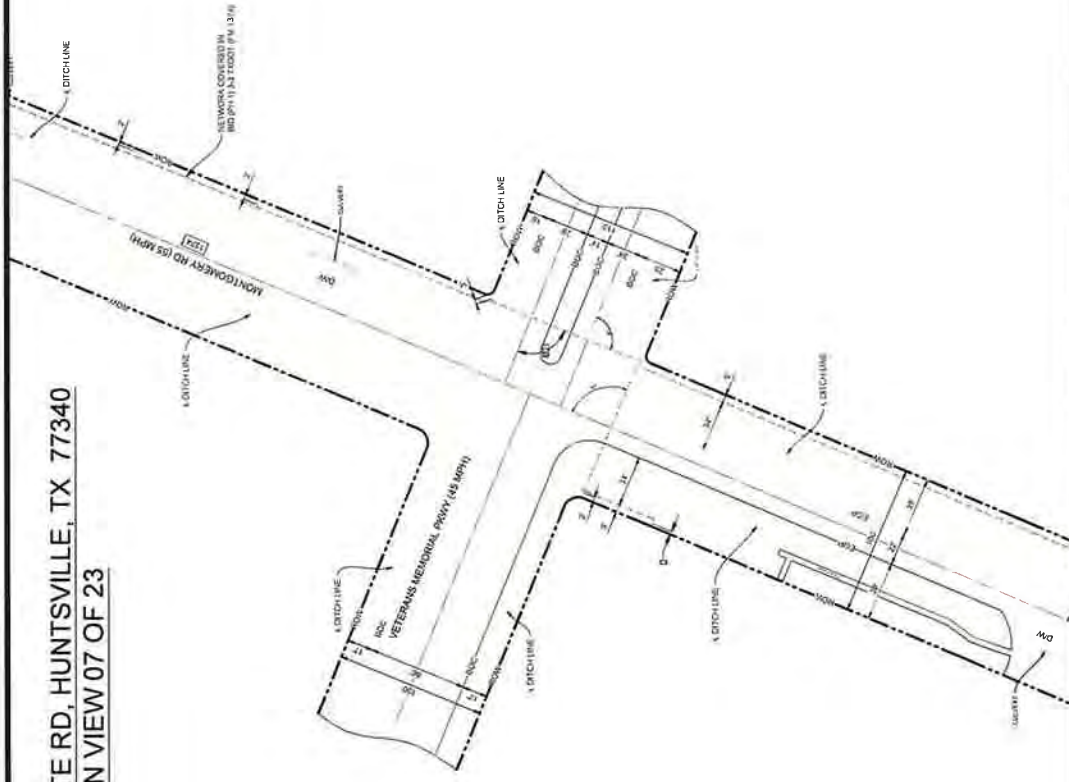

NOTES:

1. THE WALKER COUNTY WILL BE NOTIFIED IN WRITING 48 HOURS PRIOR TO COMMENCING WORK.
2. THE WALKER COUNTY UTILITIES DEPARTMENT AND PUBLIC WORKS DEPARTMENT WILL BE NOTIFIED FOR LINE LOCATES AT (330) 438-0339
3. THE CONTRACTOR SHALL CONTACT TEXAS ONE CALL SYSTEM AT 1-800-455-6545 MIN. 48 HOURS BEFORE DIGGING
4. THE CONTRACTOR SHALL DETERMINE THE EXACT LOCATION OF ALL UNDERGROUND FACILITIES BEFORE COMMENCING WORK AND AGREE TO BE FULLY RESPONSIBLE FOR ALL DAMAGES CAUSED BY HIS FAILURE TO EXACTLY LOCATE AND PRESERVE ALL UNDERGROUND FACILITIES
5. NO MORE TRENCH OPENED AT ONE TIME THAN CAN BE BACKFILLED AND COMPACTED IN 10' LIFTS AT THE END OF EACH DAY (NO TRENCH LEFT OPENED OVERNIGHT)
6. ALL EXCESS EXCAVATION TO BE REMOVED FROM THE ROAD RIGHT-OF-WAY AT THE END OF EACH DAY.
7. DITCHES TO BE OPENED AT THE END OF EACH DAY TO ASSURE ADEQUATE DRAINAGE
8. ROAD MUST BE KEPT OPEN TO TRAFFIC AND CONTRACTOR MUST PROVIDE ADEQUATE FLAGMEN, SIGNALS, ETC., TO PROVIDE COMPLETE SAFETY TO THE PUBLIC.
9. IF IT BECOMES NECESSARY FOR EQUIPMENT TO OPERATE ON A PORTION OF THE PAVEMENT PRECAUTIONS MUST BE TAKEN TO PREVENT ANY DAMAGE WHATSOEVER TO THE PAVEMENT
10. CONDITION OF ROAD UPON COMPLETION OF JOB SHALL BE AS GOOD OR BETTER THAN PRIOR TO STARTING
11. CONTRACTOR SHALL OBTAIN ALL NECESSARY PERMITS AND UTILITIES ELECTRICAL SAFETY CODE (NEC) REQUIREMENTS, CENTERPOINT ENERGY ELECTRICAL POLE ATTACHMENT GUIDELINES & PROCEDURES AND ALL APPLICABLE LOCAL REQUIREMENTS AND REGULATIONS FOR CONSTRUCTION OF AERIAL CABLE FACILITIES 18" MIN VERTICAL CLEARANCE
12. ALL UTILITIES WILL BE IDENTIFIED BY PO-HOLE BEFORE ANY CONSTRUCTION.
13. COMCAST WILL MAINTAIN (2FT) HORIZONTAL & VERTICAL SEPARATION FROM ANY EXISTING UTILITIES
14. THE CONTRACTOR TO CONTACT WALKER COUNTY PRECINCT 2 AT LEAST 48 HOURS PRIOR TO CONSTRUCTION



Norm P. Lasky, PE
The Aspen Utility Company, LLC
Exp. No. 23308
36502 Hempstead Highway
Huntsville, TX 77340
+1 (702) 693-3861

DESIGNED BY:
QUANTA TELECOM SERVICES
DWG NO.
SHEET NO. 9 OF 28




JB1767579 - 26 DARRELL WHITE RD,
HUNTSVILLE, TX 77340

COMCAST PROPOSES TO INSTALL FIBER OPTIC CABLE
COMCAST PROPOSES TO PLACE DIRECTIONAL BORE 876 FT TO INSTALL FIBER OPTIC CABLE TO PROVIDE SERVICE TO 26 DARRELL WHITE RD HUNTSVILLE TX 77340, INSIDE THE ROW OF THE WALKER COUNTY TX.
TOTAL PROJECT FOOTAGE: 976'



SEP 02 2025

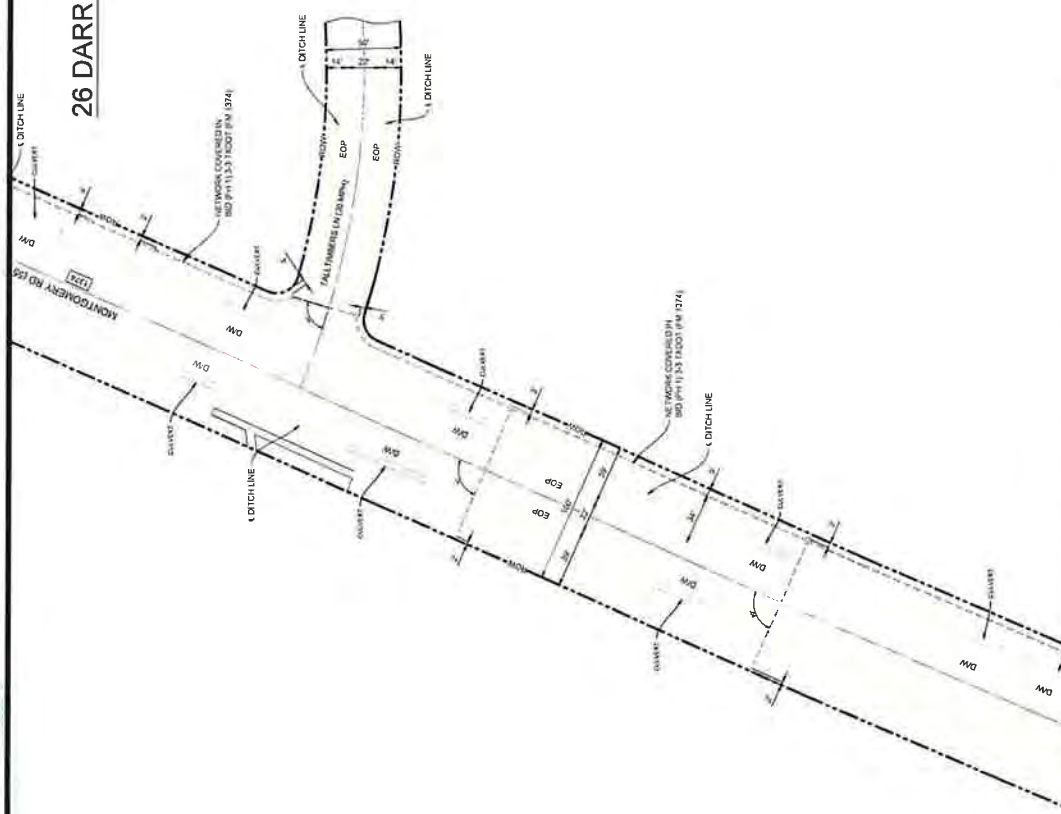

26 DARRELL WHITE RD, HUNTSVILLE, TX 77340 PLAN VIEW 08 OF 23

NOTES:

1. THE WALKER COUNTY WILL BE NOTIFIED IN WRITING 48 HOURS PRIOR TO COMMENCING WORK.
2. THE WALKER COUNTY UTILITIES DEPARTMENT AND PUBLIC WORKS DEPARTMENT WILL BE NOTIFIED FOR LINE LOCATES AT (936) 438-4939.
3. THE CONTRACTOR SHALL CONTACT TEXAS ONE CALL SYSTEM AT 1-800-245-4545 MIN 48 HOURS BEFORE DIGGING.
4. THE CONTRACTOR SHALL DETERMINE THE EXIST LOCATION OF ALL UNDERGROUND FACILITIES BEFORE COMMENCING WORK AND AGREE TO BE FULLY RESPONSIBLE FOR ALL DAMAGES CAUSED BY HIS FAILURE TO EXACTLY LOCATE AND PRESERVE ALL UNDERGROUND FACILITIES.
5. NO MORE TRENCH OPENED AT ONE TIME THAN CAN BE BACKFILLED AND COMPACTED IN 10' LIFTS AT THE END OF EACH DAY. (NO TRENCH LEFT OPENED OVERNIGHT).
6. ALL EXCESS EXCAVATION TO BE REMOVED FROM THE ROAD RIGHT-OF-WAY AT THE END OF EACH DAY.
7. DITCHES TO BE OPENED AT THE END OF EACH DAY TO ASSURE ADEQUATE DRAINAGE.
8. ROAD MUST BE KEPT OPEN TO TRAFFIC AND CONTRACTOR MUST PROVIDE ADEQUATE FLAGMEN, SIGNALS, ETC., TO PROVIDE COMPLETE SAFETY TO THE PUBLIC.
9. IF IT BECOMES NECESSARY FOR EQUIPMENT TO OPERATE ON A PORTION OF THE PAVEMENT, PRECAUTIONS MUST BE TAKEN TO PREVENT ANY DAMAGE WHATSOEVER TO THE PAVEMENT.
10. CONDITION OF ROAD UPON COMPLETION OF JOB SHALL BE AS GOOD OR BETTER THAN PRIOR TO STARTING.
11. CONTRACTOR SHALL COMPLY WITH ALL APPLICABLE NATIONAL ELECTRICAL SAFETY CODE (NEC) REQUIREMENTS, CENTERPOINT ENERGY ELECTRIC POLE ATTACHMENT GUIDELINES & PROCEDURES AND ALL APPLICABLE LOCAL REQUIREMENTS AND REGULATIONS FOR PLACEMENT OF FIBER OPTIC FACILITIES. 10' MIN VERTICAL CLEARANCE.
12. ALL UTILITIES WILL BE IDENTIFIED BY PO-HOLE BEFORE ANY CONSTRUCTION.
13. COMCAST WILL MAINTAIN (B7) HORIZONTAL & VERTICAL SEPARATION FROM ANY EXISTING UTILITIES.
14. THE CONTRACTOR TO CONTACT WALKER COUNTY PRECINCT 2 AT LEAST 48 HOURS PRIOR TO CONSTRUCTION.

Kurt P. Luby, PE
The Aspen Utility Company, LLC
10000 W. 3500 S.
35000 Huntswood Highway
Huntsville, TX 77447
+1 (702) 493-3661



COMCAST PROPOSES TO INSTALL FIBER OPTIC CABLE.
COMCAST PROPOSES TO PLACE DIRECTIONAL BORE 0.75 FT TO INSTALL FIBER OPTIC CABLE TO PROVIDE SERVICE TO 26 DARRELL WHITE RD HUNTSVILLE, TX 77340, INSIDE THE ROW OF THE WALKER COUNTY, TX.
TOTAL PROJECT FOOTAGE: #16

JB1767579 - 26 DARRELL WHITE RD,
HUNTSVILLE, TX 77340




DESIGNED BY:
QUANTA TELECOM SERVICES

LAUREN: WA
DATE: 08/19/2025
KEY MAP NO: 33M
SCALE: 1"=40'

DWG. NO.
SHEET NO. 10 OF 28

26 DARRELL WHITE RD, HUNTSVILLE, TX 77340 PLAN VIEW 09 OF 23

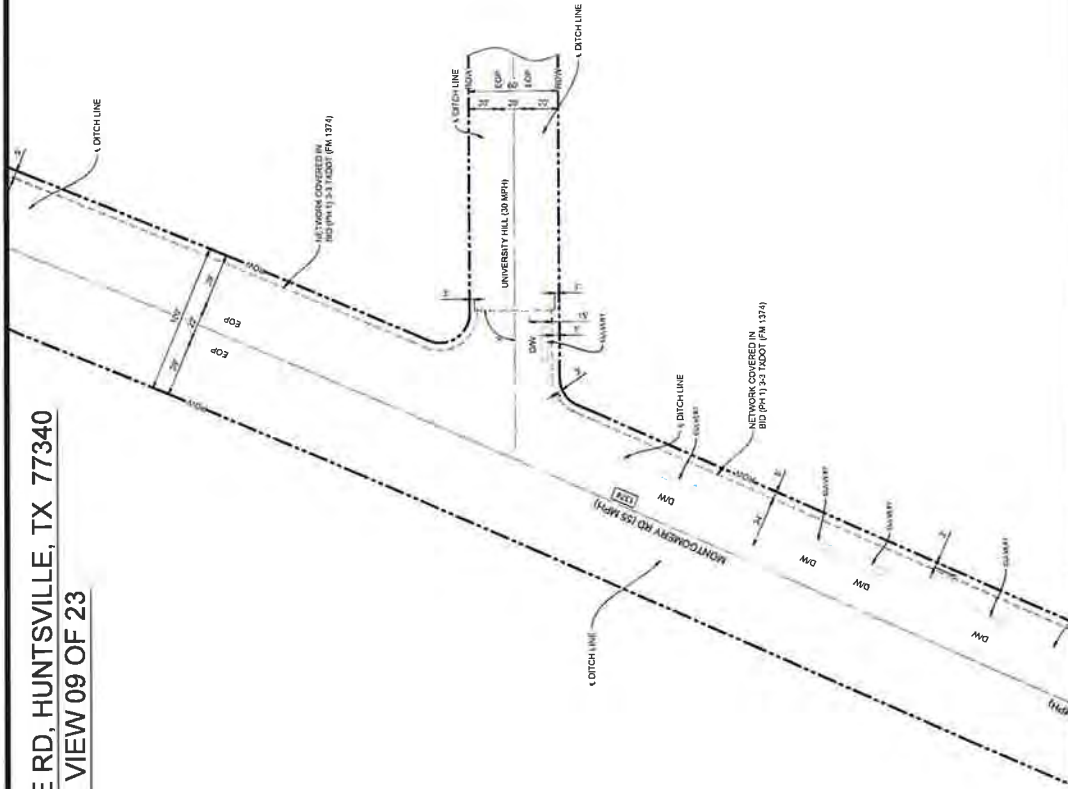

NOTES:

1. THE WALKER COUNTY WILL BE NOTIFIED IN WRITING 48 HOURS PRIOR TO COMMENCING WORK.
2. THE WALKER COUNTY UTILITIES DEPARTMENT AND PUBLIC WORKS DEPARTMENT WILL BE NOTIFIED FOR LINE LOCATES AT (936) 436-4839
3. THE CONTRACTOR SHALL CONTACT TEXAS ONE CALL SYSTEM AT 1-800-368-5845 MIN. 48 HOURS BEFORE DIGGING.
4. THE CONTRACTOR SHALL DETERMINE THE EXACT LOCATION OF ALL UNDERGROUND UTILITIES BEFORE COMMENCING WORK AND AGREE TO BE FULLY RESPONSIBLE FOR ALL DAMAGES CAUSED BY HIS FAILURE TO EXACTLY LOCATE AND PRESERVE ALL UNDERGROUND FACILITIES.
5. NO MORE TRENCH OPENED AT ONE TIME THAN CAN BE BACKFILLED AND COMPACTED IN 10' LIFTS AT THE END OF EACH DAY (NO TRENCH LEFT OPENED OVERNIGHT).
6. ALL EXCESS EXCAVATION TO BE REMOVED FROM THE ROAD RIGHT-OF-WAY AT THE END OF EACH DAY.
7. ADEQUATE DRAINAGE.
8. ROAD MUST BE KEPT OPEN TO TRAFFIC AND CONTRACTOR MUST PROVIDE ADEQUATE FLASHING SIGNALS ETC. TO PROVIDE COMPLETE SAFETY TO THE PUBLIC.
9. IF IT BECOMES NECESSARY TO DISCONTINUE THE OPERATION OF A PORTION OF THE PAVEMENT, PRECAUTIONS MUST BE TAKEN TO PREVENT ANY DAMAGE WHATSOEVER TO THE PAVEMENT.
10. CONDITION OF ROAD UPON COMPLETION OF JOB SHALL BE AS GOOD OR BETTER THAN PRIOR TO STARTING.
11. CONTRACTOR SHALL COMPLY WITH ALL APPLICABLE NATIONAL, STATE AND LOCAL REQUIREMENTS AND REGULATIONS FOR THE INSTALLATION OF ENERGY ELECTRIC POLE ATTACHMENT GUIDELINES & PROCEDURES AND ALL APPLICABLE LOCAL REQUIREMENTS AND REGULATIONS FOR THE INSTALLATION OF AERIAL CABLE FACILITIES. 18" MIN. VERTICAL CLEARANCE.
12. ALL UTILITIES WILL BE IDENTIFIED BY POTHOLE BEFORE ANY CONSTRUCTION.
13. COMCAST WILL MAINTAIN (2FT) HORIZONTAL & VERTICAL SEPARATION FROM ANY EXISTING UTILITIES.
14. THE CONTRACTOR TO CONTACT WALKER COUNTY PRECINCT 2 AT LEAST 48 HOURS PRIOR TO CONSTRUCTION.


Kevin P. Lusk, PE
The Aspen Utility Company, LLC
Firm No. 23325
36502 Hempstead Highway
Huntsville, TX 77340
+1 (702) 653-3641



COMCAST PROPOSES TO INSTALL FIBER OPTIC CABLE
COMCAST PROPOSES TO PLACE DIRECTIONAL BORE 916 FT TO INSTALL FIBER OPTIC CABLE TO PROVIDE SERVICE TO 26 DARRELL WHITE RD, HUNTSVILLE, TX 77340 UNDER THE TOWN OF THE WALKER COUNTY, TX.

TOTAL PROJECT FOOTAGE 916'

 JB1767579 - 26 DARRELL WHITE RD,
HUNTSVILLE, TX 77340




36502 HEMPSTEAD HWY, HOOKLEY,
TX 77347

DESIGNED BY:
QUANTA TELECOM SERVICES

DWG. NO. 11 OF 28
SHEET NO. 11 OF 28

LAMBERT: N/A
DATE: 08/19/2025
KEY MAP NO. 33M
SCALE: 1" = 40'

26 DARRELL WHITE RD, HUNTSVILLE, TX 77340 PLAN VIEW 10 OF 23

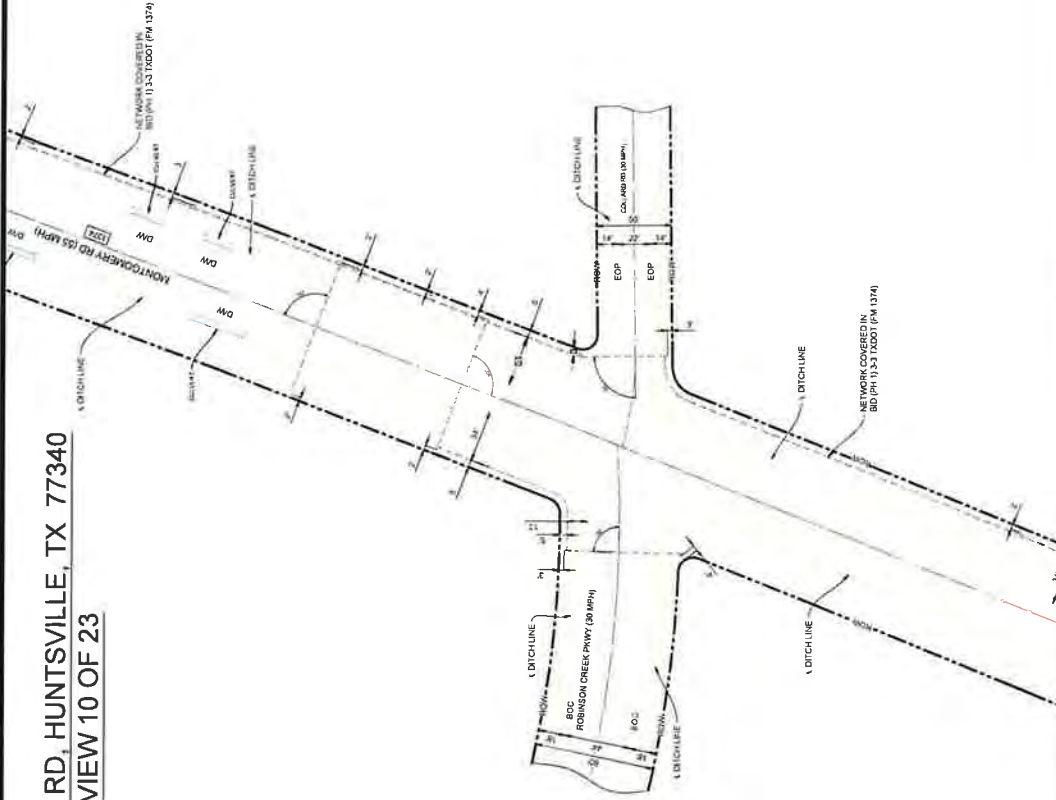

NOTES

1. THE WALKER COUNTY WILL BE NOTIFIED IN WRITING 48 HOURS PRIOR TO COMMENCING WORK.
2. THE WALKER COUNTY UTILITIES DEPARTMENT AND PUBLIC WORKS DEPARTMENT WILL BE NOTIFIED FOR LINE LOCATES AT (936) 436-4339
3. THE CONTRACTOR SHALL CONTACT TEXAS ONE CALL SYSTEM AT 1-800-245-4545 MIN. 48 HOURS BEFORE DIGGING
4. THE CONTRACTOR SHALL DETERMINE THE EXACT LOCATION OF ALL UNDERGROUND FACILITIES BEFORE COMMENCING ANY WORK. THE CONTRACTOR SHALL BE FULLY RESPONSIBLE FOR ALL DAMAGES CAUSED BY HIS FAILURE TO EXACTLY LOCATE AND PRESERVE ALL UNDERGROUND FACILITIES
5. NO MORE TRENCH OPENED AT ONE TIME THAN CAN BE BACKFILLED AND COMPACTED IN 10' LIFTS AT THE END OF EACH DAY (NO TRENCH LEFT OPENED OVERNIGHT)
6. ALL EXCESS EXCAVATION TO BE REMOVED FROM THE ROAD RIGHT-OF-WAY AT THE END OF EACH DAY
7. DITCHES TO BE OPENED AT THE END OF EACH DAY TO ASSURE ADEQUATE DRAINAGE
8. ROAD MUST BE KEPT OPEN TO TRAFFIC AND CONTRACTOR MUST PROVIDE ADEQUATE FLAGMEN, SIGNALS, ETC., TO PROVIDE COMPLETE SAFETY TO THE PUBLIC
9. IF IT BECOMES NECESSARY FOR EQUIPMENT TO OPERATE ON A PORTION OF THE PAVEMENT, PRECAUTIONS MUST BE TAKEN TO PREVENT ANY DAMAGE WHATSOEVER TO THE PAVEMENT
10. CONDITION OF ROAD UPON COMPLETION OF JOB SHALL BE AS GOOD OR BETTER THAN PRIOR TO STARTING
11. CONTRACTOR SHALL COMPLY WITH ALL APPLICABLE NATIONAL ELECTRICAL SAFETY CODE (NEC) REQUIREMENTS, CENTERPOINT ENERGY ELECTRIC POLE ATTACHMENT GUIDELINES & PROCEDURES AND ALL APPLICABLE LOCAL REQUIREMENTS AND REGULATIONS FOR PLACEMENT OF AERIAL CABLE FACILITIES 18' MIN. VERTICAL CLEARANCE
12. ALL UTILITIES WILL BE IDENTIFIED BY POTHOLE BEFORE ANY CONSTRUCTION
13. COMCAST WILL MAINTAIN (RTT) HORIZONTAL & VERTICAL SEPARATION FROM ANY EXISTING UTILITIES.
14. THE CONTRACTOR TO CONTACT WALKER COUNTY PRECINCT 2 AT LEAST 48 HOURS PRIOR TO CONSTRUCTION

Kevin P. Lash, PE
The Aspen Utility Company, LLC
2305 West Loop South, Suite 200
Houston, TX 77027
+1 (702) 692-3981



LAMBERT: N/A
DATE: 06/16/2025
KEY MAP NO. 33M
SCALE: 1" = 40'

DESIGNED BY:
QUANTA TELECOM SERVICES
DWG. NO. 12 OF 28
SHEET NO. 12 OF 28




JB1767579 - 26 DARRELL WHITE RD,
HUNTSVILLE, TX 77340

COMCAST PROPOSES TO INSTALL FIBER OPTIC CABLE
COMCAST PROPOSES TO PLACE DIRECTIONAL BORE DRILL TO INSTALL FIBER
OPTIC CABLE TO PROVIDE SERVICE TO 26 DARRELL WHITE RD, HUNTSVILLE, TX
77340 INSIDE THE ROW OF THE WALKER COUNTY, TX
TOTAL PROJECT FOOTAGE: 81W



26 DARRELL WHITE RD, HUNTSVILLE, TX 77340 PLAN VIEW 11 OF 23

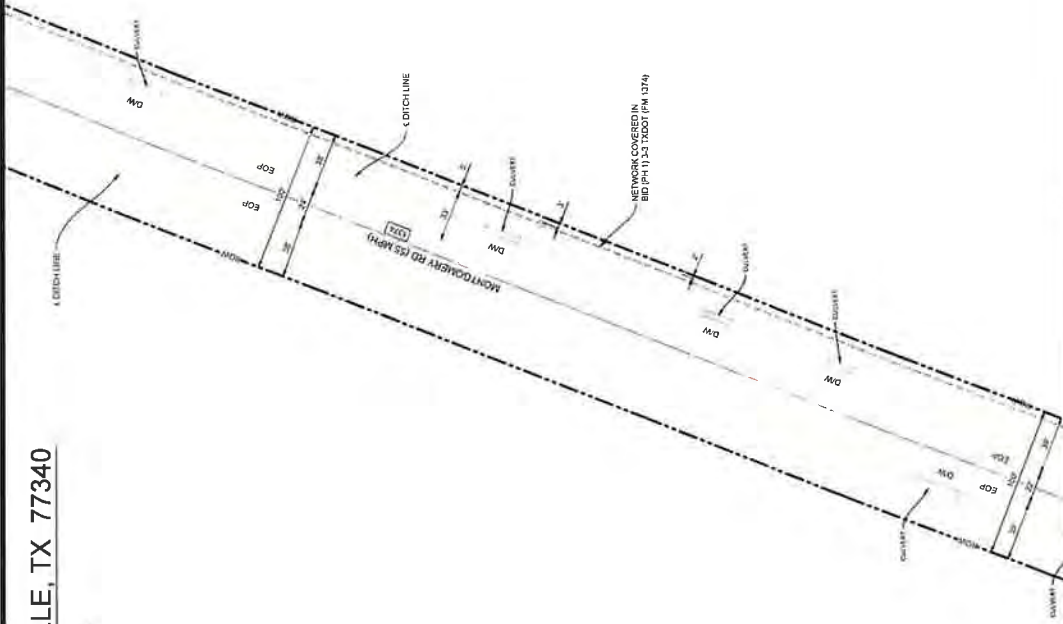

NOTES

1. THE WALKER COUNTY WILL BE NOTIFIED IN WRITING 48 HOURS PRIOR TO COMMENCING WORK.
2. THE WALKER COUNTY UTILITIES DEPARTMENT AND PUBLIC WORKS DEPARTMENT WILL BE NOTIFIED FOR LINE LOCATES AT (888) 498-4099.
3. THE CONTRACTOR SHALL CONTACT TEXAS ONE CALL SYSTEM AT 1-800-345-4545 MIN 48 HOURS BEFORE DIGGING.
4. THE CONTRACTOR SHALL DETERMINE THE EXACT LOCATION OF ALL UTILITIES PRIOR TO ANY EXCAVATION. THE CONTRACTOR SHALL BE FULLY RESPONSIBLE FOR ALL DAMAGES CAUSED BY HIS FAILURE TO EXACTLY LOCATE AND PRESERVE ALL UNDERGROUND FACILITIES.
5. NO MORE TRENCH OPENED AT ONE TIME THAN CAN BE BACKFILLED AND COMPACTED IN 10' LIFTS AT THE END OF EACH DAY (NO TRENCH LEFT OPENED OVERNIGHT).
6. ALL EXCESS EXCAVATION TO BE REMOVED FROM THE ROAD RIGHT-OF-WAY AT THE END OF EACH DAY.
7. DITCHES TO BE OPENED AT THE END OF EACH DAY TO ASSURE ADEQUATE DRAINAGE.
8. ROAD MUST BE KEPT OPEN TO TRAFFIC AND CONTRACTOR MUST MAINTAIN ADEQUATE TRAFFIC CONTROL, SIGNALS, ETC. TO PROVIDE COMPLETE SAFETY TO THE PUBLIC.
9. IF IT BECOMES NECESSARY FOR EQUIPMENT TO OPERATE ON A PORTION OF THE PAVEMENT PRECAUTIONS MUST BE TAKEN TO PREVENT ANY DAMAGE WHATSOEVER TO THE PAVEMENT.
10. CONDITION OF ROAD UPON COMPLETION OF JOB SHALL BE AS GOOD OR BETTER THAN PRIOR TO STARTING.
11. CONTRACTOR SHALL COMPLY WITH ALL APPLICABLE NATIONAL, STATE, AND LOCAL REQUIREMENTS FOR THE PROTECTION OF ENERGY ELECTRIC POLE ATTACHMENT GUIDELINES & PROCEDURES AND ALL APPLICABLE LOCAL REQUIREMENTS AND REGULATIONS FOR THE PROTECTION OF AERIAL CABLE FACILITIES. 18" MIN. VERTICAL CLEARANCE.
12. ALL UTILITIES WILL BE IDENTIFIED BY POTHOLE BEFORE ANY CONSTRUCTION.
13. COMCAST WILL MAINTAIN (2FT) HORIZONTAL & VERTICAL SEPARATION FROM ANY EXISTING UTILITIES.
14. THE CONTRACTOR TO CONTACT WALKER COUNTY PRECINCT 2 AT LEAST 48 HOURS PRIOR TO CONSTRUCTION.

Kevin P. Lark, PE
The Aspen Group Company LLC
Firm No. 23338
2605 Highway 100, Suite 100
Huntsville, TX 77340
+1 (713) 450-3691



DESIGNED BY:
QUANTA TELECOM SERVICES
DWG. NO.
SHEET NO. 13 OF 28



JB1767579 - 26 DARRELL WHITE RD,
HUNTSVILLE, TX 77340

COMCAST PROPOSES TO INSTALL FIBER OPTIC CABLE
COMCAST PROPOSES TO PLACE DIRECTIONAL BORE 9/8 FT TO INSTALL FIBER
OPTIC CABLE TO PROVIDE SERVICE TO 26 DARRELL WHITE RD HUNTSVILLE TX
77340, INSIDE THE ROW OF THE WALKER COUNTY, TX.
TOTAL PROJECT FOOTAGE: 878'



LAMBERT: N/A
DATE: 08/19/2025
KEY MAP NO: 33M
SCALE: 1:40

26 DARRELL WHITE RD,
HUNTSVILLE, TX 77340
PLAN VIEW 12 OF 23

COMCAST PROPOSES TO INSTALL FIBER OPTIC CABLE
COMCAST PROPOSES TO PLACE DIRECTIONAL BORE 876 FT TO INSTALL FIBER
OPTIC CABLE 7740, INSIDE THE ROW OF THE WALKER COUNTY, TX
TOTAL PROJECT FOOTAGE 876

Comcast
of HOUSTON, LLC
900 W. DOWELL RD HOUSTON, TEXAS 77060

DESIGNED BY:
QUANTA TELECOM SERVICES
36502 HEMPSTEAD HWY, HOCKLEY,
TX 77447

JB17167579 - 26 DARRELL WHITE RD,
HUNTSVILLE, TX 77340

ASPEN
A S P E N
36502 HEMPSTEAD HWY, HOCKLEY,
TX 77447

ENGINEER SEAL
KAREN P. LARKY, PE
The Aspen Line Company, LLC
Firm No. 23258
16050 Highway 29, Suite 200
Hockley, TX 77447
+1 (702) 492 3691

NOTES
1. THE WALKER COUNTY WILL BE NOTIFIED IN WRITING 48 HOURS PRIOR
TO COMMENCING WORK.
2. THE WALKER COUNTY UTILITIES DEPARTMENT AND PUBLIC WORKS
DEPARTMENT WILL BE NOTIFIED FOR LINE LOCATES AT (850) 436-4936.
3. THE CONTRACTOR SHALL CONTACT TEXAS ONE CALL SYSTEM AT
1-800-245-4545 MIN. 48 HOURS BEFORE DIGGING.
4. THE CONTRACTOR SHALL DETERMINE THE EXACT LOCATION OF ALL
UNDERGROUND FACILITIES BEFORE COMMENCING WORK AND AGREE TO
BE FULLY RESPONSIBLE FOR ALL DAMAGES CAUSED BY HIS FAILURE TO
EXACTLY LOCATE AND PRESERVE ALL UNDERGROUND FACILITIES.
5. NO MORE TRENCH OPENED AT ONE TIME THAN CAN BE BACKFILLED AND
REINTEGRATED WITHIN THE SAME DAY AT THE END OF EACH DAY. (NO TRENCH LEFT
OPENED OVERNIGHT).
6. ALL EXCESS EXCAVATION TO BE REMOVED FROM THE ROAD
RIGHT-OF-WAY AT THE END OF EACH DAY.
7. DITCHES TO BE OPENED AT THE END OF EACH DAY TO ASSURE
ADEQUATE DRAINAGE.
8. ROAD MUST BE KEPT OPEN TO TRAFFIC AND CONTRACTOR MUST
PROVIDE ADEQUATE FLAGMEN, SIGNALS, ETC., TO PROVIDE COMPLETE
SAFETY TO THE PUBLIC.
9. IF IT BECOMES NECESSARY FOR EQUIPMENT TO OPERATE ON A PORTION
OF THE PAVEMENT, PRECAUTIONS MUST BE TAKEN TO PREVENT ANY
DAMAGE WHATSOEVER TO THE PAVEMENT.
10. CONDITION OF ROAD UPON COMPLETION OF JOB SHALL BE AS GOOD OR
BETTER THAN PRIOR TO STARTING.
11. CONTRACTOR SHALL COMPLY WITH ALL APPLICABLE NATIONAL,
ELECTRICAL SAFETY CODE (NEC) REQUIREMENTS, CENTERPOINT
UTILITY COMPANY'S STANDARD SPECIFICATIONS, AND ALL APPLICABLE LOCAL
REQUIREMENTS AND REGULATIONS FOR
PLACEMENT OF AERIAL CABLE FACILITIES. 18" MIN. VERTICAL
CLEARANCE.
12. ALL UTILITIES WILL BE IDENTIFIED BY POT HOLE BEFORE ANY
CONSTRUCTION.
13. COMCAST WILL MAINTAIN (2FT) HORIZONTAL & VERTICAL SEPARATION
FROM ANY EXISTING UTILITIES.
14. THE CONTRACTOR TO CONTACT WALKER COUNTY PRECINCT 2
AT LEAST 48 HOURS PRIOR TO CONSTRUCTION.

ENGINEER SEAL

Kenneth P. Lashy PE
The Aspen Utility Company, LLC
Firm No. 23556
30502 Hempstead Highway
Rockledge, TX 77467
*1 (702) 692-5681

6/27/2005

DESIGNED BY: QUANTA TELECOM SERVICES	LAMBERT: N/A
	DATE: 08/19/2025
	KEY MAP NO 33M
DWG. NO.	SCALE: 1:40
SHEET NO. 14 OF 28	

ASPEN
A HICKORY CREEK COMPANY

JB1767579 - 26 DARRELL WHITE RD,
HUNTSVILLE, TX 77340


COMCAST PROPOSES TO INSTALL FIBER OPTIC CABLE

COMCAST PROPOSES TO PLACE DIRECTIONAL BORE 976 FT TO INSTALL FIBER OPTIC CABLE TO PROVIDE SERVICE TO BARNWELL WHITE RD HUNTSVILLE, TX 77340, INSIDE THE ROW OF THE PALMER COUNTY, TX.

TOTAL PROJECT FOOTAGE 976



comcast
of HOUSTON, LLC
8600 W. TIDWELL RD., HOUSTON, TEXAS 77060

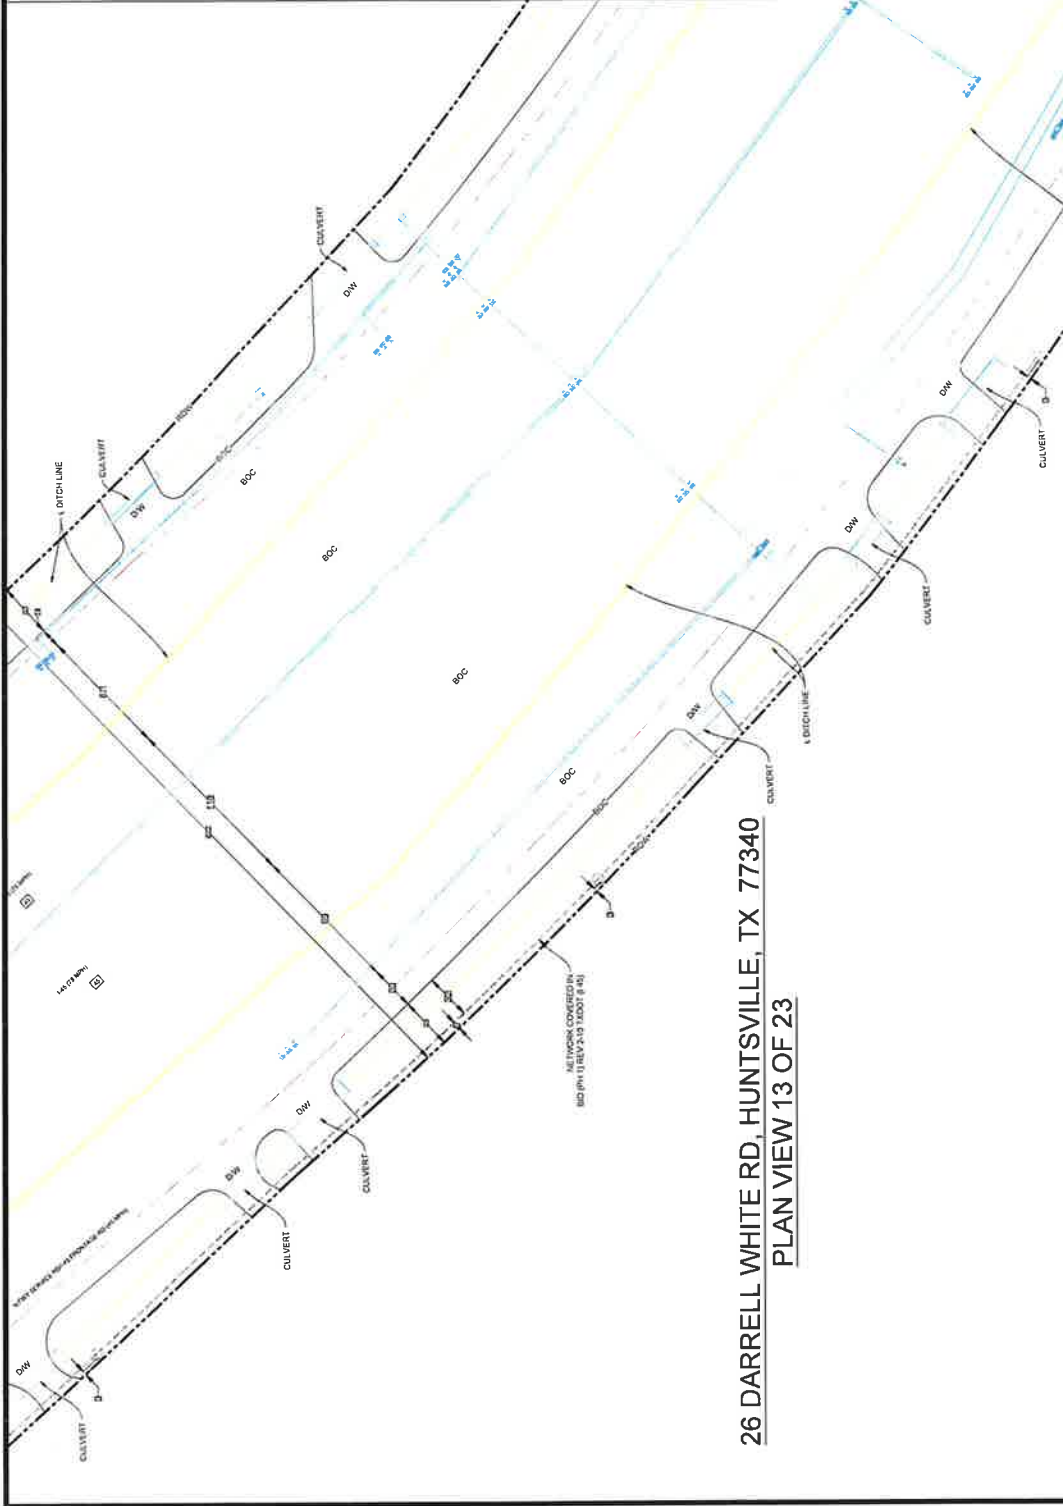

NOTES:

1. THE WALKER COUNTY WILL BE NOTIFIED IN WRITING 48 HOURS PRIOR TO COMMENCING WORK.
2. THE WALKER COUNTY UTILITIES DEPARTMENT AND PUBLIC WORKS DEPARTMENT WILL BE NOTIFIED FOR LINE LOCATES AT (936) 438-4839.
3. THE CONTRACTOR SHALL CONTACT TEXAS ONE CALL SYSTEM AT 1-800-368-4645 MIN. 48 HOURS BEFORE DIGGING.
4. THE CONTRACTOR SHALL DETERMINE THE EXACT LOCATION OF ALL EXISTING UTILITIES PRIOR TO ANY EXCAVATION. THE CONTRACTOR SHALL BE FULLY RESPONSIBLE FOR ALL DAMAGES CAUSED BY HIS FAILURE TO EXACTLY LOCATE AND PRESERVE ALL UNDERGROUND FACILITIES.
5. NO MORE TRENCH OPENED AT ONE TIME THAN CAN BE BACKFILLED AND COMPACTED IN 10' LIFTS AT THE END OF EACH DAY, (NO TRENCH LEFT OPENED OVERNIGHT).
6. ALL EXCESS EXCAVATION TO BE REMOVED FROM THE ROAD RIGHT-OF-WAY AT THE END OF EACH DAY.
7. STITCHES TO BE OPENED AT THE END OF EACH DAY TO ASSURE ADEQUATE DRAINAGE.
8. ROAD MUST BE KEPT OPEN TO TRAFFIC AND CONTRACTOR MUST MAINTAIN ADEQUATE TRAFFIC CONTROL, SIGNS, ETC., TO PROVIDE COMPLETE SAFETY TO THE PUBLIC.
9. IF IT BECOMES NECESSARY FOR EQUIPMENT TO OPERATE ON A PORTION OF THE ROAD PRIOR TO THE COMPLETION OF THE TRENCH, THE CONTRACTOR SHALL MAINTAIN ADEQUATE TRAFFIC CONTROL.
10. CONDITION OF ROAD UPON COMPLETION OF JOB SHALL BE AS GOOD OR BETTER THAN PRIOR TO STARTING.
11. CONTRACTOR SHALL COMPLY WITH ALL APPLICABLE NATIONAL, STATE, AND LOCAL REQUIREMENTS FOR THE PROTECTION OF EXISTING UTILITIES. THE CONTRACTOR SHALL MAINTAIN ADEQUATE CLEARANCE FOR ALL ENERGY ELECTRIC POLE ATTACHMENTS, GUIDELINES & PROCEDURES AND ALL APPLICABLE LOCAL REQUIREMENTS AND REGULATIONS FOR PLACEMENT OF AERIAL CABLE FACILITIES 18' MIN. VERTICAL CLEARANCE.
12. ALL UTILITIES WILL BE IDENTIFIED BY POTHOLE BEFORE ANY CONSTRUCTION.
13. COMCAST WILL MAINTAIN (2FT) HORIZONTAL & VERTICAL SEPARATION FROM ANY EXISTING UTILITIES.
14. THE CONTRACTOR TO CONTACT WALKER COUNTY PRECINCT 2 AT LEAST 48 HOURS PRIOR TO CONSTRUCTION.

Kevin P. Lusk, PE
The Aspen Utility Company, LLC
36502 Hempstead Highway
Huntsville, TX 77340
+1 (713) 400-3081



DESIGNED BY:
QUANTA TELECOM SERVICES

DATE: 08/11/2025
KEY MAP NO: 33M
SCALE: 1"=40'

DWG. NO.
JB1757579

SHEET NO. 15 OF 28

ASPEN
A QUANTA SERVICES COMPANY

36502 HEMPSTEAD HWY, HOCKLEY,
TX 77447

JB1757579 - 26 DARRELL WHITE RD,
HUNTSVILLE, TX 77340


COMCAST PROPOSES TO INSTALL FIBER OPTIC CABLE
COMCAST PROPOSES TO PLACE DIRECTIONAL BORE 9/16" FT TO INSTALL FIBER
OPTIC CABLE TO PROVIDE SERVICE TO 26 DARRELL WHITE RD, HUNTSVILLE TX
77340, INSIDE THE ROW OF THE WALKER COUNTY, TX.
TOTAL PROJECT FOOTAGE 876'



Comcast
#1 HOUSTON, LLC

6550 W. TIDWELL RD, HOUSTON, TEXAS 77060

SEP 02 2025

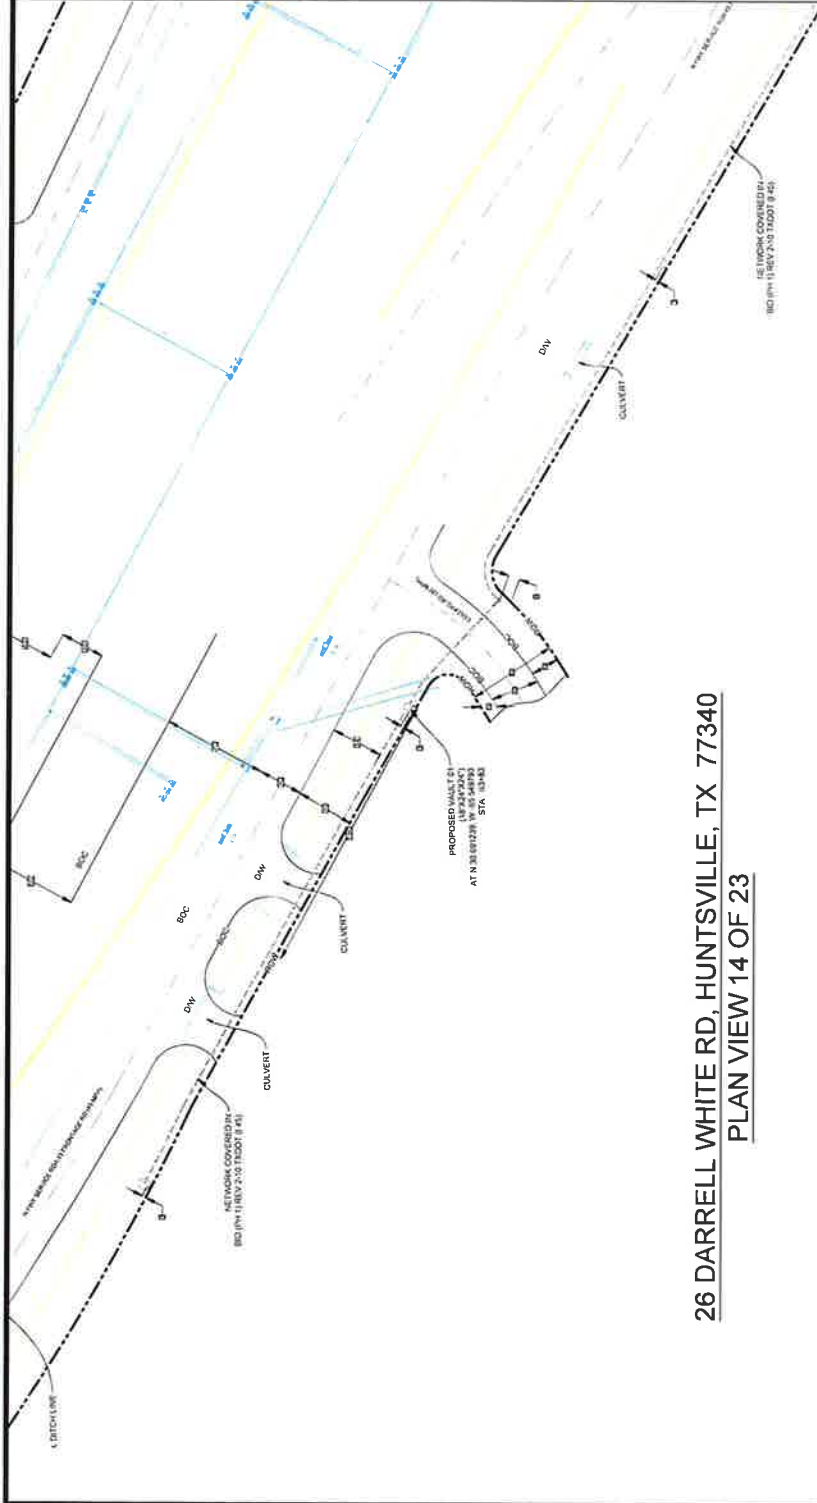

26 DARRELL WHITE RD, HUNTSVILLE, TX 77340
PLAN VIEW 14 OF 23

NOTES

1. THE WALKER COUNTY WILL BE NOTIFIED IN WRITING 48 HOURS PRIOR TO COMMENCING WORK.
2. THE WALKER COUNTY UTILITIES DEPARTMENT AND PUBLIC WORKS DEPARTMENT WILL BE NOTIFIED FOR LINE LOCATES AT (936) 436-4039.
3. THE CONTRACTOR SHALL CONTACT TEXAS ONE CALL SYSTEM AT 1-800-245-6449 MIN. 48 HOURS BEFORE DIGGING.
4. THE CONTRACTOR SHALL DETERMINE THE EXACT LOCATION OF ALL UTILITIES AND MARK THEM WITH FLAGGING. THE CONTRACTOR SHALL BE FULLY RESPONSIBLE FOR ALL DAMAGES CAUSED BY HIS FAILURE TO EXACTLY LOCATE AND PRESERVE ALL UNDERGROUND FACILITIES.
5. NO MORE TRENCH OPENED AT ONE TIME THAN CAN BE BACKFILLED AND COMPACTED IN 10' LIFTS AT THE END OF EACH DAY. (NO TRENCH LEFT OPENED OVERNIGHT).
6. ALL EXCESS EXCAVATION TO BE REMOVED FROM THE ROAD RIGHT-OF-WAY AT THE END OF EACH DAY.
7. DITCHES TO BE OPENED AT THE END OF EACH DAY TO ASSURE ADEQUATE DRAINAGE.
8. ROAD MUST BE KEPT OPEN TO TRAFFIC AND CONTRACTOR MUST PROVIDE ADEQUATE FLAGMEN, SIGNALS, ETC., TO PROVIDE COMPLETE SAFETY TO THE PUBLIC.
9. IF IT BECOMES NECESSARY FOR EQUIPMENT TO OPERATE ON A PORTION OF THE PAVEMENT, PRECAUTIONS MUST BE TAKEN TO PREVENT ANY DAMAGE WHATSOEVER TO THE PAVEMENT.
10. CONDITION OF ROAD UPON COMPLETION OF JOB SHALL BE AS GOOD OR BETTER THAN PRIOR TO STARTING.
11. CONTRACTOR SHALL COMPLY WITH ALL APPLICABLE NATIONAL, ELECTRICAL, SAFETY CODE (NECA), REQUIREMENTS, CENTERPOINT ENERGY ELECTRICAL POLE ATTACHMENT GUIDELINES & PROCEDURES AND ALL APPLICABLE LOCAL REQUIREMENTS AND REGULATIONS FOR ERECTION OF AERIAL CABLE FACILITIES, 18\"/>
12. ALL UTILITIES WILL BE IDENTIFIED BY POTHOLE BEFORE ANY CONSTRUCTION.
13. COMCAST WILL MAINTAIN 8FT HORIZONTAL & VERTICAL SEPARATION FROM ANY EXISTING UTILITIES.
14. THE CONTRACTOR TO CONTACT WALKER COUNTY PRECINCT 2 AT LEAST 48 HOURS PRIOR TO CONSTRUCTION.

ENGINEER SEAL

Kevon P. Lusk, PE
The Aspen Utility Company, LLC
P.O. Box 23306
Houston, TX 77242
• (713) 463-3801



COMCAST PROPOSES TO INSTALL FIBER OPTIC CABLE
COMCAST PROPOSES TO PLACE DIRECTIONAL BORE 1/4\"/>



JB1767579 - 26 DARRELL WHITE RD,
HUNTSVILLE, TX 77340


DESIGNED BY:
QUANTA TELECOM SERVICES

DWG. NO. 16 OF 28
SHEET NO. 16 OF 28

LAMBERT: N/A
DATE: 08/19/2025
KEY MAP NO. 33M
SCALE: 1:40



PLAN VIEW 15 OF 23

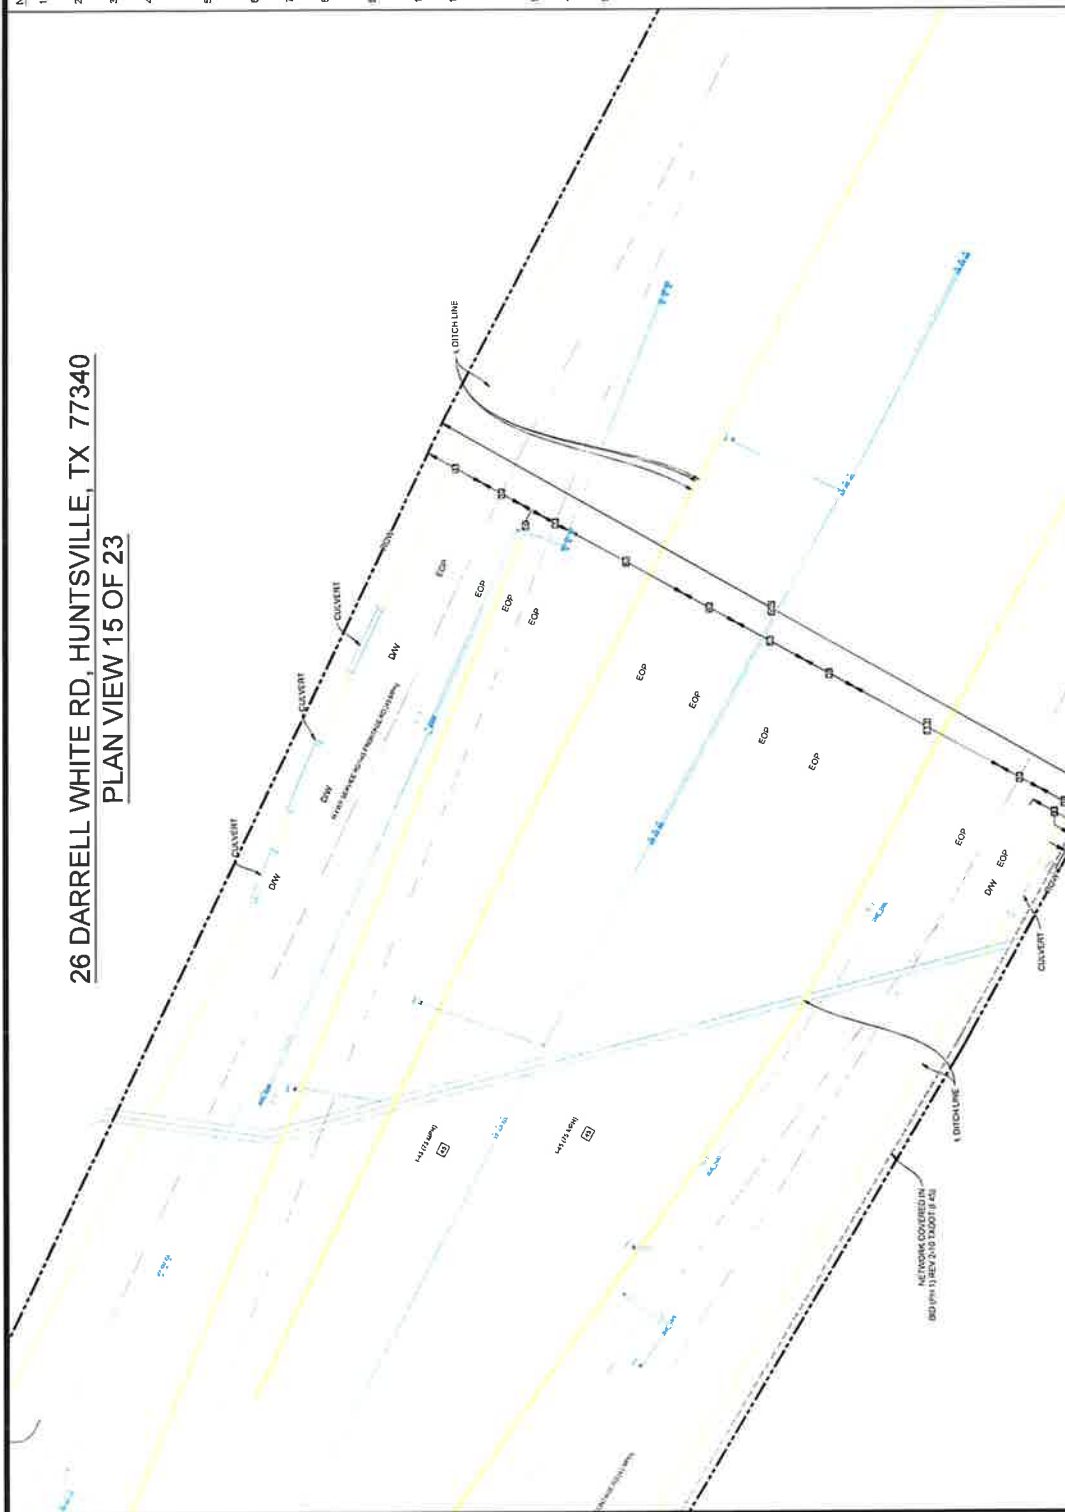

1. THE WALKER COUNTY WILL BE NOTIFIED IN WRITING 48 HOURS PRIOR TO COMMENCING WORK.
2. THE WALKER COUNTY UTILITIES DEPARTMENT AND PUBLIC WORKS DEPARTMENT WILL BE NOTIFIED IN LINE LOCATES AT (936) 494-8339
3. THE CONTRACTOR SHALL CONTACT TEXAS ONE CALL SYSTEM AT 1-800-254-4505 MIN. 48 HOURS BEFORE DIGGING.
4. THE CONTRACTOR SHALL DETERMINE THE EXACT LOCATION OF ALL UTILITIES TO BE FULLY RESPONSIBLE FOR ALL DAMAGES CAUSED BY HIS FAILURE TO EXACTLY LOCATE AND PRESERVE ALL UNDERGROUNDS FACILITIES.
5. NO MORE TRENCH DEPTH AT ONE TIME THAN CAN BE BACKFILLED AND COMPACTED IN 10' LIFTS AT THE END OF EACH DAY. (NO TRENCH LEFT OPENED OVERNIGHT).
6. ALL EXCESS EXCAVATION TO BE REMOVED FROM THE ROAD RIGHT-OF-WAY AT THE END OF EACH DAY.
7. DITCHES TO BE OPENED AT THE END OF EACH DAY TO ASSURE ADEQUATE DRAINAGE.
8. ROAD MUST BE KEPT OPEN TO TRAFFIC AND CONTRACTOR MUST PROVIDE ADEQUATE FLAGMEN, SIGNALS, ETC., TO PROVIDE COMPLETE SAFETY TO THE PUBLIC.
9. IF IT BECOMES NECESSARY FOR EQUIPMENT TO OPERATE ON A PORTION OF THE PAVEMENT, PRECAUTIONS MUST BE TAKEN TO PREVENT ANY DAMAGE WHATSOEVER TO THE PAVEMENT.
10. CONDITION OF ROAD UPON COMPLETION OF JOB SHALL BE AS GOOD OR BETTER THAN PRIOR TO STARTING.
11. CONTRACTOR SHALL COMPLY WITH ALL APPLICABLE NATIONAL ELECTRICAL SAFETY CODE (NEC) REQUIREMENTS, CIRCUMFERENCE AND ELECTRICAL SLEEVES SHALL BE USED TO PROTECT ALL CABLES AND ALL APPLICATIONS OF ELECTRICAL MATERIALS AND PRIOR TO ANY TRENCH PLACEMENT OF AERIAL CABLE FACILITIES, 18" MIN VERTICAL CLEARANCE
12. ALL UTILITIES WILL BE IDENTIFIED BY POTHOLE BEFORE ANY CONSTRUCTION
13. COMCAST WILL MAINTAIN (27') HORIZONTAL & VERTICAL SEPARATION FROM ANY EXISTING UTILITIES
14. THE CONTRACTOR TO CONTACT WALKER COUNTY PRECINCT 2 AT LEAST 48 HOURS PRIOR TO CONSTRUCTION.

6/23/2025

N
DATE: 08/19/2025
KEY MAP NO. 33M
SCALE: 1:40

ASPEN
A QUANTA SERVICES COMPANY
36502 HEMPSTEAD HWY. #100
DALLAS, TX 77447

JB1767579 - 26 DARRELL WHITE RD,
HUNTSVILLE, TX 77340


COMCAST PROPOSES TO INSTALL FIBER OPTIC CABLE
COMCAST PROPOSES TO PLACE DIRECTIONAL BORE 976 FT TO INSTALL FIBER
OPTIC CABLE TO PROVIDE SERVICE TO 28 DARRELL WHITE RD, HUNTSVILLE, TX
77340. INSIDE THE ROW OF THE WALKER COUNTY, TX.

TOTAL PROJECT FOOTAGE 976'



comcast
#HOUSTON, LLC
5900 W. TIDWELL RD. HOUSTON, TEXAS 77060

SEP 02 2025

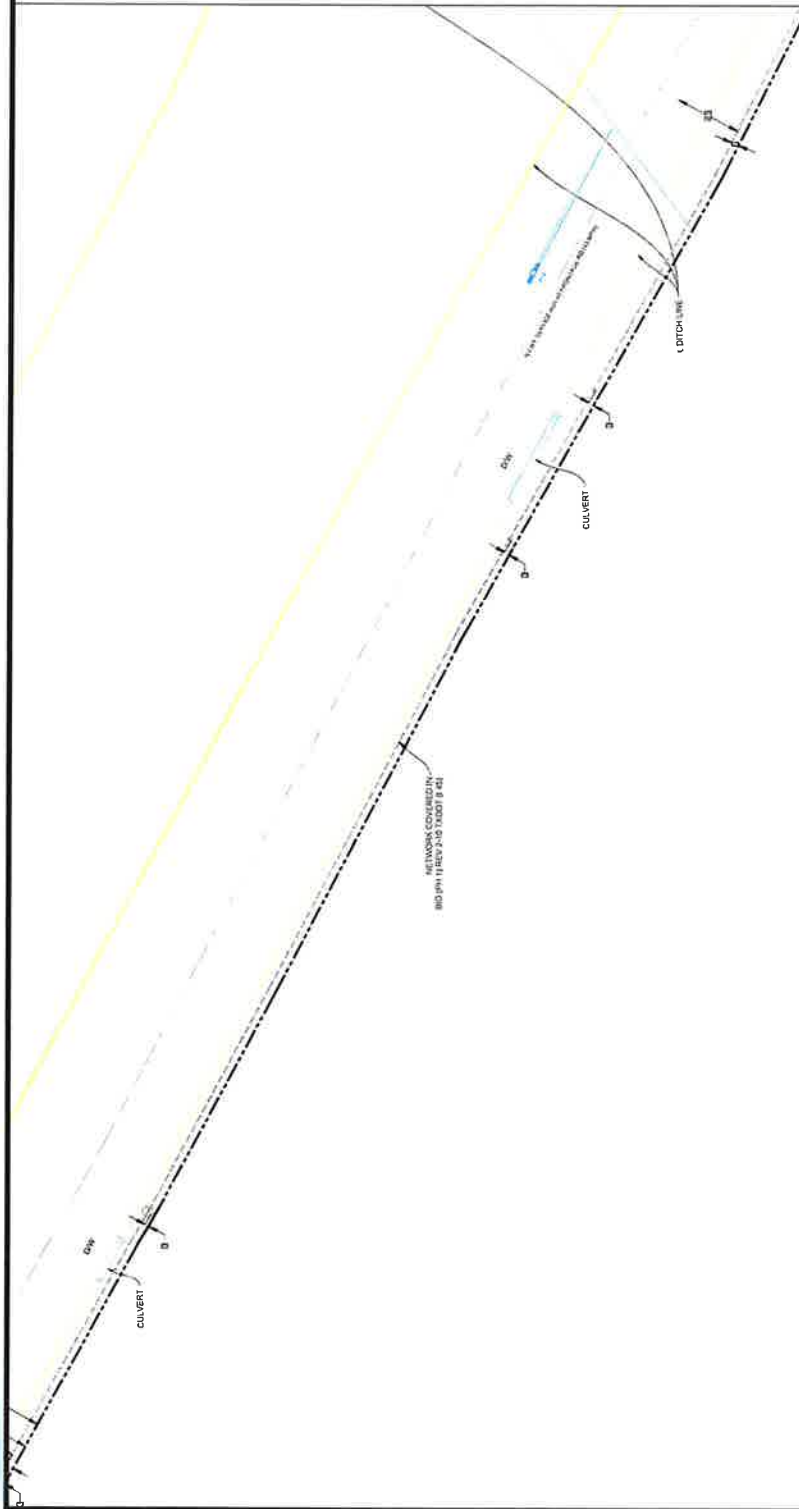

26 DARRELL WHITE RD, HUNTSVILLE, TX 77340
PLAN VIEW 16 OF 23

Kenneth P. Lusk, PE
The Aspen Utility Company, LLC
10000 N. Loop West, Suite 200
Houston, TX 77047
+1 (713) 663-3691



NOTES:

1. THE WALKER COUNTY WILL BE NOTIFIED IN WRITING 48 HOURS PRIOR TO COMMENCING WORK.
2. THE WALKER COUNTY UTILITIES DEPARTMENT AND PUBLIC WORKS DEPARTMENT WILL BE NOTIFIED FOR LINE LOCATES AT (336) 436-4039.
3. THE CONTRACTOR SHALL CONTACT TEXAS ONE CALL SYSTEM AT 1-800-368-5848 MIN. 48 HOURS BEFORE DIGGING.
4. THE CONTRACTOR SHALL DETERMINE THE EXACT LOCATION OF ALL UNDERGROUND FACILITIES BEFORE COMMENCING WORK AND AGREE TO BE FULLY RESPONSIBLE FOR ALL DAMAGES CAUSED BY HIS FAILURE TO EXACTLY LOCATE AND PRESERVE ALL UNDERGROUND FACILITIES.
5. NO MORE TRENCH OPENED AT ONE TIME THAN CAN BE BACKFILLED AND COMPACTED IN 10' LIFTS AT THE END OF EACH DAY. (NO TRENCH LEFT OPENED OVERNIGHT).
6. ALL EXCESS EXCAVATION TO BE REMOVED FROM THE ROAD RIGHT-OF-WAY AT THE END OF EACH DAY.
7. DITCHES TO BE OPENED AT THE END OF EACH DAY TO ASSURE ADEQUATE DRAINAGE.
8. ROAD MUST BE KEPT OPEN TO TRAFFIC AND CONTRACTOR MUST PROVIDE ADEQUATE FLAGMEN, SIGNALS, ETC., TO PROVIDE COMPLETE SAFETY TO THE PUBLIC.
9. IF IT BECOMES NECESSARY FOR EQUIPMENT TO OPERATE ON A PORTION OF THE PAVEMENT, PRECAUTIONS MUST BE TAKEN TO PREVENT ANY DAMAGE WHATSOEVER TO THE PAVEMENT.
10. CONDITION OF ROAD UPON COMPLETION OF JOB SHALL BE AS GOOD OR BETTER THAN PRIOR TO STARTING.
11. CONTRACTOR SHALL COMPLY WITH ALL APPLICABLE NATIONAL ELECTRICAL SAFETY CODE (NEC) REQUIREMENTS, CENTERPOINT ENERGY ELECTRIC POLE ATTACHMENT GUIDELINES & PROCEDURES AND ALL OTHER REQUIREMENTS FOR THE PROTECTION OF ALL UTILITIES FOR PLACEMENT OF AERIAL CABLE FACILITIES. 18" MIN. VERTICAL CLEARANCE.
12. ALL UTILITIES WILL BE IDENTIFIED BY POTHOLE BEFORE ANY CONSTRUCTION.
13. COMCAST WILL MAINTAIN OPT. HORIZONTAL & VERTICAL SEPARATION FROM ANY EXISTING UTILITIES.
14. THE CONTRACTOR TO CONTACT WALKER COUNTY PRECINCT 2 AT LEAST 48 HOURS PRIOR TO CONSTRUCTION.



COMCAST PROPOSES TO INSTALL FIBER OPTIC CABLE
COMCAST PROPOSES TO PLACE DIRECTIONAL BORE 674 FT TO INSTALL FIBER OPTIC CABLE TO PROVIDE SERVICE TO 26 DARRELL WHITE RD, HUNTSVILLE, TX 77340 INSIDE THE ROW OF THE WALKER COUNTY, TX.
TOTAL PROJECT FOOTAGE: 976'

JB1767579 - 26 DARRELL WHITE RD,
HUNTSVILLE, TX 77340




36502 HEMPSTEAD HWY, HOCKLEY,
TX 77447

DESIGNED BY:
QUANTA TELECOM SERVICES

DWG. NO.
SHEET NO. 18 OF 28

LAMBERT: IVA
DATE: 08/09/2025
KEY MAP NO. 33M
SCALE: 1" = 40'



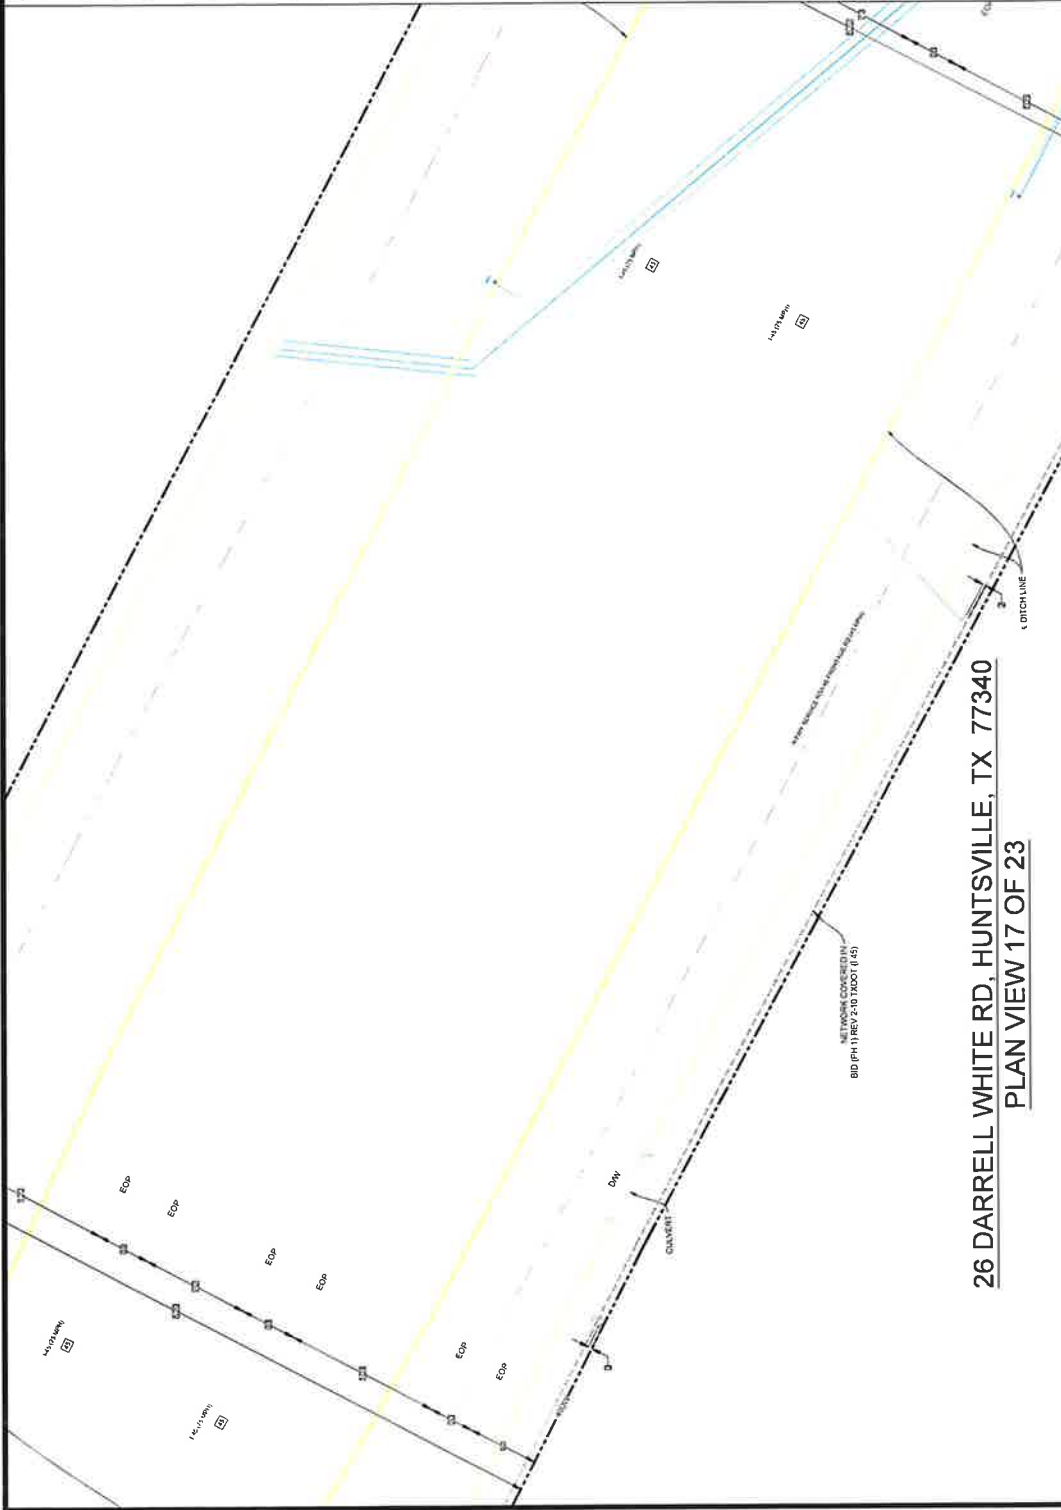


26 DARRELL WHITE RD, HUNTSVILLE, TX 77340
PLAN VIEW 17 OF 23

NOTES:


1. THE WALKER COUNTY WILL BE NOTIFIED IN WRITING 48 HOURS PRIOR TO COMMENCING WORK.
2. THE WALKER COUNTY UTILITIES DEPARTMENT AND PUBLIC WORKS DEPARTMENT WILL BE NOTIFIED FOR LINE LOCATES AT (830) 496-4899.
3. THE CONTRACTOR SHALL CONTACT TEXAS ONE CALL SYSTEM AT 1-800-245-4545 MIN. 48 HOURS BEFORE DIGGING.
4. THE CONTRACTOR SHALL DETERMINE THE EXACT LOCATION OF ALL UNDERGROUND FACILITIES BEFORE COMMENCING WORK AND AGREE TO BE FULLY RESPONSIBLE FOR ALL DAMAGES CAUSED BY HIS FAILURE TO EXACTLY LOCATE AND PRESERVE ALL UNDERGROUND FACILITIES.
5. NO MORE TRENCH OPENED AT ONE TIME THAN CAN BE BACKFILLED AND COMPACTED IN 10' LIFTS AT THE END OF EACH DAY. (NO TRENCH LEFT OPENED OVERNIGHT).
6. ALL EXCESS EXCAVATION TO BE REMOVED FROM THE ROAD RIGHT-OF-WAY AT THE END OF EACH DAY.
7. DITCHES TO BE OPENED AT THE END OF EACH DAY TO ASSURE ADEQUATE DRAINAGE.
8. ROAD MUST BE LEFT OPEN TO TRAFFIC AND CONTRACTORS MUST PROVIDE ADEQUATE FLAGMEN, SIGNALS, ETC., TO PROVIDE COMPLETE SAFETY TO THE PUBLIC.
9. IF IT BECOMES NECESSARY FOR EQUIPMENT TO OPERATE ON A PORTION OF THE PAVEMENT, PRECAUTIONS MUST BE TAKEN TO PREVENT ANY DAMAGE WHATSOEVER TO THE PAVEMENT.
10. CONDITION OF ROAD UPON COMPLETION OF JOB SHALL BE AS GOOD OR BETTER THAN PRIOR TO STARTING.
11. CONTRACTOR SHALL COMPLY WITH ALL APPLICABLE NATIONAL ELECTRICAL SAFETY CODE (NEC) REQUIREMENTS, CENTERPOINT ENERGY ELECTRIC POLE ATTACHMENT GUIDELINES & PROCEDURES AND ALL APPLICABLE LOCAL REQUIREMENTS AND REGULATIONS FOR CLEARANCE OF ASPHALT, CABLE FACILITIES, 14\"/>
12. ALL UTILITIES WILL BE IDENTIFIED BY POT HOLE BEFORE ANY CONSTRUCTION.
13. COMCAST WILL MAINTAIN (2FT) HORIZONTAL & VERTICAL SEPARATION FROM ANY EXISTING UTILITIES.
14. THE CONTRACTOR TO CONTACT WALKER COUNTY PRECINCT 2 AT LEAST 48 HOURS PRIOR TO CONSTRUCTION.

 Kenn F. Lash, PE
The Aspen Utility Company, LLC
Emp No. 23506
36502 Hempstead Highway
Huntsville, TX 77340
+1 (832) 452-3891



 8550 W. TIDWELL RD. HOUSTON, TEXAS 77060		COMCAST PROPOSES TO INSTALL FIBER OPTIC CABLE COMCAST PROPOSES TO PLACE DIRECTIONAL LORE 878 FT TO INSTALL FIBER OPTIC CABLE TO PROVIDE SERVICE TO 26 DARRELL WHITE RD, HUNTSVILLE, TX 77340, INSIDE THE ROW OF THE WALKER COUNTY, TX. TOTAL PROJECT FOOTAGE 878'	JBT1767579 - 26 DARRELL WHITE RD, HUNTSVILLE, TX 77340	 36502 HEMPSTEAD HWY, HOCKLEY, TX 77447	DESIGNED BY: QUANTA TELECOM SERVICES DWG. NO. _____ SHEET NO. 19 OF 28	LAURENT: N/A DATE: 08/19/2025 KEY MAP NO. 33M SCALE: 1:40
---	---	---	---	---	---	--

SEP 02 2025

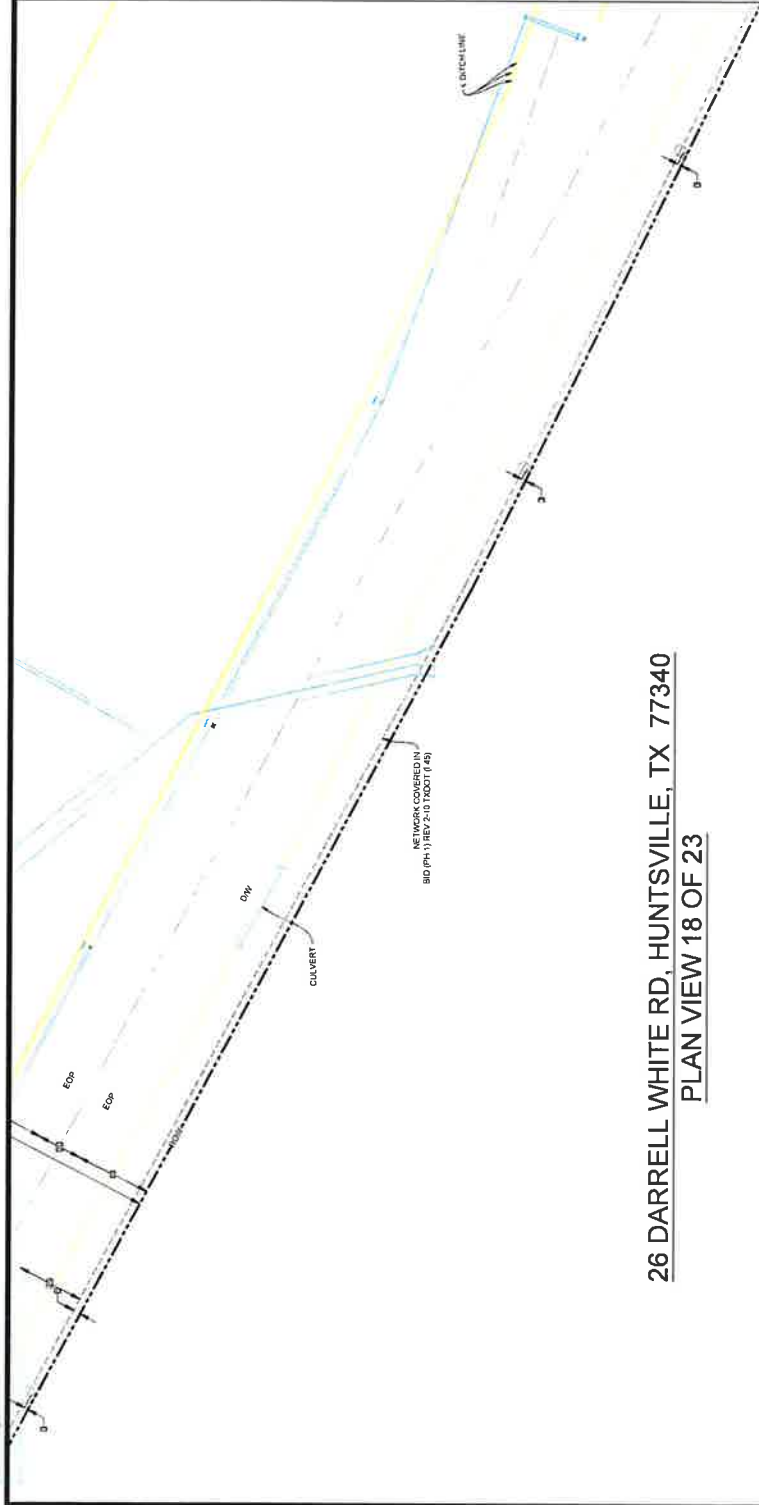

26 DARRELL WHITE RD, HUNTSVILLE, TX 77340
PLAN VIEW 18 OF 23

NOTES:

1. THE WALKER COUNTY WILL BE NOTIFIED IN WRITING 48 HOURS PRIOR TO COMMENCING WORK.
2. THE WALKER COUNTY UTILITIES DEPARTMENT AND PUBLIC WORKS DEPARTMENT WILL BE NOTIFIED FOR LINE LOCATES AT (936) 436-4339.
3. THE CONTRACTOR SHALL CONTACT TEXAS ONE CALL SYSTEM AT 1-800-368-5846 MIN. 48 HOURS BEFORE DIGGING.
4. THE CONTRACTOR SHALL DETERMINE THE EXACT LOCATION OF ALL UNDERGROUND FACILITIES BEFORE COMMENCING WORK AND AGREE TO BE FULLY RESPONSIBLE FOR ALL DAMAGES CAUSED BY HIS FAILURE TO EXACTLY LOCATE AND PRESERVE ALL UNDERGROUND FACILITIES.
5. NO MORE TRENCH OPENED AT ONE TIME THAN CAN BE BACKFILLED AND COMPACTED IN 10' LIFTS AT THE END OF EACH DAY. (NO TRENCH LEFT OPENED OVERNIGHT).
6. ALL EXCESS EXCAVATION TO BE REMOVED FROM THE ROAD RIGHT-OF-WAY AT THE END OF EACH DAY.
7. DITCHES TO BE OPENED AT THE END OF EACH DAY TO ASSURE ADEQUATE DRAINAGE.
8. ROAD MUST BE KEPT OPEN TO TRAFFIC AND CONTRACTOR MUST PROVIDE ADEQUATE FLAGMEN, SIGNALS, ETC. TO PROVIDE COMPLETE SAFETY TO THE PUBLIC.
9. IF IT BECOMES NECESSARY FOR EQUIPMENT TO OPERATE ON A PORTION OF THE PAVEMENT, PRECAUTIONS MUST BE TAKEN TO PREVENT ANY DAMAGE WHATSOEVER TO THE PAVEMENT.
10. CONDITION OF ROAD UPON COMPLETION OF JOB SHALL BE AS GOOD OR BETTER THAN PRIOR TO STARTING.
11. CONTRACTOR SHALL COMPLY WITH ALL APPLICABLE NATIONAL ELECTRICAL SAFETY CODE (NEC) REQUIREMENTS, CENTERPOINT ENERGY ELECTRIC POLE ATTACHMENT GUIDELINES & PROCEDURES AND ALL OTHER REQUIREMENTS AND STANDARDS FOR THE PROPER PLACEMENT OF AERIAL CABLE FACILITIES, 18" MIN. VERTICAL CLEARANCE.
12. ALL UTILITIES WILL BE IDENTIFIED BY POTHOLE BEFORE ANY CONSTRUCTION.
13. COMCAST WILL MAINTAIN 10' HORIZONTAL & VERTICAL SEPARATION FROM ANY EXISTING UTILITIES.
14. THE CONTRACTOR TO CONTACT WALKER COUNTY PRECINCT 2 AT LEAST 48 HOURS PRIOR TO CONSTRUCTION.

Kenneth P. Lusk, PE
The Aspen Utility Company, LLC
10000 N. Loop West, Suite 200
Houston, TX 77047
+1 (713) 463-2931

ENGINEER SEAL



COMCAST PROPOSES TO INSTALL FIBER OPTIC CABLE
COMCAST PROPOSES TO PLACE DIRECTIONAL BORE START TO INSTALL FIBER OPTIC CABLE TO PROVIDE SERVICE TO 26 DARRELL WHITE RD HUNTSVILLE, TX 77340, INSIDE THE ROW OF THE WALKER COUNTY, TX.
TOTAL PROJECT FOOTAGE: 878'

JB1767579 - 26 DARRELL WHITE RD,
HUNTSVILLE, TX 77340



36502 HEMPSTEAD HWY, HOCKLEY,
TX 77447

DESIGNED BY:
QUANTA TELECOM SERVICES

DWG. NO.
SHEET NO. 20 OF 28

LAMBERT, WA

DATE: 08/19/2025

KEY MAP NO. 33M

SCALE: 1" = 40'



 800 W. TIDWELL RD. HOUSTON, TEXAS 77060	 811 TEXAS	COMCAST PROPOSES TO INSTALL FIBER OPTIC CABLE COMCAST PROPOSES TO PLACE DIRECTIONAL BORE 678 FT TO INSTALL FIBER OPTIC CABLE 11.75' FROM THE ROW OF THE WALKER COUNTY, TX 77340, INSIDE THE ROW OF THE WALKER COUNTY, TX TOTAL PROJECT FOOTAGE: 678'	JB1767579 - 26 DARRELL WHITE RD, HUNTSVILLE, TX 77340	 35502 HEMPSTEAD HWY. HOCKLEY, TX 77447	DESIGNED BY: QUANTA TELECOM SERVICES DWG. NO. 22 OF 28 SHEET NO. 22 OF 28 LAWBERT: MIA DATE: 06/19/2025 KEY MAP NO: 33M SCALE: 1" = 40'
--	--	--	--	--	--

NOTES

1. THE WALKER COUNTY WILL BE NOTIFIED IN WRITING 48 HOURS PRIOR TO COMMENCING WORK.
2. THE WALKER COUNTY UTILITIES DEPARTMENT AND PUBLIC WORKS DEPARTMENT WILL BE NOTIFIED FOR LINE LOCATES AT (936) 456-8839.
3. THE CONTRACTOR SHALL CONTACT TEXAS ONE CALL SYSTEM AT 1-800-245-4545 MIN. 48 HOURS BEFORE DIGGING.
4. THE CONTRACTOR SHALL DETERMINE THE EXACT LOCATION OF ALL UNDERGROUND UTILITIES PRIOR TO ANY EXCAVATION. THE CONTRACTOR SHALL BE FULLY RESPONSIBLE FOR ALL DAMAGES CAUSED BY HIS FAILURE TO EXACTLY LOCATE AND PRESERVE ALL UNDERGROUND FACILITIES.
5. NO MORE TRENCH OPENED AT ONE TIME THAN CAN BE BACKFILLED AND COMPACTED IN 10' LIFTS AT THE END OF EACH DAY. (NO TRENCH LEFT OPENED OVERNIGHT).
6. ALL EXCESS EXCAVATION TO BE REMOVED FROM THE ROAD RIGHT-OF-WAY AT THE END OF EACH DAY.
7. DITCHES TO BE OPENED AT THE END OF EACH DAY TO ASSURE ADEQUATE DRAINAGE.
8. ROAD MUST BE KEPT OPEN TO TRAFFIC AND CONTRACTOR MUST PROVIDE ADEQUATE FLAGMEN, SIGNALS, ETC., TO PROVIDE COMPLETE SAFETY TO THE PUBLIC.
9. IF IT BECOMES NECESSARY FOR EQUIPMENT TO OPERATE ON A PORTION OF THE PAVEMENT, PRECAUTIONS MUST BE TAKEN TO PREVENT ANY DAMAGE WHATSOEVER TO THE PAVEMENT.
10. CONDITION OF ROAD UPON COMPLETION OF JOB SHALL BE AS GOOD OR BETTER THAN PRIOR TO STARTING.
11. CONTRACTOR SHALL COMPLY WITH ALL APPLICABLE NATIONAL ELECTRICAL SAFETY CODE (NEC) REQUIREMENTS, CENTERPOINT ENERGY ELECTRIC POLE ATTACHMENT GUIDELINES & PROCEDURES AND ALL OTHERS. CONTRACTOR SHALL MAINTAIN MINIMUM 10' CLEARANCE FOR PLACEMENT OF AERIAL CABLE FACILITIES, 10' MIN. VERTICAL CLEARANCE.
12. ALL UTILITIES WILL BE IDENTIFIED BY POT HOLE BEFORE ANY CONSTRUCTION.
13. CONTRACTOR WILL MAINTAIN 8'7" HORIZONTAL & VERTICAL SEPARATION FROM ANY EXISTING UTILITIES.
14. THE CONTRACTOR TO CONTACT WALKER COUNTY PRECINCT 2 AT LEAST 48 HOURS PRIOR TO CONSTRUCTION.

Kenn P. Lusk, PE
The Aspen Utility Company, LLC
35502 Hempstead Highway
Hockley, TX 77447
+1 (281) 693-2693

ENGINEER SEAL





- ENGINEER SEAL

Kern P. Lasky, PE
The Aspen Utility Company, LLC
Firm No. 23536
30502 Hemphill Highway
Hockley, TX 77447
-1 (702) 490-3691



LAMBERT, NIA
DATE 08/19/20
KEY MAP NO: 3
SCALE 1:40

DESIGNED BY:
QUANTA TELECOM SERVICES

DWG. NO.
SHEET NO. 23 OF 28



36502 HEMPSTEAD HWY. HOCKLEY,
TX 77447

JB1767579 - 26 DARRELL WHITE RD,
HUNTSVILLE, TX 77340

COMCAST PROPOSES TO INSTALL FIBER OPTIC CABLE

COMCAST PROPOSES TO PLACE DIRECTIONAL BORE 976 FT TO INSTALL FIBER OPTIC CABLE TO PROVIDE SERVICE TO 28 DARRILL WHITE RD, HUNTSVILLE, TX 77340, INSIDE THE ROW OF THE WALKER COUNTY, TX.

TOTAL PROJECT FOOTAGE 976'



3590 W TIDWELL RD, HOUSTON, TEXAS 77040

26 DARRELL WHITE RD, HUNTSVILLE, TX 77340

PLAN VIEW 22 OF 23

Comcast
of Houston, LLC
8550 W. TIDWELL RD HOUSTON, TEXAS 77060

Texas 811

COMCAST PROPOSES TO INSTALL FIBER OPTIC CABLE
COMCAST PROPOSES TO PLACE DIRECTIONAL BORE 9/16 FT TO INSTALL FIBER OPTIC CABLE ALONG THE ROW OF THE WALKER COUNTY, TX
TOTAL PROJECT FOOTAGE 976'

**JB1767579 - 26 DARRELL WHITE RD,
HUNTSVILLE, TX 77340**

ASPEN
CONSULTING ENGINEERS & ARCHITECTS
P.C.
36502 HEMPSTEAD HWY, HOCKLEY
TX 77447

**DESIGNED BY:
QUANTA TELECOM SERVICES**

**DWG. NO. 24 OF 28
SHEET NO. 24 OF 28**

LAMBERT N/A
DATE: 09/02/23
KEY MAP NO: 33M
SCALE: 1"=40'

 
ENGINEER SEAL
Kerwin P. Lusk, PE
The Aspen Utility Company, LLC
Firm No. 23306
Aspen Utility Company, Inc.
Hockley, TX 77447
• 1 (702) 693-3991

NOTES

- THE WALKER COUNTY WILL BE NOTIFIED IN WRITING 48 HOURS PRIOR TO COMMENCING WORK.
- THE WALKER COUNTY UTILITIES DEPARTMENT AND PUBLIC WORKS DEPARTMENT WILL BE NOTIFIED FOR LINE LOCATES AT (936) 456-4959.
- THE CONTRACTOR SHALL CONTACT TEXAS ONE CALL SYSTEM AT 1-800-485-4545 MIN. 48 HOURS BEFORE DIGGING.
- THE CONTRACTOR SHALL DETERMINE THE EXACT LOCATION OF ALL UNDERGROUND FACILITIES BEFORE COMMENCING WORK AND AGREE TO BE FULLY RESPONSIBLE FOR ALL DAMAGES CAUSED BY HIS FAILURE TO EXACTLY LOCATE AND PRESERVE ALL UNDERGROUND FACILITIES.
- NO MORE TRENCH OPENED AT ONE TIME THAN CAN BE BACKFILLED AND COMPACTED IN 10' LIFTS AT THE END OF EACH DAY. (NO TRENCH LEFT OPENED OVERNIGHT).
- ALL EXCESS EXCAVATION TO BE REMOVED FROM THE ROAD RIGHT-OF-WAY AT THE END OF EACH DAY.
- ADEQUATE DRAINAGE.
- ROAD MUST BE KEPT OPEN TO TRAFFIC AND CONTRACTOR MUST PROVIDE ADEQUATE FLAGMEN, SIGNALS, ETC., TO PROVIDE COMPLETE SAFETY TO THE PUBLIC.
- IF IT BECOMES NECESSARY FOR EQUIPMENT TO OPERATE ON A PORTION OF THE PAVEMENT, PRECAUTIONS MUST BE TAKEN TO PREVENT ANY DAMAGE WHATSOEVER TO THE PAVEMENT.
- CONDITION OF ROAD UPON COMPLETION OF JOB SHALL BE AS GOOD OR BETTER THAN PRIOR TO STARTING.
- CONTRACTOR SHALL COMPLY WITH ALL APPLICABLE NATIONAL ELECTRICAL SAFETY CODE (NEC) REQUIREMENTS; CENTERPOINT ENERGY ELECTRIC POLE ATTACHMENT GUIDELINES & PROCEDURES AND ALL OTHER LOCAL REQUIREMENTS AND REGULATIONS FOR PLACEMENT OF ADJACENT CABLE FACILITIES. 18" MIN VERTICAL CLEARANCE.
- ALL UTILITIES WILL BE IDENTIFIED BY POT-HOLE BEFORE ANY CONSTRUCTION.
- COMCAST WILL MAINTAIN (2FT) HORIZONTAL & VERTICAL SEPARATION FROM ANY EXISTING UTILITIES.
- THE CONTRACTOR TO CONTACT WALKER COUNTY PRECINCT 2 AT LEAST 48 HOURS PRIOR TO CONSTRUCTION.

1. THE WALKER COUNTY WILL BE NOTIFIED IN WRITING 48 HOURS PRIOR TO COMMENCING WORK.
2. THE WALKER COUNTY UTILITIES DEPARTMENT AND PUBLIC WORKS DEPARTMENT WILL BE NOTIFIED FOR WORK LOCATED AT (360) 456-4939.
3. THE CONTRACTOR SHALL CONTACT TEXAS ONE CALL SYSTEM AT 1-800-531-4569 MIN. 48 HOURS BEFORE DIGGING.
4. THE CONTRACTOR SHALL DETERMINE THE EXACT LOCATION OF ALL UTILITIES LOCATED WITHIN THE PROJECT AREA PRIOR TO COMMENCING WORK AND AGREE TO BE FULLY RESPONSIBLE FOR ANY DAMAGE TO EXISTING UTILITIES. UTILITIES SHOULD BE EXPLICITLY LOCATED AND PRESERVE ALL UNDERGROUND FACILITIES.
5. NO MORE TRENCH DEPTHS AT ONE TIME THAN CAN BE BACKFILLED AND COMPACTED IN 10 LIFTS AT THE END OF EACH DAY. (NO TRENCH LEFT OPENED OVERNIGHT).
6. ALL EXCESS EXCAVATION TO BE REMOVED FROM THE ROAD RIGHT-OF-WAY AT THE END OF EACH DAY.
7. DITCHES TO BE OPENED AT THE END OF EACH DAY TO ASSURE ADEQUATE DRAINAGE.
8. ROAD WAYS WILL BE KEPT OPEN TO TRAFFIC AND CONTRACTOR MUST PROVIDE ADEQUATE FLOWERS, SIGNALS, ETC., TO PROVIDE COMPLETE SAFETY TO THE PUBLIC.
9. IF IT BECOMES NECESSARY FOR EQUIPMENT TO OPERATE ON A PORTION OF THE PAVEMENT, PRECAUTIONS MUST BE TAKEN TO PREVENT ANY DAMAGE WHATSOEVER TO THE PAVEMENT.
10. CONDITION OF ROAD UPON COMPLETION OF JOB SHALL BE AS GOOD OR BETTER THAN PRIOR TO STARTING.
11. CONTRACTOR SHALL COMPLY WITH ALL APPLICABLE NATIONAL ELECTRICAL SAFETY CODE (NEC) REQUIREMENTS; CENTERPOINT ENERGY ELECTRIC POLE ATTACHMENT REGULATIONS; CENTERPOINT ENERGY CONSTRUCTION STANDARDS; AND ALL OTHERS PERTAINING TO THE PLACEMENT OF AERIAL CABLE FACILITIES, 18" MIN. VERTICAL CLEARANCE.
12. ALL UTILITIES WILL BE IDENTIFIED BY POT-HOLE BEFORE ANY CONSTRUCTION.
13. CONCAST WILL MAINTAIN 8 FT+ HORIZONTAL & VERTICAL SEPARATION FROM ANY EXISTING UTILITIES.
14. THE CONTRACTOR TO CONTACT WALKER COUNTY PRECINCT 2

Reviews P. Lasky, PE
The Aspen Utility Company, LLC
Attn No. 23536
6502 Memorial Highway
Rockley, TX 77447
(702) 403-3504



comcast
of HOUSTON, LLC
550 W. TIDWELL RD. HOUSTON, TEXAS 77060



COMCAST PROPOSES TO INSTALL FIBER OPTIC CABLE

COMCAST PROPOSES TO PLACE DIRECTIONAL BORE 978 FT. TO INSTALL FIBER OPTIC CABLE TO PROVIDE SERVICE TO 28 DARRELL WHITE RD. HUNTSVILLE, TX 77340. INSIDE THE ROW OF THE WALKER COUNTY, TX.

TOTAL PROJECT FOOTAGE: 978'

JB1767579 - 26 DARRELL WHITE RD,
HUNTSVILLE, TX 77340



36502 HEMPSTEAD HWY, HOCKLEY,
TX 77447


DESIGNED BY:
ATLANTA TELECOM SERVICES

DWG. NO.
SHEET NO. 24 OF 28

LAMBERT N/A

DATE: 08/19/2025
KEY MAP NO: 33M



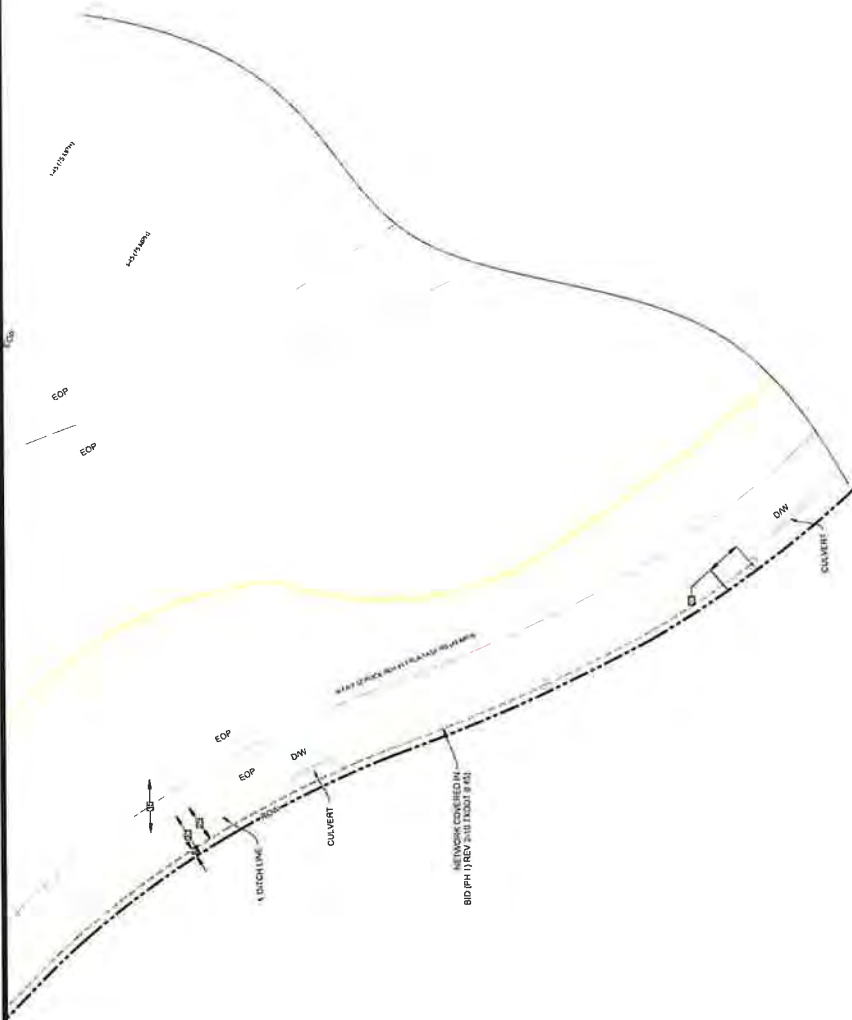

26 DARRELL WHITE RD, HUNTSVILLE, TX 77340 PLAN VIEW 23 OF 23

- NOTES**
1. THE WALKER COUNTY WILL BE NOTIFIED IN WRITING 48 HOURS PRIOR TO COMMENCING WORK.
 2. THE WALKER COUNTY UTILITIES DEPARTMENT AND PUBLIC WORKS DEPARTMENT WILL BE NOTIFIED FOR LINE LOCATES AT (936) 438-4939
 3. THE CONTRACTOR SHALL CONTACT TEXAS ONE CALL SYSTEM AT 1-800-345-4545 MIN. 48 HOURS BEFORE DIGGING
 4. THE CONTRACTOR SHALL DETERMINE THE EXACT LOCATION OF ALL UNDERGROUND FACILITIES BEFORE COMMENCING WORK AND AGREE TO BE FULLY RESPONSIBLE FOR ALL DAMAGES CAUSED BY HIS FAILURE TO EXACTLY LOCATE AND PRESERVE ALL UNDERGROUND FACILITIES
 5. NO MORE TRENCH OPENED AT ONE TIME THAN CAN BE BACKFILLED AND COMPACTED IN 10' LIFTS AT THE END OF EACH DAY (NO TRENCH LEFT OPENED OVERNIGHT)
 6. ALL EXCESS EXCAVATION TO BE REMOVED FROM THE ROAD RIGHT-OF-WAY AT THE END OF EACH DAY
 7. DITCHES TO BE OPENED AT THE END OF EACH DAY TO ASSURE ADEQUATE DRAINAGE
 8. ROAD MUST BE KEPT OPEN TO TRAFFIC AND CONTRACTOR MUST PROVIDE ADEQUATE FLAGMEN, SIGNALS, ETC. TO PROVIDE COMPLETE SAFETY TO THE PUBLIC
 9. IF IT BECOMES NECESSARY FOR EQUIPMENT TO OPERATE ON A PORTION OF THE PAVEMENT, PRECAUTIONS MUST BE TAKEN TO PREVENT ANY DAMAGE WHATSOEVER TO THE PAVEMENT
 10. CONDITION OF ROAD UPON COMPLETION OF JOB SHALL BE AS GOOD OR BETTER THAN PRIOR TO STARTING
 11. CONTRACTOR SHALL COMPLY WITH ALL APPLICABLE NATIONAL ELECTRICAL SAFETY CODE (NEC) REQUIREMENTS, CENTERPOINT ENERGY ELECTRIC POLE ATTACHMENT GUIDELINES, & PROCEDURES AND ALL APPLICABLE LOCAL ORDINANCES AND REGULATIONS. THE CONTRACTOR SHALL MAINTAIN CLEARANCE OF ALL UTILITIES, 18" MIN. VERTICAL CLEARANCE
 12. ALL UTILITIES WILL BE IDENTIFIED BY POT-HOLE BEFORE ANY CONSTRUCTION
 13. COMCAST WILL MAINTAIN (2FT) HORIZONTAL & VERTICAL SEPARATION FROM ANY EXISTING UTILITIES
 14. THE CONTRACTOR TO CONTACT WALKER COUNTY PRECINCT 2 AT LEAST 48 HOURS PRIOR TO CONSTRUCTION

Kerri P. Lutz, PE
The Aspen Utility Company, LLC
36502 Hempstead Highway
Hockley, TX 77447
(817) 493-3991



 8590 W. TIDWELL RD. HOUSTON, TEXAS 77060		COMCAST PROPOSES TO PLACE DIRECTIONAL BORE 876 FT TO INSTALL FIBER OPTIC CABLE TO PROVIDE SERVICE TO 26 DARRELL WHITE RD, HUNTSVILLE, TX 77340, INSIDE THE TOWN OF THE WALKER COUNTY, TX. TOTAL PROJECT FOOTAGE 876'	JB17167579 - 26 DARRELL WHITE RD, HUNTSVILLE, TX 77340	 A QUANTA SERVICES COMPANY 36502 HEMPSTEAD HWY, HOCKLEY, TX 77447	DESIGNED BY: QUANTA TELECOM SERVICES DWG. NO. 25 OF 28 KEY MAP NO. 23M SCALE: 1"=40' LAMBERT: N/A DATE: 08/19/2025
--	--	--	---	---	--

3. ALL SEWERS SHALL BE CONSTRUCTED IN ACCORDANCE WITH THE WALKER COUNTY STANDARD CONSTRUCTION SPECIFICATIONS FOR WASTEWATER COLLECTION SYSTEMS. WATER LINES, STORM DRAINAGE, STREET PAVING AND TRAFFIC AND ALL CURB AND GUTTER AMENDMENTS HERETO AND BE SUBJECT TO STANDARD EXPIRATION TEST. TESTS ARE TO BE PERFORMED ON THE TOTAL FOOTAGE OF SEWER LINE INCLUDED IN THE PROJECT. REQUIREMENTS OF TEXAS ADMINISTRATIVE CODE, TITLE 30, CHAPTER 37, "DESIGN CRITERIA FOR SEWERAGE SYSTEMS" SHALL GOVERN WHERE CONFLICTS EXIST EXCEPT WHERE CITY REQUIREMENTS ARE MORE STRINGENT.

- [illegible]

1. CONTRACTOR TO LOCATE AND PROTECT IN PLACE ALL SERVICE CONNECTIONS TO BUILDINGS ADJACENT TO PROPOSED ROAD AND REPAIR DAMAGE OR REPLACE AS REQUIRED TO MAINTAIN SERVICE.

2. CONTRACTOR TO FOLLOW ALL CITY-OR-ADOPTED RULES FOR ERECTION IN AND AROUND CONSTRUCTION ZONE.

3. STATEWORKS TO FOLLOW ALL CITY-OR-ADOPTED RULES FOR PROPOSED FACILITY UNLESS OTHERWISE NOTED.

CONTRACTOR SHALL VERIFY EXACT LOCATION OF EXISTING WATER LINE AND OTHER UTILITIES PRIOR TO BEGINNING CONSTRUCTION. IF ANY DISCREPANCIES EXIST, NOTIFY ENGINEER.

THE LOCATIONS OF BURIED UTILITIES WERE DERIVED FROM CITY PROVIDED CONSTRUCTION PLANS. BUILT-UPS AND HAVE BEEN VERIFIED BY FIELD SURVEY. CONTRACTOR SHALL VERIFY EXISTING UTILITIES PRIOR TO CONSTRUCTION. CONTRACTOR DOES NOT WARRANT THE INFORMATION IS ACCURATE OR COMPLETE AND IS NOT PROVIDING FOR INFORMATION. CONTRACTOR SHALL BE RESPONSIBLE FOR ANY UTILITIES NOT FIELD VERIFIED BY THE CONTRACTOR PRIOR TO COMMENCING UNDERGROUND WORK.

LOCATIONS OF EXISTING UTILITY LINES ARE BASED ON AVAILABLE CONSTRUCTION PLANS.

AT LEAST 48 HOURS BEFORE EXCAVATING IN STREET R.O.W. OR EASEMENTS CALL UTILITY COORDINATING COMMITTEE: 1-800-245-4545

CONTRACTOR TO ADJUST BORE PITS) TO
MAINTAIN MINIMUM BORING REQUIREMENTS.
CHANGES/REVISION TO SCOPE IN
OCE-APPROVED PLAN WILL REQUIRE OCE
REVIEW AND RE-APPROVAL

WATER MAINS SHALL BE CONSTRUCTED IN ACCORDANCE WITH THE LATEST WALKER COUNTY INFRASTRUCTURE DESIGN MANUAL, STANDARD SPECIFICATION, AND CONSTRUCTION DETAILS.

SECTION 0600 - ALL WATER MAINS SHALL BE 48" I.D. PRESSURE RATED WATER MAIN WITH 2' AND SMALLER WATER SERVICE LINE TO CONTAIN UNDER MINIMUM 15 MPA C151' WITH AMMA C151' AND AMMA C150' THROUGH EXISTING OR NEW TIE INS ARE NECESSARY TO PREVENT PIPE MOVEMENT. JOINTS WHEN PREVENTING MOVEMENT OF 1/4" OR GREATER PIPE IS NECESSARY DUE TO THREAT.

ALL WATER LINES UNDER IMPROVED OR FUTURE PAVING TO A POINT OF ONE (1) FOOT BACK AT APPROXIMATELY 10% GRADE. SLOPE SHALL BE 1" PER 10'. OVER PIPE AND BOLLTILLED WITH CEMENT STABILIZED SAND TO WITHIN ONE (1) FOOT OF SURFACE.

ALL WATER LINE AND SEWER LINE CROSSINGS SHALL BE CONSTRUCTED PER WALKER COUNTY AND TC&O

ALL WATER VALVES SHALL BE SUPPLIED AND INSTALLED IN ACCORDANCE WITH THE LATEST EDITION OF ANMA C-300 AND SHALL BE OF THE RESILIENT SEAT TYPE.

ALL VALVES SHALL BE INSPECTED IN CONFORMANCE WITH AMMA C-651 AND THE TEXAS STATE DEPARTMENT OF TRANSPORTATION'S STANDARD SPECIFICATIONS FOR HIGHWAY CONSTRUCTION. ALL VALVES SHALL BE TESTED TO PROVE LEAKAGE FREE.

ALL BELOW GRADE VALVES SHALL BE GASKETED HUB-END DATE VALVES WITH A CAST IRON BOX, EXCEPT WHERE 4" THRU 17" TINGS SHALL BE CEMENT MORTAR UNDO COMPACTED RATIO IRON PRESSURE FITTINGS PER ANSI A21.53, OR PUSH ON FITTINGS PER ANSI A21.10 PRESSURE RATED AT 250 PSIG.

ALL ABOVE GRADE VALVES SHALL BE 12" CLEARANCE FROM THE CURB AND SHALL BE IN ACCORDANCE WITH THE LATEST WALKER COUNTY STANDARD CONSTRUCTION APPLICATIONS. TESTS ARE TO BE PERFORMED ON THE ENTIRE FOOTAGE OF WATER PIPE LINE INCLUDED IN THE PROJECT.

ALL EXISTING VALVES OTHERWISE NOTED ON LANS, ALL WATER LINE MINIMUM 12" CLEARANCE TO OTHER UTILITIES AND RESTRANDED JOINT FITTINGS.

CONSTRUCTION SHALL KEEPT WATER PIPE CLEAN AND CAPPED OR OTHERWISE EFFECTIVELY COVERED OPEN ENDS TO PREVENT SEDIMENTATION AND CONTAMINATION FROM UNFINISHED OPEN ENDS AT TIMES WHEN CONSTRUCTION IS NOT IN PROGRESS.

GENERAL CONTRACTOR AND ALL SUBCONTRACTORS SHALL VERIFY THE SUITABILITY OF ALL EXISTING AND PROPOSED SITE CONDITIONS INCLUDING GRADES AND DIMENSIONS BEFORE STARTING CONSTRUCTION. THE ENGINEER SHALL BE NOTIFIED IMMEDIATELY OF ANY DISCREPANCIES.

BEFORE STARTING CONSTRUCTION, CONTRACTOR SHALL VERIFY BENCHMARK ELEVATION AND NOTIFY ENGINEER IF ANY DISCREPANCY IS FOUND.

AFTER STARTING CONSTRUCTION, CONTRACTOR SHALL VERIFY THE FOLLOWING:

- CONTRACTOR SHALL ENSURE THERE IS POSITIVE DRAINAGE FROM THE PROPOSED BUILDINGS AND NO POURING IN PAVED AREAS, AND SHALL NOTIFY ENGINEER IF ANY GRADING DISCREPANCIES ARE FOUND IN THE EXISTING AND PROPOSED AREAS.
- CONTRACTOR SHALL PROTECT ALL MANHOLE COVERS WITH 18" DIA. FIRE HYDRANTS, POWER POLES OR GUARDRAILS.
- CONTRACTOR SHALL PROTECT ALL MANHOLE COVERS WITH 18" DIA. FIRE HYDRANTS, POWER POLES OR GUARDRAILS.
- CONTRACTOR SHALL REMOVE ALL TRUCKS, TRAILERS, AND OTHER OBSTRUCTIONS FROM THE CONSTRUCTION SITE.
- ALL EXISTING CONCRETE PAVING, SIDEWALK, AND CURB DEMOLITION SHALL BE REMOVED AND DISPOSED OF BY CONTRACTOR. DISPOSAL SHALL BE AN APPROVED OFF-SITE, LAWFUL LOCATION, UNLESS DIRECTED OTHERWISE BY THE ENGINEER.

[illegible]

SITE PLANS MUST BE APPROVED PRIOR TO OBTAINING THE REQUIRED HCFO RIGHT-OF-WAY NOTIFICATION. BE ADVISED THAT THE HCFO RIGHT-OF-WAY NOTIFICATION IS SEPARATE FROM THE SITE DEVELOPMENT PERMIT PACKAGE.

1. HCCD RIGHT-OF-WAY NOTIFICATION (PERMIT)
2. HCCD 48-HR PRE-CONSTRUCTION NOTICE

[illegible]

PEDESTAL DETAIL



Kevin P. Law, PE
The Aspen Utility Company LLC
P.O. Box 23536
35502 Henscheid Highway
Cedar Bay, TX 77447
+1 (802) 493 4601

NOTE: CITY SIGNATURES VALID FOR ONE YEAR ONLY AFTER DATE OF SIGNATURES

WAIKIKI COUNTY
PUBLIC WORKS

NO 181767579

SHEET 123 OF 26	DRAWING SCALE
FOR WALKER COUNTY USE ONLY	

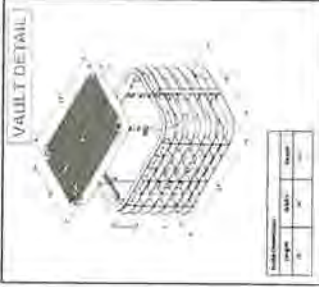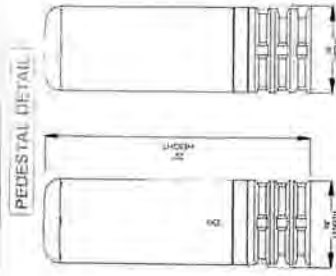


TRAFFIC CONTROL PLAN SECTION SHALL BE COMPLETED
BY ENGINEER

HOUSE	PORTED SPEED	TAKE LENGTH	CHALLENGE SPEED	WINNING SPEED	BUFFER SPACE
DARRELL WHITE RD	30	110	22	120	30

[illegible][illegible]

Conventional Roads Only

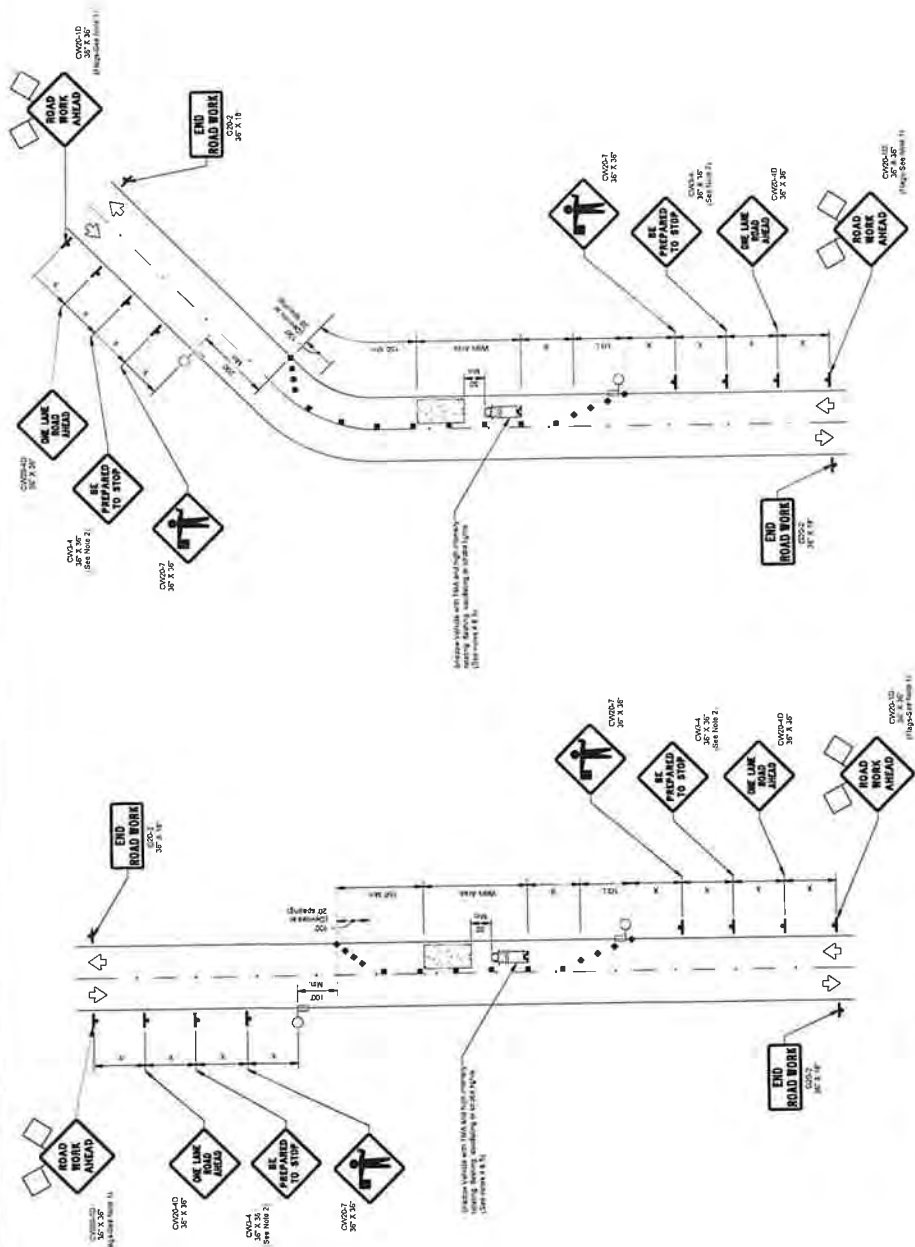

Kevin P. Lash, PE
The Aspen Utility Company, LLC
Firm No. 23530
36502 Hempstead Highway
Hudson, TX 77447
512.703.6933-3691



DESIGNED BY:
QUANTA TELECOM SERVICES

DWG. NO.
SHEET NO. 27 OF 28



B1767579 - 26 DARRELL WHITE RD,
HUNTSVILLE, TX 77340

WALKER COUNTY
ENGINEERING DEPARTMENT



AMBERT: N/A

DATE: 08/19/2025
KEY MAP NO 33M
SCALE: F - NTS

NAME	POINT SPED	TAPER LENGTH	TABLETS CHALLENGE TABLETS	100% SPACE	REFUSE SPACE
MONTGOMERY RD	50	100	50	100	400

LEGEND	
	Heavy Motor Vehicle
	Trailer Mounted
	Trailer Mounted
	Trailer Mounted
	Trailer Mounted
	Trailer Mounted
	Trailer Mounted
	Trailer Mounted

[illegible]

KEVIN P. LOMAY PE
The Austen Utility Company, LLC
Flint No 235, c.
36502 Hempstead Highway
Hockley TX 77447
+1 (702) 493-3691



comcast
of HOUSTON, LLC
3550 W. TIDWELL RD. HOUSTON, TEXAS 77040



WALKER COUNTY
ENGINEERING DEPARTMENT

67579 - 26 DARRELL WHITE RD,
HUNTSVILLE, TX 77340



36502 HEMPSTEAD HWY, HOCKLEY
TX 77447

DESIGNED BY:
QUANTA TELECOM SERVICES

DWG. NO.
SHEET NO. 28 OF 28

LAMBERT: N/A

DATE : 08/19/2025
KEY MAP NO 33M

SCALE : NTS



Utility Installation Request

To the Commissioner's Court of Walker County

Date 09/02/2025

Application is hereby made by Guadalupe Tobon-Horner

to place FIBER OPTIC CABLE

and/or perform the following described work _____ within the Right of Way of that Walker County road known as TX-150 at the following approximate coordinates (lat/long) N 30.545016, W -95.49342

The exact location and extent of the proposed work shall be as shown on the attached specifications and drawings.

We will construct and maintain the line on the road right of way as shown on the attached drawing and in accordance with the rules, regulations and policies of Walker County, the Texas Department of Transportation (TXDOT), and all governing laws, including, but not limited to, the "Texas Engineering Practice Act," "Federal Clean Water Act," the "National Endangered Species Act," "Americans with Disabilities Act," and the "Federal Historic Preservation Act." Upon request by Walker County, we will submit to Walker County proof of compliance with all governing laws, rules and regulations before commencement of construction. Plans shall include the design, proposed location, vertical elevations, and horizontal alignments of the facility based on the department's survey datum, the relationship to existing highway facilities and the right of way line, traffic safety and access procedures, and location of existing utilities that may be affected by the proposed utility facility. The location and description of the proposed line and appurtenances is more fully shown by a complete set of drawings attached to this Utility Installation Request. We will give plans to Walker County for each future proposed modification or expansion to our facility and all Walker County to review and approve submittals prior to commencement of the work.

A new request may be required as a condition of approval.

Our organization will use Best Management Practices to minimize erosion and sedimentation resulting from the proposed installation, and we will re-vegetate the project area as indicated under "Re-vegetation Special Provisions."

Our organization will ensure that traffic control measures complying with applicable portions of the *Texas Manual on Uniform Traffic Control Devices* will be installed and maintained for the duration of this installation.

When installing our utility on controlled access facilities, we shall conform to the Texas Transportation Code, Title 6 Roadways, Chapter 203, Subchapter C, Control of Access, §203.031. We shall limit access for servicing this installation to access via (a) frontage roads where provided, (b) nearby or adjacent public roads or streets, (c) trails along or near the highway right of way lines, connecting only to an intersecting road; from any one or all of which entry may be made to the outer portion of the highway right of way for normal service and maintenance operations. Our rights of access to the through traffic roadways and ramps shall be subject to the same rules and regulations that apply to the general public.

It is expressly understood that Walker County does not purport, hereby, to grant any right, claim, title or easement in or upon this road; and it is further understood that Walker County may require us to relocate this line and any associated infrastructure, at the total expense of the applicant/utility owner, by giving thirty (30) days written notice prior to the date that the relocation shall be completed. We understand that a new Request will be required for the relocation.

We will notify Walker County prior to commencement of any routine or periodic maintenance which requires pruning of trees within the highway right of way, so that Walker County may provide specifications for the extent and methods to govern in, but not limited to, trimming, topping, tree balance, type of cuts, painting cuts and clean up.

Our installation shall not damage any part of the roadway structure or associated appurtenances and we will make adequate provisions to minimize inconveniences to the traveling public, and adjacent property owners. In the event we fail to comply with any or all of the requirements as set forth herein, the County may take such action as it deems appropriate to compel our compliance.

Following approval, we will begin construction on or after 11/03/2025 (month/day/yr)

Additional Provisions and Requirements (for TxDOT input only)

General Special Provisions:

- ☒ Are attached.
☐ Are not attached

As-built Plans/Certifications of Construction:

- ☐ Are required and shall be certified as accurate by an authorized representative of the company.
☒ Are required and shall be signed and sealed by a State of Texas Licensed Professional Engineer.
☒ Certification that utility was installed as approved
☐ Are not required

Re-vegetation Special Provisions: In order to minimize erosion and sedimentation resulting from the proposed installation, the project area will be re-vegetated:

- ☒ In accordance with TxDOT's Standard Specification Item 164 which specifies the appropriate grass seed mix to be used, or:
☐ as indicated on the attachment.

The Precinct Commissioner or his/her representative is to be notified 48 hours prior to beginning construction.

If approved, we understand that we will assume all risks associated with this installation within the Walker County right of way. These risks include, but are not limited to, injuries to our workers, damage to contiguous utility lines that may be in the area, injuries or damage resulting from our failure to properly install and maintain the line as shown on plans.

We understand Walker County may place additional provisions and requirements as listed above, based upon, but not limited to, the type of utility being installed, local site conditions, soil types and traffic.

We acknowledge that this Utility Installation Request approval **expires** on the **91st** calendar day from the date of issuance, unless otherwise approved, if we do not begin our installation by this date. If we do not begin our installation within this time frame and still wish to continue, we will resubmit our request in accordance with the prevailing governing laws, rules, regulations and policies at the time of resubmission.

By signing as/for the requestor below, I certify that I am authorized to represent the requestor, that I agree to the provisions and requirements included in this Utility Installation Request, and our commencement of construction will further attest to our review and acceptance of said additional provisions and requirements

Requestor:

Approved By:

Date: 09/02/2025

Date: _____

By: Guadalupe Tobon-Horner

By: _____

Signature: Guadalupe Tobon-Horner

Signature: _____

Title: Permit Coordinator

Title: _____

Address: 36502 HEMPSTEAD RD. LOT #20,
HOCKLEY, TX. 77447

Address: _____

Telephone: 346-471-2612

Telephone: _____

**General Special Provisions
Walker County Utility Installation Request**

1. Effective Period of Permit Approval. All approvals are void if installation does not begin within 3 months from the date of approval.
2. ALL UTILITY INSTALLATIONS SHALL CONFORM WITH THE STANDARDS DESCRIBED IN TITLE 43, PART 1, CHAPTER 21, SUBCHAPTER C, OF THE TEXAS ADMINISTRATIVE CODE (UTILITY ACCOMODATIONS)
3. A FINAL AS-BUILT SET OF PLANS SHALL BE SUBMITTED AND CERTIFIED BY A PROFESSIONAL ENGINEER, INCLUDING A CERTIFICATION THAT THE INSTALLATION WAS COMPLETED IN CONFORMANCE AND COMPLIANCE WITH THE ABOVE DESCRIBED SECTIONS OF THE TEXAS ADMINISTRATIVE CODE AND TEXAS DEPARTMENT OF TRANSPORTATION MINIMUM SPECIFICATIONS. A statement must be included certifying that any pipe/casing installed is properly designed for the application and the installation meets the minimum standards for TxDOT and Title 43 of the Texas Administrative Code.
4. Minimum Depth of Cover. The minimum depth of cover for any underground utility line shall be as shown on the "Minimum Depth of Cover Table" for the TxDOT District or attached schematic whichever is deeper.
5. Locating Utilities. Applicant shall take all reasonable and necessary steps to locate existing utilities and address them in accordance with all state, local, and or federal requirements.
6. Aerial Electric Lines. Aerial electric power lines crossing over the highway shall be installed and maintained a minimum of twenty-two (22) feet above the surface of the traffic lanes. For electric power lines with greater than 50,000 volts, the clearance shall be increased in accordance with National Electric Safety Code as published in the National Bureau of Standards, Handbook 30.
7. Aerial Communication Lines. Aerial communication lines crossing over the highway shall be installed and maintained a minimum of eighteen (18) feet above the surface of the traffic lanes.
8. Open Trenching or Boring Operations for Utility Work. To insure that disturbed areas are restored and revegetated properly and in a reasonable period as the utility work progresses, the following requirements shall apply:

Unless otherwise approved or directed by Walker County, the length of "active utility work" shall not exceed one mile in length. "Active utility work" shall be defined as the total disturbed area measured from the beginning of open trenching to the point where backfill has been compacted, the right of way has been restored to its original line and grade, any structures damaged by the utility work have been repaired, erosion control measures have been placed and are being properly maintained, approved topsoil seed and compost has been placed uniformly, and watering for revegetation has begun. "Active utility work" also includes areas of bore pits and receiving pits; however, it does not include the underground boring length. When any area of "active utility work" is substantially complete (i.e., watering of seeded areas has begun), that area is no longer considered to be "active utility work", and "active utility work" can proceed further within the right of way as long as it does not exceed the above appropriate limits. Areas where Walker County determines that the "active utility work" is substantially complete does not mean that Walker County considers that area totally acceptable and complete.

9. Backfill, Erosion Control, and Re-vegetation. All excavations within the right-of-way (ROW) and not under pavement shall be backfilled by tamping in six (6) inch horizontal layers to the density of the surrounding soil or as directed by the Walker County. All surplus material shall be removed and the ROW shall be reshaped to

**General Special Provisions
Walker County Utility Installation Request**

its original condition or better. This work shall be done in accordance with Item 164 of the Texas Department of Transportation (TxDOT) "Standard Specifications for Construction and Maintenance of Highways, Streets, and Bridges." Erosion control measures such as soil retention blankets, rock berms, and silt fences shall be installed and maintained until permanent perennial vegetation is established over 70% of the disturbed area. The amount of revegetation is considered acceptable when it resembles the amount of existing vegetation in the surrounding undisturbed area. **If erosion control and/or storm water run-off requirements of other State, Federal, or Local Jurisdictions exceed these requirements then the more stringent requirements would prevail.**

8. Boring and Jacking. Boring and jacking of utility lines shall be provided as specified below.
- a. Under Paved County Roads. Utility lines to be constructed under an existing paved (asphalt pavement or concrete pavement) county road shall be installed by boring and jacking with casing.
 - b. Under Paved Driveways. Utility lines to be constructed under existing paved (asphalt pavement or concrete pavement) driveways shall be installed by boring and jacking methods, unless the utility company furnishes Walker County with a "Letter of No Objection" signed by the driveway owner to allow open cutting of their driveway.
 - c. Under Unpaved County Roads or Driveways. Utility lines to be constructed under an existing unpaved county road or under existing unpaved driveways may be open cut only when approved in advance by Walker County, and after the driveway owner is notified. Any open cuts should be repaired and restored to a minimum of pre-cut conditions as quickly as possible so as not to impact road and/or driveway traffic. Applicant shall take all necessary precautions to insure safety as site of open cut.
 - d. Under Desirable Trees. To preserve the natural environment and protect wildlife habitat, boring may be required when underground utility lines are to be placed within the "protected root area" of "desirable trees" located within road ROW or on adjacent property. The "protected root area" is defined as the area between the tree trunk and five (5) feet from the tree trunk or 2/3 the actual distance from the tree trunk to the dripline, whichever is greater. "Desirable trees" include (but are not limited to) any tree with a trunk diameter of six (6) inches or more that Walker County or the Owner of the tree determines to be of environmental and aesthetic value. Boring under all "desirable trees" will be required with the following exceptions: (1) in areas where planned highway construction/maintenance work would require tree removal, or (2) when the Walker County approves of open trenching for the utility installation or removal of the tree.
9. Manhole Covers. All manhole covers shall be installed flush with the ground surface.
10. Traffic Control. Traffic control in utility work zones shall conform to applicable requirements of the "Texas Manual on Uniform Traffic Control Devices for Streets and Highways, Part VI". Adequate signs, barricades, flag personnel, etc. shall be erected and maintained in complete compliance with the Texas Manual on Uniform Traffic Control Devices. Any travel lane closures are only permitted after a traffic control plan is approved by Walker County prior to beginning any construction activities.
11. Sunday or Holiday Work. Sunday or Holiday work will not be permitted for the installation of any utility line unless directed or approved by Walker County.

**General Special Provisions
Walker County Utility Installation Request**

12. The approval of this utility installation request shall in no way be taken as a waiver or variance to any other existing local, state, or federal permits or requirements that may be required by the applicant.
13. Please note that Walker County will be making no verification through this process of the actual location of the public right of way as to width or location. The responsibility to locate the bounds of any public right of way that your project will utilize is the responsibility of your company. Walker County's approval of the request is not an agreement as to location of the public right of way, nor does it confer any easement, right of way, or property right for the project area.
14. Protection of Trees and Landscaping. Existing trees and landscaping within the ROW shall be protected as specified below. Removal of trees from the ROW will require prior Walker County approval.
- a. Tree Pruning. All tree pruning within the ROW will require prior TxDOT approval. All oak trees that are damaged or pruned shall be treated with an approved tree wound dressing within 20 minutes of causing the damage or making the pruning cut.
- b. Landscaping. When existing landscaping is located near the proposed utility alignment, the utility contractor shall notify Walker County and the owner of the landscaping prior to the proposed utility installation. Walker County may require underground utilities to be installed by: (1) boring under such landscaping or (2) by replacement of specific landscape items. Landscaping is defined as, but not limited to, trees, shrubs, grass, irrigation lines, landscape pavers, sidewalks, and other ROW improvements.




JB1771404 - 995 TX-150, NEW WAVERLY, TX 77358/PRECINCT 4

COMCAST PROPOSES TO PLACE DIRECTIONAL BORE 710 FT TO INSTALL FIBER OPTIC CABLE TO PROVIDE SERVICE TO 995 TX-150, NEW WAVERLY, TX 77358, INSIDE THE ROW OF THE WALKER COUNTY, TX.



SPECIFY HDPE PIPE SHALL BE GLUED WITH APPROPRIATE ADHESIVE, BONDED, OR MECHANICALLY FASTENED PER 43 TAC \$21.40(A)(1), \$21.40(G)(4), \$21.40(G)(5).

NOT TO SCALE

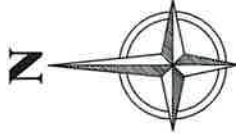

NO.	DATE	REVISION	APP.

Kevin P. Lundy, PE
The Aspen Utility Company, LLC
P.O. Box 23330
Houston, TX 77247
+1 (702) 455-3001



WALKER COUNTY

PUBLIC WORKS DEPARTMENT
FOR THE USE OF THE WALKER COUNTY ENGINEERING DEPARTMENT

SHEET NO: 1 OF 45 DATE : 10/27/2025

BUILD		QUANTITY	UNIT
DESCRIPTION			
DIRECTIONAL BORE	710	0	FT
TRENCH	0	0	FT
OVERWALL EXISTING CONDUIT	0	0	EA
BARE PITS	1	1	EA
PROPOSED VAULTS	3	3	EA
EXISTING VAULTS	0	0	EA
EX. CIRCULAR PEDESTAL	0	0	EA
PROPOSED CIRCULAR PEDESTAL	0	0	EA
ASPHALT RIBBON	0	0	FT
NEW STAND	0	0	EA
OVERLASH	0	0	EA
MANHOLE	0	0	EA
PROPOSED MANHOLE	1	1	EA
EXISTING POLES	0	0	EA
NEW POLES	0	0	EA
EXISTING POLES (TCP)	0	0	EA
TOTAL PROJECT FOOTAGE	710	0	FT

SHEET INDEX

1. COVER PAGE
2. PLAN OVERVIEW
- 3-43. PLAN VIEWS (1-41)
44. GENERAL NOTE
45. TRAFFIC CONTROL PLAN

ANY INSTALLATION OUTSIDE OF THE EXISTING COUNTY RIGHT-OF-WAY IS EXCLUDED FROM ANY COUNTY UIR APPROVALS

ASPEN UTILITY IS RESPONSIBLE FOR PLACING THE CONDUIT IN THE WALKER COUNTY ROW AND RESPONSIBLE FOR CONFIRMING ALL RIGHT-OF-WAY WIDTHS.

ACCORDING TO MAP NO. 48471C0525D OF THE FEDERAL EMERGENCY MANAGEMENT AGENCY'S FLOOD INSURANCE RATE MAPS FOR WALKER COUNTY UNINCORPORATED AREAS, DATED 8/16/2011, THE SUBJECT TRACT IS SITUATED WITHIN: FLOOD PLAIN ZONE X, UNSHADED

LEGEND

- PROPOSED BORE PIT
- EX. HAND HOLE
- EX. PEDESTAL
- PROPOSED PEDESTAL
- EX. CIRCULAR TAP PEDESTAL
- PROPOSED CIRCULAR TAP PEDESTAL
- EX. CATV VAULT
- PROPOSED CATV VAULT
- ANCHOR
- WATER METER
- CATV TRENCH ROUTE
- CATV BORE ROUTE
- STORM DRAINAGE
- WATER
- SEWER
- STORM SEWER
- CATV AERIAL ROUTE
- PRIVATE FENCE
- STORM DRAIN INLET
- CATCH BASIN
- STORM MANHOLE
- JOINT USE POLE
- EX. JOINT USE POLE
- JOINT USE POLE WITH TRANSFORMER
- BOC - BACK OF CURB
- EOP - EDGE OF PAVEMENT
- ROW - RIGHT OF WAY
- AERIAL RISER


NOTES 1. THE WALKER COUNTY WILL BE NOTIFIED IN WRITING 48 HOURS PRIOR TO COMMENCING WORK. 2. THE WALKER COUNTY UTILITIES DEPARTMENT AND PUBLIC WORKS DEPARTMENT WILL BE NOTIFIED FOR UTILITIES LOCATED AT (250) 450-4539. 3. THE CONTRACTOR SHALL CONTACT TEXAS ONE CALL SYSTEM AT 1-800-245-4545 MIN. 48 HOURS BEFORE DIGGING. 4. THE CONTRACTOR SHALL DETERMINE THE EXACT LOCATION OF ALL UNDERGROUND FACILITIES BEFORE COMMENCING WORK AND AGREE TO EXISTING FACILITIES AND PRESERVE ALL UNDERGROUND FACILITIES TO EXISTING LOCATIONS AND PRESERVE ALL UNDERGROUND FACILITIES. 5. NO MORE TRENCH OPENED AT ONE TIME THAN CAN BE BACKFILLED AND COMPACTED IN 10 DAYS AT THE END OF EACH DAY (NO TRENCH LEFT OPENED OVERNIGHT). 6. ALL EXCESS EXCAVATION TO BE REMOVED FROM THE ROAD RIGHT-OF-WAY AT THE END OF EACH DAY. 7. DITCHES TO BE OPENED AT THE END OF EACH DAY TO ASSURE ADEQUATE DRAINAGE. 8. ROAD MUST BE KEPT OPEN TO TRAFFIC AND CONTRACTOR MUST MAINTAIN ALL TRAFFIC SIGNALS, ETC., TO PROVIDE COMPLETE SAFETY TO THE PUBLIC. 9. IF IT BECOMES NECESSARY FOR EQUIPMENT TO OPERATE ON A PORTION OF THE ROAD, THE CONTRACTOR SHALL TAKE NECESSARY MEASURES TO PREVENT DAMAGE WHATSOEVER TO THE PAVEMENT. 10. CONDITION OF ROAD UPON COMPLETION OF JOB SHALL BE AS GOOD OR BETTER THAN PRIOR TO STARTING. 11. CONTRACTOR SHALL COMPLY WITH ALL APPLICABLE NATIONAL ELECTRICAL CODES, LOCAL ORDINANCES, AND ALL APPLICABLE LOCAL REQUIREMENTS AND REGULATIONS FOR PLACEMENT OF AERIAL CABLE FACILITIES. 18" MIN. VERTICAL CLEARANCE. 12. ALL UTILITIES WILL BE IDENTIFIED BY POT-HOLE BEFORE ANY CONSTRUCTION. 13. COMCAST WILL MAINTAIN (GFI) HORIZONTAL & VERTICAL SEPARATION FROM ANY EXISTING UTILITIES. 14. THE CONTRACTOR TO CONTACT WALKER COUNTY PRECINCT 4 AT LEAST 48 HOURS PRIOR TO CONSTRUCTION. 15. SPECIFY HOPE PIPE SHALL BE GULDED WITH APPROPRIATE ADHESIVE BONDED OR MECHANICALLY FASTENED PER 43 TAC §21.40A(1) §21.40G(4), §21.40G(5). Kevin P. Lashley, PE The Aspen Utility Company, LLC Firm No. 23526 38502 Hempstead Highway Hockley, TX 77447 • (727) 483-3091	DESIGNED BY: QUANTA TELECOM SERVICES DWG. NO. SHEET NO. 2 OF 45
---	--

	JB1771404 - 995 TX-150, NEW WAVERLY, TX 77358 PLAN OVERVIEW
--	--

JB1771404 - 995 TX-150, NEW WAVERLY, TX 77358
PLAN VIEW 01 OF 41



ROAD BORE DETAIL

SCALE: NTS

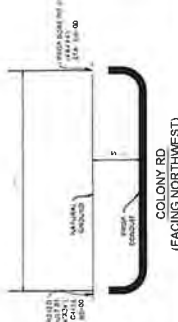

DIRECTIONAL BORE DETAIL

SCALE: NTS

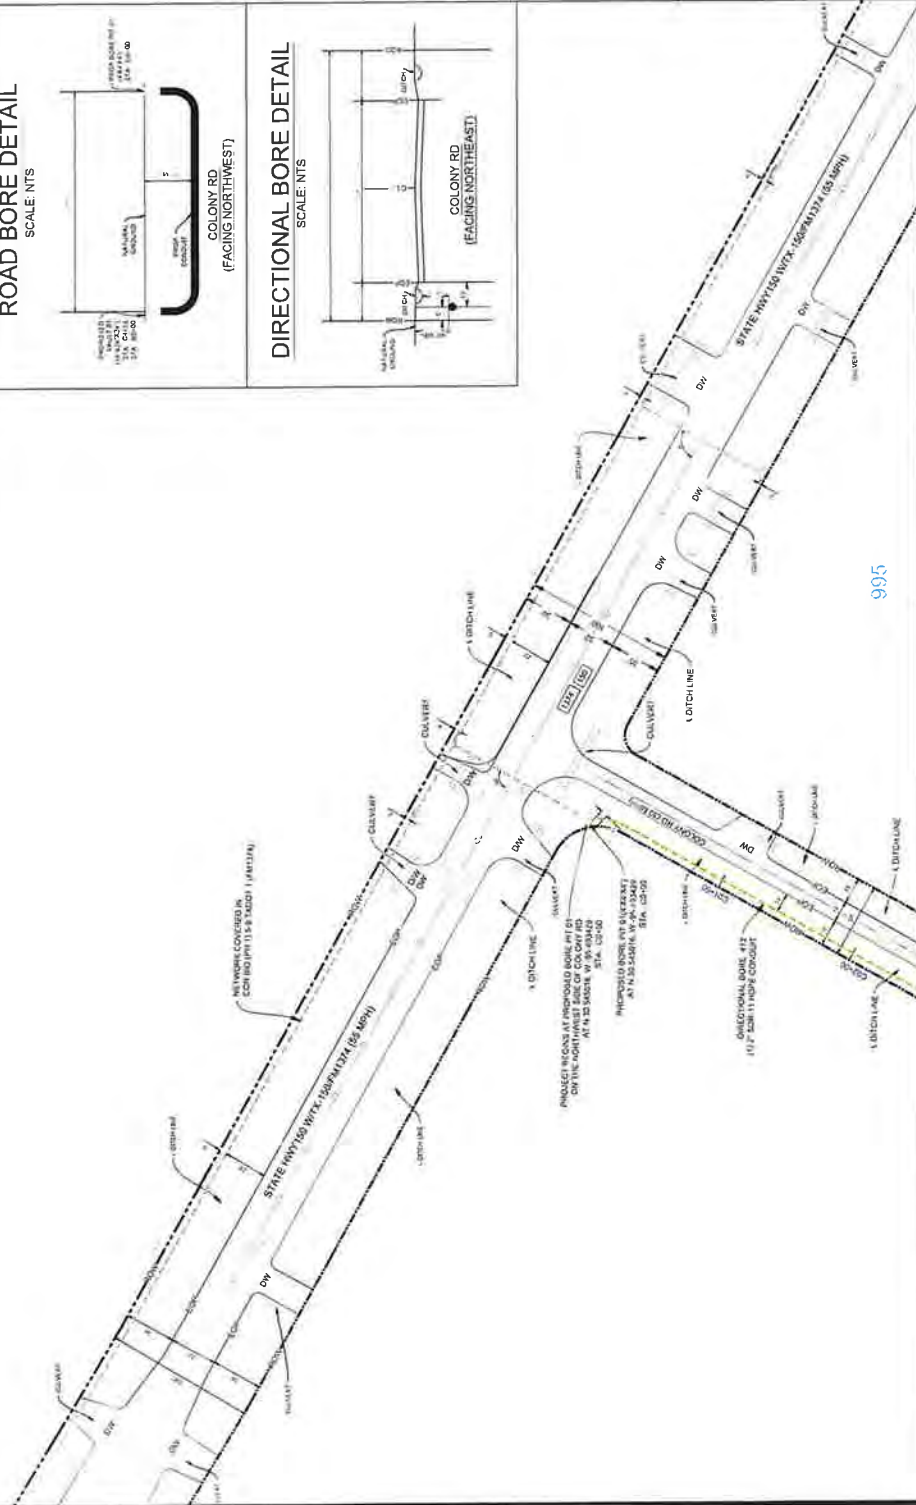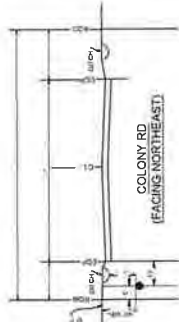

NOTES

1. THE WALKER COUNTY WILL BE NOTIFIED IN WRITING 48 HOURS PRIOR TO COMMENCING WORK.
2. THE WALKER COUNTY UTILITIES DEPARTMENT AND PUBLIC WORKS DEPARTMENT WILL BE NOTIFIED FOR LINE LOCATES AT (800) 436-4999.
3. THE CONTRACTOR SHALL CONTACT TEXAS ONE CALL SYSTEM AT 1-800-245-4545 MIN. 48 HOURS BEFORE DIGGING.
4. THE CONTRACTOR SHALL DETERMINE THE EXACT LOCATION OF ALL UNDERGROUND FACILITIES BEFORE COMMENCING WORK AND AGREE TO BE FULLY RESPONSIBLE FOR ALL DAMAGES CAUSED BY HIS FAILURE TO EXACTLY LOCATE AND PRESERVE ALL UNDERGROUND FACILITIES.
5. NO MORE TRENCH OPENED AT ONE TIME THAN CAN BE BACKFILLED AND COMPACTED IN 10 LIFTS AT THE END OF EACH DAY (NO TRENCH LEFT OPENED OVERNIGHT).
6. ALL EXCESS EXCAVATION TO BE REMOVED FROM THE ROAD RIGHT-OF-WAY AT THE END OF EACH DAY.
7. DITCHES TO BE OPENED AT THE END OF EACH DAY TO ASSURE ADEQUATE DRAINAGE.
8. ROAD MUST BE KEPT OPEN TO TRAFFIC AND CONTRACTOR MUST PROVIDE ADEQUATE FLAGMEN, SIGNALS, ETC., TO PROVIDE COMPLETE SAFETY TO THE PUBLIC.
9. IF IT BECOMES NECESSARY FOR EQUIPMENT TO OPERATE ON A PORTION OF THE PAVEMENT, PRECAUTIONS MUST BE TAKEN TO PREVENT ANY DAMAGE WHATSOEVER TO THE PAVEMENT.
10. CONDITION OF ROAD UPON COMPLETION OF JOB SHALL BE AS GOOD OR BETTER THAN PRIOR TO STARTING.
11. CONTRACTOR SHALL COMPLY WITH ALL APPLICABLE NATIONAL ELECTRICAL SAFETY CODE (NEC) REQUIREMENTS, CENTERPOINT ENERGY, LOCAL ORDINANCES, AND ALL CITY ORDINANCES AND ALL APPLICABLE LOCAL ORDINANCES AND REGULATIONS FOR PLACEMENT OF AERIAL CABLE FACILITIES. 18" MIN VERTICAL CLEARANCE.
12. ALL UTILITIES WILL BE IDENTIFIED BY POTHOLE BEFORE ANY CONSTRUCTION.
13. CONTRACTOR WILL MAINTAIN (PT) HORIZONTAL & VERTICAL SEPARATION FROM ANY EXISTING UTILITIES.
14. THE CONTRACTOR TO CONTACT WALKER COUNTY PRECINCT 4 AT LEAST 148 HOURS PRIOR TO CONSTRUCTION.

Kevin P. Lissy PE
The Aspen Utility Company, LLC
Firm No. 23526
Professional Engineer
Hockley, TX 77447
+1 (281) 893 3601



JB1771404 - 995 TX-150, NEW WAVERLY, TX 77358

CONCAST PROPOSES TO INSTALL FIBER OPTIC CABLE.
CONCAST PROPOSES TO PLACE DIRECTIONAL BORE 710 FT TO INSTALL FIBER OPTIC CABLE TO PROVIDE SERVICE TO 995 TX-150, NEW WAVERLY, TX 77358.
INSIDE THE ROW OF THE WALKER COUNTY, TX.
TOTAL PROJECT FOOTAGE 710




DESIGNED BY:
QUANTA TELECOM SERVICES

DWG. NO. 3 OF 45
SHEET NO. 3 OF 45




LAMBERT: N/A
DATE: 10/27/2025
KEY MAP NO. 75K
SCALE: 1" = 40'

JB1771404 - 995 TX-150, NEW WAVERLY, TX 77358
PLAN VIEW 02 OF 41

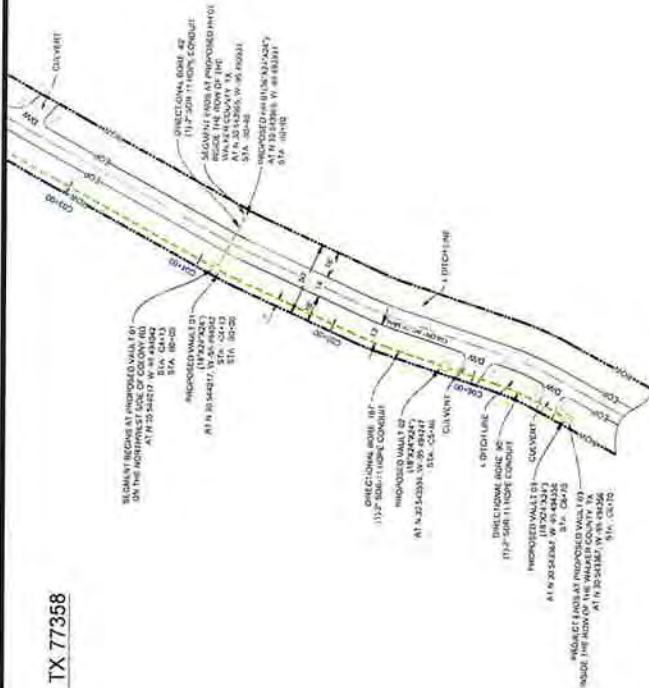

ROAD BORE DETAIL


SCALE: NTS

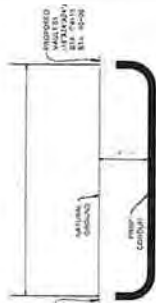

COLONY RD
(FACING NORTHWEST)

CROSSING BORE DETAIL


SCALE: NTS

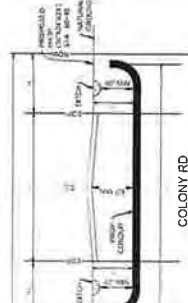

COLONY RD
(FACING NORTHEAST)

DRIVEWAY BORE DETAIL


SCALE: NTS

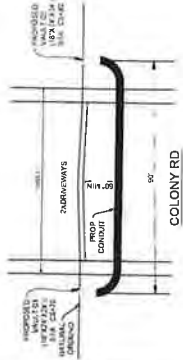

COLONY RD
(FACING NORTHWEST)

DIRECTIONAL BORE DETAIL

SCALE: NTS

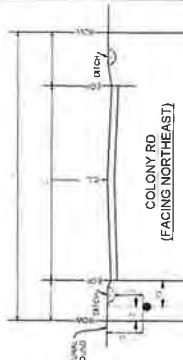

COLONY RD
(FACING NORTHEAST)

NOTES

1. THE WALKER COUNTY WILL BE NOTIFIED IN WRITING 48 HOURS PRIOR TO COMMENCING WORK.
2. THE WALKER COUNTY UTILITIES DEPARTMENT AND PUBLIC WORKS DEPARTMENT WILL BE NOTIFIED FOR LINE LOCATES AT (936) 438-4939.
3. THE CONTRACTOR SHALL CONTACT TEXAS ONE CALL SYSTEM AT 1-800-245-5545 MIN 48 HOURS BEFORE DIGGING.
4. THE CONTRACTOR SHALL DETERMINE THE EXACT LOCATION OF ALL UNDERGROUND FACILITIES BEFORE COMMENCING WORK AND AGREE TO BE RESPONSIBLE FOR ALL DAMAGES CAUSED BY HIS FAILURE TO EXACTLY LOCATE AND PRESERVE ALL UNDERGROUND FACILITIES.
5. NO MORE TRENCH OPENED AT ONE TIME THAN CAN BE BACKFILLED AND RECLOSED WITHIN 24 HOURS OF THE END OF EACH DAY (NO TRENCH LEFT OPENED OVERNIGHT).
6. ALL EXCESS EXCAVATION TO BE REMOVED FROM THE ROAD RIGHT-OF-WAY AT THE END OF EACH DAY.
7. DITCHES TO BE OPENED AT THE END OF EACH DAY TO ASSURE ADEQUATE DRAINAGE.
8. ROAD MUST BE KEPT OPEN TO TRAFFIC AND CONTRACTOR MUST PROVIDE ADEQUATE FLAGMEN SIGNALS ETC. TO PROVIDE COMPLETE SAFETY TO THE PUBLIC.
9. IF IT BECOMES NECESSARY FOR EQUIPMENT TO OPERATE ON A PORTION OF THE PAVEMENT PRECAUTIONS MUST BE TAKEN TO PREVENT ANY DAMAGE WHATSOEVER TO THE PAVEMENT.
10. CONDITION OF ROAD UPON COMPLETION OF JOB SHALL BE AS GOOD OR BETTER THAN PRIOR TO STARTING.
11. CONTRACTOR SHALL COMPLY WITH ALL APPLICABLE NATIONAL ELECTRICAL SAFETY CODE (NEC) REQUIREMENTS, CENTERPOINT UTILITY CODES, AND ALL APPLICABLE LOCAL REQUIREMENTS AND REGULATIONS FOR PLACEMENT OF AERIAL CABLE FACILITIES 18" MIN VERTICAL CLEARANCE.
12. ALL UTILITIES WILL BE IDENTIFIED BY POTHOLE BEFORE ANY CONSTRUCTION.
13. COMCAST WILL MAINTAIN (DFT) HORIZONTAL & VERTICAL SEPARATION FROM ANY EXISTING UTILITIES.
14. THE CONTRACTOR TO CONTACT WALKER COUNTY PRECINCT 4 AT LEAST 48 HOURS PRIOR TO CONSTRUCTION.
15. SPECIFY WIRE SHALL BE CALLED WITH APPROPRIATE ADHESIVE BONDED OR MECHANICALLY FASTENED PER 45 TAG \$21.40(A)(1) \$21.40(G)(4), \$21.40(G)(5).

ENGINEER SEAL

Kevin P. Lundy PE
The Aspen Utility Company LLC
P.O. Box 23038
Houston, TX 77205
+1 (713) 403-3691



COMCAST PROPOSES TO INSTALL FIBER OPTIC CABLE
COMCAST PROPOSES TO PLACE DIRECTIONAL BORE 710 FT TO INSTALL FIBER
OPTIC CABLE TO PROVIDE SERVICE TO 995 TX-150 NEW WAVERLY, TX 77358
INSIDE THE ROW OF THE WALKER COUNTY, TX
TOTAL PROJECT FOOTAGE: 710'

JB1771404 - 995 TX-150, NEW WAVERLY, TX 77358




DESIGNED BY:
QUANTA TELECOM SERVICES

DWG NO.
SHEET NO. 4 OF 45



LAMBERT N/A
DATE 10/27/2025
KEY MAP NO 75K

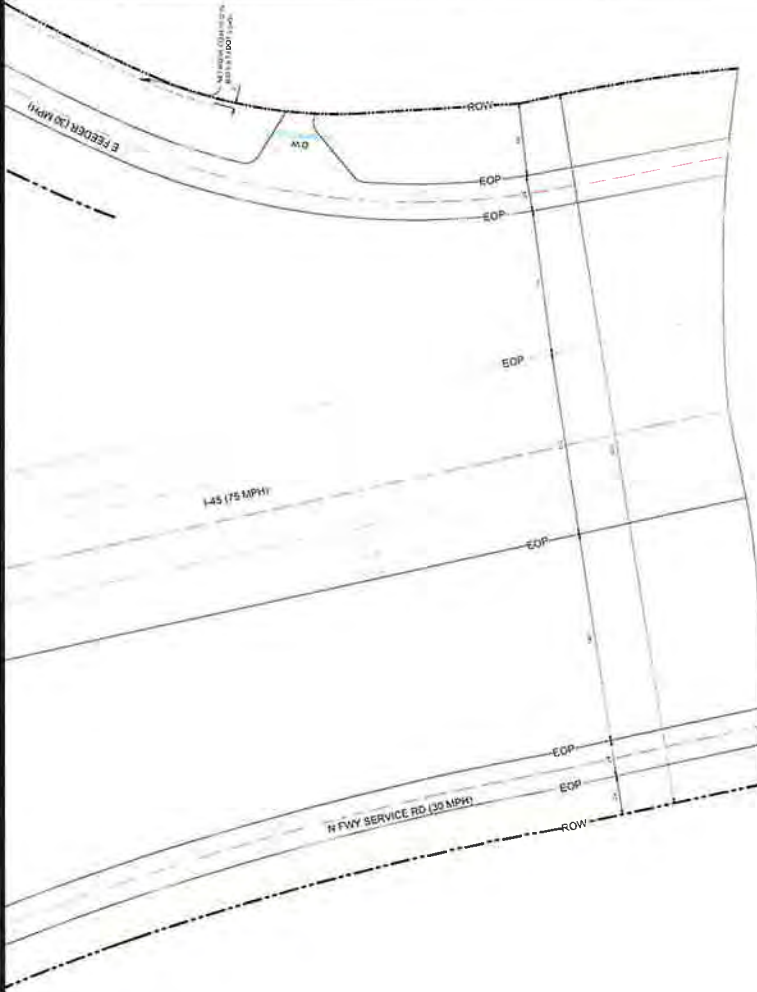

JB1771404 - 995 TX-150, NEW WAVERLY, TX 77358
PLAN VIEW 03 OF 41

NOTES

1. THE WALKER COUNTY WILL BE NOTIFIED IN WRITING 48 HOURS PRIOR TO COMMENCING WORK.
2. THE WALKER COUNTY UTILITIES DEPARTMENT AND PUBLIC WORKS DEPARTMENT WILL BE NOTIFIED FOR LINE LOCATES AT (936) 436-4939.
3. THE CONTRACTOR SHALL CONTACT TEXAS ONE CALL SYSTEM AT 1-800-245-3453 MIN. 48 HOURS BEFORE DIGGING.
4. THE CONTRACTOR SHALL DETERMINE THE EXACT LOCATION OF ALL UNDERGROUND FACILITIES BEFORE COMMENCING WORK AND AGREE TO BE FULLY RESPONSIBLE FOR ALL DAMAGES CAUSED BY HIS FAILURE TO EXACTLY LOCATE AND PRESERVE ALL UNDERGROUND FACILITIES.
5. NO MORE TRENCH OPENED AT ONE TIME THAN CAN BE BACKFILLED AND COMPACTED IN 12' LIFTS AT THE END OF EACH DAY (NO TRENCH LEFT OPENED OVERNIGHT).
6. ALL EXCESS EXCAVATION TO BE REMOVED FROM THE ROAD RIGHT-OF-WAY AT THE END OF EACH DAY.
7. DITCHES TO BE OPENED AT THE END OF EACH DAY TO ASSURE ADEQUATE DRAINAGE.
8. ROAD MUST BE KEPT OPEN TO TRAFFIC AND CONTRACTOR MUST PROVIDE ADEQUATE FLAGMEN SIGNALS, ETC., TO PROVIDE COMPLETE SAFETY TO THE PUBLIC.
9. IF IT BECOMES NECESSARY FOR EQUIPMENT TO OPERATE ON A PORTION OF THE PAVEMENT, PRECAUTIONS MUST BE TAKEN TO PREVENT ANY DAMAGE WHATSOEVER TO THE PAVEMENT.
10. CONDITION OF ROAD UPON COMPLETION OF JOB SHALL BE AS GOOD OR BETTER THAN PRIOR TO STARTING.
11. CONTRACTOR SHALL COMPLY WITH ALL APPLICABLE NATIONAL ELECTRICAL SAFETY CODE (NEC) REQUIREMENTS, CENTERPOINT ENERGY ELECTRIC POLE ATTACHMENT GUIDELINES & PROCEDURES AND ALL APPLICABLE LOCAL ORDINANCES AND REGULATIONS FOR THE PLACEMENT OF FIBER OPTIC CABLE FACILITIES. 18" MIN. VERTICAL CLEARANCE.
12. ALL UTILITIES SHALL BE IDENTIFIED BY POTHOLE BEFORE ANY CONSTRUCTION.
13. CONTRACTOR WILL MAINTAIN (8FT) HORIZONTAL & VERTICAL SEPARATION FROM ANY EXISTING UTILITIES.
14. THE CONTRACTOR TO CONTACT WALKER COUNTY PRECINCT 4 AT LEAST 48 HOURS PRIOR TO CONSTRUCTION.

Karen P. Lohdy, PE
The Aspen Utility Company, LLC
35502 Hempstead Highway
Hockley, TX 77447
+1 (281) 993-3601



LAMBERT: N/A
DATE: 10/27/2023
KEY MAP NO. TXA
SCALE: 1"=40'

DESIGNED BY:
QUANTA TELECOM SERVICES
DWG. NO.
SHEET NO. 5 OF 45




JB1771404 - 995 TX-150, NEW WAVERLY, TX 77358

CONCAST PROPOSES TO INSTALL FIBER OPTIC CABLE
CONCAST PROPOSES TO PLACE OVERHEAD BORE 110 FT TO INSTALL FIBER
OPTIC CABLE TO PROVIDE SERVICE TO 995 TX-150, NEW WAVERLY, TX 77358.
INSIDE THE ROW OF THE WALKER COUNTY, TX.
TOTAL PROJECT FOOTAGE: 110'



JB1771404 - 995 TX-150, NEW WAVERLY, TX 77358
PLAN VIEW 4 OF 41

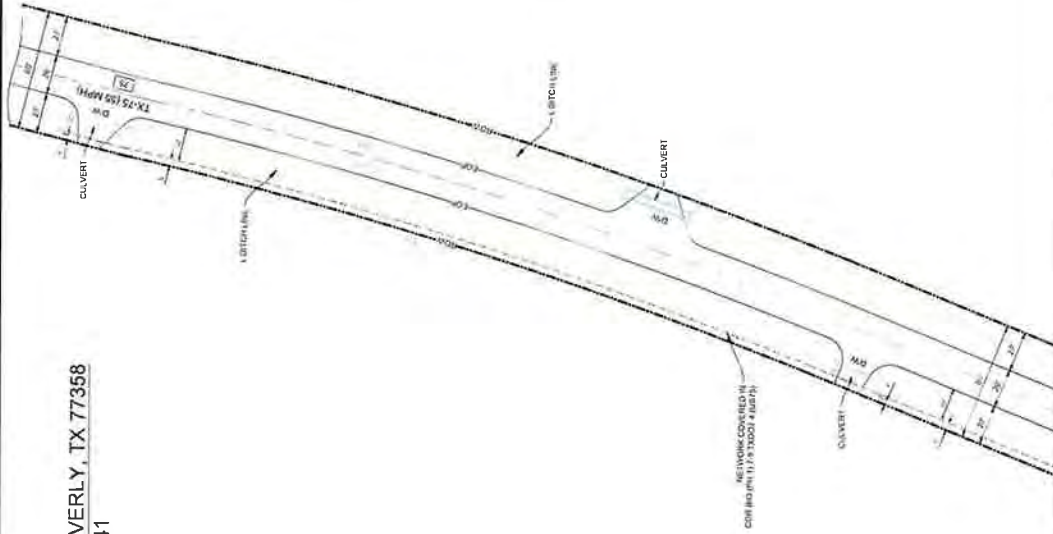

NOTES

1. THE WALKER COUNTY WILL BE NOTIFIED IN WRITING 48 HOURS PRIOR TO COMMENCING WORK.
2. THE WALKER COUNTY UTILITIES DEPARTMENT AND PUBLIC WORKS DEPARTMENT WILL BE NOTIFIED FOR LINE LOCATES AT (361) 436-4339
3. THE CONTRACTOR SHALL CONTACT TEXAS ONE CALL SYSTEM AT 1-800-245-4545 MIN. 48 HOURS BEFORE DIGGING.
4. THE CONTRACTOR SHALL DETERMINE THE EXACT LOCATION OF ALL UNDERGROUND FACILITIES BEFORE COMMENCING WORK AND AGREE TO BE FULLY RESPONSIBLE FOR ALL DAMAGES CAUSED BY HIS FAILURE TO EXACTLY LOCATE AND PRESERVE ALL UNDERGROUND FACILITIES.
5. NO MORE TRENCH OPENED AT ONE TIME THAN CAN BE BACKFILLED AND COMPACTED IN 10' LIFTS AT THE END OF EACH DAY (NO TRENCH LEFT OPENED OVERNIGHT).
6. ALL EXCESS EXCAVATION TO BE REMOVED FROM THE ROAD RIGHT-OF-WAY AT THE END OF EACH DAY.
7. DITCHES TO BE OPENED AT THE END OF EACH DAY TO ASSURE ADEQUATE DRAINAGE.
8. ROAD MUST BE KEPT OPEN TO TRAFFIC AND CONTRACTOR MUST PROVIDE ADEQUATE FLAGMEN, SIGNALS, ETC. TO PROVIDE COMPLETE SAFETY TO THE PUBLIC.
9. IF IT BECOMES NECESSARY FOR EQUIPMENT TO OPERATE ON A PORTION OF THE PAVEMENT, PRECAUTIONS MUST BE TAKEN TO PREVENT ANY DAMAGE WHATSOEVER TO THE PAVEMENT.
10. CONDITION OF ROAD UPON COMPLETION OF JOB SHALL BE AS GOOD OR BETTER THAN PRIOR TO STARTING.
11. CONTRACTOR SHALL COMPLY WITH ALL APPLICABLE NATIONAL ELECTRICAL SAFETY CODE (NEC) REQUIREMENTS, CENTERPOINT ENERGY ELECTRIC POLE ATTACHMENT GUIDELINES & PROCEDURES AND ALL APPLICABLE STATE AND LOCAL REQUIREMENTS FOR THE PLACEMENT OF AERIAL CABLE FACILITIES. 18\"/>
- 12. ALL UTILITIES WILL BE IDENTIFIED BY POT-HOLE BEFORE ANY CONSTRUCTION.
- 13. COMCAST WILL MAINTAIN 6\"/>
- 14. THE CONTRACTOR TO CONTACT WALKER COUNTY PRECINCT 4 AT LEAST 48 HOURS PRIOR TO CONSTRUCTION.

Kevin P. Lashy, PE
The Aspen Utility Company, LLC
P.O. Box 2354
Hockley, Texas 77447
+1 (281) 483-3001



COMCAST PROPOSES TO INSTALL FIBER OPTIC CABLE
COMCAST PROPOSES TO PLACE DIRECTIONAL BORE 710 FT TO INSTALL FIBER OPTIC CABLE TO PROVIDE SERVICE TO 995 TX-150, NEW WAVERLY, TX 77358 INSIDE THE ROW OF THE WALKER COUNTY, TX.
TOTAL PROJECT FOOTAGE: 110'

JB1771404 - 995 TX-150, NEW WAVERLY, TX 77358




DESIGNED BY:
QUANTA TELECOM SERVICES

LAMBERT: N/A
DATE: 10/27/2015
KEY MAP NO. 73K
SCALE: 1" = 40'



DWG. NO.
SHEET NO. 6 OF 45

JB1771404 - 995 TX-150, NEW WAVERLY, TX 77358
PLAN VIEW 05 OF 41

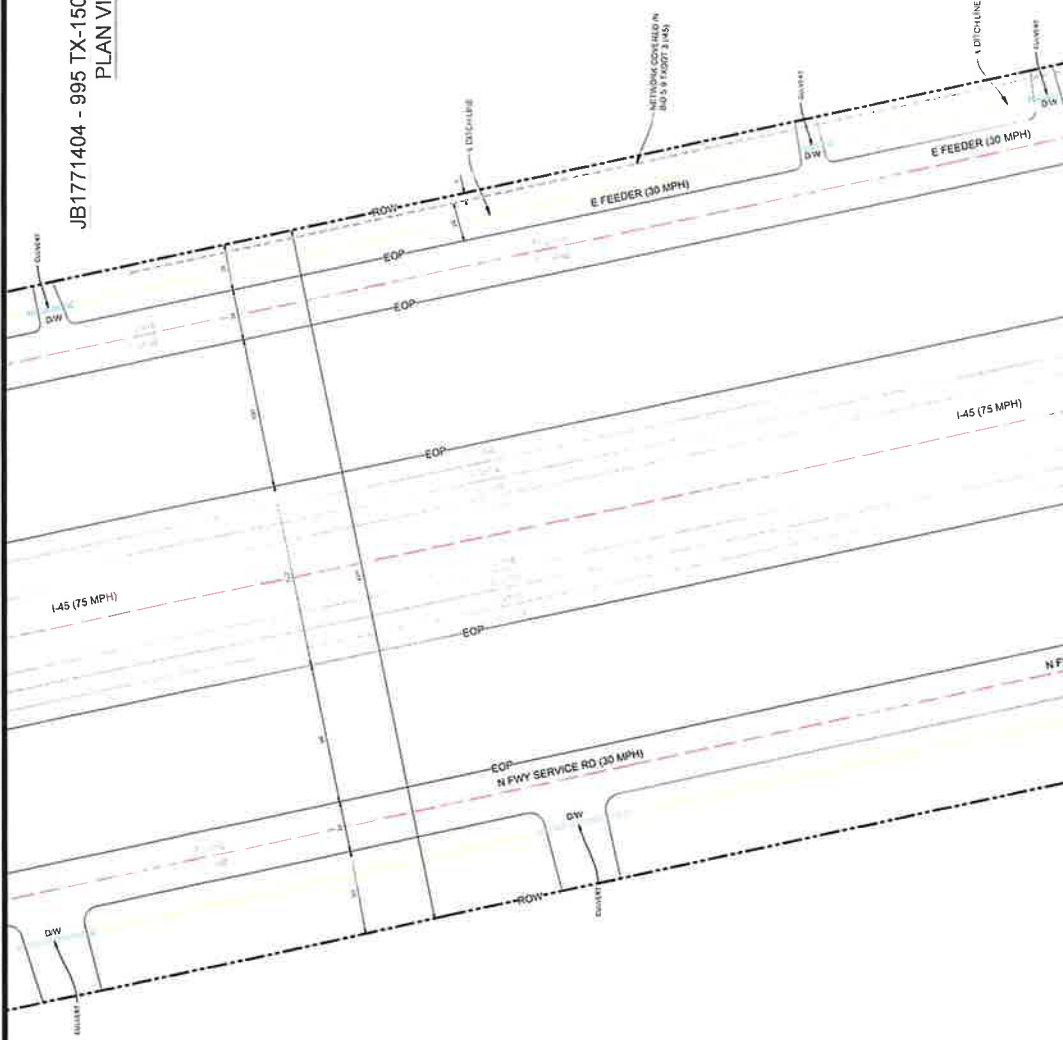

NOTES

1. THE WALKER COUNTY WILL BE NOTIFIED IN WRITING 48 HOURS PRIOR TO COMMENCING WORK.
2. THE WALKER COUNTY UTILITIES DEPARTMENT AND PUBLIC WORKS DEPARTMENT WILL BE NOTIFIED FOR LINE LOCATES AT (836) 436-4993.
3. THE CONTRACTOR SHALL CONTACT TEXAS ONE CALL SYSTEM AT 1-800-345-4545 MIN. 48 HOURS BEFORE DIGGING.
4. THE CONTRACTOR SHALL DETERMINE THE EXACT LOCATION OF ALL UNDERGROUND FACILITIES BEFORE COMMENCING WORK AND AGREE TO BE FULLY RESPONSIBLE FOR ALL DAMAGES CAUSED BY HIS FAILURE TO EXACTLY LOCATE AND PRESERVE ALL UNDERGROUND FACILITIES.
5. NO MORE TRENCH OPENED AT ONE TIME THAN CAN BE BACKFILLED AND COMPACTED IN 12 LIFTS AT THE END OF EACH DAY. (NO TRENCH LEFT OPENED OVERNIGHT).
6. ALL EXCESS EXCAVATION TO BE REMOVED FROM THE ROAD RIGHT-OF-WAY AT THE END OF EACH DAY.
7. DITCHES TO BE OPENED AT THE END OF EACH DAY TO ASSURE ADEQUATE DRAINAGE.
8. ROAD MUST BE KEPT OPEN TO TRAFFIC AND CONTRACTOR MUST PROVIDE ADEQUATE FLAGMEN, SIGNALS, ETC., TO PROVIDE COMPLETE SAFETY TO THE PUBLIC.
9. IF IT BECOMES NECESSARY FOR EQUIPMENT TO OPERATE ON A PORTION OF THE PAVEMENT, PRECAUTIONS MUST BE TAKEN TO PREVENT ANY DAMAGE WHATSOEVER TO THE PAVEMENT.
10. CONDITION OF ROAD UPON COMPLETION OF JOB SHALL BE AS GOOD OR BETTER THAN PRIOR TO STARTING.
11. CONTRACTOR SHALL COMPLY WITH ALL APPLICABLE NATIONAL ELECTRICAL SAFETY CODE (NEC) REQUIREMENTS, CENTERPOINT ENERGY ELECTRIC POLE ATTACHMENT GUIDELINES & PROCEDURES AND ALL APPLICABLE LOCAL ORDINANCES AND REGULATIONS FOR PLACEMENT OF AERIAL CABLE FACILITIES. 18" MIN. VERTICAL CLEARANCE.
12. ALL UTILITIES WILL BE IDENTIFIED BY POT-HOLE BEFORE ANY CONSTRUCTION.
13. COMCAST WILL MAINTAIN (GFT) HORIZONTAL & VERTICAL SEPARATION FROM ANY EXISTING UTILITIES.
14. THE CONTRACTOR TO CONTACT WALKER COUNTY PRECINCT 4 AT LEAST 48 HOURS PRIOR TO CONSTRUCTION.

Kyle P. Lundy, P.E.
Texas One-Call System, LLC
Firm No. 20234
36502 Hempstead Highway
Hockley, TX 77447
+1 (702) 493 3691



36502 HEMPSTEAD HWY.
HOCKLEY, TX 77447

COMCAST PROPOSES TO INSTALL FIBER OPTIC CABLE
COMCAST PROPOSES TO PLACE DIRECTIONAL BORE 110 FT TO INSTALL FIBER
OPTIC CABLE TO PROVIDE SERVICE TO 995 TX-150 NEW WAVERLY, TX 77358
INSIDE THE ROW OF THE WALKER COUNTY, TX
TOTAL PROJECT FOOTAGE 710'



JB1771404 - 995 TX-150, NEW WAVERLY, TX 77358

DESIGNED BY:
QUANTA TELECOM SERVICES

DWG. NO.
SHEET NO. 7 OF 45

LAMBERT: N/A
DATE: 10/27/2023
KEY MAP NO: 75K
SCALE: 1"=40'



JB17714
NEW WA
PLAN

MAXIMUM CORNER RADIUS 5.9' (2.14m)

ROW

EOP

DW

Service Rd (30 MPH)

THE WALKER COUNTY SHALL BE NOTIFIED IN WRITING 48 HOURS PRIOR TO COMMENCING WORK.

THE WALKER COUNTY UTILITIES DEPARTMENT AND PUBLIC WORKS DEPARTMENT WILL NOT BE NOTIFIED FOR LINE LOCATES AT (930) 426-4993.

THE CONTRACTOR SHALL CONTACT TEXAS ONE CALL SYSTEM AT 1-800-455-4545 MIN. 48 HOURS BEFORE DIGGING.

1. THE CONTRACTOR SHALL DETERMINE THE EXACT LOCATION OF ALL UTILITIES AND THE DEPTHS OF THE UTILITIES PRIOR TO ANY CONSTRUCTION BEING FULLY RESPONSIBLE FOR ALL DAMAGES CAUSED BY HIS FAILURE TO EXACTLY LOCATE AND PRESERVE ALL UNDERGROUND FACILITIES.

2. NO MORE TRENCH OPENED AT ONE TIME THAN CAN BE BACKFILLED AND COMPACTED 18" UP AT THE END OF EACH DAY, (NO TRENCH LEFT OPEN OR OVERNIGHT).

3. ALL EXCESS EXCAVATION TO BE REMOVED FROM THE ROAD RIGHT-OF-WAY AT THE END OF EACH DAY.

4. DITCHES TO BE OPENED AT THE END OF EACH DAY TO ASSURE ADEQUATE DRAINAGE.

5. ROAD MUST BE KEPT OPEN TO TRAFFIC AND CONTRACTOR MUST PROVIDE ADEQUATE FLAGMEN, SIGNALS, ETC. TO PROVIDE COMPLETE SAFETY TO THE PUBLIC.

6. IF IT BECOMES NECESSARY FOR EQUIPMENT TO OPERATE ON A PORTION OF THE PAVEMENT PRECAUTIONS MUST BE TAKEN TO PREVENT ANY DAMAGE WHATSOEVER TO THE PAVEMENT.

7. CONDITION OF ROAD UPON COMPLETION OF JOB SHALL BE AS GOOD OR BETTER THAN PRIOR TO STARTING.

1. CONTRACTOR SHALL COMPLY WITH ALL APPLICABLE NATIONAL ELECTRICAL SAFETY CODE (NEC) REQUIREMENTS, CERTIFICATIONS AND ALL APPLICABLE STATE AND LOCAL REGULATIONS AND ORDINANCES. CONTRACTOR SHALL MAINTAIN ADEQUATE CLEARANCE FOR ALL OVERHEAD PLACEMENT OF AERIAL CABLE FACILITIES, 18" MIN. VERTICAL CLEARANCE.

2. ALL UTILITIES WILL BE IDENTIFIED BY POTHOLE BEFORE ANY CONSTRUCTION.

3. CONCAST WILL MAINTAIN (27") HORIZONTAL & VERTICAL SEPARATION FROM ANY EXISTING UTILITIES.

4. THE CONTRACTOR TO CONTACT WALKER COUNTY PRECINCT 4 AT LEAST 48 HOURS PRIOR TO CONSTRUCTION.

ASPEN
A COMMERCIAL SERVICE CORPORATION
36502 HEMPSTEAD HWY.
HOCKLEY, TX 77447

DWG. NO.
SHEET NO. 8 OF 45

LAMBERT: N/A
DATE: 10/27/00
KEY MAP NO. 75
SCALE: 1:40



JB1771404 - 995 TX-150, NEW WAVERLY, TX 77358
PLAN VIEW 07 OF 41



NOTES

1. THE WALKER COUNTY WILL BE NOTIFIED IN WRITING 48 HOURS PRIOR TO COMMENCING WORK.
2. THE WALKER COUNTY UTILITIES DEPARTMENT AND PUBLIC WORKS DEPARTMENT WILL BE NOTIFIED FOR LINE LOCATES AT (936) 436-8939.
3. THE CONTRACTOR SHALL CONTACT TEXAS ONE CALL SYSTEM AT 1-800-244-4545 MIN. 48 HOURS BEFORE DIGGING.
4. THE CONTRACTOR SHALL DETERMINE THE EXACT LOCATION OF ALL UNDERGROUND FACILITIES BEFORE COMMENCING WORK AND AGREE TO BE FULLY RESPONSIBLE FOR ALL DAMAGES CAUSED BY HIS FAILURE TO EXACTLY LOCATE AND PRESERVE ALL UNDERGROUND FACILITIES.
5. NO MORE TRENCH OPENED AT ONE TIME THAN CAN BE BACKFILLED AND COMPACTED IN 10' LIFTS AT THE END OF EACH DAY. (NO TRENCH LEFT OPENED OVERNIGHT).
6. ALL EXCESS EXCAVATION TO BE REMOVED FROM THE ROAD RIGHT-OF-WAY AT THE END OF EACH DAY.
7. DITCHES TO BE OPENED AT THE END OF EACH DAY TO ASSURE ADEQUATE DRAINAGE.
8. ROAD MUST BE KEPT OPEN TO TRAFFIC AND CONTRACTOR MUST PROVIDE ADEQUATE FLAGMEN SIGNALS, ETC., TO PROVIDE COMPLETE SAFETY TO THE PUBLIC.
9. IF IT BECOMES NECESSARY FOR EQUIPMENT TO OPERATE ON A PORTION OF THE PAVEMENT, PRECAUTIONS MUST BE TAKEN TO PREVENT ANY DAMAGE WHATSOEVER TO THE PAVEMENT.
10. CONDITION OF ROAD UPON COMPLETION OF JOB SHALL BE AS GOOD OR BETTER THAN PRIOR TO STARTING.
11. CONTRACTOR SHALL COMPLY WITH ALL APPLICABLE NATIONAL ELECTRICAL SAFETY CODE (NEC) REQUIREMENTS, CENTERPOINT ENERGY ELECTRIC POLE ATTACHMENT GUIDELINES & PROCEDURES AND ALL OTHER REQUIREMENTS OF THE UTILITY OWNERS. THE CONTRACTOR SHALL MAINTAIN CLEARANCE OF AERIAL CABLE FACILITIES. 18' MIN. VERTICAL CLEARANCE.
12. ALL UTILITIES WILL BE IDENTIFIED BY POTHOLE BEFORE ANY CONSTRUCTION.
13. CONTRACTOR SHALL MAINTAIN 20' HORIZONTAL & VERTICAL SEPARATION FROM ANY EXISTING UTILITIES.
14. THE CONTRACTOR TO CONTACT WALKER COUNTY PRECINCT 4 AT LEAST 48 HOURS PRIOR TO CONSTRUCTION.

Kevin P. Latta, PE
The Aspen Group, Company, LLC
P.O. Box 20305
36502 Hempstead Highway
Hockley, TX 77447
+1 (281) 633-2001

ENGINEER SEAL



DESIGNED BY:
QUANTA TELECOM SERVICES




JB1771404 - 995 TX-150, NEW WAVERLY, TX 77358

COMCAST PROPOSES TO INSTALL FIBER OPTIC CABLE
COMCAST PROPOSES TO PLACE DIRECTIONAL BORE 110 FT TO INSTALL FIBER
OPTIC CABLE TO PROVIDE SERVICE TO 995 TX-150, NEW WAVERLY, TX 77358
INSIDE THE ROW OF THE WALKER COUNTY, TX.
TOTAL PROJECT FOOTAGE: 710



LAURENT, NY
DATE: 10/27/2023
KEY MAP NO: 75A
SCALE: 1" = 40'

DWG. NO.
SHEET NO. 9 OF 45

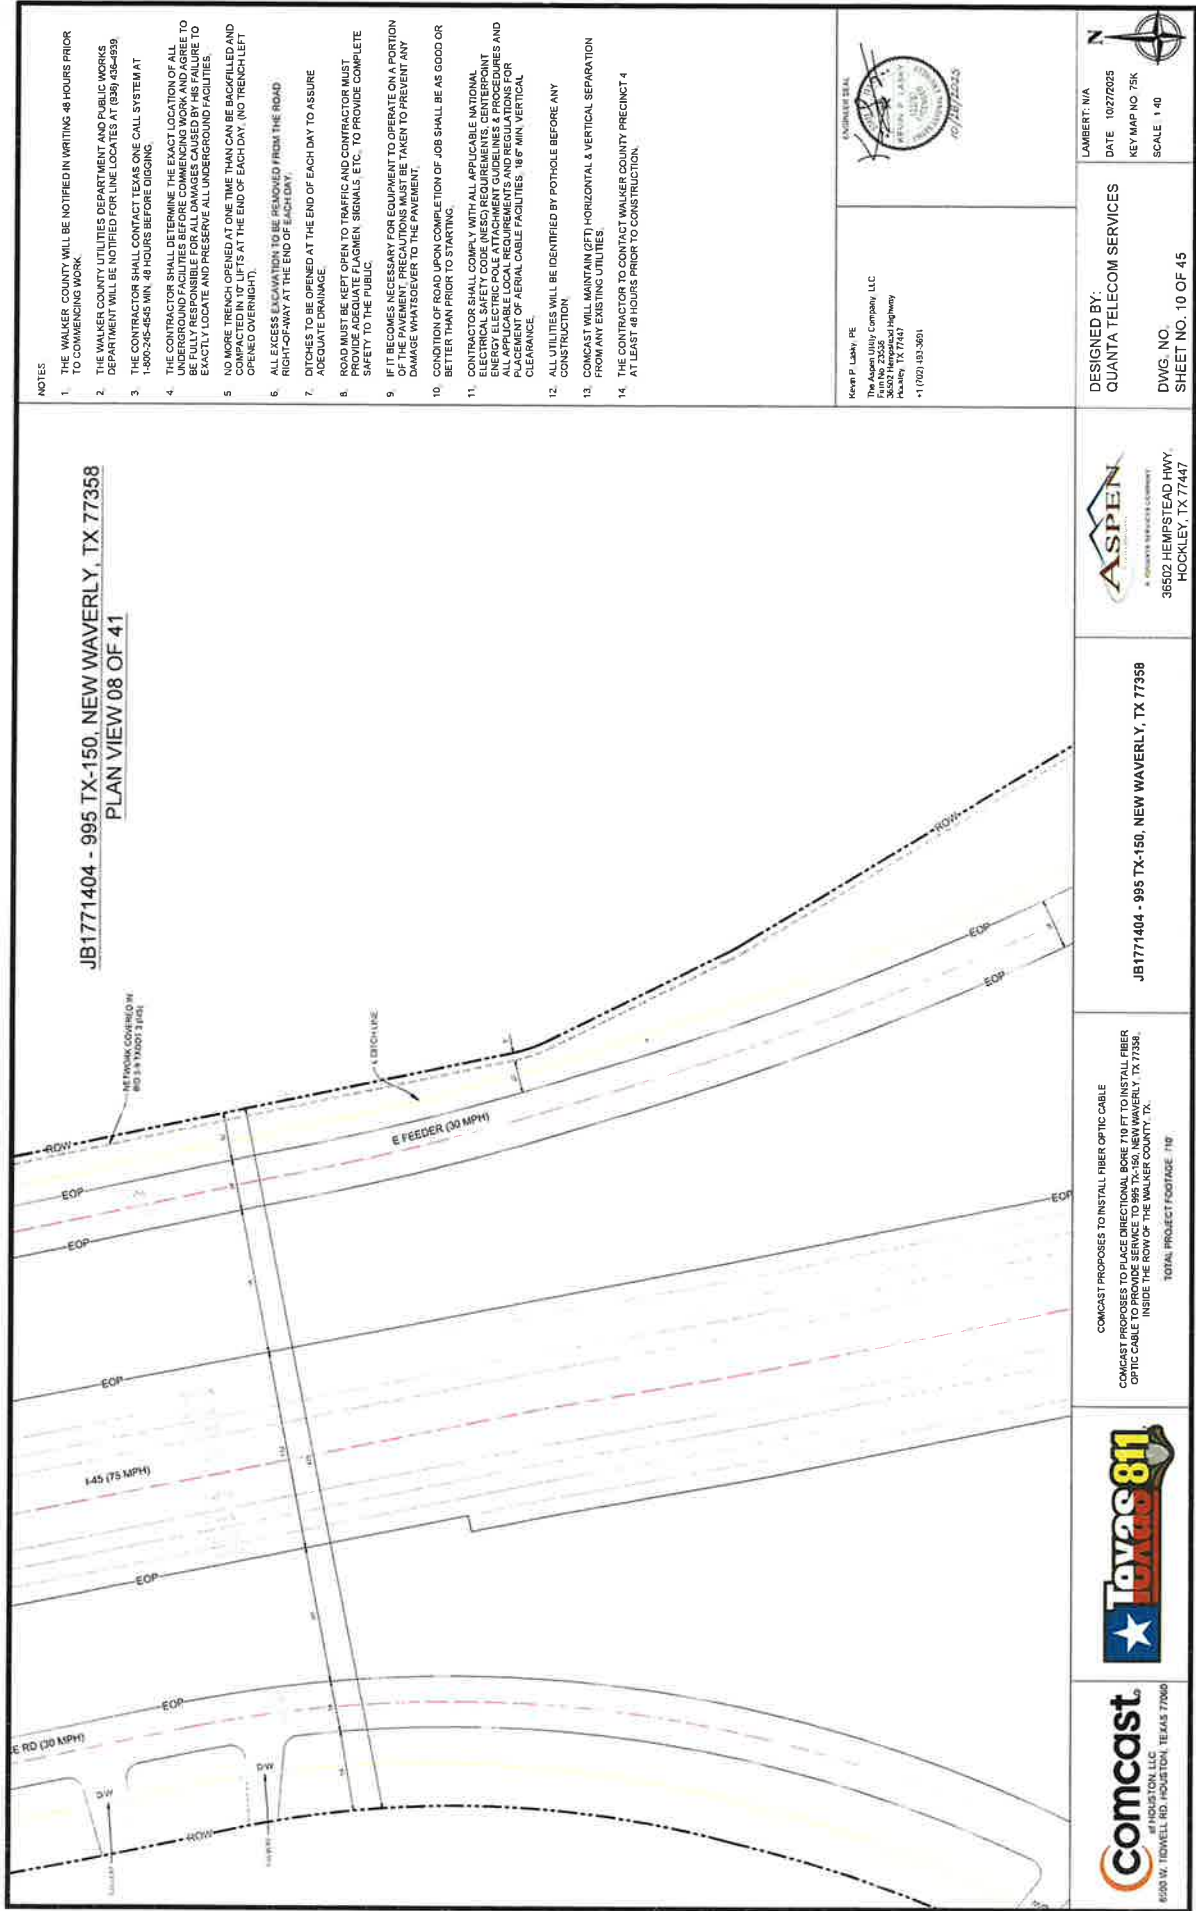

NOTES

1. THE WALKER COUNTY WILL BE NOTIFIED IN WRITING 48 HOURS PRIOR TO COMMENCING WORK.
2. THE WALKER COUNTY UTILITIES DEPARTMENT AND PUBLIC WORKS DEPARTMENT WILL BE NOTIFIED FOR LINE LOCATES AT (839) 436-4599.
3. THE CONTRACTOR SHALL CONTACT TEXAS ONE CALL SYSTEM AT 1-800-245-4545 MIN. 48 HOURS BEFORE DIGGING.
4. THE CONTRACTOR SHALL DETERMINE THE EXACT LOCATION OF ALL UNDERGROUND FACILITIES BEFORE COMMENCING WORK AND SHALL BE FULLY RESPONSIBLE FOR ALL DAMAGES CAUSED BY HIS FAILURE TO EXACTLY LOCATE AND PRESERVE ALL UNDERGROUND FACILITIES.
5. NO MORE TRENCH OPENED AT ONE TIME THAN CAN BE BACKFILLED AND COMPACTED IN 10' LIFTS AT THE END OF EACH DAY. (NO TRENCH LEFT OPENED OVERNIGHT).
6. ALL EXCESS EXCAVATION TO BE REMOVED FROM THE ROAD RIGHT-OF-WAY AT THE END OF EACH DAY.
7. DITCHES TO BE OPENED AT THE END OF EACH DAY TO ASSURE ADEQUATE DRAINAGE.
8. ROAD MUST BE KEPT OPEN TO TRAFFIC AND CONTRACTOR MUST PROVIDE ADEQUATE FLAGMEN, SIGNALS, ETC. TO PROVIDE COMPLETE SAFETY TO THE PUBLIC.
9. IF IT BECOMES NECESSARY FOR EQUIPMENT TO OPERATE ON A PORTION OF THE PAVEMENT, PRECAUTIONS MUST BE TAKEN TO PREVENT ANY DAMAGE WHATSOEVER TO THE PAVEMENT.
10. CONDITION OF ROAD UPON COMPLETION OF JOB SHALL BE AS GOOD OR BETTER THAN PRIOR TO STARTING.
11. CONTRACTOR SHALL COMPLY WITH ALL APPLICABLE NATIONAL ELECTRICAL SAFETY CODE (NEC) REQUIREMENTS, CENTERPOINT ENERGY ELECTRIC POLE ATTACHMENT GUIDELINES & PROCEDURES AND ALL APPLICABLE LOCAL ORDINANCES AND REGULATIONS FOR PLACEMENT OF AERIAL CABLE FACILITIES, 18' MIN. VERTICAL CLEARANCE.
12. ALL UTILITIES WILL BE IDENTIFIED BY POT-HOLE BEFORE ANY CONSTRUCTION.
13. COMCAST WILL MAINTAIN (2FT) HORIZONTAL & VERTICAL SEPARATION FROM ANY EXISTING UTILITIES.
14. THE CONTRACTOR TO CONTACT WALKER COUNTY PRECINCT 4 AT LEAST 48 HOURS PRIOR TO CONSTRUCTION.

Kerwin P. Lashley, PE
The Aspen Utility Company, LLC
Engine No. 23258
36502 Hempstead Highway
Hockley, TX 77447
+1 (282) 433-3201



DESIGNED BY:
QUANTA TELECOM SERVICES


DWG. NO.
SHEET NO. 10 OF 45



JB1771404 - 995 TX-150, NEW WAVERLY, TX 77358

COMCAST PROPOSES TO INSTALL FIBER OPTIC CABLE
COMCAST PROPOSES TO PLACE DIRECTIONAL BORE 710 FT TO INSTALL FIBER
OPTIC CABLE TO PROVIDE SERVICE TO 995 TX-150, NEW WAVERLY, TX 77358,
INSIDE THE ROW OF THE WALKER COUNTY, TX.
TOTAL PROJECT FOOTAGE: 118'




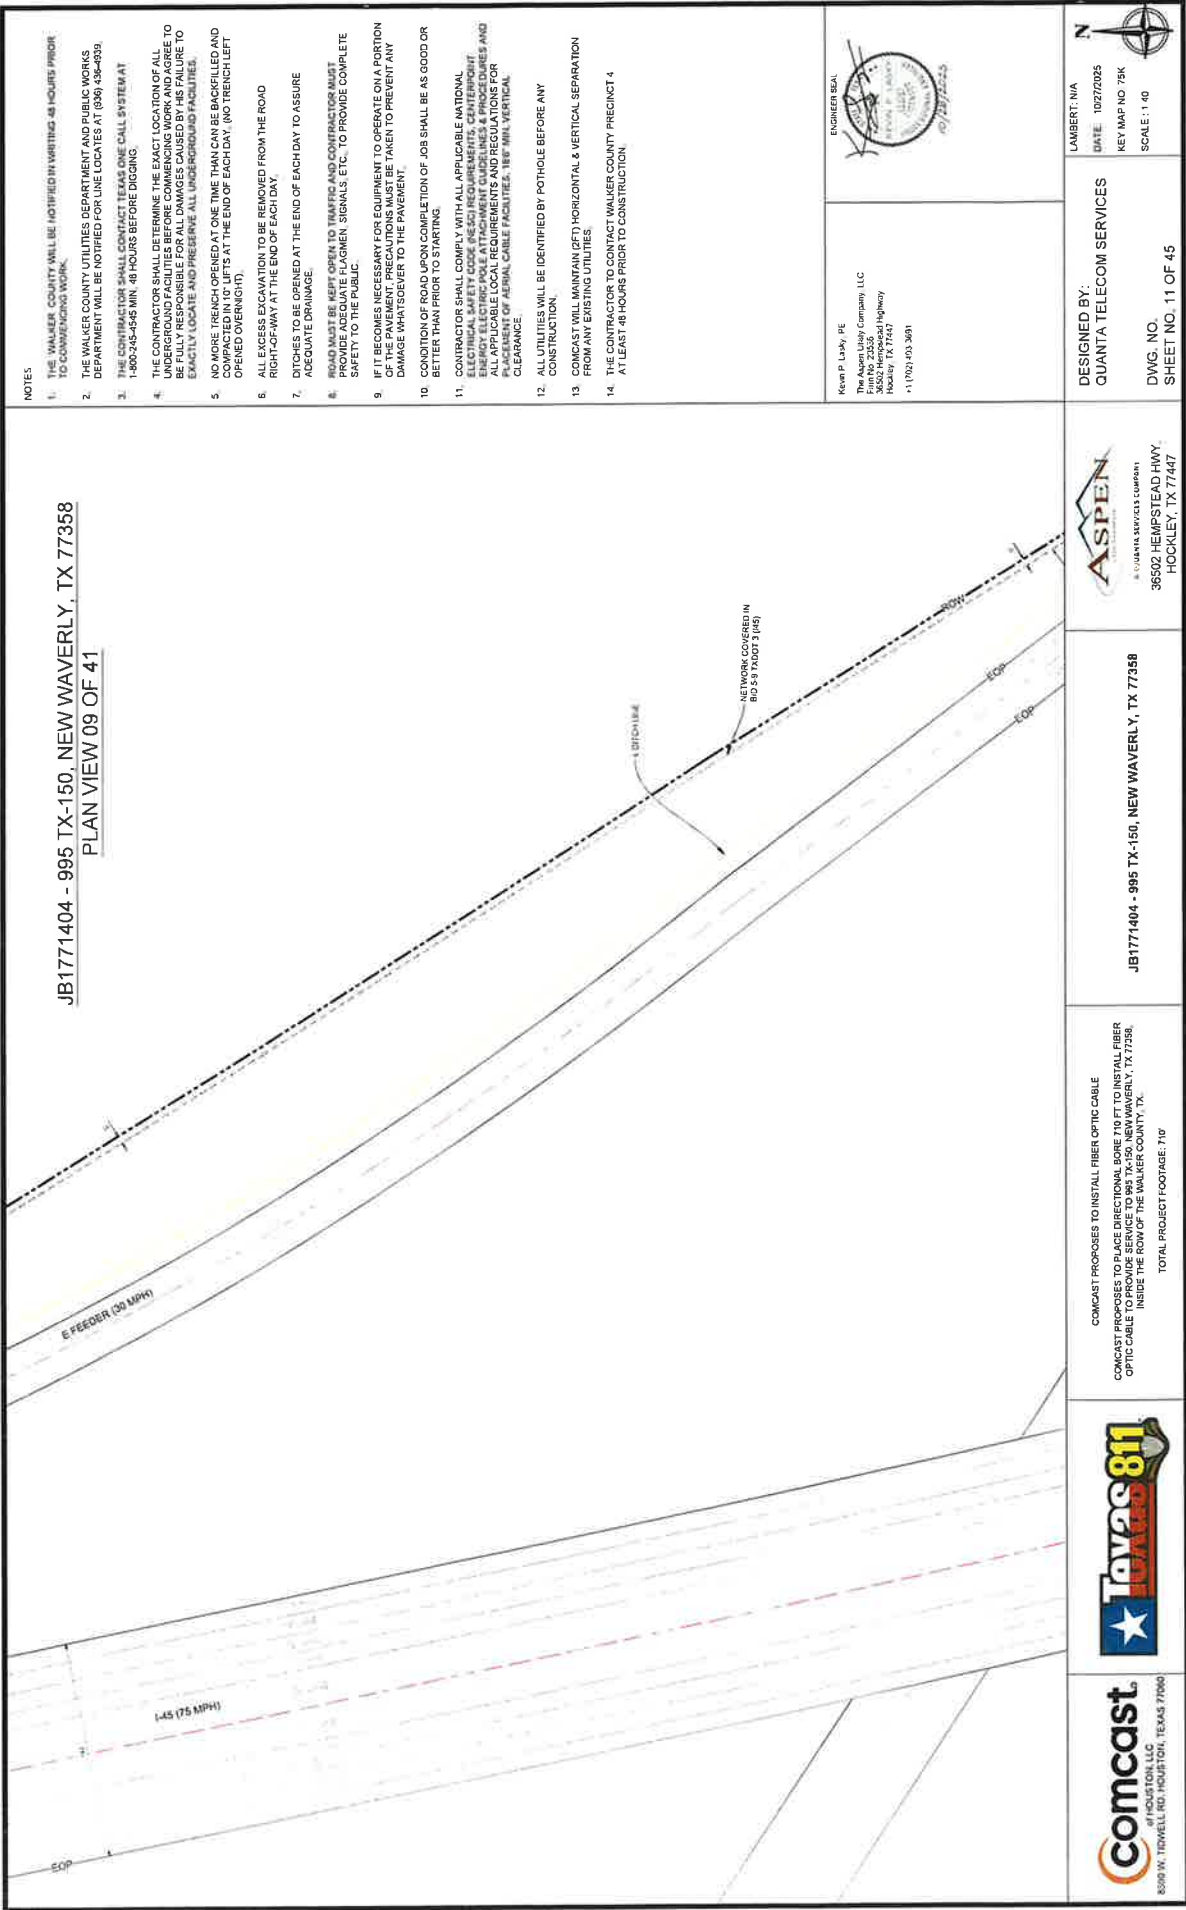



- 1 THE WALKER COUNTY WILL BE NOTIFIED IN WRITING 48 HOURS PRIOR
- 2 TO COMMENCING WORK.
- 3
- 4 THE WALKER COUNTY UTILITIES DEPARTMENT AND PUBLIC WORKS
- 5 DEPARTMENT WILL BE NOTIFIED FOR LINE LOCATES AT (936) 438-0899
- 6
- 7 THE CONTRACTOR SHALL CONTACT TEXAS ONE CALL SYSTEM AT
- 8 1-800-8-5454 MIN. 48 HOURS BEFORE WORK BEGINS.
- 9 THE CONTRACTOR SHALL DETERMINE THE EXACT LOCATION OF ALL
- 10 EXISTING UTILITIES AND MARK THEM WITH REFLECTOR PINS. THE CONTRACTOR
- 11 WILL BE FULLY RESPONSIBLE FOR ALL DAMAGES CAUSED BY HIS FAILURE TO
- 12 EXACTLY LOCATE AND PRESERVE ALL UNDERGROUND UTILITIES.
- 13
- 14 NO MORE TRENCH OPENED AT ONE TIME THAN CAN BE BACKFILLED AND
- 15 COMPACTED IN 10 LIFTS AT THE END OF EACH DAY, NO TRENCH LEFT
- 16 OPENED OVERNIGHT.
- 17
- 18 ALL EXCESS EXCAVATION TO BE REMOVED FROM THE ROAD
- 19 RIGHT-OF-WAY AT THE END OF EACH DAY.
- 20
- 21 STITCHES TO BE ORIED AT THE END OF EACH DAY TO ASSURE
- 22 ADEQUATE DRAINAGE.
- 23
- 24 ROAD MUST BE KEPT OPEN TO TRAFFIC AND CONTRACTOR MUST
- 25 PROVIDE ADEQUATE FLAGMEN SIGNALS, ETC. TO PROVIDE COMPLETE
- 26 SAFETY TO THE PUBLIC.
- 27
- 28 IF IT BECOMES NECESSARY FOR EQUIPMENT TO OPERATE ON A PORTION
- 29 OF THE PAVEMENT, PRECAUTIONS MUST BE TAKEN TO PREVENT ANY
- 30 DAMAGE WHATSOEVER TO THE PAVEMENT.
- 31
- 32 CONDITION OF ROAD UPON COMPLETION OF JOB SHALL BE AS GOOD OR
- 33 BETTER THAN PRIOR TO STARTING.
- 34
- 35 CONTRACTOR SHALL COMPLY WITH ALL APPLICABLE NATIONAL
- 36 ELECTRICAL SAFETY CODE (NEC) REQUIREMENTS, CENTERPOINT
- 37 ENERGY ELECTRIC POLE ATTACHMENT GUIDELINES & PROCEDURES AND
- 38 ALL OTHER APPLICABLE STANDARDS AND SPECIFICATIONS FOR
- 39 PLACEMENT OF AERIAL CABLE FACILITIES, 18" MIN. VERTICAL
- 40 CLEARANCE.
- 41
- 42 ALL UTILITIES WILL BE IDENTIFIED BY POT HOLE BEFORE ANY
- 43 CONSTRUCTION.
- 44
- 45 CONTRACT WILL MAINTAIN LEFT HORIZONTAL & VERTICAL SEPARATION
- 46 FROM ANY EXISTING UTILITIES.
- 47
- 48 THE CONTRACTOR TO CONTACT WALKER COUNTY PRECINCT 4

Kevin P. Lasky PE
The Aspen Utility Company LLC
Fax: No. 235-36
36502 Hempstead Highway
Hockley TX 77447
+1 (702) 493-3691

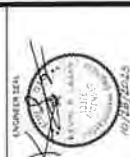

5502 HEMPSTEAD HWY
HOCKLEY, TX 77447

JB1771404 - 995 TX-150, NEW WAVERLY, TX 77358

COMCAST PROPOSES TO PLACE DIRECTIONAL BORE 710 FT TO INSTALL FIBER OPTIC CABLE TO PROVIDE SERVICE TO 985 TX-150, NEW WAVELEY, TX 77358 INSIDE THE ROW OF THE WALKER COUNTY TX



DESIGNED BY:
QUANTA TELECOM SERVICES

DWG NO.
SHEET NO. 13 OF 45

LAMBERT: N/A


DATE 10/27/2015

6320712701 21W0

KEY MAP NO: 75K



JB1771404 - 995 TX-150, NEW WAVERLY, TX 77358
PLAN VIEW 12 OF 41

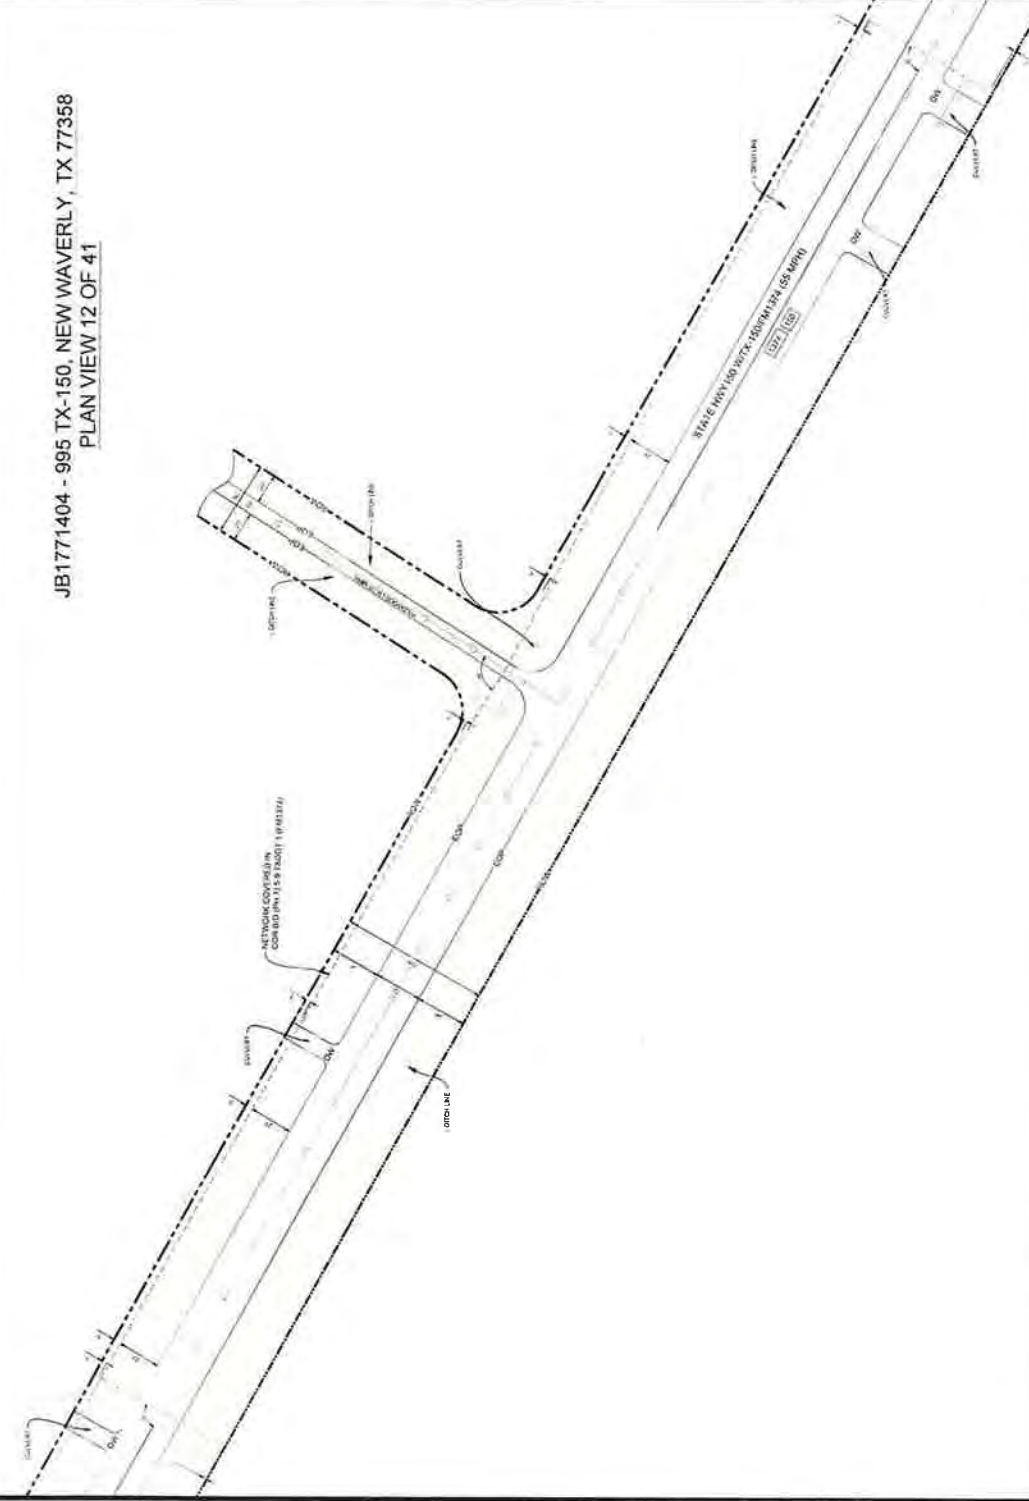

NOTES

1. THE WALKER COUNTY WILL BE NOTIFIED IN WRITING 48 HOURS PRIOR TO COMMENCING WORK.
2. THE WALKER COUNTY UTILITIES DEPARTMENT AND PUBLIC WORKS DEPARTMENT WILL BE NOTIFIED FOR LINE LOCATES AT (890) 436-0393
3. THE CONTRACTOR SHALL CONTACT TEXAS ONE CALL SYSTEM AT 1-800-245-4545 MIN. 48 HOURS BEFORE DIGGING
4. THE CONTRACTOR SHALL DETERMINE THE EXACT LOCATION OF ALL UNDERGROUND FACILITIES BEFORE COMMENCING WORK AND AGREE TO BE FULLY RESPONSIBLE FOR ALL DAMAGES CAUSED BY HIS FAILURE TO EXACTLY LOCATE AND PRESERVE ALL UNDERGROUND FACILITIES
5. NO MORE TRENCH OPENED AT ONE TIME THAN CAN BE BACKFILLED AND COMPACTED IN 10' LIFTS AT THE END OF EACH DAY (NO TRENCH LEFT OPENED OVERNIGHT)
6. ALL EXCESS EXCAVATION TO BE REMOVED FROM THE ROAD RIGHT-OF-WAY AT THE END OF EACH DAY
7. DITCHES TO BE OPENED AT THE END OF EACH DAY TO ASSURE ADEQUATE DRAINAGE
8. ROAD MUST BE KEPT OPEN TO TRAFFIC AND CONTRACTOR MUST PROVIDE ADEQUATE FLAGMEN SIGNALS ETC. TO PROVIDE COMPLETE SAFETY TO THE PUBLIC
9. IF IT BECOMES NECESSARY FOR EQUIPMENT TO OPERATE ON A PORTION OF THE PAVEMENT, PRECAUTIONS MUST BE TAKEN TO PREVENT ANY DAMAGE WHATSOEVER TO THE PAVEMENT
10. CONDITION OF ROAD UPON COMPLETION OF JOB SHALL BE AS GOOD OR BETTER THAN PRIOR TO STARTING
11. CONTRACTOR SHALL COMPLY WITH ALL APPLICABLE NATIONAL ELECTRICAL SAFETY CODE (NEC) REQUIREMENTS, CENTERPOINT ENERGY ELECTRICITY ATTACHMENT GUIDELINES & PROCEDURES AND ALL APPLICABLE LOCAL ORDINANCES. THE CONTRACTOR SHALL MAINTAIN PLACEMENT OF AERIAL CABLE FACILITIES 18' MIN. VERTICAL CLEARANCE
12. ALL UTILITIES WILL BE IDENTIFIED BY POT-HOLE BEFORE ANY CONSTRUCTION
13. COMCAST WILL MAINTAIN (25') HORIZONTAL & VERTICAL SEPARATION FROM ANY EXISTING UTILITIES
14. THE CONTRACTOR TO CONTACT WALKER COUNTY PRECINCT 4 AT LEAST 48 HOURS PRIOR TO CONSTRUCTION

Kevin P. Lasky, PE
The Aspen Utility Company, LLC
1100 N. 205th
Hockley, TX 77447
+1 (281) 493-3031

ENGINEER SEAL



DESIGNED BY:
QUANTA TELECOM SERVICES

LAMBERT: N/A
DATE: 10/27/2025
KEY: MAP NO. 75K
SCALE: 1" = 40'

DWG. NO.
SHEET NO. 14 OF 45



JB1771404 - 995 TX-150, NEW WAVERLY, TX 77358

COMCAST PROPOSES TO INSTALL FIBER OPTIC CABLE
COMCAST PROPOSES TO PLACE DIRECTIONAL BORE 710 FT TO INSTALL FIBER OPTIC CABLE TO PROVIDE SERVICE TO 995 TX-150, NEW WAVERLY, TX 77358, INSIDE THE ROW OF THE WALKER COUNTY, TX
TOTAL PROJECT FOOTAGE: 710'



THE WALKER COUNTY WILL BE NOTIFIED IN WRITING 48 HOURS PRIOR TO COMMENCING WORK.

- 2 THE WALKER COUNTY UTILITIES DEPARTMENT AND PUBLIC WORKS DEPARTMENT WILL BE NOTIFIED FOR LINE LOCATES AT (936) 956-4929
- 3 THE CONTRACTOR SHALL CONTACT TEXAS ONE CALL SYSTEM AT (800) 4-A-HEAD (426-3463), AS APPLICABLE BEFORE DIGGING.
- 4 THE CONTRACTOR SHALL DETERMINE THE EXACT LOCATION OF ALL UNDERGROUND FACILITIES BEFORE COMMENCING WORK AND AGREE TO EXCAVATE AND PRESERVE ALL UNDERGROUND FACILITIES TO EXIST EXACTLY LOCATE AND PRESERVE ALL UNDERGROUND FACILITIES.
- 5 NO MORE TRENCH OPENED AT ONE TIME THAN CAN BE BACKFILLED AND RECLOSED WITHIN 24 HOURS OF EACH DAY. (NO TRENCH LEFT OPENED OVERNIGHT)
- 6 ALL EXCESS EXCAVATION TO BE REMOVED FROM THE ROAD RIGHT-OF-WAY AT THE END OF EACH DAY
- 7 DITCHES TO BE OPENED AT THE END OF EACH DAY TO ASSURE ADEQUATE DRAINAGE.
- 8 ROAD SHALL BE KEPT OPEN TO TRAFFIC AND CONTRACTOR MUST PROVIDE ADEQUATE FLAGMEN SIGNALS, ETC. TO PROVIDE COMPLETE SAFETY TO THE PUBLIC.
- 9 IF IT BECOMES NECESSARY FOR EQUIPMENT TO OPERATE ON A PORTION OF THE PAVEMENT PRECAUTIONS MUST BE TAKEN TO PREVENT ANY DAMAGE WHATSOEVER TO THE PAVEMENT.
- 10 CONDITION OF ROAD UPON COMPLETION OF JOB SHALL BE AS GOOD OR BETTER THAN PRIOR TO STARTING.
- 11 CONTRACTOR SHALL COMPLY WITH ALL APPLICABLE NATIONAL ELECTRICAL SAFETY CODE, NEED REQUIREMENTS, CENTERPOINT ALL APPLICABLE POLE ATTACHMENT GUIDELINES & PROCEDURES AND ALL APPLICABLE LOCAL REQUIREMENTS AND REGULATIONS FOR PLACEMENT OF AERIAL CABLE FACILITIES 18" MIN. VERTICAL CLEARANCE
- 12 ALL UTILITIES WILL BE IDENTIFIED BY POT HOLE BEFORE ANY CONSTRUCTION
- 13 CONCAST WILL MAINTAIN (2FT) HORIZONTAL & VERTICAL SEPARATION FROM ANY EXISTING UTILITIES
- 14 THE CONTRACTOR TO CONTACT WALKER COUNTY PRECINCT 4 AT LEAST 24 HOURS PRIOR TO CONSTRUCTION.

Kevin P. Lasky PE
The Aspen Utility Company LLC
P.O. Box 235
66502 Hempstead Highway
Ackerly TX 77447
1-800-245-5601

DESIGNED BY:
QUANTA TELECOM SERVICES

DESIGNED BY:
QUANTA TELECOM S

DWG. NO.
SHEET NO. 15 OF 45

ASPEN
A Division of Aspen Technology, Inc.
166502 HEMPSTEAD HWY
HOCKLEY, TX 77447

COMCAST PROPOSES TO INSTALL FIBER OPTIC CABLE
COMCAST PROPOSES TO PLACE DIRECTIONAL BORE 710 FT TO INSTALL FIBER
OPTIC CABLE TO PROVIDE SERVICE TO 995 TX-150, NEW WAVELEY, TX 77358
INSIDE THE ROW OF THE WALKER COUNTY, TX
TOTAL PROJECT FOOTAGE: 710'



comcast
#HOUSTON,LLC
3800 W. TIDWELL RD. HOUSTON, TEXAS 77040

LAMBERT N/A
 DATE 10/27/2025
 KEY MAP NO 75K
 SCALE: 1:40



1. THE WALKER COUNTY SHALL BE NOTIFIED BY WRITING 48 HOURS PRIOR TO COMMENCING WORK.
2. THE WALKER COUNTY UTILITIES DEPARTMENT AND PUBLIC WORKS DEPARTMENT WILL BE NOTIFIED FOR ONE LOCATES AT (304) 456-4829
3. THE CONTRACTOR SHALL CONTACT TEXAS ONE CALL SYSTEM AT 1-800-255-4545 WITH 48 HOURS BEFORE DIGGING.
4. THE CONTRACTOR SHALL DETERMINE THE EXACT LOCATION OF ALL UTILITIES AND MARK THEM WITH WHITE FLAG OR PLYWOOD SIGNS TO BE FULLY RESPONSIBLE FOR ALL DAMAGES CAUSED BY HIS FAILURE TO EXACTLY LOCATE AND PRESERVE ALL UNDERGROUND FACILITIES
5. NO MORE TRENCH OPENED AT ONE TIME THAN CAN BE BACKFILLED AND COMPACTED IN 10 LIFTS AT THE END OF EACH DAY (NO TRENCH LEFT OPENED OVERNIGHT)
6. ALL EXCESS EXCAVATION TO BE REMOVED FROM THE ROAD RIGHT-OF-WAY AT THE END OF EACH DAY.
7. DITCHES TO BE OPENED AT THE END OF EACH DAY TO ASSURE ADEQUATE DRAINAGE.
8. ROAD MUST BE KEPT OPEN TO TRAFFIC AND CONTRACTOR MUST PROVIDE ADEQUATE FLAGMEN, SIGNALS, ETC., TO PROVIDE COMPLETE SAFETY TO THE PUBLIC.
9. IF IT BECOMES NECESSARY FOR EQUIPMENT TO OPERATE ON A PORTION OF THE PAVEMENT, PRECAUTIONS MUST BE TAKEN TO PREVENT ANY DAMAGE WHATSOEVER TO THE PAVEMENT
10. CONDITION OF ROAD UPON COMPLETION OF JOB SHALL BE AS GOOD OR BETTER THAN PRIOR TO STARTING.
11. CONTRACTOR SHALL COMPLY WITH ALL APPLICABLE NATIONAL ELECTRICAL, SAFETY CODE (NEC) REQUIREMENTS, CENTERPOINT ENERGY ELECTRIC POLE ATTACHMENT GUIDELINES & PROCEDURES AND ALL OTHER APPLICABLE REGULATIONS AND STANDARDS FOR THE PLACEMENT OF AERIAL CABLE FACILITIES 18" MIN VERTICAL CLEARANCE.
12. ALL UTILITIES WILL BE IDENTIFIED BY POTHOLE BEFORE ANY CONSTRUCTION
13. CONCAST WILL MAINTAIN 20" HORIZONTAL & VERTICAL SEPARATION FROM ANY EXISTING UTILITIES
14. THE CONTRACTOR TO CONTACT WALKER COUNTY PRECINCT 4 AT LEAST 48 HOURS PRIOR TO CONSTRUCTION

Steven P. Lasky, PE
The Aspen Utility Company, LLC
Attn: No. 23526
55502 Hempstead Highway
Duckley, TX 77447
1 (702) 492-3621



comcast
© HOUSTON LLC
550 W. TIDWELL RD HOUSTON TEXAS 77002



COMCAST PROPOSES TO INSTALL FIBER OPTIC CABLE
COMCAST PROPOSES TO PLACE DIRECTIONAL BORE HOLE TO INSTALL FIBER
OPTIC CABLE TO PROVIDE SERVICE TO 995 TX-150 NEW WAVELEY, TX 77358
INSIDE THE ROW OF THE WALKER COUNTY, TX
TOTAL PROJECT FOOTAGE: 710

JB1771404 - 995 TX-150, NEW WAVERLY, TX 77358



66502 HEMPSTEAD HWY
HOCKLEY, TX 77447

DESIGNED BY:
QUANTA TELECOM SERVICES

DWG NO
SHEET NO 16 OF 45

AMBERT: N/A


DATE 10/27/2025

REF MAP NO 75K

SCALE 140



JB1771404 - 995 TX-150, NEW WAVERLY, TX 77358
PLAN VIEW 15 OF 41

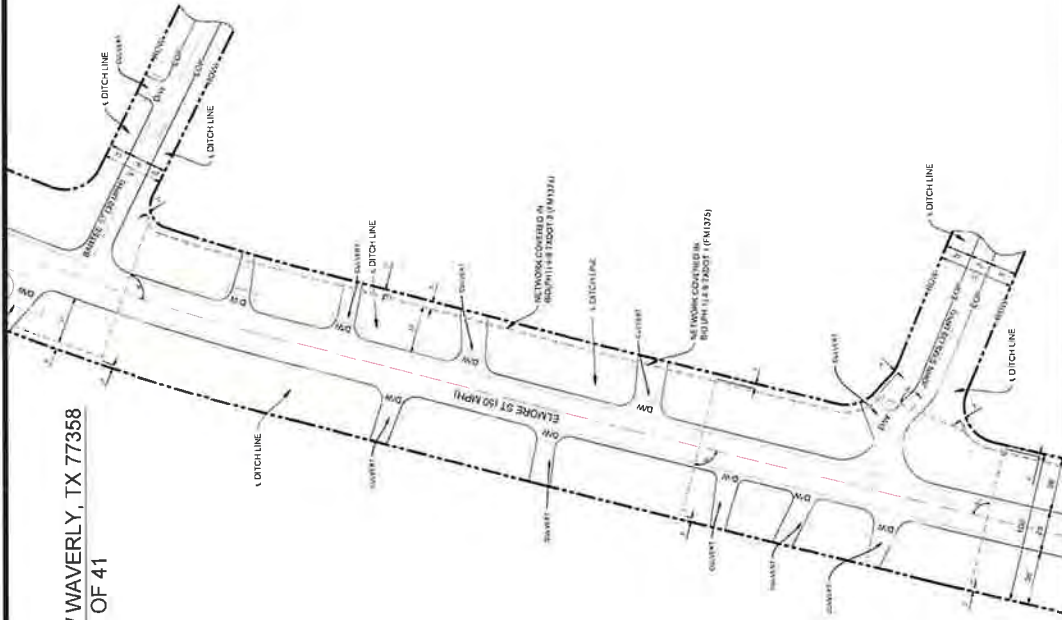

NOTES

- 1 THE WALKER COUNTY WILL BE NOTIFIED IN WRITING 48 HOURS PRIOR TO COMMENCING WORK
- 2 THE WALKER COUNTY UTILITIES DEPARTMENT AND PUBLIC WORKS DEPARTMENT WILL BE NOTIFIED FOR LINE LOCATES AT (836) 456-4899
- 3 THE CONTRACTOR SHALL CONTACT TEXAS ONE CALL SYSTEM AT 1-800-245-8545 MIN. 48 HOURS BEFORE DIGGING
- 4 THE CONTRACTOR SHALL DETERMINE THE EXACT LOCATION OF ALL UNDERGROUND FACILITIES BEFORE COMMENCING WORK AND AGREE TO BE FULLY RESPONSIBLE FOR ALL DAMAGES CAUSED BY HIS FAILURE TO EXACTLY LOCATE AND PRESERVE ALL UNDERGROUND FACILITIES
- 5 NO MORE TRENCH OPENED AT ONE TIME THAN CAN BE BACKFILLED AND COMPACTED IN 10 LIFTS AT THE END OF EACH DAY (NO TRENCH LEFT OPENED OVERNIGHT)
- 6 ALL EXCESS EXCAVATION TO BE REMOVED FROM THE ROAD RIGHT-OF-WAY AT THE END OF EACH DAY
- 7 DITCHES TO BE OPENED AT THE END OF EACH DAY TO ASSURE ADEQUATE DRAINAGE
- 8 ROAD MUST BE KEPT OPEN TO TRAFFIC AND CONTRACTOR MUST PROVIDE ADEQUATE FLAGMEN SIGNALS, ETC. TO PROVIDE COMPLETE SAFETY TO THE PUBLIC
- 9 IF IT BECOMES NECESSARY FOR EQUIPMENT TO OPERATE ON A PORTION OF THE PAVEMENT PRECAUTIONS MUST BE TAKEN TO PREVENT ANY DAMAGE WHATSOEVER TO THE PAVEMENT
- 10 CONDITION OF ROAD UPON COMPLETION OF JOB SHALL BE AS GOOD OR BETTER THAN PRIOR TO STARTING
- 11 CONTRACTOR SHALL COMPLY WITH ALL APPLICABLE NATIONAL ELECTRICAL SAFETY CODE (NEC) REQUIREMENTS, CENTERPOINT ENERGY ELECTRIC POLE ATTACHMENT GUIDELINES & PROCEDURES AND ALL APPLICABLE LOCAL ORDINANCES AND REGULATIONS. THE CONTRACTOR SHALL MAINTAIN CLEARANCE OF ALL UTILITIES. 18" MIN. VERTICAL CLEARANCE
- 12 ALL UTILITIES WILL BE IDENTIFIED BY POT-HOLE BEFORE ANY CONSTRUCTION
- 13 CONTRACTOR WILL MAINTAIN (8" MIN) HORIZONTAL & VERTICAL SEPARATION FROM ANY EXISTING UTILITIES
- 14 THE CONTRACTOR TO CONTACT WALKER COUNTY FREDMINT #1 AT LEAST 48 HOURS PRIOR TO CONSTRUCTION

Kevin P. Lusk, PE
The Aspen Utility Company, LLC
P.O. Box 22538
Houston, Texas 77202
+1 (281) 493-5001

ENGINEER SEAL



JB1771404 - 995 TX-150, NEW WAVERLY, TX 77358

 
COMCAST PROPOSES TO INSTALL FIBER OPTIC CABLE
COMCAST PROPOSES TO PLACE DIRECTIONAL BORE 710 FT TO INSTALL FIBER
OPTIC CABLE TO PROVIDE SERVICE TO 995 TX-150, NEW WAVERLY, TX 77358
INSIDE THE ROW OF THE WALKER COUNTY, TX.
TOTAL PROJECT FOOTAGE 710'



DESIGNED BY:
QUANTA TELECOM SERVICES

DWG. NO.
SHEET NO. 17 OF 45

LAMBERT N/A
DATE 10/27/2025
KEY MAP NO 71K
SCALE 1:40



PLAN VIEW 16 OF 41



1. THE WALKER COUNTY WILL BE NOTIFIED IN WRITING 48 HOURS PRIOR TO COMMENCING WORK
2. THE WALKER COUNTY UTILITIES DEPARTMENT AND PUBLIC WORKS DEPARTMENT WILL BE NOTIFIED FOR LINE LOCATES AT (506) 432-4343
3. THE CONTRACTOR SHALL CONTACT TEXAS ONE CALL SYSTEM AT 1-800-245-6450 MIN. 48 HOURS BEFORE DIGGING
4. THE CONTRACTOR SHALL DETERMINE THE EXACT LOCATION OF ALL UTILITIES TO BE EXCAVATED. THE CONTRACTOR SHALL BE FULLY RESPONSIBLE FOR ALL DAMAGES CAUSED BY HIS FAILURE TO EXACTLY LOCATE AND PRESERVE ALL UNDERGROUND FACILITIES
5. NO MORE TRENCH EXCAVATION AT ONE TIME THAN CAN BE BACKFILLED AND COMPACTED IN 10' LIFTS AT THE END OF EACH DAY. (W/ TRENCH LEFT OPENED OVERNIGHT)
6. ALL EXCESS EXCAVATION TO BE REMOVED FROM THE ROAD RIGHT-OF-WAY AT THE END OF EACH DAY
7. DITCHES TO BE OPENED AT THE END OF EACH DAY TO ASSURE ADEQUATE DRAINAGE
8. ROAD MUST BE KEPT OPEN TO TRAFFIC AND CONTRACTOR MUST PROVIDE ADEQUATE FLAGMEN SIGNALS, ETC. TO PROVIDE COMPLETE SAFETY TO THE PUBLIC
9. IF IT BECOMES NECESSARY FOR EQUIPMENT TO OPERATE ON A PORTION OF THE PAVEMENT PRECAUTIONS MUST BE TAKEN TO PREVENT ANY DAMAGE WHATSOEVER TO THE PAVEMENT
10. CONDITION OF ROAD UPON COMPLETION OF JOB SHALL BE AS GOOD OR BETTER THAN PRIOR TO STARTING
11. CONTRACTOR SHALL COMPLY WITH ALL APPLICABLE NATIONAL ELECTRICAL SAFETY CODE (NEC) REQUIREMENTS. CENTERPOINT ENERGY ELECTRIC POLE & TOWER GUIDELINES & PROCEDURES AND THE TEXAS TRANSMISSION & DISTRIBUTION DEPARTMENT WORK PLACEMENT OF AERIAL CABLE FACILITIES. 18" MIN. VERTICAL CLEARANCE
12. ALL UTILITIES WILL BE IDENTIFIED BY POTHOLE BEFORE ANY CONSTRUCTION
13. CONCAST WILL MAINTAIN (2FT) HORIZONTAL & VERTICAL SEPARATION FROM ANY EXISTING UTILITIES
14. THE CONTRACTOR TO CONTACT WALKER COUNTY, PRECINCT 4 AT LEAST 48 HOURS PRIOR TO CONSTRUCTION



JB1771404 - 995 TX-150, NEW WAVERLY, TX 77358

ASPEN
A WOODWARD CLARK COMPANY
36502 HEMPSTEAD HWY
HOCKLEY, TX 77447

DESIGNED BY:
QUANTA TELECOM SERVICES


DWG NO.
SHEET NO. 18 OF 45

LAMBERT: N/A
DATE 10/27/2007
KEY MAP NO 7
SCALE 1:40



JB1771404 - 995 TX-150, NEW WAVERLY, TX 77358

PLAN VIEW 17 OF 41

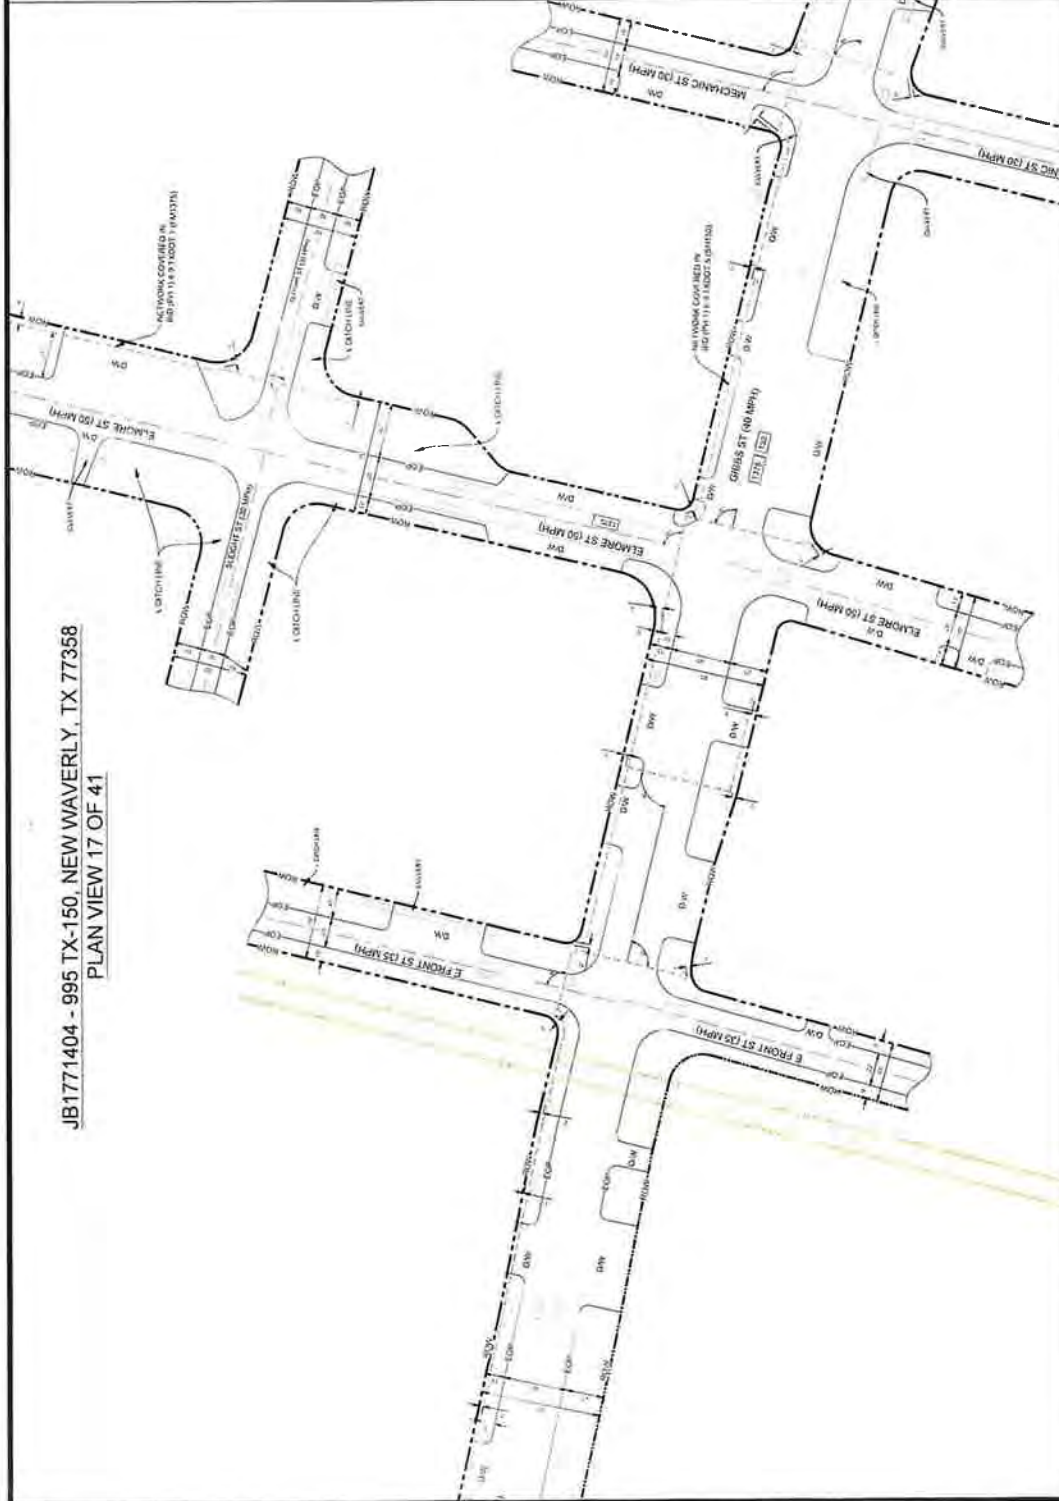


NOTES

1. THE WALKER COUNTY WILL BE NOTIFIED IN WRITING 48 HOURS PRIOR TO COMMENCING WORK.
2. THE WALKER COUNTY UTILITIES DEPARTMENT AND PUBLIC WORKS DEPARTMENT WILL BE NOTIFIED FOR LINE LOCATES AT (888) 456-4839
3. THE CONTRACTOR SHALL CONTACT TEXAS ONE CALL SYSTEM AT 1-800-245-4545 MIN. 48 HOURS BEFORE DIGGING
4. THE CONTRACTOR SHALL DETERMINE THE EXACT LOCATION OF ALL UNDERGROUND FACILITIES BEFORE COMMENCING WORK AND AGREE TO BE FULLY RESPONSIBLE FOR ALL DAMAGES CAUSED BY HIS FAILURE TO EXACTLY LOCATE AND PRESERVE ALL UNDERGROUND FACILITIES
5. NO MORE TRENCH OPENED AT ONE TIME THAN CAN BE BACKFILLED AND COMPACTED IN 10' LIFTS AT THE END OF EACH DAY (NO TRENCH LEFT OPENED OVERNIGHT)
6. ALL EXCESS EXCAVATION TO BE REMOVED FROM THE ROAD RIGHT-OF-WAY AT THE END OF EACH DAY
7. DITCHES TO BE OPENED AT THE END OF EACH DAY TO ASSURE ADEQUATE DRAINAGE
8. ROAD MUST BE KEPT OPEN TO TRAFFIC AND CONTRACTOR MUST PROVIDE ADEQUATE FLAGMEN SIGNALS ETC. TO PROVIDE COMPLETE SAFETY TO THE PUBLIC
9. IF IT BECOMES NECESSARY FOR EQUIPMENT TO OPERATE ON A PORTION OF THE PAVEMENT, PRECAUTIONS MUST BE TAKEN TO PREVENT ANY DAMAGE WHATSOEVER TO THE PAVEMENT
10. CONDITION OF ROAD UPON COMPLETION OF JOB SHALL BE AS GOOD OR BETTER THAN PRIOR TO STARTING
11. CONTRACTOR SHALL COMPLY WITH ALL APPLICABLE NATIONAL ELECTRICAL SAFETY CODE (NEC) REQUIREMENTS, CENTERPOINT ENERGY ELECTRIC POLE ATTACHMENT GUIDELINES & PROCEDURES AND ALL OTHER APPLICABLE REQUIREMENTS. THE CONTRACTOR SHALL MAINTAIN ADEQUATE CLEARANCE OF AERIAL CABLE FACILITIES. 18" MIN. VERTICAL CLEARANCE
12. ALL UTILITIES WILL BE IDENTIFIED BY POTHOLE BEFORE ANY CONSTRUCTION
13. CONCAST WILL MAINTAIN (2FT) HORIZONTAL & VERTICAL SEPARATION FROM ANY EXISTING UTILITIES
14. THE CONTRACTOR TO CONTACT WALKER COUNTY PRECINCT 4 AT LEAST 48 HOURS PRIOR TO CONSTRUCTION

Kovach P. Lamy, PE
The Aspen Utility Company, LLC
P.O. Box 225-25
Hockley, TX 77447
11/1/2024 09:30:01



 DESIGNED BY:
QUANTA TELECOM SERVICES



36502 HEMPSTEAD HWY
HOCKLEY, TX 77447

JB1771404 - 995 TX-150, NEW WAVERLY, TX 77358

CONCAST PROPOSES TO INSTALL FIBER OPTIC CABLE
CONCAST PROPOSES TO PLACE DIRECTIONAL BORE 210 FT TO INSTALL FIBER
OPTIC CABLE TO PROVIDE SERVICE TO 995 TX-150, NEW WAVERLY, TX 77358
INSIDE THE ROW OF THE WALKER COUNTY, TX
TOTAL PROJECT FOOTAGE: 710'



LAUREN NIA
DATE: 10/27/2025
KEY MAP NO. 75K
SCALE: 1" = 40'

DWG. NO.
SHEET NO. 19 OF 45



1. THE WALKER COUNTY WILL BE NOTIFIED IN WRITING 48 HOURS PRIOR TO COMMENCING WORK.
2. THE WALKER COUNTY UTILITIES DEPARTMENT AND PUBLIC WORKS DEPARTMENT WILL BE NOTIFIED FOR LINE LOCATES AT 1306 434-4239
3. THE CONTRACTOR SHALL CONTACT TEXAS ONE CALL SYSTEM AT 1-800-455-4555 MIN. 48 HOURS BEFORE COMMENCE
4. THE CONTRACTOR SHALL DETERMINE THE EXACT LOCATION OF ALL EXISTING UTILITIES AND RECORD THEM ON THE PLANS. THE CONTRACTOR SHALL BE FULLY RESPONSIBLE FOR ALL DAMAGES CAUSED BY HIS FAILURE TO EXACTLY LOCATE AND PRESERVE ALL UNDERGROUND FACILITIES
5. NO MORE TRENCH OPERATED AT ONE TIME THAN CAN BE BACKFILLED AND COMPACTED IN LIFTS AT THE END OF EACH DAY (NO TRENCH LEFT OPENED OVERNIGHT)
6. ALL EXCESS EXCAVATION TO BE REMOVED FROM THE ROAD RIGHT-OF-WAY AT THE END OF EACH DAY
7. DITCHES TO BE OPENED AT THE END OF EACH DAY TO ASSURE ADEQUATE DRAINAGE
8. ROAD MUST BE KEPT OPEN TO TRAFFIC AND CONTRACTOR MUST PROVIDE ADEQUATE FLAGMEN SIGNALS, ETC. TO PROVIDE COMPLETE SAFETY TO THE PUBLIC.
9. IF IT BECOMES NECESSARY FOR EQUIPMENT TO OPERATE ON A PORTION OF THE PAVEMENT, PREPARATIONS MUST BE TAKEN TO PREVENT ANY DAMAGE WHATSOEVER TO THE PAVEMENT
10. CONDITION OF ROAD UPON COMPLETION OF JOB SHALL BE AS GOOD OR BETTER THAN PRIOR TO STARTING
11. CONTRACTOR SHALL COMPLY WITH ALL APPLICABLE NATIONAL, ELECTRICAL, SAFETY CODE (NEC) REQUIREMENTS, CIRCULARS AND ENERGY RELATED RULE (FEDERAL GUIDELINES & PROCEDURES) AND ALL OTHER APPLICABLE REGULATIONS AND ORDINANCES. WORK PLACEMENT OF AERIAL CABLE FACILITIES: 18" MIN VERTICAL CLEARANCE
12. ALL UTILITIES WILL BE IDENTIFIED BY POT HOLE BEFORE ANY CONSTRUCTION
13. CONCASS WILL MAINTAIN (27") HORIZONTAL & VERTICAL SEPARATION FROM ANY EXISTING UTILITIES
14. THE CONTRACTOR TO CONTACT WALKER COUNTY (PRECINCT 4) AT LEAST 48 HOURS PRIOR TO CONSTRUCTION

ENGINEER SEAL



CONCAST PROPOSES TO PLACE DIRECTIONAL BORE 710 FT TO INSTALL OPTIC CABLE TO PROVIDE SERVICE TO 995 TX-150 NEW WAVERLY, INSIDE THE ROW OF THE WALKER COUNTY TX

JB1771404 - 99S TX-150, NEW WAVERLY, TX 77358



6502 HEMPSTEAD HWY,
HOCKLEY, TX 77447

DESIGNED BY:
QUANTA TELECOM SERVICES

DWG NO
SHEET NO 20 OF 45

LAMBERT N/A


NAME _____ **DATE** _____

DATE 10/27/2025

KEY MAP NO 75K



JB1771404 - 995 TX-150, NEW WAVERLY, TX 77358
PLAN VIEW 19 OF 41


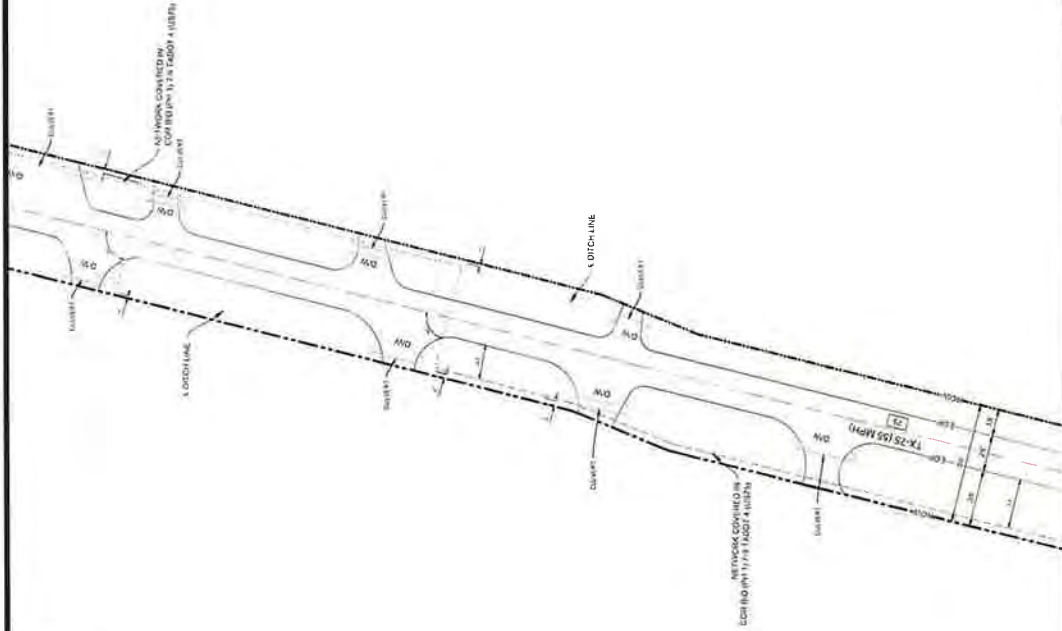


NOTES

1. THE WALKER COUNTY WILL BE NOTIFIED IN WRITING 48 HOURS PRIOR TO COMMENCING WORK.
2. THE WALKER COUNTY UTILITIES DEPARTMENT AND PUBLIC WORKS DEPARTMENT WILL BE NOTIFIED FOR LINE LOCATES AT (830) 438-4939.
3. THE CONTRACTOR SHALL CONTACT TEXAS ONE CALL SYSTEM AT 1-800-255-4545 MIN 48 HOURS BEFORE DIGGING.
4. THE CONTRACTOR SHALL DETERMINE THE EXACT LOCATION OF ALL UNDERGROUND FACILITIES BEFORE COMMENCING WORK AND AGREE TO BE FULLY RESPONSIBLE FOR ALL DAMAGE CAUSED BY ANY FAILURE TO EXISTING LOCATE AND PRESERVE ALL UNDERGROUND FACILITIES.
5. NO MORE TRENCH OPENED AT ONE TIME THAN CAN BE BACKFILLED AND COMPLETED WITHIN 24 HOURS OF THE END OF EACH DAY (NO TRENCH LEFT OPENED OVERNIGHT).
6. ALL EXCESS EXCAVATION TO BE REMOVED FROM THE ROAD RIGHT-OF-WAY AT THE END OF EACH DAY.
7. DITCHES TO BE OPENED AT THE END OF EACH DAY TO ASSURE ADEQUATE DRAINAGE.
8. ROAD MUST BE KEPT OPEN TO TRAFFIC AND CONTRACTOR MUST PROVIDE ADEQUATE FLAGMEN, SIGNALS, ETC. TO PROVIDE COMPLETE SAFETY TO THE PUBLIC.
9. IF IT BECOMES NECESSARY FOR EQUIPMENT TO OPERATE ON A PORTION OF THE PAVEMENT, PRECAUTIONS MUST BE TAKEN TO PREVENT ANY DAMAGE WHATSOEVER TO THE PAVEMENT.
10. CONDITION OF ROAD UPON COMPLETION OF JOB SHALL BE AS GOOD OR BETTER THAN PRIOR TO STARTING.
11. CONTRACTOR SHALL COMPLY WITH ALL APPLICABLE NATIONAL ELECTRICAL SAFETY CODE (NEC) REQUIREMENTS, CENTERPOINT ELECTRICITY DELIVERY SYSTEMS, AND ALL APPLICABLE LOCAL, STATE, AND FEDERAL REQUIREMENTS AND REGULATIONS FOR PLACEMENT OF AERIAL CABLE FACILITIES. 18" MIN VERTICAL CLEARANCE.
12. ALL UTILITIES WILL BE IDENTIFIED BY POTHOLE BEFORE ANY CONSTRUCTION.
13. CONCAT WILL MAINTAIN 2 FT HORIZONTAL & VERTICAL SEPARATION FROM ANY EXISTING UTILITIES.
14. THE CONTRACTOR TO CONTACT WALKER COUNTY PRECINCT 4 AT LEAST 48 HOURS PRIOR TO CONSTRUCTION.

Kenneth P. Lundy, PE
The Aspen Utility Company, LLC
P.O. Box 233,000
Houston, Texas 77243
+1 (702) 493-3011

  ENGINEER'S SEAL



38502 HEMPSTEAD HWY
HOOKLET, TX 77447

JB1771404 - 995 TX-150, NEW WAVERLY, TX 77358

CONCAT PROPOSES TO INSTALL FIBER OPTIC CABLE
CONCAT PROPOSES TO PLACE DIRECTIONAL BORE 710 FT TO INSTALL FIBER OPTIC CABLE TO PROVIDE SERVICE TO 995 TX-150, NEW WAVERLY, TX 77358 INSIDE THE ROW OF THE WALKER COUNTY, TX.
TOTAL PROJECT FOOTAGE: 710



DESIGNED BY:
QUANTA TELECOM SERVICES

DWG. NO.
SHEET NO. 21 OF 45

LAMBERT, N/A


DATE: 10/27/2025

KEY MAP NO. 75K

SCALE: 1" = 40'




JB1771404 - 995 TX-150, NEW WAVERLY, TX 77358
PLAN VIEW 20 OF 41

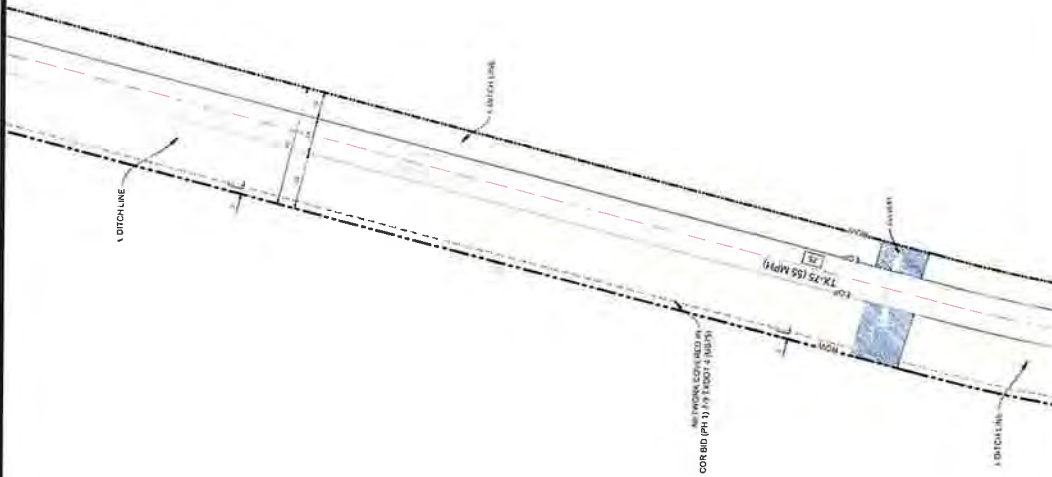

NOTES

1. THE WALKER COUNTY WILL BE NOTIFIED IN WRITING 48 HOURS PRIOR TO COMMENCING WORK.
2. THE WALKER COUNTY UTILITIES DEPARTMENT AND PUBLIC WORKS DEPARTMENT WILL BE NOTIFIED FOR LINE LOCATES AT (836) 438-4398.
3. THE CONTRACTOR SHALL CONTACT TEXAS ONE CALL SYSTEM AT 1-800-245-4545 MIN. 48 HOURS BEFORE DIGGING.
4. THE CONTRACTOR SHALL DETERMINE THE EXACT LOCATION OF ALL UNDERGROUND UTILITIES PRIOR TO ANY CONSTRUCTION. THE CONTRACTOR SHALL BE FULLY RESPONSIBLE FOR ALL DAMAGES CAUSED BY HIS FAILURE TO EXACTLY LOCATE AND PRESERVE ALL UNDERGROUND FACILITIES.
5. NO MORE TRENCH OPENED AT ONE TIME THAN CAN BE BACKFILLED AND COMPACTED IN 10' LIFTS AT THE END OF EACH DAY (NO TRENCH LEFT OPENED OVERNIGHT).
6. ALL EXCESS EXCAVATION TO BE REMOVED FROM THE ROAD RIGHT-OF-WAY AT THE END OF EACH DAY.
7. DITCHES TO BE OPENED AT THE END OF EACH DAY TO ASSURE ADEQUATE DRAINAGE.
8. ROAD MUST BE KEPT OPEN TO TRAFFIC AND CONTRACTOR MUST PROVIDE ADEQUATE FLAGMEN, SIGNALS, ETC. TO PROVIDE COMPLETE SAFETY TO THE PUBLIC.
9. IF IT BECOMES NECESSARY FOR EQUIPMENT TO OPERATE ON A PORTION OF THE PAVEMENT, PRECAUTIONS MUST BE TAKEN TO PREVENT ANY DAMAGE WHATSOEVER TO THE PAVEMENT.
10. CONDITION OF ROAD UPON COMPLETION OF JOB SHALL BE AS GOOD OR BETTER THAN PRIOR TO STARTING.
11. CONTRACTOR SHALL COMPLY WITH ALL APPLICABLE NATIONAL ELECTRICAL SAFETY CODE (NEC) REQUIREMENTS, CENTERPOINT ENERGY ELECTRIC POLE ATTACHMENT GUIDELINES & PROCEDURES AND ALL APPLICABLE CITY, COUNTY AND STATE REGULATIONS FOR THE PROTECTION OF AERIAL CABLE FACILITIES. 18" MIN. VERTICAL CLEARANCE.
12. ALL UTILITIES WILL BE IDENTIFIED BY POTHOLE BEFORE ANY CONSTRUCTION.
13. COMCAST WILL MAINTAIN (2FT) HORIZONTAL & VERTICAL SEPARATION FROM ANY EXISTING UTILITIES.
14. THE CONTRACTOR TO CONTACT WALKER COUNTY PRECINCT 4 AT LEAST 48 HOURS PRIOR TO CONSTRUCTION.

Kevin P. Lashy, PE
The Aspen Utility Company, LLC
Firm No. 23256
10000 Highway 100, Suite 100
Hockley, TX 77447
+1 (702) 403-3001

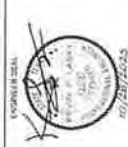

COMCAST PROPOSES TO INSTALL FIBER OPTIC CABLE
COMCAST PROPOSES TO PLACE DIRECTIONAL BORE 7.0 FT TO INSTALL FIBER OPTIC CABLE TO PROVIDE SERVICE TO 995 TX-150, NEW WAVERLY, TX 77358 INSIDE THE ROW OF THE WALKER COUNTY, TX
TOTAL PROJECT FOOTAGE: 710'

JB1771404 - 995 TX-150, NEW WAVERLY, TX 77358




DESIGNED BY:
QUANTA TELECOM SERVICES
DWG. NO.
SHEET NO. 22 OF 45

LAMBERT N/A
DATE 10/27/2025
KEY MAP NO 75K
SCALE 1" = 40'



JB1771404 - 995 TX-150, NEW WAVERLY, TX 77358
 PLAN VIEW 21 OF 41

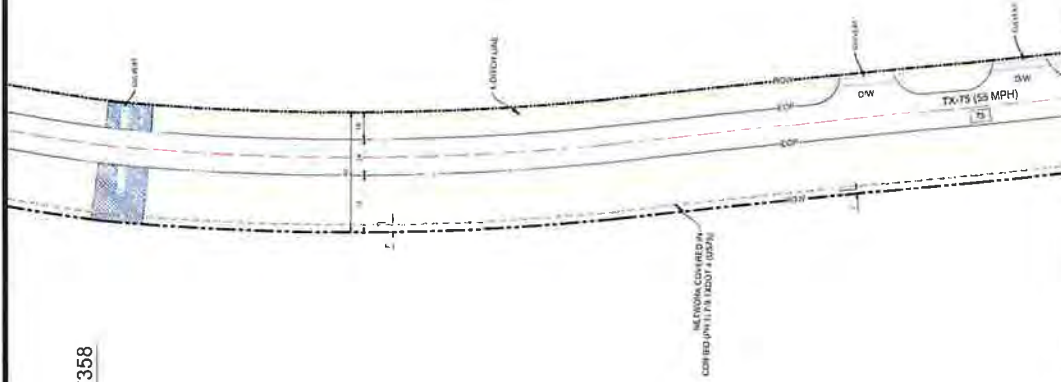

NOTES

1. THE WALKER COUNTY WILL BE NOTIFIED IN WRITING 48 HOURS PRIOR TO COMMENCING WORK.
2. THE WALKER COUNTY UTILITIES DEPARTMENT AND PUBLIC WORKS DEPARTMENT WILL BE NOTIFIED FOR LINE LOCATES AT (888) 458-4939.
3. THE CONTRACTOR SHALL CONTACT TEXAS ONE CALL SYSTEM AT 1-800-245-4545 MIN. 48 HOURS BEFORE DIGGING.
4. THE CONTRACTOR SHALL DETERMINE THE EXACT LOCATION OF ALL UNDERGROUND FACILITIES BEFORE COMMENCING WORK AND AGREE TO EXISTING REMAINING FACILITIES. THE CONTRACTOR SHALL BE RESPONSIBLE TO EXACTLY LOCATE AND PRESERVE ALL UNDERGROUND FACILITIES.
5. NO MORE TRENCH OPENED AT ONE TIME THAN CAN BE BACKFILLED AND COMPLETED WITHIN 24 HOURS OF THE END OF EACH DAY (NO TRENCH LEFT OPENED OVERNIGHT).
6. ALL EXCESS EXCAVATION TO BE REMOVED FROM THE ROAD RIGHT-OF-WAY AT THE END OF EACH DAY.
7. DITCHES TO BE OPENED AT THE END OF EACH DAY TO ASSURE ADEQUATE DRAINAGE.
8. ROAD MUST BE KEPT OPEN TO TRAFFIC AND CONTRACTOR MUST PROVIDE ADEQUATE FLAGMEN, SIGNALS, ETC. TO PROVIDE COMPLETE SAFETY TO THE PUBLIC.
9. IF IT BECOMES NECESSARY FOR EQUIPMENT TO OPERATE ON A PORTION OF THE PAVEMENT, PRECAUTIONS MUST BE TAKEN TO PREVENT ANY DAMAGE WHEN GIVEN TO THE PAVEMENT.
10. CONDITION OF ROAD UPON COMPLETION OF JOB SHALL BE AS GOOD OR BETTER THAN PRIOR TO STARTING.
11. CONTRACTOR SHALL COMPLY WITH ALL APPLICABLE NATIONAL ELECTRICAL SAFETY CODE (NEC) REQUIREMENTS, CENTERPOINT ENERGY COMPANY, INC. (CEC) REQUIREMENTS, AND ALL APPLICABLE LOCAL REQUIREMENTS AND REGULATIONS FOR PLACEMENT OF AERIAL CABLE FACILITIES. 18" MIN. VERTICAL CLEARANCE.
12. ALL UTILITIES WILL BE IDENTIFIED BY POTHOLE BEFORE ANY CONSTRUCTION.
13. COMCAST WILL MAINTAIN 6FT HORIZONTAL & VERTICAL SEPARATION FROM ANY EXISTING UTILITIES.
14. THE CONTRACTOR TO CONTACT WALKER COUNTY PRECINCT 4 AT LEAST 48 HOURS PRIOR TO CONSTRUCTION.

Kent P. Lusk, PE
 The Aspen Utility Company, LLC
 2500 W. Highway
 Hooksett, TX 77443
 +1 (702) 463-3601



COMCAST PROPOSES TO INSTALL FIBER OPTIC CABLE
 COMCAST PROPOSES TO PLACE DIRECTIONAL BORE 710 FT TO INSTALL FIBER OPTIC CABLE TO PROVIDE SERVICE TO 995 TX-150, NEW WAVERLY, TX 77358.
 INSIDE THE ROW OF THE WALKER COUNTY, TX.
 TOTAL PROJECT FOOTAGE 710'


JB1771404 - 995 TX-150, NEW WAVERLY, TX 77358



DESIGNED BY:
 QUANTA TELECOM SERVICES
 DWG. NO.
 SHEET NO. 23 OF 45



JB1771404 - 995 TX-150, NEW WAVERLY, TX 77358
PLAN VIEW 22 OF 41

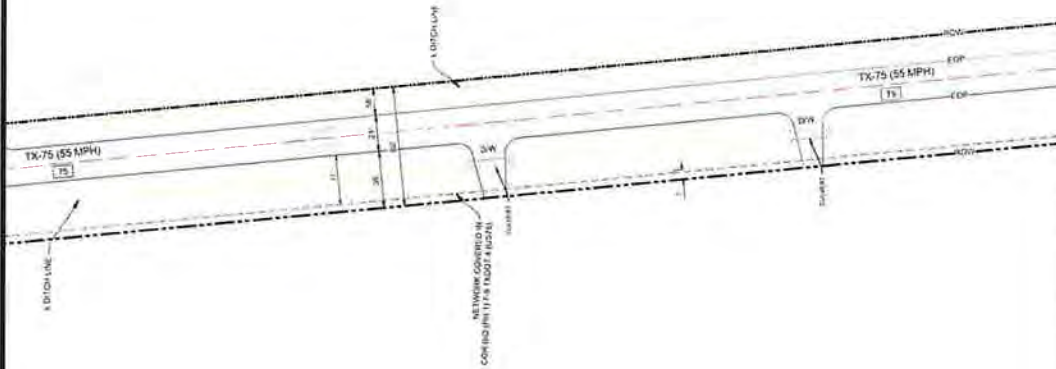

NOTES

1. THE WALKER COUNTY WILL BE NOTIFIED IN WRITING 48 HOURS PRIOR TO COMMENCING WORK.
2. THE WALKER COUNTY UTILITIES DEPARTMENT AND PUBLIC WORKS DEPARTMENT WILL BE NOTIFIED FOR LINE LOCATES AT (936) 436-4399.
3. THE CONTRACTOR SHALL CONTACT TEXAS ONE CALL SYSTEM AT 1-800-245-4545 MIN. 48 HOURS BEFORE DIGGING.
4. THE CONTRACTOR SHALL DETERMINE THE EXACT LOCATION OF ALL UNDERGROUND FACILITIES BEFORE COMMENCING WORK AND AGREE TO BE FULLY RESPONSIBLE FOR ALL DAMAGES CAUSED BY HIS FAILURE TO EXACTLY LOCATE AND PRESERVE ALL UNDERGROUND FACILITIES.
5. NO MORE TRENCH OPENED AT ONE TIME THAN CAN BE BACKFILLED AND COMPACTED IN 107 LIFTS AT THE END OF EACH DAY. (NO TRENCH LEFT OPENED OVERNIGHT)
6. ALL EXCESS EXCAVATION TO BE REMOVED FROM THE ROAD RIGHT-OF-WAY AT THE END OF EACH DAY.
7. DITCHES TO BE OPENED AT THE END OF EACH DAY TO ASSURE ADEQUATE DRAINAGE.
8. ROAD MUST BE KEPT OPEN TO TRAFFIC AND CONTRACTOR MUST PROVIDE ADEQUATE FLAGMEN, SIGNALS, ETC. TO PROVIDE COMPLETE SAFETY TO THE PUBLIC.
9. IF IT BECOMES NECESSARY FOR EQUIPMENT TO OPERATE ON A PORTION OF THE PAVEMENT, PRECAUTIONS MUST BE TAKEN TO PREVENT ANY DAMAGE WHATSOEVER TO THE PAVEMENT.
10. CONDITION OF ROAD UPON COMPLETION OF JOB SHALL BE AS GOOD OR BETTER THAN PRIOR TO STARTING.
11. CONTRACTOR SHALL COMPLY WITH ALL APPLICABLE NATIONAL ELECTRICAL SAFETY CODE (NEC) REQUIREMENTS, CENTERPOINT ENERGY ELECTRIC POLE ATTACHMENT GUIDELINES & PROCEDURES AND ALL APPLICABLE LOCAL ORDINANCES AND REGULATIONS FOR THE PLACEMENT OF AERIAL CABLE FACILITIES. 18" MIN. VERTICAL CLEARANCE.
12. ALL UTILITIES WILL BE IDENTIFIED BY POTHOLE BEFORE ANY CONSTRUCTION.
13. COMCAST WILL MAINTAIN 8FT/10 FT HORIZONTAL & VERTICAL SEPARATION FROM ANY EXISTING UTILITIES.
14. THE CONTRACTOR TO CONTACT WALKER COUNTY PRECINCT 4 AT LEAST 48 HOURS PRIOR TO CONSTRUCTION.

ENGINEER SEAL

Kevin P. Lacey, P.E.
The Aspen Liberty Company, LLC
P.O. Box 23206
Houston, Texas 77202-0206
Hockley, TX 77447
+1 (702) 493-5091




COMCAST PROPOSES TO INSTALL FIBER OPTIC CABLE
COMCAST PROPOSES TO PLACE DIRECTIONAL BORE 18 FT TO INSTALL FIBER
OPTIC CABLE TO PROVIDE SERVICE TO 995 TX-150, NEW WAVERLY, TX 77358
INSIDE THE ROW OF THE WALKER COUNTY, TX.
TOTAL PROJECT FOOTAGE: 110'

JB1771404 - 995 TX-150, NEW WAVERLY, TX 77358




DESIGNED BY:
QUANTA TELECOM SERVICES

 DWG. NO. 24 OF 45
SHEET NO. 24 OF 45



JB1771404 - 995 TX-150, NEW WAVERLY, TX 77358
 PLAN VIEW 23 OF 41

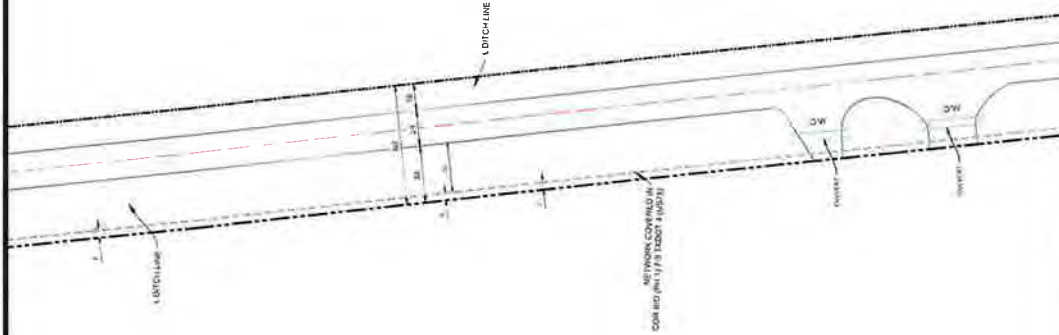

NOTES

1. THE WALKER COUNTY WILL BE NOTIFIED IN WRITING 48 HOURS PRIOR TO COMMENCING WORK.
2. THE WALKER COUNTY UTILITIES DEPARTMENT AND PUBLIC WORKS DEPARTMENT WILL BE NOTIFIED FOR LINE LOCATES AT (866) 436-4399.
3. THE CONTRACTOR SHALL CONTACT TEXAS ONE CALL SYSTEM AT 1-800-368-5454 MIN. 48 HOURS BEFORE DIGGING.
4. THE CONTRACTOR SHALL DETERMINE THE EXACT LOCATION OF ALL UNDERGROUND FACILITIES BEFORE COMMENCING WORK AND AGREE TO BE FULLY RESPONSIBLE FOR ALL DAMAGES CAUSED BY HIS FAILURE TO EXACTLY LOCATE AND PRESERVE ALL UNDERGROUND FACILITIES.
5. NO MORE TRENCH OPENED AT ONE TIME THAN CAN BE BACKFILLED AND COMPACTED IN 10 LIFTS AT THE END OF EACH DAY (NO TRENCH LEFT OPENED OVERNIGHT).
6. ALL EXCESS EXCAVATION TO BE REMOVED FROM THE ROAD RIGHT-OF-WAY AT THE END OF EACH DAY.
7. DITCHES TO BE OPENED AT THE END OF EACH DAY TO ASSURE ADEQUATE DRAINAGE.
8. ROAD MUST BE KEPT OPEN TO TRAFFIC AND CONTRACTOR MUST PROVIDE ADEQUATE FLAGMEN SIGNALS, ETC. TO PROVIDE COMPLETE SAFETY TO THE PUBLIC.
9. IF IT BECOMES NECESSARY FOR EQUIPMENT TO OPERATE ON A PORTION OF THE PAVEMENT, PRECAUTIONS MUST BE TAKEN TO PREVENT ANY DAMAGE WHATSOEVER TO THE PAVEMENT.
10. CONSTRUCTION OF ROAD UPON COMPLETION OF JOB SHALL BE AS GOOD OR BETTER THAN PRIOR TO STARTING.
11. CONTRACTOR SHALL COMPLY WITH ALL APPLICABLE NATIONAL ELECTRICAL SAFETY CODE (NEC) REQUIREMENTS, CENTERPOINT ENERGY ELECTRIC CODE ATTACHMENT GUIDELINES & PROCEDURES AND ALL OTHER APPLICABLE REGULATIONS AND ORDINANCES FOR THE PLACEMENT OF AERIAL CABLE FACILITIES. 18" MIN VERTICAL CLEARANCE.
12. ALL UTILITIES WILL BE IDENTIFIED BY POT-HOLE BEFORE ANY CONSTRUCTION.
13. CONCAST WILL MAINTAIN (GFI) HORIZONTAL & VERTICAL SEPARATION FROM ANY EXISTING UTILITIES.
14. THE CONTRACTOR TO CONTACT WALKER COUNTY PRECINCT 4 AT (866) 436-4399 PRIOR TO COMMENCING WORK.

Kevin P. Lash, PE
 The Aspen Utility Company, LLC
 Firm No. 235-06
 10000 Highway
 Houston, TX 77041
 • (1) (202) 493-3691

ENGINEER SEAL



CONCAST PROPOSES TO INSTALL FIBER OPTIC CABLE
 CONCAST PROPOSES TO PLACE DIRECTIONAL BORE 318 FT TO INSTALL FIBER OPTIC CABLE TO PROVIDE SERVICE TO 995 TX-150, NEW WAVERLY, TX 77358, INSIDE THE ROW OF THE WALKER COUNTY, TX.
 TOTAL PROJECT FOOTAGE: 710'

JB1771404 - 995 TX-150, NEW WAVERLY, TX 77358




DESIGNED BY:
 QUANTA TELECOM SERVICES

DWG. NO.
 SHEET NO. 25 OF 45

LAMBERT N/A
 DATE 10/27/2025
 KEY MAP NO 75K
 SCALE: 1" = 40'



JB1771404 - 995 TX-150, NEW WAVERLY, TX 77358
PLAN VIEW 24 OF 41

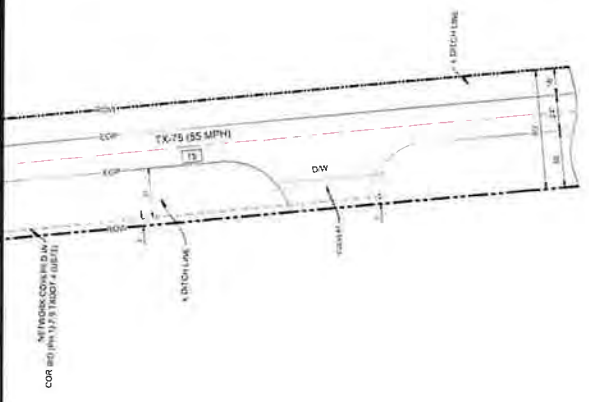

NOTES

- 1 THE WALKER COUNTY WILL BE NOTIFIED IN WRITING 48 HOURS PRIOR TO COMMENCING WORK.
- 2 THE WALKER COUNTY UTILITIES DEPARTMENT AND PUBLIC WORKS DEPARTMENT WILL BE NOTIFIED FOR LINE LOCATES AT (936) 436-4939.
- 3 THE CONTRACTOR SHALL CONTACT TEXAS ONE CALL SYSTEM AT 1-800-245-4545 MIN. 48 HOURS BEFORE DIGGING.
- 4 THE CONTRACTOR SHALL DETERMINE THE EXACT LOCATION OF ALL UNDERGROUND FACILITIES BEFORE COMMENCING WORK AND AGREE TO BE FULLY RESPONSIBLE FOR ALL DAMAGES CAUSED BY HIS FAILURE TO EXACTLY LOCATE AND PRESERVE ALL UNDERGROUND FACILITIES.
- 5 NO MORE TRENCH OPENED AT ONE TIME THAN CAN BE BACKFILLED AND COMPACTED IN 10' LIFTS AT THE END OF EACH DAY (NO TRENCH LEFT OPENED OVERNIGHT).
- 6 ALL EXCESS EXCAVATION TO BE REMOVED FROM THE ROAD RIGHT-OF-WAY AT THE END OF EACH DAY.
- 7 DITCHES TO BE OPENED AT THE END OF EACH DAY TO ASSURE ADEQUATE DRAINAGE.
- 8 ROAD MUST BE KEPT OPEN TO TRAFFIC AND CONTRACTOR MUST PROVIDE ADEQUATE FLAGMEN, SIGNALS, ETC. TO PROVIDE COMPLETE SAFETY TO THE PUBLIC.
- 9 IF IT BECOMES NECESSARY FOR EQUIPMENT TO OPERATE ON A PORTION OF THE PAVEMENT, PRECAUTIONS MUST BE TAKEN TO PREVENT ANY DAMAGE WHATSOEVER TO THE PAVEMENT.
- 10 CONDITION OF ROAD UPON COMPLETION OF JOB SHALL BE AS GOOD OR BETTER THAN PRIOR TO STARTING.
- 11 CONTRACTOR SHALL COMPLY WITH ALL APPLICABLE NATIONAL ELECTRICAL SAFETY CODE (NEC) REQUIREMENTS, CENTERPOINT ENERGY ELECTRIC POLE ATTACHMENT GUIDELINES & PROCEDURES AND TEXAS ONE CALL SYSTEM REQUIREMENTS FOR THE PROPER PLACEMENT OF AERIAL CABLE FACILITIES. 18' MIN. VERTICAL CLEARANCE.
- 12 ALL UTILITIES WILL BE IDENTIFIED BY POTHOLE BEFORE ANY CONSTRUCTION.
- 13 COMCAST WILL MAINTAIN 8 FT. HORIZONTAL & VERTICAL SEPARATION FROM ANY EXISTING UTILITIES.
- 14 THE CONTRACTOR TO CONTACT WALKER COUNTY PRECINCT 4 AT LEAST 48 HOURS PRIOR TO CONSTRUCTION.

Kevin P. Lasky, PE
The Aspen Utility Company, LLC
P.O. Box 23329
Hockley, Texas 77447
• (713) 483-3091



COMCAST PROPOSES TO INSTALL FIBER OPTIC CABLE. COMCAST PROPOSES TO PLACE DIRECTIONAL BORE 710 FT TO INSTALL FIBER OPTIC CABLE TO PROVIDE SERVICE TO 995 TX-150, NEW WAVERLY, TX 77358, INSIDE THE ROW OF THE WALKER COUNTY TX. TOTAL PROJECT FOOTAGE: 710'

JB1771404 - 995 TX-150, NEW WAVERLY, TX 77358




36502 HEMPSTEAD HWY
HOCKLEY, TX 77447


DESIGNED BY:
QUANTA TELECOM SERVICES

DWG. NO. 26 OF 45
SHEET NO. 26 OF 45

LAMBERT N/A
DATE 10/27/2025
KEY MAP NO 75K
SCALE 1" = 40'

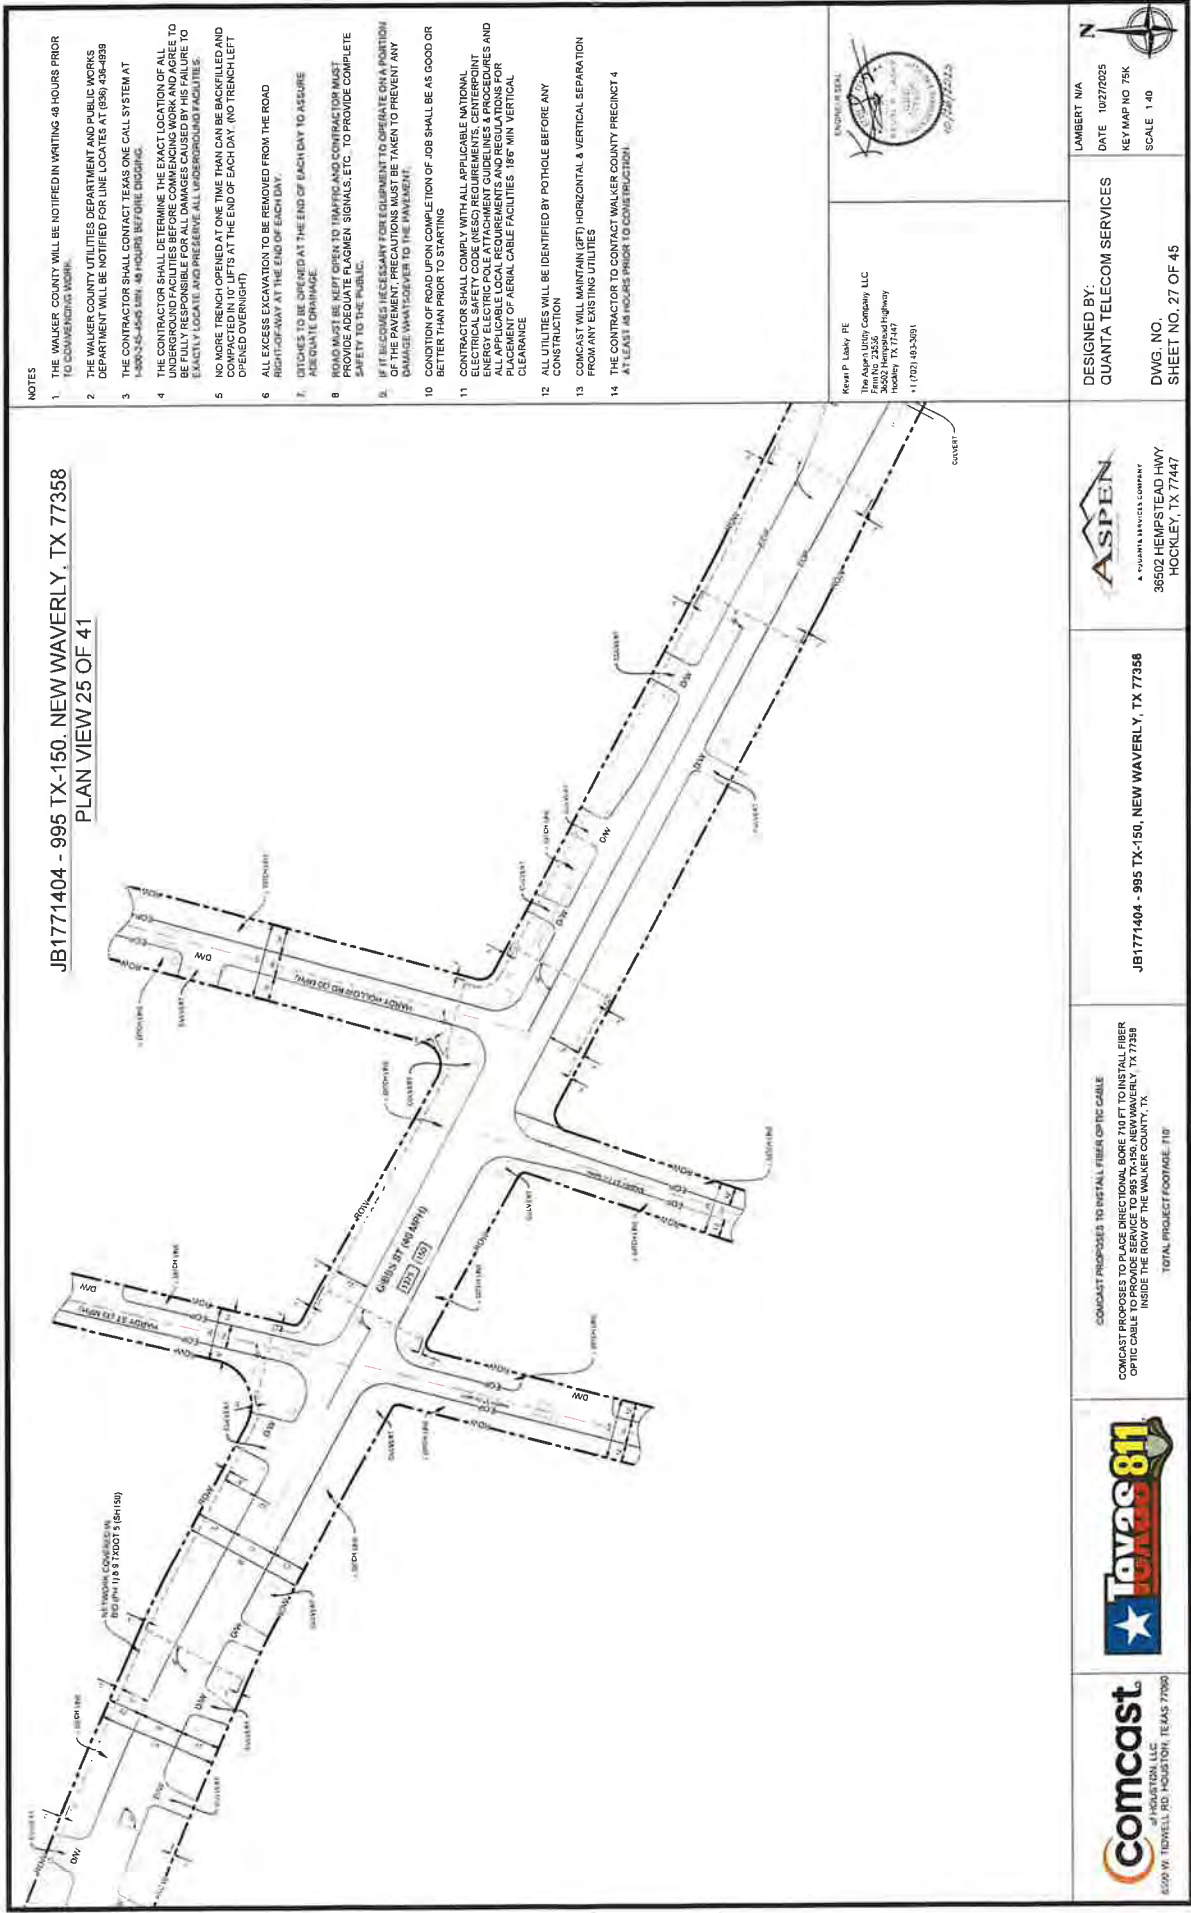

PLAN VIEW 26 OF 41

 

1. THE WALKER COUNTY WILL BE NOTIFIED IN WRITING 48 HOURS PRIOR TO COMMENCING WORK
2. THE WALKER COUNTY UTILITIES DEPARTMENT AND PUBLIC WORKS DEPARTMENT WILL BE NOTIFIED FOR LINE LOCATES AT (880) 445-1039
3. CONTRACTOR SHALL CONTACT TEXAS ONE CALL SYSTEM AT 1-800-252-4545 MIN. 48 HOURS BEFORE DIGGING
4. THE CONTRACTOR SHALL DETERMINE THE EXACT LOCATION OF ALL UNDERGROUND UTILITIES PRIOR TO ANY EXCAVATION. THE CONTRACTOR SHALL BE FULLY RESPONSIBLE FOR ALL DAMAGES CAUSED BY HIS FAILURE TO EXACTLY LOCATE AND PRESERVE ALL UNDERGROUND FACILITIES
5. NO MORE TRENCH-OPENED AT ONE TIME THAN CAN BE BACKFILLED AND COMPACTED IN 10' LIFTS AT THE END OF EACH DAY (NO TRENCH LEFT OPENED OVERNIGHT)
6. ALL EXCESS EXCAVATION TO BE REMOVED FROM THE ROAD RIGHT-OF-WAY AT THE END OF EACH DAY
7. DITCHES TO BE OPENED AT THE END OF EACH DAY TO ASSURE ADEQUATE DRAINAGE
8. ROAD MUST BE KEPT OPEN TO TRAFFIC AND CONTRACTOR MUST PROVIDE ADEQUATE FLAGGERS, SIGNALS, ETC. TO PROVIDE COMPLETE SAFETY TO THE PUBLIC
9. IF IT BECOMES NECESSARY FOR EQUIPMENT TO OPERATE ON A PORTION OF THE PAVEMENT, PRECAUTIONS MUST BE TAKEN TO PREVENT ANY DAMAGE WHATSOEVER TO THE PAVEMENT
10. CONDITION OF ROAD UPON COMPLETION OF JOB SHALL BE AS GOOD OR BETTER THAN PRIOR TO STARTING
11. CONTRACTOR SHALL COMPLY WITH ALL APPLICABLE NATIONAL ELECTRICAL, SAFETY CODE (NEC) REQUIREMENTS, STANDARDS AND ALL APPLICABLE LOCAL REQUIREMENTS AND REGULATIONS FOR THE PLACEMENT OF AERIAL CABLE FACILITIES 18" MIN. VERTICAL CLEARANCE
12. ALL UTILITIES WILL BE IDENTIFIED BY POT-HOLE BEFORE ANY CONSTRUCTION
13. CONCREAT WILL MAINTAIN (2FT) HORIZONTAL & VERTICAL SEPARATION FROM ANY EXISTING UTILITIES
14. THE CONTRACTOR TO CONTACT WALKER COUNTY PRECINCT 4 AT LEAST 48 HOURS PRIOR TO CONSTRUCTION

LAMBERT N/A
DATE 10/27/2025
KEY MAP NO: 75K
SCALE 1:40



COMCAST PROPOSES TO INSTALL FIBER OPTIC CABLE TO PROVIDE SERVICE TO 965 TX-150, NEW WAVE, TX 77358, INSIDE THE ROW OF THE WALLER COUNTY, TX.



© 2006 Comcast. All rights reserved.



NOTES

1. THE WALKER COUNTY WILL BE NOTIFIED IN WRITING 48 HOURS PRIOR TO COMMENCING WORK.
2. THE WALKER COUNTY UTILITIES DEPARTMENT AND PUBLIC WORKS DEPARTMENT WILL BE NOTIFIED FOR LINE LOCATES AT (929) 438-4299
3. THE CONTRACTOR SHALL CONTACT TEXAS ONE CALL SYSTEM AT 1-800-252-5543 MIN. 48 HOURS BEFORE BEGINNING.
4. THE CONTRACTOR SHALL DETERMINE THE EXACT LOCATION OF ALL UTILITIES TO BE FULLY RESPONSIBLE FOR ALL DAMAGES CAUSED BY HIS FAILURE TO EXACTLY LOCATE AND PREPARE ALL UNDERGROUND FACILITIES.
5. NO TRENCH OPERATED AT ONE TIME THEN CAN BE BACKFILLED AND COMPACTED IN 1' LIFTS AT THE END OF EACH DAY (NO TRENCH LEFT OPENED OVERNIGHT).
6. ALL EXCESS EXCAVATION TO BE REMOVED FROM THE ROAD RIGHT-OF-WAY AT THE END OF EACH DAY.
7. DITCHES TO BE OPENED AT THE END OF EACH DAY TO ASSURE ADEQUATE DRAINAGE.
8. ROAD MUST BE KEPT OPEN TO TRAFFIC AND CONTRACTOR MUST PROVIDE ADEQUATE FLAGMEN SIGNALS ETC. TO PROVIDE COMPLETE SAFETY TO THE PUBLIC.
9. IF IT BECOMES NECESSARY FOR EQUIPMENT TO OPERATE ON A PORTION OF THE PAVEMENT, PRECAUTIONS MUST BE TAKEN TO PREVENT ANY DAMAGE WHATSOEVER TO THE PAVEMENT.
10. CONDITION OF ROAD UPON COMPLETION OF JOB SHALL BE AS GOOD OR BETTER THAN PRIOR TO STARTING.
11. CONTRACTOR SHALL COMPLY WITH ALL APPLICABLE NATIONAL ELECTRICAL SAFETY CODE AND INSPECTION REQUIREMENTS, CENTERPOINT ENERGY ELECTRICAL POLE ATTACHMENT GUIDELINES & PROCEDURES AND ALL OTHER APPLICABLE STANDARDS AND REGULATIONS FOR THE PROPER PLACEMENT OF AERIAL CABLE FACILITIES. 18" MIN VERTICAL CLEARANCE.
12. ALL UTILITIES WILL BE IDENTIFIED BY POT HOLE BEFORE ANY CONSTRUCTION.
13. CONCAST WILL MAINTAIN (LEFT) HORIZONTAL & VERTICAL SEPARATION FROM ANY EXISTING UTILITIES.
14. THE CONTRACTOR TO CONTACT WALKER COUNTY PRECINCT 4 AT LEAST 48 HOURS PRIOR TO COMMENCING WORK.



COMCAST PROPOSES TO INSTALL FIBER OPTIC CABLE
COMCAST PROPOSES TO PLACE DIRECTIONAL BORE 710 FT TO INSTALL FIBER
OPTIC CABLE TO PROVIDE SERVICE TO 965 TX-150, NEW WAVERLY, TX 77558
INSIDE THE ROW OF THE WALKER COUNTY, TX.


ASPEN
A. KLEINER & COMPANY, INC.

DESIGNED BY:
QUANTA TELECOM SERVICES

DWG NO
SHEET NO 29 OF 45

LAMBERT NIA
 DATE 10/27/025
 KEY MAP NO. 75K
 SCALE 1 40

JB1771404 - 995 TX-150, NEW WAVERLY, TX 77358
PLAN VIEW 28 OF 41

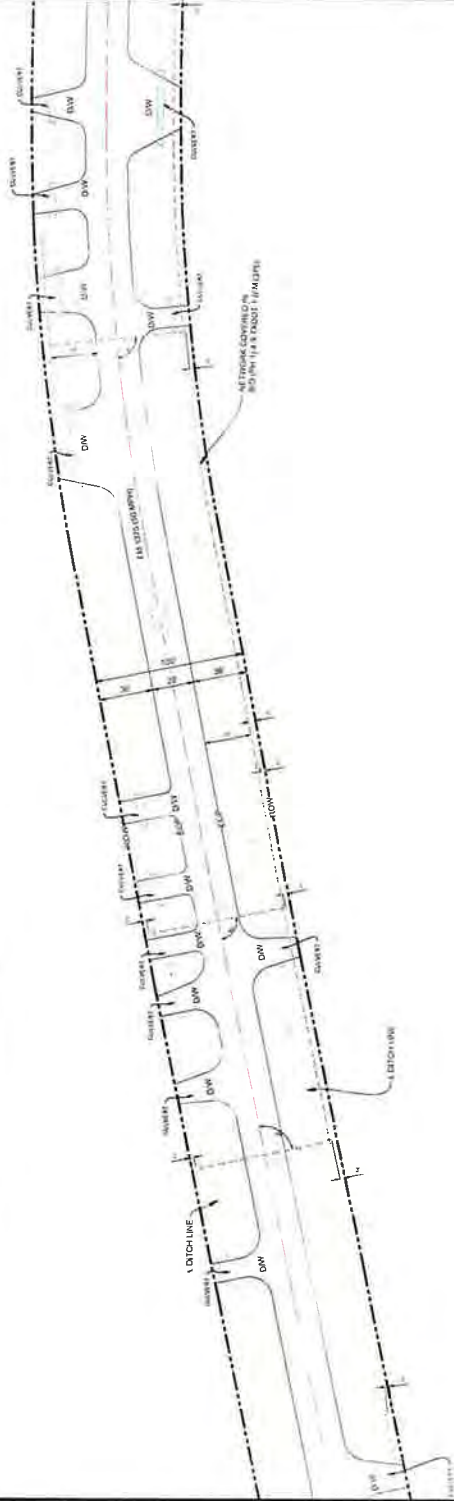

NOTES

- 1 THE WALKER COUNTY WILL BE NOTIFIED IN WRITING 48 HOURS PRIOR TO COMMENCING WORK
- 2 THE WALKER COUNTY UTILITIES DEPARTMENT AND PUBLIC WORKS DEPARTMENT WILL BE NOTIFIED FOR LINE LOCATES AT (936) 456-4939
- 3 THE CONTRACTOR SHALL CONTACT TEXAS ONE CALL SYSTEM AT 1-800-452-4545 MIN. 48 HOURS BEFORE DIGGING
- 4 THE CONTRACTOR SHALL DETERMINE THE EXACT LOCATION OF ALL UNDERGROUND FACILITIES BEFORE COMMENCING WORK AND AGREE TO BE FULLY RESPONSIBLE FOR ALL DAMAGES CAUSED BY HIS FAILURE TO EXACTLY LOCATE AND PRESERVE ALL UNDERGROUND FACILITIES
- 5 NO MORE TRENCH OPENED AT ONE TIME THAN CAN BE BACKFILLED AND COMPACTED IN 10' LIFTS AT THE END OF EACH DAY (NO TRENCH LEFT OPENED OVERNIGHT)
- 6 ALL EXCESS EXCAVATION TO BE REMOVED FROM THE ROAD RIGHT-OF-WAY AT THE END OF EACH DAY
- 7 DITCHES TO BE OPENED AT THE END OF EACH DAY TO ASSURE ADEQUATE DRAINAGE
- 8 ROAD MUST BE KEPT OPEN TO TRAFFIC AND CONTRACTOR MUST PROVIDE ADEQUATE FLAGMEN, SIGNALS, ETC. TO PROVIDE COMPLETE SAFETY TO THE PUBLIC
- 9 IF IT BECOMES NECESSARY FOR EQUIPMENT TO OPERATE ON A PORTION OF THE PAVEMENT PRECAUTIONS MUST BE TAKEN TO PREVENT ANY DAMAGE WHATSOEVER TO THE PAVEMENT
- 10 CONDITION OF ROAD UPON COMPLETION OF JOB SHALL BE AS GOOD OR BETTER THAN PRIOR TO STARTING
- 11 CONTRACTOR SHALL COMPLY WITH ALL APPLICABLE NATIONAL ELECTRICAL SAFETY CODE (NEC) REQUIREMENTS, CENTERPOINT ENERGY ELECTRIC POLE ATTACHMENT GUIDELINES & PROCEDURES AND ALL APPLICABLE LOCAL ORDINANCES AND REGULATIONS FOR PLACEMENT OF AERIAL CABLE FACILITIES. 18" MIN. VERTICAL CLEARANCE
- 12 ALL UTILITIES WILL BE IDENTIFIED BY HOLE BEFORE ANY CONSTRUCTION
- 13 CONTRACTOR WILL MAINTAIN 4FT. HORIZONTAL & VERTICAL SEPARATION FROM ANY EXISTING UTILITIES
- 14 THE CONTRACTOR TO CONTACT WALKER COUNTY PRECINCT 4 AT LEAST 48 HOURS PRIOR TO CONSTRUCTION

Kevin P. Lundy, PE
The Aspen Utility Company, LLC
P.O. Box 23256
Houston, Texas 77202-2566
Hockley, TX 77447
• (713) 493-5091



COMCAST PROPOSES TO INSTALL FIBER OPTIC CABLE
COMCAST PROPOSES TO PLACE DIRECTIONAL BORE 119 FT TO INSTALL FIBER OPTIC CABLE TO PROVIDE SERVICE TO 995 TX-150, NEW WAVERLY, TX 77358 INSIDE THE ROW OF THE WALKER COUNTY TX
TOTAL PROJECT FOOTAGE 710'

JB1771404 - 995 TX-150, NEW WAVERLY, TX 77358




DESIGNED BY:
QUANTA TELECOM SERVICES

DWG. NO.
SHEET NO. 30 OF 45



JB1771404 - 995 TX-150, NEW WAVERLY, TX 77358

PLAN VIEW 29 OF 41

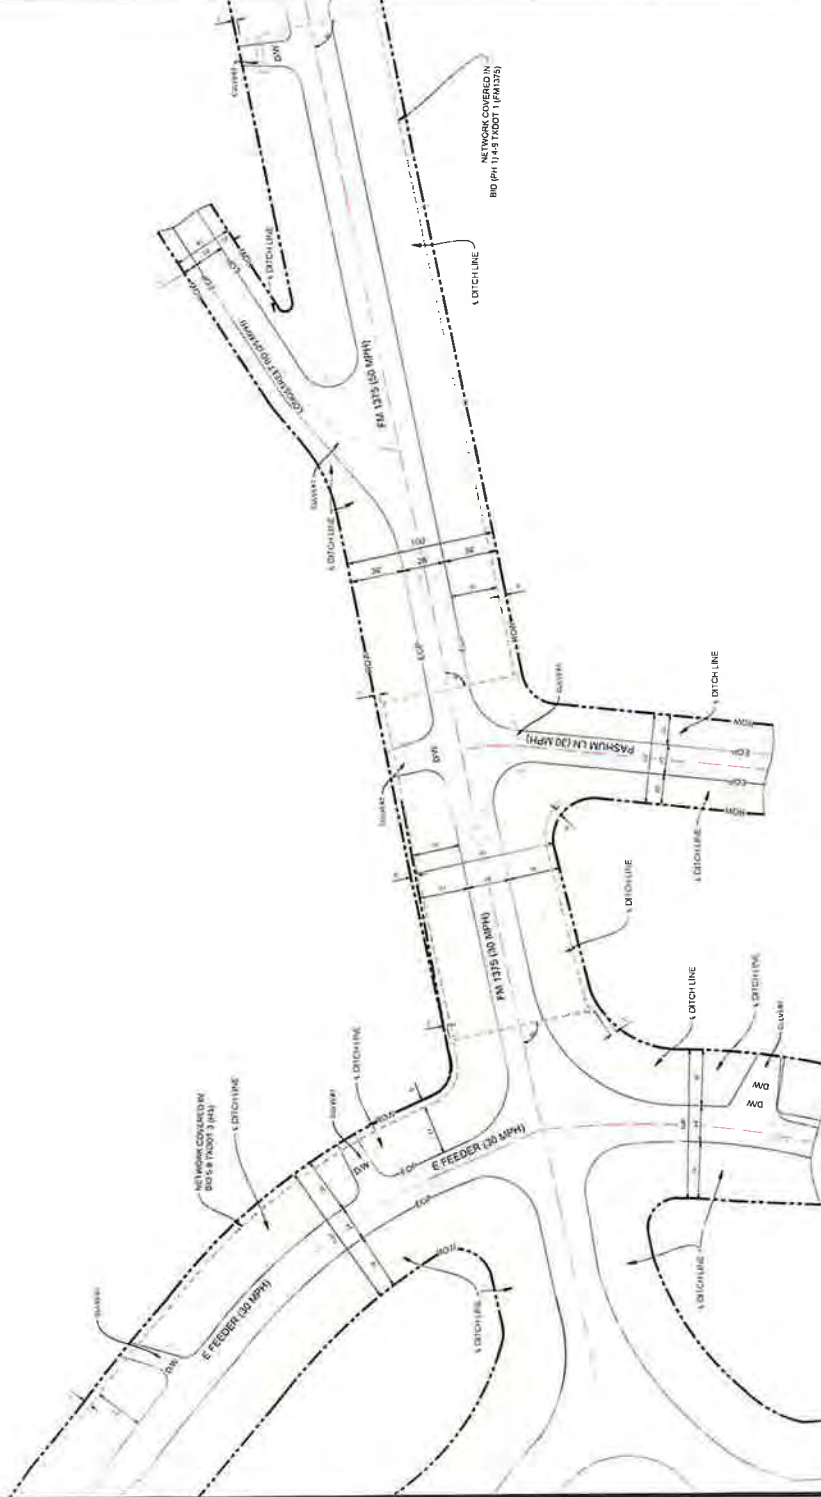

NOTES

1. THE WALKER COUNTY WILL BE NOTIFIED IN WRITING 48 HOURS PRIOR TO COMMENCING WORK.
2. THE WALKER COUNTY UTILITIES DEPARTMENT AND PUBLIC WORKS DEPARTMENT WILL BE NOTIFIED FOR LINE LOCATES AT (830) 459-4959.
3. THE CONTRACTOR SHALL CONTACT TEXAS ONE CALL SYSTEM AT 1-800-245-4545 MIN. 48 HOURS BEFORE DIGGING.
4. THE CONTRACTOR SHALL DETERMINE THE EXACT LOCATION OF ALL UNDERGROUND FACILITIES BEFORE COMMENCING WORK AND AGREE TO BE FULLY RESPONSIBLE FOR ANY DAMAGE TO EXISTING UTILITIES TO EXACTLY LOCATE AND PRESERVE ALL UNDERGROUND FACILITIES.
5. NO MORE TRENCH OPENED AT ONE TIME THAN CAN BE BACKFILLED AND COMPLETED WITHIN 24 HOURS OF THE END OF EACH DAY (NO TRENCH LEFT OPENED OVERNIGHT).
6. ALL EXCESS EXCAVATION TO BE REMOVED FROM THE ROAD RIGHT-OF-WAY AT THE END OF EACH DAY.
7. DITCHES TO BE OPENED AT THE END OF EACH DAY TO ASSURE ADEQUATE DRAINAGE.
8. ROAD MUST BE KEPT OPEN TO TRAFFIC AND CONTRACTOR MUST PROVIDE ADEQUATE FLAGMEN, SIGNALS, ETC. TO PROVIDE COMPLETE SAFETY TO THE PUBLIC.
9. IF IT BECOMES NECESSARY FOR EQUIPMENT TO OPERATE ON A PORTION OF THE PAVEMENT, THE UTILITIES MUST BE TAKEN TO PREVENT ANY DAMAGE WHEN DELIVER TO THE TOWN.
10. CONDITION OF ROAD UPON COMPLETION OF JOB SHALL BE AS GOOD OR BETTER THAN PRIOR TO STARTING.
11. CONTRACTOR SHALL COMPLY WITH ALL APPLICABLE NATIONAL ELECTRICAL SAFETY CODE (NEC) REQUIREMENTS, CENTERPOINT REQUIREMENTS, AND ALL APPLICABLE LOCAL REQUIREMENTS AND REGULATIONS FOR PLACEMENT OF AERIAL CABLE FACILITIES. 18" MIN. VERTICAL CLEARANCE.
12. ALL UTILITIES WILL BE IDENTIFIED BY POTHOLE BEFORE ANY CONSTRUCTION.
13. COMCAST WILL MAINTAIN 8FT HORIZONTAL & VERTICAL SEPARATION FROM ANY EXISTING UTILITIES.
14. THE CONTRACTOR TO CONTACT WALKER COUNTY PRECINCT 4 AT LEAST 48 HOURS PRIOR TO CONSTRUCTION.

Kevin P. Lundy, PE
The Aspen Utility Company, LLC
2500 Highway 235
Hockley, TX 77447
+1 (281) 452-3601



DESIGNED BY:
QUANTA TELECOM SERVICES
DATE: 10/27/2023
KEY MAP NO. 75K
SCALE: 1" = 40'
DWG. NO.
SHEET NO. 31 OF 45


ASPEN
A DIVISION OF SPACELAND COMPANY
35500 HEMPSTEAD HWY.
HOCKLEY, TX 77447

JB1771404 - 995 TX-150, NEW WAVERLY, TX 77358

COMCAST PROPOSES TO INSTALL FIBER OPTIC CABLE
COMCAST PROPOSES TO PLACE DIRECTIONAL BORE 7.0 FT TO INSTALL FIBER
OPTIC CABLE TO PROVIDE SERVICE TO 995 TX-150, NEW WAVERLY, TX 77358,
INSIDE THE ROW OF THE WALKER COUNTY, TX.
TOTAL PROJECT FOOTAGE: 710'



JB1771404 - 995 TX-150, NEW WAVERLY, TX 77358
PLAN VIEW 30 OF 41

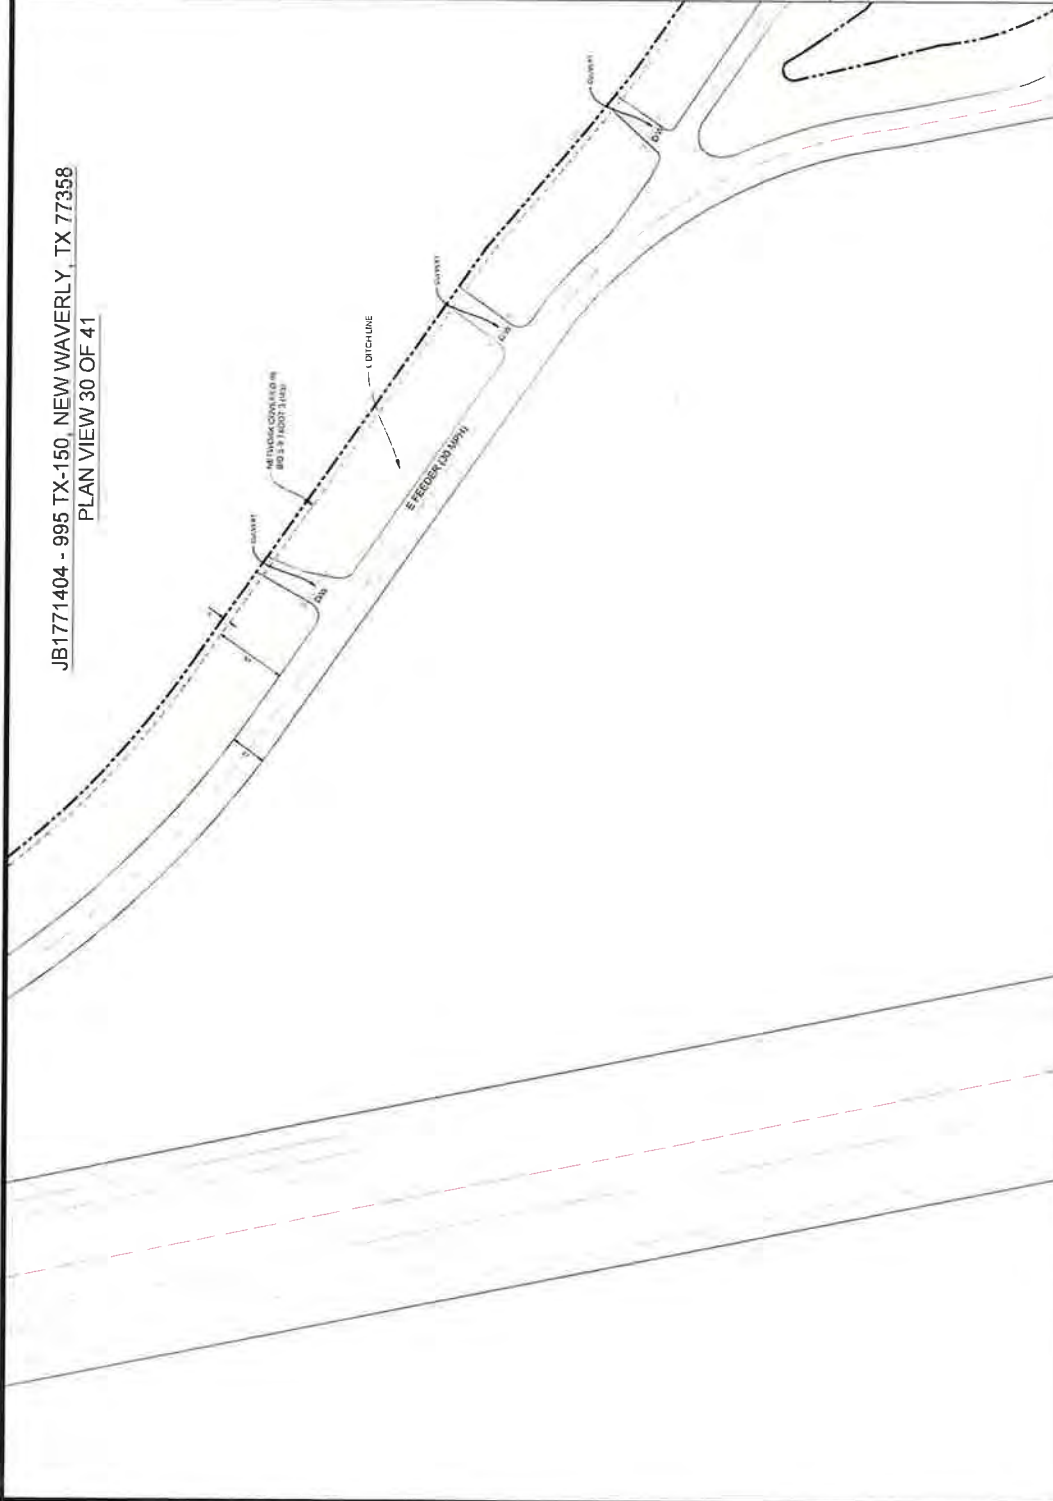

NOTES

1. THE WALKER COUNTY WILL BE NOTIFIED IN WRITING 48 HOURS PRIOR TO COMMENCING WORK
2. THE WALKER COUNTY UTILITIES DEPARTMENT AND PUBLIC WORKS DEPARTMENT WILL BE NOTIFIED FOR LINE LOCATES AT (936) 436-0399
3. THE CONTRACTOR SHALL CONTACT TEXAS ONE CALL SYSTEM AT 1-800-245-4545 MIN. 48 HOURS BEFORE DIGGING
4. THE CONTRACTOR SHALL DETERMINE THE EXACT LOCATION OF ALL UNDERGROUND FACILITIES BEFORE COMMENCING CONSTRUCTION. THE CONTRACTOR SHALL BE FULLY RESPONSIBLE FOR ALL DAMAGES CAUSED BY HIS FAILURE TO EXACTLY LOCATE AND PRESERVE ALL UNDERGROUND FACILITIES
5. NO MORE TRENCH OPENED AT ONE TIME THAN CAN BE BACKFILLED AND COMPACTED IN 10' LIFTS AT THE END OF EACH DAY (NO TRENCH LEFT OPENED OVERNIGHT)
6. ALL EXCESS EXCAVATION TO BE REMOVED FROM THE ROAD RIGHT-OF-WAY AT THE END OF EACH DAY
7. DITCHES TO BE OPENED AT THE END OF EACH DAY TO ASSURE ADEQUATE DRAINAGE
8. ROAD MUST BE KEPT OPEN TO TRAFFIC AND CONTRACTOR MUST PROVIDE ADEQUATE FLAGMEN, SIGNALS, ETC. TO PROVIDE COMPLETE SAFETY TO THE PUBLIC
9. IF IT BECOMES NECESSARY FOR EQUIPMENT TO OPERATE ON A PORTION OF THE PAVEMENT, PRECAUTIONS MUST BE TAKEN TO PREVENT ANY DAMAGE WHATSOEVER TO THE PAVEMENT
10. CONDITION OF ROAD UPON COMPLETION OF JOB SHALL BE AS GOOD OR BETTER THAN PRIOR TO STARTING
11. CONTRACTOR SHALL COMPLY WITH ALL APPLICABLE NATIONAL ELECTRICAL SAFETY CODE (NEC) REQUIREMENTS, CENTERPOINT ENERGY ELECTRIC POLE ATTACHMENT GUIDELINES & PROCEDURES AND ALL APPLICABLE STATE AND FEDERAL REGULATIONS FOR PLACEMENT OF AERIAL CABLE FACILITIES 10' MIN VERTICAL CLEARANCE
12. ALL UTILITIES WILL BE IDENTIFIED BY POT-HOLE BEFORE ANY CONSTRUCTION
13. COMCAST WILL MAINTAIN (2FT) HORIZONTAL & VERTICAL SEPARATION FROM ANY EXISTING UTILITIES
14. THE CONTRACTOR TO CONTACT WALKER COUNTY PRECINCT 4 AT LEAST 48 HOURS PRIOR TO CONSTRUCTION

Kevin P. Lasky PE
The Aspen Utility Company, LLC
14141 Hwy 25236
Hockley, TX 77447
(281) 493-3091



COMCAST PROPOSES TO INSTALL FIBER OPTIC CABLE
COMCAST PROPOSES TO PLACE DIRECTIONAL BORE 710 FT TO INSTALL FIBER OPTIC CABLE TO PROVIDE SERVICE TO 995 TX-150 NEW WAVERLY, TX 77358, INSIDE THE ROW OF THE WALKER COUNTY TX
TOTAL PROJECT FOOTAGE: 710'

JB1771404 - 995 TX-150, NEW WAVERLY, TX 77358



DESIGNED BY:
QUANTA TELECOM SERVICES

DWG. NO.
SHEET NO. 32 OF 45

LAMBERT N/A
DATE 10/27/2025
KEY MAP NO 75K
SCALE 1"=40'



JB1771404 - 995 TX-1
PLAN

NETWORK COVERED IN
80'S 9'S AND 2'S (45)

L. G. CHINA

E FEEDER (30 MPH)

I-45 (75 MPH)

N FWY SERVICE RD (30 MPH)

0 50 100

1. THE WALKER COUNTY WILL BE NOTIFIED IN WRITING 48 HOURS PRIOR TO COMMENCING WORK.

2. THE WALKER COUNTY UTILITIES DEPARTMENT AND PUBLIC WORKS DEPARTMENT WILL BE NOTIFIED FOR LINE LOCATES AT (833) 456-0938.
3. THE CONTRACTOR SHALL CONTACT TEXAS ONE CALL SYSTEM AT 1-800-535-4545 MIN. 48 HOURS BEFORE DIGGING.
4. THE CONTRACTOR SHALL DETERMINE THE EXACT LOCATION OF ALL UNDERGROUND FACILITIES BEFORE COMMENCING WORK AND AGREE TO TAKE ALL NECESSARY PRECAUTIONS TO AVOID DAMAGE TO FACILITIES. LOCATE AND PRESERVE ALL UNDERGROUND FACILITIES.
5. NO MORE TRENCH OPENED AT ONE TIME THAN CAN BE BACKFILLED AND REINTEGRATED WITHIN 24 HOURS OF EACH DAY. (NO TRENCH LEFT OPENED OVERNIGHT).
6. ALL EXCESS EXCAVATION TO BE REMOVED FROM THE ROAD RIGHT-OF-WAY AT THE END OF EACH DAY.
7. DITCHES TO BE OPENED AT THE END OF EACH DAY TO ASSURE ADEQUATE DRAINAGE.
8. ROAD MUST BE KEPT OPEN TO TRAFFIC AND CONTRACTOR MUST PROVIDE ADEQUATE FLAGMEN SIGNAGE, ETC., TO PROVIDE COMPLETE SAFETY TO THE PUBLIC.
9. IF IT BECOMES NECESSARY FOR EQUIPMENT TO OPERATE ON A PORTION OF THE PAVEMENT, PRECAUTIONS MUST BE TAKEN TO PREVENT ANY DAMAGE WHATSOEVER TO THE PAVEMENT.
10. CONDITION OF ROAD UPON COMPLETION OF JOB SHALL BE AS GOOD OR BETTER THAN PRIOR TO STARTING.
11. CONTRACTOR SHALL COMPLY WITH ALL APPLICABLE NATIONAL ELECTRICAL SAFETY CODES AND REQUIREMENTS, CORRESPONDING ENERGY ELECTRICAL ATTACHMENT GUIDELINES & PROCEDURES AND ALL APPLICABLE LOCAL REQUIREMENTS AND REGULATIONS FOR PLACEMENT OF ASPHALT CHUTE FACILITIES, 18" MIN VERTICAL CLEARANCE.
12. ALL UTILITIES WILL BE IDENTIFIED BY POT HOLE BEFORE ANY CONSTRUCTION.
13. CONCAST WILL MAINTAIN GFI HORIZONTAL & VERTICAL SEPARATION FROM ANY EXISTING UTILITIES.
14. THE CONTRACTOR TO CONTACT WALKER COUNTY PRECINCT 4 AT LEAST 1-48 HOURS PRIOR TO CONSTRUCTION.

Karen P. Lasky, PE
The Aspen Utility Company LLC
Furn No 22536
36502 Hempstead Highway
Huddley TX 77447
+1 702 493 3691



ASPEN
A COMMERCIAL SERVICES COMPANY
36502 HEMPSTEAD HWY.
HOCKLEY, TX 77447

JB1771404 - 995 TX-150, NEW WAVERLY, TX 777358

COMCAST PROPOSES TO INSTALL FIBER OPTIC CABLE
COMCAST PROPOSES TO PLACE DIRECTIONAL BORE 710 FT TO INSTALL FIBER
OPTIC CABLE TO PROVIDE SERVICE TO 995 TX-150, NEW WEAVERLY TX 77359,
INSIDE THE ROW OF THE WALKER COUNTY, TX.



DESIGNED BY:
QUANTA TELECOM SERVICES

DWG. NO. 33 OF 45

LAMBERT: N/A

at a time

© 2004 Blackwell Publishing Ltd
Journal of Internal Medicine 255: 103–110

KEY WORDS: NO

SCALE: 1 40



JB1771404 - 995 TX-150, NEW WAVERLY, TX 77358
PLAN VIEW 32 OF 41



NOTES

1. THE WALKER COUNTY WILL BE NOTIFIED IN WRITING 48 HOURS PRIOR TO COMMENCING WORK.
2. THE WALKER COUNTY UTILITIES DEPARTMENT AND PUBLIC WORKS DEPARTMENT WILL BE NOTIFIED FOR LINE LOCATES AT (936) 436-4299.
3. THE CONTRACTOR SHALL CONTACT TEXAS ONE CALL SYSTEM AT 1-800-245-4545 MIN. 48 HOURS BEFORE DIGGING.
4. THE CONTRACTOR SHALL DETERMINE THE EXACT LOCATION OF ALL UNDERGROUND FACILITIES BEFORE COMMENCING WORK AND AGREE TO BE FULLY RESPONSIBLE FOR ALL DAMAGES CAUSED BY HIS FAILURE TO EXACTLY LOCATE AND PRESERVE ALL UNDERGROUND FACILITIES.
5. NO MORE TRENCH OPENED AT ONE TIME THAN CAN BE BACKFILLED AND COMPACTED IN 10' LIFTS AT THE END OF EACH DAY. (NO TRENCH LEFT OPENED OVERNIGHT).
6. ALL EXCESS EXCAVATION TO BE REMOVED FROM THE ROAD RIGHT-OF-WAY AT THE END OF EACH DAY.
7. DITCHES TO BE OPENED AT THE END OF EACH DAY TO ASSURE ADEQUATE DRAINAGE.
8. ROAD MUST BE KEPT OPEN TO TRAFFIC AND CONTRACTOR MUST PROVIDE ADEQUATE FLAGMEN, SIGNALS, ETC. TO PROVIDE COMPLETE SAFETY TO THE PUBLIC.
9. IF IT BECOMES NECESSARY FOR EQUIPMENT TO OPERATE ON A PORTION OF THE PAVEMENT, PRECAUTIONS MUST BE TAKEN TO PREVENT ANY DAMAGE WHATSOEVER TO THE PAVEMENT.
10. CONDITION OF ROAD UPON COMPLETION OF JOB SHALL BE AS GOOD OR BETTER THAN PRIOR TO STARTING.
11. CONTRACTOR SHALL COMPLY WITH ALL APPLICABLE NATIONAL ELECTRICAL SAFETY CODE (NEC) REQUIREMENTS, CENTERPOINT ENERGY ELECTRIC POLE ATTACHMENT GUIDELINES & PROCEDURES AND ALL OTHER REQUIREMENTS AND PROCEDURES FOR THE PROPER PLACEMENT OF AERIAL CABLE FACILITIES, NOT MIN. VERTICAL CLEARANCE.
12. ALL UTILITIES WILL BE IDENTIFIED BY POTHOLE BEFORE ANY CONSTRUCTION.
13. COMCAST WILL MAINTAIN (8FT) HORIZONTAL & VERTICAL SEPARATION FROM ANY EXISTING UTILITIES.
14. THE CONTRACTOR TO CONTACT WALKER COUNTY PRECINCT 4 AT LEAST 48 HOURS PRIOR TO CONSTRUCTION.

Kevin P. Lash, PE
The Aspen Utility Company, LLC
P.O. Box 23038
Houston, TX 77207
+1 (281) 833-2000



COMCAST PROPOSES TO INSTALL FIBER OPTIC CABLE
COMCAST PROPOSES TO PLACE DIRECTIONAL BORE 710 FT TO INSTALL FIBER
OPTIC CABLE TO PROVIDE SERVICE TO 995 TX-150, NEW WAVERLY, TX 77358,
INSIDE THE ROW OF THE WALKER COUNTY, TX.
TOTAL PROJECT FOOTAGE: 710

JB1771404 - 995 TX-150, NEW WAVERLY, TX 77358

 



36502 HEMPSTEAD HWY.
HOCKLEY, TX 77447

DESIGNED BY:
QUANTA TELECOM SERVICES

DWG. NO.
SHEET NO. 34 OF 45

LAMBERT N/A
DATE: 10/27/2023
KEY MAP NO. 75K
SCALE: 1" = 40'



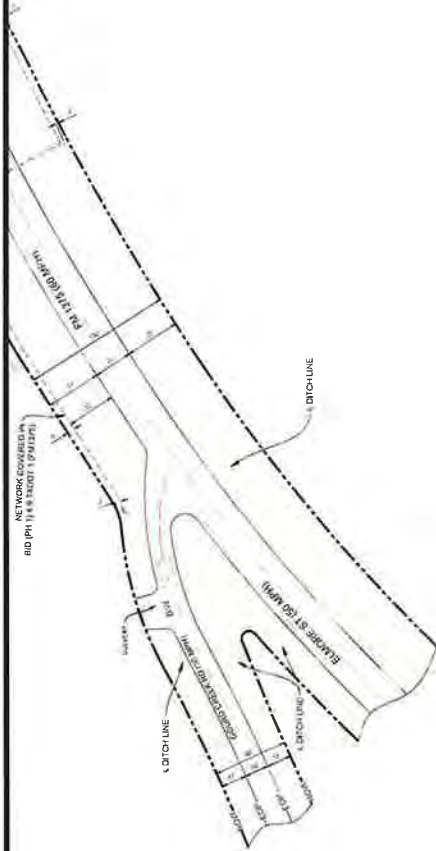


JB1771404 - 995 TX-150, NEW WAVERLY, TX 77358 PLAN VIEW 33 OF 41

NOTES

1. THE WALKER COUNTY WILL BE NOTIFIED IN WRITING 48 HOURS PRIOR TO COMMENSING WORK.
2. THE WALKER COUNTY UTILITIES DEPARTMENT AND PUBLIC WORKS DEPARTMENT WILL BE NOTIFIED FOR LINE LOCATES AT (936) 438-4339
3. THE CONTRACTOR SHALL CONTACT TEXAS ONE CALL SYSTEM AT 1-800-245-4545 MIN. 48 HOURS BEFORE DIGGING.
4. THE CONTRACTOR SHALL DETERMINE THE EXACT LOCATION OF ALL UNDERGROUND FACILITIES BEFORE COMMENCING WORK AND AGREE TO BE FULLY RESPONSIBLE FOR ALL DAMAGES CAUSED BY HIS FAILURE TO EXACTLY LOCATE AND PRESERVE ALL UNDERGROUND FACILITIES.
5. NO MORE TRENCH OPENED AT ONE TIME THAN CAN BE BACKFILLED AND COMPLETED IN 10 LIFTS AT THE END OF EACH DAY. (NO TRENCH LEFT OPENED OVERNIGHT).
6. ALL EXCESS EXCAVATION TO BE REMOVED FROM THE ROAD RIGHT-OF-WAY AT THE END OF EACH DAY.
7. DITCHES TO BE GRADED AT THE END OF EACH DAY TO ASSURE ADEQUATE DRAINAGE.
8. ROAD MUST BE KEPT OPEN TO TRAFFIC AND CONTRACTOR MUST PROVIDE ADEQUATE FLAGMEN SIGNALS ETC. TO PROVIDE COMPLETE SAFETY TO THE PUBLIC.
9. IF IT BECOMES NECESSARY FOR EQUIPMENT TO OPERATE ON A PORTION OF THE PAVEMENT, PRECAUTIONS MUST BE TAKEN TO PREVENT ANY DAMAGE WHATSOEVER TO THE PAVEMENT.
10. CONDITION OF ROAD UPON COMPLETION OF JOB SHALL BE AS GOOD OR BETTER THAN PRIOR TO STARTING.
11. CONTRACTOR SHALL COMPLY WITH ALL APPLICABLE NATIONAL ELECTRICAL SAFETY CODE (NEC) REQUIREMENTS, CENTERPOINT ENERGY UTILITY COMPANY'S ALL ELECTRICITY CODES & REQUIREMENTS AND ALL APPLICABLE OCCUPATIONAL SAFETY AND HEALTH REQUIREMENTS FOR PLACEMENT OF AERIAL CABLE FACILITIES. 18" MIN VERTICAL CLEARANCE.
12. ALL UTILITIES WILL BE IDENTIFIED BY POTHOLE BEFORE ANY CONSTRUCTION.
13. COMCAST WILL MAINTAIN (2FT) HORIZONTAL & VERTICAL SEPARATION FROM ANY EXISTING UTILITIES.
14. THE CONTRACTOR TO CONTACT WALKER COUNTY PRECINCT 4 AT LEAST 24 HOURS PRIOR TO CONSTRUCTION.

 Kevin P. Luby, PE
The Aspen Utility Company LLC
Firm No. 28538
Hockley, TX 77447
+1 (936) 483-5701



COMCAST PROPOSES TO INSTALL FIBER OPTIC CABLE
COMCAST PROPOSES TO PLACE DIRECTIONAL BORE 710 FT TO INSTALL FIBER OPTIC CABLE TO PROVIDE SERVICE TO 995 TX-150, NEW WAVERLY, TX 77358
INSIDE THE ROW OF THE WALKER COUNTY TX.
TOTAL PROJECT FOOTAGE 710'

JB1771404 - 995 TX-150, NEW WAVERLY, TX 77358



DESIGNED BY:
QUANTA TELECOM SERVICES
DWG. NO.
SHEET NO. 35 OF 45

UNBERT: WA
DATE: 10/27/2023
KEY MAP NO. 754
SCALE: 1" = 40'



JB1771404 - 995 TX-150, NEW WAVERLY, TX 77358
PLAN VIEW 34 OF 41

- 1 THE WALKER COUNTY WILL BE NOTIFIED IN WRITING 48 HOURS PRIOR TO COMMENCING WORK.
- 2 THE WALKER COUNTY UTILITIES DEPARTMENT AND PUBLIC WORKS DEPARTMENT WILL BE NOTIFIED FOR JOB LOCATES AT (206) 426-0099.
- 3 THE CONTRACTOR SHALL CONTACT TEXAS ONE CALL SYSTEM AT 1-800-254-4545 MIN. 48 HOURS BEFORE DIGGING.
- 4 THE CONTRACTOR SHALL DETERMINE THE EXACT LOCATION OF ALL UTILITIES AND MARK THEM WITH FLAGGING. THE CONTRACTOR SHALL BE FULLY RESPONSIBLE FOR ALL DAMAGES CAUSED BY HIS FAILURE TO EXACTLY LOCATE AND PRESERVE ALL UNDERGROUND FACILITIES.
- 5 NO WORK/FRENCH OPENED AT ONE TIME THAN CAN BE BACKFILLED AND COMPACTED IN 10' LIFTS AT THE END OF EACH-DAY (NO FRENCH LEFT OPENED OVERNIGHT)
- 6 ALL EXCESS EXCAVATION TO BE REMOVED FROM THE ROAD RIGHT-OF-WAY AT THE END OF EACH DAY
- 7 DITCHES TO BE OPENED AT THE END OF EACH-DAY TO ASSURE ADEQUATE DRAINAGE
- 8 ROAD MUST BE KEPT OPEN TO TRAFFIC AND CONTRACTOR MUST PROVIDE ADEQUATE FLAGMEN, SIGNALS, ETC. TO PROVIDE COMPLETE SAFETY TO THE PUBLIC
- 9 IF IT BECOMES NECESSARY FOR EQUIPMENT TO OPERATE ON A PORTION OF THE PAVEMENT PRECAUTIONS MUST BE TAKEN TO PREVENT ANY DAMAGE WHATSOEVER TO THE PAVEMENT
- 10 CONDITION OF ROAD UPON COMPLETION OF JOB SHALL BE AS GOOD OR BETTER THAN PRIOR TO STARTING
- 11 CONTRACTOR SHALL COMPLY WITH ALL APPLICABLE NATIONAL ELECTRICAL SAFETY CODE (NEC) REQUIREMENTS, CENTERPOINT ALL APPLICABLE LOCAL REQUIREMENTS, GUIDELINES & PROCEDURES AND ALL APPLICABLE LOCAL REQUIREMENTS FOR THE PROPER WORK PLACEMENT OF AERIAL CABLE FACILITIES 18" MIN VERTICAL CLEARANCE
- 12 ALL UTILITIES WILL BE IDENTIFIED BY POTHOLE BEFORE ANY CONSTRUCTION
- 13 CONCAST WILL MAINTAIN (2FT) HORIZONTAL & VERTICAL SEPARATION FROM ANY EXISTING UTILITIES
- 14 THE CONTRACTOR IS TO CONTACT WALKER COUNTY PRECINCT 4 AT LEAST 48 HOURS PRIOR TO CONSTRUCTION

ENGINEER SEAL

10/28/2025



COMCAST PROPOSES TO PLACE DIRECTIONAL BORE 710 FT TO INSTALL OPTIC CABLE TO PROVIDE SERVICE TO 995 TX-150, NEW WAVERLY INSIDE THE ROW OF THE WALKER COUNTY, TX

TOTAL PROJECT FOOTAGE: 710'

JB1771404 - 995 TX-150, NEW WAVERLY, TX 77358




6502 HEMPSTEAD HWY
HOCKLEY TX 77447

DWG. NO.
SHEET NO. 36 OF 45

LAMBERT N/A
DATE 10/27/2025
KEY MAP NO 75K
SCALE 1:40


JB1771404 - 995 TX-150, NEW WAVERLY, TX 77358
 PLAN VIEW 35 OF 41

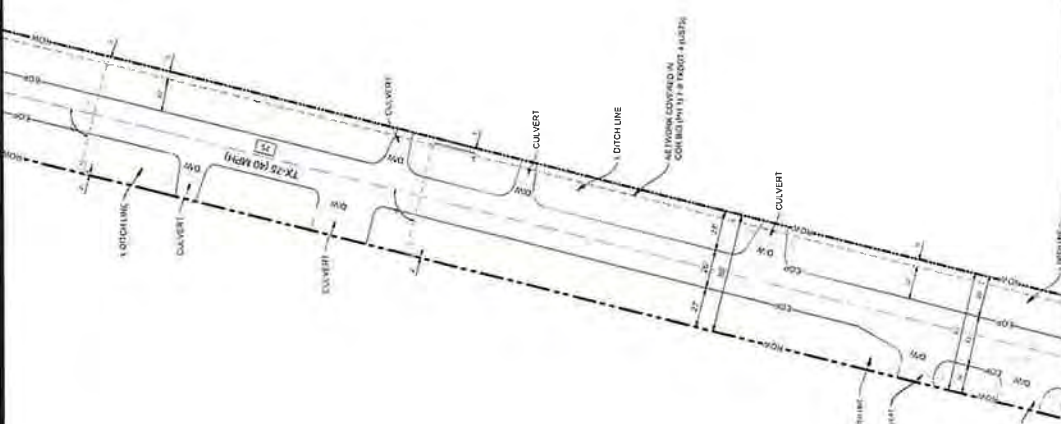

NOTES

1. THE WALKER COUNTY WILL BE NOTIFIED IN WRITING 48 HOURS PRIOR TO COMMENCING WORK.
2. THE WALKER COUNTY UTILITIES DEPARTMENT AND PUBLIC WORKS DEPARTMENT WILL BE NOTIFIED FOR LINE LOCATES AT (936) 438-4859.
3. THE CONTRACTOR SHALL CONTACT TEXAS ONE CALL SYSTEM AT 1-800-255-4545 MIN. 48 HOURS BEFORE DIGGING.
4. THE CONTRACTOR SHALL DETERMINE THE EXACT LOCATION OF ALL UNDERGROUND FACILITIES BEFORE COMMENCING WORK AND AGREE TO BE FULLY RESPONSIBLE FOR ALL DAMAGES CAUSED BY THIS FAILURE TO EXACTLY LOCATE AND PRESERVE ALL UNDERGROUND FACILITIES.
5. NO MORE TRENCH OPENED AT ONE TIME THAN CAN BE BACKFILLED AND COMPLETED WITHIN 24 HOURS AT THE END OF EACH DAY (NO TRENCH LEFT OPENED OVERNIGHT).
6. ALL EXCESS EXCAVATION TO BE REMOVED FROM THE ROAD RIGHT-OF-WAY AT THE END OF EACH DAY.
7. DITCHES TO BE OPENED AT THE END OF EACH DAY TO ASSURE ADEQUATE DRAINAGE.
8. ROAD MUST BE KEPT OPEN TO TRAFFIC AND CONTRACTOR MUST PROVIDE ADEQUATE FLAGMEN, SIGNALS, ETC. TO PROVIDE COMPLETE SAFETY TO THE PUBLIC.
9. IF IT BECOMES NECESSARY FOR EQUIPMENT TO OPERATE ON A PORTION OF THE PAVEMENT, PRECAUTIONS MUST BE TAKEN TO PREVENT ANY DAMAGE WHATSOEVER TO THE PAVEMENT.
10. CONDITION OF ROAD UPON COMPLETION OF JOB SHALL BE AS GOOD OR BETTER THAN PRIOR TO STARTING.
11. CONTRACTOR SHALL COMPLY WITH ALL APPLICABLE NATIONAL ELECTRICAL SAFETY CODE (NEC) REQUIREMENTS, CENTERPOINT ENERGY COMPANY POLICIES AND REGULATIONS, AND ALL APPLICABLE LOCAL REQUIREMENTS AND REGULATIONS FOR PLACEMENT OF AERIAL CABLE FACILITIES. 18" MIN. VERTICAL CLEARANCE.
12. ALL UTILITIES WILL BE IDENTIFIED BY POI/HOLE BEFORE ANY CONSTRUCTION.
13. CONCAST WILL MAINTAIN BOTH HORIZONTAL & VERTICAL SEPARATION FROM ANY EXISTING UTILITIES.
14. THE CONTRACTOR TO CONTACT WALKER COUNTY PRECINCT 4 AT LEAST 48 HOURS PRIOR TO CONSTRUCTION.

Kevin P. Lash, PE
 The Aspen Utility Company, LLC
 P.O. Box 23526
 Houston, Texas 77202
 Hockley, TX 77447
 • 1 (702) 493-5001

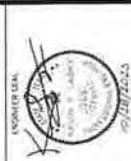

35502 HEMPSTEAD HWY.
 HOCKLEY, TX 77447


DESIGNED BY:
 QUANTA TELECOM SERVICES

DWG. NO.
 SHEET NO. 37 OF 45



CONCAST PROPOSES TO INSTALL FIBER OPTIC CABLE
 CONCAST PROPOSES TO PLACE DIRECTIONAL BORE 7.0 FT TO INSTALL FIBER
 OPTIC CABLE TO PROVIDE SERVICE TO 995 TX-150, NEW WAVERLY, TX 77358
 INSIDE THE ROW OF THE WALKER COUNTY, TX.
 TOTAL PROJECT FOOTAGE 710'



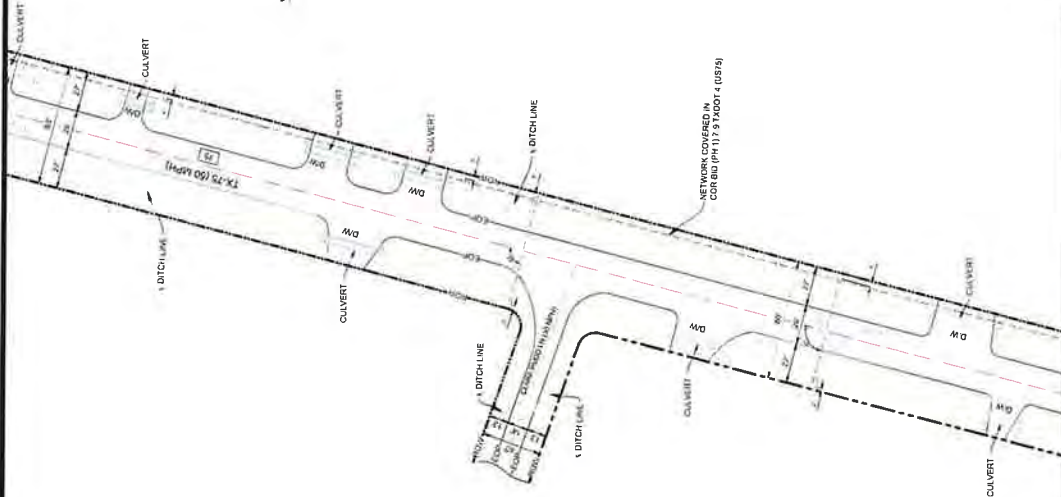

JB1771404 - 995 TX-150, NEW WAVERLY, TX 77358
 PLAN VIEW 36 OF 41

NOTES

1. THE WALKER COUNTY WILL BE NOTIFIED IN WRITING 48 HOURS PRIOR TO COMMENCING WORK.
2. THE WALKER COUNTY UTILITIES DEPARTMENT AND PUBLIC WORKS DEPARTMENT WILL BE NOTIFIED FOR LINE LOCATES AT (836) 436-4939
3. THE CONTRACTOR SHALL CONTACT TEXAS ONE CALL SYSTEM AT 1-800-245-4545 MIN. 48 HOURS BEFORE DIGGING.
4. THE CONTRACTOR SHALL DETERMINE THE EXISTING LOCATION OF ALL UNDERGROUND FACILITIES BEFORE COMMENCED WORK. THE CONTRACTOR SHALL BE FULLY RESPONSIBLE FOR ALL DAMAGES CAUSED BY HIS FAILURE TO EXACTLY LOCATE AND PRESERVE ALL UNDERGROUND FACILITIES.
5. NO MORE TRENCH OPENED AT ONE TIME THAN CAN BE BACKFILLED AND COMPACTED IN 12' LIFTS AT THE END OF EACH DAY (NO TRENCH LEFT OPENED OVERNIGHT).
6. ALL EXCESS EXCAVATION TO BE REMOVED FROM THE ROAD RIGHT-OF-WAY AT THE END OF EACH DAY.
7. DITCHES TO BE OPENED AT THE END OF EACH DAY TO ASSURE ADEQUATE DRAINAGE.
8. ROAD MUST BE KEPT OPEN TO TRAFFIC AND CONTRACTOR MUST PROVIDE ADEQUATE FLAGMEN, SIGNALS, ETC. TO PROVIDE COMPLETE SAFETY TO THE PUBLIC.
9. IF IT BECOMES NECESSARY FOR EQUIPMENT TO OPERATE ON A PORTION OF THE PAVEMENT, PRECAUTIONS MUST BE TAKEN TO PREVENT ANY DAMAGE WHATSOEVER TO THE PAVEMENT.
10. CONDITION OF ROAD UPON COMPLETION OF JOB SHALL BE AS GOOD OR BETTER THAN PRIOR TO STARTING.
11. CONTRACTOR SHALL COMPLY WITH ALL APPLICABLE NATIONAL ELECTRICAL SAFETY CODE (NEC) REQUIREMENTS, CENTERPOINT ENERGY ELECTRIC POLE ATTACHMENT GUIDELINES & PROCEDURES AND ALL APPLICABLE LOCAL ORDINANCES AND REGULATIONS FOR THE PLACEMENT OF AERIAL CABLE FACILITIES. 18' MIN. VERTICAL CLEARANCE.
12. ALL UTILITIES WILL BE IDENTIFIED BY POT-HOLE BEFORE ANY CONSTRUCTION.
13. COMCAST WILL MAINTAIN (87') HORIZONTAL & VERTICAL SEPARATION FROM ANY EXISTING UTILITIES.
14. THE CONTRACTOR TO CONTACT WALKER COUNTY PRECINCT 4 AT LEAST 48 HOURS PRIOR TO CONSTRUCTION.

Kevin R. Luby PE
 The Aspen Utility Company, LLC
 2000 Hwy 73506
 Hookley, TX 77447
 +1 (702) 403-3001



COMCAST PROPOSES TO INSTALL FIBER OPTIC CABLE
 COMCAST PROPOSES TO PLACE DIRECTIONAL BURE 710 FT TO INSTALL FIBER OPTIC CABLE TO PROVIDE SERVICE TO 995 TX-150, NEW WAVERLY, TX 77358
 INSIDE THE ROW OF THE WALKER COUNTY, TX
 TOTAL PROJECT FOOTAGE: 710'

JB1771404 - 995 TX-150, NEW WAVERLY, TX 77358




36502 HEMPSTEAD HWY
 HOOKLEY, TX 77447

DESIGNED BY:
 QUANTA TELECOM SERVICES

DWG. NO.
 SHEET NO. 38 OF 45

LAMBERT: N/A
 DATE: 10/27/2025
 KEY MAP NO. 75K
 SCALE: 1" = 40'

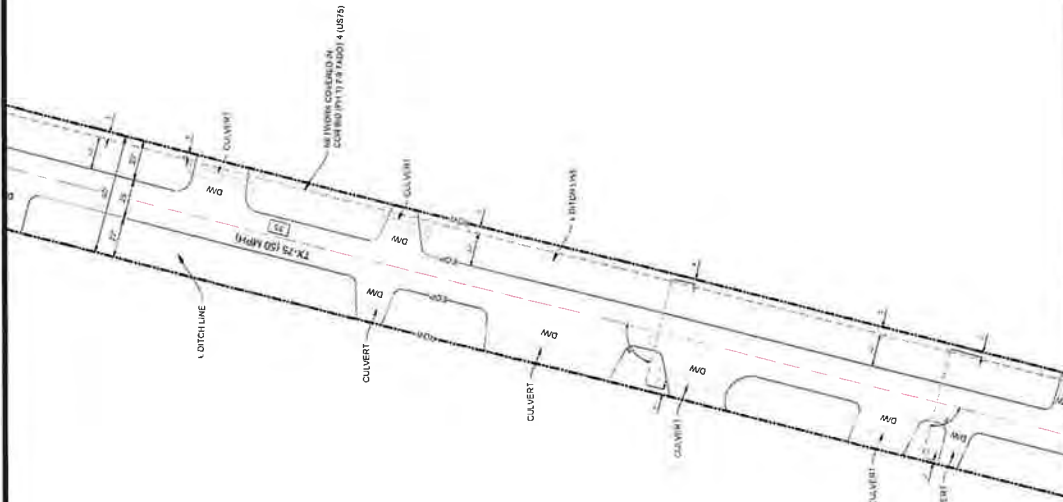


JB1771404 - 395 TX-150, NEW WAVERLY, TX 77358
PLAN VIEW 37 OF 41

NOTES

1. THE WALKER COUNTY WILL BE NOTIFIED IN WRITING 48 HOURS PRIOR TO COMMENCING WORK.
2. THE WALKER COUNTY UTILITIES DEPARTMENT AND PUBLIC WORKS DEPARTMENT WILL BE NOTIFIED FOR LINE LOCATES AT (936) 336-4399.
3. THE CONTRACTOR SHALL CONTACT TEXAS ONE CALL SYSTEM AT 1-800-368-5848, 48 HOURS BEFORE DIGGING.
4. THE CONTRACTOR SHALL DETERMINE THE EXACT LOCATION OF ALL UNDERGROUND FACILITIES BEFORE COMMENCING WORK AND AGREE TO EXACTLY LOCATE AND PRESERVE ALL UNDERGROUND FACILITIES.
5. NO MORE TRENCH OPENED AT ONE TIME THAN CAN BE BACKFILLED AND COMPACTED IN 10' LIFTS AT THE END OF EACH DAY (NO TRENCH LEFT OPENED OVERNIGHT).
6. ALL EXCESS EXCAVATION TO BE REMOVED FROM THE ROAD RIGHT-OF-WAY AT THE END OF EACH DAY.
7. DITCHES TO BE OPENED AT THE END OF EACH DAY TO ASSURE ADEQUATE DRAINAGE.
8. ROAD MUST BE KEPT OPEN TO TRAFFIC AND CONTRACTOR MUST PROVIDE ADEQUATE FLAGMEN, SIGNALS, ETC., TO PROVIDE COMPLETE SAFETY TO THE PUBLIC.
9. IF IT BECOMES NECESSARY FOR EQUIPMENT TO OPERATE ON A PORTION OF THE PAVEMENT, PRECAUTIONS MUST BE TAKEN TO PREVENT ANY DAMAGE WHATSOEVER TO THE PAVEMENT.
10. CONDITION OF ROAD UPON COMPLETION OF JOB SHALL BE AS GOOD OR BETTER THAN PRIOR TO STARTING.
11. CONTRACTOR SHALL COMPLY WITH ALL APPLICABLE NATIONAL ELECTRICAL SAFETY CODE (NEC) REQUIREMENTS, CENTERPOINT ENERGY ELECTRIC POLE ATTACHMENT GUIDELINES & PROCEDURES AND ALL APPLICABLE LOCAL ORDINANCES AND REGULATIONS FOR THE PROTECTION OF AERIAL CABLE FACILITIES, 18" MIN. VERTICAL CLEARANCE.
12. ALL UTILITIES WILL BE IDENTIFIED BY POT HOLE BEFORE ANY CONSTRUCTION.
13. CONTRACTOR SHALL MAINTAIN (2FT) HORIZONTAL & VERTICAL SEPARATION FROM ANY EXISTING UTILITIES.
14. THE CONTRACTOR TO CONTACT WALKER COUNTY PRECINCT 4 AT LEAST 48 HOURS PRIOR TO CONSTRUCTION.

 Kevin P. Lusk, PE
The Aspen Utility Company, LLC
Firm No. 23326
38502 Hempstead Highway
Hockley, TX 77447
• (1) (20) 193.50-1



38502 HEMPSTEAD HWY
HOCKLEY, TX 77447



CONCAST PROPOSES TO INSTALL FIBER OPTIC CABLE
CONCAST PROPOSES TO PLACE DIRECTIONAL BORE 710 FT TO INSTALL FIBER
OPTIC CABLE TO PROVIDE SERVICE TO 395 TX-150, NEW WAVERLY, TX 77358
INSIDE THE ROW OF THE WALKER COUNTY, TX
TOTAL PROJECT FOOTPADE: 710'




DESIGNED BY:
QUANTA TELECOM SERVICES

DWG. NO.
SHEET NO. 39 OF 45



LAMBERT N/A
DATE 10/27/2023
KEY MAP NO 75K
SCALE 1\"/>


JB1771404 - 995 TX-150, NEW WAVERLY, TX 77358
 PLAN VIEW 38 OF 41

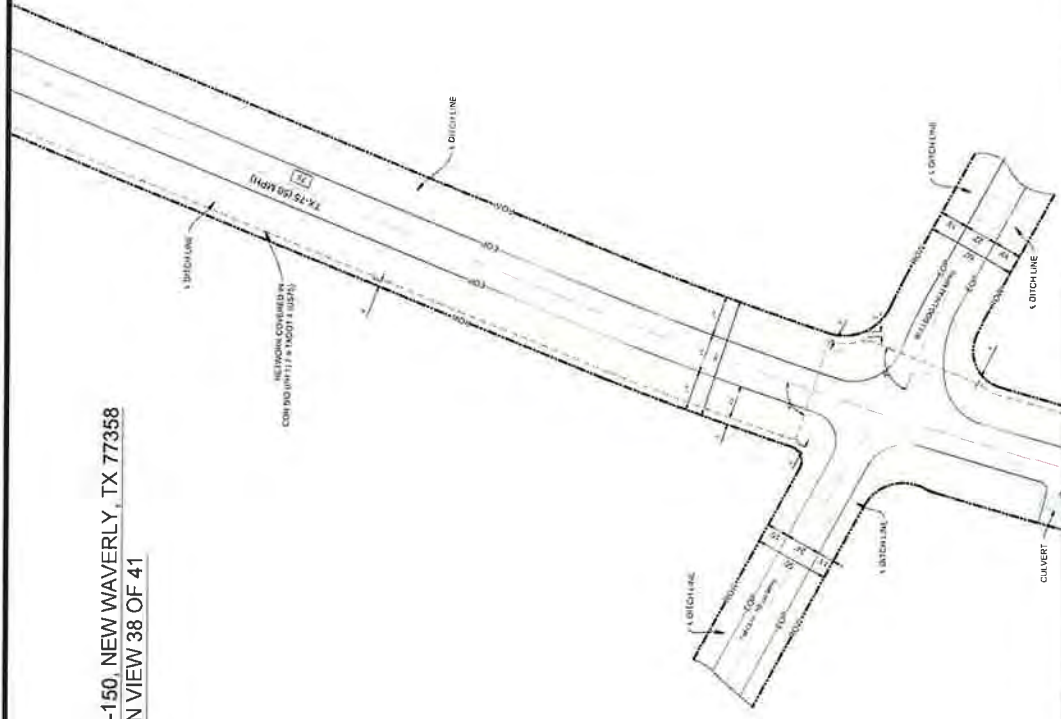

NOTES

1. THE WALKER COUNTY WILL BE NOTIFIED IN WRITING 48 HOURS PRIOR TO COMMENCING WORK.
2. THE WALKER COUNTY UTILITIES DEPARTMENT AND PUBLIC WORKS DEPARTMENT WILL BE NOTIFIED FOR LINE LOCATES AT (936) 436-4839
3. THE CONTRACTOR SHALL CONTACT TEXAS ONE CALL SYSTEM AT 1-800-254-4545 MIN. 48 HOURS BEFORE DIGGING
4. THE CONTRACTOR SHALL DETERMINE THE EXACT LOCATION OF ALL UNDERGROUND FACILITIES BEFORE COMMENCING WORK. CONTRACTOR SHALL BE FULLY RESPONSIBLE FOR ALL DAMAGES CAUSED BY HIS FAILURE TO EXACTLY LOCATE AND PRESERVE ALL UNDERGROUND FACILITIES
5. NO MORE TRENCH OPENED AT ONE TIME THAN CAN BE BACKFILLED AND COMPACTED IN 10' LIFTS AT THE END OF EACH DAY (NO TRENCH LEFT OPENED OVERNIGHT)
6. ALL EXCESS EXCAVATION TO BE REMOVED FROM THE ROAD RIGHT-OF-WAY AT THE END OF EACH DAY
7. DITCHES TO BE OPENED AT THE END OF EACH DAY TO ASSURE ADEQUATE DRAINAGE
8. ROAD MUST BE KEPT OPEN TO TRAFFIC AND CONTRACTOR MUST PROVIDE ADEQUATE FLAGMEN SIGNALS, ETC. TO PROVIDE COMPLETE SAFETY TO THE PUBLIC.
9. IF IT BECOMES NECESSARY FOR EQUIPMENT TO OPERATE ON A PORTION OF THE PAVEMENT, PRECAUTIONS MUST BE TAKEN TO PREVENT ANY DAMAGE WHATSOEVER TO THE PAVEMENT
10. CONDITION OF ROAD UPON COMPLETION OF JOB SHALL BE AS GOOD OR BETTER THAN PRIOR TO STARTING
11. CONTRACTOR SHALL COMPLY WITH ALL APPLICABLE NATIONAL ELECTRICAL SAFETY CODE (NEC) REQUIREMENTS, CENTERPOINT ENERGY ELECTRIC POLE ATTACHMENT GUIDELINES & PROCEDURES AND ALL APPLICABLE LOCAL ORDINANCES AND REGULATIONS FOR PLACEMENT OF AERIAL CABLE FACILITIES 18' MIN. VERTICAL CLEARANCE
12. ALL UTILITIES WILL BE IDENTIFIED BY POT-HOLE BEFORE ANY CONSTRUCTION
13. COMCAST WILL MAINTAIN (2FT) HORIZONTAL & VERTICAL SEPARATION FROM ANY EXISTING UTILITIES
14. THE CONTRACTOR TO CONTACT WALKER COUNTY PRECINCT 4 AT LEAST 48 HOURS PRIOR TO CONSTRUCTION

Kevin P. Lasky PE
 The Aspen Utility Company, LLC
 Firm No. 23326
 14000 Katy Freeway, Suite 100
 Houston, TX 77057
 • (713) 493-3001

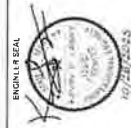


COMCAST PROPOSES TO INSTALL FIBER OPTIC CABLE
 COMCAST PROPOSES TO PLACE DIRECTIONAL BORE 710 FT TO INSTALL FIBER OPTIC CABLE TO PROVIDE SERVICE TO 995 TX-150, NEW WAVERLY, TX 77358
 INSIDE THE ROW OF THE WALKER COUNTY, TX.
 TOTAL PROJECT FOOTAGE: 110'


JB1771404 - 995 TX-150, NEW WAVERLY, TX 77358



 DESIGNED BY:
 QUANTA TELECOM SERVICES
 DWG NO.
 SHEET NO. 40 OF 45



JB1771404 - 995 TX-150, NEW WAVERLY, TX 77358
PLAN VIEW 39 OF 41

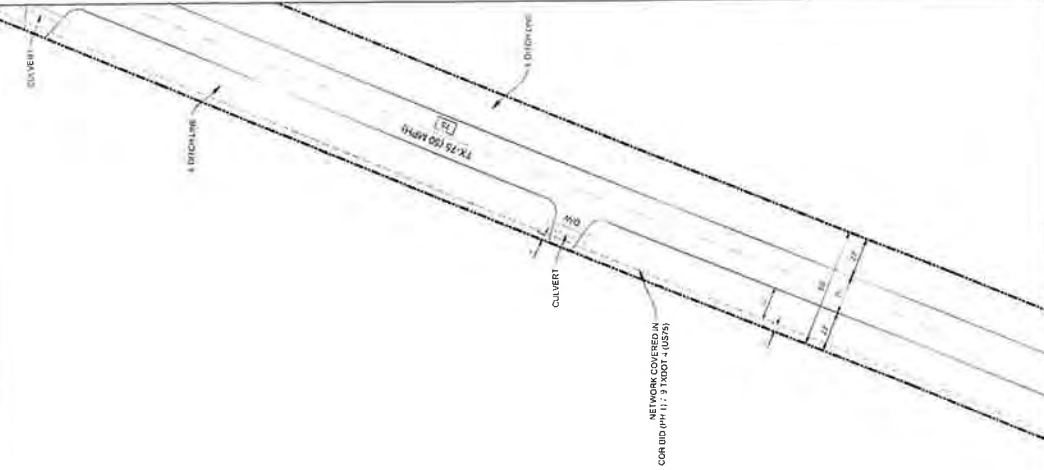

NOTES

1. THE WALKER COUNTY WILL BE NOTIFIED IN WRITING 48 HOURS PRIOR TO COMMENCING WORK.
2. THE WALKER COUNTY UTILITIES DEPARTMENT AND PUBLIC WORKS DEPARTMENT WILL BE NOTIFIED FOR LINE LOCATES AT (336) 436-4899.
3. THE CONTRACTOR SHALL CONTACT TEXAS ONE CALL SYSTEM AT 1-800-245-4545 MIN 48 HOURS BEFORE DIGGING.
4. THE CONTRACTOR SHALL DETERMINE THE EXACT LOCATION OF ALL UNDERGROUND FACILITIES BEFORE COMMENCING WORK AND AGREE TO BE FULLY RESPONSIBLE FOR ALL DAMAGES CAUSED BY HIS FAILURE TO EXACTLY LOCATE AND PRESERVE ALL UNDERGROUND FACILITIES.
5. NO MORE TRENCH OPENED AT ONE TIME THAN CAN BE BACKFILLED AND COMPACTED IN 24 HOURS AT THE END OF EACH DAY (NO TRENCH LEFT OPENED OVERNIGHT).
6. ALL EXCESS EXCAVATION TO BE REMOVED FROM THE ROAD RIGHT-OF-WAY AT THE END OF EACH DAY.
7. DITCHES TO BE OPENED AT THE END OF EACH DAY TO ASSURE ADEQUATE DRAINAGE.
8. ROAD MUST BE KEPT OPEN TO TRAFFIC AND CONTRACTOR MUST PROVIDE ADEQUATE FLAGMEN, SIGNALS, ETC. TO PROVIDE COMPLETE SAFETY TO THE PUBLIC.
9. IF IT BECOMES NECESSARY FOR EQUIPMENT TO OPERATE ON A PORTION OF THE PAVEMENT PRECAUTIONS MUST BE TAKEN TO PREVENT ANY DAMAGE WHATSOEVER TO THE PAVEMENT.
10. CONDITION OF ROAD UPON COMPLETION OF JOB SHALL BE AS GOOD OR BETTER THAN PRIOR TO STARTING.
11. CONTRACTOR SHALL COMPLY WITH ALL APPLICABLE NATIONAL ELECTRICAL SAFETY CODE (NEC) REQUIREMENTS, CENTERPOINT ENERGY ELECTRIC POLE ATTACHMENT GUIDELINES & PROCEDURES AND ALL APPLICABLE LOCAL ORDINANCES AND REGULATIONS FOR THE PLACEMENT OF AERIAL CABLE FACILITIES, 18" MIN VERTICAL CLEARANCE.
12. ALL UTILITIES WILL BE IDENTIFIED BY POT HOLE BEFORE ANY CONSTRUCTION.
13. COMCAST WILL MAINTAIN BOTH HORIZONTAL & VERTICAL SEPARATION FROM ANY EXISTING UTILITIES.
14. THE CONTRACTOR TO CONTACT WALKER COUNTY PRECINCT 4 AT LEAST 48 HOURS PRIOR TO COMMENCING WORK.

Kevin P. Lundy, PE
The Aspen Utility Company, LLC
Engine No. 23258
36502 Hempstead Highway
Hockley, TX 77447
+1 (832) 493-5201

ENGINEER SEAL



DESIGNED BY:
QUANTA TELECOM SERVICES

 
LAMBERT: N/A

DATE: 10/27/2025

KEY MAP NO. 75K

SCALE: 1" = 40'

DWG. NO.
SHEET NO. 41 OF 45




36502 HEMPSTEAD HWY
HOCKLEY, TX 77447

JB1771404 - 995 TX-150, NEW WAVERLY, TX 77358

COMCAST PROPOSES TO INSTALL FIBER OPTIC CABLE
COMCAST PROPOSES TO PLACE DIRECTIONAL DRILL JUST TO INSTALL FIBER
OPTIC CABLE TO PROVIDE SERVICE TO 995 TX-150, NEW WAVERLY, TX 77358
INSIDE THE ROW OF THE WALKER COUNTY, TX
TOTAL PROJECT FOOTAGE: 712'



JB1771404 - 995 TX-150, NEW WAVERLY, TX 77358
PLAN VIEW 40 OF 41

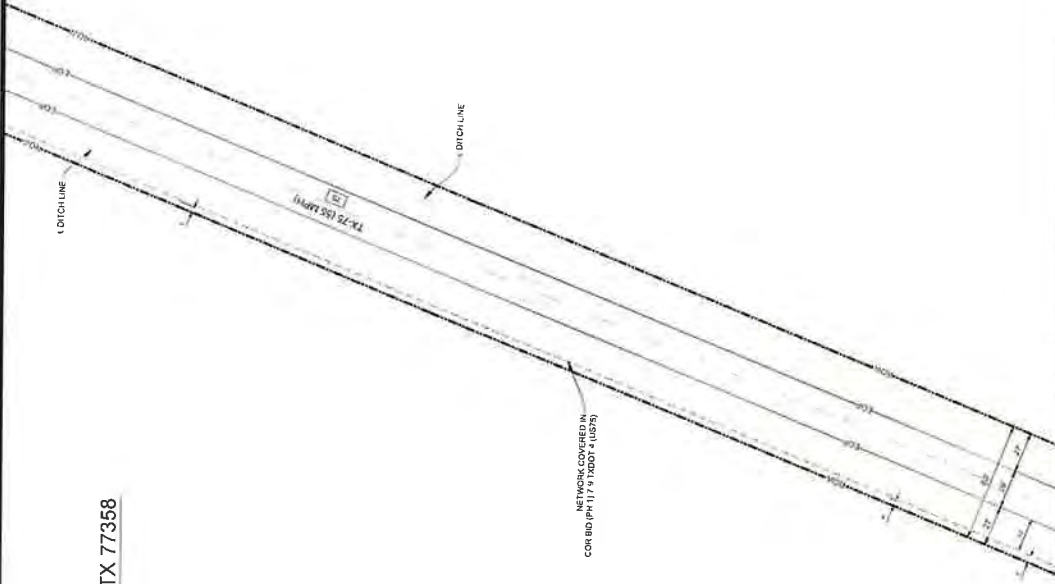

NOTES

1. THE WALKER COUNTY WILL BE NOTIFIED IN WRITING 48 HOURS PRIOR TO COMMENCING WORK.
2. THE WALKER COUNTY UTILITIES DEPARTMENT AND PUBLIC WORKS DEPARTMENT WILL BE NOTIFIED FOR LINE LOCATES AT (886) 436-4898.
3. THE CONTRACTOR SHALL CONTACT TEXAS ONE CALL SYSTEM AT 1-800-245-4545 MIN. 48 HOURS BEFORE DIGGING.
4. THE CONTRACTOR SHALL DETERMINE THE EXACT LOCATION OF ALL UNDERGROUND FACILITIES BEFORE COMMENCING WORK. THE CONTRACTOR SHALL BE FULLY RESPONSIBLE FOR ALL DAMAGES CAUSED BY HIS FAILURE TO EXACTLY LOCATE AND PRESERVE ALL UNDERGROUND FACILITIES.
5. NO MORE TRENCH OPENED AT ONE TIME THAN CAN BE BACKFILLED AND COMPACTED IN 10' LIFTS AT THE END OF EACH DAY (NO TRENCH LEFT OPENED OVERNIGHT).
6. ALL EXCESS EXCAVATION TO BE REMOVED FROM THE ROAD RIGHT-OF-WAY AT THE END OF EACH DAY.
7. DITCHES TO BE OPENED AT THE END OF EACH DAY TO ASSURE ADEQUATE DRAINAGE.
8. ROAD MUST BE KEPT OPEN TO TRAFFIC AND CONTRACTOR MUST PROVIDE ADEQUATE FLAGMEN, SIGNALS, ETC. TO PROVIDE COMPLETE SAFETY TO THE PUBLIC.
9. IF IT BECOMES NECESSARY FOR EQUIPMENT TO OPERATE ON A PORTION OF THE PAVEMENT, PRECAUTIONS MUST BE TAKEN TO PREVENT ANY DAMAGE WHATSOEVER TO THE PAVEMENT.
10. CONDITION OF ROAD UPON COMPLETION OF JOB SHALL BE AS GOOD OR BETTER THAN PRIOR TO STARTING.
11. CONTRACTOR SHALL COMPLY WITH ALL APPLICABLE NATIONAL ELECTRICAL SAFETY CODE (NEC) REQUIREMENTS, CENTERPOINT ENERGY ELECTRIC POLE ATTACHMENT GUIDELINES & PROCEDURES AND ALL OTHER LOCAL, STATE, FEDERAL AND REGULATORY REQUIREMENTS FOR PLACEMENT OF AERIAL CABLE FACILITIES. 18' MIN. VERTICAL CLEARANCE.
12. ALL UTILITIES WILL BE IDENTIFIED BY POT-HOLE BEFORE ANY CONSTRUCTION.
13. COMCAST WILL MAINTAIN (8FT) HORIZONTAL & VERTICAL SEPARATION FROM ANY EXISTING UTILITIES.
14. THE CONTRACTOR TO CONTACT WALKER COUNTY PRECINCT 4 AT LEAST 48 HOURS PRIOR TO CONSTRUCTION.

Kenn P. Lasky, PE
The Aspen Utility Company, LLC
P.O. Box 22308
Houston, Texas 77202
New Waverly, TX 77447
+1 (702) 453-3601



35502 HEMPSTEAD HWY
HOCKLEY, TX 77447

JB1771404 - 995 TX-150, NEW WAVERLY, TX 77358

 
COMCAST PROPOSES TO INSTALL FIBER OPTIC CABLE
COMCAST PROPOSES TO PLACE DIRECTIONAL BORE 710 FT TO INSTALL FIBER
OPTIC CABLE TO PROVIDE SERVICE TO 995 TX-150, NEW WAVERLY, TX 77358.
INSIDE THE ROW OF THE WALKER COUNTY, TX.
TOTAL PROJECT FOOTAGE: 710'



DESIGNED BY:
QUANTA TELECOM SERVICES

DWG. NO.
SHEET NO. 42 OF 45

DATE: 10/27/2025
KEY MAP NO. 70K
SCALE: 1"=40'



[illegible]

1. THE WALKER COUNTY SHALL BE NOTIFIED IN WRITING 48 HOURS PRIOR TO COMMENCING WORK.
2. THE WALKER COUNTY UTILITIES DEPARTMENT AND PUBLIC WORKS DEPARTMENT WILL BE NOTIFIED FOR LINE LOCATES AT (806) 434-4939
3. THE CONTRACTOR SHALL CONTACT TEXAS ONE CALL SYSTEM AT 1-800-368-5868 MIN. 48 HOURS BEFORE BEGINNING
4. THE CONTRACTOR SHALL DETERMINE THE EXACT LOCATION OF ALL UTILITIES AND BE FULLY RESPONSIBLE FOR ALL DAMAGES CAUSED BY HIS FAILURE TO EXACTLY LOCATE AND PRESERVE ALL UNDERGROUND FACILITIES
5. NO MORE THAN 12' OPEN AT ONE TIME THAN CAN BE BACKFILLED AND COMPACTED IN 12' LIFTS AT THE END OF EACH DAY (NO TRENCH LEFT OPENED OVERNIGHT)
6. ALL EXCESS EXCAVATION TO BE REMOVED FROM THE ROAD RIGHT-OF-WAY AT THE END OF EACH DAY
7. DITCHES TO BE OPENED AT THE END OF EACH DAY TO ASSURE ADEQUATE DRAINAGE.
8. ROAD MUST BE KEPT OPEN TO TRAFFIC AND CONTRACTOR MUST PROVIDE ADEQUATE FLAGMEN SIGNALS, ETC. TO PROVIDE COMPLETE SAFETY TO THE PUBLIC
9. IF IT BECOMES NECESSARY FOR EQUIPMENT TO OPERATE ON A PORTION OF THE PAVEMENT PRECAUTIONS MUST BE TAKEN TO PREVENT ANY DAMAGE WHATSOEVER TO THE PAVEMENT
10. CONDITION OF ROAD UPON COMPLETION OF JOB SHALL BE AS GOOD OR BETTER THAN PRIOR TO STARTING
11. CONTRACTOR SHALL COMPLY WITH ALL APPLICABLE NATIONAL ELECTRICAL SAFETY CODE (NEC) REQUIREMENTS, CENTERPOINT ENERGY ELECTRICAL P pole ATTACHMENT GUIDELINES & PROCEDURES AND ALL APPLICABLE FEDERAL, STATE AND LOCAL ELECTRICAL WORK PLACEMENT OF AERIAL CABLE FACILITIES 18" MIN VERTICAL CLEARANCE
12. ALL UTILITIES WILL BE IDENTIFIED BY POT HOLE BEFORE ANY CONSTRUCTION
13. CONCRETE SHALL BE IDENTIFIED BY POT HOLE & VERTICAL SEPARATION FROM ANY EXISTING UTILITIES
14. THE CONTRACTOR TO CONTACT WALKER COUNTY PRECINCT 4 AT LEAST 48 HOURS PRIOR TO CONSTRUCTION



COMCAST PROPOSES TO INSTALL FIBER OPTIC CABLE
COMCAST PROPOSES TO PLACE DIRECTIONAL BORE 710 FT TO INSTALL FIBER
OPTIC CABLE TO PROVIDE SERVICE TO 985 TX-150, NEW WAVERLY, TX 77358
INSIDE THE ROW OF THE WALKER COUNTY, TX
TOTAL PROJECT FOOTAGE: 710'

ASPEN
36502 HEMPSTEAD HWY
HOCKLEY TX 77447

DWG. NO.
SHEET NO. 43 OF 45

LAMBERT: N/A
DATE 10/27/2
KEY MAP NO 7
SCALE: 1:40



Utility Installation Request

To the Commissioner's Court of Walker County

Date 09/02/2025

Application is hereby made by Guadalupe Tobon-Horner

to place FIBER OPTIC CABLE

and/or perform the following described work _____ within the Right of Way of that Walker County road known as TX-150 at the following approximate coordinates (lat/long) N 30.545016, W -95.49342

The exact location and extent of the proposed work shall be as shown on the attached specifications and drawings.

We will construct and maintain the line on the road right of way as shown on the attached drawing and in accordance with the rules, regulations and policies of Walker County, the Texas Department of Transportation (TXDOT), and all governing laws, including, but not limited to, the "Texas Engineering Practice Act," "Federal Clean Water Act," the "National Endangered Species Act," "Americans with Disabilities Act," and the "Federal Historic Preservation Act." Upon request by Walker County, we will submit to Walker County proof of compliance with all governing laws, rules and regulations before commencement of construction. Plans shall include the design, proposed location, vertical elevations, and horizontal alignments of the facility based on the department's survey datum, the relationship to existing highway facilities and the right of way line, traffic safety and access procedures, and location of existing utilities that may be affected by the proposed utility facility. The location and description of the proposed line and appurtenances is more fully shown by a complete set of drawings attached to this Utility Installation Request. We will give plans to Walker County for each future proposed modification or expansion to our facility and all Walker County to review and approve submittals prior to commencement of the work.

A new request may be required as a condition of approval.

Our organization will use Best Management Practices to minimize erosion and sedimentation resulting from the proposed installation, and we will re-vegetate the project area as indicated under "Re-vegetation Special Provisions."

Our organization will ensure that traffic control measures complying with applicable portions of the *Texas Manual on Uniform Traffic Control Devices* will be installed and maintained for the duration of this installation.

When installing our utility on controlled access facilities, we shall conform to the Texas Transportation Code, Title 6 Roadways, Chapter 203, Subchapter C, Control of Access, §203.031. We shall limit access for servicing this installation to access via (a) frontage roads where provided, (b) nearby or adjacent public roads or streets, (c) trails along or near the highway right of way lines, connecting only to an intersecting road; from any one or all of which entry may be made to the outer portion of the highway right of way for normal service and maintenance operations. Our rights of access to the through traffic roadways and ramps shall be subject to the same rules and regulations that apply to the general public.

It is expressly understood that Walker County does not purport, hereby, to grant any right, claim, title or easement in or upon this road; and it is further understood that Walker County may require us to relocate this line and any associated infrastructure, at the total expense of the applicant/utility owner, by giving thirty (30) days written notice prior to the date that the relocation shall be completed. We understand that a new Request will be required for the relocation.

We will notify Walker County prior to commencement of any routine or periodic maintenance which requires pruning of trees within the highway right of way, so that Walker County may provide specifications for the extent and methods to govern in, but not limited to, trimming, topping, tree balance, type of cuts, painting cuts and clean up.

Our installation shall not damage any part of the roadway structure or associated appurtenances and we will make adequate provisions to minimize inconveniences to the traveling public, and adjacent property owners. In the event we fail to comply with any or all of the requirements as set forth herein, the County may take such action as it deems appropriate to compel our compliance.

RECEIVED

SEP 02 2025

BY:

Following approval, we will begin construction on or after 11/03/2025 (month/day/yr)

Additional Provisions and Requirements (for TxDOT input only)

General Special Provisions:

- ☒ Are attached.
☐ Are not attached

As-built Plans/Certifications of Construction:

- ☐ Are required and shall be certified as accurate by an authorized representative of the company.
☒ Are required and shall be signed and sealed by a State of Texas Licensed Professional Engineer.
☒ Certification that utility was installed as approved
☐ Are not required

Re-vegetation Special Provisions: In order to minimize erosion and sedimentation resulting from the proposed installation, the project area will be re-vegetated:

- ☒ In accordance with TxDOT's Standard Specification Item 164 which specifies the appropriate grass seed mix to be used, or:
☐ As indicated on the attachment.

The Precinct Commissioner or his/her representative is to be notified 48 hours prior to beginning construction.

If approved, we understand that we will assume all risks associated with this installation within the Walker County right of way. These risks include, but are not limited to, injuries to our workers, damage to contiguous utility lines that may be in the area, injuries or damage resulting from our failure to properly install and maintain the line as shown on plans.

We understand Walker County may place additional provisions and requirements as listed above, based upon, but not limited to, the type of utility being installed, local site conditions, soil types and traffic.

We acknowledge that this Utility Installation Request approval **expires** on the **91st** calendar day from the date of issuance, unless otherwise approved, if we do not begin our installation by this date. If we do not begin our installation within this time frame and still wish to continue, we will resubmit our request in accordance with the prevailing governing laws, rules, regulations and policies at the time of resubmission.

By signing as/for the requestor below, I certify that I am authorized to represent the requestor, that I agree to the provisions and requirements included in this Utility Installation Request, and our commencement of construction will further attest to our review and acceptance of said additional provisions and requirements

Requestor:

Date: 09/02/2025

By: Guadalupe Tobon-Horner

Signature: Guadalupe Tobon-Horner

Title: Permit Coordinator

Address: 36502 HEMPSTEAD RD. LOT #20,
HOCKLEY, TX. 77447

Telephone: 346-471-2612

Approved By:

Date: _____

By: _____

Signature: _____

Title: _____

Address: _____

Telephone: _____

RECEIVED

SEP 02 2025

BY:

**General Special Provisions
Walker County Utility Installation Request**

1. Effective Period of Permit Approval. All approvals are void if installation does not begin within 3 months from the date of approval.
2. ALL UTILITY INSTALLATIONS SHALL CONFORM WITH THE STANDARDS DESCRIBED IN TITLE 43, PART 1, CHAPTER 21, SUBCHAPTER C, OF THE TEXAS ADMINISTRATIVE CODE (UTILITY ACCOMODATIONS)
3. A FINAL AS-BUILT SET OF PLANS SHALL BE SUBMITTED AND CERTIFIED BY A PROFESSIONAL ENGINEER, INCLUDING A CERTIFICATION THAT THE INSTALLATION WAS COMPLETED IN CONFORMANCE AND COMPLIANCE WITH THE ABOVE DESCRIBED SECTIONS OF THE TEXAS ADMINISTRATIVE CODE AND TEXAS DEPARTMENT OF TRANSPORTATION MINIMUM SPECIFICATIONS. A statement must be included certifying that any pipe/casing installed is properly designed for the application and the installation meets the minimum standards for TxDOT and Title 43 of the Texas Administrative Code.
4. Minimum Depth of Cover. The minimum depth of cover for any underground utility line shall be as shown on the "Minimum Depth of Cover Table" for the TxDOT District or attached schematic whichever is deeper.
5. Locating Utilities. Applicant shall take all reasonable and necessary steps to locate existing utilities and address them in accordance with all state, local, and or federal requirements.
6. Aerial Electric Lines. Aerial electric power lines crossing over the highway shall be installed and maintained a minimum of twenty-two (22) feet above the surface of the traffic lanes. For electric power lines with greater than 50,000 volts, the clearance shall be increased in accordance with National Electric Safety Code as published in the National Bureau of Standards, Handbook 30.
7. Aerial Communication Lines. Aerial communication lines crossing over the highway shall be installed and maintained a minimum of eighteen (18) feet above the surface of the traffic lanes.
8. Open Trenching or Boring Operations for Utility Work. To insure that disturbed areas are restored and revegetated properly and in a reasonable period as the utility work progresses, the following requirements shall apply:

Unless otherwise approved or directed by Walker County, the length of "active utility work" shall not exceed one mile in length. "Active utility work" shall be defined as the total disturbed area measured from the beginning of open trenching to the point where backfill has been compacted, the right of way has been restored to its original line and grade, any structures damaged by the utility work have been repaired, erosion control measures have been placed and are being properly maintained, approved topsoil seed and compost has been placed uniformly, and watering for revegetation has begun. "Active utility work" also includes areas of bore pits and receiving pits; however, it does not include the underground boring length. When any area of "active utility work" is substantially complete (i.e., watering of seeded areas has begun), that area is no longer considered to be "active utility work", and "active utility work" can proceed further within the right of way as long as it does not exceed the above appropriate limits. Areas where Walker County determines that the "active utility work" is substantially complete does not mean that Walker County considers that area totally acceptable and complete.

9. Backfill, Erosion Control, and Re-vegetation. All excavations within the right-of-way (ROW) and not under pavement shall be backfilled by tamping in six (6) inch horizontal layers to the density of the surrounding soil or as directed by the Walker County. All surplus material shall be removed and the ROW shall be reshaped to



**General Special Provisions
Walker County Utility Installation Request**

its original condition or better. This work shall be done in accordance with Item 164 of the Texas Department of Transportation (TxDOT) "Standard Specifications for Construction and Maintenance of Highways, Streets, and Bridges." Erosion control measures such as soil retention blankets, rock berms, and silt fences shall be installed and maintained until permanent perennial vegetation is established over 70% of the disturbed area. The amount of revegetation is considered acceptable when it resembles the amount of existing vegetation in the surrounding undisturbed area. **If erosion control and/or storm water run-off requirements of other State, Federal, or Local Jurisdictions exceed these requirements then the more stringent requirements would prevail.**

 
8. Boring and Jacking. Boring and jacking of utility lines shall be provided as specified below.
- a. Under Paved County Roads. Utility lines to be constructed under an existing paved (asphalt pavement or concrete pavement) county road shall be installed by boring and jacking with casing.
 - b. Under Paved Driveways. Utility lines to be constructed under existing paved (asphalt pavement or concrete pavement) driveways shall be installed by boring and jacking methods, unless the utility company furnishes Walker County with a "Letter of No Objection" signed by the driveway owner to allow open cutting of their driveway.
 - c. Under Unpaved County Roads or Driveways. Utility lines to be constructed under an existing unpaved county road or under existing unpaved driveways may be open cut only when approved in advance by Walker County, and after the driveway owner is notified. Any open cuts should be repaired and restored to a minimum of pre-cut conditions as quickly as possible so as not to impact road and/or driveway traffic. Applicant shall take all necessary precautions to insure safety as site of open cut.
 - d. Under Desirable Trees. To preserve the natural environment and protect wildlife habitat, boring may be required when underground utility lines are to be placed within the "protected root area" of "desirable trees" located within road ROW or on adjacent property. The "protected root area" is defined as the area between the tree trunk and five (5) feet from the tree trunk or 2/3 the actual distance from the tree trunk to the dripline, whichever is greater. "Desirable trees" include (but are not limited to) any tree with a trunk diameter of six (6) inches or more that Walker County or the Owner of the tree determines to be of environmental and aesthetic value. Boring under all "desirable trees" will be required with the following exceptions: (1) in areas where planned highway construction/maintenance work would require tree removal, or (2) when the Walker County approves of open trenching for the utility installation or removal of the tree.
9. Manhole Covers. All manhole covers shall be installed flush with the ground surface.
10. Traffic Control. Traffic control in utility work zones shall conform to applicable requirements of the "Texas Manual on Uniform Traffic Control Devices for Streets and Highways, Part VI". Adequate signs, barricades, flag personnel, etc. shall be erected and maintained in complete compliance with the Texas Manual on Uniform Traffic Control Devices. Any travel lane closures are only permitted after a traffic control plan is approved by Walker County prior to beginning any construction activities.
11. Sunday or Holiday Work. Sunday or Holiday work will not be permitted for the installation of any utility line unless directed or approved by Walker County.



**General Special Provisions
Walker County Utility Installation Request**

12. The approval of this utility installation request shall in no way be taken as a waiver or variance to any other existing local, state, or federal permits or requirements that may be required by the applicant.
13. Please note that Walker County will be making no verification through this process of the actual location of the public right of way as to width or location. The responsibility to locate the bounds of any public right of way that your project will utilize is the responsibility of your company. Walker County's approval of the request is not an agreement as to location of the public right of way, nor does it confer any easement, right of way, or property right for the project area.
14. Protection of Trees and Landscaping. Existing trees and landscaping within the ROW shall be protected as specified below. Removal of trees from the ROW will require prior Walker County approval.
- a. Tree Pruning. All tree pruning within the ROW will require prior TxDOT approval. All oak trees that are damaged or pruned shall be treated with an approved tree wound dressing within 20 minutes of causing the damage or making the pruning cut.
- b. Landscaping. When existing landscaping is located near the proposed utility alignment, the utility contractor shall notify Walker County and the owner of the landscaping prior to the proposed utility installation. Walker County may require underground utilities to be installed by: (1) boring under such landscaping or (2) by replacement of specific landscape items. Landscaping is defined as, but not limited to, trees, shrubs, grass, irrigation lines, landscape pavers, sidewalks, and other ROW improvements.

RECEIVED
SEP 02 2025
BY:.....



JB1771404 - 995 TX-150, NEW WAVERLY, TX 77358/PRECINCT 4

COMCAST PROPOSES TO PLACE DIRECTIONAL BORE 710 FT TO INSTALL FIBER OPTIC CABLE TO PROVIDE SERVICE TO 995 TX-150, NEW WAVERLY, TX 77358, INSIDE THE ROW OF THE WALKER COUNTY, TX.

NOT TO SCALE




WORK AREA

VICINITY MAP

KEY MAP : 75K

LAMBERT : N/A

GIMS: N/A

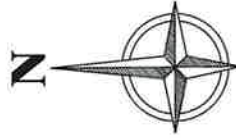[illegible]

BUILD	DESCRIPTION	UNIT	QUANTITY
	DIRECTIONAL SLOPE	110	11
	TRENCH	0	11
	ON-SITE DRAINAGE CONDUIT	0	11
	BORE PITS	1	EA
	KNOW WALLS	0	EA
	EXISTING WALLS	0	EA
	FOR CIRCULAR PERIMETER	0	EA
	HYDROLOGIC DECLIN. HOUSING	3	EA
	AERIAL RIGGING	0	11
	WIRE STRAPPING	0	11
	OVERLASH	0	11
	ANCHORS	0	EA
	PRE-CASTED HOUSING	1	EA
	EXISTING POLES	3	EA
	EXISTING POLES (TOP)	0	EA
	TOTAL PROJECT FOOTAGE	728	11

SHEET INDEX

- | | |
|-------|-------------------|
| 1. | COVER PAGE |
| 2. | PLAN OVERVIEW |
| 3-43. | PLAN VIEWS (1-41) |
| 44. | GENERAL NOTE |
| 45. | TRAFFIC CONTROL |

SHEET NO: 1 OF 45	DATE : 08/18/2025
-------------------	-------------------

ASPEN UTILITY IS RESPONSIBLE FOR PLACING THE CONDUIT IN THE WALKER COUNTY ROW

ACCORDING TO MAP NO. 48471C0525D, 48471C0525D OF THE
FEDERAL EMERGENCY MANAGEMENT AGENCY'S FLOOD
INSURANCE RATE MAPS FOR WALKER COUNTY
UNINCORPORATED AREAS, DATED 8/16/2011,
THE SUBJECT TRACT IS SITUATED WITHIN: FLOOD
PLAIN ZONE X, UNSHADED

LEGEND

- PROPOSED BORE PIT
- EX. PEDestal
- EX. CIRCULAR TAP PEDESTAL
- PROPOSED CIRCULAR TAP PEDESTAL
- EX. CATV VAULT
- PROPOSED CATV VAULT
- ANCHOR
- WATER METER
- CATV TRENCH ROUTE
- CATV BORE ROUTE
- STORM DRAINAGE
- WATER
- SEWER
- STORM SEWER
- CATV AERIAL ROUTE
- PRIVATE FENCE
- STORM DRAIN INLET
- CATCH BASIN
- STORM MANHOLE
- JOINT USE POLE
- EX. JOINT USE POLE
- JOINT USE POLE WITH TRANSFORMER
- BACK OF CURB
- EDGE OF PAVEMENT
- DRIVEWAY
- RIGHT OF WAY
- AERIAL RISER

WALKER COUNTY

PUBLIC WORKS DEPARTMENT

FOR THE USE OF THE WALKER COUNTY ENGINEERING DEPARTMENT

1. COVER PAGE


2. PLAN OVERVIEW

3-43. PLAN VIEWS (1-41)

44. GENERAL NOTE

45. TRAFFIC CONTROL

RECEIVED
SEP 02 2025
BY:

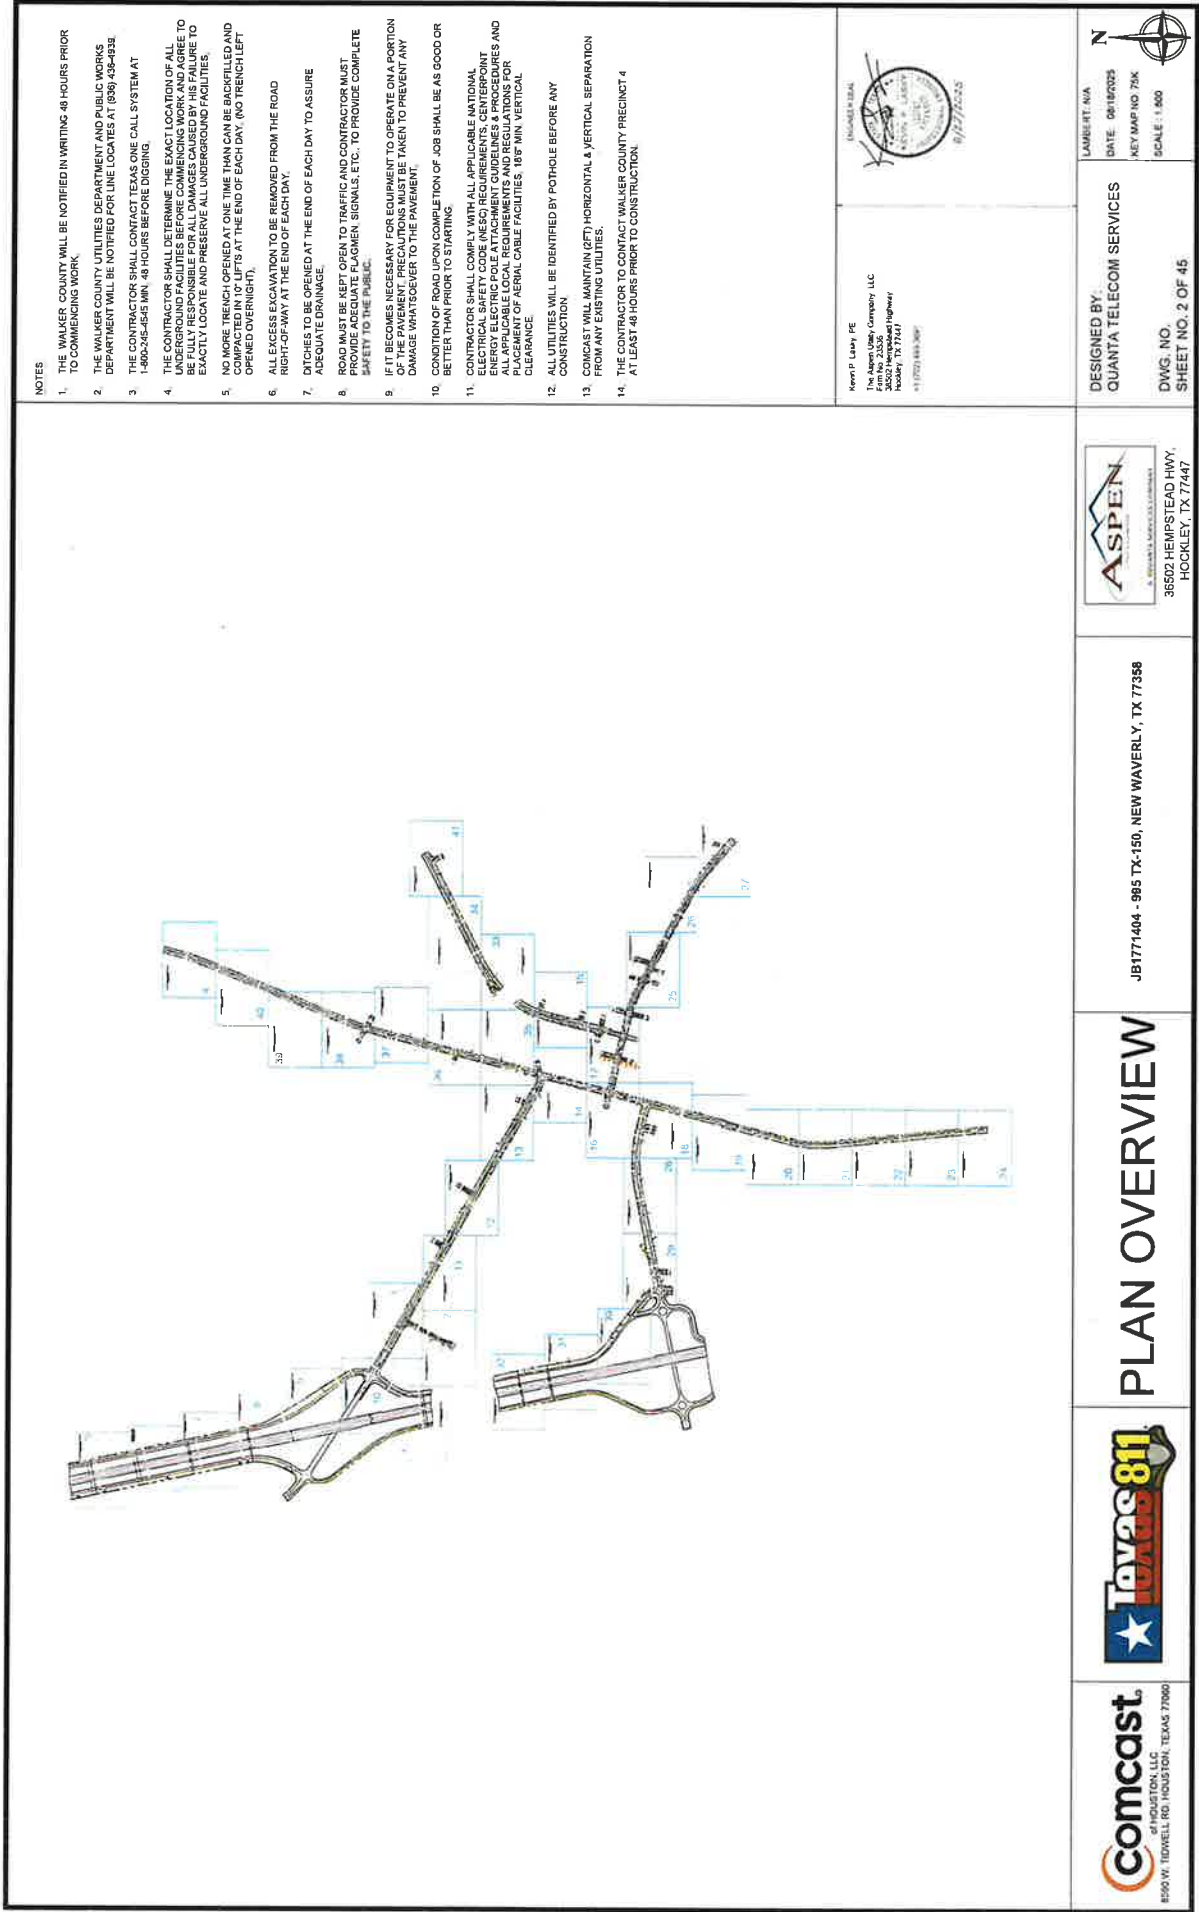


JB1771404 - 995 TX-150, NEW WAVERLY, TX 77358

PLAN VIEW 01 OF 41



ROAD BORE DETAIL

SCALE: NTS

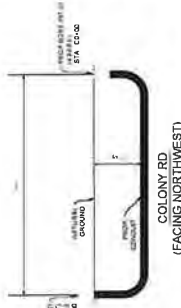

DIRECTIONAL BORE DETAIL

SCALE: NTS

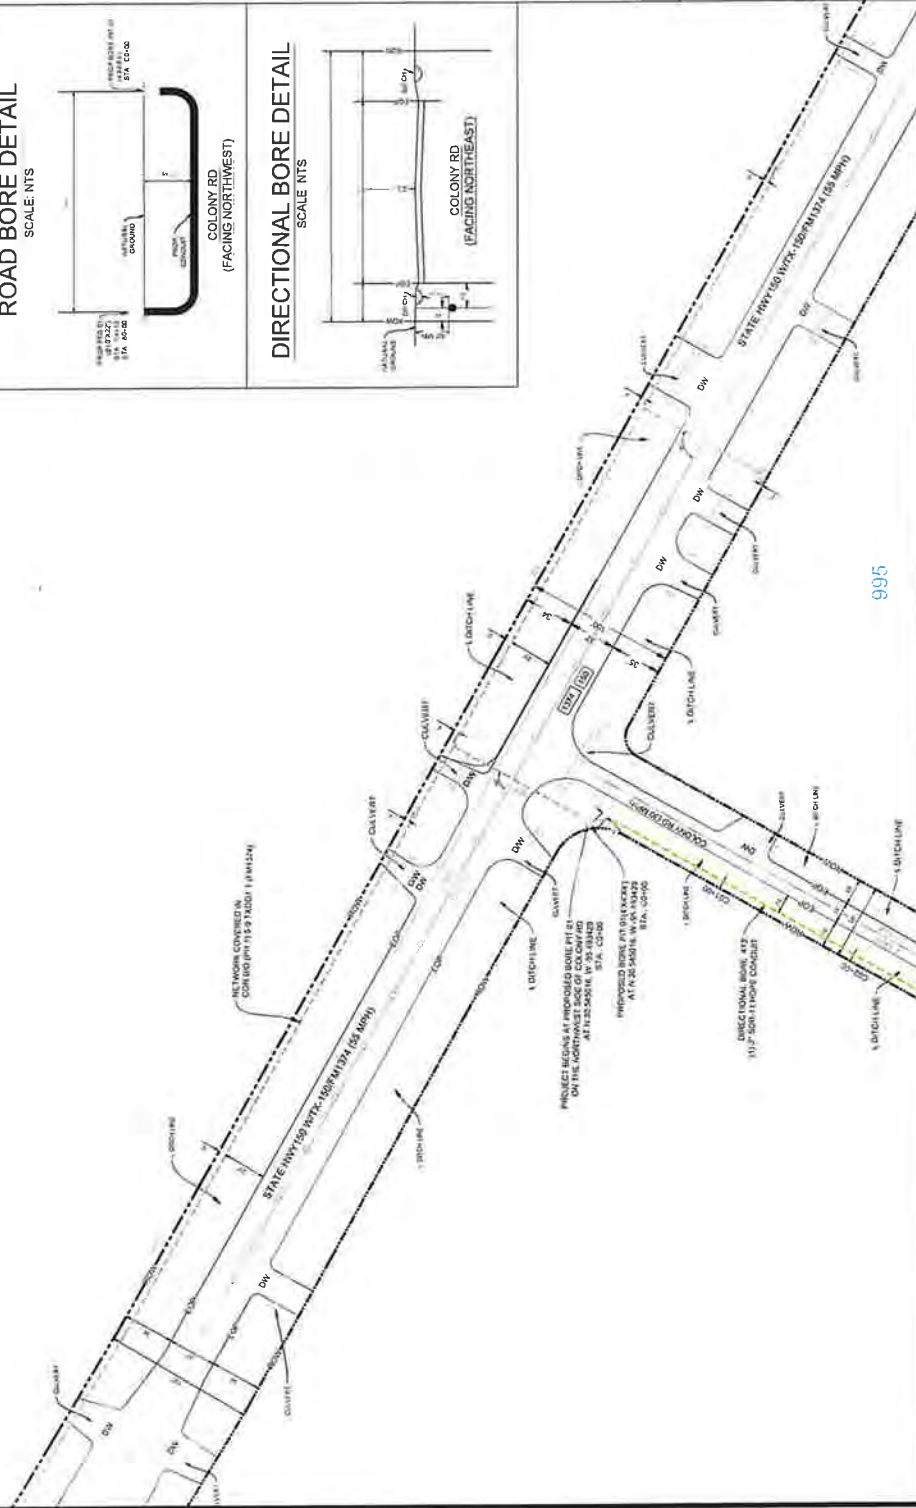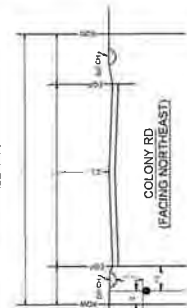

NOTES

1. THE WALKER COUNTY WILL BE NOTIFIED IN WRITING 48 HOURS PRIOR TO COMMENCING WORK.
2. THE WALKER COUNTY UTILITIES DEPARTMENT AND PUBLIC WORKS DEPARTMENT WILL BE NOTIFIED FOR LINE LOCATES AT (936) 436-4939.
3. THE CONTRACTOR SHALL CONTACT TEXAS ONE CALL SYSTEM AT 1-800-345-4545 MIN. 48 HOURS BEFORE DIGGING.
4. THE CONTRACTOR SHALL DETERMINE THE EXACT LOCATION OF ALL UNDERGROUND FACILITIES BEFORE COMMENCING WORK AND AGREE TO BE FULLY RESPONSIBLE FOR ALL DAMAGES CAUSED BY HIS FAILURE TO EXACTLY LOCATE AND PRESERVE ALL UNDERGROUND FACILITIES.
5. NO MORE TRENCH OPENED AT ONE TIME THAN CAN BE BACKFILLED AND COMPACTED WITHIN 24 HOURS AT THE END OF EACH DAY. (NO TRENCH LEFT OPENED OVERNIGHT).
6. ALL EXCESS EXCAVATION TO BE REMOVED FROM THE ROAD RIGHT-OF-WAY AT THE END OF EACH DAY.
7. DITCHES TO BE OPENED AT THE END OF EACH DAY TO ASSURE ADEQUATE DRAINAGE.
8. ROAD MUST BE KEPT OPEN TO TRAFFIC AND CONTRACTOR MUST PROVIDE ADEQUATE FLAGMEN, SIGNALS, ETC. TO PROVIDE COMPLETE SAFETY TO THE PUBLIC.
9. IF IT BECOMES NECESSARY FOR EQUIPMENT TO OPERATE ON A PORTION OF THE PAVEMENT, PRECAUTIONS MUST BE TAKEN TO PREVENT ANY DAMAGE WHATSOEVER TO THE PAVEMENT.
10. CONDITION OF ROAD UPON COMPLETION OF JOB SHALL BE AS GOOD OR BETTER THAN PRIOR TO STARTING.
11. CONTRACTOR SHALL COMPLY WITH ALL APPLICABLE NATIONAL ELECTRICAL SAFETY CODE (NEC) REQUIREMENTS, CENTERPOINT ENERGY ELECTRIC POLE ATTACHMENT GUIDELINES & PROCEDURES AND ALL OTHER REQUIREMENTS FOR THE PROTECTION OF ALL UTILITIES. THE CONTRACTOR SHALL MAINTAIN A MINIMUM 18" MIN. VERTICAL CLEARANCE.
12. ALL UTILITIES WILL BE IDENTIFIED BY POT-HOLE BEFORE ANY CONSTRUCTION.
13. COMCAST WILL MAINTAIN (GTT) HORIZONTAL & VERTICAL SEPARATION FROM ANY EXISTING UTILITIES.
14. THE CONTRACTOR TO CONTACT WALKER COUNTY PRECINCT #4 AT LEAST 48 HOURS PRIOR TO CONSTRUCTION.

New P. Leary PE
The Aspen Utility Company, LLC
P.O. Box 2336
Hockley, TX 77447
(281) 441-1800



DESIGNED BY:
QUANTA TELECOM SERVICES

DWG. NO.
SHEET NO. 3 OF 45


LAMBERT: N/A
DATE: 08/16/2023
KEY MAP NO. 75K
SCALE: 1:40



JB1771404 - 995 TX-150, NEW WAVERLY, TX 77358

COMCAST PROPOSES TO INSTALL FIBER OPTIC CABLE
COMCAST PROPOSES TO PLACE DIRECTIONAL BORE 210 FT TO INSTALL FIBER
OPTIC CABLE TO PROVIDE SERVICE TO 995 TX-150, NEW WAVERLY, TX 77358,
INSIDE THE ROW OF THE WALKER COUNTY, TX.
TOTAL PROJECT FOOTAGE: 710'



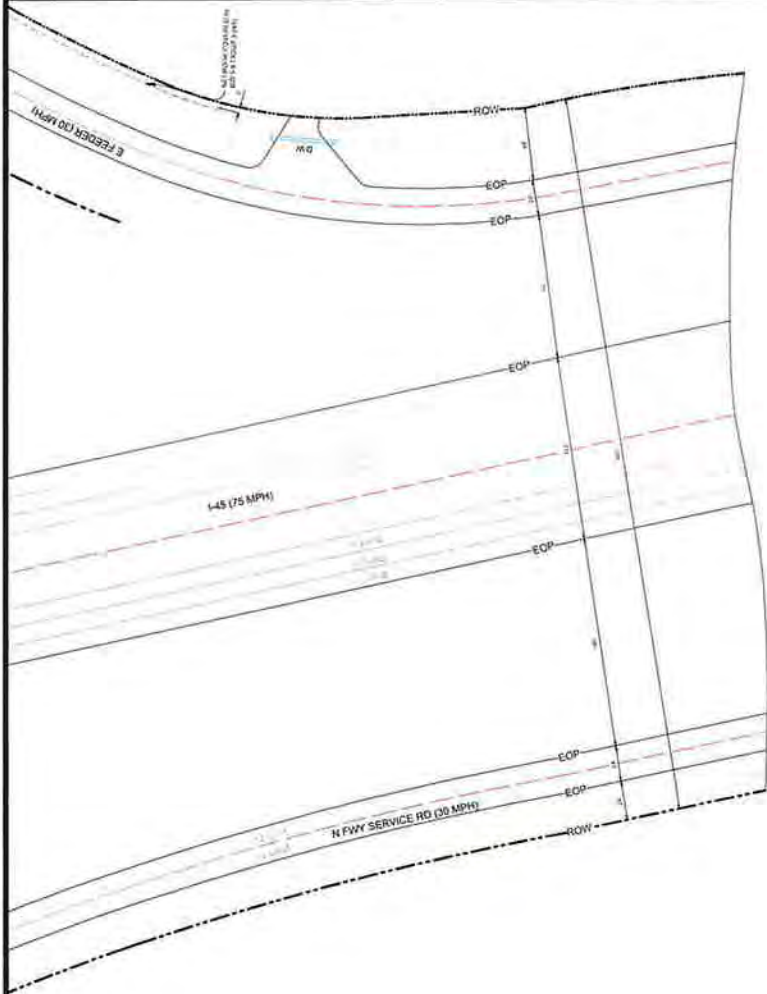


JB1771404 - 995 TX-150, NEW WAVERLY, TX 77358
PLAN VIEW 03 OF 41

NOTES:

1. THE WALKER COUNTY WILL BE NOTIFIED IN WRITING 48 HOURS PRIOR TO COMMENCING WORK.
2. THE WALKER COUNTY UTILITIES DEPARTMENT AND PUBLIC WORKS DEPARTMENT WILL BE NOTIFIED FOR LINE LOCATES AT (936) 436-4929.
3. THE CONTRACTOR SHALL CONTACT TEXAS ONE CALL AT (800) 455-4545, 48 HOURS BEFORE DIGGING.
4. THE CONTRACTOR SHALL DETERMINE THE EXACT LOCATION OF ALL UNDERGROUND FACILITIES BEFORE COMMENCING WORK AND AGREE TO BE FULLY RESPONSIBLE FOR ALL DAMAGES CAUSED BY HIS FAILURE TO EXACTLY LOCATE AND PRESERVE ALL UNDERGROUND FACILITIES.
5. NO MORE TRENCH OPENED AT ONE TIME THAN CAN BE BACKFILLED AND COMPACTED IN 10' LIFTS AT THE END OF EACH DAY (NO TRENCH LEFT OPENED OVERNIGHT).
6. ALL EXCESS EXCAVATION TO BE REMOVED FROM THE ROAD RIGHT-OF-WAY AT THE END OF EACH DAY.
7. DITCHES TO BE OPENED AT THE END OF EACH DAY TO ASSURE ADEQUATE DRAINAGE.
8. ROAD MUST BE KEPT OPEN TO TRAFFIC AND CONTRACTOR MUST PROVIDE ADEQUATE FLAGMEN, SIGNALS, ETC., TO PROVIDE COMPLETE SAFETY TO THE PUBLIC.
9. IF IT BECOMES NECESSARY FOR EQUIPMENT TO OPERATE ON A PORTION OF THE PAVEMENT, PRECAUTIONS MUST BE TAKEN TO PREVENT ANY DAMAGE WHATSOEVER TO THE PAVEMENT.
10. CONDITION OF ROAD UPON COMPLETION OF JOB SHALL BE AS GOOD OR BETTER THAN PRIOR TO STARTING.
11. CONTRACTOR SHALL COMPLY WITH ALL APPLICABLE NATIONAL ELECTRICAL SAFETY CODE (NEC) REQUIREMENTS, CENTERPOINT ENERGY ELECTRIC POLE ATTACHMENT GUIDELINES & PROCEDURES AND ALL OTHER REQUIREMENTS AND PROCEDURES FOR THE PROTECTION OF PLACEMENT OF AERIAL CABLE FACILITIES. 18" MIN. VERTICAL CLEARANCE.
12. ALL UTILITIES WILL BE IDENTIFIED BY POT-HOLE BEFORE ANY CONSTRUCTION.
13. COMCAST WILL MAINTAIN (8FT) HORIZONTAL & VERTICAL SEPARATION FROM ANY EXISTING UTILITIES.
14. THE CONTRACTOR TO CONTACT WALKER COUNTY PRECINCT 4 AT LEAST 48 HOURS PRIOR TO CONSTRUCTION.

Kevin P. Lundy PE
The Aspen Utility Company, LLC
Firm No. 22536
36502 Hempstead Highway
Hockley, TX 77447
(281) 702-4813/509

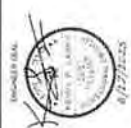

COMCAST PROPOSES TO INSTALL FIBER OPTIC CABLE
COMCAST PROPOSES TO PLACE DIRECTIONAL BORE 710 FT TO INSTALL FIBER OPTIC CABLE TO PROVIDE SERVICE TO 995 TX-150, NEW WAVERLY, TX 77358.
INSIDE THE ROW OF THE WALKER COUNTY, TX
TOTAL PROJECT FOOTAGE: 710'

JB1771404 - 995 TX-150, NEW WAVERLY, TX 77358



DESIGNED BY:
QUANTA TELECOM SERVICES
DWG. NO.
SHEET NO. 5 OF 45

DESIGNED BY:
QUANTA TELECOM SERVICES
DATE: 08/16/2025
KEY MAP NO. 75K
SCALE: 1"=40'



NOTES

1. THE WALKER COUNTY WILL BE NOTIFIED IN WRITING 48 HOURS PRIOR TO COMMENCING WORK.
2. THE WALKER COUNTY UTILITIES DEPARTMENT AND PUBLIC WORKS DEPARTMENT WILL BE NOTIFIED FOR LINE LOCATES AT (936) 438-4899.
3. THE CONTRACTOR SHALL CONTACT TEXAS ONE CALL SYSTEM AT 1-800-245-4545 MIN. 48 HOURS BEFORE DIGGING.
4. THE CONTRACTOR SHALL DETERMINE THE EXACT LOCATION OF ALL UNDERGROUND FACILITIES BEFORE COMMENCING WORK AND AGREE TO BE FULLY RESPONSIBLE FOR ALL DAMAGES CAUSED BY HIS FAILURE TO EXACTLY LOCATE AND PRESERVE ALL UNDERGROUND FACILITIES.
5. NO MORE TRENCH OPENED AT ONE TIME THAN CAN BE BACKFILLED AND COMPLETED WITHIN THE SAME DAY AT THE END OF EACH DAY. (NO TRENCH LEFT OPENED OVERNIGHT).
6. ALL EXCESS EXCAVATION TO BE REMOVED FROM THE ROAD RIGHT-OF-WAY AT THE END OF EACH DAY.
7. DITCHES TO BE OPENED AT THE END OF EACH DAY TO ASSURE ADEQUATE DRAINAGE.
8. ROAD MUST BE KEPT OPEN TO TRAFFIC AND CONTRACTOR MUST PROVIDE ADEQUATE FLAGMEN, SIGNALS, ETC., TO PROVIDE COMPLETE SAFETY TO THE PUBLIC.
9. IF IT BECOMES NECESSARY FOR EQUIPMENT TO OPERATE ON A PORTION OF THE PAVEMENT, PRECAUTIONS MUST BE TAKEN TO PREVENT ANY DAMAGE WHATSOEVER TO THE PAVEMENT.
10. CONDITION OF ROAD UPON COMPLETION OF JOB SHALL BE AS GOOD OR BETTER THAN PRIOR TO STARTING.
11. CONTRACTOR SHALL COMPLY WITH ALL APPLICABLE NATIONAL ELECTRICAL SAFETY CODE (NEC) REQUIREMENTS, CENTERPOINT ENERGY, TEXAS ONE CALL, AND ALL APPLICABLE LOCAL REQUIREMENTS AND REGULATIONS FOR PLACEMENT OF AERIAL CABLE FACILITIES. 18" MIN. VERTICAL CLEARANCE.
12. ALL UTILITIES WILL BE IDENTIFIED BY POTHOLE BEFORE ANY CONSTRUCTION.
13. CONCAST WILL MAINTAIN (DFT) HORIZONTAL & VERTICAL SEPARATION FROM ANY EXISTING UTILITIES.
14. THE CONTRACTOR TO CONTACT WALKER COUNTY PRECINCT 4 AT LEAST 48 HOURS PRIOR TO CONSTRUCTION.

Mark P. Luby PE
The Aspen Utility Company, LLC
35502 Hempstead Highway
Hockley, TX 77447
(817) 443-3891

DESIGNED BY:
QUANTA TELECOM SERVICES

DWG. NO.
SHEET NO. 6 OF 45

LAURENT N/A
DATE: 08/18/2023
KEY MAP NO. 71K
SCALE: 1"=40'

JB1771404 - 995 TX-150, NEW WAVERLY, TX 77358
PLAN VIEW 4 OF 41

JB1771404 - 995 TX-150, NEW WAVERLY, TX 77358

CONCAST PROPOSES TO INSTALL FIBER OPTIC CABLE
CONCAST PROPOSES TO PLACE DIRECTIONAL BORE 710 FT TO INSTALL FIBER OPTIC CABLE INSIDE THE ROW OF THE WALKER COUNTY, TX.
TOTAL PROJECT FOOTAGE: 710'

PLAN VIEW 05 OF 41



1. THE WALKER COUNTY WILL BE NOTIFIED IN WRITING 48 HOURS PRIOR TO COMMENCING WORK.
2. THE WALKER COUNTY UTILITIES DEPARTMENT, AND PUBLIC WORKS DEPARTMENT WILL BE NOTIFIED FOR UNLOCATES AT 430-432-4303.
3. THE CONTRACTOR SHALL CONTACT TEXAS ONE CALL SYSTEM AT 1-800-368-5848, 4 HOURS BEFORE CONSTRUCTION.
4. THE CONTRACTOR SHALL DETERMINE THE EXACT LOCATION OF ALL UTILITIES AND MARK THEM WITH FLAGGING AND SURVEYING TO BE FULLY RESPONSIBLE FOR ALL DAMAGES CAUSED BY HIS FAILURE TO EXACTLY LOCATE AND PRESERVE ALL UNDERGROUND FACILITIES.
5. NO MORE TRENCH OPENED AT ONE TIME THAN CAN BE BACKFILLED AND COMPACTED IN 10 DAYS AT THE END OF EACH DAY, NO TRENCH LEFT OPENED OVERNIGHT.
6. ALL EXCESS EXCAVATION TO BE REMOVED FROM THE ROAD RIGHT-OF-WAY AT THE END OF EACH DAY.
7. DITCHES TO BE OPENED AT THE END OF EACH DAY TO ASSURE ADEQUATE DRAINAGE.
8. ROAD MUST BE KEPT OPEN TO TRAFFIC AND CONTRACTOR MUST PROVIDE ADEQUATE FLAGMEN, SIGNALS, ETC., TO PROVIDE COMPLETE SAFETY TO THE PUBLIC.
9. IF IT BECOMES NECESSARY FOR EQUIPMENT TO TAKE ON A PORTION OF THE PAVEMENT, PRECAUTIONS MUST BE TAKEN TO PREVENT ANY DAMAGE WHATSOEVER TO THE PAVEMENT.
10. CONDITION OF ROAD UPON COMPLETION OF JOB SHALL BE AS GOOD OR BETTER THAN PRIOR TO STARTING.
11. CONTRACTOR SHALL COMPLY WITH ALL APPLICABLE NATIONAL, ELECTRICAL SAFETY CODE (NEC) REQUIREMENTS, CERTIFICENT AND ALL APPLICABLE LOCAL REQUIREMENTS AND REGULATIONS FOR PLACEMENT OF FERRAL CABLE FACILITIES, 18" MIN. VERTICAL CLEARANCE.
12. ALL UTILITIES WILL BE IDENTIFIED BY POT HOLE BEFORE ANY CONSTRUCTION.
13. CONCAST WILL MAINTAIN (2FT) HORIZONTAL & VERTICAL SEPARATION FROM ANY EXISTING UTILITIES.
14. THE CONTRACTOR TO CONTACT WALKER COUNTY PRECINCT # 4 AT LEAST 48 HOURS PRIOR TO CONSTRUCTION.

6/27/2025

AMBERT: N/A
DATE: 08/18/2025
KEY MAP NO 75K
SCALE: 1:40


36502 HEMPSTEAD HWY,
HOCKLEY, TX 77447

COMCAST PROPOSES TO INSTALL FIBER OPTIC CABLE
COMCAST PROPOSES TO PLACE DIRECTIONAL BORE 710 FT TO INSTALL
OPTIC CABLE TO PROVIDE SERVICE TO 995 TX-150, NEW WAVERLY,
INSIDE THE ROW OF THE WALKER COUNTY, TX.



RECEIVED
SEP 02 2025
BY:

JB1771404 - 995 TX-150
NEW WAVERLY, TX 77358
PLAN VIEW 06 OF 41

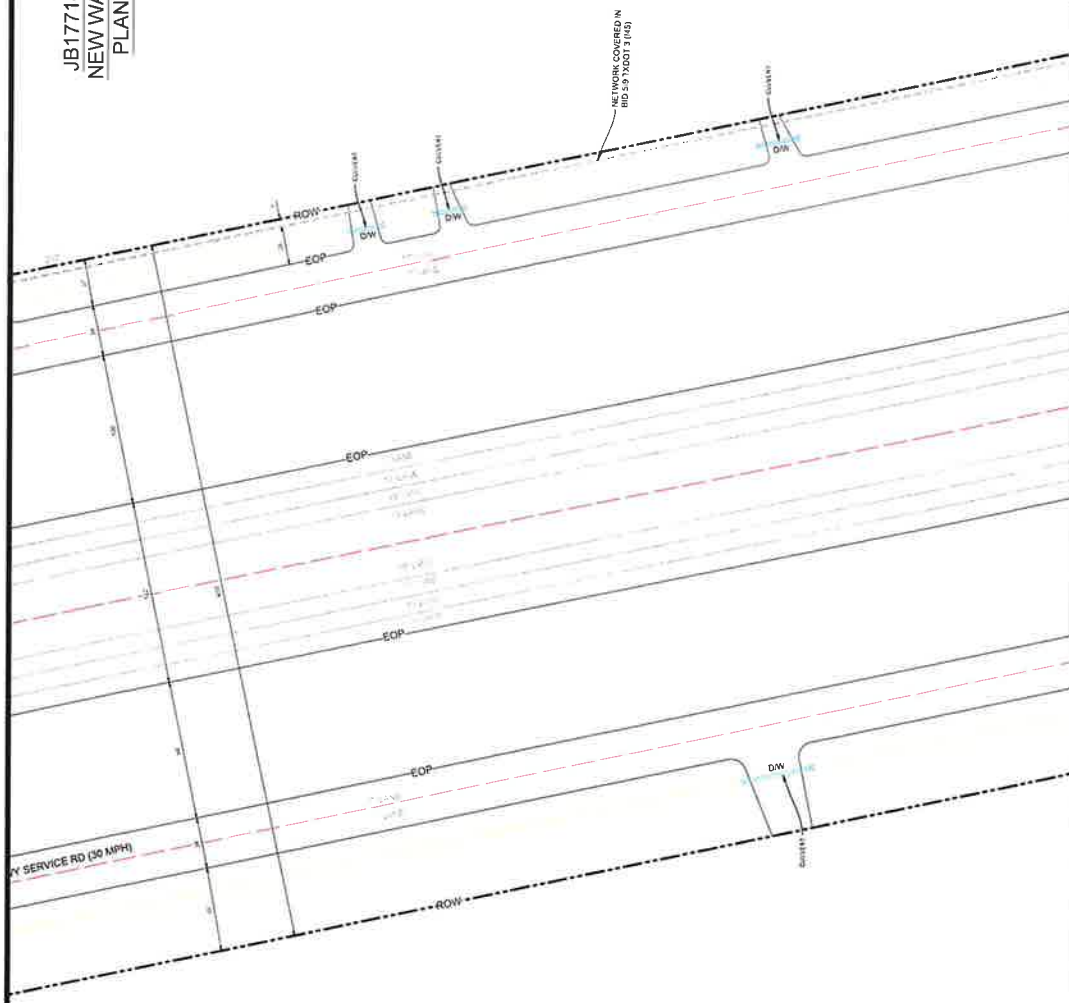

NOTES

1. THE WALKER COUNTY WILL BE NOTIFIED IN WRITING 48 HOURS PRIOR TO COMMENCING WORK.
2. THE WALKER COUNTY UTILITIES DEPARTMENT AND PUBLIC WORKS DEPARTMENT WILL BE NOTIFIED FOR LINE LOCATES AT (505) 496-0939.
3. THE CONTRACTOR SHALL CONTACT TEXAS ONE CALL SYSTEM AT 1-800-255-4545 MIN. 48 HOURS BEFORE DIGGING.
4. THE CONTRACTOR SHALL DETERMINE THE EXACT LOCATION OF ALL UNDERGROUND FACILITIES BEFORE COMMENCING WORK AND AGREE TO FULLY RESPONSIBLE FOR ALL DAMAGES CAUSED BY HIS FAILURE TO EXACTLY LOCATE AND PRESERVE ALL UNDERGROUND FACILITIES.
5. NO MORE TRENCH OPENED AT ONE TIME THAT CAN BE BACKFILLED AND RECLOSED WITHIN 24 HOURS AT THE END OF EACH DAY. (NO TRENCH LEFT OPENED OVERNIGHT).
6. ALL EXCESS EXCAVATION TO BE REMOVED FROM THE ROAD RIGHT-OF-WAY AT THE END OF EACH DAY.
7. DITCHES TO BE OPENED AT THE END OF EACH DAY TO ASSURE ADEQUATE DRAINAGE.
8. ROAD MUST BE KEPT OPEN TO TRAFFIC AND CONTRACTOR MUST PROVIDE ADEQUATE FLAGMEN, SIGNALS, ETC., TO PROVIDE COMPLETE SAFETY TO THE PUBLIC.
9. IF IT BECOMES NECESSARY FOR EQUIPMENT TO OPERATE ON A PORTION OF THE PAVEMENT, PRECAUTIONS MUST BE TAKEN TO PREVENT ANY DAMAGE WHATSOEVER TO THE PAVEMENT.
10. CONDITION OF ROAD UPON COMPLETION OF JOB SHALL BE AS GOOD OR BETTER THAN PRIOR TO STARTING.
11. CONTRACTOR SHALL COMPLY WITH ALL APPLICABLE NATIONAL ELECTRICAL SAFETY CODE (NEC) REQUIREMENTS, CENTERPOINT UTILITY REGULATIONS, TEXAS PUBLIC UTILITY REGULATIONS AND ALL APPLICABLE LOCAL REQUIREMENTS AND REGULATIONS FOR PLACEMENT OF AERIAL CABLE FACILITIES, 18" MIN. VERTICAL CLEARANCE.
12. ALL UTILITIES WILL BE IDENTIFIED BY POTHOLE BEFORE ANY CONSTRUCTION.
13. COMCAST WILL MAINTAIN 6FT HORIZONTAL & VERTICAL SEPARATION FROM ANY EXISTING UTILITIES.
14. THE CONTRACTOR TO CONTACT WALKER COUNTY PRECINCT 4 AT LEAST 48 HOURS PRIOR TO CONSTRUCTION.

Kevin P. Leary, PE
The Aspen Utility Company, LLC
10000 Highway 100
Hockley, TX 77447
+1 (281) 483-2667




COMCAST PROPOSES TO INSTALL FIBER OPTIC CABLE
COMCAST PROPOSES TO PLACE DIRECTIONAL BORE 710 FT TO INSTALL FIBER OPTIC CABLE TO PROVIDE SERVICE TO 995 TX-150, NEW WAVERLY, TX 77358, UNDER THE RIGHT OF THE WALKER COUNTY, TX.
TOTAL PROJECT FOOTAGE: 710'

JB1771404 - 995 TX-150, NEW WAVERLY, TX 77358




DESIGNED BY:
QUANTA TELECOM SERVICES
DWG. NO.
SHEET NO. 8 OF 45

 LAMBERT, WA
DATE: 08/16/2025
KEY MAP NO. 75K
SCALE: 1" = 40'



JB1771404 - 995 TX-150, NEW WAVERLY, TX 77358
 PLAN VIEW 07 OF 41

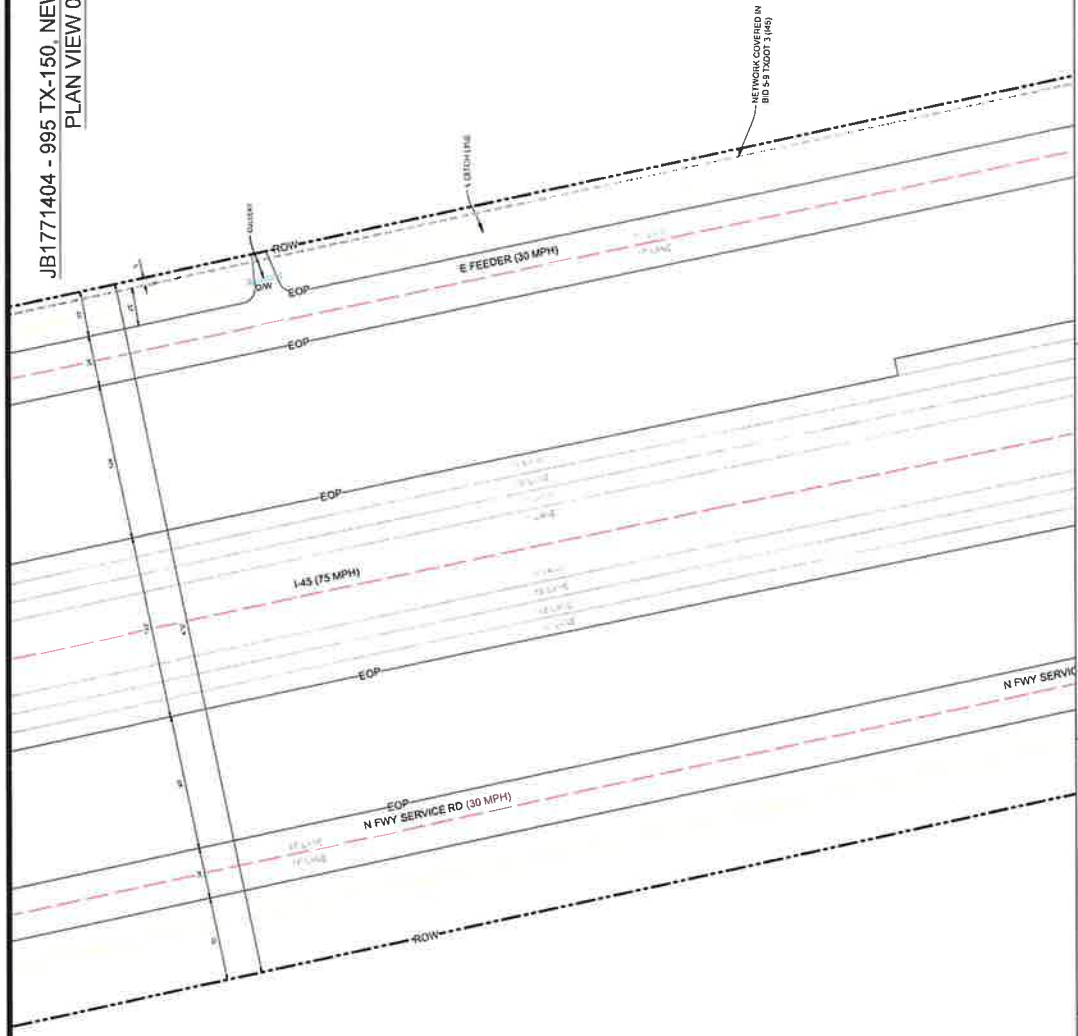

NOTES

1. THE WALKER COUNTY WILL BE NOTIFIED IN WRITING 48 HOURS PRIOR TO COMMENCING WORK.
2. THE WALKER COUNTY UTILITIES DEPARTMENT AND PUBLIC WORKS DEPARTMENT WILL BE NOTIFIED FOR LINE LOCATES AT (936) 456-4939.
3. THE CONTRACTOR SHALL CONTACT TEXAS ONE CALL SYSTEM AT 1-800-245-5545 MIN. 48 HOURS BEFORE DIGGING.
4. THE CONTRACTOR SHALL DETERMINE THE EXACT LOCATION OF ALL UNDERGROUND FACILITIES BEFORE COMMENCING WORK AND AGREE TO BE FULLY RESPONSIBLE FOR ALL DAMAGES CAUSED BY HIS FAILURE TO EXACTLY LOCATE AND PRESERVE ALL UNDERGROUND FACILITIES.
5. NO MORE TRENCH OPENED AT ONE TIME THAN CAN BE BACKFILLED AND COMPACTED IN 10' LIFTS AT THE END OF EACH DAY. (NO TRENCH LEFT OPENED OVERNIGHT).
6. ALL EXCESS EXCAVATION TO BE REMOVED FROM THE ROAD RIGHT-OF-WAY AT THE END OF EACH DAY.
7. DITCHES TO BE OPENED AT THE END OF EACH DAY TO ASSURE ADEQUATE DRAINAGE.
8. ROAD MUST BE KEPT OPEN TO TRAFFIC AND CONTRACTOR MUST PROVIDE ADEQUATE FLAGMEN, SIGNALS, ETC. TO PROVIDE COMPLETE SAFETY TO THE PUBLIC.
9. IF IT BECOMES NECESSARY FOR EQUIPMENT TO OPERATE ON A PORTION OF THE PAVEMENT, PRECAUTIONS MUST BE TAKEN TO PREVENT ANY DAMAGE WHATSOEVER TO THE PAVEMENT.
10. CONDITION OF ROAD UPON COMPLETION OF JOB SHALL BE AS GOOD OR BETTER THAN PRIOR TO STARTING.
11. CONTRACTOR SHALL COMPLY WITH ALL APPLICABLE NATIONAL ELECTRICAL SAFETY CODE (NEC) REQUIREMENTS, CENTERPOINT ENERGY ELECTRIC POLE ATTACHMENT GUIDELINES & PROCEDURES AND ALL APPLICABLE TEXAS REGULATIONS AND ORDINANCES FOR THE PLACEMENT OF AERIAL CABLE FACILITIES. 18' MIN. VERTICAL CLEARANCE.
12. ALL UTILITIES WILL BE IDENTIFIED BY POT HOLE BEFORE ANY CONSTRUCTION.
13. COMCAST WILL MAINTAIN (2FT) HORIZONTAL & VERTICAL SEPARATION FROM ANY EXISTING UTILITIES.
14. THE CONTRACTOR TO CONTACT WALKER COUNTY PRECINCT 4 AT LEAST 48 HOURS PRIOR TO CONSTRUCTION.

Kevin P. Lundy, PE
 The Aspen Group, LLC
 1000 W. 22nd St.
 Suite 100
 Houston, TX 77002
 11/2021/0012409



DESIGNED BY:
 QUANTA TELECOM SERVICES

DWG. NO.
 SHEET NO. 9 OF 45

LAMBERT: N/A
 DATE: 08/18/2025
 KEY MAP NO. 754
 SCALE: 1" = 40'




JB1771404 - 995 TX-150, NEW WAVERLY, TX 77358

COMCAST PROPOSES TO INSTALL FIBER OPTIC CABLE TO PLACE IN THE ROW OF THE WALKER COUNTY, TX. TOTAL PROJECT FOOTAGE: 710'



RECEIVED
SEP 02 2025
BY:

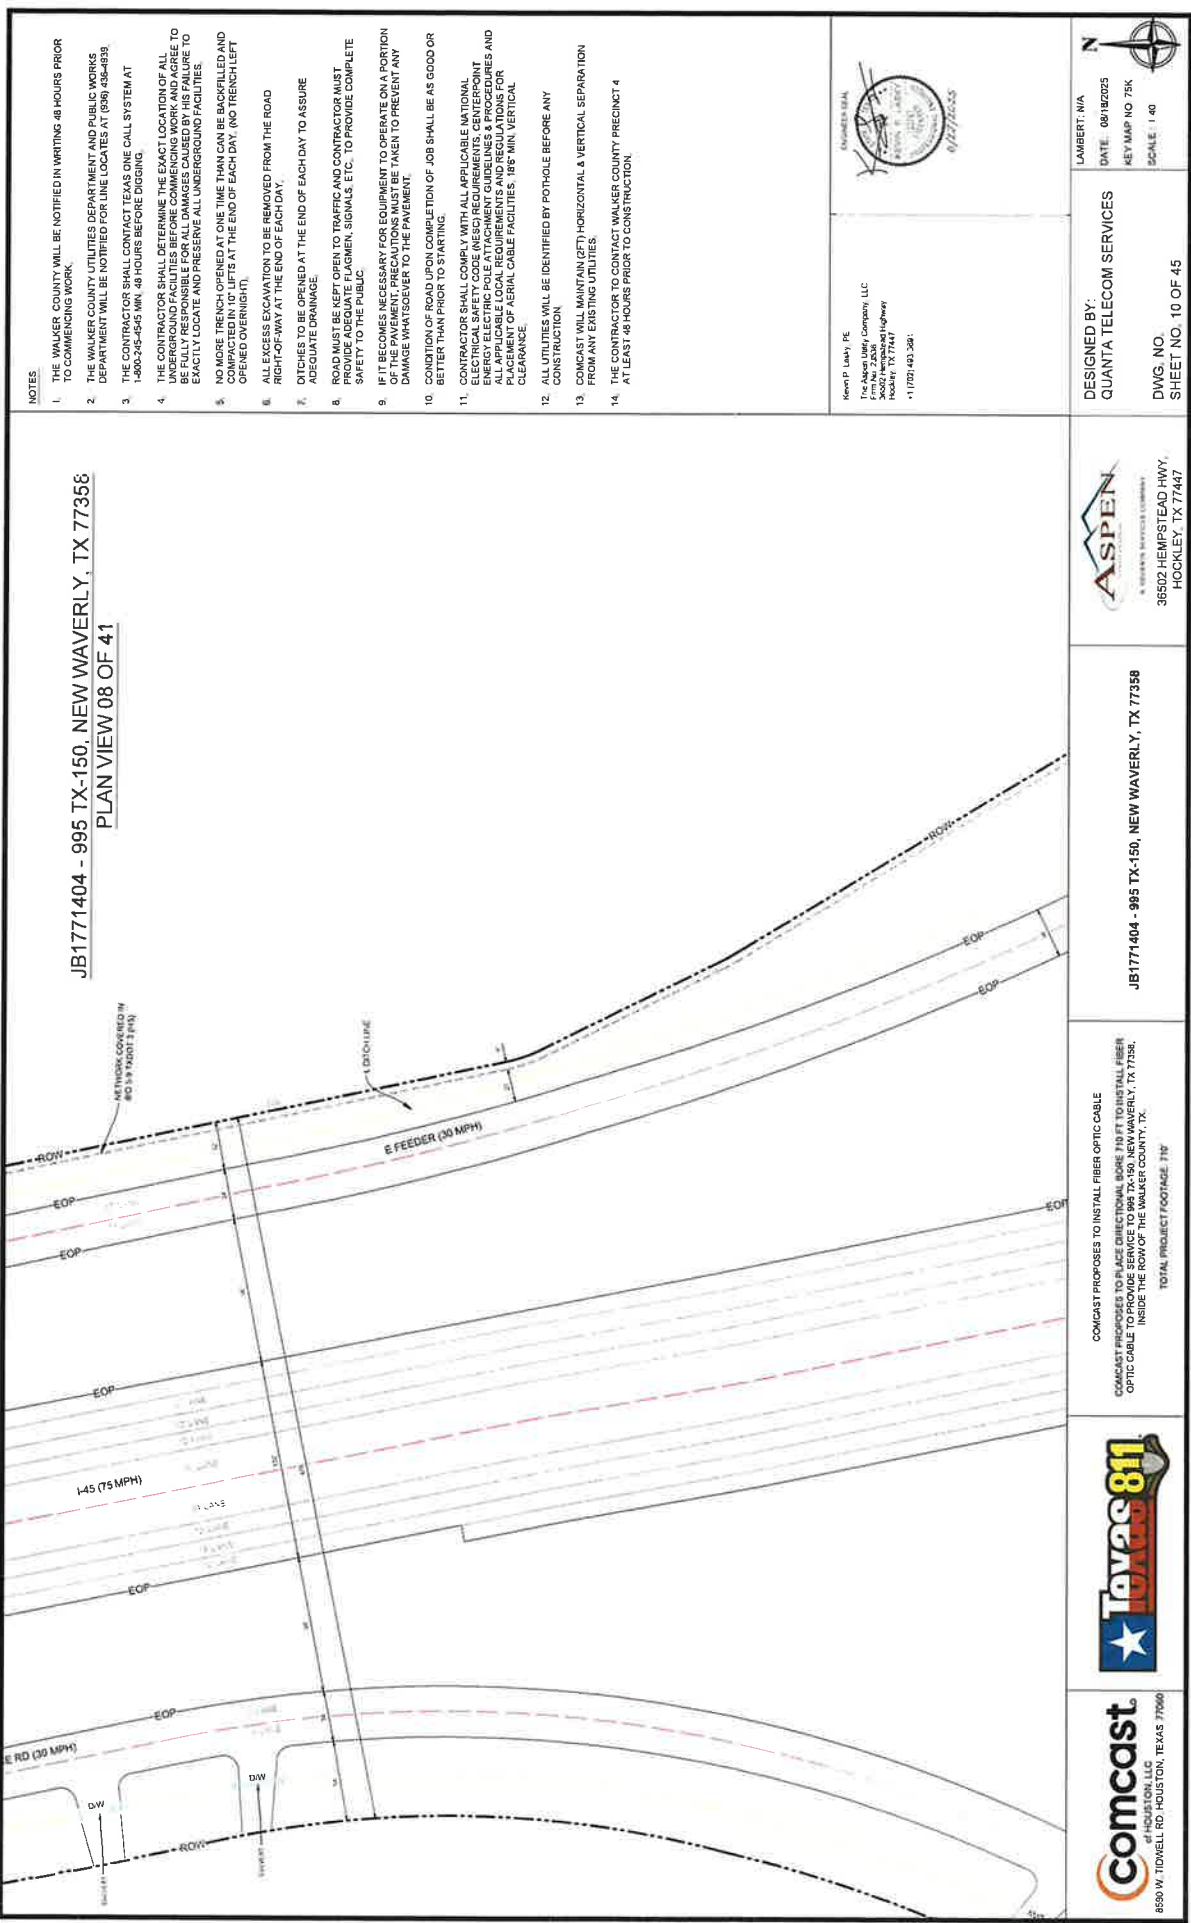

NOTES

1. THE WALKER COUNTY WILL BE NOTIFIED IN WRITING 48 HOURS PRIOR TO COMMENCING WORK.
2. THE WALKER COUNTY UTILITIES DEPARTMENT AND PUBLIC WORKS DEPARTMENT WILL BE NOTIFIED FOR LINE LOCATES AT (936) 434-8339.
3. THE CONTRACTOR SHALL CONTACT TEXAS ONE CALL SYSTEM AT 1-800-245-4545 MIN. 48 HOURS BEFORE DIGGING.
4. THE CONTRACTOR SHALL DETERMINE THE EXACT LOCATION OF ALL UNDERGROUND FACILITIES BEFORE COMMENCING WORK AND AGREE TO BE FULLY RESPONSIBLE FOR ALL DAMAGES CAUSED BY HIS FAILURE TO EXACTLY LOCATE AND PRESERVE ALL UNDERGROUND FACILITIES.
5. NO MORE TRENCH OPENED AT ONE TIME THAN CAN BE BACKFILLED AND COMPACTED IN 10' LIFTS AT THE END OF EACH DAY. (NO TRENCH LEFT OPENED OVERNIGHT).
6. ALL EXCESS EXCAVATION TO BE REMOVED FROM THE ROAD RIGHT-OF-WAY AT THE END OF EACH DAY.
7. DITCHES TO BE OPENED AT THE END OF EACH DAY TO ASSURE ADEQUATE DRAINAGE.
8. ROAD MUST BE KEPT OPEN TO TRAFFIC AND CONTRACTOR MUST PROVIDE ADEQUATE FLAGMEN, SIGNALS, ETC. TO PROVIDE COMPLETE SAFETY TO THE PUBLIC.
9. IF IT BECOMES NECESSARY FOR EQUIPMENT TO OPERATE ON A PORTION OF THE PAVEMENT, PRECAUTIONS MUST BE TAKEN TO PREVENT ANY DAMAGE WHATSOEVER TO THE PAVEMENT.
10. CONDITION OF ROAD UPON COMPLETION OF JOB SHALL BE AS GOOD OR BETTER THAN PRIOR TO STARTING.
11. CONTRACTOR SHALL COMPLY WITH ALL APPLICABLE NATIONAL ELECTRICAL SAFETY CODE (NEC) REQUIREMENTS, CENTERPOINT ENERGY ELECTRIC POLE ATTACHMENT GUIDELINES & PROCEDURES AND ALL OTHER APPLICABLE REGULATIONS AND STANDARDS FOR THE PROPER PLACEMENT OF AERIAL CABLE FACILITIES. 18\"/>
12. ALL UTILITIES WILL BE IDENTIFIED BY POT-HOLE BEFORE ANY CONSTRUCTION.
13. COMCAST WILL MAINTAIN (5') HORIZONTAL & VERTICAL SEPARATION FROM ANY EXISTING UTILITIES.
14. THE CONTRACTOR TO CONTACT WALKER COUNTY PRECINCT 4 AT LEAST 48 HOURS PRIOR TO CONSTRUCTION.

Kevin P. Lasky, P.E.
The Aspen Utility Company, LLC
4101 N. 28th
Hockley, TX 77447
+1 (727) 442-2481



LAURET: N/A
DATE: 08/18/2025
KEY MAP NO 75K
SCALE: 1" = 40'


DESIGNED BY:
QUANTA TELECOM SERVICES
DWG. NO.
SHEET NO. 10 OF 45



JB1771404 - 985 TX-150, NEW WAVERLY, TX 77358

COMCAST PROPOSES TO INSTALL FIBER OPTIC CABLE
COMCAST PROPOSES TO PLACE DIRECTIONAL BORE 210 FT TO INSTALL FIBER OPTIC CABLE TO PROVIDE SERVICE TO 985 TX-150, NEW WAVERLY, TX 77358. INSIDE THE ROW OF THE WALKER COUNTY, TX.
TOTAL PROJECT FOOTAGE: 210'



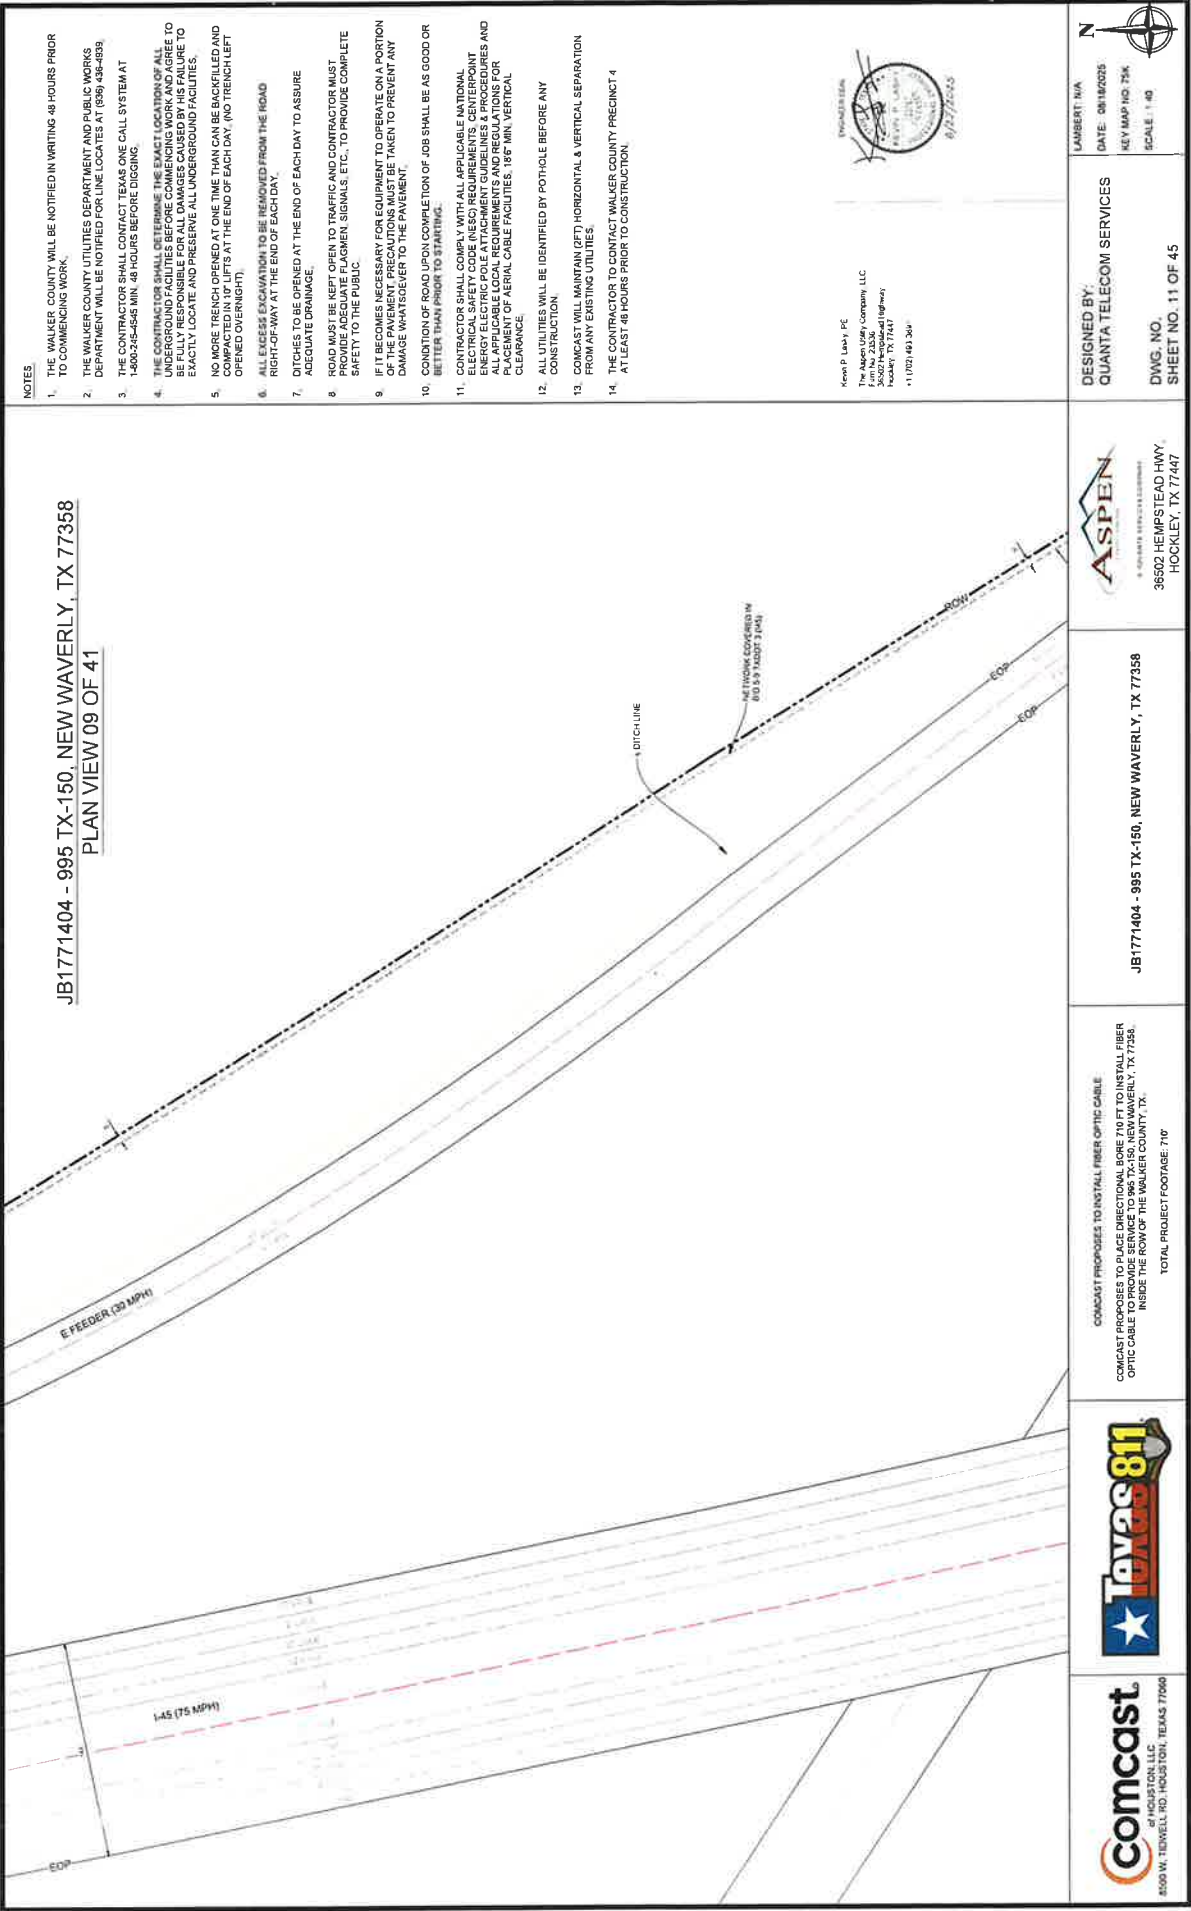


JB1771404 - 995 TX-150, NEW WAVERLY, TX 77358
PLAN VIEW 09 OF 41

NOTES

1. THE WALKER COUNTY WILL BE NOTIFIED IN WRITING 48 HOURS PRIOR TO COMMENCING WORK.
2. THE WALKER COUNTY UTILITIES DEPARTMENT AND PUBLIC WORKS DEPARTMENT WILL BE NOTIFIED FOR LINE LOCATES AT (936) 436-4399.
3. THE CONTRACTOR SHALL CONTACT TEXAS ONE CALL SYSTEM AT 1-800-245-4545 MIN. 48 HOURS BEFORE DIGGING.
4. THE CONTRACTOR SHALL DETERMINE THE EXACT LOCATION OF ALL UNDERGROUND FACILITIES BEFORE COMMENCING WORK AND AGREE TO BE FULLY RESPONSIBLE FOR ALL DAMAGES CAUSED BY HIS FAILURE TO EXACTLY LOCATE AND PRESERVE ALL UNDERGROUND FACILITIES.
5. NO MORE TRENCH OPENED AT ONE TIME THAN CAN BE BACKFILLED AND COMPACTED IN 10' LIFTS AT THE END OF EACH DAY. (NO TRENCH LEFT OPENED OVERNIGHT).
6. ALL EXCESS EXCAVATION TO BE REMOVED FROM THE ROAD RIGHT-OF-WAY AT THE END OF EACH DAY.
7. DITCHES TO BE OPENED AT THE END OF EACH DAY TO ASSURE ADEQUATE DRAINAGE.
8. ROAD MUST BE KEPT OPEN TO TRAFFIC AND CONTRACTOR MUST PROVIDE ADEQUATE FLAGMEN SIGNALS, ETC., TO PROVIDE COMPLETE SAFETY TO THE PUBLIC.
9. IF IT BECOMES NECESSARY FOR EQUIPMENT TO OPERATE ON A PORTION OF THE PAVEMENT, PRECAUTIONS MUST BE TAKEN TO PREVENT ANY DAMAGE WHATSOEVER TO THE PAVEMENT.
10. CONDITION OF ROAD UPON COMPLETION OF JOB SHALL BE AS GOOD OR BETTER THAN PRIOR TO STARTING.
11. CONTRACTOR SHALL COMPLY WITH ALL APPLICABLE NATIONAL ELECTRICAL SAFETY CODE (NEC) REQUIREMENTS, CENTERPOINT ENERGY ELECTRIC POLE ATTACHMENT GUIDELINES & PROCEDURES AND ALL OTHER REQUIREMENTS FOR THE PROPER INSTALLATION AND PLACEMENT OF AERIAL CABLE FACILITIES, 18" MIN. VERTICAL CLEARANCE.
12. ALL UTILITIES WILL BE IDENTIFIED BY POT-HOLE BEFORE ANY CONSTRUCTION.
13. COMCAST WILL MAINTAIN (8FT) HORIZONTAL & VERTICAL SEPARATION FROM ANY EXISTING UTILITIES.
14. THE CONTRACTOR TO CONTACT WALKER COUNTY PRECINCT 4 AT LEAST 48 HOURS PRIOR TO CONSTRUCTION.

Kevin P. Leahy PE
The Aspen Group, Inc.
P.O. Box 23326
Hockley, TX 77447
+1 (281) 463-2344

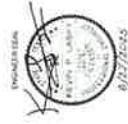

DESIGNED BY:
QUANTA TELECOM SERVICES
DATE: 08/16/2025
KEY MAP NO. 754
SCALE: 1" = 40'

DESIGNED BY:
QUANTA TELECOM SERVICES
DATE: 08/16/2025
KEY MAP NO. 754
SCALE: 1" = 40'

JB1771404 - 995 TX-150, NEW WAVERLY, TX 77358
36502 HEMPSTEAD HWY.
HOCKLEY, TX 77447


COMCAST PROPOSES TO INSTALL FIBER OPTIC CABLE
COMCAST PROPOSES TO PLACE DIRECTIONAL BORE 110' FT TO INSTALL FIBER
OPTIC CABLE TO PROVIDE SERVICE TO 995 TX-150, NEW WAVERLY, TX 77358.
INSIDE THE ROW OF THE WALKER COUNTY, TX.
TOTAL PROJECT FOOTAGE: 710'

COMCAST PROPOSES TO INSTALL FIBER OPTIC CABLE
COMCAST PROPOSES TO PLACE DIRECTIONAL BORE 110' FT TO INSTALL FIBER
OPTIC CABLE TO PROVIDE SERVICE TO 995 TX-150, NEW WAVERLY, TX 77358.
INSIDE THE ROW OF THE WALKER COUNTY, TX.
TOTAL PROJECT FOOTAGE: 710'



BY:



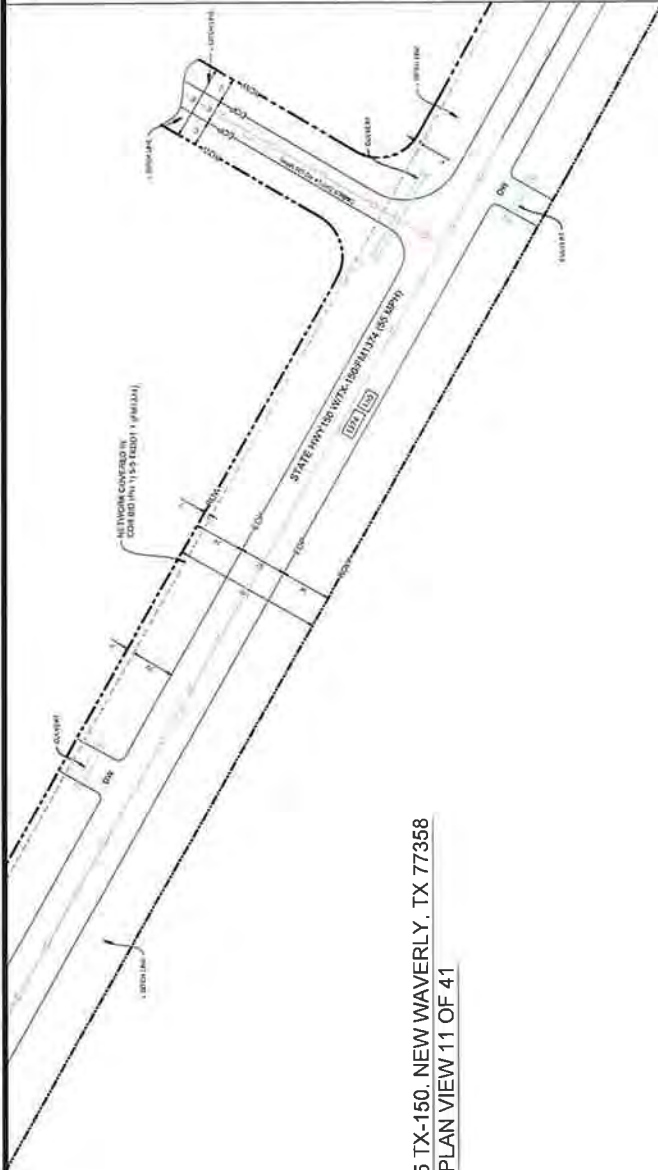

JB1771404 - 995 TX-150, NEW WAVERLY, TX 77358
PLAN VIEW 11 OF 41

- NOTES

- 1 THE WALKER COUNTY WILL BE NOTIFIED IN WRITING 48 HOURS PRIOR TO COMMENCING WORK.
- 2 THE WALKER COUNTY UTILITIES DEPARTMENT AND PUBLIC WORKS DEPARTMENT WILL BE NOTIFIED FOR LINE LOCATES AT (936) 436-4329
- 3 THE CONTRACTOR SHALL CONTACT TEXAS ONE CALL SYSTEM AT 1-800-333-4543 MIN. 48 HOURS BEFORE WORK BEGINS.
- 4 THE CONTRACTOR SHALL DETERMINE THE EXACT LOCATION OF ALL UTILITIES TO BE FULLY RESPONSIBLE FOR ALL DAMAGES CAUSED BY HIS FAILURE TO EXACTLY LOCATE AND PRESERVE ALL UNDERGROUND FACILITIES.
- 5 NO MORE TRENCH OPENED AT ONE TIME THAN CAN BE BACKFILLED AND COMPLETED IN 14 DAYS AT THE END OF EACH DAY (NO TRENCH LEFT OPENED OVERNIGHT)
- 6 ALL EXCESS DCAVATION TO BE REMOVED FROM THE ROAD RIGHT-OF-WAY AT THE END OF EACH DAY
- 7 DITCHES TO BE OPENED AT THE END OF EACH DAY TO ASSURE ADEQUATE DRAINAGE
- 8 ROAD MUST BE KEPT OPEN TO TRAFFIC AND CONTRACTOR MUST PROVIDE ADEQUATE FLAGMEN SIGNALS ETC. TO PROVIDE COMPLETE SAFETY TO THE PUBLIC
- 9 IF IT BECOMES NECESSARY FOR EQUIPMENT TO OPERATE ON A PORTION OF THE PAVEMENT, PRECAUTIONS MUST BE TAKEN TO PREVENT ANY DAMAGE WHATSOEVER TO THE PAVEMENT
- 10 CONDITION OF ROAD UPON COMPLETION OF JOB SHALL BE AS GOOD OR BETTER THAN PRIOR TO STARTING.
- 11 CONTRACTOR SHALL COMPLY WITH ALL APPLICABLE NATIONAL ELECTRICAL SAFETY CODE (NESC) REQUIREMENTS, CENTERPOINT ENERGY ELECTRICAL POLE ATTACHMENT GUIDELINES & PROCEDURES AND ALL OTHER APPLICABLE REGULATIONS AND STANDARDS FOR THE PROPER PLACEMENT OF AERIAL CABLE FACILITIES, 18" MIN VERTICAL CLEARANCE
- 12 ALL UTILITIES WILL BE IDENTIFIED BY POT HOLE BEFORE ANY CONSTRUCTION
- 13 CONTRACT WILL MAINTAIN (GFI) HORIZONTAL & VERTICAL SEPARATION FROM ANY EXISTING UTILITIES
- 14 THE CONTRACTOR TO CONTACT WALKER COUNTY PRECINCT 4 AT LEAST 48 HOURS PRIOR TO CONSTRUCTION

Karen P. Leaky PE
The Aspen Utility Company, LLC
Firm No. 23536
36502 Memorial Highway
Houston, TX 77447
409.572.3636



DESIGNED BY:
QUANTA TELECOM SERVICES

LAMBERT: N/A
DATE: 08/18/22
KEY MAP NO: 7
SCALE: 1 40

DWG. NO. SHEET NO. 13 OF 45



36502 HEMPSTEAD HWY
HOCKLEY, TX 77447

JB1771404 - 995 TX-150, NEW WAVERLY, TX 77358

COMCAST PROPOSES TO INSTALL FIBER OPTIC CABLE
COMCAST PROPOSES TO PLACE DIRECTIONAL BORE 710 FT TO INSTALL FIBER
OPTIC CABLE TO PROVIDE SERVICE TO 985 TX-150, NEW WAVERLY, TX 77558,
INSIDE THE ROW OF THE WALKER COUNTY, TX
TOTAL PROJECT FOOTAGE: 710'



BY:



1. THE WALKER COUNTY WILL BE NOTIFIED IN WRITING 48 HOURS PRIOR TO COMMENCING WORK.

2. THE WALKER COUNTY UTILITIES DEPARTMENT AND PUBLIC WORKS DEPARTMENT WILL BE NOTIFIED FOR UNEL LOCATES AT (936) 434-8339

3. THE CONTRACTOR SHALL CONTACT TEXAS ONE CALL SYSTEM AT 1-800-368-5868 OR, AT 936-434-8339 PRIOR TO BEGINNING.

4. CONTRACTOR SHALL DETERMINE THE EXACT LOCATION OF ALL UTILITIES PRIOR TO EXCAVATION. THE CONTRACTOR SHALL BE RESPONSIBLE FOR ALL DAMAGES CAUSED BY HIS FAILURE TO EXACTLY LOCATE AND PRESERVE ALL UNDERGROUND FACILITIES.

5. NO MORE TRENCH DEPTH AT ONE TIME THAN CAN BE BACKFILLED AND COMPACTED IN 10' LIFTS AT THE END OF EACH DAY (NO TRENCH LEFT OPENED OVERNIGHT)

6. ALL EXCESS EXCAVATION TO BE REMOVED FROM THE ROAD RIGHT-OF-WAY AT THE END OF EACH DAY

7. DITCHES TO BE OPENED AT THE END OF EACH DAY TO ASSURE ADEQUATE DRAINAGE

8. ROAD MUST BE KEPT OPEN TO TRAFFIC AND CONTRACTOR MUST PROVIDE ADEQUATE FLAGMEN SIGNALS, ETC. TO PROVIDE COMPLETE SAFETY TO THE PUBLIC.

9. IF IT BECOMES NECESSARY FOR EQUIPMENT TO OPERATE ON A PORTION OF THE PAVEMENT, PRECAUTIONS MUST BE TAKEN TO PREVENT ANY DAMAGE WHATSOEVER TO THE PAVEMENT.

10. CONDITION OF ROAD UPON COMPLETION OF JOB SHALL BE AS GOOD OR BETTER THAN PRIOR TO STARTING.


11. CONTRACTOR SHALL COMPLY WITH ALL APPLICABLE NATIONAL ELECTRICAL SAFETY CODE (NEC) REQUIREMENTS. CENTERPOINT ENERGY ELECTRIC POLE/TAPE HANGING GUIDELINES & PROCEDURES AND CENTERPOINT ENERGY CABLE TENSIONING GUIDELINES & PROCEDURES. PLACEMENT OF AIRFUEL, CABLE FACILITIES, 18" MIN VERTICAL CLEARANCE

12. ALL UTILITIES WILL BE IDENTIFIED BY POTHOLE BEFORE ANY CONSTRUCTION

13. CONCAST WILL MAINTAIN (2FT) HORIZONTAL & VERTICAL SEPARATION FROM ANY EXISTING UTILITIES

14. THE CONTRACTOR TO CONTACT WALKER COUNTY PRECINCT 4 AT LEAST 48 HOURS PRIOR TO CONSTRUCTION

Kevin P. Lusk PE
The Aspen Utility Company, LLC
Farm Rd. 23536
36502 Hempstead Highway
Hockley TX 77447

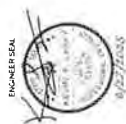

DESIGNED BY:
QUANTA TELECOM SERVICES

DWG. NO
SHEET NO. 15 OF 45

LAMBERT: N/A
DATE: 08/19/2025
KEY MAP NO 75K
SCALE: 1:40



ASPEN
A Division of The McGraw-Hill Companies

UB1771404 - 995 TX-150, NEW WAVERLY, TX 77358

COMCAST PROPOSES TO INSTALL FIBER OPTIC CABLE
COMCAST PROPOSES TO PLACE DIRECTIONAL BORE 710 FT TO INSTALL FIBER
OPTIC CABLE TO PROMOTE SERVICE TO 995 TX-150, NEW WAVELEY, TX 77558
INSIDE THE ROW OF THE WALKER COUNTY, TX



comcast
© HOUSTON, LLC
1590 W. TIDWELL RD. HOUSTON, TEXAS 77060

By:



1. THE WALKER COUNTY WILL BE NOTIFIED IN WRITING 48 HOURS PRIOR TO COMMENCING WORK.
2. THE WALKER COUNTY WILL NOTIFY THE DEPARTMENT AND PUBLIC WORKS DEPARTMENT WILL BE NOTIFIED FOR ONE LOCATES AT (906) 432-0098.
3. THE CONTRACTOR SHALL CONTACT TEXAS ONE CALL SYSTEM AT 1-800-4-A-S-H-I-P, 7 DAYS BEFORE DIGGING.
4. THE CONTRACTOR SHALL DETERMINE THE EXACT LOCATION OF ALL UTILITIES THAT MAY BE AFFECTED BY THE PROPOSED PROJECT. HE/ SHE WILL BE FULLY RESPONSIBLE FOR ALL DAMAGES CAUSED BY HIS FAILURE TO EXACTLY LOCATE AND PRESERVE ALL UNDERGROUND FACILITIES.
5. NO HOLE, TRENCH OR OTHER TIME THAT CAN BE BACKFILLED AND COMPACTED IN 10' LIFTS AT THE END OF EACH DAY, AND TRENCHE LEFT OPENED OVERNIGHT.
6. ALL EXCESS EXCAVATION TO BE REMOVED FROM THE ROAD RIGHT-OF-WAY AT THE END OF EACH DAY.
7. DITCHES TO BE OPENED AT THE END OF EACH DAY TO ASSURE ADEQUATE DRAINAGE.
8. ROAD MUST BE KEPT OPEN TO TRAFFIC AND CONTRACTOR MUST PROVIDE IMMEDIATE FLAGMEN, SIGNALS, ETC., TO PROVIDE COMPLETE SAFETY TO THE PUBLIC.
9. IF IT BECOMES NECESSARY FOR EQUIPMENT TO OPERATE ON A PORTION OF THE PAVEMENT, PREPARATIONS MUST BE TAKEN TO PREVENT ANY DAMAGE WHATSOEVER TO THE PAVEMENT.
10. CONDITION OF ROAD UPON COMPLETION OF JOB SHALL BE AS GOOD OR BETTER THAN PRIOR TO STARTING.
11. CONTRACTOR SHALL COMPLY WITH ALL APPLICABLE NATIONAL ELECTRICAL SAFETY CODE (NEC) REQUIREMENTS, CENTROPOINT ENERGY ELECTRIC POLE ATTACHMENT GUIDELINES, 1 PROCEDURES AND STANDARDS, AND ALL CITY ORDINANCES REGARDING THE PLACEMENT OF AIRIAL CABLE FACILITIES, 18" MIN VERTICAL CLEARANCE.
12. ALL UTILITIES WILL BE IDENTIFIED BY POT-HOLE BEFORE ANY CONSTRUCTION
13. CONCASSI WILL MAINTAIN GFI/HORIZONTAL & VERTICAL SEPARATION FROM ANY EXISTING UTILITIES.
14. THE CONTRACTOR TO CONTACT WALKER COUNTY PRECINCT 4 AT THE FAST RESPONSE CENTER FOR ASSISTANCE.

Kenn P. Lewy PE
The Aspen Utility Co.
Furn #60 23536
36-02 Montpelier Rd
Hawthorne, TX 77447
1/1/2021 4:52:34pm



comcast
of HOUSTON, LLC
3550 W. KIRKWOOD RD. HOUSTON, TEXAS 77060



COMCAST PROPOSES TO INSTALL FIBER OPTIC CABLE
COMCAST PROPOSES TO PLACE DIRECTIONAL BORE 710 FT TO INSTALL FIBER
OPTIC CABLE TO PROVIDE SERVICE TO 993 TA-150, NEW WAVELEY, TX 77358
INSIDE THE ROW OF THE WALKER COUNTY, TX.

JB1771404 - 995 TX-150, NEW WAVERLY, TX 77358




502 HEMPSTEAD HWY.
HOCKLEY, TX 77447

DESIGNED BY:
QUANTA TELECOM SERVICES

DWG. NO.
SHEET NO. 16 OF 45

LAMBERT: N/A
DATE 08/18/2022
KEY MAP NO 75H
SCALE: 1:40

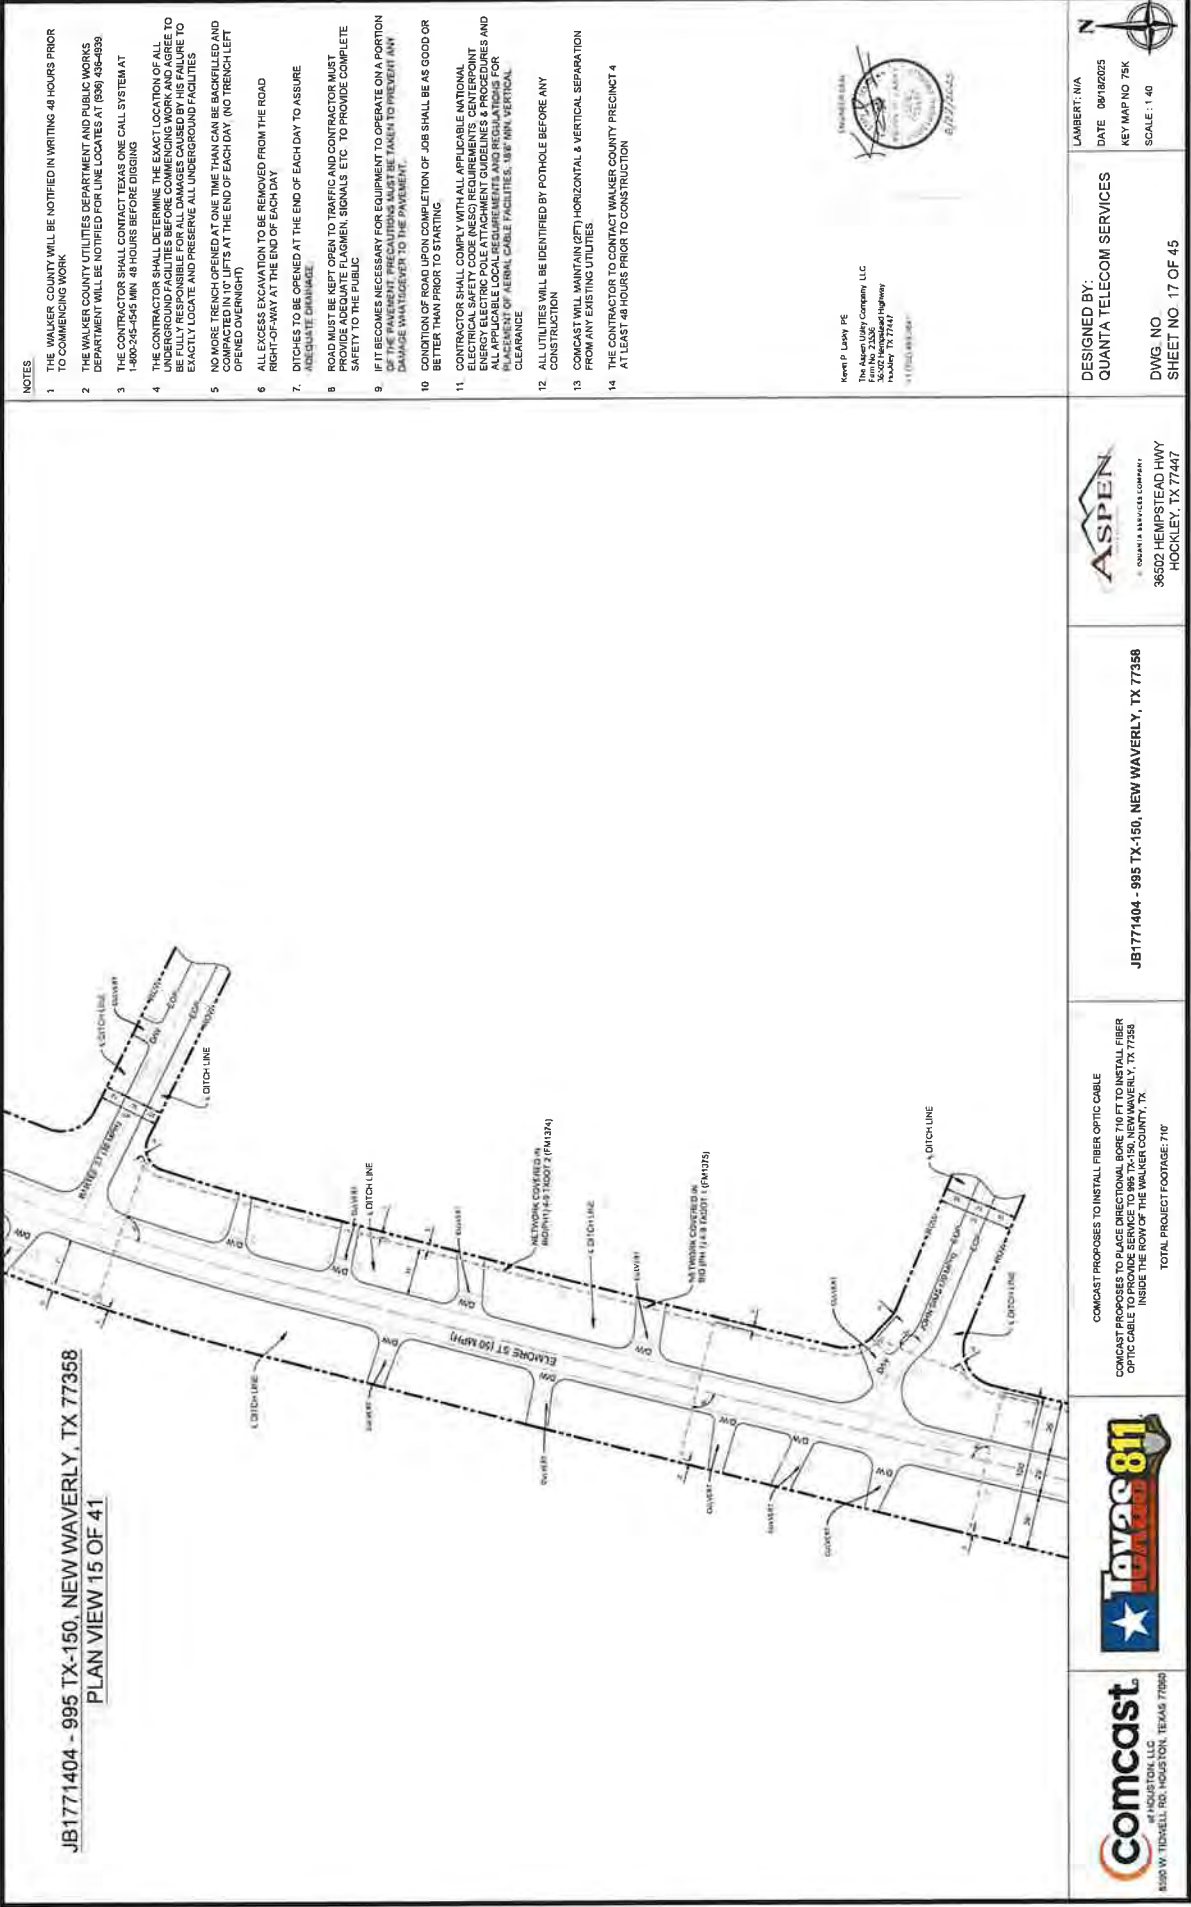

- NOTES**
1. THE WALKER COUNTY WILL BE NOTIFIED IN WRITING 48 HOURS PRIOR TO COMMENCING WORK.
 2. THE WALKER COUNTY UTILITIES DEPARTMENT AND PUBLIC WORKS DEPARTMENT WILL BE NOTIFIED FOR LINE LOCATES AT (936) 458-4939
 3. THE CONTRACTOR SHALL CONTACT TEXAS ONE CALL SYSTEM AT 1-800-245-4545 MIN. 48 HOURS BEFORE DIGGING.
 4. THE CONTRACTOR SHALL DETERMINE THE EXACT LOCATION OF ALL UNDERGROUND FACILITIES BEFORE COMMENCING WORK AND AGREE TO BE FULLY RESPONSIBLE FOR ALL DAMAGES CAUSED BY HIS FAILURE TO EXACTLY LOCATE AND PRESERVE ALL UNDERGROUND FACILITIES.
 5. NO MORE TRENCH OPENED AT ONE TIME THAN CAN BE BACKFILLED AND COMPACTED IN 10' LIFTS AT THE END OF EACH DAY. (NO TRENCH LEFT OPENED OVERNIGHT)
 6. ALL EXCESS EXCAVATION TO BE REMOVED FROM THE ROAD RIGHT-OF-WAY AT THE END OF EACH DAY.
 7. DITCHES TO BE OPENED AT THE END OF EACH DAY TO ASSURE ADEQUATE DRAINAGE.
 8. ROAD MUST BE KEPT OPEN TO TRAFFIC AND CONTRACTOR MUST PROVIDE ADEQUATE FLAGMEN, SIGNALS, ETC. TO PROVIDE COMPLETE SAFETY TO THE PUBLIC.
 9. IF IT BECOMES NECESSARY FOR EQUIPMENT TO OPERATE ON A PORTION OF THE PAVEMENT, PRECAUTIONS MUST BE TAKEN TO PREVENT ANY DAMAGE WHATSOEVER TO THE PAVEMENT.
 10. CONDITION OF ROAD UPON COMPLETION OF JOB SHALL BE AS GOOD OR BETTER THAN PRIOR TO STARTING.
 11. CONTRACTOR SHALL COMPLY WITH ALL APPLICABLE NATIONAL ELECTRICAL SAFETY CODE (NEC) REQUIREMENTS, CENTERPOINT ENERGY ELECTRIC POLE ATTACHMENT GUIDELINES & PROCEDURES AND ALL APPLICABLE LOCAL ORDINANCES AND REGULATIONS FOR THE PLACEMENT OF AERIAL CABLE FACILITIES, 180' MIN. VERTICAL CLEARANCE.
 12. ALL UTILITIES WILL BE IDENTIFIED BY POT-HOLE BEFORE ANY CONSTRUCTION.
 13. COMCAST WILL MAINTAIN (2FT) HORIZONTAL & VERTICAL SEPARATION FROM ANY EXISTING UTILITIES.
 14. THE CONTRACTOR TO CONTACT WALKER COUNTY PRECINCT 4 AT LEAST 48 HOURS PRIOR TO CONSTRUCTION.



Kevin P. Lundy, PE
The Aspen Group Company, LLC
Firm No. 22386
Mechanical Engineering
Houston, TX 77047
11/15/2019 8:53:40 AM

LAMBERT: N/A
DATE: 08/18/2025
KEY MAP NO. 75K
SCALE: 1" = 40'

DESIGNED BY:
QUANTA TELECOM SERVICES
DWG. NO.
SHEET NO. 17 OF 45

ASPEN
A QUANTA SERVICES COMPANY
36502 HEMPSTEAD HWY
HOCKLEY, TX 77447

JB1771404 - 995 TX-150, NEW WAVERLY, TX 77358

COMCAST PROPOSES TO INSTALL FIBER OPTIC CABLE
COMCAST PROPOSES TO PLACE DIRECTIONAL BORE 110 FT TO INSTALL FIBER OPTIC CABLE TO PROVIDE SERVICE TO 995 TX-150, NEW WAVERLY, TX 77358
INSIDE THE ROW OF THE WALKER COUNTY, TX.
TOTAL PROJECT FOOTAGE: 710'




Comcast
A HOUSTON, LLC
8300 W. TIDWELL RD., HOUSTON, TEXAS 77060



JB1771404 - 995 TX-150, NEW WAVERLY, TX 77358

PLAN VIEW 17 OF 41

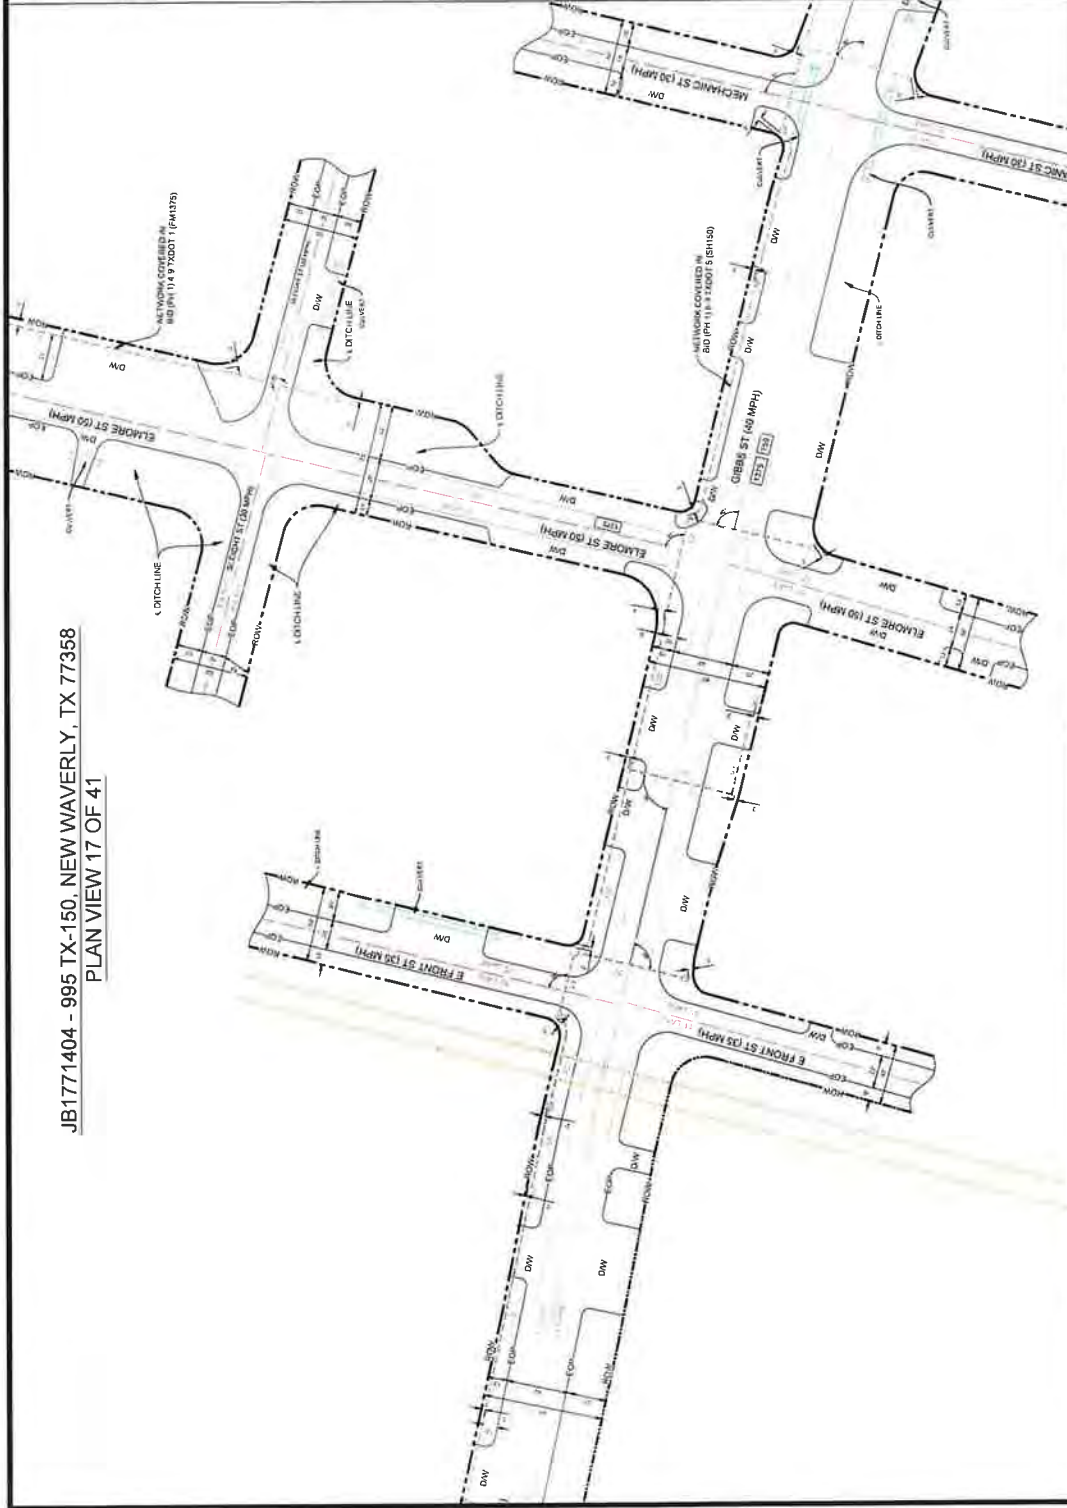

NOTES


1. THE WALKER COUNTY WILL BE NOTIFIED IN WRITING 48 HOURS PRIOR TO COMMENCING WORK.
2. THE WALKER COUNTY UTILITIES DEPARTMENT AND PUBLIC WORKS DEPARTMENT WILL BE NOTIFIED FOR LINE LOCATES AT (936) 494-4999
3. THE CONTRACTOR SHALL CONTACT TEXAS ONE CALL SYSTEM AT 1-800-345-4545 WITH 48 HOURS BEFORE DIGGING.
4. THE CONTRACTOR SHALL DETERMINE THE EXACT LOCATION OF ALL UNDERGROUND FACILITIES BEFORE COMMENCING WORK AND AGREE TO BE FULLY RESPONSIBLE FOR ALL DAMAGES CAUSED BY HIS FAILURE TO EXACTLY LOCATE AND PRESERVE ALL UNDERGROUND FACILITIES.
5. NO MORE TRENCH OPENED AT ONE TIME THAN CAN BE BACKFILLED AND COMPACTED IN 10' LIFTS AT THE END OF EACH DAY. (NO TRENCH LEFT OPENED OVERNIGHT)
6. ALL EXCESS EXCAVATION TO BE REMOVED FROM THE ROAD RIGHT-OF-WAY AT THE END OF EACH DAY
7. DITCHES TO BE OPENED AT THE END OF EACH DAY TO ASSURE ADEQUATE DRAINAGE
8. ROAD MUST BE KEPT OPEN TO TRAFFIC AND CONTRACTOR MUST PROVIDE ADEQUATE FLAGMEN SIGNALS ETC. TO PROVIDE COMPLETE SAFETY TO THE PUBLIC.
9. IF IT BECOMES NECESSARY FOR EQUIPMENT TO OPERATE ON A PORTION OF THE PAVEMENT PRECAUTIONS MUST BE TAKEN TO PREVENT ANY DAMAGE WHATSOEVER TO THE PAVEMENT.
10. CONDITION OF ROAD UPON COMPLETION OF JOB SHALL BE AS GOOD OR BETTER THAN PRIOR TO STARTING.
11. CONTRACTOR SHALL COMPLY WITH ALL APPLICABLE NATIONAL ELECTRICAL SAFETY CODE (NEC) REQUIREMENTS, CENTERPOINT ENERGY ELECTRIC POLE ATTACHMENT GUIDELINES & PROCEDURES AND ALL OTHER REQUIREMENTS FOR THE PROTECTION OF ALL UTILITIES ON PLACEMENT OF AERIAL CABLE FACILITIES. 18' MIN. VERTICAL CLEARANCE.
12. ALL UTILITIES WILL BE IDENTIFIED BY POT-HOLE BEFORE ANY CONSTRUCTION
13. COMCAST WILL MAINTAIN 8FT+ HORIZONTAL & VERTICAL SEPARATION FROM ANY EXISTING UTILITIES
14. THE CONTRACTOR TO CONTACT WALKER COUNTY PRECINCT 4 AT LEAST 48 HOURS PRIOR TO CONSTRUCTION

Kevin P. Lundy PE
The Aspen Utility Company, LLC
P.O. Box 25348
Houston, TX 77244
+1 (713) 483-3685



 8300 W. TOWNHILL RD. HOUSTON, TEXAS 77060		COMCAST PROPOSES TO INSTALL FIBER OPTIC CABLE COMCAST PROPOSES TO PLACE DIRECTIONAL BORE PIT TO INSTALL FIBER OPTIC CABLE INSIDE THE ROW OF THE WALKER COUNTY, TX. TOTAL PROJECT FOOTAGE: 710	JB1771404 - 995 TX-150, NEW WAVERLY, TX 77358	 36502 HEMPSTEAD HWY. HOCKLEY, TX 77447	DESIGNED BY: QUANTA TELECOM SERVICES DWG. NO. SHEET NO. 19 OF 45	LAMBERT: N/A DATE: 08/18/2025 KEY MAP NO 79K SCALE: 1" = 40'
--	---	---	---	--	---	---

RECEIVED
SEP 02 2025
BY:.....

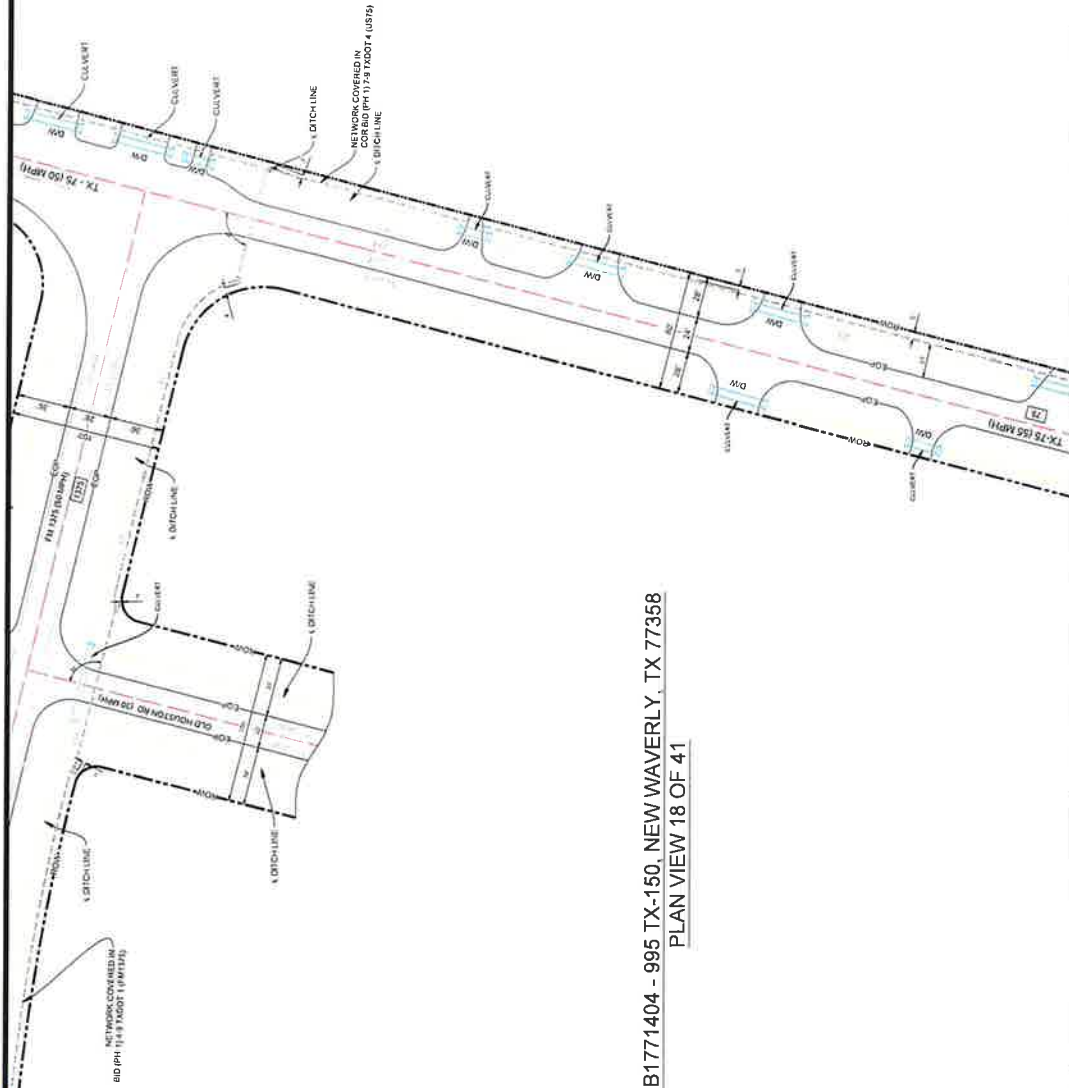


JB1771404 - 995 TX-150, NEW WAVERLY, TX 77358
PLAN VIEW 18 OF 41

NOTES

1. THE WALKER COUNTY WILL BE NOTIFIED IN WRITING 48 HOURS PRIOR TO COMMENCING WORK.
2. THE WALKER COUNTY UTILITIES DEPARTMENT AND PUBLIC WORKS DEPARTMENT WILL BE NOTIFIED FOR LINE LOCATES AT (930) 436-4539.
3. THE CONTRACTOR SHALL CONTACT TEXAS ONE CALL SYSTEM AT 1-800-345-4545 MIN. 48 HOURS BEFORE DIGGING.
4. THE CONTRACTOR SHALL DETERMINE THE EXACT LOCATION OF ALL UNDERGROUND FACILITIES BEFORE COMMENCING WORK AND AGREE TO EXISTING FACILITIES. THE CONTRACTOR SHALL BE RESPONSIBLE FOR ANY DAMAGES CAUSED BY HIS FAILURE TO EXACTLY LOCATE AND PRESERVE ALL UNDERGROUND FACILITIES.
5. NO MORE TRENCH OPENED AT ONE TIME THAN CAN BE BACKFILLED AND RECLOSED WITHIN 24 HOURS AT THE END OF EACH DAY. (NO TRENCH LEFT OPENED OVERNIGHT).
6. ALL EXCESS EXCAVATION TO BE REMOVED FROM THE ROAD RIGHT-OF-WAY AT THE END OF EACH DAY.
7. DITCHES TO BE OPENED AT THE END OF EACH DAY TO ASSURE ADEQUATE DRAINAGE.
8. ROAD MUST BE KEPT OPEN TO TRAFFIC AND CONTRACTOR MUST PROVIDE ADEQUATE FLAGMEN, SIGNALS, ETC., TO PROVIDE COMPLETE SAFETY TO THE PUBLIC.
9. IF IT BECOMES NECESSARY FOR EQUIPMENT TO OPERATE ON A PORTION OF THE PAVEMENT, PRECAUTIONS MUST BE TAKEN TO PREVENT ANY DAMAGE WHATSOEVER TO THE PAVEMENT.
10. CONDITION OF ROAD UPON COMPLETION OF JOB SHALL BE AS GOOD OR BETTER THAN PRIOR TO STARTING.
11. CONTRACTOR SHALL COMPLY WITH ALL APPLICABLE NATIONAL ELECTRICAL SAFETY CODE (NEC) REQUIREMENTS, CENTERPOINT ELECTRICITY DELIVERY RULES AND REGULATIONS, AND ALL APPLICABLE LOCAL REQUIREMENTS AND REGULATIONS FOR PLACEMENT OF AERIAL CABLE FACILITIES, 18" MIN. VERTICAL CLEARANCE.
12. ALL UTILITIES WILL BE IDENTIFIED BY POTHOLE BEFORE ANY CONSTRUCTION.
13. COMCAST WILL MAINTAIN (GFI) HORIZONTAL & VERTICAL SEPARATION FROM ANY EXISTING UTILITIES.
14. THE CONTRACTOR TO CONTACT WALKER COUNTY PRECINCT 4 AT LEAST 48 HOURS PRIOR TO CONSTRUCTION.

Kenneth P. Lusk, P.E.
The Aspen Utility Company, LLC
10000 N. Loop West, Suite 200
Houston, TX 77047
+1 (281) 463-3067

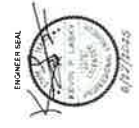

COMCAST PROPOSES TO INSTALL FIBER OPTIC CABLE
COMCAST PROPOSES TO PLACE DIRECTIONAL BORE 110 FT TO INSTALL FIBER OPTIC CABLE UNDERGROUND TO 995 TX-150, NEW WAVERLY, TX 77358, INSIDE THE ROW OF THE WALKER COUNTY, TX.
TOTAL PROJECT FOOTAGE: 710'

JB1771404 - 995 TX-150, NEW WAVERLY, TX 77358




DESIGNED BY:
QUANTA TELECOM SERVICES

LAMBERT, WA
DATE: 08/02/2025
KEY MAP NO 79K
SCALE: 1" = 40'

DWG. NO.
SHEET NO. 20 OF 45

JB1771404 - 995 TX-150, NEW WAVERLY, TX 77358
PLAN VIEW 19 OF 41

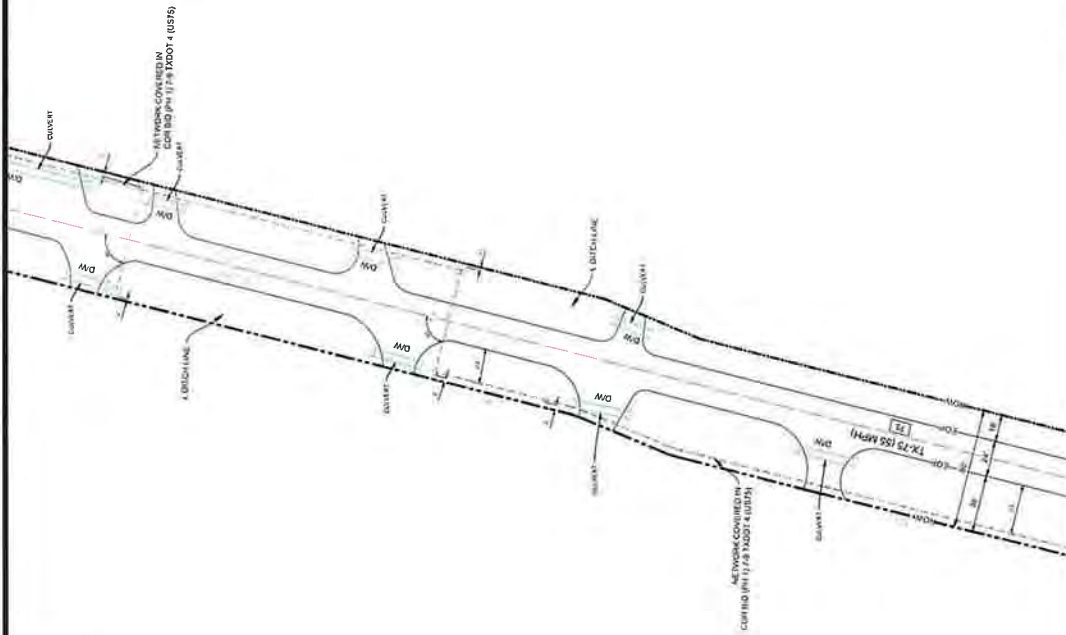

NOTES

- 1 THE WALKER COUNTY WILL BE NOTIFIED IN WRITING 48 HOURS PRIOR TO COMMENCING WORK
- 2 THE WALKER COUNTY UTILITIES DEPARTMENT AND PUBLIC WORKS DEPARTMENT WILL BE NOTIFIED FOR LINE LOCATES AT (980) 434-4939
- 3 THE CONTRACTOR SHALL CONTACT TEXAS ONE CALL SYSTEM AT 1-800-345-4545 MIN. 48 HOURS BEFORE DIGGING
- 4 THE CONTRACTOR SHALL DETERMINE THE EXACT LOCATION OF ALL UNDERGROUND FACILITIES BEFORE COMMENCING WORK AND AGREE TO BE FULLY RESPONSIBLE FOR ALL DAMAGES CAUSED BY HIS FAILURE TO EXACTLY LOCATE AND PRESERVE ALL UNDERGROUND FACILITIES
- 5 NO MORE TRENCH OPENED AT ONE TIME THAN CAN BE BACKFILLED AND COMPACTED IN 10' LIFTS AT THE END OF EACH DAY. (NO TRENCH LEFT OPENED OVERNIGHT)
- 6 ALL EXCESS EXCAVATION TO BE REMOVED FROM THE ROAD RIGHT-OF-WAY AT THE END OF EACH DAY
- 7 DITCHES TO BE OPENED AT THE END OF EACH DAY TO ASSURE ADEQUATE DRAINAGE
- 8 ROAD MUST BE KEPT OPEN TO TRAFFIC AND CONTRACTOR MUST PROVIDE ADEQUATE FLAGMEN, SIGNALS, ETC. TO PROVIDE COMPLETE SAFETY TO THE PUBLIC
- 9 IF IT BECOMES NECESSARY FOR EQUIPMENT TO OPERATE ON A PORTION OF THE PAVEMENT PRECAUTIONS MUST BE TAKEN TO PREVENT ANY DAMAGE WHATSOEVER TO THE PAVEMENT
- 10 CONDITION OF ROAD UPON COMPLETION OF JOB SHALL BE AS GOOD OR BETTER THAN PRIOR TO STARTING
- 11 CONTRACTOR SHALL COMPLY WITH ALL APPLICABLE NATIONAL ELECTRICAL SAFETY CODE (NEC) REQUIREMENTS, CENTERPOINT ENERGY ELECTRIC POLE ATTACHMENT GUIDELINES & PROCEDURES AND ALL OTHER REQUIREMENTS AND PROCEDURES FOR THE PROTECTION OF AERIAL CABLE FACILITIES. 18" MIN. VERTICAL CLEARANCE
- 12 ALL UTILITIES WILL BE IDENTIFIED BY POT HOLE BEFORE ANY CONSTRUCTION
- 13 COMCAST WILL MAINTAIN (2FT) HORIZONTAL & VERTICAL SEPARATION FROM ANY EXISTING UTILITIES
- 14 THE CONTRACTOR TO CONTACT WALKER COUNTY PRECINCT 4 AT LEAST 48 HOURS PRIOR TO CONSTRUCTION

Kevin P. Lundy, PE
The Aspen Utility Company, LLC
P.O. Box 220,000
Houston, TX 77241
+1 (702) 453-3490

ENGINEER SEAL



DESIGNED BY:
QUANTA TELECOM SERVICES
DWG. NO.
SHEET NO. 21 OF 45

ASPEN
QUANTA SERVICES COMPANY
36502 HEMPSTEAD HWY
HOCKLEY, TX 77447


JB1771404 - 995 TX-150, NEW WAVERLY, TX 77358

COMCAST PROPOSES TO INSTALL FIBER OPTIC CABLE
COMCAST PROPOSES TO PLACE PRELIMINARY PILES 10' FT FOR INSTALL FIBER
OPTIC CABLE INSIDE THE ROW OF THE WALKER COUNTY, TX
TOTAL PROJECT FOOTAGE: 710'



RECEIVED
SEP 02 2025
BY:

JB1771404 - 995 TX-150, NEW WAVERLY, TX 77358
PLAN VIEW 20 OF 41

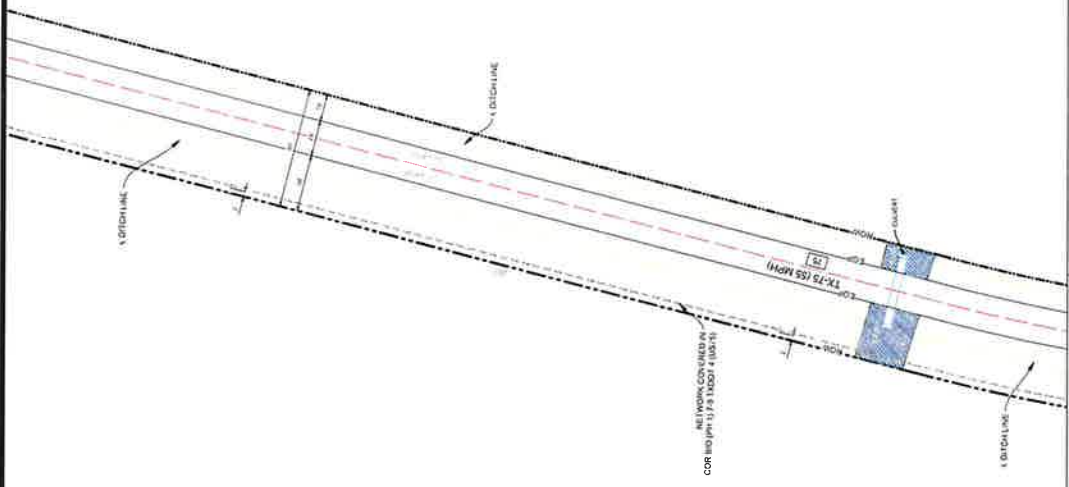

NOTES


1. THE WALKER COUNTY WILL BE NOTIFIED IN WRITING 48 HOURS PRIOR TO COMMENCING WORK.
2. THE WALKER COUNTY UTILITIES DEPARTMENT AND PUBLIC WORKS DEPARTMENT WILL BE NOTIFIED FOR LINE LOCATES AT (936) 436-4938.
3. THE CONTRACTOR SHALL CONTACT TEXAS ONE CALL SYSTEM AT 1-800-245-5449 MIN. 48 HOURS BEFORE DIGGING.
4. THE CONTRACTOR SHALL DETERMINE THE EXACT LOCATION OF ALL UNDERGROUND FACILITIES BEFORE COMMENCING WORK AND AGREE TO BE FULLY RESPONSIBLE FOR ALL DAMAGES CAUSED BY HIS FAILURE TO EXACTLY LOCATE AND PRESERVE ALL UNDERGROUND FACILITIES.
5. NO MORE TRENCH OPENED AT ONE TIME THAN CAN BE BACKFILLED AND COMPLETED INTO UPS AT THE END OF EACH DAY. (NO TRENCH LEFT OPENED OVERNIGHT).
6. ALL EXCESS EXCAVATION TO BE REMOVED FROM THE ROAD RIGHT-OF-WAY AT THE END OF EACH DAY.
7. DITCHES TO BE OPENED AT THE END OF EACH DAY TO ASSURE ADEQUATE DRAINAGE.
8. ROAD MUST BE KEPT OPEN TO TRAFFIC AND CONTRACTOR MUST PROVIDE ADEQUATE FLAGMEN, SIGNALS, ETC. TO PROVIDE COMPLETE SAFETY TO THE PUBLIC.
9. IF IT BECOMES NECESSARY FOR EQUIPMENT TO OPERATE ON A PORTION OF THE PAVEMENT, PRECAUTIONS MUST BE TAKEN TO PREVENT ANY DAMAGE WHATSOEVER TO THE PAVEMENT.
10. CONDITION OF ROAD UPON COMPLETION OF JOB SHALL BE AS GOOD OR BETTER THAN PRIOR TO STARTING.
11. CONTRACTOR SHALL COMPLY WITH ALL APPLICABLE NATIONAL ELECTRICAL SAFETY CODE (NEC) REQUIREMENTS, CENTERPOINT ENERGY COMPANY, TEXAS, AND ALL APPLICABLE LOCAL ORDINANCES AND ALL APPLICABLE LOCAL REQUIREMENTS AND REGULATIONS FOR PLACEMENT OF AERIAL CABLE FACILITIES, 18" MIN. VERTICAL CLEARANCE.
12. ALL UTILITIES WILL BE IDENTIFIED BY POTHOLE BEFORE ANY CONSTRUCTION.
13. COMCAST WILL MAINTAIN (GFI) HORIZONTAL & VERTICAL SEPARATION FROM ANY EXISTING UTILITIES.
14. THE CONTRACTOR TO CONTACT WALKER COUNTY PRECINCT 4 AT LEAST 48 HOURS PRIOR TO CONSTRUCTION.

Kevin P. Lisle, PE
The Aspen Utility Company, LLC
P.O. Box 23330
Hockley, TX 77447
1 (727) 493-2961



 8500 W. TIDWELL, HO. HOUSTON, TEXAS 77060		COMCAST PROPOSES TO PLACE DIRECTIONAL BORE 710 FT TO INSTALL FIBER OPTIC CABLE TO PROVIDE SERVICE TO 995 TX-150, NEW WAVERLY, TX 77358, INSIDE THE ROW OF THE WALKER COUNTY, TX. TOTAL PROJECT FOOTAGE: 710'	JB1771404 - 995 TX-150, NEW WAVERLY, TX 77358	 36502 HEMPSTEAD HWY. HOCKLEY, TX 77447	DESIGNED BY: QUANTA TELECOM SERVICES DWG. NO. SHEET NO. 22 OF 45	LAMBERT, WA DATE: 08/02/2025 KEY MAP NO. 79K SCALE: 1" = 40'
--	---	---	---	--	---	---

JB1771404 - 995 TX-150, NEW WAVERLY, TX 77358
 PLAN VIEW 21 OF 41

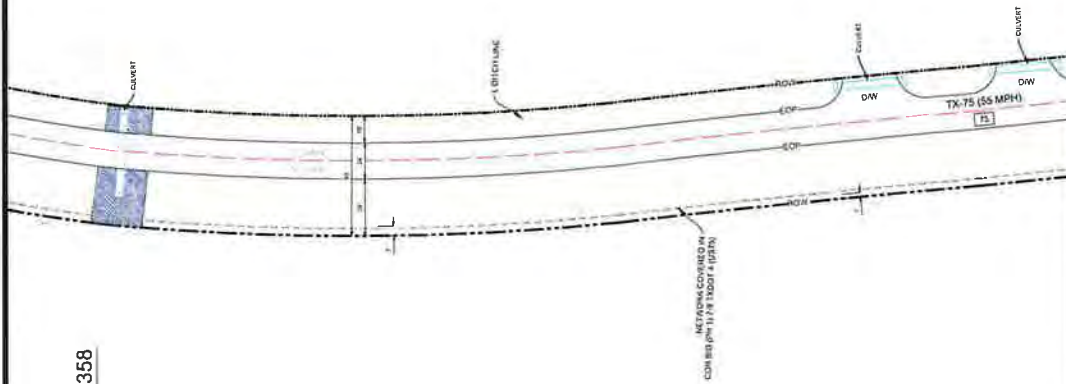

NOTES

1. THE WALKER COUNTY WILL BE NOTIFIED IN WRITING 48 HOURS PRIOR TO COMMENCING WORK.
2. THE WALKER COUNTY UTILITIES DEPARTMENT AND PUBLIC WORKS DEPARTMENT WILL BE NOTIFIED FOR LINE LOCATES AT (800) 496-6999
3. THE CONTRACTOR SHALL CONTACT TEXAS ONE CALL SYSTEM AT 1-800-345-4545 MIN. 48 HOURS BEFORE DIGGING.
4. THE CONTRACTOR SHALL DETERMINE THE EXACT LOCATION OF ALL UNDERGROUND FACILITIES BEFORE COMMENCING WORK AND AGREE TO BE FULLY RESPONSIBLE FOR ALL DAMAGES CAUSED BY HIS FAILURE TO EXACTLY LOCATE AND PRESERVE ALL UNDERGROUND FACILITIES.
5. NO MORE TRENCH OPENED AT ONE TIME THAN CAN BE BACKFILLED AND COMPACTED IN 10' LIFTS AT THE END OF EACH DAY. (NO TRENCH LEFT OPENED OVERNIGHT)
6. ALL EXCESS EXCAVATION TO BE REMOVED FROM THE ROAD RIGHT-OF-WAY AT THE END OF EACH DAY.
7. DITCHES TO BE OPENED AT THE END OF EACH DAY TO ASSURE ADEQUATE DRAINAGE
8. ROAD MUST BE KEPT OPEN TO TRAFFIC AND CONTRACTOR MUST PROVIDE ADEQUATE FLAGMEN, SIGNALS, ETC. TO PROVIDE COMPLETE SAFETY TO THE PUBLIC
9. IF IT BECOMES NECESSARY FOR EQUIPMENT TO OPERATE ON A PORTION OF THE PAVEMENT, PRECAUTIONS MUST BE TAKEN TO PREVENT ANY DAMAGE WHATSOEVER TO THE PAVEMENT.
10. CONDITION OF ROAD UPON COMPLETION OF JOB SHALL BE AS GOOD OR BETTER THAN PRIOR TO STARTING.
11. CONTRACTOR SHALL COMPLY WITH ALL APPLICABLE NATIONAL ELECTRICAL SAFETY CODE (NEC) REQUIREMENTS, CENTERPOINT ENERGY ELECTRIC POLE ATTACHMENT GUIDELINES & PROCEDURES AND ALL APPLICABLE LOCAL ORDINANCES AND REGULATIONS FOR PLACEMENT OF ABOVE GROUND FACILITIES. NO NEW VERTICAL CLEARANCE.
12. ALL UTILITIES WILL BE IDENTIFIED BY POT-HOLE BEFORE ANY CONSTRUCTION.
13. COMCAST WILL MAINTAIN (2FT) HORIZONTAL & VERTICAL SEPARATION FROM ANY EXISTING UTILITIES
14. THE CONTRACTOR TO CONTACT WALKER COUNTY PRECINCT #4 AT LEAST 48 HOURS PRIOR TO CONSTRUCTION.

Kevin P. Luby, PE
 The Aspen Utility Company, LLC
 2000 N. 23rd
 Suite 100
 Houston, TX 77061
 (281) 461-3941



DESIGNED BY:
 QUANTA TELECOM SERVICES
 DWG. NO.
 SHEET NO. 23 OF 45

ASPEN
 A QUANTA SERVICES COMPANY
 36502 HEMPSTEAD HWY.
 HOCKLEY, TX 77447


JB1771404 - 995 TX-150, NEW WAVERLY, TX 77358

COMCAST PROPOSES TO INSTALL FIBER OPTIC CABLE
 COMCAST PROPOSES TO PLACE DIRECTIONAL BORE 140 FT TO INSTALL FIBER
 OPTIC CABLE TO PREPARE SITES TO 995 TX-150, NEW WAVERLY, TX 77358
 INSIDE THE ROW OF THE WALKER COUNTY, TX.
 TOTAL PROJECT FOOTAGE: 710'



RECEIVED
SEP 02 2025
BY:

JB1771404 - 995 TX-150, NEW WAVERLY, TX 77358
PLAN VIEW 22 OF 41

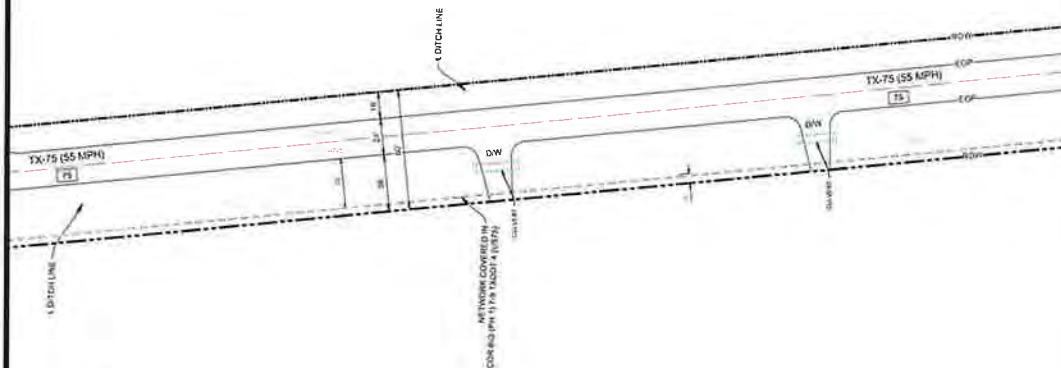

1. THE WALKER COUNTY WILL BE NOTIFIED IN WRITING 48 HOURS PRIOR TO COMMENCING WORK.
2. THE WALKER COUNTY UTILITIES DEPARTMENT AND PUBLIC WORKS DEPARTMENT WILL BE NOTIFIED FOR LINE LOCATES AT (800) 456-4839
3. THE CONTRACTOR SHALL CONTACT TEXAS ONE CALL SYSTEM AT 1-800-255-4545 MIN. 48 HOURS BEFORE DIGGING.
4. THE CONTRACTOR SHALL DETERMINE THE EXACT LOCATION OF ALL UTILITIES AND BE FULLY RESPONSIBLE FOR ALL DAMAGES CAUSED BY HIS FAILURE TO EXACTLY LOCATE AND PRESERVE ALL UNDERGROUND FACILITIES.
5. NO MORE TRENCH OPENED AT ONE TIME THAN CAN BE BACKFILLED AND COMPACTED IN 10' LIFTS AT THE END OF EACH DAY (NO TRENCH LEFT OPENED OVERNIGHT).
6. ALL EXCESS EXCAVATION TO BE REMOVED FROM THE ROAD RIGHT-OF-WAY AT THE END OF EACH DAY
7. DITCHES TO BE OPENED AT THE END OF EACH DAY TO ASSURE ADEQUATE DRAINAGE.
8. ROAD MUST BE KEPT OPEN TO TRAFFIC AND CONTRACTOR MUST PROVIDE ADEQUATE FLAGMEN, SIGNALS, ETC. TO PROVIDE COMPLETE SAFETY TO THE PUBLIC.
9. IF IT BECOMES NECESSARY FOR EQUIPMENT TO OPERATE ON A PORTION OF THE PAVEMENT, PRECAUTIONS MUST BE TAKEN TO PREVENT ANY DAMAGE WHATSOEVER TO THE PAVEMENT.
10. CONDITION OF ROAD UPON COMPLETION OF JOB SHALL BE AS GOOD OR BETTER THAN PRIOR TO STARTING
11. CONTRACTOR SHALL COMPLY WITH ALL APPLICABLE NATIONAL ELECTRICAL SAFETY CODE (NEC) REQUIREMENTS, CENTERPOINT ENERGY ELECTRIC POLE ATTACHMENT GUIDELINES & PROCEDURES AND ALL OTHER APPLICABLE REGULATIONS AND STANDARDS FOR THE PLACEMENT OF AERIAL CABLE FACILITIES. 18" MIN. VERTICAL CLEARANCE
12. ALL UTILITIES WILL BE IDENTIFIED BY POT HOLE BEFORE ANY CONSTRUCTION
13. CONCAST WILL MAINTAIN (GFI) HORIZONTAL & VERTICAL SEPARATION FROM ANY EXISTING UTILITIES
14. THE CONTRACTOR TO CONTACT WALKER COUNTY PRECINCT 4 AT LEAST 48 HOURS PRIOR TO CONSTRUCTION.

Kevin P. Lavy PE
The Aasen Utility Company, LLC
Farm No. 2, Box 36
16502 Hempstead Highway
Humble, TX 77447



comcast
of HOUSTON, LLC
3500 W. TIDWELL RD., HOUSTON, TEXAS 77060



COMCAST PROPOSES TO INSTALL FIBER OPTIC CABLE

COMCAST PROPOSES TO PLACE DIRECTIONAL BORE 710 FT TO INSTALL FIBER OPTIC CABLE TO PROVIDE SERVICE TO 995 TX-150, NEW WAVELEY, TX 77358 INSIDE THE ROW OF THE WALKER COUNTY, TX.

TOTAL PROJECT FOOTAGE: 710'

JB1771404 - 995 TX-150, NEW WAVERLY, TX 77358




36502 HEMPSTEAD HWY,
HOCKLEY, TX 77447

DESIGNED BY:
QUANTA TELECOM SERVICES

DWG. NO.
SHEET NO. 24 OF 45



JB1771404 - 995 TX-150, NEW WAVERLY, TX 77358
PLAN VIEW 23 OF 41

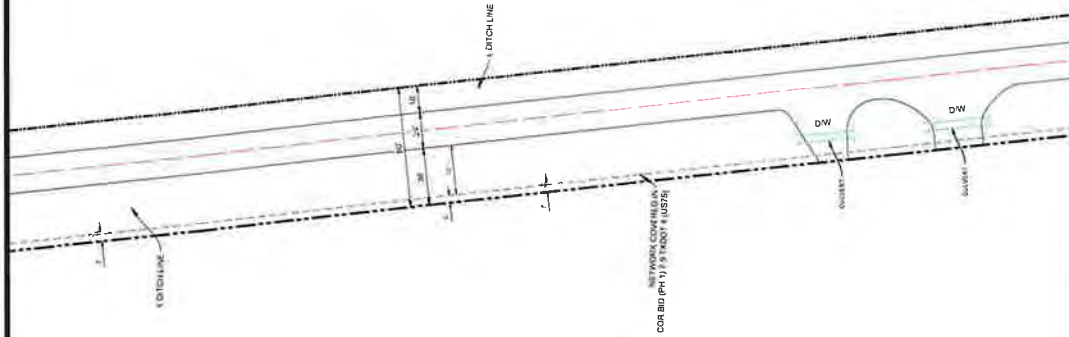

NOTES

1. THE WALKER COUNTY WILL BE NOTIFIED IN WRITING 48 HOURS PRIOR TO COMMENCING WORK.
2. THE WALKER COUNTY UTILITIES DEPARTMENT AND PUBLIC WORKS DEPARTMENT WILL BE NOTIFIED FOR LINE LOCATES AT (936) 458-4839.
3. THE CONTRACTOR SHALL CONTACT TEXAS ONE CALL SYSTEM AT 1-800-245-4545 MIN. 48 HOURS BEFORE DIGGING.
4. THE CONTRACTOR SHALL DETERMINE THE EXACT LOCATION OF ALL UNDERGROUND FACILITIES BEFORE COMMENCING WORK AND AGREE TO BE FULLY RESPONSIBLE FOR ALL DAMAGES CAUSED BY HIS FAILURE TO EXACTLY LOCATE AND PRESERVE ALL UNDERGROUND FACILITIES.
5. NO MORE TRENCH OPENED AT ONE TIME THAN CAN BE BACKFILLED AND COMPACTED IN 107 LIFTS AT THE END OF EACH DAY (NO TRENCH LEFT OPENED OVERNIGHT).
6. ALL EXCESS EXCAVATION TO BE REMOVED FROM THE ROAD RIGHT-OF-WAY AT THE END OF EACH DAY.
7. DITCHES TO BE OPENED AT THE END OF EACH DAY TO ASSURE ADEQUATE DRAINAGE.
8. ROAD MUST BE KEPT OPEN TO TRAFFIC AND CONTRACTOR MUST PROVIDE ADEQUATE FLAGMEN SIGNALS, ETC. TO PROVIDE COMPLETE SAFETY TO THE PUBLIC.
9. IF IT BECOMES NECESSARY FOR EQUIPMENT TO OPERATE ON A PORTION OF THE PAVEMENT, PRECAUTIONS MUST BE TAKEN TO PREVENT ANY DAMAGE WHATSOEVER TO THE PAVEMENT.
10. CONDITION OF ROAD UPON COMPLETION OF JOB SHALL BE AS GOOD OR BETTER THAN PRIOR TO STARTING.
11. CONTRACTOR SHALL COMPLY WITH ALL APPLICABLE NATIONAL ELECTRICAL SAFETY CODE (NEC) REQUIREMENTS, CENTERPOINT ENERGY ELECTRIC POLE ATTACHMENT GUIDELINES & PROCEDURES AND ALL OTHER REQUIREMENTS OF THE UTILITY OWNERS. CONTRACTOR SHALL MAINTAIN ADEQUATE CLEARANCE OF AERIAL CABLE FACILITIES. 18' MIN. VERTICAL CLEARANCE.
12. ALL UTILITIES WILL BE IDENTIFIED BY POT-HOLE BEFORE ANY CONSTRUCTION.
13. COMCAST WILL MAINTAIN (GET) HORIZONTAL & VERTICAL SEPARATION FROM ANY EXISTING UTILITIES.
14. THE CONTRACTOR TO CONTACT WALKER COUNTY PRECINCT 4 AT LEAST 48 HOURS PRIOR TO CONSTRUCTION.

Kevin P. Luby, PE
The Aspen Utility Company, LLC
P.O. Box 23256
Dallas, Texas 75225
Hockley, TX 77447
(972) 993-2844

ENGINEER SEAL



LAMBERT: N/A
DATE: 06/02/2023
KEY MAP NO. 75K
SCALE: 1"=40'

DESIGNED BY:
QUANTA TELECOM SERVICES
DWG. NO.
SHEET NO. 25 OF 45

ASPEN
36502 HEMPSTEAD HWY
HOCKLEY, TX 77447

JB1771404 - 995 TX-150, NEW WAVERLY, TX 77358

COMCAST PROPOSES TO INSTALL FIBER OPTIC CABLE
COMCAST PROPOSES TO PLACE PRELIMINARY 100' FT TO INSTALL FIBER
OPTIC CABLE TO SERVICE SERVICE TO 995 TX-150 NEW WAVERLY, TX 77358
INSIDE THE ROW OF THE WALKER COUNTY, TX
TOTAL PROJECT FOOTAGE: 110'



BY:

[illegible]

1. THE WALKER COUNTY WILL BE NOTIFIED IN WRITING 48 HOURS PRIOR TO COMMENCING WORK.

2. THE WALKER COUNTY UTILITIES DEPARTMENT AND PUBLIC WORKS DEPARTMENT SHALL BE NOTIFIED FOR LINE LOCATES AT (896) 124-4939.
3. THE CONTRACTOR SHALL CONTACT TEXAS ONE CALL SYSTEM AT 1.800.243.6545 MIN. 48 HOURS BEFORE DIGGING.
4. THE CONTRACTOR SHALL DETERMINE THE EXACT LOCATION OF ALL UTILITIES AND SHALL BE RESPONSIBLE FOR ANY DAMAGES CAUSED BY FAILURE TO BE FULLY RESPONSIBLE FOR ALL DAMAGES CAUSED BY FAILURE TO BE FULLY LOCATE AND PRESERVE ALL UNDERGROUND FACILITIES.
5. NO MORE TRENCHES OPENED AT ONE TIME THAN CAN BE BACKFILLED AND COMPACTED IN 24 HOURS AT THE END OF EACH DAY. (NO TRENCH LEFT OPENED OVERNIGHT).
6. ALL EXCESS EXCAVATION TO BE REMOVED FROM THE ROAD RIGHT-OF-WAY AT THE END OF EACH DAY.
7. DITCHES TO BE OPENED AT THE END OF EACH DAY TO ASSURE ADEQUATE DRAINAGE.
8. ROAD MUST BE KEPT OPEN TO TRAFFIC AND CONTRACTOR MUST PROVIDE ADEQUATE FLAGMEN, SIGNALS, ETC., TO PROVIDE COMPLETE SAFETY TO THE PUBLIC.
9. IF IT BECOMES NECESSARY FOR EQUIPMENT TO OPERATE ON A PORTION OF THE WATERSHED, PRECAUTIONS MUST BE TAKEN TO PREVENT ANY DAMAGE WHATSOEVER TO THE PAVEMENT.
10. CONDITION OF ROAD UPON COMPLETION OF JOB SHALL BE AS GOOD OR BETTER THAN PRIOR TO STARTING.
11. CONTRACTOR SHALL COMPLY WITH ALL APPLICABLE NATIONAL ELECTRICAL SAFETY CODE AND ANY REQUIREMENTS, CENTERPOINT ENERGY ELECTRIC POLE ATTACHMENT GUIDELINES & PROCEDURES AND ALL APPLICABLE LOCAL ATTACHMENT GUIDELINES & REGULATIONS FOR THE PROTECTION OF ACHM, CABLE FACILITIES, 18" MIN. VERTICAL CLEARANCE.
12. ALL UTILITIES WILL BE IDENTIFIED BY POT HOLE BEFORE ANY CONSTRUCTION.
13. CONCREAT WILL MAINTAIN (27") HORIZONTAL & VERTICAL SEPARATION FROM ANY EXISTING UTILITIES.
14. THE CONTRACTOR TO CONTACT WALKER COUNTY PRECINCT 4 AT LEAST 48 HOURS PRIOR TO CONSTRUCTION.

Kevin P. Leavy, PE
The Aspen Utility Company, LLC
Firm No. 23536
36502 Homestead Highway
Muckley, TX 77447
+1 (817) 463-3000

ENGINEER'S SEAL



comcast
 IF HOUSTON, LLC
 8550 W. TIDWELL RD. HOUSTON, TEXAS 77060



COMCAST PROPOSES TO PLACE DIRECTIONAL BORE 710 FT TO INSTALL FIBER OPTIC CABLE TO PROVIDE SERVICE TO 995 TX-150, NEW WAVELEY, TX 77358 INSIDE THE ROW OF THE WALKER COUNTY, TX.

JB1771404 - 995 TX-150, NEW WAVERLY, TX 77358




6502 HEMPSTEAD HWY.
HOCKLEY, TX 77447

DESIGNED BY:
QUANTA TELECOM SERVICES

DWG. NO. SHEET NO. 26 OF 45

LAMBERT, N/A
DATE: 08/18/2022
KEY MAP NO: 755
SCALE: 1:40

JB1771404 - 995 TX-150, NEW WAVERLY, TX 77358
PLAN VIEW 25 OF 41

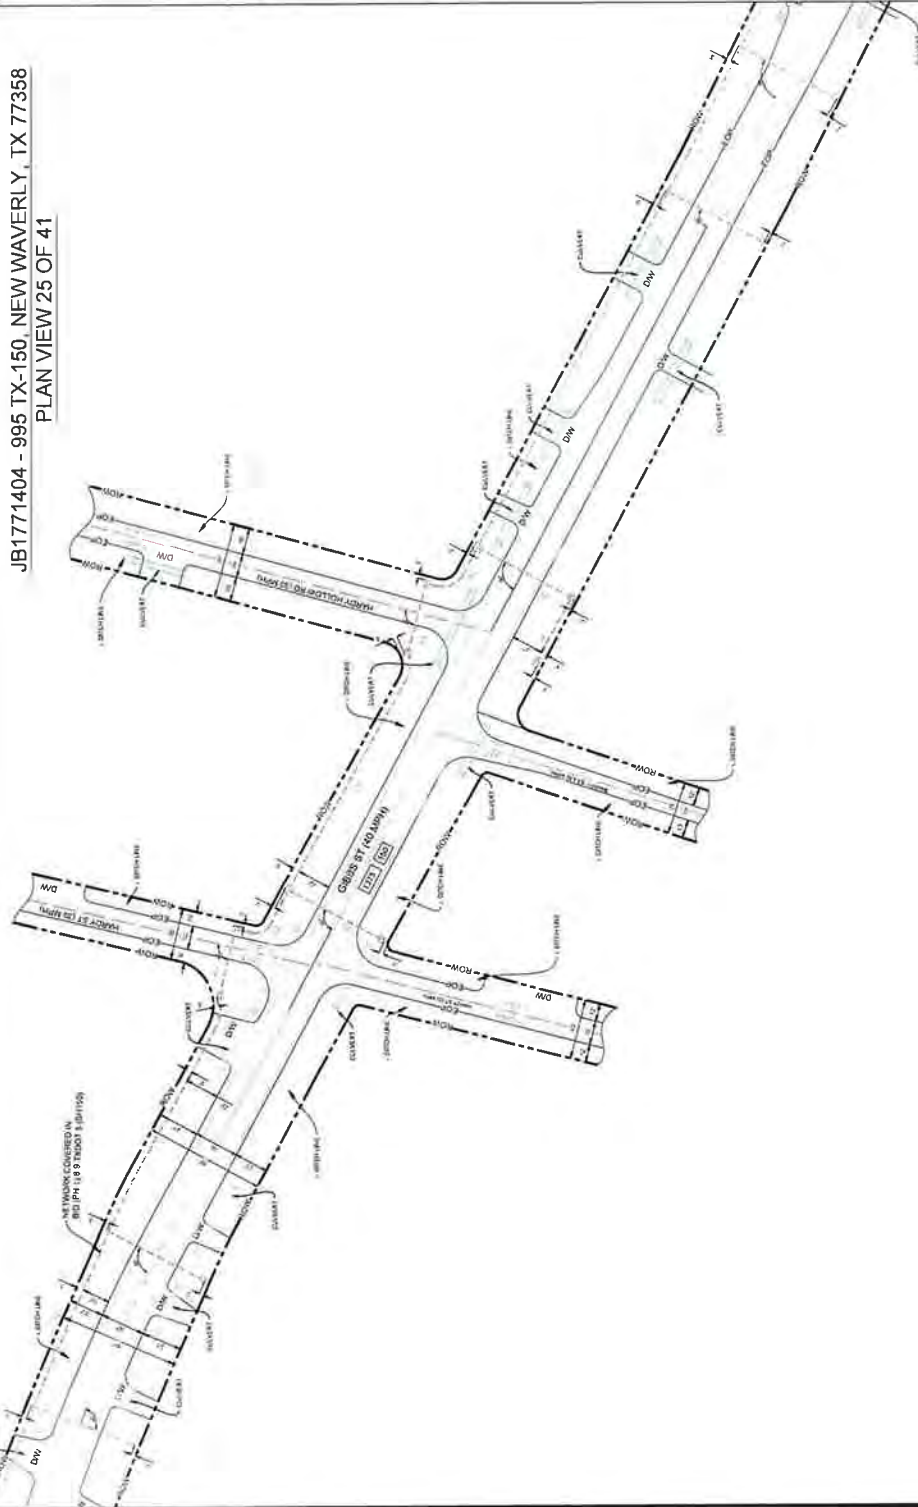

NOTES

1. THE WALKER COUNTY WILL BE NOTIFIED IN WRITING 48 HOURS PRIOR TO COMMENCING WORK.
2. THE WALKER COUNTY UTILITIES DEPARTMENT AND PUBLIC WORKS DEPARTMENT WILL BE NOTIFIED FOR LINE LOCATES AT (936) 436-4559.
3. THE CONTRACTOR SHALL CONTACT TEXAS ONE CALL SYSTEM AT 1-800-245-4545 MIN. 48 HOURS BEFORE DIGGING.
4. THE CONTRACTOR SHALL DETERMINE THE EXACT LOCATION OF ALL UNDERGROUND FACILITIES BEFORE COMMENCING WORK AND AGREE TO BE FULLY RESPONSIBLE FOR ANY DAMAGES CAUSED BY FAILURE TO LOCATE AND PRESERVE ALL UNDERGROUND FACILITIES.
5. NO MORE TRENCH OPENED AT ONE TIME THAN CAN BE BACKFILLED AND COMPLETED WITHIN 24 HOURS AT THE END OF EACH DAY. (NO TRENCH LEFT OPENED OVERNIGHT).
6. ALL EXCESS EXCAVATION TO BE REMOVED FROM THE ROAD RIGHT-OF-WAY AT THE END OF EACH DAY.
7. DITCHES TO BE OPENED AT THE END OF EACH DAY TO ASSURE ADEQUATE DRAINAGE.
8. ROAD MUST BE KEPT OPEN TO TRAFFIC AND CONTRACTOR MUST PROVIDE ADEQUATE FLAGMEN SIGNALS, ETC., TO PROVIDE COMPLETE SAFETY TO THE PUBLIC.
9. IF IT BECOMES NECESSARY FOR EQUIPMENT TO OPERATE ON A PORTION OF THE PAVEMENT, PRECAUTIONS MUST BE TAKEN TO PREVENT ANY DAMAGE WHATSOEVER TO THE PAVEMENT.
10. CONDITION OF ROAD UPON COMPLETION OF JOB SHALL BE AS GOOD OR BETTER THAN PRIOR TO STARTING.
11. CONTRACTOR SHALL COMPLY WITH ALL APPLICABLE NATIONAL ELECTRICAL SAFETY CODE (NEC) REQUIREMENTS, CENTERPOINT ENERGY REGULATORY REQUIREMENTS, AND ALL APPLICABLE LOCAL REQUIREMENTS AND REGULATIONS FOR PLACEMENT OF AERIAL CABLE FACILITIES. 18" MIN VERTICAL CLEARANCE.
12. ALL UTILITIES WILL BE IDENTIFIED BY POTHOLE BEFORE ANY CONSTRUCTION.
13. COMCAST WILL MAINTAIN (GET) HORIZONTAL & VERTICAL SEPARATION FROM ANY EXISTING UTILITIES.
14. THE CONTRACTOR TO CONTACT WALKER COUNTY PRECINCT 4 AT LEAST 48 HOURS PRIOR TO CONSTRUCTION.

Kenneth P. Lundy, PE
The Aspen Utility Company, LLC
2400 W. 2332nd
Hockley, TX 77447
+1 (281) 462-2607



LAMBERT: N/A
DATE 08/18/2025
KEY MAP NO 75K
SCALE: 1" = 40'

DESIGNED BY:
QUANTA TELECOM SERVICES

DWG. NO.
SHEET NO. 27 OF 45


ASPEN
36502 HEIMPSTEAD HWY.
HOCKLEY, TX 77447

JB1771404 - 995 TX-150, NEW WAVERLY, TX 77358

COMCAST PROPOSES TO INSTALL FIBER OPTIC CABLE
COMCAST PROPOSES TO PLACE DIRECTIONAL BORE 7.5 FT TO INSTALL FIBER OPTIC CABLE TO PROVIDE SERVICE TO 995 TX-150, NEW WAVERLY, TX 77358
INSIDE THE ROW OF THE WALKER COUNTY, TX.
TOTAL PROJECT FOOTAGE: 710'




 BY:



1. THE WALKER COUNTY WILL BE NOTIFIED IN WRITING 48 HOURS PRIOR TO COMMENCING WORK.
2. THE WALKER COUNTY UTILITIES DEPARTMENT AND PUBLIC WORKS DEPARTMENT WILL BE NOTIFIED FOR LINE LOCATES AT (936) 436-8238
3. THE CONTRACTOR SHALL CONTACT TEXAS ONE CALL SYSTEM AT 1-800-252-4525 MIN. 48 HOURS BEFORE DISINTEGRATION.
4. THE CONTRACTOR SHALL DETERMINE THE EXACT LOCATION OF ALL UTILITIES TO BE FULLY RESPONSIBLE FOR ALL DAMAGES CAUSED BY HIS FAILURE TO EXACTLY LOCATE AND PRESERVE ALL UNDERGROUND FACILITIES.
5. NO MORE TRENCH DEPTH AT ONE TIME THAT CAN BE BACKFILLED AND COMPACTED IN 10' LIFTS AT THE END OF EACH DAY. (NO TRENCH LEFT OPEN OVERNIGHT).
6. ALL EXCESS EXCAVATION TO BE REMOVED FROM THE ROAD RIGHT-OF-WAY AT THE END OF EACH DAY.
7. DITCHES TO BE OPENED AT THE END OF EACH DAY TO ASSURE ADEQUATE DRAINAGE.
8. ROAD MUST BE KEPT OPEN TO TRAFFIC AND CONTRACTOR MUST PROVIDE ADEQUATE PLACEMENT, SIGNALS, ETC., TO PROVIDE COMPLETE SAFETY TO THE PUBLIC.
9. IF IT BECOMES NECESSARY FOR EQUIPMENT TO OPERATE ON A PORTION OF THE PAVEMENT, PRECAUTIONS MUST BE TAKEN TO PREVENT ANY DAMAGE WHATSOEVER TO THE PAVEMENT.
10. CONDITION OF ROAD UPON COMPLETION OF JOB SHALL BE AS GOOD OR BETTER THAN PRIOR TO STARTING.
11. CONTRACTOR SHALL COMPLY WITH ALL APPLICABLE NATIONAL ELECTRICAL SAFETY CODE (NEC) REQUIREMENTS, CENTERPOINT ENERGY ELECTRIC POLE ATTACHMENT GUIDELINES & PROCEDURES AND ALL OTHER APPLICABLE REGULATIONS AND STANDARDS FOR THE PLACEMENT OF AERIAL CABLE FACILITIES, 18" MIN. VERTICAL CLEARANCE.
12. ALL UTILITIES WILL BE IDENTIFIED BY POT-HOLE BEFORE ANY CONSTRUCTION.
13. CONCAST WILL MAINTAIN (2FT) HORIZONTAL & VERTICAL SEPARATION FROM ANY EXISTING UTILITIES.
14. THE CONTRACTOR TO CONTACT WALKER COUNTY PRECINCT 4 AT LEAST 48 HOURS PRIOR TO CONSTRUCTION.

 8530 W. TIDWELL RD. HOUSTON, TEXAS 77060		COMCAST PROPOSES TO INSTALL FIBER OPTIC CABLE COMCAST PROPOSES TO PLACE DIRECTIONAL BORE 710 FT TO INSTALL FIBER OPTIC CABLE TO PROVIDE SERVICE TO 895 TX-150, NEW WAVERLY, TX 77582, INSIDE THE ROW OF THE VALDEZ COUNTY, TX. TOTAL PROJECT FOOTAGE 719	JB1771404 - 895 TX-150, NEW WAVERLY, TX 77538	 DESIGNED BY: QUANTA TELECOM SERVICES DATE: 04/18/2025 KEY MAP NO. 75K SCALE: 1"=40' DWG. NO. 38502 HEMPSTEAD HWY. HOCKLEY, TX 77447 SHEET NO. 28 OF 45
---	---	---	--	--

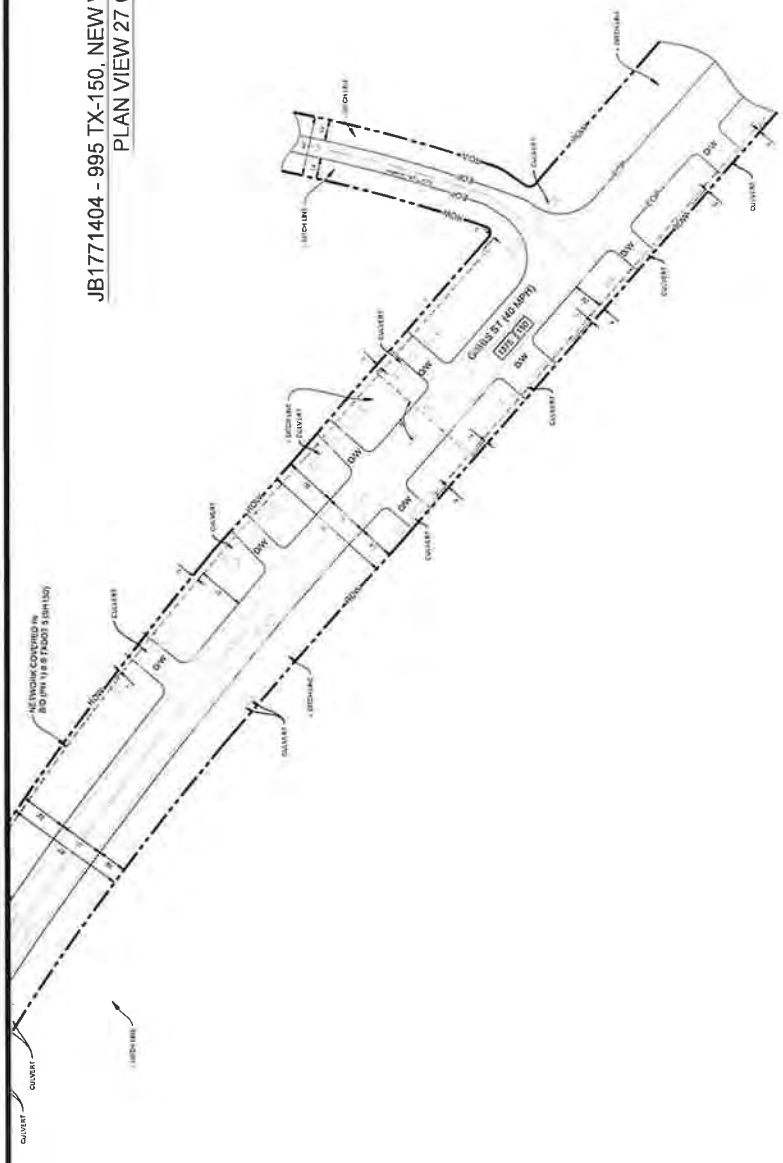

JB1771404 - 995 TX-150, NEW WAVERLY, TX 77358
PLAN VIEW 27 OF 41

NOTES:

1. THE WALKER COUNTY WILL BE NOTIFIED IN WRITING 48 HOURS PRIOR TO COMMENCING WORK.
2. THE WALKER COUNTY UTILITIES DEPARTMENT AND PUBLIC WORKS DEPARTMENT WILL BE NOTIFIED FOR LINE LOCATES AT (936) 436-3339
3. THE CONTRACTOR SHALL CONTACT TEXAS ONE CALL SYSTEM AT 1-800-254-4343 WITH 48 HOURS BEFORE DIGGING.
4. THE CONTRACTOR SHALL DETERMINE THE EXACT LOCATION OF ALL UNDERGROUND FACILITIES BEFORE COMMENCING WORK AND AGREE TO BE FULLY RESPONSIBLE FOR ALL DAMAGES CAUSED BY HIS FAILURE TO EXACTLY LOCATE AND PRESERVE ALL UNDERGROUND FACILITIES.
5. NO MORE TRENCH OPENED AT ONE TIME THAN CAN BE BACKFILLED AND COMPACTED IN 10' LIFTS AT THE END OF EACH DAY (NO TRENCH LEFT OPENED OVERNIGHT).
6. ALL EXCESS EXCAVATION TO BE REMOVED FROM THE ROAD RIGHT-OF-WAY AT THE END OF EACH DAY.
7. DITCHES TO BE OPENED AT THE END OF EACH DAY TO ASSURE ADEQUATE DRAINAGE.
8. ROAD MUST BE KEPT OPEN TO TRAFFIC AND CONTRACTOR MUST PROVIDE ADEQUATE FLAGMEN, SIGNALS, ETC. TO PROVIDE COMPLETE SAFETY TO THE PUBLIC.
9. IF IT BECOMES NECESSARY FOR EQUIPMENT TO OPERATE ON A PORTION OF THE PAVEMENT, PRECAUTIONS MUST BE TAKEN TO PREVENT ANY DAMAGE WHATSOEVER TO THE PAVEMENT.
10. CONDITION OF ROAD UPON COMPLETION OF JOB SHALL BE AS GOOD OR BETTER THAN PRIOR TO STARTING.
11. CONTRACTOR SHALL COMPLY WITH ALL APPLICABLE NATIONAL ELECTRICAL SAFETY CODE (NEC) REQUIREMENTS, CENTERPOINT ENERGY ELECTRIC POLE ATTACHMENT GUIDELINES & PROCEDURES AND ALL OTHER REQUIREMENTS FOR THE PROTECTION OF THE PUBLIC OR PLACEMENT OF AERIAL CABLE FACILITIES. 18' MIN. VERTICAL CLEARANCE.
12. ALL UTILITIES WILL BE IDENTIFIED BY POT-HOLE BEFORE ANY CONSTRUCTION.
13. COMCAST WILL MAINTAIN 8 FT. HORIZONTAL & VERTICAL SEPARATION FROM ANY EXISTING UTILITIES.
14. THE CONTRACTOR TO CONTACT WALKER COUNTY PRECINCT 4 AT LEAST 48 HOURS PRIOR TO CONSTRUCTION.

Kevin P. Lundy, PE
The Aspen Utility Company, LLC
Form No. 2836
Aspen Utility Company, Inc.
Houston, TX 77041
411 (202) 693-2891



DESIGNED BY:
QUANTA TELECOM SERVICES
DWG. NO.
SHEET NO. 29 OF 45

LAMBERT: N/A
DATE: 08/16/2025
KEY/MAP NO. 75K
SCALE: 1" = 40'

ASPEN
36502 HEMPSTEAD HWY.
HOCKLEY, TX 77447


JB1771404 - 995 TX-150, NEW WAVERLY, TX 77358

COMCAST PROPOSES TO INSTALL FIBER OPTIC CABLE
COMCAST PROPOSES TO PLACE UNDERGROUND, 8000 FT. SUBURBAN FIBER OPTIC CABLE TO PROVIDE SERVICE TO 995 TX-150, NEW WAVERLY, TX 77358
INSIDE THE ROW OF THE WALKER COUNTY, TX
TOTAL PROJECT FOOTAGE: 710



RECEIVED
SEP 02 2025
BY:

JB1771404 - 995 TX-150, NEW WAVERLY, TX 77358
PLAN VIEW 28 OF 41

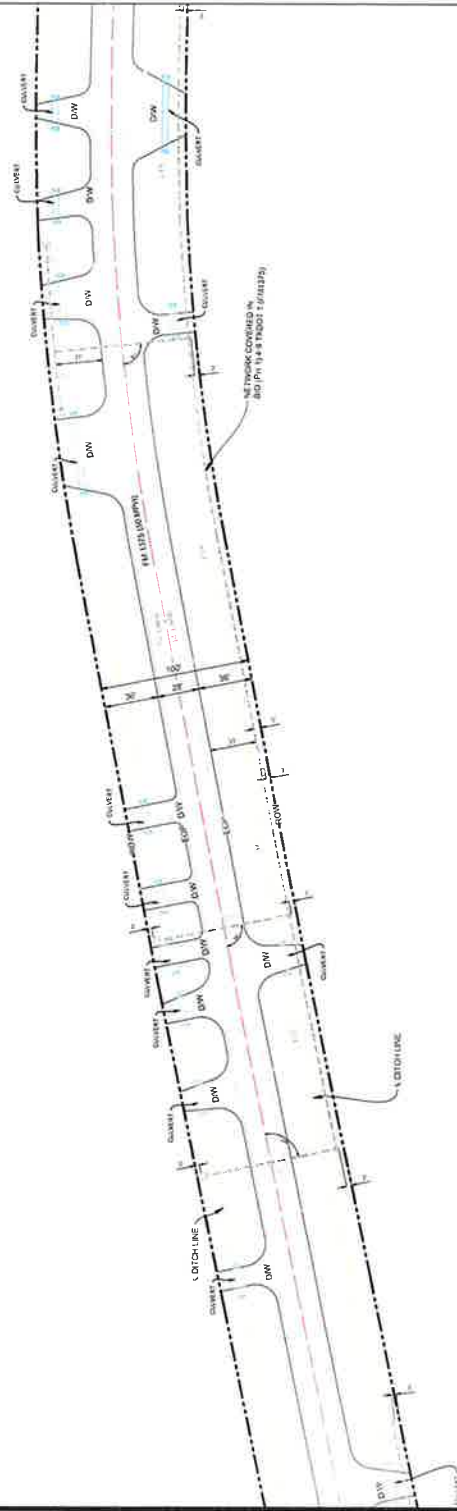

NOTES

1. THE WALKER COUNTY WILL BE NOTIFIED IN WRITING 48 HOURS PRIOR TO COMMENCING WORK.
2. THE WALKER COUNTY UTILITIES DEPARTMENT AND PUBLIC WORKS DEPARTMENT WILL BE NOTIFIED FOR LINE LOCATES AT (330) 484-0399.
3. THE CONTRACTOR SHALL CONTACT TEXAS ONE CALL SYSTEM AT 1-800-368-5868 MIN. 48 HOURS BEFORE DIGGING.
4. THE CONTRACTOR SHALL DETERMINE THE EXACT LOCATION OF ALL UNDERGROUND FACILITIES BEFORE COMMENCING WORK AND AGREE TO EXISTING FACILITIES. THE CONTRACTOR SHALL BE RESPONSIBLE TO EXACTLY LOCATE AND PRESERVE ALL UNDERGROUND FACILITIES.
5. NO MORE TRENCH OPENED AT ONE TIME THAN CAN BE BACKFILLED AND IMPACTED AT THE END OF EACH DAY. NO TRENCH LEFT OPENED OVERNIGHT.
6. ALL EXCESS EXCAVATION TO BE REMOVED FROM THE ROAD RIGHT-OF-WAY AT THE END OF EACH DAY.
7. DITCHES TO BE OPENED AT THE END OF EACH DAY TO ASSURE ADEQUATE DRAINAGE.
8. ROAD MUST BE KEPT OPEN TO TRAFFIC AND CONTRACTOR MUST PROVIDE ADEQUATE FLAGMEN, SIGNALS, ETC., TO PROVIDE COMPLETE SAFETY TO THE PUBLIC.
9. IF IT BECOMES NECESSARY FOR EQUIPMENT TO OPERATE ON A PORTION OF THE ROAD, THE CONTRACTOR SHALL BE TAKEN TO PREVENT ANY DAMAGE WHATSOEVER TO THE PAVEMENT.
10. CONDITION OF ROAD UPON COMPLETION OF JOB SHALL BE AS GOOD OR BETTER THAN PRIOR TO STARTING.
11. CONTRACTOR SHALL COMPLY WITH ALL APPLICABLE NATIONAL ELECTRICAL SAFETY CODE (NEC) REQUIREMENTS, CENTERPOINT UTILITY REQUIREMENTS, AND ALL APPLICABLE LOCAL REQUIREMENTS AND REGULATIONS FOR PLACEMENT OF AERIAL CABLE FACILITIES, 18" MIN. VERTICAL CLEARANCE.
12. ALL UTILITIES WILL BE IDENTIFIED BY POTHOLE BEFORE ANY CONSTRUCTION.
13. COMCAST WILL MAINTAIN 6FT HORIZONTAL & VERTICAL SEPARATION FROM ANY EXISTING UTILITIES.
14. THE CONTRACTOR TO CONTACT WALKER COUNTY PRECINCT 4 AT LEAST 48 HOURS PRIOR TO CONSTRUCTION.

Kevin P. Lasky PE
The Aspen Utility Company, LLC
36502 Hempstead Highway
Rockley, TX 77447
+1 (282) 694-3881



COMCAST PROPOSES TO INSTALL FIBER OPTIC CABLE
COMCAST PROPOSES TO PLACE DIRECTIONAL BORE 110 FT TO INSTALL FIBER OPTIC CABLE TO PLACE SERVICE TO MAINLINE NEW WAVERLY, TX 77358, INSIDE THE RIGHT OF THE WALKER COUNTY, TX.
TOTAL PROJECT FOOTAGE 710'

JB1771404 - 995 TX-150, NEW WAVERLY, TX 77358




DESIGNED BY:
QUANTA TELECOM SERVICES
DWG. NO.
SHEET NO. 30 OF 45



JB1771404 - 995 TX-150, NEW WAVERLY, TX 77358


PLAN VIEW 29 OF 41

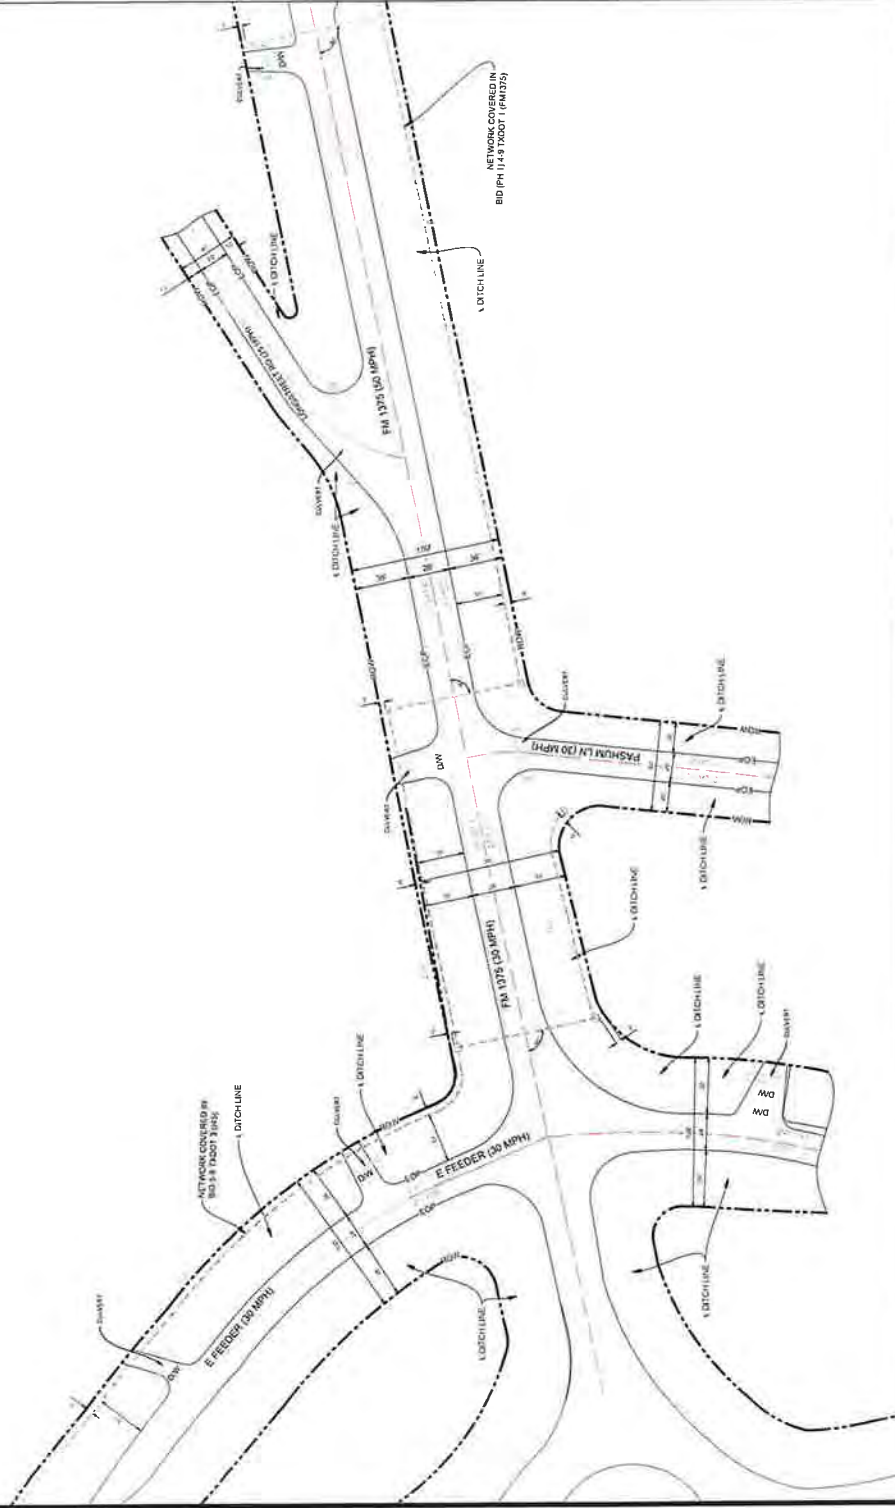

NOTES

1. THE WALKER COUNTY WILL BE NOTIFIED IN WRITING 48 HOURS PRIOR TO COMMENCING WORK.
2. THE WALKER COUNTY UTILITIES DEPARTMENT AND PUBLIC WORKS DEPARTMENT WILL BE NOTIFIED FOR LINE LOCATES AT (580) 436-4939
3. THE CONTRACTOR SHALL CONTACT TEXAS ONE CALL SYSTEM AT 1-800-345-4545 24 HRS. 48 HOURS BEFORE DIGGING.
4. THE CONTRACTOR SHALL DETERMINE THE EXACT LOCATION OF ALL UNDERGROUND FACILITIES BEFORE COMMENCING WORK AND AGREE TO BE FULLY RESPONSIBLE FOR ALL DAMAGES CAUSED BY HIS FAILURE TO EXACTLY LOCATE AND PRESERVE ALL UNDERGROUND FACILITIES
5. NO MORE TRENCH OPENED AT ONE TIME THAN CAN BE BACKFILLED AND COMPACTED IN 10' LIFTS AT THE END OF EACH DAY (NO TRENCH LEFT OPENED OVERNIGHT)
6. ALL EXCESS EXCAVATION TO BE REMOVED FROM THE ROAD RIGHT-OF-WAY AT THE END OF EACH DAY
7. DITCHES TO BE OPENED AT THE END OF EACH DAY TO ASSURE ADEQUATE DRAINAGE
8. ROAD MUST BE KEPT OPEN TO TRAFFIC AND CONTRACTOR MUST PROVIDE ADEQUATE FLAGMEN, SIGNALS, ETC. TO PROVIDE COMPLETE SAFETY TO THE PUBLIC.
9. IF IT BECOMES NECESSARY FOR EQUIPMENT TO OPERATE ON A PORTION OF THE PAVEMENT, PRECAUTIONS MUST BE TAKEN TO PREVENT ANY DAMAGE WHATSOEVER TO THE PAVEMENT
10. CONDITION OF ROAD UPON COMPLETION OF JOB SHALL BE AS GOOD OR BETTER THAN PRIOR TO STARTING.
11. CONTRACTOR SHALL COMPLY WITH ALL APPLICABLE NATIONAL ELECTRICAL SAFETY CODE (NEC) REQUIREMENTS, CENTERPOINT ENERGY ELECTRIC POLE ATTACHMENT GUIDELINES & PROCEDURES AND ALL OTHER REQUIREMENTS FOR THE PROTECTION OF THE PLACEMENT OF AERIAL CABLE FACILITIES. 18" MIN. VERTICAL CLEARANCE
12. ALL UTILITIES WILL BE IDENTIFIED BY POT-HOLE BEFORE ANY CONSTRUCTION
13. COMCAST WILL MAINTAIN (87") HORIZONTAL & VERTICAL SEPARATION FROM ANY EXISTING UTILITIES
14. THE CONTRACTOR TO CONTACT WALKER COUNTY PRECINCT 4 AT LEAST 48 HOURS PRIOR TO CONSTRUCTION

Mark P. Lundy PE
The Aspen Lane Company, LLC
Firm No. 253-8
14000 Highway 190
Houston, TX 77044
+1 (713) 453 3450

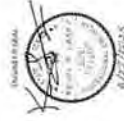

DESIGNED BY:
QUANTA TELECOM SERVICES
DWG. NO.
SHEET NO. 31 OF 45


ASPEN
A Synergistic Engineering Company
36502 HEMPSTEAD HWY.
HOCKLEY, TX 77447

JB1771404 - 995 TX-150, NEW WAVERLY, TX 77358

COMCAST PROPOSES TO INSTALL FIBER OPTIC CABLE
COMCAST PROPOSES TO PLACE DIRECTIONAL ASSES AND TO INSTALL FIBER
OPTIC CABLE TO PROVIDE SERVICE TO 995 TX-150, NEW WAVERLY, TX 77358
INSIDE THE ROW OF THE WALKER COUNTY, TX
TOTAL PROJECT FOOTAGE: 310'



LAMBERT: N/A
DATE: 08/19/2025
KEY MAP NO: 73K
SCALE: 1"=40'

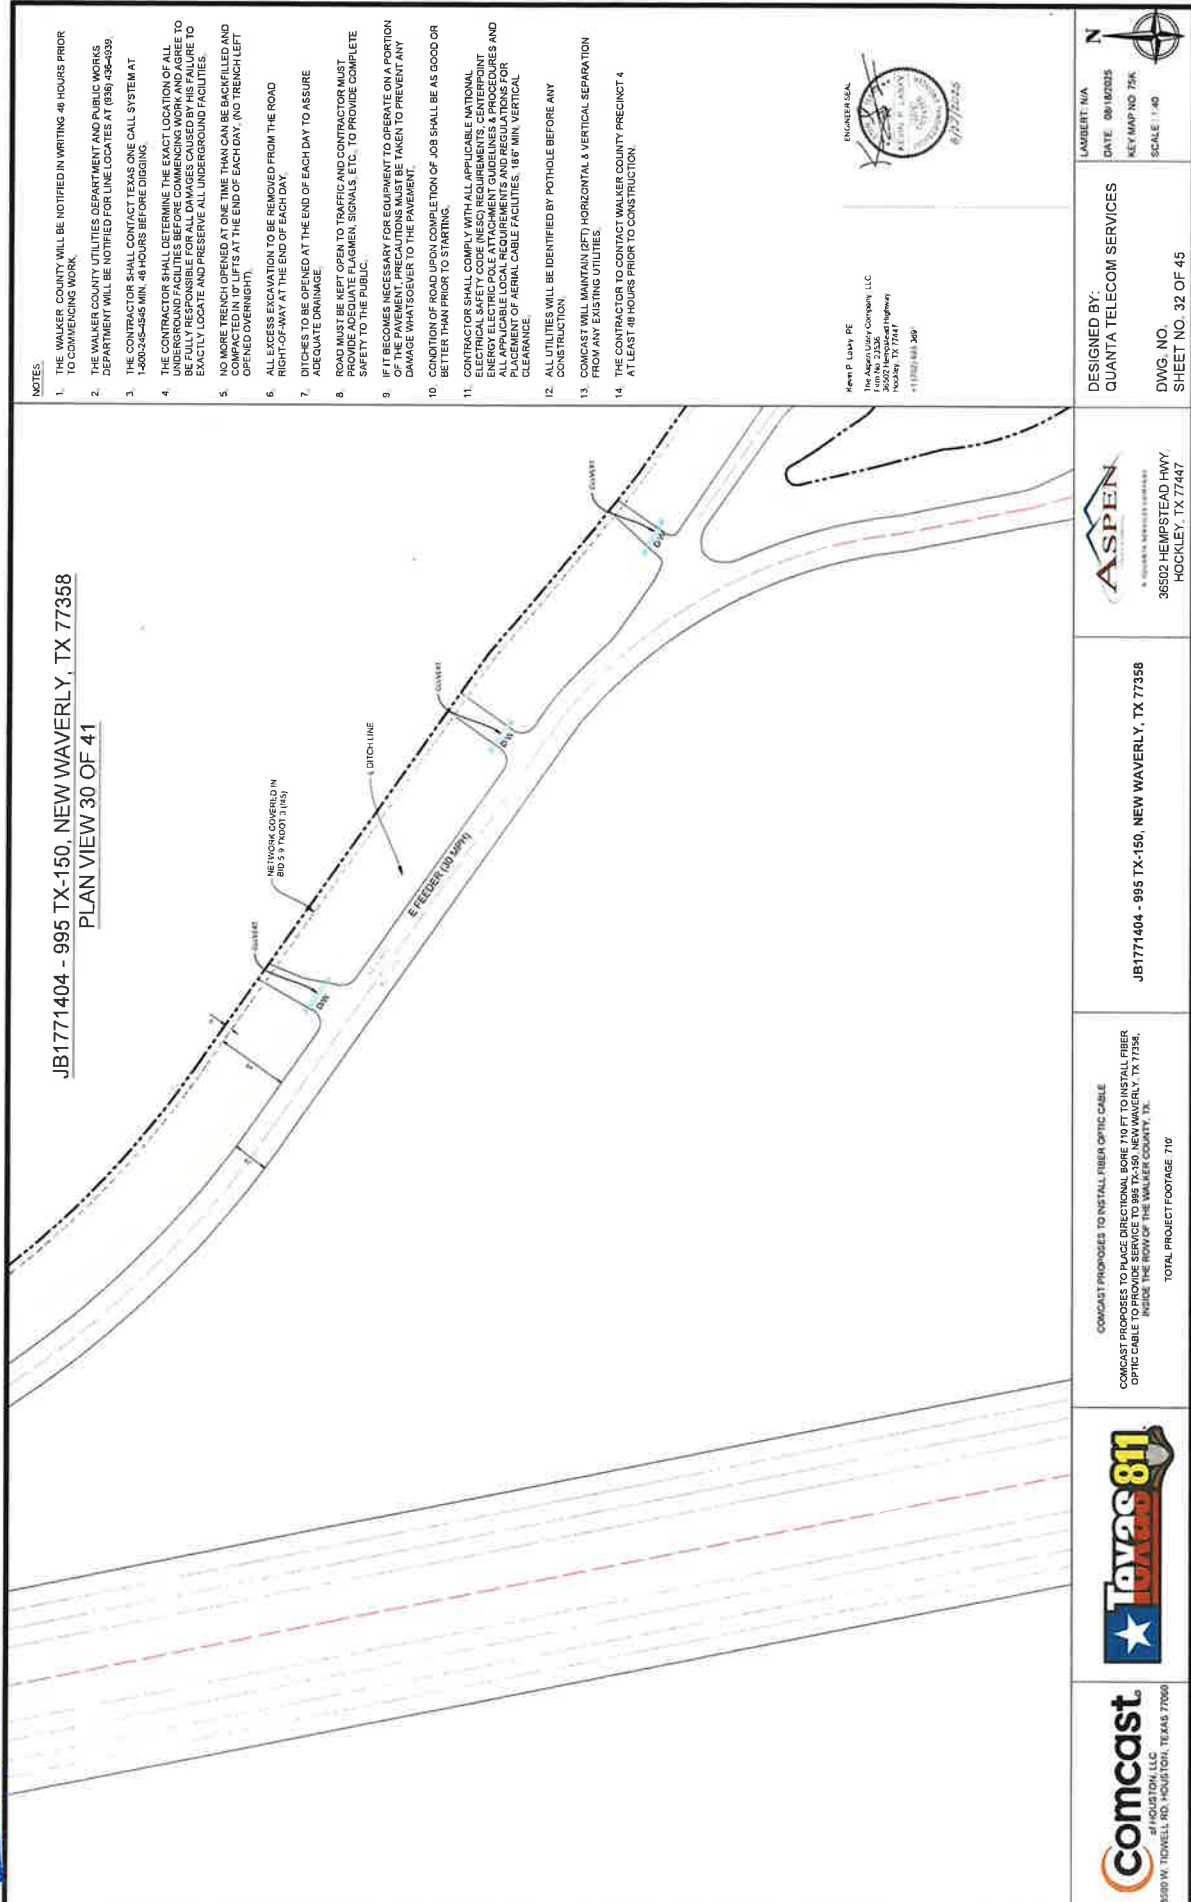


JB1771404 - 995 TX-150, NEW WAVERLY, TX 77358
PLAN VIEW 30 OF 41

NOTES

1. THE WALKER COUNTY WILL BE NOTIFIED IN WRITING 48 HOURS PRIOR TO COMMENCING WORK.
2. THE WALKER COUNTY UTILITIES DEPARTMENT AND PUBLIC WORKS DEPARTMENT WILL BE NOTIFIED FOR LINE LOCATES AT (936) 446-0339.
3. THE CONTRACTOR SHALL CONTACT TEXAS ONE CALL SYSTEM AT 1-888-333-4545 MIN. 48 HOURS BEFORE DIGGING.
4. THE CONTRACTOR SHALL DETERMINE THE EXACT LOCATION OF ALL UTILITIES TO BE RESPONSIBLE FOR ALL UNDERGROUNDS CAUSED BY HIS FAILURE TO BE EXACTLY LOCATE AND PRESERVE ALL UNDERGROUND FACILITIES.
5. NO MORE TRENCH OPENED AT ONE TIME THAN CAN BE BACKFILLED AND COMPACTED IN 10 LIFTS AT THE END OF EACH DAY. (NO TRENCH LEFT OPENED OVERNIGHT).
6. ALL EXCESS EXCAVATION TO BE REMOVED FROM THE ROAD RIGHT-OF-WAY AT THE END OF EACH DAY.
7. DITCHES TO BE OPENED AT THE END OF EACH DAY TO ASSURE ADEQUATE DRAINAGE.
8. ROAD MUST BE KEPT OPEN TO TRAFFIC AND CONTRACTOR MUST PROVIDE ADEQUATE FLAGMEN, SIGNALS, ETC., TO PROVIDE COMPLETE SAFETY TO THE PUBLIC.
9. IF IT BECOMES NECESSARY FOR EQUIPMENT TO OPERATE ON A PORTION OF THE PAVEMENT, PRECAUTIONS MUST BE TAKEN TO PREVENT ANY DAMAGE WHATSOEVER TO THE PAVEMENT.
10. CONDITION OF ROAD UPON COMPLETION OF JOB SHALL BE AS GOOD OR BETTER THAN PRIOR TO STARTING.
11. CONTRACTOR SHALL COMPLY WITH ALL APPLICABLE NATIONAL ELECTRICAL, SAFETY CODE (NEC) REQUIREMENTS, CENTERPOINT ENERGY ELECTRIC POLE ATTACHMENT GUIDELINES & PROCEDURES AND ALL OTHER APPLICABLE REGULATIONS AND STANDARDS FOR THE PROPER PLACEMENT OF AERIAL CABLE FACILITIES, 18" MIN. VERTICAL CLEARANCE.
12. ALL UTILITIES WILL BE IDENTIFIED BY POT HOLE BEFORE ANY CONSTRUCTION.
13. CONTRACT WILL MAINTAIN (RTT) HORIZONTAL & VERTICAL SEPARATION FROM ANY EXISTING UTILITIES.
14. THE CONTRACTOR TO CONTACT WALKER COUNTY PRECINCT 4 AT LEAST 48 HOURS PRIOR TO CONSTRUCTION.

Kevin P. Lohry, PE
The Aspen Utility Company, LLC
400 N. 235th St.
36502 Hempstead Highway
Rockley, TX 77447
214.232.84.3691

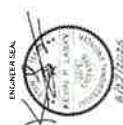

comcast
of HOUSTON, LLC
5650 W. TIDWELL RD., HOUSTON, TEXAS 77060



COMCAST PROPOSES TO INSTALL FIBER OPTIC CABLE
COMCAST PROPOSES TO PLACE DIRECTIONAL BORE 710 FT TO INSTALL FIBER
OPTIC CABLE TO PROVIDE SERVICE TO 995 TX-150, NEW WAVERLY, TX 77358,
INSIDE THE ROW OF THE WALKER COUNTY, TX.

JIB1771404 - 995 TX-150, NEW WAVERLY, TX 77358



36502 HEMPSTEAD HWY
HOCKLEY, TX 77447

DESIGNED BY:
QUANTA TELECOM SERVICES

DWG. NO.
SHEET NO. 32 OF 45


LAURENT N/A

© 2000 Blackwell Science Ltd
Journal of Internal Medicine 247: 111–117

DATE 06/10/2015

KEY MAP NO. 75K



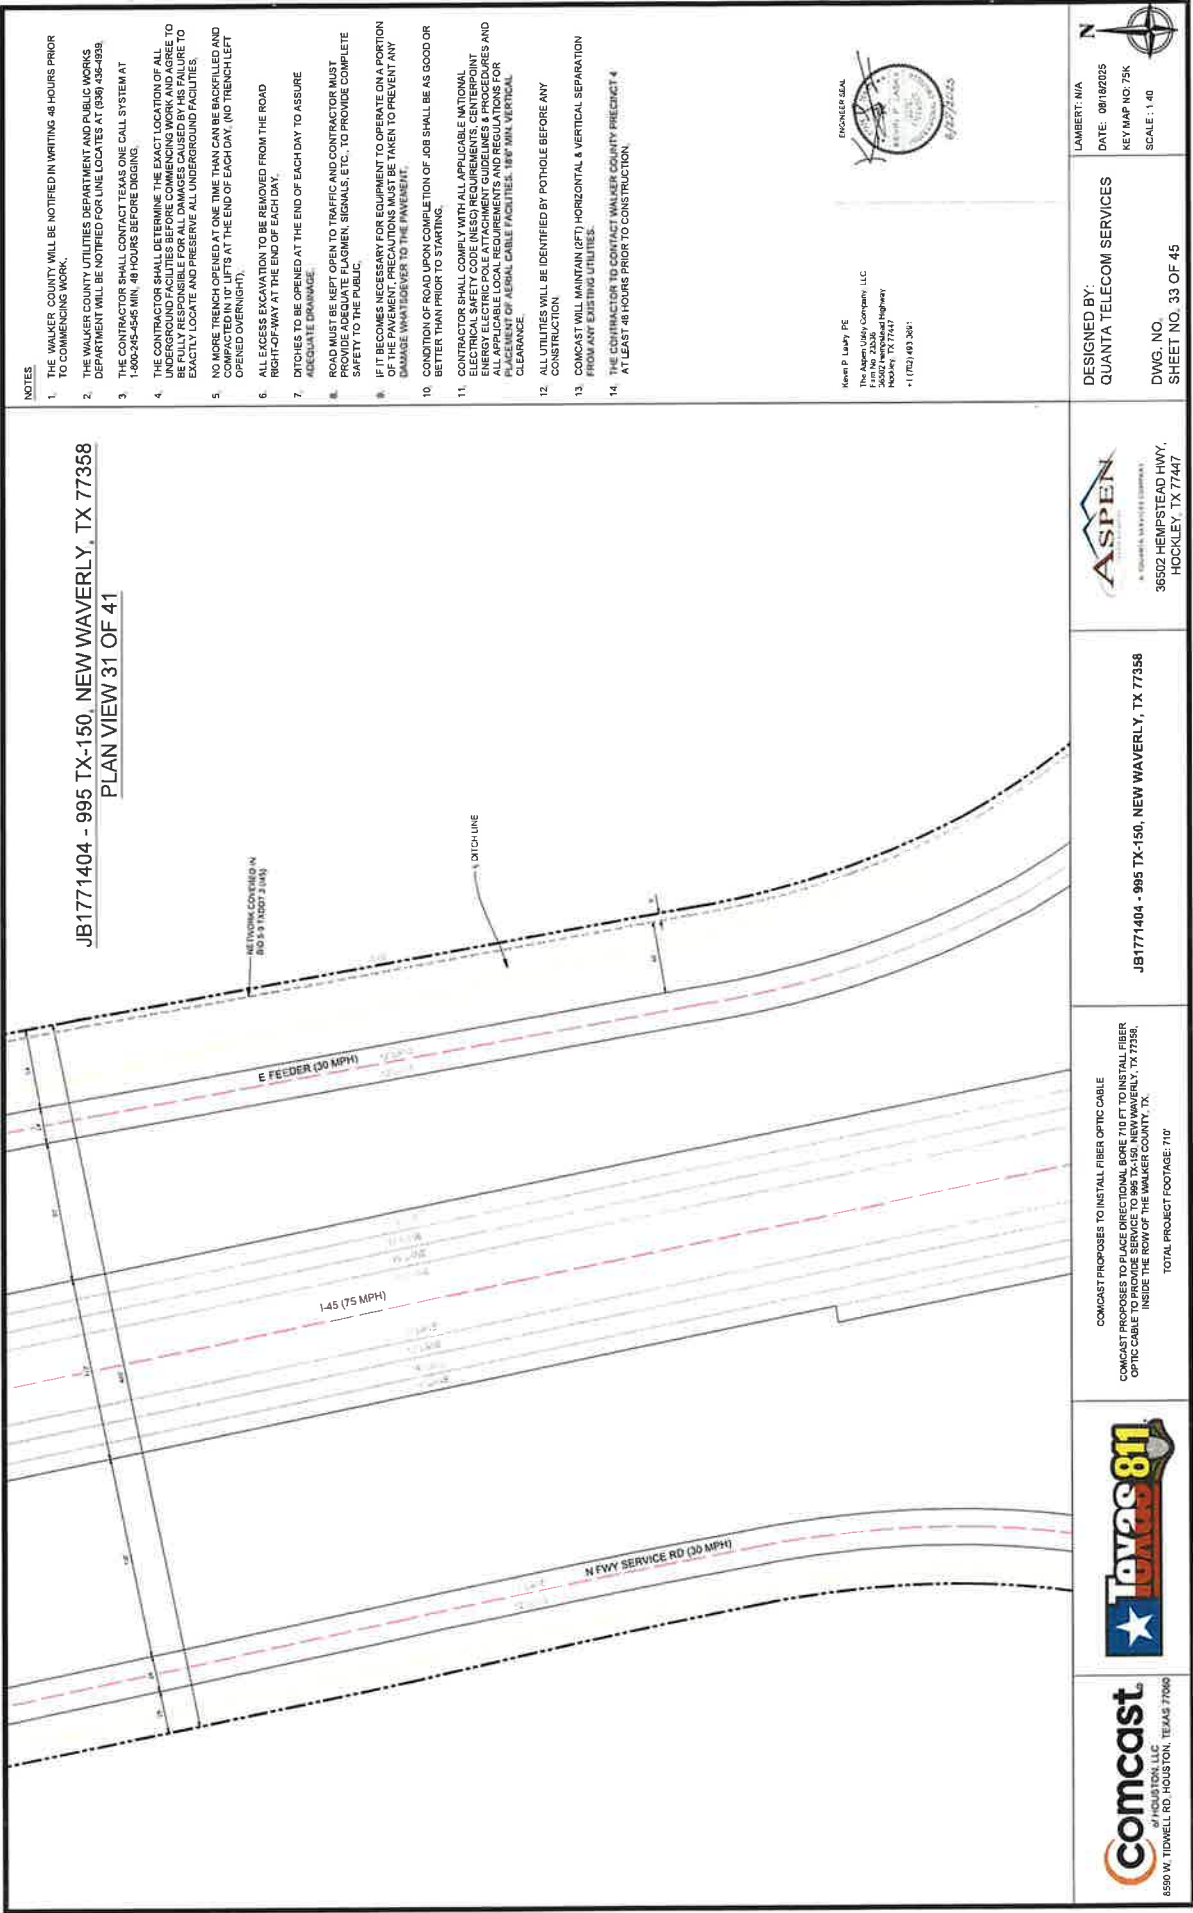

RECEIVED
SEP 02 2025
BY:.....

JB1771404 - 995 TX-150, NEW WAVERLY, TX 77358
PLAN VIEW 32 OF 41



NOTES

1. THE WALKER COUNTY WILL BE NOTIFIED IN WRITING 48 HOURS PRIOR TO COMMENCING WORK.
2. THE WALKER COUNTY UTILITIES DEPARTMENT AND PUBLIC WORKS DEPARTMENT WILL BE NOTIFIED FOR LINE LOCATES AT (936) 456-1939.
3. THE CONTRACTOR SHALL CONTACT TEXAS ONE CALL SYSTEM AT 1-800-345-4545 MIN. 48 HOURS BEFORE DIGGING.
4. THE CONTRACTOR SHALL DETERMINE THE EXACT LOCATION OF ALL UNDERGROUND FACILITIES BEFORE COMMENCING WORK AND AGREE TO BE FULLY RESPONSIBLE FOR ALL DAMAGES CAUSED BY HIS FAILURE TO EXACTLY LOCATE AND PRESERVE ALL UNDERGROUND FACILITIES.
5. NO MORE TRENCH OPENED AT ONE TIME THAN CAN BE BACKFILLED AND RECLOSED WITHIN 24 HOURS OF THE END OF EACH DAY. (NO TRENCH LEFT OPENED OVERNIGHT).
6. ALL EXCESS EXCAVATION TO BE REMOVED FROM THE ROAD RIGHT-OF-WAY AT THE END OF EACH DAY.
7. DITCHES TO BE OPENED AT THE END OF EACH DAY TO ASSURE ADEQUATE DRAINAGE.
8. ROAD MUST BE KEPT OPEN TO TRAFFIC AND CONTRACTOR MUST PROVIDE ADEQUATE FLAGMEN, SIGNALS, ETC. TO PROVIDE COMPLETE SAFETY TO THE PUBLIC.
9. IF IT BECOMES NECESSARY FOR EQUIPMENT TO OPERATE ON A PORTION OF THE PAVEMENT, PRECAUTIONS MUST BE TAKEN TO PREVENT ANY DAMAGE WHATSOEVER TO THE PAVEMENT.
10. CONDITION OF ROAD UPON COMPLETION OF JOB SHALL BE AS GOOD OR BETTER THAN PRIOR TO STARTING.
11. CONTRACTOR SHALL COMPLY WITH ALL APPLICABLE NATIONAL ELECTRICAL SAFETY CODE (NEC) REQUIREMENTS, CENTERPOINT ELECTRICITY DELIVERY AND DISTRIBUTION RULES & PROCEDURES AND ALL APPLICABLE LOCAL REQUIREMENTS AND REGULATIONS FOR THE PLACEMENT OF AERIAL CABLE FACILITIES. 18" MIN. VERTICAL CLEARANCE.
12. ALL UTILITIES WILL BE IDENTIFIED BY POT-HOLE BEFORE ANY CONSTRUCTION.
13. CONCAST WILL MAINTAIN BOTH HORIZONTAL & VERTICAL SEPARATION FROM ANY EXISTING UTILITIES.
14. THE CONTRACTOR TO CONTACT WALKER COUNTY PRECINCT 4 AT LEAST 48 HOURS PRIOR TO CONSTRUCTION.



Kevin P. Lashy - PE
The Aspen Utility Company, LLC
1000 N. 230th St.
Hockley, TX 77447
+1 (281) 492-3461



CONCAST PROPOSES TO INSTALL FIBER OPTIC CABLE
CONCAST PROPOSES TO PLACE DIRECTIONAL BORE 710 FT TO INSTALL FIBER OPTIC CABLE TO PROVIDE SERVICE TO 995 TX-150, NEW WAVERLY, TX 77358. IN THE ROW OF THE WALKER COUNTY, TX.
TOTAL PROJECT FOOTAGE: 710'

JB1771404 - 995 TX-150, NEW WAVERLY, TX 77358




98502 HEMPSTEAD HWY.
HOCKLEY, TX 77447

DESIGNED BY:
QUANTA TELECOM SERVICES

DATE: 06/18/2025
KEY MAP NO 75K
SCALE: 1:40

DWG. NO. 34 OF 45
SHEET NO. 34 OF 45

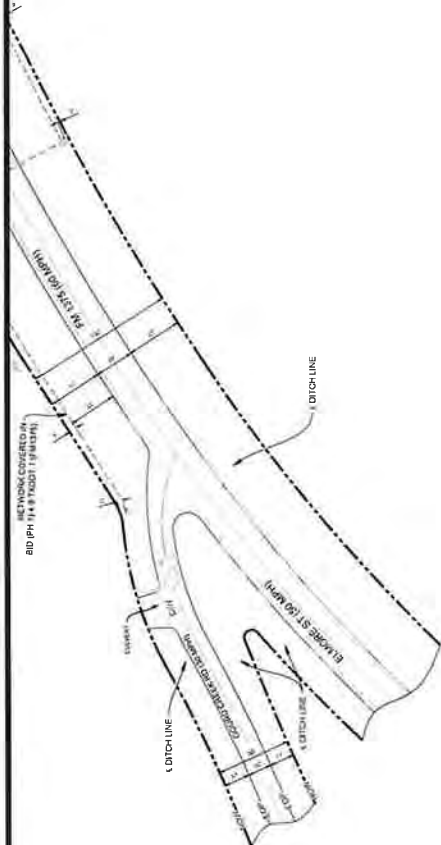


JB1771404 - 995 TX-150, NEW WAVERLY, TX 77358
PLAN VIEW 33 OF 41

NOTES

1. THE WALKER COUNTY WILL BE NOTIFIED IN WRITING 48 HOURS PRIOR TO COMMENCING WORK.
2. THE WALKER COUNTY UTILITIES DEPARTMENT AND PUBLIC WORKS DEPARTMENT WILL BE NOTIFIED FOR LINE LOCATES AT (838) 436-4399.
3. THE CONTRACTOR SHALL CONTACT TEXAS ONE CALL SYSTEM AT 1-800-245-4545 MIN 48 HOURS BEFORE DIGGING.
4. THE CONTRACTOR SHALL DETERMINE THE EXACT LOCATION OF ALL UNDERGROUND FACILITIES BEFORE COMMENCING WORK AND AGREE TO BE FULLY RESPONSIBLE FOR ALL DAMAGES CAUSED BY HIS FAILURE TO EXACTLY LOCATE AND PRESERVE ALL UNDERGROUND FACILITIES.
5. NO MORE TRENCH OPENED AT ONE TIME THAN CAN BE BACKFILLED AND COMPACTED IN 10' LIFTS AT THE END OF EACH DAY (NO TRENCH LEFT OPENED OVERNIGHT).
6. ALL EXCESS EXCAVATION TO BE REMOVED FROM THE ROAD RIGHT-OF-WAY AT THE END OF EACH DAY.
7. DITCHES TO BE OPENED AT THE END OF EACH DAY TO ASSURE ADEQUATE DRAINAGE.
8. ROAD MUST BE KEPT OPEN TO TRAFFIC AND CONTRACTOR MUST PROVIDE ADEQUATE FLAGMEN, SIGNALS, ETC., TO PROVIDE COMPLETE SAFETY TO THE PUBLIC.
9. IF IT BECOMES NECESSARY FOR EQUIPMENT TO OPERATE ON A PORTION OF THE PAVEMENT, PRECAUTIONS MUST BE TAKEN TO PREVENT ANY DAMAGE WHATSOEVER TO THE PAVEMENT.
10. CONDITION OF ROAD UPON COMPLETION OF JOB SHALL BE AS GOOD OR BETTER THAN PRIOR TO STARTING.
11. CONTRACTOR SHALL COMPLY WITH ALL APPLICABLE NATIONAL ELECTRICAL SAFETY CODE (NEC) REQUIREMENTS, CENTERPOINT ENERGY ELECTRIC POLE ATTACHMENT GUIDELINES & PROCEDURES AND ALL APPLICABLE LOCAL ORDINANCES AND REGULATIONS ON PLACEMENT OF AERIAL CABLE FACILITIES, 18" MIN VERTICAL CLEARANCE.
12. ALL UTILITIES WILL BE IDENTIFIED BY POT-HOLE BEFORE ANY CONSTRUCTION.
13. CONTRACTOR WILL MAINTAIN (2FT) HORIZONTAL & VERTICAL SEPARATION FROM ANY EXISTING UTILITIES.
14. THE CONTRACTOR TO CONTACT WALKER COUNTY PRECINCT 4 AT LEAST 48 HOURS PRIOR TO CONSTRUCTION.

Kenneth P. Luby, PE
The Aspen Utility Company, LLC
Firm No. 22582
36502 Hempstead Highway
Hockley, TX 77447
+1 (281) 463-2907

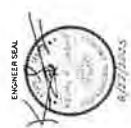

DESIGNED BY:
QUANTA TELECOM SERVICES

DWG. NO.
SHEET NO. 35 OF 45

DATE: 08/18/2023
KEY MAP NO. 734
SCALE: 1"=40'

ASPEN
36502 HEMPSTEAD HWY.
HOCKLEY, TX 77447

JB1771404 - 995 TX-150, NEW WAVERLY, TX 77358


COMCAST PROPOSES TO INSTALL FIBER OPTIC CABLE
COMCAST PROPOSES TO PLACE DIRECTIONAL BORE 100 FT TO INSTALL FIBER
OPTIC CABLE INSIDE THE ROW OF THE WALKER COUNTY, TX.
TOTAL PROJECT FOOTAGE: 210'

Texas 811

Comcast
6390 W. TIDWELL RD HOUSTON, TEXAS 77060

RECEIVED
SEP 02 2025
BY.

JB1771404 - 995 TX-150, NEW WAVERLY, TX 77358
PLAN VIEW 34 OF 41

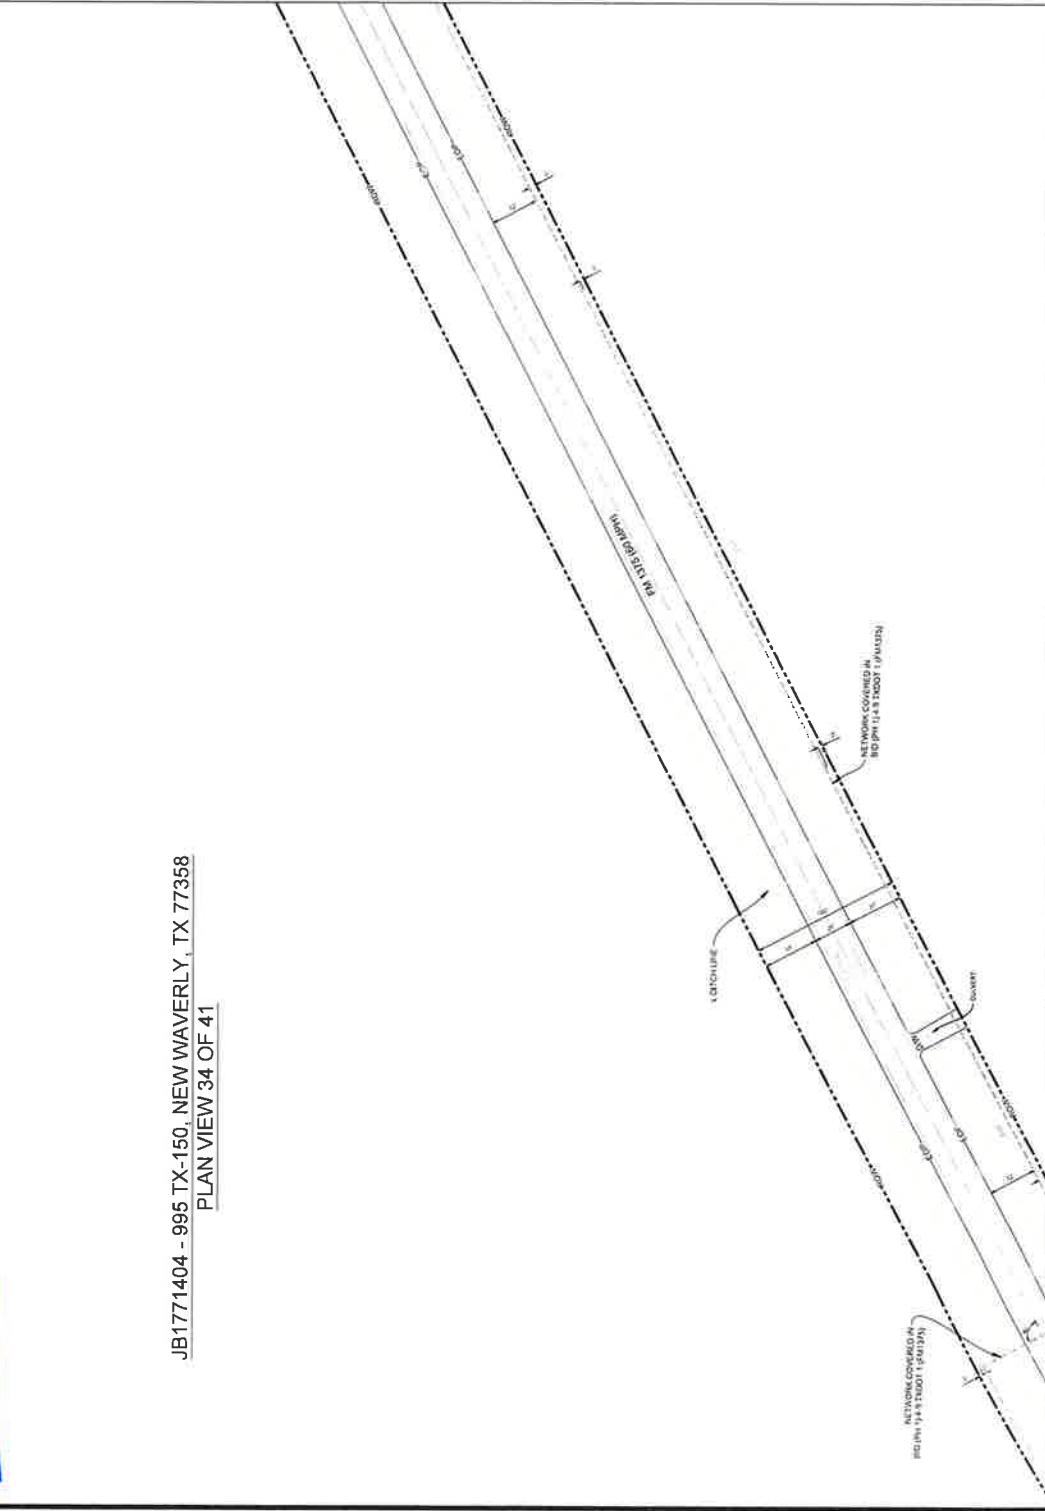

- NOTES
1. THE WALKER COUNTY WILL BE NOTIFIED IN WRITING 48 HOURS PRIOR TO COMMENCING WORK.
 2. THE WALKER COUNTY UTILITIES DEPARTMENT AND PUBLIC WORKS DEPARTMENT WILL BE NOTIFIED FOR LINE LOCATES AT (950) 434-4993.
 3. THE CONTRACTOR SHALL CONTACT TEXAS ONE CALL SYSTEM AT 1-800-245-4545 MIN. 48 HOURS BEFORE DIGGING.
 4. THE CONTRACTOR SHALL DETERMINE THE EXACT LOCATION OF ALL UNDERGROUND FACILITIES BEFORE COMMENCING WORK AND AGREE TO BE FULLY RESPONSIBLE FOR ALL DAMAGES CAUSED BY HIS FAILURE TO EXACTLY LOCATE AND PRESERVE ALL UNDERGROUND FACILITIES.
 5. NO MORE TRENCH OPENED AT ONE TIME THAN CAN BE BACKFILLED AND COMPACTED WITHIN 24 HOURS AT THE END OF EACH DAY. (NO TRENCH LEFT OPENED OVERNIGHT).
 6. ALL EXCESS EXCAVATION TO BE REMOVED FROM THE ROAD RIGHT-OF-WAY AT THE END OF EACH DAY.
 7. DITCHES TO BE OPENED AT THE END OF EACH DAY TO ASSURE ADEQUATE DRAINAGE.
 8. ROAD MUST BE KEPT OPEN TO TRAFFIC AND CONTRACTOR MUST PROVIDE ADEQUATE FLAGMEN, SIGNALS, ETC. TO PROVIDE COMPLETE SAFETY TO THE PUBLIC.
 9. IF IT BECOMES NECESSARY FOR EQUIPMENT TO OPERATE ON A PORTION OF THE PAVEMENT, PRECAUTIONS MUST BE TAKEN TO PREVENT ANY DAMAGE WHATSOEVER TO THE PAVEMENT.
 10. CONDITION OF ROAD UPON COMPLETION OF JOB SHALL BE AS GOOD OR BETTER THAN PRIOR TO STARTING.
 11. CONTRACTOR SHALL COMPLY WITH ALL APPLICABLE NATIONAL ELECTRICAL SAFETY CODE (NEC) REQUIREMENTS, CENTERPOINT ENERGY COMPANY REGULATIONS, AND ALL APPLICABLE LOCAL ORDINANCES AND REGULATIONS FOR THE PROTECTION OF AERIAL CABLE FACILITIES. 18\"/>
 12. ALL UTILITIES WILL BE IDENTIFIED BY POT HOLE BEFORE ANY CONSTRUCTION.
 13. COMCAST WILL MAINTAIN 6 FT HORIZONTAL & VERTICAL SEPARATION FROM ANY EXISTING UTILITIES.
 14. THE CONTRACTOR TO CONTACT WALKER COUNTY PRECINCT 4 AT LEAST 48 HOURS PRIOR TO CONSTRUCTION.

Kevin P. Leary PE
The Aspen Utility Company, LLC
2000 W. 235th St.
Waverly, TX 77487
(937) 693-2067

ENGINEER SEAL
KEVIN P. LEARY
6/17/2025

 8580 W. JIDWELL RD HOUSTON, TEXAS 77066		COMCAST PROPOSES TO INSTALL FIBER OPTIC CABLE COMCAST PROPOSES TO PLACE DIRECTIONAL BORE 710 FT TO INSTALL FIBER OPTIC CABLE TO PROVIDE SERVICE TO 995 TX-150, NEW WAVERLY, TX 77358, INSIDE THE ROW OF THE WALKER COUNTY, TX. TOTAL PROJECT FOOTAGE: 710'	JB1771404 - 995 TX-150, NEW WAVERLY, TX 77358	 36502 HEMPSTEAD HWY, HOCKLEY TX 77447	DESIGNED BY: QUANTA TELECOM SERVICES DWC. NO. SHEET NO. 36 OF 45	LAMBERT N/A DATE: 08/10/2025 KEY MAP NO. 75K SCALE: 1" = 40'
--	---	--	---	---	---	---

[illegible]

1. THE WALKER COUNTY WILL BE NOTIFIED IN WRITING 48 HOURS PRIOR TO COMMENCING WORK.
2. THE WALKER COUNTY UTILITIES DEPARTMENT AND PUBLIC WORKS DEPARTMENT WILL BE NOTIFIED FOR LINE LOCATES AT (920) 434-4329
3. THE CONTRACTOR SHALL CONDUCT REASONS ONE CALL SYSTEM AT 48-52-54-56 MIN. IN ADVANCE BEFORE BEGINNING.
4. THE CONTRACTOR SHALL DETERMINE THE EXACT LOCATION OF ALL UTILITIES TO BE FULLY RESPONSIBLE FOR ALL DAMAGES CAUSED BY HIS FAILURE TO EXACTLY LOCATE AND PRESERVE ALL UNDERGROUND FACILITIES
5. NO MORE TRENCH OPENED AT ONE TIME THAN CAN BE BACKFILLED AND COMPACTED IN 14 LIFTS AT THE END OF EACH DAY (NO TRENCH LEFT OPENED OVERNIGHT)
6. ALL EXCESS EXCAVATION TO BE REMOVED FROM THE ROAD RIGHT-OF-WAY AT THE END OF EACH DAY
7. DITCHES TO BE OPENED AT THE END OF EACH DAY TO ASSURE ADEQUATE DRAINAGE
8. ROAD MUST BE KEPT OPEN TO TRAFFIC AND CONTRACTOR MUST PROVIDE ADEQUATE FLAGMEN SIGNALS, ETC., TO PROVIDE COMPLETE SAFETY TO THE PUBLIC.
9. IF IT BECOMES NECESSARY FOR EQUIPMENT TO OPERATE ON A PORTION OF THE PAVEMENT, PRECAUTIONS MUST BE TAKEN TO PREVENT ANY DAMAGE WHATSOEVER TO THE PAVEMENT
10. CONDITION OF ROAD UPON COMPLETION OF JOB SHALL BE AS GOOD OR BETTER THAN PRIOR TO STARTING
11. CONTRACTOR SHALL COMPLY WITH ALL APPLICABLE NATIONAL ELECTRICAL SAFETY CODE (NEC) REQUIREMENTS, CENTERPOINT ENERGY ELECTRIC POLE/UTILITY GUIDELINES AND PROCEDURES AND ALL OTHER APPLICABLE REGULATIONS AND STANDARDS FOR THE WORK PLACEMENT OF AERIAL CABLE FACILITIES, 96" MIN. VERTICAL CLEARANCE.
12. ALL UTILITIES WILL BE IDENTIFIED BY POT HOLE BEFORE ANY CONSTRUCTION
13. COMCAST WILL MAINTAIN (2FT) HORIZONTAL & VERTICAL SEPARATION FROM ANY EXISTING UTILITIES
14. THE CONTRACTOR TO CONTACT WALKER COUNTY PRECINCT 4 AT LEAST 48 HOURS PRIOR TO CONSTRUCTION



LAMBERT: N/A
DATE: 08/18/2025
KEY MAP NO 75K
SCALE: 1:40

DESIGNED BY:
QUANTA TELECOM SERVICES

DWG. NO.
SHEET NO. 37 OF 45

ASPEN
36502 HEMPSTEAD HWY
HOCKLEY, TX 77447

JB1771404 - 995 TX-150, NEW WAVERLY, TX 77358

COMCAST PROPOSES TO INSTALL FIBER OPTIC CABLE
COMCAST PROPOSES TO PLACE DIRECTIONAL BORE 710 FT TO INSTALL FIBER
OPTIC CABLE TO PROVIDE SERVICE TO 895 TX-150, NEW WAVERLY, TX 77356
INSIDE THE ROW OF THE WALKER COUNTY, TX.
TOTAL PROJECT FOOTAGE: 710'




8800 W. TIDWELL RD. HOUSTON, TEXAS 77060
H HOUSTON, LLC

RECEIVED

SEP 02 2025

BY:

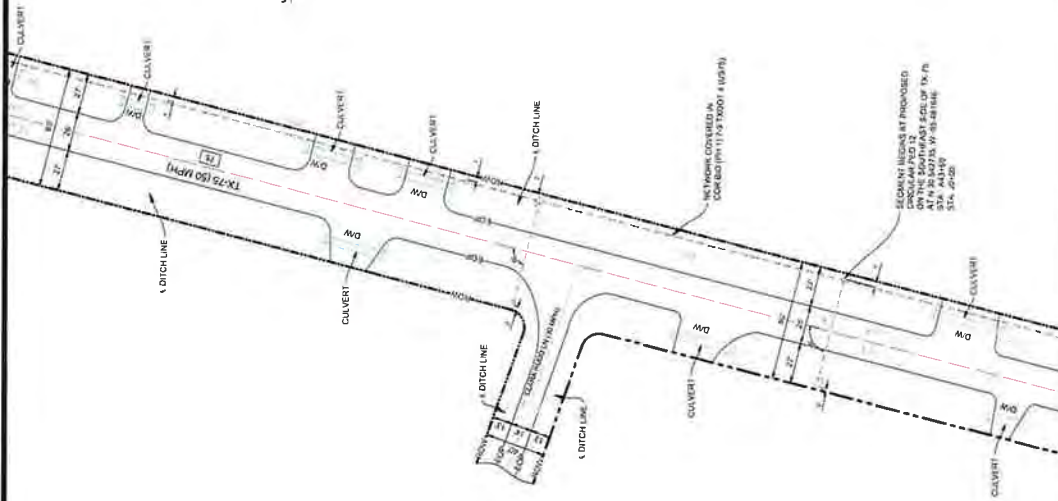


JB1771404 - 995 TX-150, NEW WAVERLY, TX 77358
PLAN VIEW 36 OF 41

NOTES:


- 1 THE WALKER COUNTY WILL BE NOTIFIED IN WRITING 48 HOURS PRIOR TO COMMENCING WORK.
- 2 THE WALKER COUNTY UTILITIES DEPARTMENT AND PUBLIC WORKS DEPARTMENT WILL BE NOTIFIED FOR LINE LOCATES AT (936) 435-4939.
- 3 THE CONTRACTOR SHALL CONTACT TEXAS ONE CALL SYSTEM AT 1-800-455-4545 MIN. 48 HOURS BEFORE DIGGING.
- 4 THE CONTRACTOR SHALL DETERMINE THE EXACT LOCATION OF ALL UNDERGROUND FACILITIES BEFORE COMMENCING WORK AND AGREE TO EXISTING FACILITIES. ANY CHANGES CAUSED BY HIS FAILURE TO EXACTLY LOCATE AND PRESERVE ALL UNDERGROUND FACILITIES.
- 5 NO MORE TRENCH OPENED AT ONE TIME THAN CAN BE BACKFILLED AND RESTORED WITHIN THE SAME DAY. IF NOT, THE TRENCH SHALL BE OPENED OVERNIGHT.
- 6 ALL EXCESS EXCAVATION TO BE REMOVED FROM THE ROAD RIGHT-OF-WAY AT THE END OF EACH DAY.
- 7 DITCHES TO BE OPENED AT THE END OF EACH DAY TO ASSURE ADEQUATE DRAINAGE.
- 8 ROAD MUST BE KEPT OPEN TO TRAFFIC AND CONTRACTOR MUST PROVIDE ADEQUATE FLAGMEN SIGNALS, ETC., TO PROVIDE COMPLETE SAFETY TO THE PUBLIC.
- 9 IF IT BECOMES NECESSARY FOR EQUIPMENT TO OPERATE ON A PORTION OF THE PAVEMENT PRECAUTIONS MUST BE TAKEN TO PREVENT ANY DAMAGE WHATSOEVER TO THE PAVEMENT.
- 10 CONDITION OF ROAD UPON COMPLETION OF JOB SHALL BE AS GOOD OR BETTER THAN PRIOR TO STARTING.
- 11 CONTRACTOR SHALL COMPLY WITH ALL APPLICABLE NATIONAL ELECTRICAL SAFETY CODE (NEC) REQUIREMENTS, CENTERPOINT UTILITY REQUIREMENTS, AND ALL APPLICABLE LOCAL ORDINANCES AND ALL APPLICABLE LOCAL REQUIREMENTS AND REGULATIONS FOR PLACEMENT OF AERIAL CABLE FACILITIES. 18" MIN. VERTICAL CLEARANCE.
- 12 ALL UTILITIES WILL BE IDENTIFIED BY POT HOLE BEFORE ANY CONSTRUCTION.
- 13 COMCAST WILL MAINTAIN (2FT) HORIZONTAL & VERTICAL SEPARATION FROM ANY EXISTING UTILITIES.
- 14 THE CONTRACTOR TO CONTACT WALKER COUNTY PRECINCT 4 AT LEAST 48 HOURS PRIOR TO CONSTRUCTION.

Kenny P. Lundy, PE
The Aspen Utility Company, LLC
3100 Highway 200, Suite 200
Hockley, TX 77447
+1 (282) 483-3461

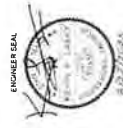

COMCAST PROPOSES TO INSTALL FIBER OPTIC CABLE
COMCAST PROPOSES TO PLACE DIRECTIONAL BORE 710 FT TO INSTALL FIBER OPTIC CABLE TO PROVIDE SERVICE TO 995 TX-150, NEW WAVERLY, TX 77358. UNDER THE ROAD OF THE PROJECT COUNTY, TX.
TOTAL PROJECT FOOTAGE: 710'

 JB1771404 - 995 TX-150, NEW WAVERLY, TX 77358




DESIGNED BY:
QUANTA TELECOM SERVICES
DWG. NO.
SHEET NO. 36 OF 45

LAURENT N/A
DATE: 08/16/2025
KEY MAP NO. 75K
SCALE: 1" = 40'



JB1771404 - 995 TX-150, NEW WAVERLY, TX 77358
PLAN VIEW 37 OF 41

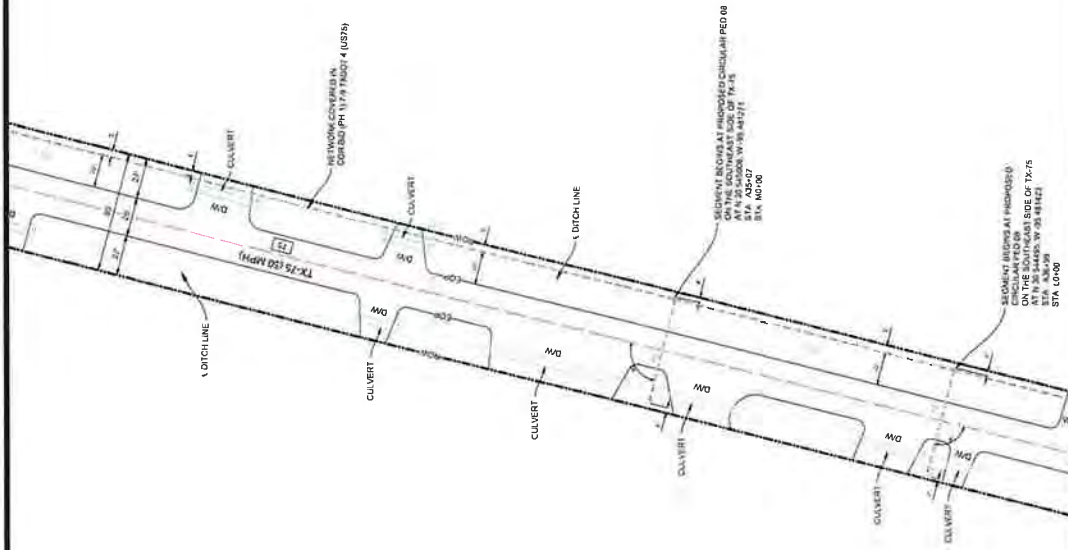

NOTES

1. THE WALKER COUNTY WILL BE NOTIFIED IN WRITING 48 HOURS PRIOR TO CONSTRUCTION WORK.
2. THE WALKER COUNTY UTILITIES DEPARTMENT AND PUBLIC WORKS DEPARTMENT WILL BE NOTIFIED FOR LINE LOCATES AT (850) 458-4359
3. THE CONTRACTOR SHALL CONTACT TEXAS ONE CALL SYSTEM AT 1-800-245-4545 MIN. 48 HOURS BEFORE DIGGING
4. THE CONTRACTOR SHALL DETERMINE THE EXACT LOCATION OF ALL UNDERGROUND FACILITIES BEFORE COMMENCING WORK AND AGREE TO BE FULLY RESPONSIBLE FOR ALL DAMAGES CAUSED BY HIS FAILURE TO EXACTLY LOCATE AND PRESERVE ALL UNDERGROUND FACILITIES.
5. NO MORE TRENCH OPENED AT ONE TIME THAN CAN BE BACKFILLED AND COMPACTED IN 10' LIFTS AT THE END OF EACH DAY. (NO TRENCH LEFT OPEN OVERNIGHT)
6. ALL EXCESS EXCAVATION TO BE REMOVED FROM THE ROAD RIGHT-OF-WAY AT THE END OF EACH DAY
7. DITCHES TO BE OPENED AT THE END OF EACH DAY TO ASSURE ADEQUATE DRAINAGE
8. ROAD MUST BE KEPT OPEN TO TRAFFIC AND CONTRACTOR MUST PROVIDE ADEQUATE FLAGMEN, SIGNALS, ETC., TO PROVIDE COMPLETE SAFETY TO THE PUBLIC
9. IF IT BECOMES NECESSARY FOR EQUIPMENT TO OPERATE ON A PORTION OF THE PAVEMENT, PRECAUTIONS MUST BE TAKEN TO PREVENT ANY DAMAGE WHATSOEVER TO THE PAVEMENT
10. CONDITION OF ROAD UPON COMPLETION OF JOB SHALL BE AS GOOD OR BETTER THAN PRIOR TO STARTING.
11. CONTRACTOR SHALL COMPLY WITH ALL APPLICABLE NATIONAL ELECTRICAL SAFETY CODE (NEC) REQUIREMENTS, CENTERPOINT ENERGY ELECTRIC POLE ATTACHMENT GUIDELINES & PROCEDURES AND ALL APPLICABLE TEXAS ELECTRICAL SAFETY CODE REQUIREMENTS. PLACEMENT OF AERIAL CABLE FACILITIES, 18" MIN. VERTICAL CLEARANCE
12. ALL UTILITIES WILL BE IDENTIFIED BY POT-HOLE BEFORE ANY CONSTRUCTION
13. COMCAST WILL MAINTAIN (GTD) HORIZONTAL & VERTICAL SEPARATION FROM ANY EXISTING UTILITIES
14. THE CONTRACTOR TO CONTACT WALKER COUNTY PRECINCT 4 AT LEAST 48 HOURS PRIOR TO CONSTRUCTION

Kevin P. Lundy, PE
The Aspen Utility Company, LLC
Form No. 203206
36502 HEMPSTEAD HWY.
HOCKLEY, TX 77447
+1 (702) 463 3657



DESIGNED BY:
QUANTA TELECOM SERVICES
DATE: 08/18/2023
KEY MAP NO. 75K
SCALE: 1" = 40'


JB1771404 - 995 TX-150, NEW WAVERLY, TX 77358
36502 HEMPSTEAD HWY.
HOCKLEY, TX 77447

COMCAST PROPOSES TO INSTALL FIBER OPTIC CABLE
COMCAST PROPOSES TO PLACE DIRECTIONAL BORE 110 FT TO INSTALL FIBER OPTIC CABLE TO PROVIDE SERVICE TO 995 TX-150, NEW WAVERLY, TX 77358.
INSIDE THE ROW OF THE WALKER COUNTY, TX.
TOTAL PROJECT FOOTAGE: 110'



RECEIVED
SEP 02 2025
BY:

JB1771404 - 995 TX-150, NEW WAVERLY, TX 77358
PLAN VIEW 38 OF 41

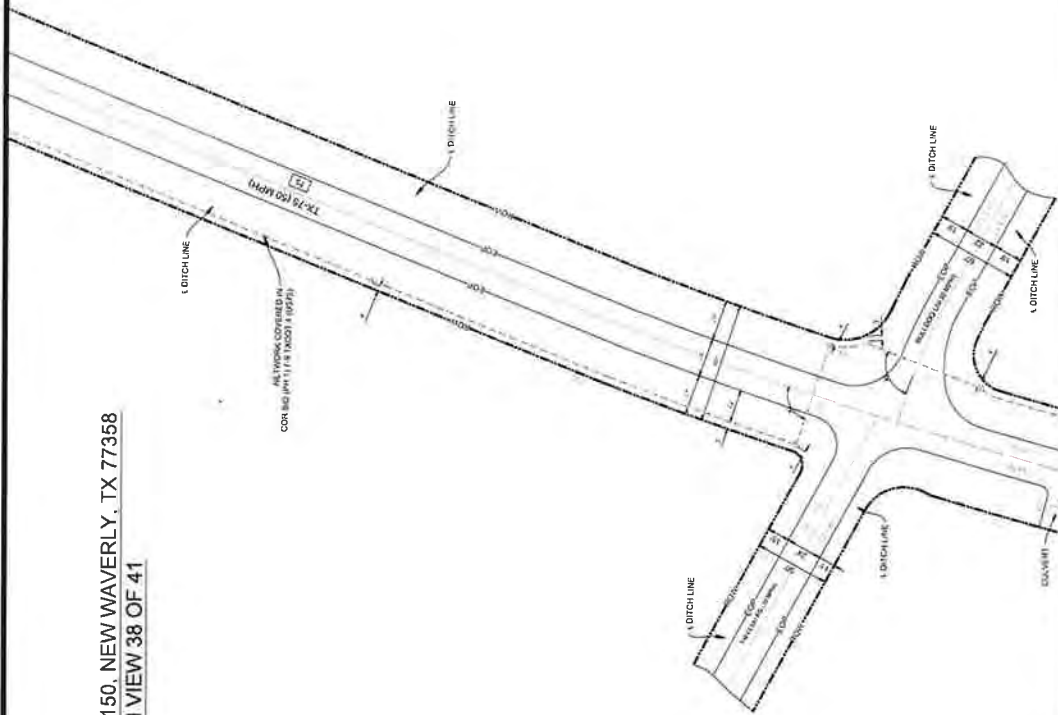

NOTES

1. THE WALKER COUNTY WILL BE NOTIFIED IN WRITING 48 HOURS PRIOR TO COMMENCING WORK.
2. THE WALKER COUNTY UTILITIES DEPARTMENT AND PUBLIC WORKS DEPARTMENT WILL BE NOTIFIED FOR LINE LOCATES AT (580) 458-4839.
3. THE CONTRACTOR SHALL CONTACT TEXAS ONE CALL SYSTEM AT 1-800-255-4565 MIN. 48 HOURS BEFORE DIGGING.
4. THE CONTRACTOR SHALL DETERMINE THE EXACT LOCATION OF ALL UNDERGROUND FACILITIES BEFORE COMMENCING WORK AND AGREE TO THE EXACT LOCATION OF ALL UNDERGROUND FACILITIES WITH THE UTILITY TO EXACTLY LOCATE AND PRESERVE ALL UNDERGROUND FACILITIES.
5. NO MORE TRENCH OPENED AT ONE TIME THAN CAN BE BACKFILLED AND OPENED OVERNIGHT.
6. ALL EXCESS EXCAVATION TO BE REMOVED FROM THE ROAD RIGHT-OF-WAY AT THE END OF EACH DAY.
7. DITCHES TO BE OPENED AT THE END OF EACH DAY TO ASSURE ADEQUATE DRAINAGE.
8. ROAD MUST BE KEPT OPEN TO TRAFFIC AND CONTRACTOR MUST PROVIDE ADEQUATE FLAGMEN, SIGNALS, ETC. TO PROVIDE COMPLETE SAFETY TO THE PUBLIC.
9. IF IT BECOMES NECESSARY FOR EQUIPMENT TO OPERATE ON A PORTION OF THE ROAD, PRECAUTIONS MUST BE TAKEN TO PREVENT ANY DAMAGE WHATSOEVER TO THE FACILITY.
10. CONDITION OF ROAD UPON COMPLETION OF JOB SHALL BE AS GOOD OR BETTER THAN PRIOR TO STARTING.
11. CONTRACTOR SHALL COMPLY WITH ALL APPLICABLE NATIONAL ELECTRICAL SAFETY CODE (NEC) REQUIREMENTS, CENTERPOINT ENERGY COMPANY, INC. (CEC) REQUIREMENTS, AND ALL APPLICABLE LOCAL REQUIREMENTS AND REGULATIONS FOR PLACEMENT OF AERIAL CABLE FACILITIES. 18" MIN. VERTICAL CLEARANCE.
12. ALL UTILITIES WILL BE IDENTIFIED BY POTHOLE BEFORE ANY CONSTRUCTION.
13. CONCAST WILL MAINTAIN (GFT) HORIZONTAL & VERTICAL SEPARATION FROM ANY EXISTING UTILITIES.
14. THE CONTRACTOR TO CONTACT WALKER COUNTY PRECINCT 4 AT LEAST 48 HOURS PRIOR TO CONSTRUCTION.

Robert P. Lundy PE
The Aspen Utility Company, LLC
11115 E. Highway 150
25002 Hempstead Highway
Hockley, TX 77447
(817) 553-4430



CONCAST PROPOSES TO INSTALL FIBER OPTIC CABLE
CONCAST PROPOSES TO PLACE DIRECTIONAL BORE 110 FT TO INSTALL FIBER OPTIC CABLE
INSIDE THE ROW OF THE WALKER COUNTY, TX
TOTAL PROJECT FOOTAGE: 710'


JB1771404 - 995 TX-150, NEW WAVERLY, TX 77358




DESIGNED BY:
QUANTA TELECOM SERVICES
DWG. NO.
SHEET NO. 40 OF 45



JB1771404 - 995 TX-150, NEW WAVERLY, TX 77358
PLAN VIEW 39 OF 41

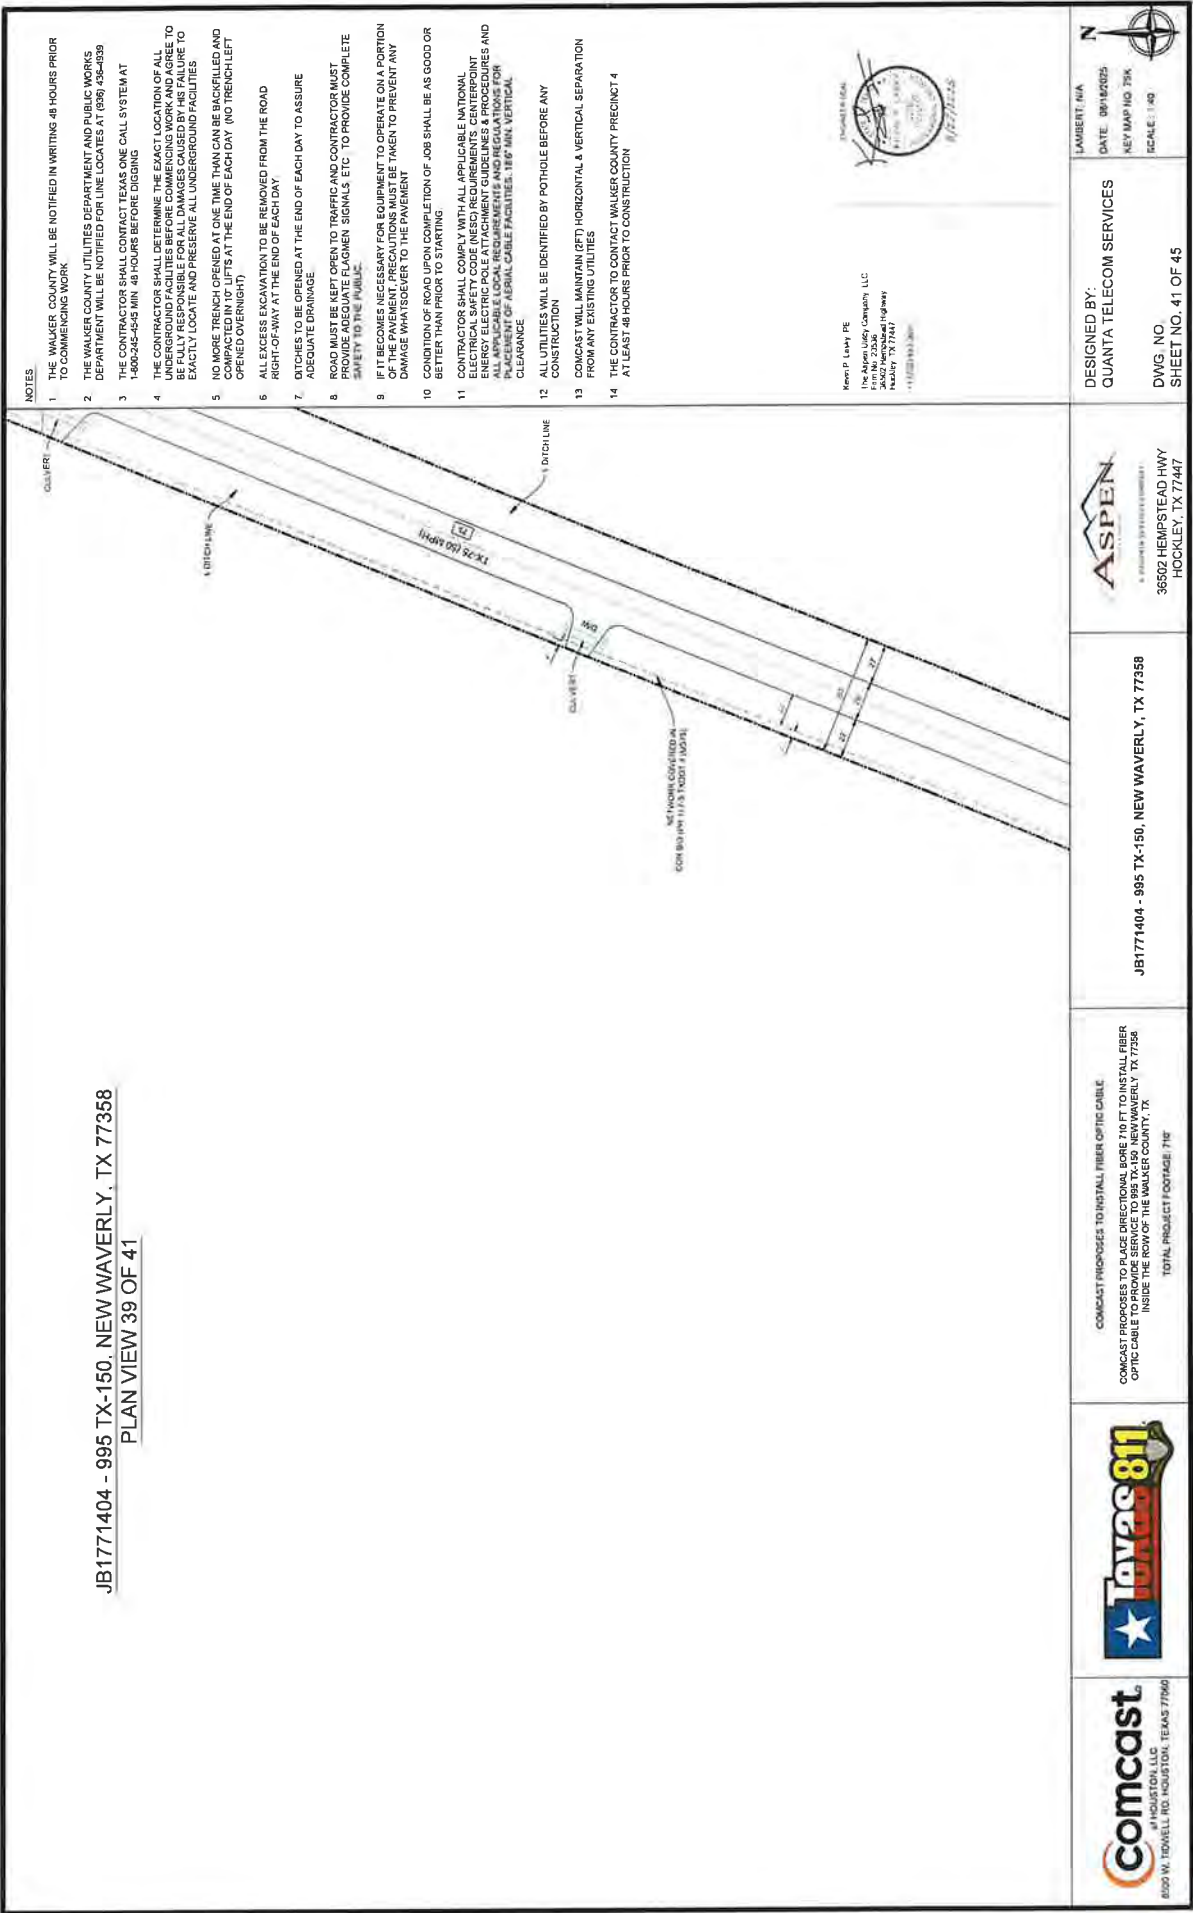

RECEIVED
SEP 02 2025
BY:

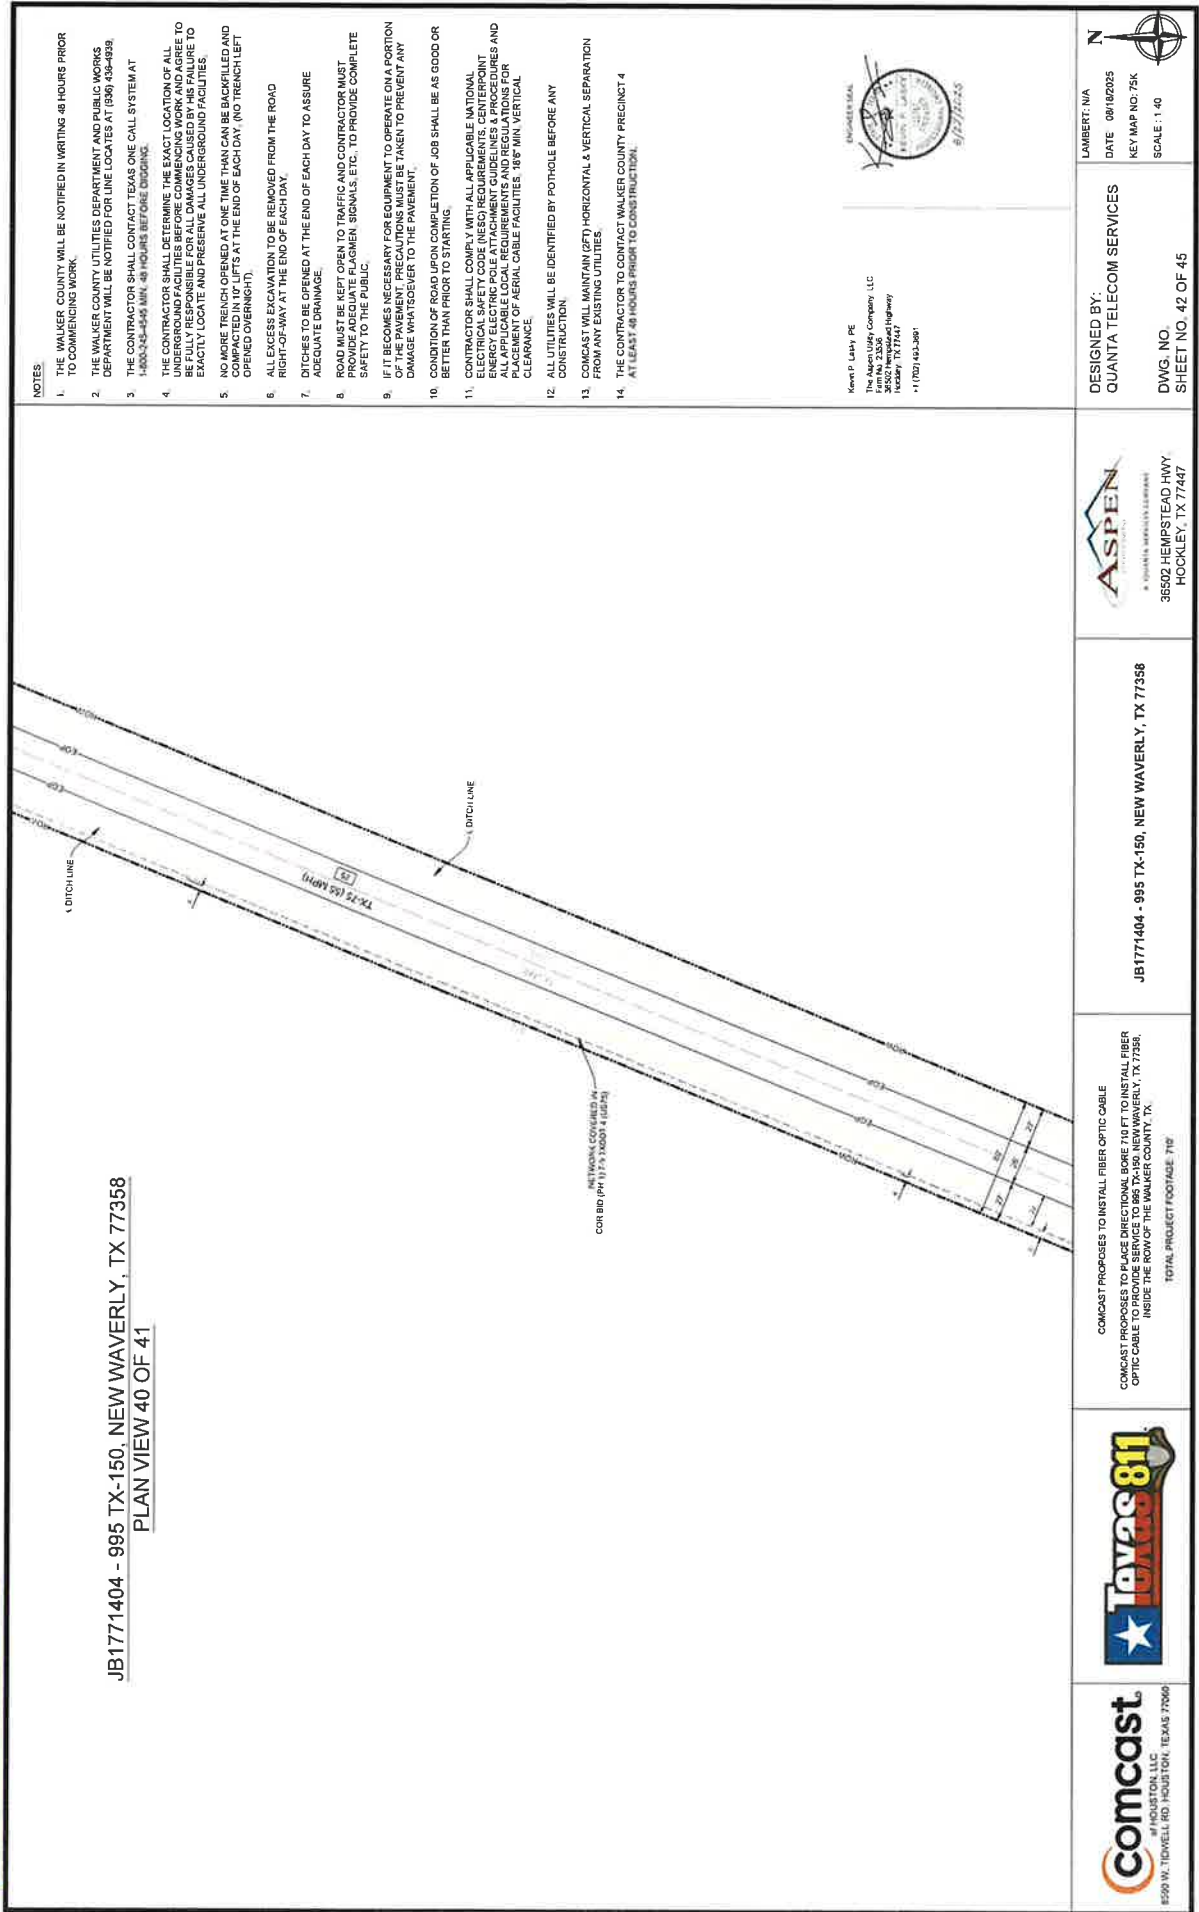

[illegible]

1	THE WALKER COUNTY WILL BE NOTIFIED IN WRITING 48 HOURS PRIOR TO COMMENCING WORK.
2	
3	THE WALKER COUNTY UTILITIES DEPARTMENT AND PUBLIC WORKS DEPARTMENT WILL BE NOTIFIED FOR LINE LOCATES AT 1000 456-4324.
4	1-800-254-4565 MIN. 48 HOURS BEFORE DIGGING.
5	CONTRACT SHALL COMPLY WITH THE FOLLOWING: CALL SYSTEMS AT 1-800-254-4565 MIN. 48 HOURS BEFORE DIGGING.
6	THE CONTRACTOR SHALL DETERMINE THE EXACT LOCATION OF ALL UTILITIES PRIOR TO THE START OF ANY WORK. THE CONTRACTOR SHALL BE FULLY RESPONSIBLE FOR ALL DAMAGES CAUSED BY HIS FAILURE TO EXACTLY LOCATE AND PRESERVE ALL UNDERGROUND FACILITIES.
7	NO MORE TRENCH DEPTH AT ONE TIME THAN CAN BE BACKFILLED AND COMPACTED IN 10' LIFTS AT THE END OF EACH DAY (NO TRENCH LEFT OPENED OVERNIGHT).
8	ALL EXCESS EXCAVATION TO BE REMOVED FROM THE ROAD RIGHT-OF-WAY AT THE END OF EACH DAY.
9	DITCHES TO BE OPENED AT THE END OF EACH DAY TO ASSURE ADEQUATE DRAINAGE.
10	ROAD MUST BE KEPT OPEN TO TRAFFIC AND CONTRACTOR MUST PROVIDE ADEQUATE FLAGMEN SIGNALS, ETC. TO PROVIDE COMPLETE SAFETY TO THE PUBLIC.
11	IF IT BECOMES NECESSARY FOR EQUIPMENT TO OPERATE ON A PORTION OF THE PAVEMENT, PRECAUTIONS MUST BE TAKEN TO PREVENT ANY DAMAGE WHATSOEVER TO THE PAVEMENT.
12	CONDITION OF ROAD UPON COMPLETION OF JOB SHALL BE AS GOOD OR BETTER THAN PRIOR TO STARTING.
13	CONTRACTOR SHALL COMPLY WITH ALL APPLICABLE NATIONAL ELECTRICAL, SAFETY CODE (NEC) REQUIREMENTS, CENTERPOINT ENERGY, ELECTRICAL SAFETY CODE, OSHA, AND ALL OTHER APPLICABLE CODES, ORDINANCES, AND REGULATIONS. CONTRACTOR SHALL PROVIDE ALL NECESSARY CLEARANCE FOR PLACEMENT OF AERIAL CABLE FACILITIES. 105" MIN VERTICAL CLEARANCE.
14	ALL UTILITIES WILL BE IDENTIFIED BY POTHOLE BEFORE ANY CONSTRUCTION FROM ANY EXISTING UTILITIES.
15	CONTRACT WILL MAINTAIN 25 FT. HORIZONTAL & VERTICAL SEPARATION FROM ANY EXISTING UTILITIES.
16	THE CONTRACTOR SHALL CONTACT WALKER COUNTY PRECINCT 4 AT LEAST 48 HOURS PRIOR TO CONSTRUCTION.

Kevin P. Lash, PE
The Aspen Valley Company, LLC
P.O. Box 23536
36502 Hemphill Highway
Mackley, TX 77447
1 (702) 493-3666

ENCLOSURE SEAL



36502 HEMPSTEAD HWY
HOCKLEY, TX 77447

JB17771404 - 995 TX-150, NEW WAVERLY, TX 77358

COMCAST PROPOSES TO INSTALL FIBER OPTIC CABLE
COMCAST PROPOSES TO PLACE DIRECTIONAL BORE 710 FT TO INST
OPTIC CABLE TO PROVIDE SERVICE TO 995 TX-150, NEW WAVERLY
INSIDE THE ROW OF THE WALKER COUNTY, TX
TOTAL PROJECT FOOTAGE: 710'

TOTAL PROJECT FOOTAGE: 710'



DESIGNED BY:
QUANTA TELECOM SERVICES

DWG NO
SHEET NO. 43 OF 45

LANAUBERT N/A
DATE 03/18/20
KEY MAP NO 75







Utility Installation Request

To the Commissioner's Court of Walker County

Date 09/02/2025

Application is hereby made by Guadalupe Tobon-Horner

to place INSTALL FIBER OPTIC

and/or perform the following described work within the Right of Way of that Walker County road known as I-45 at the following approximate coordinates (lat/long) N 30.559757, W -95.504482

The exact location and extent of the proposed work shall be as shown on the attached specifications and drawings.

We will construct and maintain the line on the road right of way as shown on the attached drawing and in accordance with the rules, regulations and policies of Walker County, the Texas Department of Transportation (TXDOT), and all governing laws, including, but not limited to, the "Texas Engineering Practice Act," "Federal Clean Water Act," the "National Endangered Species Act," "Americans with Disabilities Act," and the "Federal Historic Preservation Act." Upon request by Walker County, we will submit to Walker County proof of compliance with all governing laws, rules and regulations before commencement of construction. Plans shall include the design, proposed location, vertical elevations, and horizontal alignments of the facility based on the department's survey datum, the relationship to existing highway facilities and the right of way line, traffic safety and access procedures, and location of existing utilities that may be affected by the proposed utility facility. The location and description of the proposed line and appurtenances is more fully shown by a complete set of drawings attached to this Utility Installation Request. We will give plans to Walker County for each future proposed modification or expansion to our facility and all Walker County to review and approve submittals prior to commencement of the work.

A new request may be required as a condition of approval.

Our organization will use Best Management Practices to minimize erosion and sedimentation resulting from the proposed installation, and we will re-vegetate the project area as indicated under "Re-vegetation Special Provisions."

Our organization will ensure that traffic control measures complying with applicable portions of the *Texas Manual on Uniform Traffic Control Devices* will be installed and maintained for the duration of this installation.

When installing our utility on controlled access facilities, we shall conform to the Texas Transportation Code, Title 6 Roadways, Chapter 203, Subchapter C, Control of Access, §203.031. We shall limit access for servicing this installation to access via (a) frontage roads where provided, (b) nearby or adjacent public roads or streets, (c) trails along or near the highway right of way lines, connecting only to an intersecting road; from any one or all of which entry may be made to the outer portion of the highway right of way for normal service and maintenance operations. Our rights of access to the through traffic roadways and ramps shall be subject to the same rules and regulations that apply to the general public.

It is expressly understood that Walker County does not purport, hereby, to grant any right, claim, title or easement in or upon this road; and it is further understood that Walker County may require us to relocate this line and any associated infrastructure, at the total expense of the applicant/utility owner, by giving thirty (30) days written notice prior to the date that the relocation shall be completed. We understand that a new Request will be required for the relocation.

We will notify Walker County prior to commencement of any routine or periodic maintenance which requires pruning of trees within the highway right of way, so that Walker County may provide specifications for the extent and methods to govern in, but not limited to, trimming, topping, tree balance, type of cuts, painting cuts and clean up.

Our installation shall not damage any part of the roadway structure or associated appurtenances and we will make adequate provisions to minimize inconveniences to the traveling public, and adjacent property owners. In the event we fail to comply with any or all of the requirements as set forth herein, the County may take such action as it deems appropriate to compel our compliance.

RECEIVED
SEP 02 2025
BY:

Following approval, we will begin construction on or after 11/03/2025 (month/day/yr)

Additional Provisions and Requirements (for TxDOT input only)

General Special Provisions:

- ☒ Are attached.
☐ Are not attached

As-built Plans/Certifications of Construction:

- ☐ Are required and shall be certified as accurate by an authorized representative of the company.
☒ Are required and shall be signed and sealed by a State of Texas Licensed Professional Engineer.
☒ Certification that utility was installed as approved
☐ Are not required

Re-vegetation Special Provisions: In order to minimize erosion and sedimentation resulting from the proposed installation, the project area will be re-vegetated:

- ☒ In accordance with TxDOT's Standard Specification Item 164 which specifies the appropriate grass seed mix to be used, or:
☐ As indicated on the attachment.

The Precinct Commissioner or his/her representative is to be notified 48 hours prior to beginning construction.

If approved, we understand that we will assume all risks associated with this installation within the Walker County right of way. These risks include, but are not limited to, injuries to our workers, damage to contiguous utility lines that may be in the area, injuries or damage resulting from our failure to properly install and maintain the line as shown on plans.

We understand Walker County may place additional provisions and requirements as listed above, based upon, but not limited to, the type of utility being installed, local site conditions, soil types and traffic.

We acknowledge that this Utility Installation Request approval **expires** on the **91st** calendar day from the date of issuance, unless otherwise approved, if we do not begin our installation by this date. If we do not begin our installation within this time frame and still wish to continue, we will resubmit our request in accordance with the prevailing governing laws, rules, regulations and policies at the time of resubmission.

By signing as/for the requestor below, I certify that I am authorized to represent the requestor, that I agree to the provisions and requirements included in this Utility Installation Request, and our commencement of construction will further attest to our review and acceptance of said additional provisions and requirements

Requestor:

Approved By:

Date: 09/02/2025

Date: _____

By: Guadalupe Tobon-Horner

By: _____

Signature: Guadalupe Tobon-Horner

Signature: _____

Title: Permit Coordinator

Title: _____

Address: 36502 HEMPSTEAD RD. LOT #20,
HOCKLEY, TX. 77447

Address: _____

Telephone: 346-471-2612

Telephone: _____

RECEIVED
SEP 02 2025
BY:

**General Special Provisions
Walker County Utility Installation Request**

1. Effective Period of Permit Approval. All approvals are void if installation does not begin within 3 months from the date of approval.
2. ALL UTILITY INSTALLATIONS SHALL CONFORM WITH THE STANDARDS DESCRIBED IN TITLE 43, PART 1, CHAPTER 21, SUBCHAPTER C, OF THE TEXAS ADMINISTRATIVE CODE (UTILITY ACCOMODATIONS)
3. A FINAL AS-BUILT SET OF PLANS SHALL BE SUBMITTED AND CERTIFIED BY A PROFESSIONAL ENGINEER, INCLUDING A CERTIFICATION THAT THE INSTALLATION WAS COMPLETED IN CONFORMANCE AND COMPLIANCE WITH THE ABOVE DESCRIBED SECTIONS OF THE TEXAS ADMINISTRATIVE CODE AND TEXAS DEPARTMENT OF TRANSPORTATION MINIMUM SPECIFICATIONS. A statement must be included certifying that any pipe/casing installed is properly designed for the application and the installation meets the minimum standards for TxDOT and Title 43 of the Texas Administrative Code.
4. Minimum Depth of Cover. The minimum depth of cover for any underground utility line shall be as shown on the "Minimum Depth of Cover Table" for the TXDOT District or attached schematic whichever is deeper.
5. Locating Utilities. Applicant shall take all reasonable and necessary steps to locate existing utilities and address them in accordance with all state, local, and or federal requirements.
6. Aerial Electric Lines. Aerial electric power lines crossing over the highway shall be installed and maintained a minimum of twenty-two (22) feet above the surface of the traffic lanes. For electric power lines with greater than 50,000 volts, the clearance shall be increased in accordance with National Electric Safety Code as published in the National Bureau of Standards, Handbook 30.
7. Aerial Communication Lines. Aerial communication lines crossing over the highway shall be installed and maintained a minimum of eighteen (18) feet above the surface of the traffic lanes.
8. Open Trenching or Boring Operations for Utility Work. To insure that disturbed areas are restored and revegetated properly and in a reasonable period as the utility work progresses, the following requirements shall apply:

Unless otherwise approved or directed by Walker County, the length of "active utility work" shall not exceed one mile in length. "Active utility work" shall be defined as the total disturbed area measured from the beginning of open trenching to the point where backfill has been compacted, the right of way has been restored to its original line and grade, any structures damaged by the utility work have been repaired, erosion control measures have been placed and are being properly maintained, approved topsoil seed and compost has been placed uniformly, and watering for revegetation has begun. "Active utility work" also includes areas of bore pits and receiving pits; however, it does not include the underground boring length. When any area of "active utility work" is substantially complete (i.e., watering of seeded areas has begun), that area is no longer considered to be "active utility work", and "active utility work" can proceed further within the right of way as long as it does not exceed the above appropriate limits. Areas where Walker County determines that the "active utility work" is substantially complete does not mean that Walker County considers that area totally acceptable and complete.

9. Backfill, Erosion Control, and Re-vegetation. All excavations within the right-of-way (ROW) and not under pavement shall be backfilled by tamping in six (6) inch horizontal layers to the density of the surrounding soil or as directed by the Walker County. All surplus material shall be removed and the ROW shall be reshaped to

RECEIVED
SEP 02 2025
BY:

**General Special Provisions
Walker County Utility Installation Request**

its original condition or better. This work shall be done in accordance with Item 164 of the Texas Department of Transportation (TxDOT) "Standard Specifications for Construction and Maintenance of Highways, Streets, and Bridges." Erosion control measures such as soil retention blankets, rock berms, and silt fences shall be installed and maintained until permanent perennial vegetation is established over 70% of the disturbed area. The amount of revegetation is considered acceptable when it resembles the amount of existing vegetation in the surrounding undisturbed area. **If erosion control and/or storm water run-off requirements of other State, Federal, or Local Jurisdictions exceed these requirements then the more stringent requirements would prevail.**

8. Boring and Jacking. Boring and jacking of utility lines shall be provided as specified below.
- a. Under Paved County Roads. Utility lines to be constructed under an existing paved (asphalt pavement or concrete pavement) county road shall be installed by boring and jacking with casing.
 - b. Under Paved Driveways. Utility lines to be constructed under existing paved (asphalt pavement or concrete pavement) driveways shall be installed by boring and jacking methods, unless the utility company furnishes Walker County with a "Letter of No Objection" signed by the driveway owner to allow open cutting of their driveway.
 - c. Under Unpaved County Roads or Driveways. Utility lines to be constructed under an existing unpaved county road or under existing unpaved driveways may be open cut only when approved in advance by Walker County, and after the driveway owner is notified. Any open cuts should be repaired and restored to a minimum of pre-cut conditions as quickly as possible so as not to impact road and/or driveway traffic. Applicant shall take all necessary precautions to insure safety as site of open cut.
 - d. Under Desirable Trees. To preserve the natural environment and protect wildlife habitat, boring may be required when underground utility lines are to be placed within the "protected root area" of "desirable trees" located within road ROW or on adjacent property. The "protected root area" is defined as the area between the tree trunk and five (5) feet from the tree trunk or 2/3 the actual distance from the tree trunk to the dripline, whichever is greater. "Desirable trees" include (but are not limited to) any tree with a trunk diameter of six (6) inches or more that Walker County or the Owner of the tree determines to be of environmental and aesthetic value. Boring under all "desirable trees" will be required with the following exceptions: (1) in areas where planned highway construction/maintenance work would require tree removal, or (2) when the Walker County approves of open trenching for the utility installation or removal of the tree.
9. Manhole Covers. All manhole covers shall be installed flush with the ground surface.
10. Traffic Control. Traffic control in utility work zones shall conform to applicable requirements of the "Texas Manual on Uniform Traffic Control Devices for Streets and Highways, Part VI". Adequate signs, barricades, flag personnel, etc. shall be erected and maintained in complete compliance with the Texas Manual on Uniform Traffic Control Devices. Any travel lane closures are only permitted after a traffic control plan is approved by Walker County prior to beginning any construction activities.
11. Sunday or Holiday Work. Sunday or Holiday work will not be permitted for the installation of any utility line unless directed or approved by Walker County.

RECEIVED
SEP 02 2025
BY:

**General Special Provisions
Walker County Utility Installation Request**

12. The approval of this utility installation request shall in no way be taken as a waiver or variance to any other existing local, state, or federal permits or requirements that may be required by the applicant.
13. **Please note that Walker County will be making no verification through this process of the actual location of the public right of way as to width or location. The responsibility to locate the bounds of any public right of way that your project will utilize is the responsibility of your company. Walker County's approval of the request is not an agreement as to location of the public right of way, nor does it confer any easement, right of way, or property right for the project area.**
14. **Protection of Trees and Landscaping. Existing trees and landscaping within the ROW shall be protected as specified below. Removal of trees from the ROW will require prior Walker County approval.**
- a. **Tree Pruning. All tree pruning within the ROW will require prior TxDOT approval.** All oak trees that are damaged or pruned shall be treated with an approved tree wound dressing within 20 minutes of causing the damage or making the pruning cut.
- b. **Landscaping.** When existing landscaping is located near the proposed utility alignment, the utility contractor shall notify Walker County and the owner of the landscaping prior to the proposed utility installation. Walker County may require underground utilities to be installed by: (1) boring under such landscaping or (2) by replacement of specific landscape items. Landscaping is defined as, but not limited to, trees, shrubs, grass, irrigation lines, landscape pavers, sidewalks, and other ROW improvements.

RECEIVED
SEP 02 2025
BY:



JB1771404 - 2594 I-45, NEW WAVERLY, TX 77358/PRECINCT 4
COMCAST PROPOSES TO PLACE DIRECTIONAL BORE 28.487 FT TO INSTALL FIBER
OPTIC CABLE TO PROVIDE SERVICE NEAR TO 2594 I-45, NEW WAVERLY, TX 77358,
INSIDE THE ROW OF THE WALKER COUNTY, PRECINCT 4, TX.



NOT TO SCALE



ASPEN UTILITY IS RESPONSIBLE FOR PLACING
THE CONDUIT IN THE WALKER COUNTY ROW

ACCORDING TO MAP NO. 48471C0500D, 48471C0525D OF
THE FEDERAL EMERGENCY MANAGEMENT AGENCY'S
FLOOD INSURANCE RATE MAPS FOR WALKER COUNTY
UNINCORPORATED AREAS, DATED 8/16/2011, THE
SUBJECT TRACT IS SITUATED WITHIN: FLOOD
PLAIN ZONE X, UNSHADED

LEGEND

- PROPOSED BORE PIT
- EX. PEDESTAL
- PROPOSED PEDESTAL
- EX. CIRCULAR PEDESTAL
- PROPOSED CIRCULAR PEDESTAL
- EX. CATV VAULT
- PROPOSED CATV VAULT
- ANCHOR
- WATER METER
- CATV TRENCH ROUTE
- CATV BORE ROUTE
- STORM DRAINAGE
- WATER
- SEWER
- STORM SEWER
- CATV AERIAL ROUTE
- PRIVATE FENCE
- STORM DRAIN INLET
- CATCH BASIN
- STORM MANHOLE
- JOINT USE POLE
- JOINT USE POLE WITH TRANSFORMER
- BOC
- EDGE OF CURB
- EOP
- EDGE OF PAVEMENT
- DW
- DRIVEWAY
- ROW
- RIGHT OF WAY
- AERIAL RISER

VICINITY MAP
KEY MAP: 74Q, 74R, 75N, 74V, 75S, 74M, 74D, 55W, 74A, 75E
LAMBERT: NA
GIMS: NA



DESCRIPTION	QUANTITY	UNIT
DIRECTIONAL BORE	28.487	FT
TRENCH	2	FT
EXISTING CONDUIT	2	FT
BORE PITS	43	EA
NEW VAULTS	10	EA
EXISTING VAULTS	0	EA
NEW PEDESTALS	42	EA
EXISTING PEDESTALS	0	EA
AERIAL RISER	0	FT
AERIAL OVERLAP	0	FT
NEW STAND	0	FT
ANCHORS	0	EA
PROPOSED MANHOLES	13	EA
NEW POLES	0	EA
EXISTING POLES (TOP)	0	EA
EXISTING POLES (BASE)	0	EA
TOTAL PROJECT FOOTAGE	28487	FT

- SHEET INDEX
- COVER PAGE
 - PLAN OVERVIEW
 - 3-62. PLAN VIEW (1-60)
 - 63-74. TYPICAL DETAILS (1-19)
 75. GENERAL NOTES
 - 76-77. TRAFFIC CONTROL PLAN

NO. DATE REVISION APP.
Kern P. Lundy PE
The Aspen Utility Company, LLC
P.O. Box 2350
Houston, Texas 77261
+1 (713) 437-3091



WALKER COUNTY
PUBLIC WORKS DEPARTMENT


FOR THE USE OF THE WALKER COUNTY
ENGINEERING DEPARTMENT

SHEET NO: 01 OF 77 DATE : 08/27/2025

RECEIVED

SEP 02 2025


BY:

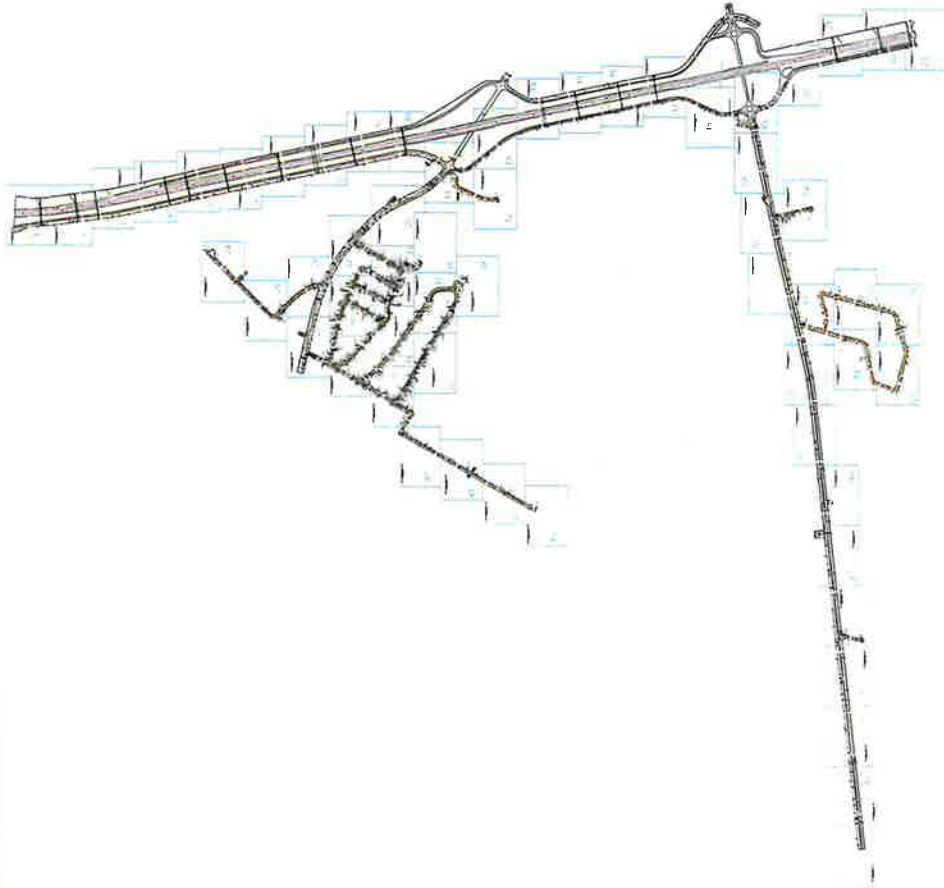

NOTES

1. THE WALKER COUNTY WILL BE NOTIFIED IN WRITING 48 HOURS PRIOR TO COMMENCING WORK.
2. THE WALKER COUNTY UTILITIES DEPARTMENT AND PUBLIC WORKS DEPARTMENT WILL BE NOTIFIED FOR LINE LOCATES AT (936) 438-4939.
3. THE CONTRACTOR SHALL CONTACT TEXAS ONE CALL SYSTEM AT 1-800-455-4545 MIN. 48 HOURS BEFORE DIGGING.
4. THE CONTRACTOR SHALL DETERMINE THE EXACT LOCATION OF ALL UTILITIES PRIOR TO ANY EXCAVATION. THE CONTRACTOR SHALL BE FULLY RESPONSIBLE FOR ALL DAMAGES CAUSED BY HIS FAILURE TO EXACTLY LOCATE AND PRESERVE ALL UNDERGROUND FACILITIES.
5. NO MORE TRENCH OPENED AT ONE TIME THAN CAN BE BACKFILLED AND COMPACTED IN 10' LIFTS AT THE END OF EACH DAY. (NO TRENCH LEFT OPENED OVERNIGHT).
6. ALL EXCESS EXCAVATION TO BE REMOVED FROM THE ROAD RIGHT-OF-WAY AT THE END OF EACH DAY.
7. DITCHES TO BE OPENED AT THE END OF EACH DAY TO ASSURE ADEQUATE DRAINAGE.
8. ROAD MUST BE LEFT OPEN TO TRAFFIC AND CONTRACTOR MUST PROVIDE ADEQUATE CONE, SIGNALS, ETC., TO PROVIDE COMPLETE SAFETY TO THE PUBLIC.
9. IF IT BECOMES NECESSARY FOR EQUIPMENT TO OPERATE ON A PORTION OF THE PAVEMENT, PRECAUTIONS MUST BE TAKEN TO PREVENT ANY DAMAGE WHATSOEVER TO THE PAVEMENT.
10. CONDITION OF ROAD UPON COMPLETION OF JOB SHALL BE AS GOOD OR BETTER THAN PRIOR TO STARTING.
11. CONTRACTOR SHALL COMPLY WITH ALL APPLICABLE NATIONAL ELECTRICAL SAFETY CODE (NEC) REQUIREMENTS, CENTERPOINT ENERGY ELECTRIC POLE ATTACHMENT GUIDELINES & PROCEDURES AND ALL APPLICABLE LOCAL REQUIREMENTS AND REGULATIONS FOR THE PROTECTION OF AERIAL CABLE FACILITIES. 18" MIN. VERTICAL CLEARANCE.
12. ALL UTILITIES WILL BE IDENTIFIED BY POT HOLE BEFORE ANY CONSTRUCTION.
13. COMCAST WILL MAINTAIN (2 FT) HORIZONTAL & VERTICAL SEPARATION FROM ANY EXISTING UTILITIES.
14. THE CONTRACTOR TO CONTACT WALKER COUNTY PRECINCT 4 AT LEAST 48 HOURS PRIOR TO CONSTRUCTION.

 Project: 14441-18
The Walker County
Project No. 2024
Project Name: 14441-18
Project No. 2024
Project Name: 14441-18



36502 HEMPSTEAD HWY.
HOCKLEY, TX 77447

PLAN OVERVIEW



6550 TX. TIDWELL RD. HOUSTON, TEXAS 77060

JB1771404 - 2594 I-45, NEW WAVERLY, TX 77358

DESIGNED BY:
QUANTA TELECOM SERVICES

DWG. NO.
SHEET NO. 02 OF 77

LAMBERT, VA

DATE: 08/02/25
TIME: 10:14:53 AM
PROJECT: 14441-18
SCALE: 1"=100'



Plan view of a proposed interchange. The diagram shows the intersection of I-45 (75 MPH) and I-45 Service Rd (50 MPH). Key features include:


- I-45 (75 MPH):** A multi-lane highway running horizontally across the upper portion of the plan.
- I-45 Service Rd (50 MPH):** A road running diagonally from the bottom left towards the center right.
- Interchange Structure:** A bridge structure crossing I-45, with a vertical curve labeled "VERTICAL CURVE IN BRIDGE" and "BRIDGE" indicated.
- Engineering Annotations:**
 - EOP:** End of Project points.
 - POF:** Point of Fitting.
 - DW:** Ditch or drainage line.
 - Stationing:** Various station markers are present along the roads.
 - Right of Way:** Indicated by dashed lines.
- Other Labels:** "I-45", "I-45 SERVICE RD", "BRIDGE", "VERTICAL CURVE IN BRIDGE", "DITCH", "DRAINAGE", "RIGHT OF WAY", "EOP", "POF", "DW", "H", "J", "K", "L", "M", "N", "O", "P", "Q", "R", "S", "T", "U", "V", "W", "X", "Y", "Z", "AA", "AB", "AC", "AD", "AE", "AF", "AG", "AH", "AI", "AJ", "AK", "AL", "AM", "AN", "AO", "AP", "AQ", "AR", "AS", "AT", "AU", "AV", "AW", "AX", "AY", "AZ", "BA", "BB", "BC", "BD", "BE", "BF", "BG", "BH", "BI", "BJ", "BK", "BL", "BM", "BN", "BO", "BP", "BQ", "BR", "BS", "BT", "BU", "BV", "BW", "BX", "BY", "BZ", "CA", "CB", "CC", "CD", "CE", "CF", "CG", "CH", "CI", "CJ", "CK", "CL", "CM", "CN", "CO", "CP", "CQ", "CR", "CS", "CT", "CU", "CV", "CW", "CX", "CY", "CZ", "DA", "DB", "DC", "DD", "DE", "DF", "DG", "DH", "DI", "DJ", "DK", "DL", "DM", "DN", "DO", "DP", "DQ", "DR", "DS", "DT", "DU", "DV", "DW", "DX", "DY", "DZ", "EA", "EB", "EC", "ED", "EE", "EF", "EG", "EH", "EI", "EJ", "EK", "EL", "EM", "EN", "EO", "EP", "EQ", "ER", "ES", "ET", "EU", "EV", "EW", "EX", "EY", "EZ", "FA", "FB", "FC", "FD", "FE", "FF", "FG", "FH", "FI", "FJ", "FK", "FL", "FM", "FN", "FO", "FP", "FQ", "FR", "FS", "FT", "FU", "FV", "FW", "FX", "FY", "FZ", "GA", "GB", "GC", "GD", "GE", "GF", "GG", "GH", "GI", "GJ", "GK", "GL", "GM", "GN", "GO", "GP", "GQ", "GR", "GS", "GT", "GU", "GV", "GW", "GX", "GY", "GZ", "HA", "HB", "HC", "HD", "HE", "HF", "HG", "HH", "HI", "HJ", "HK", "HL", "HM", "HN", "HO", "HP", "HQ", "HR", "HS", "HT", "HU", "HV", "HW", "HX", "HY", "HZ", "IA", "IB", "IC", "ID", "IE", "IF", "IG", "IH", "II", "IJ", "IK", "IL", "IM", "IN", "IO", "IP", "IQ", "IR", "IS", "IT", "IU", "IV", "IW", "IX", "IY", "IZ", "JA", "JB", "JC", "JD", "JE", "JF", "JG", "JH", "JI", "JJ", "JK", "JL", "JM", "JN", "JO", "JP", "JQ", "JR", "JS", "JT", "JU", "JV", "JW", "JX", "JY", "JZ", "KA", "KB", "KC", "KD", "KE", "KF", "KG", "KH", "KI", "KJ", "KK", "KL", "KM", "KN", "KO", "KP", "KQ", "KR", "KS", "KT", "KU", "KV", "KW", "KX", "KY", "KZ", "LA", "LB", "LC", "LD", "LE", "LF", "LG", "LH", "LI", "LJ", "LK", "LL", "LM", "LN", "LO", "LP", "LQ", "LR", "LS", "LT", "LU", "LV", "LW", "LX", "LY", "LZ", "MA", "MB", "MC", "MD", "ME", "MF", "MG", "MH", "MI", "MJ", "MK", "ML", "MM", "MN", "MO", "MP", "MQ", "MR", "MS", "MT", "MU", "MV", "MW", "MX", "MY", "MZ", "NA", "NB", "NC", "ND", "NE", "NF", "NG", "NH", "NI", "NJ", "NK", "NL", "NM", "NN", "NO", "NP", "NQ", "NR", "NS", "NT", "NU", "NV", "NW", "NX", "NY", "NZ", "OA", "OB", "OC", "OD", "OE", "OF", "OG", "OH", "OI", "OJ", "OK", "OL", "OM", "ON", "OO", "OP", "OQ", "OR", "OS", "OT", "OU", "OV", "OW", "OX", "OY", "OZ", "PA", "PB", "PC", "PD", "PE", "PF", "PG", "PH", "PI", "PJ", "PK", "PL", "PM", "PN", "PO", "PP", "PQ", "PR", "PS", "PT", "PU", "PV", "PW", "PX", "PY", "PZ", "QA", "QB", "QC", "QD", "QE", "QF", "QG", "QH", "QI", "QJ", "QK", "QL", "QM", "QN", "QO", "QP", "QQ", "QR", "QS", "QT", "QU", "QV", "QW", "QX", "QY", "QZ", "RA", "RB", "RC", "RD", "RE", "RF", "RG", "RH", "RI", "RJ", "RK", "RL", "RM", "RN", "RO", "RP", "RQ", "RR", "RS", "RT", "RU", "RV", "RW", "RX", "RY", "RZ", "SA", "SB", "SC", "SD", "SE", "SF", "SG", "SH", "SI", "SJ", "SK", "SL", "SM", "SN", "SO", "SP", "SQ", "SR", "SS", "ST", "SU", "SV", "SW", "SX", "SY", "SZ", "TA", "TB", "TC", "TD", "TE", "TF", "TG", "TH", "TI", "TJ", "TK", "TL", "TM", "TN", "TO", "TP", "TQ", "TR", "TS", "TT", "TU", "TV", "TW", "TX", "TY", "TZ", "UA", "UB", "UC", "UD", "UE", "UF", "UG", "UH", "UI", "UJ", "UK", "UL", "UM", "UN", "UO", "UP", "UQ", "UR", "US", "UT", "UU", "UV", "UW", "UX", "UY", "UZ", "VA", "VB", "VC", "VD", "VE", "VF", "VG", "VH", "VI", "VJ", "VK", "VL", "VM", "VN", "VO", "VP", "VQ", "VR", "VS", "VT", "VU", "VV", "VW", "VX", "VY", "VZ", "WA", "WB", "WC", "WD", "WE", "WF", "WG", "WH", "WI", "WJ", "WK", "WL", "WM", "WN", "WO", "WP", "WQ", "WR", "WS", "WT", "WU", "WV", "WW", "WX", "WY", "WZ", "XA", "XB", "XC", "XD", "XE", "XF", "XG", "XH", "XI", "XJ", "XK", "XL", "XM", "XN", "XO", "XP", "XQ", "XR", "XS", "XT", "XU", "XV", "XW", "XX", "XY", "XZ", "YA", "YB", "YC", "YD", "YE", "YF", "YG", "YH", "YI", "YJ", "YK", "YL", "YM", "YN", "YO", "YP", "YQ", "YR", "YS", "YT", "YU", "YV", "YW", "YX", "YY", "YZ", "ZA", "ZB", "ZC", "ZD", "ZE", "ZF", "ZG", "ZH", "ZI", "ZJ", "ZK", "ZL", "ZM", "ZN", "ZO", "ZP", "ZQ", "ZR", "ZS", "ZT", "ZU", "ZV", "ZW", "ZX", "ZY", "ZZ".

1. THE WALKER COUNTY WILL BE NOTIFIED IN WRITING 48 HOURS PRIOR TO COMMENCING WORK.
2. THE WALKER COUNTY UTILITIES DEPARTMENT AND PUBLIC WORKS DEPARTMENT WILL BE NOTIFIED FOR LINE LOCATES AT (950) 434-4339
3. THE CONTRACTOR SHALL CONTACT TEXAS ONE CALL SYSTEM AT 1-800-245-4645 MIN. 48 HOURS BEFORE DIGGING.
4. THE CONTRACTOR SHALL DETERMINE THE EXACT LOCATION OF ALL UTILITIES AND MARK THEM WITH FLAGMEN SIGNALS. THE CONTRACTOR SHALL BE FULLY RESPONSIBLE FOR ANY DAMAGES CAUSED BY HIS FAILURE TO EXACTLY LOCATE AND PRESERVE ALL UNDERGROUND FACILITIES.
5. NO MORE TRENCH OPENED AT ONE TIME THAN CAN BE BACKFILLED AND COMPACTED IN 10' LIFTS AT THE END OF EACH DAY (NO TRENCH LEFT OPENED OVERNIGHT).
6. ALL EXCESS EXCAVATION TO BE REMOVED FROM THE ROAD RIGHT-OF-WAY AT THE END OF EACH DAY.
7. DITCHES TO BE OPENED AT THE END OF EACH DAY TO ASSURE ADEQUATE DRAINAGE.
8. ROAD MUST BE KEPT OPEN TO TRAFFIC AND CONTRACTOR MUST PROVIDE ADEQUATE FLAGMEN SIGNALS, ETC., TO PROVIDE COMPLETE SAFETY TO THE PUBLIC.
9. IF IT BECOMES NECESSARY FOR EQUIPMENT TO OPERATE ON A PORTION OF THE PAVEMENT PRECAUTIONS MUST BE TAKEN TO PREVENT ANY DAMAGE WHATSOEVER TO THE PAVEMENT.
10. CONDITION OF ROAD UPON COMPLETION OF JOB SHALL BE AS GOOD OR BETTER THAN PRIOR TO STARTING.
11. CONTRACTOR SHALL COMPLY WITH ALL APPLICABLE NATIONAL ELECTRICAL SAFETY CODE (NECS) REQUIREMENTS, CENTERPOINT AND APPLICABLE LOCAL REQUIREMENTS. ALL UNDERGROUND UTILITIES AND APPLICABLE LOCAL REQUIREMENTS CONCERNING TRENCHES, TRENCH PLACEMENT OF SERIAL CABLE FACILITIES, 18" MIN. VERTICAL CLEARANCE.
12. ALL UTILITIES WILL BE IDENTIFIED BY POTHOLE BEFORE ANY CONSTRUCTION.
13. CONCAST WILL MAINTAIN 20' HORIZONTAL & VERTICAL SEPARATION FROM ANY EXISTING UTILITIES.
14. THE CONTRACTOR TO CONTACT WALKER COUNTY PRECINCT 4 AT LEAST 48 HOURS PRIOR TO CONSTRUCTION.

DESIGNED BY:
QUANTA TELECOM SERVICES

DWG. NO.
SHEET NO. 03 OF 76

DATE: 06/18/2025
KEY MAP NO.
PST: 75P-75K-75F-75
SCALE: 1:40

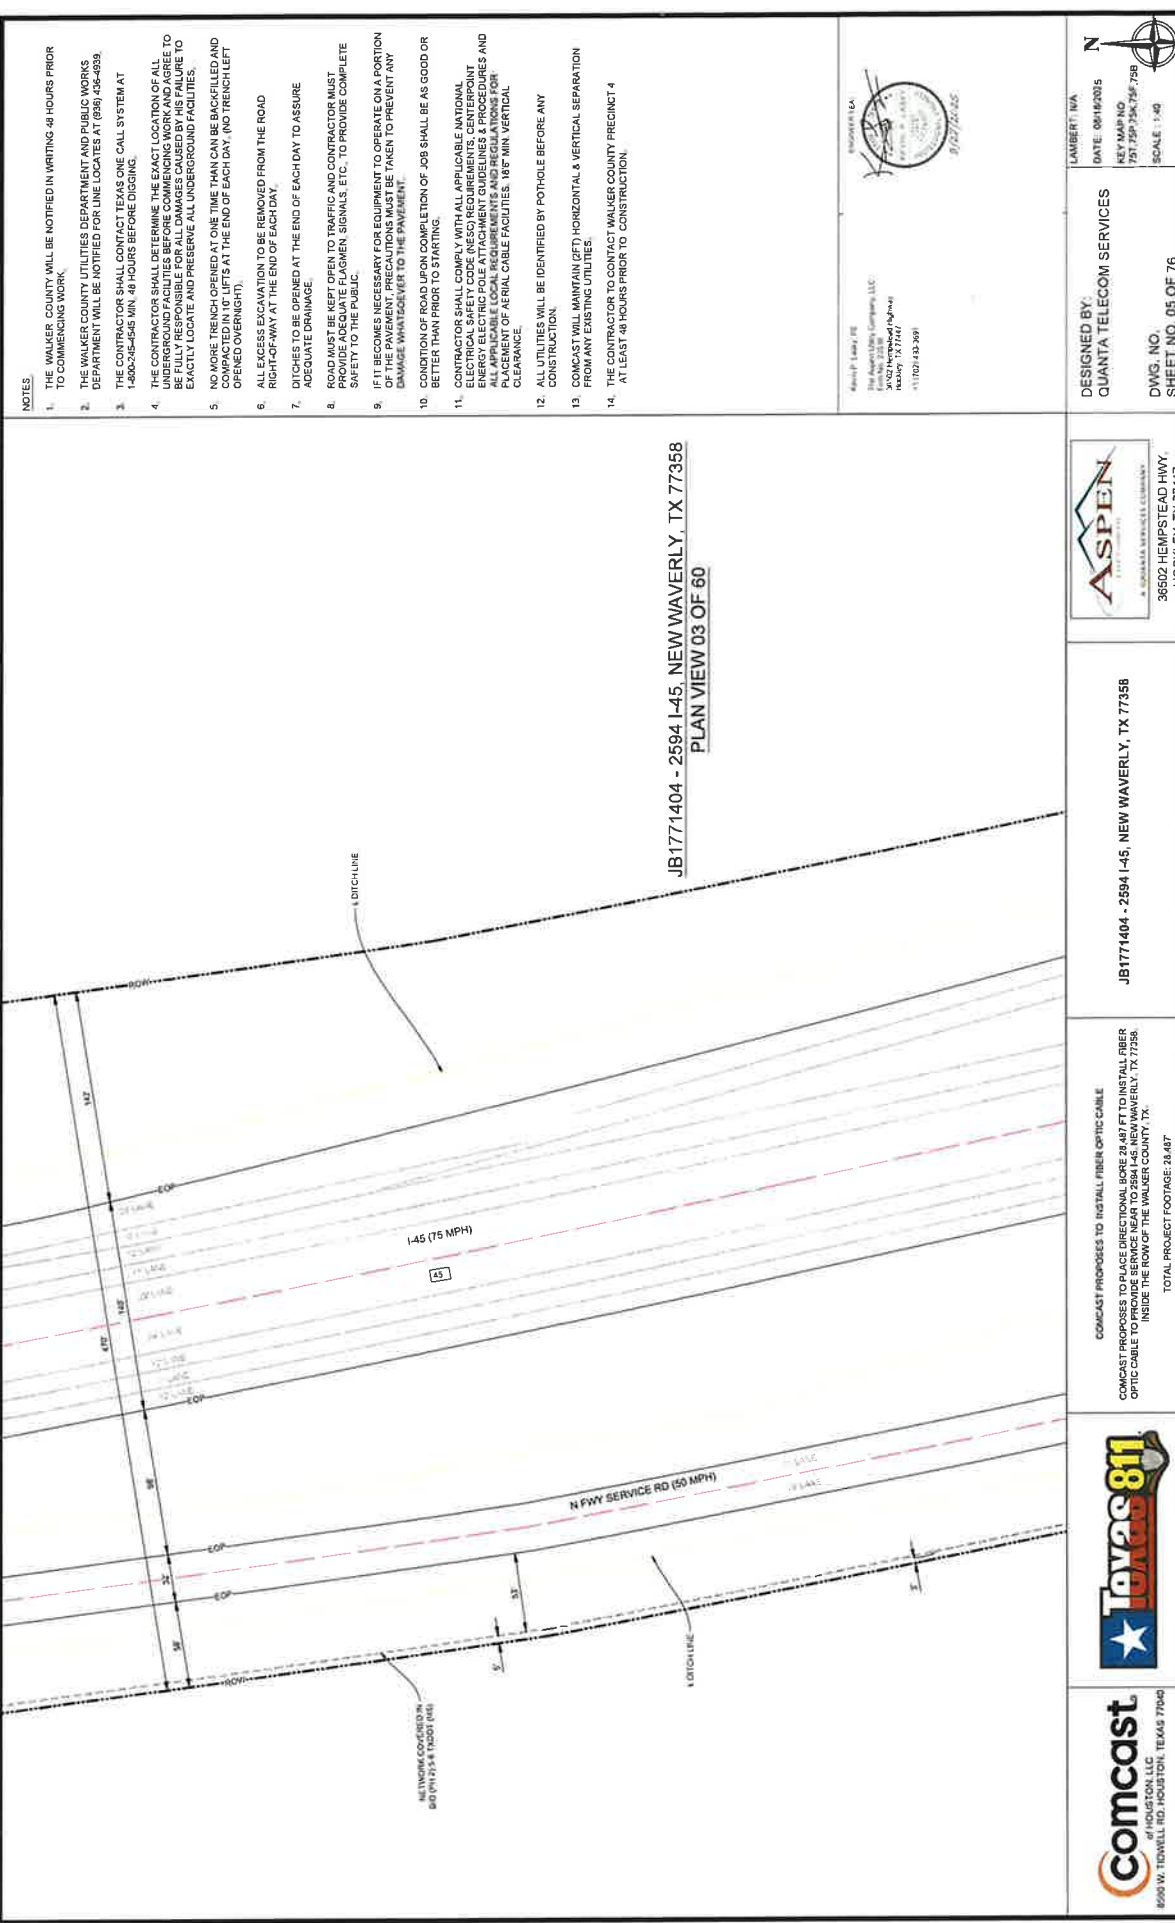

NOTES

1. THE WALKER COUNTY WILL BE NOTIFIED IN WRITING 48 HOURS PRIOR TO COMMENCING WORK.
2. THE WALKER COUNTY UTILITIES DEPARTMENT AND PUBLIC WORKS DEPARTMENT WILL BE NOTIFIED FOR LINE LOCATES AT (899) 456-4999.
3. THE CONTRACTOR SHALL CONTACT TEXAS ONE CALL SYSTEM AT 1-800-245-4545 MIN. 48 HOURS BEFORE DIGGING.
4. THE CONTRACTOR SHALL DETERMINE THE EXACT LOCATION OF ALL UNDERGROUND FACILITIES BEFORE COMMENCING WORK AND AGREE TO BE FULLY RESPONSIBLE FOR ALL DAMAGES CAUSED BY HIS FAILURE TO EXACTLY LOCATE AND PRESERVE ALL UNDERGROUND FACILITIES.
5. NO MORE TRENCH OPENED AT ONE TIME THAN CAN BE BACKFILLED AND COMPACTED IN 10' LIFTS AT THE END OF EACH DAY. (NO TRENCH LEFT OPENED OVERNIGHT).
6. ALL EXCESS EXCAVATION TO BE REMOVED FROM THE ROAD RIGHT-OF-WAY AT THE END OF EACH DAY.
7. DITCHES TO BE OPENED AT THE END OF EACH DAY TO ASSURE ADEQUATE DRAINAGE.
8. ROAD MUST BE KEPT OPEN TO TRAFFIC AND CONTRACTOR MUST PROVIDE ADEQUATE FLAGMEN, SIGNALS, ETC., TO PROVIDE COMPLETE SAFETY TO THE PUBLIC.
9. IF IT BECOMES NECESSARY FOR EQUIPMENT TO OPERATE ON A PORTION OF THE PAVEMENT, PRECAUTIONS MUST BE TAKEN TO PREVENT ANY DAMAGE WHATSOEVER TO THE PAVEMENT.
10. CONDITION OF ROAD UPON COMPLETION OF JOB SHALL BE AS GOOD OR BETTER THAN PRIOR TO STARTING.
11. CONTRACTOR SHALL COMPLY WITH ALL APPLICABLE NATIONAL ELECTRICAL SAFETY CODE (NEC) REQUIREMENTS, CENTERPOINT ENERGY ELECTRIC POLE ATTACHMENT GUIDELINES & PROCEDURES AND ALL APPLICABLE TEXAS REGULATIONS AND ORDINANCES FOR THE PLACEMENT OF AERIAL CABLE FACILITIES. 18' MIN VERTICAL CLEARANCE.
12. ALL UTILITIES WILL BE IDENTIFIED BY POT-HOLE BEFORE ANY CONSTRUCTION.
13. COMCAST WILL MAINTAIN (2FT) HORIZONTAL & VERTICAL SEPARATION FROM ANY EXISTING UTILITIES.
14. THE CONTRACTOR TO CONTACT WALKER COUNTY PRECINCT 4 AT LEAST 48 HOURS PRIOR TO CONSTRUCTION.

Kevin P. Lacey, PE
The Aspen Group, LLC
1501 West Loop South, Suite 200
Houston, TX 77047
(713) 727-1200



DESIGNED BY:
QUANTA TELECOM SERVICES

DWG. NO.
SHEET NO. 05 OF 76

ASPEN
A QUANTA NETWORKS COMPANY

36502 HEMPSTEAD HWY.
HOUSTON, TX 77047

JB1771404 - 2594 I-45, NEW WAVERLY, TX 77358

COMCAST PROPOSES TO INSTALL FIBER OPTIC CABLE
COMCAST PROPOSES TO PLACE DIRECTIONAL BORE 28.467 FT TO INSTALL FIBER OPTIC CABLE TO THE ROW OF THE WALKER COUNTY, TX.

TOTAL PROJECT FOOTAGE: 28.467

Texas 811

Comcast
HOUSTON, TX
8000 W. TIDWELL RD. HOUSTON, TEXAS 77040

RECEIVED
SEP 02 2025
BY:.....

JB1771404 - 2594 I-45, NEW WAVERLY, TX 77358
PLAN VIEW 04 OF 60



NOTES:

1. THE WALKER COUNTY WILL BE NOTIFIED IN WRITING 48 HOURS PRIOR TO COMMENCING WORK.
2. THE WALKER COUNTY UTILITIES DEPARTMENT AND PUBLIC WORKS DEPARTMENT WILL BE NOTIFIED FOR LINE LOCATES AT (936) 436-4335.
3. THE CONTRACTOR SHALL CONTACT TEXAS ONE CALL SYSTEM AT 1-800-455-4545 MIN. 48 HOURS BEFORE DIGGING.
4. THE CONTRACTOR SHALL DETERMINE THE EXACT LOCATION OF ALL UNDERGROUND FACILITIES BEFORE COMMENCING WORK AND AGREE TO BE RESPONSIBLE FOR ANY DAMAGE CAUSED BY HIS FAILURE TO EXACTLY LOCATE AND PRESERVE ALL UNDERGROUND FACILITIES.
5. NO MORE TRENCH OPENED AT ONE TIME THAN CAN BE BACKFILLED AND RECLOSED WITHIN 24 HOURS. ALL TRENCHES SHALL BE BACKFILLED AND OPENED OVERNIGHT.
6. ALL EXCESS EXCAVATION TO BE REMOVED FROM THE ROAD RIGHT-OF-WAY AT THE END OF EACH DAY.
7. DITCHES TO BE OPENED AT THE END OF EACH DAY TO ASSURE ADEQUATE DRAINAGE.
8. ROAD MUST BE KEPT OPEN TO TRAFFIC AND CONTRACTOR MUST PROVIDE ADEQUATE FLAGMEN, SIGNALS, ETC. TO PROVIDE COMPLETE SAFETY TO THE PUBLIC.
9. IF IT BECOMES NECESSARY FOR EQUIPMENT TO OPERATE ON A PORTION OF THE PAVEMENT, PRECAUTIONS MUST BE TAKEN TO PREVENT ANY DAMAGE WHATSOEVER TO THE PAVEMENT.
10. CONDITION OF ROAD UPON COMPLETION OF JOB SHALL BE AS GOOD OR BETTER THAN PRIOR TO STARTING.
11. CONTRACTOR SHALL COMPLY WITH ALL APPLICABLE NATIONAL ELECTRICAL SAFETY CODE (NEC) REQUIREMENTS, CENTERPOINT UTILITY REQUIREMENTS, AND ALL APPLICABLE LOCAL REQUIREMENTS AND REGULATIONS FOR PLACEMENT OF AERIAL CABLE FACILITIES. 18" MIN. VERTICAL CLEARANCE.
12. ALL UTILITIES WILL BE IDENTIFIED BY POT HOLE BEFORE ANY CONSTRUCTION.
13. COMCAST WILL MAINTAIN (2FT) HORIZONTAL & VERTICAL SEPARATION FROM ANY EXISTING UTILITIES.
14. THE CONTRACTOR TO COMCAST WALKER COUNTY PRECINCT 4 AT LEAST 48 HOURS PRIOR TO CONSTRUCTION.

Approved: _____
The Associated
Engineers & Surveyors
36502 Hempstead Highway
Hockley, TX 77447
Professional Seal
01/27/2025

DESIGNED BY:
QUANTA TELECOM SERVICES
DATE: 08/18/2025
KEY MAP NO.
75175P.75K.TXF.758
SCALE: 1" = 40'
DWG. NO.
SHEET NO. 06 OF 76

ASPHEN
A. S. SQUADERS REPORTS & CONSTRUCTION
36502 HEMPSTEAD HWY.
HOCKLEY, TX 77447

JB1771404 - 2594 I-45, NEW WAVERLY, TX 77358

COMCAST PROPOSES TO INSTALL FIBER OPTIC CABLE
COMCAST PROPOSES TO PLACE DIRECTIONAL BORE 28.467 FT TO INSTALL FIBER OPTIC CABLE TO PROVIDE SERVICE NEAR 2594 I-45, NEW WAVERLY, TX 77358 INSIDE THE ROW OF THE WALKER COUNTY, TX.
TOTAL PROJECT FOOTAGE: 38.467

Comcast
800 W. TIDWELL RD. HOUSTON, TEXAS 77040
Texas 811

Plan view of proposed I-45 interchange. The diagram shows the layout of the interchange, including the mainline I-45 (75 MPH) and the proposed E Feeder (30 MPH) and N FWY Service Rd (50 MPH). Key features include:

- Interchange Type:** A partial interchange with a single overpass for the E Feeder over I-45.
- Right-of-Way (ROW) and Easement of Property (EOP) Lines:** Indicated by solid and dashed lines.
- Drainage:** Ditch lines and drainage ditches (DW) are shown along the right side of the interchange.
- Stationing:** Station markers are present along the I-45 mainline.
- Notes:**
 - "45" in a box near the I-45 mainline.
 - "E FEEDER (30 MPH)" and "N FWY SERVICE RD (50 MPH)".
 - "I-45 (75 MPH)".
 - "DITCH LINE" labels pointing to specific ditch locations.
 - "DRAINAGE COVERED BY 80 MPH 5' x 10' DITCH (44)".

THE WALKER COUNTY WILL BE NOTIFIED IN WRITING 48 HOURS PRIOR TO COMMENCING WORK

1. THE WALKER COUNTY UTILITIES DEPARTMENT AND PUBLIC WORKS DEPARTMENT WILL BE NOTIFIED IN WRITING 48 HOURS PRIOR TO COMMENCING WORK.
2. THE WALKER COUNTY UTILITIES DEPARTMENT AND PUBLIC WORKS DEPARTMENT WILL BE NOTIFIED FOR LINE LOCATES AT (909) 434-9339.
3. THE CONTRACTOR SHALL CONDUCT TESTS ONE CALL SYSTEM AT 1800X50-525 MIN, 48 HOURS BEFORE DIGGING.
4. THE CONTRACTOR SHALL DETERMINE THE EXACT LOCATION OF ALL UNDERGROUND UTILITIES PRIOR TO ANY EXCAVATION. THE CONTRACTOR WILL BE FULLY RESPONSIBLE FOR ALL DAMAGES CAUSED BY HIS FAILURE TO EXACTLY LOCATE AND PRESERVE ALL UNDERGROUND FACILITIES.
5. NO TRENCH OPENED AT ONE TIME THAT CAN BE BACKFILLED AND COMPLETED IN 12' LIFTS AT THE END OF EACH DAY, (NO TRENCH LEFT OPENED OVERNIGHT).
6. ALL EXCESS EXCAVATION TO BE REMOVED FROM THE ROAD RIGHT-OF-WAY AT THE END OF EACH DAY.
7. DITCHES TO BE OPENED AT THE END OF EACH DAY TO ASSURE ADEQUATE DRAINAGE.
8. ROAD MUST BE KEPT OPEN TO TRAFFIC AND CONTRACTOR MUST PROVIDE ADEQUATE FLAGMEN, SIGNALS, ETC., TO PROVIDE COMPLETE SAFETY TO THE PUBLIC.
9. IF IT BECOMES NECESSARY FOR EQUIPMENT TO OPERATE ON A PORTION OF THE PAVEMENT, PRECAUTIONS MUST BE TAKEN TO PREVENT ANY DAMAGE WHATSOEVER TO THE PAVEMENT.
10. CONDITION OF ROAD UPON COMPLETION OF JOB SHALL BE AS GOOD OR BETTER THAN PRIOR TO STARTING.
11. CONTRACTOR SHALL COMPLY WITH ALL APPLICABLE NATIONAL ELECTRICAL SAFETY CODE (NEC) REQUIREMENTS, CENTERTOP REQUIREMENTS, AND ALL APPLICABLE LOCAL REQUIREMENTS AND REGULATIONS FOR PLACEMENT OF FEMAL CABLE FACILITIES, 18" MIN. VERTICAL CLEARANCE.
12. ALL UTILITIES WILL BE IDENTIFIED BY POT-HOLE BEFORE ANY CONSTRUCTION.
13. CONCAST WILL MAINTAIN (27') HORIZONTAL & VERTICAL SEPARATION FROM ANY EXISTING UTILITIES.
14. THE CONTRACTOR TO CONTACT WALKER COUNTY PRECINCT 4 AT LEAST 48 HOURS PRIOR TO CONSTRUCTION.

The Acumen Utility Company, LLC
Form No. 23526
36012 Hempstead Highway
Houston, TX 77447



ASPIEN

JUB1771404 - 2594 I-45, NEW WAVERLY, TX 77358

COMCAST PROPOSES TO INSTALL FIBER OPTIC CABLE
COMCAST PROPOSES TO PLACE DIRECTIONAL BORE 28.487 FT TO INSTALL FIBER
OPTIC CABLE TO PROVIDE SERVICE NEAR TO 2594 I-45, NEW WAVERLY, TX 77358
INSIDE THE ROW OF THE WALKER COUNTY, TX.

TOTAL PROJECT FOOTAGE: 28:48Y



 
comcast
a houston, llc
5500 W. TIDWELL RD HOUSTON, TEXAS 77040

AUBERT N/A

DESIGNED BY:
QUANTA TELECOM SERVICES

DWG. NO.

DWG. NO.
SHEET NO. 07 OF 76



© 2004 Blackwell Publishing Ltd, *Journal of Internal Medicine* 255: 105–112

DATE: 08/18/2025

DATE: 08/18/2025

DATE: 08/18/2025

NOTES

1. THE WALKER COUNTY WILL BE NOTIFIED IN WRITING 48 HOURS PRIOR TO COMMENCING WORK.
2. THE WALKER COUNTY UTILITIES DEPARTMENT AND PUBLIC WORKS DEPARTMENT WILL BE NOTIFIED FOR LINES LOCATED AT (800) 454-4938.
3. THE CONTRACTOR SHALL CONTACT TEXAS ONE CALL SYSTEM AT 1-800-245-4545 MIN. 48 HOURS BEFORE DIGGING.
4. THE CONTRACTOR SHALL DETERMINE THE EXACT LOCATION OF ALL UNDERGROUND UTILITIES BEFORE COMMENCING WORK AND AGREE TO BE RESPONSIBLE FOR ANY DAMAGE TO EXISTING UTILITIES. UTILITIES TO EXACTLY LOCATE AND PRESERVE ALL UNDERGROUND FACILITIES.
5. NO MORE TRENCH OPENED AT ONE TIME THAN CAN BE BACKFILLED AND COMPACTED IN 10' LIFTS AT THE END OF EACH DAY. (NO TRENCH LEFT OPENED OVERNIGHT).
6. ALL EXCESS EXCAVATION TO BE REMOVED FROM THE ROAD RIGHT-OF-WAY AT THE END OF EACH DAY.
7. POTHOLE TO BE OPENED AT THE END OF EACH DAY TO ASSURE ADEQUATE DRAINAGE.
8. ROAD MUST BE KEPT OPEN TO TRAFFIC AND CONTRACTOR MUST MAINTAIN ADEQUATE TRAFFIC CONTROL, SIGNS, ETC., TO PROVIDE COMPLETE SAFETY TO THE PUBLIC.
9. IF IT BECOMES NECESSARY FOR EQUIPMENT TO OPERATE ON A PORTION OF THE WALKER COUNTY ROAD, THE CONTRACTOR SHALL TAKE ALL NECESSARY MEASURES TO PREVENT DAMAGE WHATSOEVER TO THE PAVEMENT.
10. CONDITION OF ROAD UPON COMPLETION OF JOB SHALL BE AS GOOD OR BETTER THAN PRIOR TO STARTING.
11. CONTRACTOR SHALL COMPLY WITH ALL APPLICABLE NATIONAL AND STATE REQUIREMENTS FOR THE PROTECTION OF EXISTING UTILITIES. ALL APPLICABLE LOCAL REQUIREMENTS AND REGULATIONS FOR PLACEMENT OF AERIAL CABLE FACILITIES, 18\"/>
12. ALL UTILITIES WILL BE IDENTIFIED BY POTHOLE BEFORE ANY CONSTRUCTION.
13. COMCAST WILL MAINTAIN (2FT) HORIZONTAL & VERTICAL SEPARATION FROM ANY EXISTING UTILITIES.
14. THE CONTRACTOR TO CONTACT WALKER COUNTY PRECINCT 4 AT LEAST 48 HOURS PRIOR TO CONSTRUCTION.

DESIGNED BY:
QUANTA TELECOM SERVICES

DATE: 08/18/2025
KEY MAP NO.
751771404-2594
SCALE: 1"=40'

LAMBERT, N/A

DESIGNED BY:
QUANTA TELECOM SERVICES

DATE: 08/18/2025
KEY MAP NO.
751771404-2594
SCALE: 1"=40'

LAMBERT, N/A

DESIGNED BY:
QUANTA TELECOM SERVICES

DATE: 08/18/2025
KEY MAP NO.
751771404-2594
SCALE: 1"=40'

LAMBERT, N/A

DESIGNED BY:
QUANTA TELECOM SERVICES

DATE: 08/18/2025
KEY MAP NO.
751771404-2594
SCALE: 1"=40'

LAMBERT, N/A

DESIGNED BY:
QUANTA TELECOM SERVICES

DATE: 08/18/2025
KEY MAP NO.
751771404-2594
SCALE: 1"=40'

LAMBERT, N/A

DESIGNED BY:
QUANTA TELECOM SERVICES

DATE: 08/18/2025
KEY MAP NO.
751771404-2594
SCALE: 1"=40'

LAMBERT, N/A

DESIGNED BY:
QUANTA TELECOM SERVICES

DATE: 08/18/2025
KEY MAP NO.
751771404-2594
SCALE: 1"=40'

LAMBERT, N/A

DESIGNED BY:
QUANTA TELECOM SERVICES

DATE: 08/18/2025
KEY MAP NO.
751771404-2594
SCALE: 1"=40'

LAMBERT, N/A

DESIGNED BY:
QUANTA TELECOM SERVICES

DATE: 08/18/2025
KEY MAP NO.
751771404-2594
SCALE: 1"=40'

LAMBERT, N/A

DESIGNED BY:
QUANTA TELECOM SERVICES

DATE: 08/18/2025
KEY MAP NO.
751771404-2594
SCALE: 1"=40'

LAMBERT, N/A

DESIGNED BY:
QUANTA TELECOM SERVICES

DATE: 08/18/2025
KEY MAP NO.
751771404-2594
SCALE: 1"=40'

LAMBERT, N/A

DESIGNED BY:
QUANTA TELECOM SERVICES

DATE: 08/18/2025
KEY MAP NO.
751771404-2594
SCALE: 1"=40'

LAMBERT, N/A

DESIGNED BY:
QUANTA TELECOM SERVICES

DATE: 08/18/2025
KEY MAP NO.
751771404-2594
SCALE: 1"=40'

LAMBERT, N/A

DESIGNED BY:
QUANTA TELECOM SERVICES

DATE: 08/18/2025
KEY MAP NO.
751771404-2594
SCALE: 1"=40'

LAMBERT, N/A

DESIGNED BY:
QUANTA TELECOM SERVICES

DATE: 08/18/2025
KEY MAP NO.
751771404-2594
SCALE: 1"=40'

LAMBERT, N/A

DESIGNED BY:
QUANTA TELECOM SERVICES

DATE: 08/18/2025
KEY MAP NO.
751771404-2594
SCALE: 1"=40'

LAMBERT, N/A

DESIGNED BY:
QUANTA TELECOM SERVICES

DATE: 08/18/2025
KEY MAP NO.
751771404-2594
SCALE: 1"=40'

LAMBERT, N/A

DESIGNED BY:
QUANTA TELECOM SERVICES

DATE: 08/18/2025
KEY MAP NO.
751771404-2594
SCALE: 1"=40'

LAMBERT, N/A

DESIGNED BY:
QUANTA TELECOM SERVICES

DATE: 08/18/2025
KEY MAP NO.
751771404-2594
SCALE: 1"=40'

LAMBERT, N/A

DESIGNED BY:
QUANTA TELECOM SERVICES

DATE: 08/18/2025
KEY MAP NO.
751771404-2594
SCALE: 1"=40'

LAMBERT, N/A

DESIGNED BY:
QUANTA TELECOM SERVICES

DATE: 08/18/2025
KEY MAP NO.
751771404-2594
SCALE: 1"=40'

LAMBERT, N/A

DESIGNED BY:
QUANTA TELECOM SERVICES

DATE: 08/18/2025
KEY MAP NO.
751771404-2594
SCALE: 1"=40'

LAMBERT, N/A

DESIGNED BY:
QUANTA TELECOM SERVICES

DATE: 08/18/2025
KEY MAP NO.
751771404-2594
SCALE: 1"=40'

LAMBERT, N/A

DESIGNED BY:
QUANTA TELECOM SERVICES

DATE: 08/18/2025
KEY MAP NO.
751771404-2594
SCALE: 1"=40'

LAMBERT, N/A

DESIGNED BY:
QUANTA TELECOM SERVICES

DATE: 08/18/2025
KEY MAP NO.
751771404-2594
SCALE: 1"=40'

LAMBERT, N/A

DESIGNED BY:
QUANTA TELECOM SERVICES

DATE: 08/18/2025
KEY MAP NO.
751771404-2594
SCALE: 1"=40'

LAMBERT, N/A

DESIGNED BY:
QUANTA TELECOM SERVICES

DATE: 08/18/2025
KEY MAP NO.
751771404-2594
SCALE: 1"=40'

LAMBERT, N/A

DESIGNED BY:
QUANTA TELECOM SERVICES

DATE: 08/18/2025
KEY MAP NO.
751771404-2594
SCALE: 1"=40'

LAMBERT, N/A

DESIGNED BY:
QUANTA TELECOM SERVICES

DATE: 08/18/2025
KEY MAP NO.
751771404-2594
SCALE: 1"=40'

LAMBERT, N/A

DESIGNED BY:
QUANTA TELECOM SERVICES

DATE: 08/18/2025
KEY MAP NO.
751771404-2594
SCALE: 1"=40'

LAMBERT, N/A

DESIGNED BY:
QUANTA TELECOM SERVICES

DATE: 08/18/2025
KEY MAP NO.
751771404-2594
SCALE: 1"=40'

LAMBERT, N/A

DESIGNED BY:
QUANTA TELECOM SERVICES

DATE: 08/18/2025
KEY MAP NO.
751771404-2594
SCALE: 1"=40'

LAMBERT, N/A


DESIGNED BY:
QUANTA TELECOM SERVICES

DATE



JB1771404 - 2594 I-45, NEW WAVERLY, TX 77358
PLAN VIEW 07 OF 60

- NOTES**
1. THE WALKER COUNTY WILL BE NOTIFIED IN WRITING 48 HOURS PRIOR TO COMMENCING WORK.
 2. THE WALKER COUNTY UTILITIES DEPARTMENT AND PUBLIC WORKS DEPARTMENT WILL BE NOTIFIED FOR LINE LOCATES AT (936) 436-4339.
 3. THE CONTRACTOR SHALL CONTACT TEXAS ONE CALL SYSTEM AT 1-800-45-4545 MIN. 48 HOURS BEFORE DIGGING.
 4. THE CONTRACTOR SHALL DETERMINE THE EXACT LOCATION OF ALL UNDERGROUND FACILITIES BEFORE COMMENCING WORK AND AGREE TO BE FULLY RESPONSIBLE FOR ALL DAMAGES CAUSED BY HIS FAILURE TO EXACTLY LOCATE AND PRESERVE ALL UNDERGROUND FACILITIES.
 5. NO MORE TRENCH OPENED AT ONE TIME THAN CAN BE BACKFILLED AND COMPACTED IN 10' LIFTS AT THE END OF EACH DAY. (NO TRENCH LEFT OPENED OVERNIGHT).
 6. ALL EXCESS EXCAVATION TO BE REMOVED FROM THE ROAD RIGHT-OF-WAY AT THE END OF EACH DAY.
 7. DITCHES TO BE OPENED AT THE END OF EACH DAY TO ASSURE ADEQUATE DRAINAGE.
 8. ROAD MUST BE KEPT OPEN TO TRAFFIC AND CONTRACTOR MUST PROVIDE ADEQUATE FLAGMEN, SIGNALS, ETC. TO PROVIDE COMPLETE SAFETY TO THE PUBLIC.
 9. IF IT BECOMES NECESSARY FOR EQUIPMENT TO OPERATE ON A PORTION OF THE PAVEMENT, PRECAUTIONS MUST BE TAKEN TO PREVENT ANY DAMAGE WHATSOEVER TO THE PAVEMENT.
 10. CONDITION OF ROAD UPON COMPLETION OF JOB SHALL BE AS GOOD OR BETTER THAN PRIOR TO STARTING.
 11. CONTRACTOR SHALL COMPLY WITH ALL APPLICABLE NATIONAL ELECTRICAL SAFETY CODE (NEC) REQUIREMENTS, CENTERPOINT ENERGY ELECTRICAL POLE ATTACHMENT GUIDELINES & PROCEDURES AND ALL APPLICABLE LOCAL REQUIREMENTS AND REGULATIONS FOR THE INSTALLATION OF AERIAL CABLE FACILITIES. 18' MIN. VERTICAL CLEARANCE.
 12. ALL UTILITIES WILL BE IDENTIFIED BY POTHOLE BEFORE ANY CONSTRUCTION.
 13. COMCAST WILL MAINTAIN (2FT) HORIZONTAL & VERTICAL SEPARATION FROM ANY EXISTING UTILITIES.
 14. THE CONTRACTOR TO CONTACT WALKER COUNTY PRECINCT 4 AT LEAST 48 HOURS PRIOR TO CONSTRUCTION.

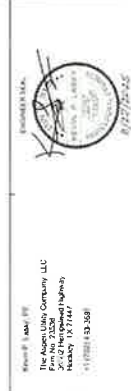

DESIGNED BY:
QUANTA TELECOM SERVICES

DATE: 08/19/2025
KEY MAP NO:
75173P/35C/347338

DWG. NO.
SHEET NO. 09 OF 76

SCALE: 1" = 40'




JB1771404 - 2594 I-45, NEW WAVERLY, TX 77358

COMCAST PROPOSES TO INSTALL FIBER OPTIC CABLE
COMCAST PROPOSES TO PLACE DIRECTIONAL BORE 28.481 FT TO INSTALL FIBER OPTIC CABLE TO THE LOCATION OF THE PROJECT, TX 77358
INSIDE THE ROW OF THE WALKER COUNTY, TX.

TOTAL PROJECT FOOTAGE: 28.481



RECEIVED
SEP 02 2025
BY:.....

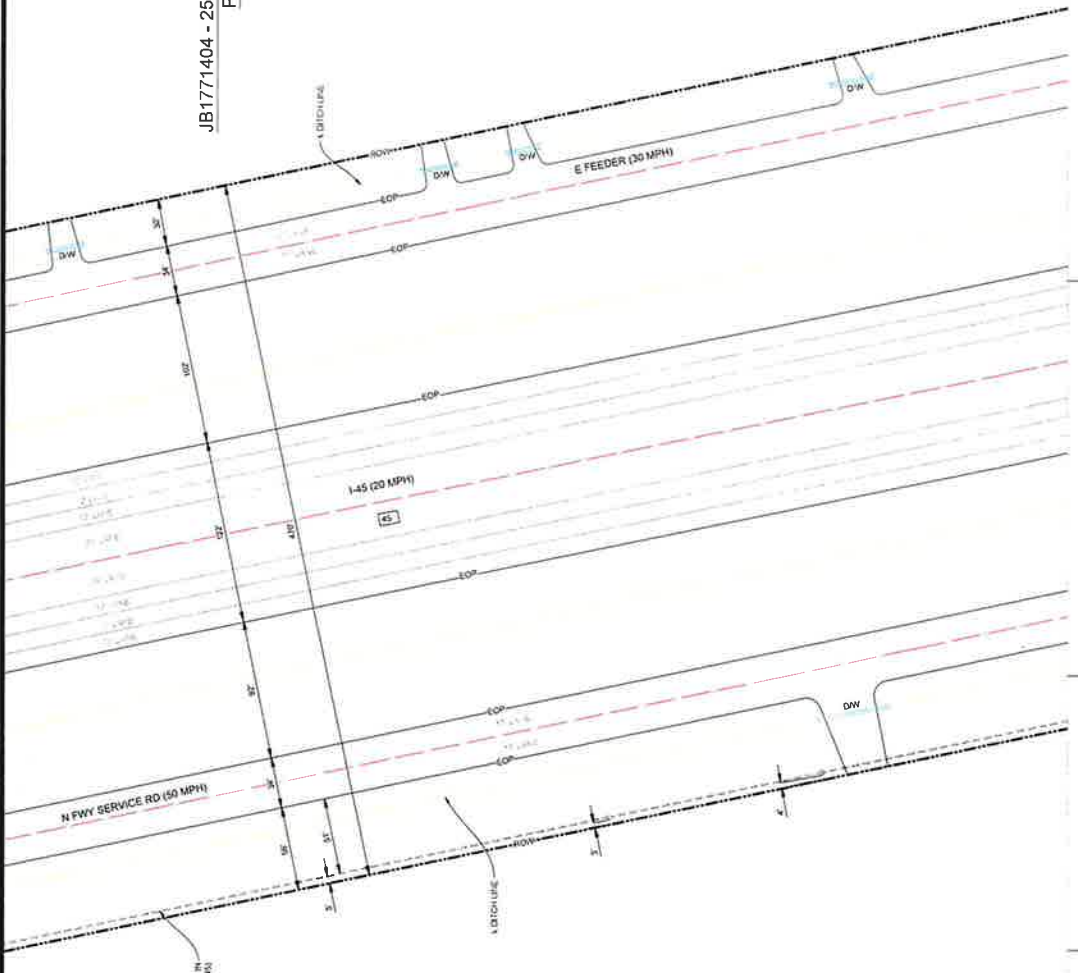

JB1771404 - 2594 I-45, NEW WAVERLY, TX 77358
PLAN VIEW 08 OF 60

NOTES

1. THE WALKER COUNTY WILL BE NOTIFIED IN WRITING 48 HOURS PRIOR TO COMMENCING WORK.
2. THE WALKER COUNTY UTILITIES DEPARTMENT AND PUBLIC WORKS DEPARTMENT WILL BE NOTIFIED FOR LINE LOCATES AT (830) 436-0333.
3. THE CONTRACTOR SHALL CONTACT TEXAS ONE CALL SYSTEM AT 1-800-345-4545 MIN. 48 HOURS BEFORE DIGGING.
4. THE CONTRACTOR SHALL DETERMINE THE EXACT LOCATION OF ALL UNDERGROUND FACILITIES BEFORE COMMENCING WORK AND AGREE TO BE RESPONSIBLE FOR ALL DAMAGES CAUSED BY HIS FAILURE TO EXACTLY LOCATE AND PREPARE ALL UNDERGROUND FACILITIES.
5. NO MORE TRENCH OPENED AT ONE TIME THAN CAN BE BACKFILLED AND COMPLETED WITHIN 24 HOURS AT THE END OF EACH DAY, (NO TRENCH LEFT OPENED OVERNIGHT).
6. ALL EXCESS EXCAVATION TO BE REMOVED FROM THE ROAD RIGHT-OF-WAY AT THE END OF EACH DAY.
7. DITCHES TO BE OPENED AT THE END OF EACH DAY TO ASSURE ADEQUATE DRAINAGE.
8. ROAD MUST BE KEPT OPEN TO TRAFFIC AND CONTRACTOR MUST PROVIDE ADEQUATE FLAGMEN, SIGNALS, ETC. TO PROVIDE COMPLETE SAFETY TO THE PUBLIC.
9. IF IT BECOMES NECESSARY FOR EQUIPMENT TO OPERATE ON A PORTION OF THE PAVEMENT, PRECAUTIONS MUST BE TAKEN TO PREVENT ANY DAMAGE WHATSOEVER TO THE PAVEMENT.
10. CONDITION OF ROAD UPON COMPLETION OF JOB SHALL BE AS GOOD OR BETTER THAN PRIOR TO STARTING.
11. CONTRACTOR SHALL COMPLY WITH ALL APPLICABLE NATIONAL ELECTRICAL SAFETY CODE (NEC) REQUIREMENTS, CENTERPOINT ELECTRICITY DELIVERY RULES AND REGULATIONS, AND ALL APPLICABLE LOCAL REQUIREMENTS AND REGULATIONS FOR PLACEMENT OF AERIAL CABLE FACILITIES. 18" MIN. VERTICAL CLEARANCE.
12. ALL UTILITIES WILL BE IDENTIFIED BY POTHOLE BEFORE ANY CONSTRUCTION.
13. COMCAST WILL MAINTAIN (2FT) HORIZONTAL & VERTICAL SEPARATION FROM ANY EXISTING UTILITIES.
14. THE CONTRACTOR TO CONTACT WALKER COUNTY PRECINCT 4 AT LEAST 48 HOURS PRIOR TO CONSTRUCTION.

LAURENT, WA
DATE: 08/16/2025
KEY MAP NO.
731 734 734 734 734
SCALE: 1" = 40'

DESIGNED BY:
QUANTA TELECOM SERVICES

DWG. NO.
SHEET NO. 10 OF 76

35502 HEMPSTEAD HWY.
HOCKLEY, TX 77447

JB1771404 - 2594 I-45, NEW WAVERLY, TX 77358

COMCAST PROPOSES TO INSTALL FIBER OPTIC CABLE
COMCAST PROPOSES TO PLACE DIRECTIONAL BORE 28.40' FT TO INSTALL FIBER
OPTIC CABLE TO PROVIDE SERVICE NEAR TO 2594 I-45, NEW WAVERLY, TX 77358
INSIDE THE ROW OF THE WALKER COUNTY, TX.
TOTAL PROJECT FOOTAGE: 28.40'

comcast
#HOUSTON, LLC
6500 W. TIDWELL RD. HOUSTON, TEXAS 77040

Texas 811

THE ASPEN GROUP
A SPINOFF OF THE ASPEN GROUP
35502 HEMPSTEAD HWY.
HOCKLEY, TX 77447

LAURENT, WA
DATE: 08/16/2025
KEY MAP NO.
731 734 734 734 734
SCALE: 1" = 40'

DESIGNED BY:
QUANTA TELECOM SERVICES

DWG. NO.
SHEET NO. 10 OF 76

35502 HEMPSTEAD HWY.
HOCKLEY, TX 77447

JB1771404 - 2594 I-45, NEW WAVERLY, TX 77358

COMCAST PROPOSES TO INSTALL FIBER OPTIC CABLE
COMCAST PROPOSES TO PLACE DIRECTIONAL BORE 28.40' FT TO INSTALL FIBER
OPTIC CABLE TO PROVIDE SERVICE NEAR TO 2594 I-45, NEW WAVERLY, TX 77358
INSIDE THE ROW OF THE WALKER COUNTY, TX.
TOTAL PROJECT FOOTAGE: 28.40'

comcast
#HOUSTON, LLC
6500 W. TIDWELL RD. HOUSTON, TEXAS 77040

Texas 811

THE ASPEN GROUP
A SPINOFF OF THE ASPEN GROUP
35502 HEMPSTEAD HWY.
HOCKLEY, TX 77447



1. THE WALKER COUNTY WILL BE NOTIFIED IN WRITING 48 HOURS PRIOR TO COMMENCING WORK.
2. THE WALKER COUNTY UTILITIES DEPARTMENT AND PUBLIC WORKS DEPARTMENT WILL BE NOTIFIED FOR ONE LOCATES AT (800) 368-4939
3. THE CONTRACTOR SHALL CONTACT TEXARK ONE CALL SYSTEM AT 1-800-525-4545 MIN. 48 HOURS BEFORE DUGGINGS.
4. THE CONTRACTOR SHALL DETERMINE THE EXACT LOCATION OF ALL UTILITIES AND BE FULLY RESPONSIBLE FOR ALL DAMAGES CAUSED BY HIS FAILURE TO EXACTLY LOCATE AND PRESERVE ALL UNDERGROUND FACILITIES.
5. NO MORE FRENCH CROWNED AT ONE TIME THAN CAN BE BACKFILLED AND COMPACTED IN 10' LIFTS AT THE END OF EACH DAY. (NO TRENCH LEFT OPEN OVERNIGHT).
6. ALL EXCESS EXCAVATION TO BE REMOVED FROM THE ROAD RIGHT-OF-WAY AT THE END OF EACH DAY.
7. DITCHES TO BE OPENED AT THE END OF EACH DAY TO ASSURE ADEQUATE DRAINAGE.
8. ROAD MUST BE KEPT OPEN TO TRAFFIC AND CONTRACTOR MUST PROVIDE ADEQUATE FLAGMEN, SIGNALS, ETC., TO PROVIDE COMPLETE SAFETY TO THE PUBLIC.
9. IF IT BECOMES NECESSARY FOR EQUIPMENT TO OPERATE ON A PORTION OF THE PAVEMENT, PRECAUTIONS MUST BE TAKEN TO PREVENT ANY DAMAGE WHATSOEVER TO THE PAVEMENT.
10. CONDITION OF ROAD UPON COMPLETION OF JOB SHALL BE AS GOOD OR BETTER THAN PRIOR TO STARTING.
11. CONTRACTOR SHALL COMPLY WITH ALL APPLICABLE NATIONAL ELECTRICAL SAFETY CODE (NEC) REQUIREMENTS, CENTERPOINT ENERGY ELECTRIC POLE ATTACHMENT GUIDELINES & PROCEDURES AND ALL OTHER APPLICABLE REGULATIONS AND STANDARDS FOR THE PLACEMENT OF AERIAL CABLE FACILITIES. 18" MIN. VERTICAL CLEARANCE.
12. ALL UTILITIES WILL BE IDENTIFIED BY POT HOLE BEFORE ANY CONSTRUCTION.
13. CONTRACT WILL MAINTAIN (27") HORIZONTAL & VERTICAL SEPARATION FROM ANY EXISTING UTILITIES.
14. THE CONTRACTOR FOR PROJECT WALKER COUNTY PRECINCT 4 AT LEAST 48 HOURS PRIOR TO CONSTRUCTION.

JB1771404 - 2594 I-45, NEW WAVERLY, TX 77358
PLAN VIEW 09 OF 60

File: Aspen USA Company LLC
Form 943 2-15-26
M-12 Hired/Unpaid (Inflow)
Worksheet 1X 7/44/



LAMBERT: N/A
 DATE: 08/18/2022
 KEY MAP NO.
 191.FSP.FSA.FSF
 SCALE: 1:40

DESIGNED BY:
QUANTA TELECOM SERVICES

DWG. NO.
SHEET NO. 11 OF 76



JJB1771404 - 2594 I-45, NEW WAVERLY, TX 77358

COMCAST PROPOSES TO INSTALL FIBER OPTIC CABLE


COMCAST PROPOSES TO PLACE DIRECTIONAL BORE 28.487 FT TO INSTALL FIBER OPTIC CABLE TO PROVIDE SERVICE NEAR TO 2584 I-45, NEW WAVERLY, TX 77358. INSIDE THE ROW OF THE WALKER COUNTY, TX.

TOTAL PROJECT FOOTAGE: 28.487



590 W. TIDWELL RD. HOUSTON, TEXAS 77040
e/HOUSTON, LLC

RECEIVED
SEP 02 2025
RY.

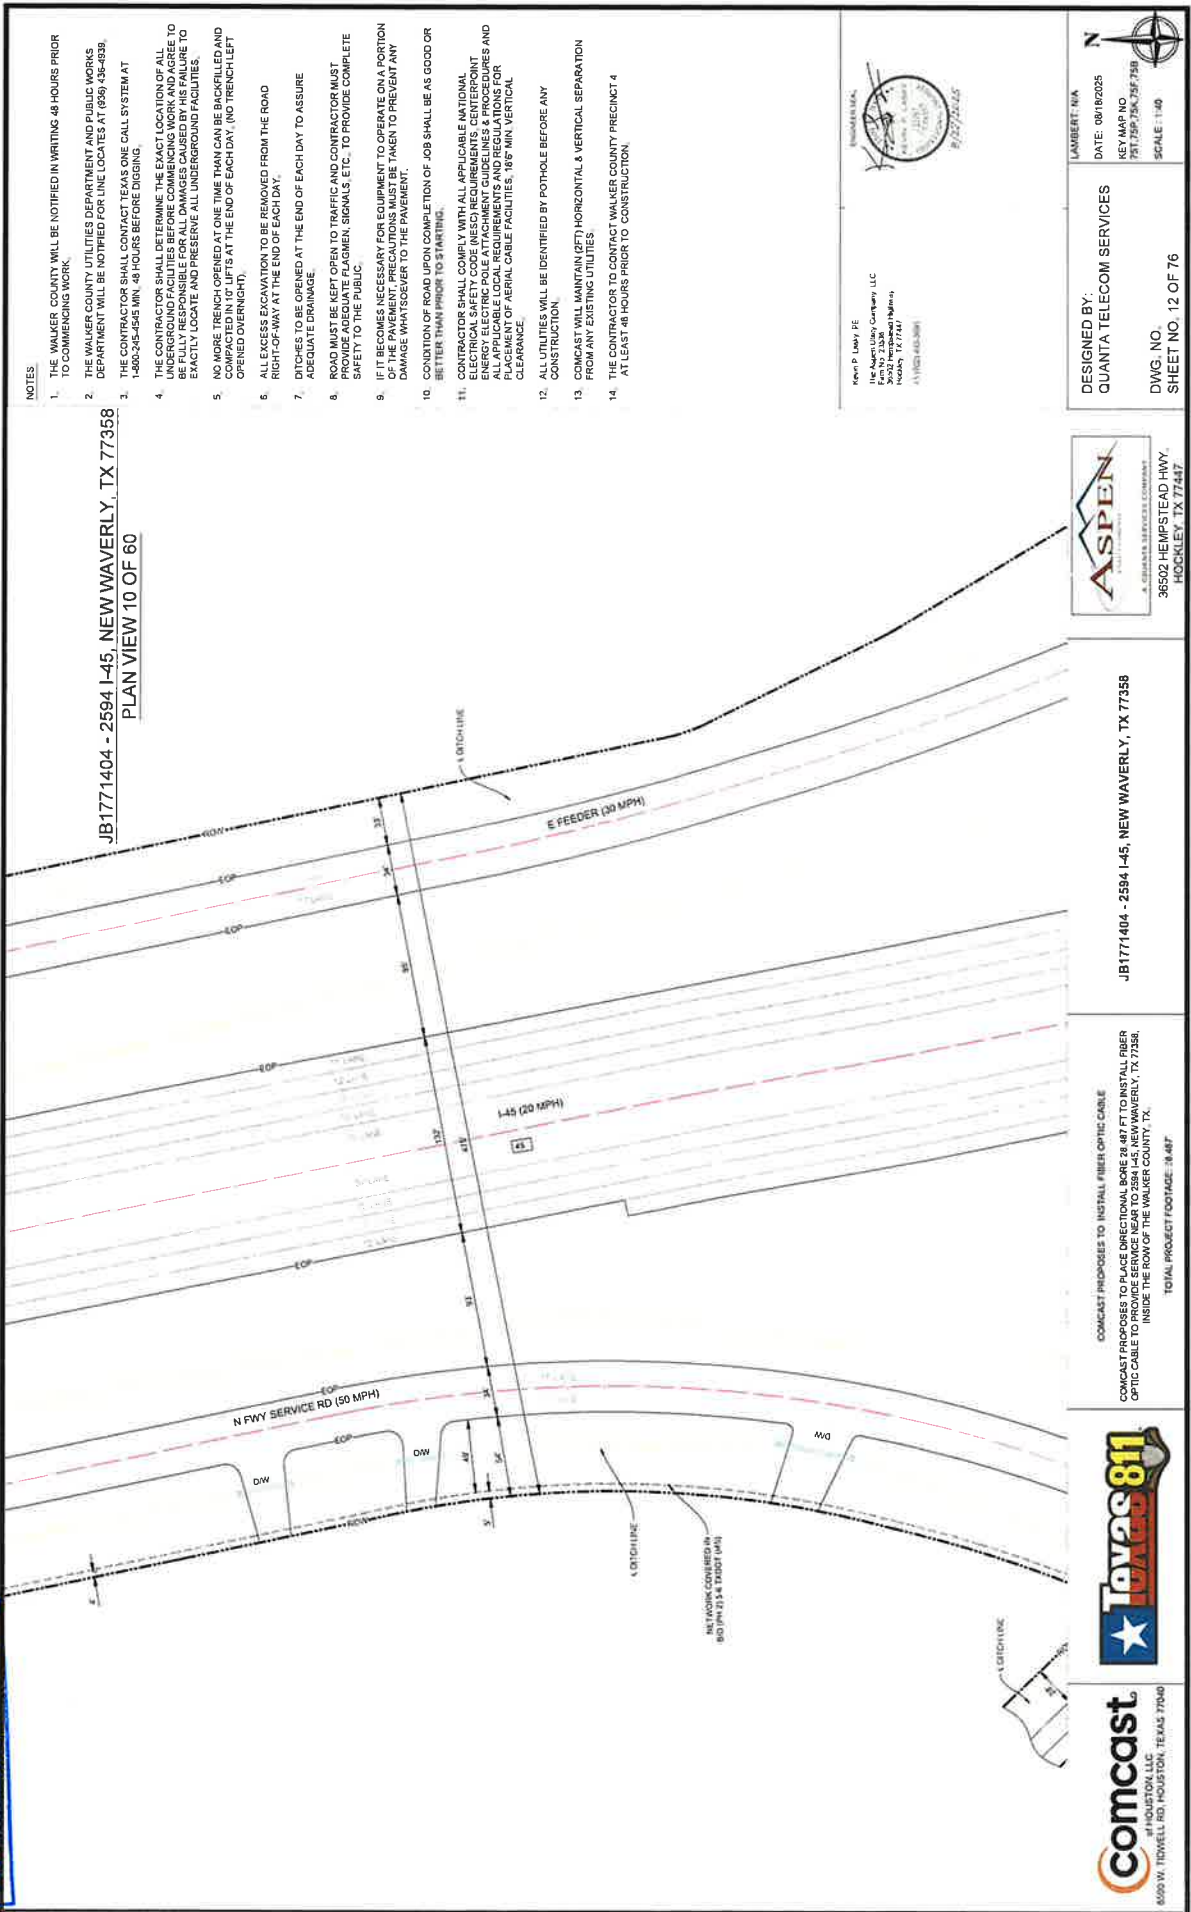

NOTES

1. THE WALKER COUNTY WILL BE NOTIFIED IN WRITING 48 HOURS PRIOR TO COMMENCING WORK.
2. THE WALKER COUNTY UTILITIES DEPARTMENT AND PUBLIC WORKS DEPARTMENT WILL BE NOTIFIED FOR LINE LOCATES AT (659) 436-4939.
3. THE CONTRACTOR SHALL CONTACT TEXAS ONE CALL SYSTEM AT 1-800-255-5445 MIN. 48 HOURS BEFORE DIGGING.
4. THE CONTRACTOR SHALL DETERMINE THE EXACT LOCATION OF ALL UNDERGROUND FACILITIES BEFORE COMMENCING WORK AND AGREE TO FULLY REPAIR ANY DAMAGE CAUSED BY HIS FAILURE TO EXACTLY LOCATE AND PRESERVE ALL UNDERGROUND FACILITIES.
5. NO MORE TRENCH OPENED AT ONE TIME THAN CAN BE BACKFILLED AND COMPACTED WITHIN 24 HOURS AT THE END OF EACH DAY. (NO TRENCH LEFT OPEN OVERNIGHT).
6. ALL EXCESS EXCAVATION TO BE REMOVED FROM THE ROAD RIGHT-OF-WAY AT THE END OF EACH DAY.
7. DITCHES TO BE OPENED AT THE END OF EACH DAY TO ASSURE ADEQUATE DRAINAGE.
8. ROAD MUST BE KEPT OPEN TO TRAFFIC AND CONTRACTOR MUST PROVIDE ADEQUATE FLAGMEN, SIGNALS, ETC., TO PROVIDE COMPLETE SAFETY TO THE PUBLIC.
9. IF IT BECOMES NECESSARY FOR EQUIPMENT TO OPERATE ON A PORTION OF THE PAVEMENT, PRECAUTIONS MUST BE TAKEN TO PREVENT ANY DAMAGE WHATSOEVER TO THE PAVEMENT.
10. CONDITION OF ROAD UPON COMPLETION OF JOB SHALL BE AS GOOD OR BETTER THAN PRIOR TO STARTING.
11. CONTRACTOR SHALL COMPLY WITH ALL APPLICABLE NATIONAL ELECTRICAL SAFETY CODE (NEC) REQUIREMENTS, CENTERPOINT ELECTRICITY DELIVERY SYSTEM REQUIREMENTS, AND ALL APPLICABLE LOCAL REQUIREMENTS AND REGULATIONS FOR PLACEMENT OF AERIAL CABLE FACILITIES, 18" MIN. VERTICAL CLEARANCE.
12. ALL UTILITIES WILL BE IDENTIFIED BY POTHOLE BEFORE ANY CONSTRUCTION.
13. COMCAST WILL MAINTAIN (2FT) HORIZONTAL & VERTICAL SEPARATION FROM ANY EXISTING UTILITIES.
14. THE CONTRACTOR TO CONTACT WALKER COUNTY PRECINCT 4 AT LEAST 48 HOURS PRIOR TO CONSTRUCTION.

Kevin P. Lundy PE
The Aspen Group, LLC
3002 Hempstead Highway
Hockley, TX 77447
(713) 402-3001



DESIGNED BY:
QUANTA TELECOM SERVICES

DATE: 09/19/2025
KEY MAP NO.
75175975K759758
SCALE: 1"=40'

DWG. NO.
38502 HEMPSTEAD HWY.
SHEET NO. 12 OF 76

ASPEN
A QUANTA SERVICES COMPANY

38502 HEMPSTEAD HWY.
HOCKLEY, TX 77447

JB1771404 - 2594 I-45, NEW WAVERLY, TX 77358

COMCAST PROPOSES TO INSTALL FIBER OPTIC CABLE
COMCAST PROPOSES TO PLACE DIRECTIONAL BORE 38.48 FT TO INSTALL FIBER
OPTIC CABLE TO PROVIDE SERVICE NEAR TO 2594 I-45, NEW WAVERLY, TX 77358.
INSIDE THE ROW OF THE WALKER COUNTY, TX.
TOTAL PROJECT FOOTAGE: 38.48'

Comcast
#1 HOUSTON, LLC
8000 W. TIDWELL RD., HOUSTON, TEXAS 77040

Texas 811

NOTES

1. THE WALKER COUNTY WILL BE NOTIFIED IN WRITING 48 HOURS PRIOR TO COMMENSAL WORK.
2. THE WALKER COUNTY UTILITIES DEPARTMENT AND PUBLIC WORKS DEPARTMENT WILL BE NOTIFIED FOR LINE LOCATES AT 890 456-4999.
3. THE CONTRACTOR SHALL CONTACT TEXAS ONE CALL SYSTEM AT 1-800-245-4543 MIN. 48 HOURS BEFORE DIGGING.
4. THE CONTRACTOR SHALL DETERMINE THE EXACT LOCATION OF ALL UNDERGROUND FACILITIES BEFORE COMMENCING WORK AND AGREE TO BE FULLY RESPONSIBLE FOR ALL DAMAGES CAUSED BY HIS FAILURE TO EXACTLY LOCATE AND PRESERVE ALL UNDERGROUND FACILITIES.
5. NO MORE TRENCH OPENED AT ONE TIME THAN CAN BE BACKFILLED AND COMPACTED IN 10 LIFTS AT THE END OF EACH DAY. (NO TRENCH LEFT OPENED OVERNIGHT)
6. ALL EXCESS EXCAVATION TO BE REMOVED FROM THE ROAD RIGHT-OF-WAY AT THE END OF EACH DAY.
7. ADAPTE DRAINAGE
8. ROAD MUST BE KEPT OPEN TO TRAFFIC AND CONTRACTOR MUST PROVIDE ADEQUATE FLAGMEN, SIGNALS, ETC. TO PROVIDE COMPLETE SAFETY TO THE PUBLIC.
9. IF IT BECOMES NECESSARY FOR EQUIPMENT TO OPERATE ON A PORTION OF THE PAVEMENT, PRECAUTIONS MUST BE TAKEN TO PREVENT ANY DAMAGE WHATSOEVER TO THE PAVEMENT.
10. CONDITION OF ROAD UPON COMPLETION OF JOB SHALL BE AS GOOD OR BETTER THAN PRIOR TO STARTING.
11. CONTRACTOR SHALL COMPLY WITH ALL APPLICABLE NATIONAL ELECTRICAL SAFETY CODE (NEC) REQUIREMENTS, CENTERPOINT ENERGY ELECTRIC POLE ATTACHMENT GUIDELINES & PROCEDURES AND ALL OTHER LOCAL, STATE AND FEDERAL REGULATIONS FOR THE PLACEMENT OF AERIAL CABLE FACILITIES. 18" MIN. VERTICAL CLEARANCE.
12. ALL UTILITIES WILL BE IDENTIFIED BY POT HOLE BEFORE ANY CONSTRUCTION.
13. COMCAST WILL MAINTAIN (2FT) HORIZONTAL & VERTICAL SEPARATION FROM ANY EXISTING UTILITIES.
14. THE CONTRACTOR TO CONTACT WALKER COUNTY PRECINCT # 4 AT LEAST 48 HOURS PRIOR TO CONSTRUCTION.

Project: P. Lash, PE
The Aspen Utility Company, LLC
3602 Hempstead Hwy.
Houston, TX 77047
+1 (281) 442-3901



LAURENT, NEA
DATE: 08/10/2025
KEY MAP NO.
781.737.734.738.739
SCALE: 1:40

DESIGNED BY:
QUANTA TELECOM SERVICES
DWG. NO.
SHEET NO. 13 OF 76


ASPEN
3602 HEMPSTEAD HWY.
HOUSTON, TX 77047

JB1771404 - 2594 I-45, NEW WAVERLY, TX 77358

COMCAST PROPOSES TO INSTALL FIBER OPTIC CABLE
COMCAST PROPOSES TO PLACE DIRECTIONAL BORE 23.487 FT TO INSTALL FIBER
OPTIC CABLE TO THE NORTHWEST SIDE OF PERRY RD
INSIDE THE ROW OF THE WALKER COUNTY, TX


Texas 811
8550 W. TIDWELL RD. HOUSTON, TEXAS 77040

comcast
8550 W. TIDWELL RD. HOUSTON, TEXAS 77040

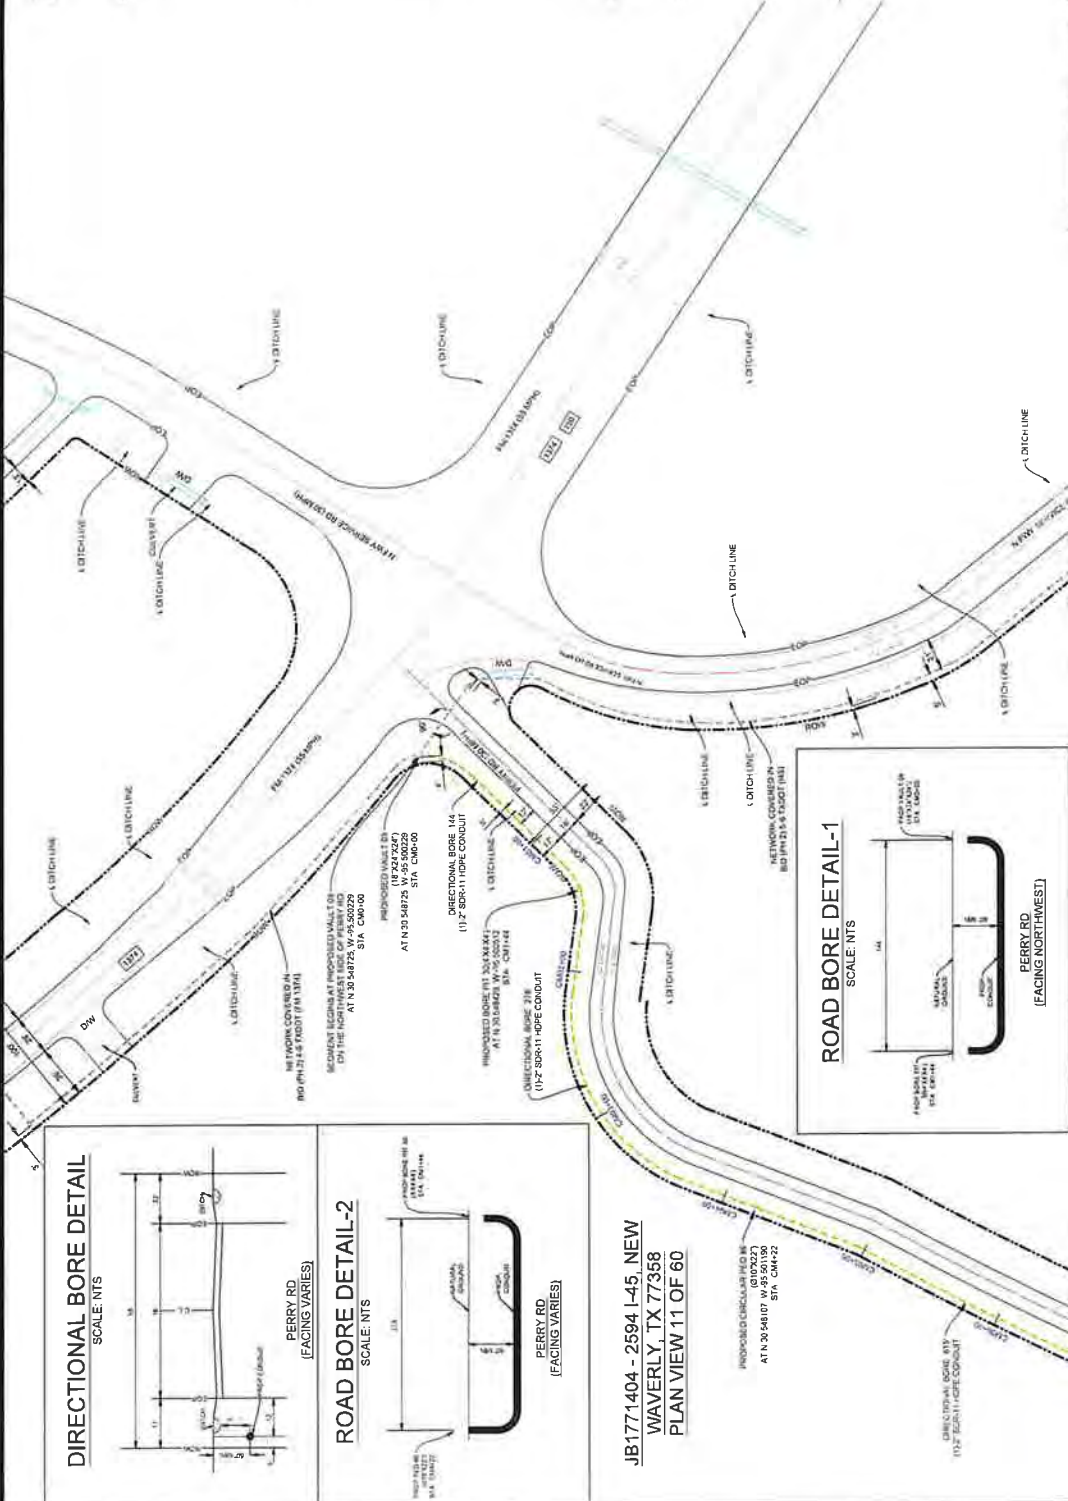


DIRECTIONAL BORE DETAIL

SCALE: NTS

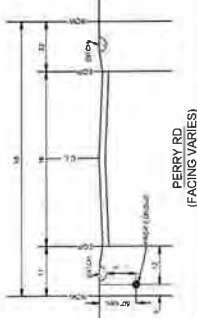

ROAD BORE DETAIL-2


SCALE: NTS

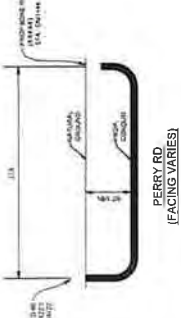

JB1771404 - 2594 I-45, NEW
WAVERLY, TX 77358
PLAN VIEW 11 OF 60

RECEIVED
SEP 02 2025
BY:


JB1771404 - 2594 I-45, NEW WAVERLY, TX 77358
PLAN VIEW 12 OF 60

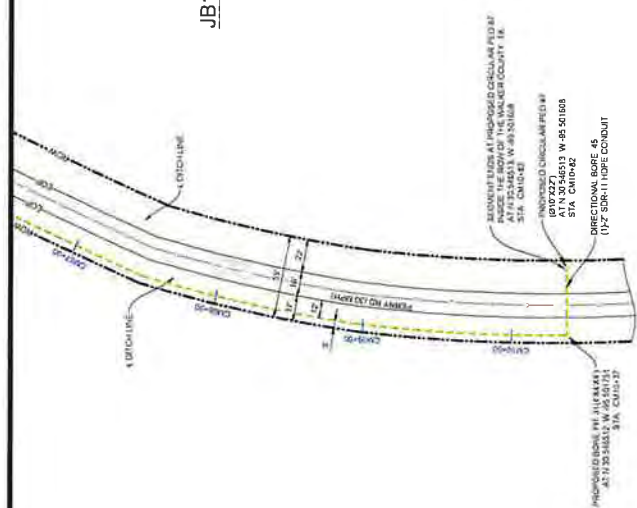


NOTES

1. THE WALKER COUNTY WILL BE NOTIFIED IN WRITING 48 HOURS PRIOR TO COMMENCING WORK
2. THE WALKER COUNTY UTILITIES DEPARTMENT AND PUBLIC WORKS DEPARTMENT WILL BE NOTIFIED FOR LINE LOCATES AT (936) 436-4999.
3. THE CONTRACTOR SHALL CONTACT TEXAS ONE CALL SYSTEM AT 1-800-345-4545 MIN 48 HOURS BEFORE DIGGING
4. THE CONTRACTOR SHALL DETERMINE THE EXACT LOCATION OF ALL UNDERGROUND FACILITIES BEFORE COMMENCING WORK AND AGREE TO BE FULLY RESPONSIBLE FOR ALL DAMAGES CAUSED BY HIS FAILURE TO EXACTLY LOCATE AND PRESERVE ALL UNDERGROUND FACILITIES
5. NO MORE TRENCH OPENED AT ONE TIME THAN CAN BE BACKFILLED AND RECLOSED WITHIN 24 HOURS AT THE END OF EACH DAY (NO TRENCH LEFT OPENED OVERNIGHT)
6. ALL EXCESS EXCAVATION TO BE REMOVED FROM THE ROAD RIGHT-OF-WAY AT THE END OF EACH DAY
7. DITCHES TO BE OPENED AT THE END OF EACH DAY TO ASSURE ADEQUATE DRAINAGE
8. ROAD MUST BE KEPT OPEN TO TRAFFIC AND CONTRACTOR MUST PROVIDE ADEQUATE FLAGMEN, SIGNALS, ETC. TO PROVIDE COMPLETE SAFETY TO THE PUBLIC
9. IF IT BECOMES NECESSARY FOR EQUIPMENT TO OPERATE ON A PORTION OF THE PAVEMENT, PRECAUTIONS MUST BE TAKEN TO PREVENT ANY DAMAGE WHATSOEVER TO THE PAVEMENT
10. CONDITION OF ROAD UPON COMPLETION OF JOB SHALL BE AS GOOD OR BETTER THAN PRIOR TO STARTING
11. CONTRACTOR SHALL COMPLY WITH ALL APPLICABLE NATIONAL ELECTRICAL SAFETY CODE (NEC) REQUIREMENTS, CENTERPOINT ELECTRICITY DELIVERY RULES, AND ALL APPLICABLE LOCAL ORDINANCES AND ALL APPLICABLE LOCAL REQUIREMENTS, REGULATIONS FOR PLACEMENT OF AERIAL CABLE FACILITIES 18" MIN VERTICAL CLEARANCE
12. ALL UTILITIES WILL BE IDENTIFIED BY POTHOLE BEFORE ANY CONSTRUCTION
13. CONTRACTOR WILL MAINTAIN 6FT HORIZONTAL & VERTICAL SEPARATION FROM ANY EXISTING UTILITIES
14. THE CONTRACTOR TO CONTACT WALKER COUNTY PRECINCT 4 AT LEAST 48 HOURS PRIOR TO CONSTRUCTION


ROAD BORE DETAIL
SCALE: NTS

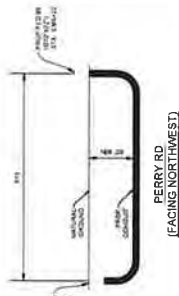

DIRECTIONAL BORE DETAIL
SCALE: NTS

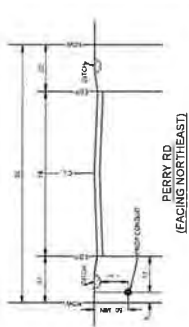

CROSSING BORE DETAIL
SCALE: NTS

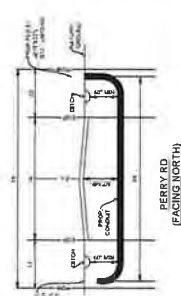

Comcast
#HOUSTON,LLC
2500 W. TEXAS RD., HOUSTON, TEXAS 77040



Comcast
#HOUSTON,LLC
2500 W. TEXAS RD., HOUSTON, TEXAS 77040

COMCAST PROPOSES TO INSTALL FIBER OPTIC CABLE
COMCAST PROPOSES TO PLACE DIRECTIONAL BORE 28.40 FT TO INSTALL FIBER
OPTIC CABLE TO PROVIDE SERVICE NEAR TO 2594 I-45, NEW WAVERLY, TX 77358,
INSIDE THE ROW OF THE WALKER COUNTY, TX.
TOTAL PROJECT FOOTAGE 28.40 FT


JB1771404 - 2594 I-45, NEW WAVERLY, TX 77358



DESIGNED BY:
QUANTA TELECOM SERVICES
DWG. NO. 38502 HEMPSTEAD HWY.
SHEET NO. 14 OF 76

LAURENCE, TX
DATE: 08/16/2025
KEY MAP NO. 751 751 751 751 751
SCALE: 1" = 40'

JB1771404 - 2594 I-45, NEW WAVERLY, TX 77358
PLAN VIEW 13 OF 60

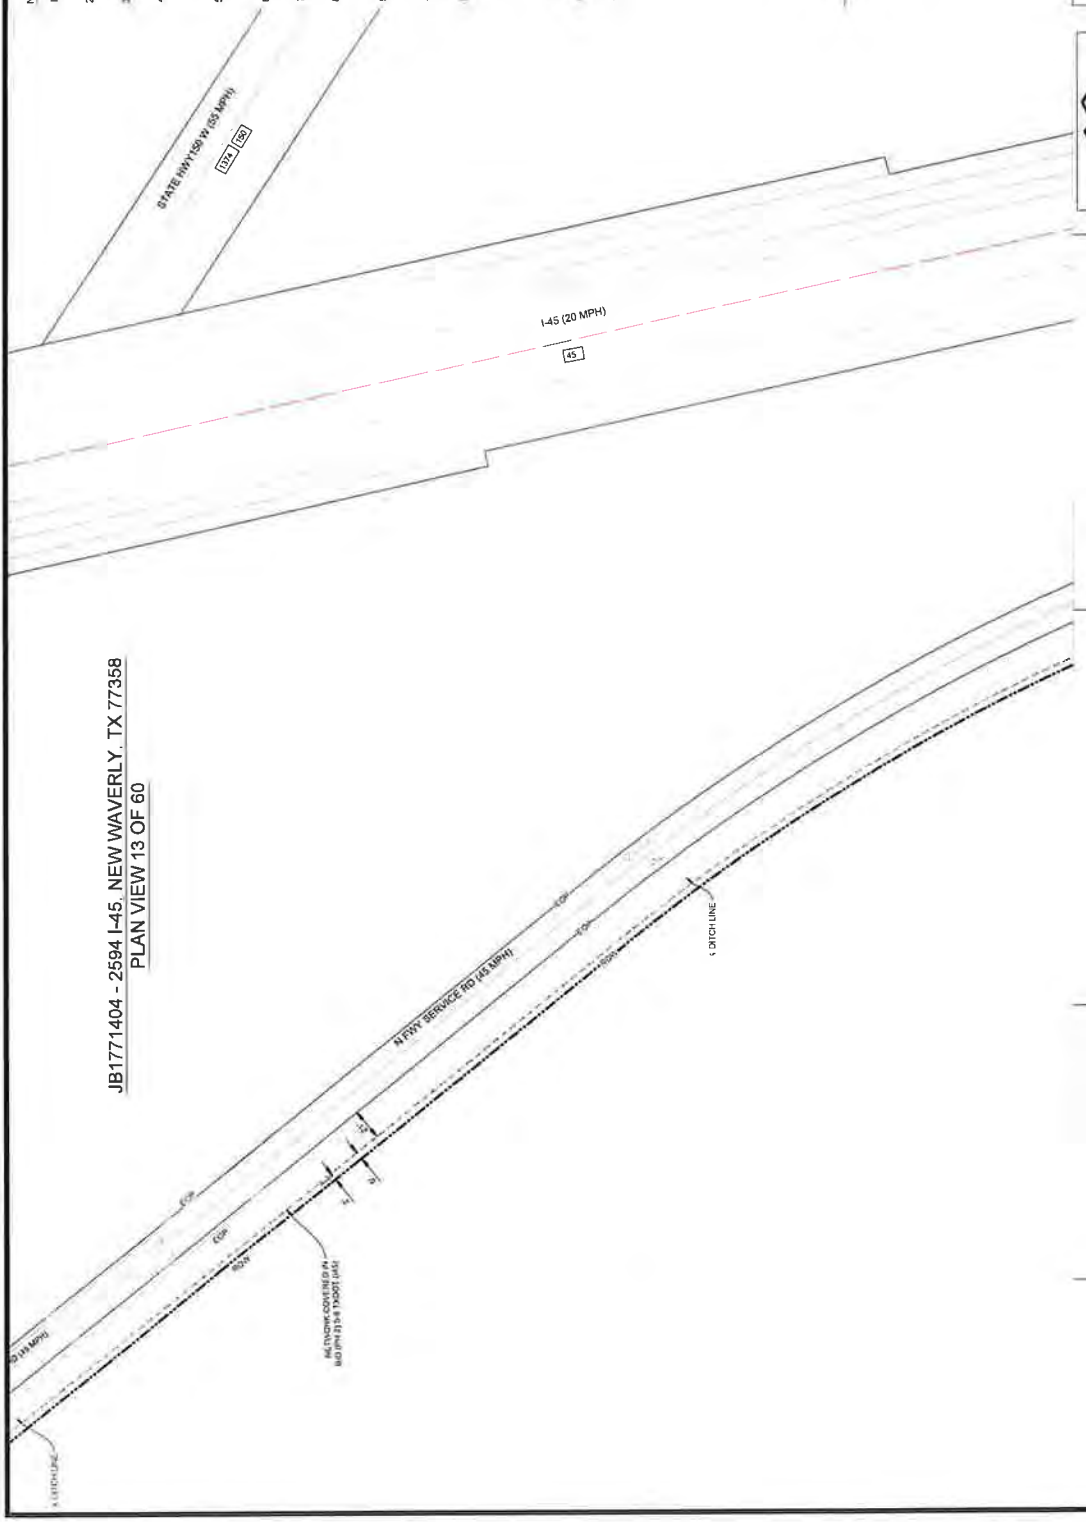

NOTES

1. THE WALKER COUNTY WILL BE NOTIFIED IN WRITING 48 HOURS PRIOR TO COMMENCING WORK.
2. THE WALKER COUNTY UTILITIES DEPARTMENT AND PUBLIC WORKS DEPARTMENT WILL BE NOTIFIED FOR LINE LOCATES AT (936) 436-0339
3. THE CONTRACTOR SHALL CONTACT TEXAS ONE CALL SYSTEM AT 1-800-345-4545 MIN. 48 HOURS BEFORE DIGGING
4. THE CONTRACTOR SHALL DETERMINE THE EXACT LOCATION OF ALL UNDERGROUND FACILITIES BEFORE COMMENCING WORK AND AGREE TO BE FULLY RESPONSIBLE FOR ALL DAMAGES CAUSED BY HIS FAILURE TO EXACTLY LOCATE AND PRESERVE ALL UNDERGROUND FACILITIES.
5. NO MORE TRENCH OPENED AT ONE TIME THAN CAN BE BACKFILLED AND RECLOSED WITHIN 24 HOURS AT THE END OF EACH DAY. (NO TRENCH LEFT OPENED OVERNIGHT).
6. ALL EXCESS EXCAVATION TO BE REMOVED FROM THE ROAD RIGHT-OF-WAY AT THE END OF EACH DAY.
7. DITCHES TO BE OPENED AT THE END OF EACH DAY TO ASSURE ADEQUATE DRAINAGE.
8. ROAD MUST BE KEPT OPEN TO TRAFFIC AND CONTRACTOR MUST PROVIDE ADEQUATE FLAGMEN, SIGNALS, ETC., TO PROVIDE COMPLETE SAFETY TO THE PUBLIC.
9. IF IT BECOMES NECESSARY FOR EQUIPMENT TO OPERATE ON A PORTION OF THE PAVEMENT, PRECAUTIONS MUST BE TAKEN TO PREVENT ANY DAMAGE WHATSOEVER TO THE PAVEMENT.
10. CONDITION OF ROAD UPON COMPLETION OF JOB SHALL BE AS GOOD OR BETTER THAN PRIOR TO STARTING.
11. CONTRACTOR SHALL COMPLY WITH ALL APPLICABLE NATIONAL ELECTRICAL SAFETY CODE (NEC) REQUIREMENTS, CENTERPOINT ENERGY ELECTRIC POLE ATTACHMENT GUIDELINES & PROCEDURES AND ALL OTHER REQUIREMENTS OF THE UTILITY OWNERS. THE CONTRACTOR SHALL MAINTAIN ADEQUATE CLEARANCE OF AERIAL CABLE FACILITIES, 18' MIN. VERTICAL CLEARANCE.
12. ALL UTILITIES WILL BE IDENTIFIED BY POT HOLE BEFORE ANY CONSTRUCTION.
13. CONTRACTOR SHALL MAINTAIN (PTI) HORIZONTAL & VERTICAL SEPARATION FROM ANY EXISTING UTILITIES.
14. THE CONTRACTOR TO CONTACT WALKER COUNTY PRECINCT 4 AT LEAST 48 HOURS PRIOR TO CONSTRUCTION.

Kevin P. Leaky PE
The Aspen Utility Company, LLC
10000 Katy Road, Suite 200
Houston, TX 77058
HOCKLEY, TX 77447
11/20/14 (45-200)




DESIGNED BY:
QUANTA TELECOM SERVICES
DATE: 08/18/2025
KEY: JAS: JAC
PST: JAP: JAC: JAS: JAC
SCALE: 1"=40'
DWG. NO.
SHEET NO. 15 OF 76



CONCAST PROPOSES TO INSTALL FIBER OPTIC CABLE
CONCAST PROPOSES TO PLACE DIRECTIONAL BORE 20.487 FT TO INSTALL FIBER
OPTIC CABLE TO PROVIDE SERVICE NEAR TO 2594 I-45, NEW WAVERLY, TX 77358
INSIDE THE ROW OF THE WALKER COUNTY, TX.
TOTAL PROJECT FOOTAGE: 20.487'

JB1771404 - 2594 I-45, NEW WAVERLY, TX 77358

RECEIVED
SEP 02 2025
BY:

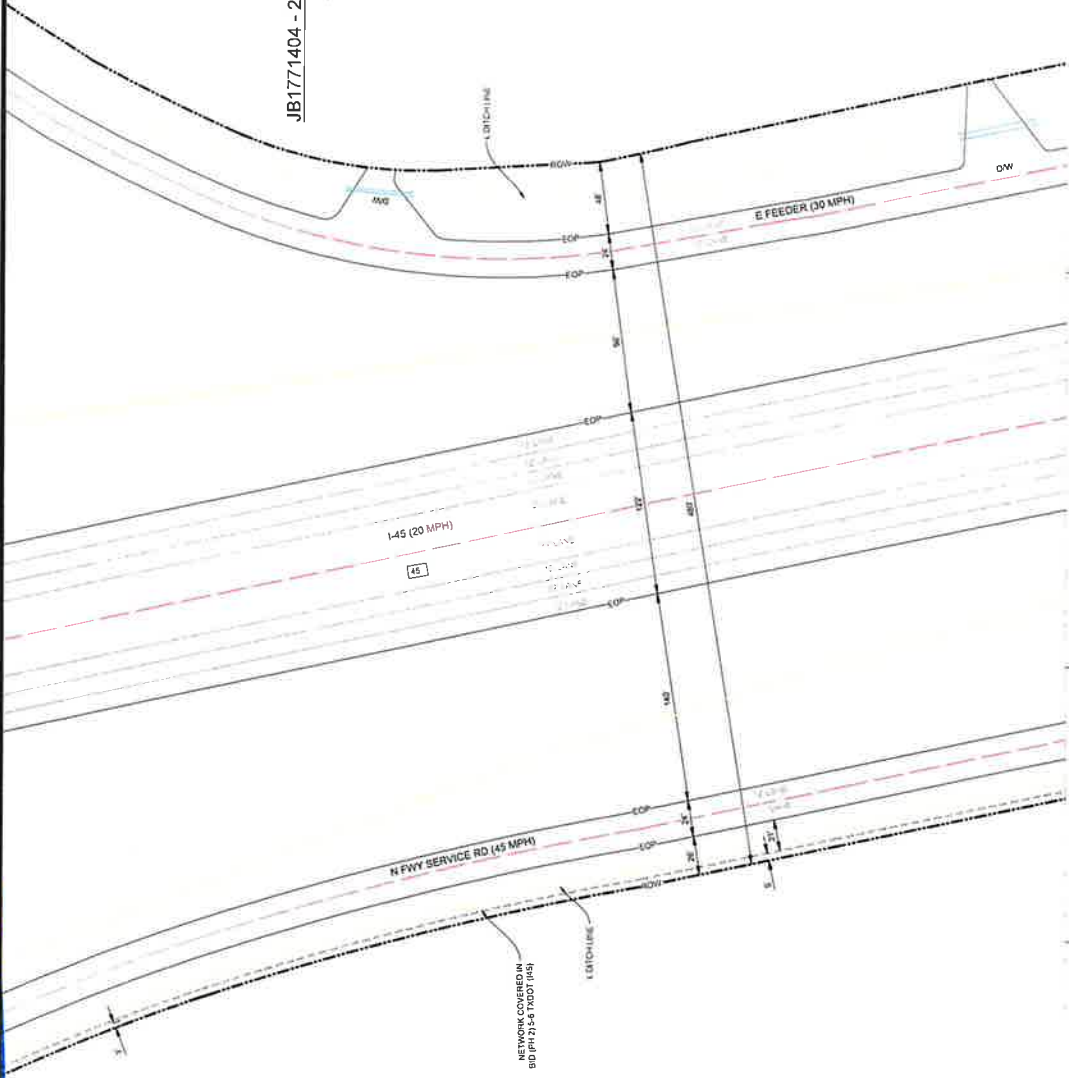

JB1771404 - 2594 I-45, NEW WAVERLY, TX 77358
PLAN VIEW 14 OF 60

NOTES

1. THE WALKER COUNTY WILL BE NOTIFIED IN WRITING 48 HOURS PRIOR TO COMMENCING WORK.
2. THE WALKER COUNTY UTILITIES DEPARTMENT AND PUBLIC WORKS DEPARTMENT WILL BE NOTIFIED FOR LINE LOCATES AT (936) 436-4939.
3. THE CONTRACTOR SHALL CONTACT TEXAS ONE CALL SYSTEM AT 1-800-345-4545 MIN. 48 HOURS BEFORE DIGGING.
4. THE CONTRACTOR SHALL DETERMINE THE EXACT LOCATION OF ALL UNDERGROUND FACILITIES BEFORE COMMENCING WORK AND AGREE TO BE FULLY RESPONSIBLE FOR ALL DAMAGES CAUSED BY HIS FAILURE TO EXACTLY LOCATE AND PRESERVE ALL UNDERGROUND FACILITIES.
5. NO MORE TRENCH OPENED AT ONE TIME THAN CAN BE BACKFILLED AND COMPACTED WITHIN 24 HOURS OF THE END OF EACH DAY. (NO TRENCH LEFT OPENED OVERNIGHT).
6. ALL EXCESS EXCAVATION TO BE REMOVED FROM THE ROAD RIGHT-OF-WAY AT THE END OF EACH DAY.
7. DITCHES TO BE OPENED AT THE END OF EACH DAY TO ASSURE ADEQUATE DRAINAGE.
8. ROAD MUST BE KEPT OPEN TO TRAFFIC AND CONTRACTOR MUST PROVIDE ADEQUATE FLAGMEN, SIGNALS, ETC. TO PROVIDE COMPLETE SAFETY TO THE PUBLIC.
9. IF IT BECOMES NECESSARY FOR EQUIPMENT TO OPERATE ON A PORTION OF THE PAVEMENT, PRECAUTIONS MUST BE TAKEN TO PREVENT ANY DAMAGE WHATSOEVER TO THE PAVEMENT.
10. CONDITION OF ROAD UPON COMPLETION OF JOB SHALL BE AS GOOD OR BETTER THAN PRIOR TO STARTING.
11. CONTRACTOR SHALL COMPLY WITH ALL APPLICABLE NATIONAL ELECTRICAL SAFETY CODE (NEC) REQUIREMENTS, CENTERPOINT ELECTRICITY DELIVERY RULES, ALL APPLICABLE STATE CODES & PROCEDURES AND ALL APPLICABLE LOCAL ORDINANCES AND REGULATIONS FOR THE PROPER PLACEMENT OF AERIAL CABLE FACILITIES. 18" MIN VERTICAL CLEARANCE.
12. ALL UTILITIES WILL BE IDENTIFIED BY POTHOLE BEFORE ANY CONSTRUCTION.
13. COMCAST WILL MAINTAIN (GFI) HORIZONTAL & VERTICAL SEPARATION FROM ANY EXISTING UTILITIES.
14. THE CONTRACTOR TO CONTACT WALKER COUNTY PRECINCT 4 AT LEAST 48 HOURS PRIOR TO CONSTRUCTION.



DESIGNED BY:
QUANTA TELECOM SERVICES

DWG. NO. 16 OF 78
SHEET NO. 16 OF 78



JB1771404 - 2594 I-45, NEW WAVERLY, TX 77358

COMCAST PROPOSES TO INSTALL FIBER OPTIC CABLE
COMCAST PROPOSES TO PLACE DIRECTIONAL BORE 28.487 FT TO INSTALL FIBER
OPTIC CABLE TO PROVIDE SERVICE NEAR TO 2594 I-45, NEW WAVERLY, TX 77358,
INSIDE THE ROW OF THE WALKER COUNTY, TX.
TOTAL PROJECT FOOTAGE 28.487




JB1771404 - 2594 I-45, NEW WAVERLY, TX 77358
PLAN VIEW 15 OF 60



NOTES

1. THE WALKER COUNTY WILL BE NOTIFIED IN WRITING 48 HOURS PRIOR TO COMMENCING WORK.
2. THE WALKER COUNTY UTILITIES DEPARTMENT AND PUBLIC WORKS DEPARTMENT WILL BE NOTIFIED FOR LINE LOCATES AT (936) 436-4039.
3. THE CONTRACTOR SHALL CONTACT TEXAS ONE CALL SYSTEM AT 1-800-368-5848 MIN. 48 HOURS BEFORE DIGGING.
4. THE CONTRACTOR SHALL DETERMINE THE EXACT LOCATION OF ALL UNDERGROUND FACILITIES BEFORE COMMENCING WORK AND AGREE TO BE FULLY RESPONSIBLE FOR ALL DAMAGES CAUSED BY HIS FAILURE TO EXACTLY LOCATE AND PRESERVE ALL UNDERGROUND FACILITIES.
5. NO MORE TRENCH OPENED AT ONE TIME THAN CAN BE BACKFILLED AND COMPACTED IN 10' LIFTS AT THE END OF EACH DAY. (NO TRENCH LEFT OPENED OVERNIGHT).
6. ALL EXCESS EXCAVATION TO BE REMOVED FROM THE ROAD RIGHT-OF-WAY AT THE END OF EACH DAY.
7. DITCHES TO BE OPENED AT THE END OF EACH DAY TO ASSURE ADEQUATE DRAINAGE.
8. ROAD MUST BE KEPT OPEN TO TRAFFIC AND CONTRACTOR MUST PROVIDE ADEQUATE FLAGMEN, SIGNALS, ETC. TO PROVIDE COMPLETE SAFETY TO THE PUBLIC.
9. IF IT BECOMES NECESSARY FOR EQUIPMENT TO OPERATE ON A PORTION OF THE PAVEMENT, PRECAUTIONS MUST BE TAKEN TO PREVENT ANY DAMAGE WHATSOEVER TO THE PAVEMENT.
10. CONDITION OF ROAD UPON COMPLETION OF JOB SHALL BE AS GOOD OR BETTER THAN PRIOR TO STARTING.
11. CONTRACTOR SHALL COMPLY WITH ALL APPLICABLE NATIONAL ELECTRICAL SAFETY CODE (NEC) REQUIREMENTS, CENTERPOINT ENERGY ELECTRIC POLE ATTACHMENT GUIDELINES & PROCEDURES AND ALL APPLICABLE LOCAL ORDINANCES AND REGULATIONS FOR THE PLACEMENT OF AERIAL CABLE FACILITIES. 18" MIN. VERTICAL CLEARANCE.
12. ALL UTILITIES WILL BE IDENTIFIED BY POT-HOLE BEFORE ANY CONSTRUCTION.
13. CONCAST WILL MAINTAIN (2FT) HORIZONTAL & VERTICAL SEPARATION FROM ANY EXISTING UTILITIES.
14. THE CONTRACTOR TO CONTACT WALKER COUNTY PRECINCT 4 AT LEAST 48 HOURS PRIOR TO CONSTRUCTION.

 Kevin P. Loney, P.E.
The Aspen Utility Company, LLC
2500 W. Loop West, Suite 200
Houston, TX 77047
+1 (281) 453-3651



DESIGNED BY:
QUANTA TELECOM SERVICES
DWG. NO. 38502 HEMPSTEAD HWY.
SHEET NO. 17 OF 76
HOUSTON, TX 77047



JB1771404 - 2594 I-45, NEW WAVERLY, TX 77358

CONCAST PROPOSES TO INSTALL FIBER OPTIC CABLE
CONCAST PROPOSES TO PLACE DIRECTIONAL BORE 20.487 FT TO INSTALL FIBER OPTIC CABLE TO PROVIDE SERVICE NEAR TO 2594 I-45, NEW WAVERLY, TX 77358, INSIDE THE ROW OF THE WALKER COUNTY, TX
TOTAL PROJECT FOOTAGE: 20.487

 


By



1. THE WALKER COUNTY WILL BE NOTIFIED IN WRITING 48 HOURS PRIOR TO COMMENCING WORK.
2. THE WALKER COUNTY UTILITIES DEPARTMENT AND PUBLIC WORKS DEPARTMENT WILL BE NOTIFIED FOR LINE LOCATES AT (905) 424-4988.
3. THE CONTRACTOR SHALL CONTACT TEXAS ONE CALL SYSTEM AT 1-800-368-5656 MIN. 24 HOURS BEFORE DIGGING.
4. THE CONTRACTOR SHALL DETERMINE THE EXACT LOCATION OF ALL UTILITIES AND MARK THEM WITH WHITE PLYWOOD OR PLASTIC. THE CONTRACTOR SHALL BE FULLY RESPONSIBLE FOR ALL DAMAGES CAUSED BY HIS FAILURE TO EXACTLY LOCATE AND PRESERVE ALL UNDERGROUND FACILITIES.
5. NO MORE TRENCH OPENED AT ONE TIME THAN CAN BE BACKFILLED AND COMPLETED IN 12 HOURS AT THE END OF EACH DAY, (NO TRENCH LEFT OPENED OVERNIGHT).
6. ALL EXCESS EXCAVATION TO BE REMOVED FROM THE ROAD RIGHT-OF-WAY AT THE END OF EACH DAY.
7. DITCHES TO BE OPENED AT THE END OF EACH DAY TO ASSURE ADEQUATE DRAINAGE.
8. ROAD MUST BE KEPT OPEN TO TRAFFIC AND CONTRACTOR MUST PROVIDE ADEQUATE FLAGMEN, SIGNALS, ETC., TO PROVIDE COMPLETE SAFETY TO THE PUBLIC.
9. IF IT BECOMES NECESSARY FOR EQUIPMENT TO OPERATE ON A PORTION OF THE PAVEMENT, PRECAUTIONS MUST BE TAKEN TO PREVENT ANY DAMAGE WHATSOEVER TO THE PAVEMENT.
10. CONDITION OF ROAD UPON COMPLETION OF JOB SHALL BE AS GOOD OR BETTER THAN PRIOR TO STARTING.
11. CONTRACTOR SHALL COMPLY WITH ALL APPLICABLE NATIONAL ELECTRICAL, SAFETY CODE (NEC) REQUIREMENTS, CENTERPOINT ENERGY ELECTRICAL POLE ATTACHMENT GUIDELINES, PROCEDURES AND SPECIFICATIONS. ALL WORK SHALL BE IN ACCORDANCE WITH THE WORK PLACEMENT OF AERIAL CABLE FACILITIES, 18" MIN. VERTICAL CLEARANCE.
12. ALL UTILITIES WILL BE IDENTIFIED BY POT-HOLE BEFORE ANY CONSTRUCTION.
13. CONCREAL WILL MAINTAIN (GFI) HORIZONTAL & VERTICAL SEPARATION FROM ANY EXISTING UTILITIES.
14. THE CONTRACTOR TO CONTACT WALKERS COUNTY PRECINCT 4 AT LEAST 48 HOURS PRIOR TO CONSTRUCTION.

Kevin P. Lash, PE
The Aspen Utility Company LLC
Form No. 2-3-36
30532 Hesperides Highway
Buckley TX 77447



DESIGNED BY:
QUANTA TELECOM SERVICES



comcast
a/houston, llc
8550 W. TIDWELL RD. HOUSTON, TEXAS 77040



COMCAST PROPOSES TO INSTALL FIBER OPTIC CABLE
COMCAST PROPOSES TO PLACE DIRECTIONAL BORE 28.487 FT TO INSTALL FIBER
OPTIC CABLE TO PROVIDE SERVICE NEAR TO 25M 145, NEW WAVELEY, TX 77554
INSIDE THE ROW OF THE WALKER COUNTY, TX.
TOTAL PROJECT FOOTAGE: 28.487'

JB1771404 - 2594 I-45, NEW WAVERLY, TX 77358

502 HEMPSTEAD -IWY.
HOCKLEY, TX 77447

DWG. NO. 18 OF 76



JB1771404 - 2594 I-45, NEW WAVERLY, TX 77358
PLAN VIEW 17 OF 60



NOTES

1. THE WALKER COUNTY WILL BE NOTIFIED IN WRITING 48 HOURS PRIOR TO COMMENCING WORK.
2. THE WALKER COUNTY UTILITIES DEPARTMENT AND PUBLIC WORKS DEPARTMENT WILL BE NOTIFIED FOR LINE LOCATES AT (830) 436-4899.
3. THE CONTRACTOR SHALL CONTACT TEXAS ONE CALL SYSTEM AT 1-800-245-4545 MIN. 48 HOURS BEFORE DIGGING.
4. THE CONTRACTOR SHALL DETERMINE THE EXACT LOCATION OF ALL UNDERGROUND FACILITIES BEFORE COMMENCING WORK AND AGREE TO BE FULLY RESPONSIBLE FOR ALL DAMAGES CAUSED BY HIS FAILURE TO EXACTLY LOCATE AND PRESERVE ALL UNDERGROUND FACILITIES.
5. NO MORE TRENCH OPENED AT ONE TIME THAN CAN BE BACKFILLED AND COMPACTED IN 10' LIFTS AT THE END OF EACH DAY. (NO TRENCH LEFT OPENED OVERNIGHT).
6. ALL EXCESS EXCAVATION TO BE REMOVED FROM THE ROAD RIGHT-OF-WAY AT THE END OF EACH DAY.
7. DITCHES TO BE OPENED AT THE END OF EACH DAY TO ASSURE ADEQUATE DRAINAGE.
8. ROAD MUST BE KEPT OPEN TO TRAFFIC AND CONTRACTOR MUST PROVIDE ADEQUATE FLAGMEN, SIGNALS, ETC., TO PROVIDE COMPLETE SAFETY TO THE PUBLIC.
9. IF IT BECOMES NECESSARY FOR EQUIPMENT TO OPERATE ON A PORTION OF THE PAVEMENT, PRECAUTIONS MUST BE TAKEN TO PREVENT ANY DAMAGE WHATSOEVER TO THE PAVEMENT.
10. CONDITION OF ROAD UPON COMPLETION OF JOB SHALL BE AS GOOD OR BETTER THAN PRIOR TO STARTING.
11. CONTRACTOR SHALL COMPLY WITH ALL APPLICABLE NATIONAL ELECTRICAL SAFETY CODE (NEC) REQUIREMENTS, CENTERPOINT ENERGY ELECTRIC POLE ATTACHMENT GUIDELINES & PROCEDURES AND ALL APPLICABLE LOCAL ORDINANCES AND REGULATIONS FOR PLACEMENT OF FIBER CABLE FACILITIES, 18" MIN. VERTICAL CLEARANCE.
12. ALL UTILITIES WILL BE IDENTIFIED BY POT-HOLE BEFORE ANY CONSTRUCTION.
13. COMCAST WILL MAINTAIN (GFI) HORIZONTAL & VERTICAL SEPARATION FROM ANY EXISTING UTILITIES.
14. THE CONTRACTOR TO CONTACT WALKER COUNTY PRECINCT 4 AT LEAST 48 HOURS PRIOR TO CONSTRUCTION.

Revised: 1-20-18
The Aspen Utility Company, LLC
Project No. 25358
36502 Highway
Hockley, TX 77447
A 177011404-2018



JB1771404 - 2594 I-45, NEW WAVERLY, TX 77358

COMCAST PROPOSES TO INSTALL FIBER OPTIC CABLE
COMCAST PROPOSES TO PLACE DIRECTIONAL BORE 24" (24") TO INSTALL FIBER OPTIC CABLE TO THE INTERSECTION OF I-45 AND N Fwy SERVICE RD.
INSIDE THE ROW OF THE WALKER COUNTY, TX.
TOTAL PROJECT FOOTAGE 28,487




DESIGNED BY:
QUANTA TELECOM SERVICES
DWG. NO.
SHEET NO. 19 OF 76

LAMBERT: N/A
DATE: 08/02/2015
KEY MAP NO.
25173073007507358
SCALE: 1:40

RECEIVED
SEP 02 2025
BY:.....


JB1771404 - 2594 I-45, NEW WAVERLY, TX 77358
PLAN VIEW 18 OF 60

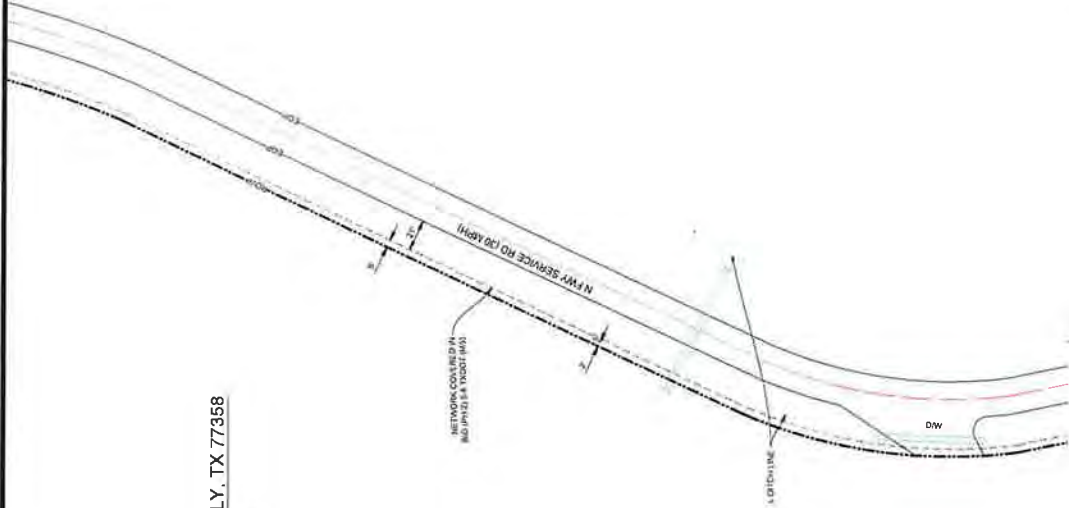

NOTES

1. THE WALKER COUNTY WILL BE NOTIFIED IN WRITING 48 HOURS PRIOR TO COMMENCING WORK
2. THE WALKER COUNTY UTILITIES DEPARTMENT AND PUBLIC WORKS DEPARTMENT WILL BE NOTIFIED FOR LINE LOCATES AT (936) 436-8899
3. THE CONTRACTOR SHALL CONTACT TEXAS ONE CALL SYSTEM AT 1-800-245-4545 MIN. 48 HOURS BEFORE DIGGING
4. THE CONTRACTOR SHALL DETERMINE THE EXACT LOCATION OF ALL UNDERGROUND FACILITIES BEFORE COMMENCING WORK AND AGREE TO BE FULLY RESPONSIBLE FOR ALL DAMAGES CAUSED BY HIS FAILURE TO EXACTLY LOCATE AND PRESERVE ALL UNDERGROUND FACILITIES
5. NO MORE TRENCH OPENED AT ONE TIME THAN CAN BE BACKFILLED AND COMPACTED IN 10' LIFTS AT THE END OF EACH DAY (NO TRENCH LEFT OPEN OVERNIGHT)
6. ALL EXCESS EXCAVATION TO BE REMOVED FROM THE ROAD RIGHT-OF-WAY AT THE END OF EACH DAY
7. DITCHES TO BE OPENED AT THE END OF EACH DAY TO ASSURE ADEQUATE DRAINAGE
8. ROAD MUST BE KEPT OPEN TO TRAFFIC AND CONTRACTOR MUST PROVIDE ADEQUATE FLAGMEN, SIGNALS, ETC., TO PROVIDE COMPLETE SAFETY TO THE PUBLIC
9. IF IT BECOMES NECESSARY FOR EQUIPMENT TO OPERATE ON A PORTION OF THE PAVEMENT, PRECAUTIONS MUST BE TAKEN TO PREVENT ANY DAMAGE WHATSOEVER TO THE PAVEMENT
10. CONDITION OF ROAD UPON COMPLETION OF JOB SHALL BE AS GOOD OR BETTER THAN PRIOR TO STARTING
11. CONTRACTOR SHALL COMPLY WITH ALL APPLICABLE NATIONAL ELECTRICAL SAFETY CODE (NEC) REQUIREMENTS, CENTERPOINT ENERGY ELECTRIC POLE ATTACHMENT GUIDELINES & PROCEDURES AND ALL OTHER REQUIREMENTS FOR THE PROTECTION OF THE PUBLIC AND THE PLACEMENT OF AERIAL CABLE FACILITIES. 18' MIN. VERTICAL CLEARANCE
12. ALL UTILITIES WILL BE IDENTIFIED BY POT-HOLE BEFORE ANY CONSTRUCTION
13. COMCAST WILL MAINTAIN (GFI) HORIZONTAL & VERTICAL SEPARATION FROM ANY EXISTING UTILITIES
14. THE CONTRACTOR TO CONTACT WALKER COUNTY PRECINCT 4 AT LEAST 48 HOURS PRIOR TO CONSTRUCTION

 DESIGNED BY:
The Aspen Utility Company, LLC
35502 Hempstead Highway
Hockley, TX 77447
(817) 448-8888



DESIGNED BY:
QUANTA TELECOM SERVICES

DATE: 08/18/2025
KEY MAP NO.
757-796-2963/378

SCALE: 1" = 40'

DWG. NO.
SHEET NO. 20 OF 76

35502 HEMPSTEAD HWY
HOCKLEY, TX 77447



COMCAST PROPOSES TO INSTALL FIBER OPTIC CABLE
COMCAST PROPOSES TO PLACE DIRECTIONAL BORE 28.487 FT TO INSTALL FIBER OPTIC CABLE TO PROVIDE SERVICE NEAR TO 2594 I-45 NEW WAVERLY, TX 77358, INSIDE THE ROW OF THE WALKER COUNTY, TX
TOTAL PROJECT FOOTAGE: 28.487

JB1771404 - 2594 I-45, NEW WAVERLY, TX 77358



-



comcast
of Houston, LLC
8550 W. TIDWELL RD. HOUSTON, TEXAS 77049

BY:

I-45 (20 MPH)

DW

NETWORK COVERED IN BIO (PH 2) S TPOOT (403)

STRUCTURE

DW

DW

1404 - 2594 I-45, NEW WAVERLY, TX 77358
PLAN VIEW 20 OF 60

Plan view of proposed I-45 interchange and N FWY Service Rd. The diagram shows a 4-lane divided highway (I-45) with a 20 MPH speed limit, intersecting a 4-lane divided highway (N FWY Service Rd) with a 55 MPH speed limit. The interchange is a partial interchange with a 90-degree turn. Key features include:

- Interchange:** A 90-degree turn from I-45 onto N FWY Service Rd. The interchange is labeled 'I-45 (20 MPH)' and 'N FWY SERVICE RD (55 MPH)'.
- Service Rd:** N FWY Service Rd (55 MPH) runs horizontally across the bottom of the plan. It has a 55 MPH speed limit and a 12' lane width.
- Interchange Structure:** The interchange is a partial interchange with a 90-degree turn. It includes a 12' lane width and a 12' lane width for the service road.
- Drainage:** A ditch line is shown along the right side of the service road, labeled 'DITCH LINE'.
- Other Features:** A 'DITCH LINE' is also shown along the right side of the service road. A 'DITCH LINE' is also shown along the right side of the service road.

1. THE WALKER COUNTY WILL BE NOTIFIED IN WRITING 48 HOURS PRIOR TO COMMENCING WORK.
2. THE WALKER COUNTY UTILITIES DEPARTMENT AND PUBLIC WORKS DEPARTMENT WILL BE NOTIFIED FOR LINE LOCATES AT (836) 458-4839
3. THE CONTRACTOR SHALL CONTACT TEXAS ONE CALL SYSTEM AT 1-800-555-4545 48 HOURS BEFORE DIGGING.
4. THE EXISTING LOCATION OF ALL UNDERGROUND FACILITIES BEFORE COMMENCING WORK SHALL BE FULLY RESPONSIBLE FOR ALL DAMAGES CAUSED BY HIS FAILURE TO EXCAVATE AND PRESERVE ALL UNDERGROUND FACILITIES.
5. NO MORE TRENCH EXCAVATION AT ONE TIME THAN CAN BE BACKFILLED AND COMPACTED IN 10' LIFTS AT THE END OF EACH DAY. (NO TRENCH LEFT OPENED OVERNIGHT).
6. ALL EXCESS EXCAVATION TO BE REMOVED FROM THE ROAD RIGHT-OF-WAY AT THE END OF EACH DAY.
7. DITCHES TO BE OPENED AT THE END OF EACH DAY TO ASSURE ADEQUATE DRAINAGE.
8. ROAD MUST BE KEPT OPEN TO TRAFFIC AND CONTRACTOR MUST PROVIDE ADEQUATE FLAGMEN SIGNALS, ETC., TO PROVIDE COMPLETE SAFETY TO THE PUBLIC.
9. IF IT BECOMES NECESSARY FOR EQUIPMENT TO OPERATE ON A PORTION OF THE PAVEMENT, PRECAUTIONS MUST BE TAKEN TO PREVENT ANY DAMAGE WHATSOEVER TO THE PAVEMENT.
10. CONDITION OF ROAD UPON COMPLETION OF JOB SHALL BE AS GOOD OR BETTER THAN PRIOR TO STARTING.
11. CONTRACTOR SHALL COMPLY WITH ALL APPLICABLE NATIONAL ELECTRICAL, SAFETY CODE (NEC) REQUIREMENTS, CENTERPOINT ENERGY ELECTRIC POLE AND TOWER GUIDELINES & PROCEDURES AND ALL OTHER APPLICABLE REGULATIONS. ALL TRENCHES SHALL BE PLACED OF AERIAL CABLE FACILITIES, 18" MIN VERTICAL CLEARANCE.
12. ALL UTILITIES WILL BE IDENTIFIED BY POT-HOLE BEFORE ANY CONSTRUCTION.
13. COMPACT WILL MAINTAIN (2FT) HORIZONTAL & VERTICAL SEPARATION FROM ANY EXISTING UTILITIES.
14. THE CONTRACTOR SHALL CONTACT WALKER COUNTY PRECINCT 4 AT LEAST 48 HOURS PRIOR TO CONSTRUCTION.

ENCLOSURE

ALBERT, N/A
 DATE: 08/18/2025
 KEY MAP NO:
 1ST 75P 75K 75F 75B
 SCALE: 1 40

DWG. NO. 76
SHEET NO. 23 OF 76

COMCAST PROPOSES TO INSTALL FIBER OPTIC CABLE
COMCAST PROPOSES TO PLACE DIRECTIONAL BORE 28.487 FT TO INSTALL FIBER
OPTIC CABLE TO PROVIDE SERVICE NEAR TO 5941 HAS NEW WAVELEY, TX 77358
INSIDE THE ROW OF THE WALKER COUNTRY, TX.
TOTAL PROJECT FOOTAGE: 28.487

Texas 811



comcast
a HOUSTON, LLC
100 W. TITZELL RD HOUSTON, TEXAS 77040

NOTES:

- THE WALKER COUNTY WILL BE NOTIFIED IN WRITING 48 HOURS PRIOR TO COMMENCING WORK.
- THE WALKER COUNTY UTILITIES DEPARTMENT AND PUBLIC WORKS DEPARTMENT WILL BE NOTIFIED FOR LINE LOCATES AT (936) 436-4939.
- THE CONTRACTOR SHALL CONTACT TEXAS ONE CALL SYSTEM AT 1-800-245-4545 MIN. 48 HOURS BEFORE DIGGINGS.
- THE CONTRACTOR SHALL DETERMINE THE EXACT LOCATION OF ALL EXISTING UTILITIES PRIOR TO CONSTRUCTION. THE CONTRACTOR SHALL BE FULLY RESPONSIBLE FOR ALL DAMAGES CAUSED BY HIS FAILURE TO EXACTLY LOCATE AND PRESERVE ALL UNDERGROUND FACILITIES.
- NO MORE TRENCH OPENED AT ONE TIME THAN CAN BE BACKFILLED AND COMPACTED IN 10' LIFTS AT THE END OF EACH DAY. (NO TRENCH LEFT OPENED OVERNIGHT).
- ALL EXCESS EXCAVATION TO BE REMOVED FROM THE ROAD RIGHT-OF-WAY AT THE END OF EACH DAY.
- DITCHES TO BE OPENED AT THE END OF EACH DAY TO ASSURE ADEQUATE DRAINAGE.
- ROAD MUST BE KEPT OPEN TO TRAFFIC AND CONTRACTOR MUST PROVIDE ADEQUATE WARNING SIGNS, ETC., TO PROVIDE COMPLETE SAFETY TO THE PUBLIC.
- IF IT BECOMES NECESSARY FOR EQUIPMENT TO OPERATE ON A PORTION OF THE PAVEMENT, PRECAUTIONS MUST BE TAKEN TO PREVENT ANY DAMAGE WHATSOEVER TO THE PAVEMENT.
- CONDITION OF ROAD UPON COMPLETION OF JOB SHALL BE AS GOOD OR BETTER THAN PRIOR TO STARTING.
- CONTRACTOR SHALL COMPLY WITH ALL APPLICABLE NATIONAL ELECTRICAL SAFETY CODE (NEC) REQUIREMENTS, CENTERPOINT ENERGY ELECTRIC POLE ATTACHMENT GUIDELINES & PROCEDURES AND ALL APPLICABLE LOCAL REQUIREMENTS AND REGULATIONS FOR CONSTRUCTION OF AIRIAL CABLE FACILITIES. 18" MIN VERTICAL CLEARANCE.
- ALL UTILITIES WILL BE IDENTIFIED BY POT-HOLE BEFORE ANY CONSTRUCTION.
- COMCAST WILL MAINTAIN (LEFT) HORIZONTAL & VERTICAL SEPARATION FROM ANY EXISTING UTILITIES.
- THE CONTRACTOR TO CONTACT WALKER COUNTY PRECINCT 4 AT LEAST 48 HOURS PRIOR TO CONSTRUCTION.

Kenneth P. Lewis, PE
The Aspen Group, LLC
Professional Engineer
No. 0000000000
Houston, TX 77047
+1 (702) 432-3691

Engineer's Seal
Seal No. 0000000000
00/00/2025

DESIGNED BY:
QUANTA TELECOM SERVICES

DATE: 08/18/2025
JOB MAP NO.: 75177P-PIN 75177P
SCALE: 1"=40'

JB1771404 - 2594 I-45, NEW WAVERLY, TX 77358
PLAN VIEW 22 OF 60

COMCAST PROPOSES TO INSTALL FIBER OPTIC CABLE
COMCAST PROPOSES TO PLACE DIRECTIONAL BORE 28.487 FT TO INSTALL FIBER OPTIC CABLE TO PROVIDE SERVICE NEAR TO 2594 I-45, NEW WAVERLY, TX 77358, INSIDE THE ROW OF THE WALKER COUNTY, TX.
TOTAL PROJECT FOOTAGE: 28.487

comcast
HOUSTON, LLC
2550 W. TOWELL RD HOUSTON, TEXAS 77060

Texas 811

ASPEN
A QUALITY SERVICE COMPANY
36502 HEMPSTEAD HWY.
HOCKLEY, TX 77447

JB1771404 - 2594 I-45, NEW WAVERLY, TX 77358

SHEET NO. 24 OF 76

JB1771404 - 2594 I-45, NEW WAVERLY, TX 77358
PLAN VIEW 22 OF 60

1. THE WALKER COUNTY WILL BE NOTIFIED IN WRITING 48 HOURS PRIOR TO COMMENCING WORK.
2. THE WALKER COUNTY UTILITIES DEPARTMENT AND PUBLIC WORKS DEPARTMENT WILL BE NOTIFIED FOR LINE LOCATES AT (936) 456-4839
3. THE CONTRACTOR SHALL CONTACT TEXAS ONE CALL SYSTEM AT 1-800-252-4545 MIN. 48 HOURS BEFORE DIGGING.
4. THE CONTRACTOR SHALL DETERMINE THE EXACT LOCATION OF ALL UNDERGROUND FACILITIES BEFORE COMMENCING WORK AND AGREE TO BE FULLY RESPONSIBLE FOR ALL DAMAGES CAUSED BY HIS FAILURE TO EXACTLY LOCATE AND PRESERVE ALL UNDERGROUND FACILITIES.
5. NO MORE TRENCH OPENED AT ONE TIME THAN CAN BE BACKFILLED AND REINTEGRATED WITHIN 24 HOURS OF THE TIME OF EACH DAY. (NO TRENCH LEFT OPEN OVERNIGHT).
6. ALL EXCESS EXCAVATION TO BE REMOVED FROM THE ROAD RIGHT-OF-WAY AT THE END OF EACH DAY.
7. DITCHES TO BE OPENED AT THE END OF EACH DAY TO ASSURE ADEQUATE DRAINAGE.
8. ROAD MUST BE KEPT OPEN TO TRAFFIC AND CONTRACTOR MUST PROVIDE ADEQUATE FLAGMEN, SIGNALS, ETC., TO PROVIDE COMPLETE SAFETY TO THE PUBLIC.
9. IF IT BECOMES NECESSARY FOR EQUIPMENT TO OPERATE ON A PORTION OF THE PAVEMENT, PRECAUTIONS MUST BE TAKEN TO PREVENT ANY CHANCE WHATSOEVER TO THE PAVEMENT.
10. CONDITION OF ROAD UPON COMPLETION OF JOB SHALL BE AS GOOD OR BETTER THAN PRIOR TO STARTING.
11. CONTRACTOR SHALL COMPLY WITH ALL APPLICABLE NATIONAL ELECTRICAL SAFETY CODE (NEC) REQUIREMENTS, CENTERPOINT UTILITY SAFETY REQUIREMENTS, TEXAS ONE CALL REQUIREMENTS AND ALL APPLICABLE LOCAL REQUIREMENTS AND REGULATIONS FOR PLACEMENT OF AERIAL CABLE FACILITIES, 18" MIN. VERTICAL CLEARANCE.
12. ALL UTILITIES WILL BE IDENTIFIED BY POT HOLE BEFORE ANY CONSTRUCTION.
13. CONCAST WILL MAINTAIN (DFT) HORIZONTAL & VERTICAL SEPARATION FROM ANY EXISTING UTILITIES.
14. AT LEAST 48 HOURS PRIOR TO CONSTRUCTION.

Kevin P. Ladd, PE
The Aspen Unity Company, LLC
Firm No. 23538
24502 Horseshoe Highway
Mudley, VA 21447
+1 (703) 493-3691



DESIGNED BY:
QUANTA TELECOM SERVICES

LANDERT: N/A
DATE: 08/18/2002
KEY MAP NO
7751 75P 75K, 75F
SCALE: 1:40

DWG. NO.
SHEET NO. 24 OF 76

502 HEMPSTEAD HWY.
MOCKLEY, TX 77647

COMCAST PROPOSES TO INSTALL FIBER OPTIC CABLE

COMCAST PROPOSES TO PLACE DIRECTIONAL BORE 28.437 FT TO INSTALL FIBER OPTIC CABLE TO PROVIDE SERVICE NEAR TO 2504 J-15, NEWNAVERLY, TX 77358, INSIDE THE ROW OF THE MAILED COUNTRY, TX

TOTAL PROJECT FOOTAGE: 28.41Y



JB1771404 - 2594145. NEW WAVERLY. TX 77358

JB1771404 - 2594 I-45, NEW WAVERLY, TX 77358
PLAN VIEW 23 OF 60



NOTES

1. THE WALKER COUNTY WILL BE NOTIFIED IN WRITING 48 HOURS PRIOR TO COMMENCING WORK.
2. THE WALKER COUNTY UTILITIES DEPARTMENT AND PUBLIC WORKS DEPARTMENT WILL BE NOTIFIED FOR LINE LOCATES AT (336) 356-4839
3. THE CONTRACTOR SHALL CONTACT TEXAS ONE CALL SYSTEM AT 1-800-345-4545 MIN. 48 HOURS BEFORE DIGGING
4. THE CONTRACTOR SHALL DETERMINE THE EXACT LOCATION OF ALL UNDERGROUND FACILITIES BEFORE COMMENCING WORK AND AGREE TO BE FULLY RESPONSIBLE FOR ALL DAMAGES CAUSED BY HIS FAILURE TO EXACTLY LOCATE AND PRESERVE ALL UNDERGROUND FACILITIES
5. NO MORE TRENCH OPENED AT ONE TIME THAN CAN BE BACKFILLED AND COMPACTED IN 10' LIFTS AT THE END OF EACH DAY (NO TRENCH LEFT OPENED OVERNIGHT)
6. ALL EXCESS EXCAVATION TO BE REMOVED FROM THE ROAD RIGHT-OF-WAY AT THE END OF EACH DAY.
7. DITCHES TO BE OPENED AT THE END OF EACH DAY TO ASSURE ADEQUATE DRAINAGE.
8. ROAD MUST BE KEPT OPEN TO TRAFFIC AND CONTRACTOR MUST PROVIDE ADEQUATE FLAGMEN, SIGNALS, ETC. TO PROVIDE COMPLETE SAFETY TO THE PUBLIC
9. IF IT BECOMES NECESSARY FOR EQUIPMENT TO OPERATE ON A PORTION OF THE PAVEMENT, PRECAUTIONS MUST BE TAKEN TO PREVENT ANY DAMAGE WHATSOEVER TO THE PAVEMENT.
10. CONDITION OF ROAD UPON COMPLETION OF JOB SHALL BE AS GOOD OR BETTER THAN PRIOR TO STARTING.
11. CONTRACTOR SHALL COMPLY WITH ALL APPLICABLE NATIONAL ELECTRICAL SAFETY CODE (NEC) REQUIREMENTS, CENTERPOINT ENERGY ELECTRIC POLE ATTACHMENT GUIDELINES & PROCEDURES AND ALL APPLICABLE LOCAL ORDINANCES AND REGULATIONS REGARDING PLACEMENT OF AERIAL CABLE FACILITIES. 18' MIN. VERTICAL CLEARANCE
12. ALL UTILITIES WILL BE IDENTIFIED BY POT-HOLE BEFORE ANY CONSTRUCTION
13. COMCAST WILL MAINTAIN (18") HORIZONTAL & VERTICAL SEPARATION FROM ANY EXISTING UTILITIES
14. THE CONTRACTOR TO CONTACT WALKER COUNTY PRECINCT 4 AT LEAST 48 HOURS PRIOR TO CONSTRUCTION.

Aspen Utility Services
1100 Aspen Utility Company, LLC
1100 Aspen Utility Company, LLC
36502 Hempstead Highway
Hockley, TX 77447
(817) 224-0000



COMCAST PROPOSES TO INSTALL FIBER OPTIC CABLE
COMCAST PROPOSES TO PLACE DIRECTIONAL BORE 30-42 FT TO INSTALL FIBER
OPTIC CABLE TO PROVIDE SERVICE NEAR TO 2594 I-45, NEW WAVERLY, TX 77358,
INSIDE THE ROW OF THE WALKER COUNTY, TX
TOTAL PROJECT FOOTAGE: 28,487

JB1771404 - 2594 I-45, NEW WAVERLY, TX 77358




DESIGNED BY:
QUANTA TELECOM SERVICES
DWG. NO.
SHEET NO. 25 OF 76

LAURENCE, WA
DATE: 08/19/2023
KEY MAP NO.
131737350-07358
SCALE: 1" = 40'

RECEIVED
SEP 02 2025
BY:

JB1771404 - 2594 I-45, NEW WAVERLY, TX 77358
PLAN VIEW 24 OF 60

SEE TYPICAL DETAILS ON
SHEET NO. 63

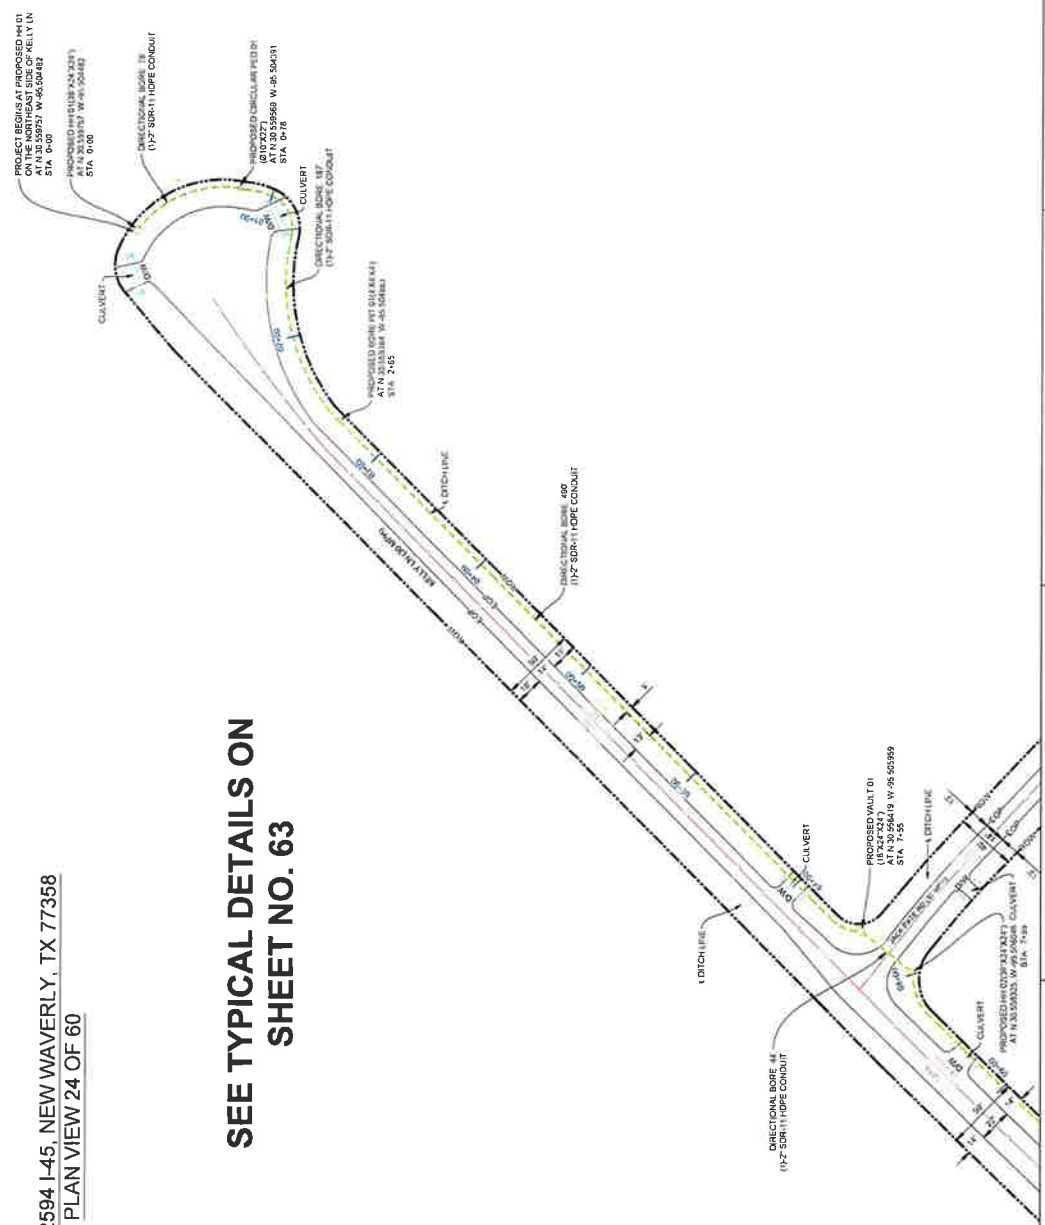

NOTES

1. THE WALKER COUNTY WILL BE NOTIFIED IN WRITING 48 HOURS PRIOR TO COMMENCING WORK.
2. THE WALKER COUNTY UTILITIES DEPARTMENT AND PUBLIC WORKS DEPARTMENT WILL BE NOTIFIED FOR LINE LOCATES AT (336) 556-4939.
3. THE CONTRACTOR SHALL CONTACT TEXAS ONE CALL SYSTEM AT 1-800-245-4545 MIN. 48 HOURS BEFORE DIGGING.
4. THE CONTRACTOR SHALL DETERMINE THE EXACT LOCATION OF ALL UNDERGROUND FACILITIES BEFORE COMMENCING WORK AND AGREE TO BE FULLY RESPONSIBLE FOR ALL DAMAGES CAUSED BY HIS FAILURE TO ENSURELY LOCATE AND PRESERVE ALL UNDERGROUND FACILITIES.
5. NO MORE TRENCH OPENED AT ONE TIME THAN CAN BE BACKFILLED AND COVERED WITHIN THE SAME DAY. ALL TRENCHES SHALL BE OPENED AND CLOSED AT THE END OF EACH DAY. (NO TRENCH LEFT OPENED OVERNIGHT).
6. ALL EXCESS EXCAVATION TO BE REMOVED FROM THE ROAD RIGHT-OF-WAY AT THE END OF EACH DAY.
7. DITCHES TO BE OPENED AT THE END OF EACH DAY TO ASSURE ADEQUATE DRAINAGE.
8. ROAD MUST BE KEPT OPEN TO TRAFFIC AND CONTRACTOR MUST PROVIDE ADEQUATE FLAGMEN, SIGNALS, ETC. TO PROVIDE COMPLETE SAFETY TO THE PUBLIC.
9. IF IT BECOMES NECESSARY FOR EQUIPMENT TO OPERATE ON A PORTION OF THE PAVEMENT, PRECAUTIONS MUST BE TAKEN TO PREVENT ANY DAMAGE WHATSOEVER TO THE PAVEMENT.
10. CONDITION OF ROAD UPON COMPLETION OF JOB SHALL BE AS GOOD OR BETTER THAN PRIOR TO STARTING.
11. CONTRACTOR SHALL COMPLY WITH ALL APPLICABLE NATIONAL ELECTRICAL SAFETY CODE (NEC) REQUIREMENTS, CENTERPOINT UTILITY REQUIREMENTS, AND ALL APPLICABLE LOCAL ORDINANCES AND ALL APPLICABLE LOCAL REQUIREMENTS AND REGULATIONS FOR PLACEMENT OF AERIAL CABLE FACILITIES. 18\"/>
12. ALL UTILITIES WILL BE IDENTIFIED BY POT HOLE BEFORE ANY CONSTRUCTION.
13. COMCAST WILL MAINTAIN (2FT) HORIZONTAL & VERTICAL SEPARATION FROM ANY EXISTING UTILITIES.
14. THE CONTRACTOR TO CONTACT WALKER COUNTY PRECINCT 4 AT LEAST 48 HOURS PRIOR TO CONSTRUCTION.



DESIGNED BY:
QUANTA TELECOM SERVICES

DWG. NO. 35502 HEMPSTEAD HWY.
SHEET NO. 25 OF 77

LAURET HA
DATE: 08/16/2025
PROJECT NO. JB1771404
SCALE: 1\"/>



JB1771404 - 2594 I-45, NEW WAVERLY, TX 77358

COMCAST PROPOSES TO INSTALL FIBER OPTIC CABLE
COMCAST PROPOSES TO PLACE DIRECTIONAL BORE 26-48\"/>



[illegible]

- 1 THE WALVER COUNTY WILL BE NOTIFIED IN WRITING 48 HOURS PRIOR
- 2 TO COMMENCING WORK
- 3
- 4 THE WALVER COUNTY UTILITIES DEPARTMENT AND PUBLIC WORKS
- 5 DEPARTMENT WILL BE NOTIFIED FOR LINE LOCATES AT (936) 456-4839
- 6
- 7 THE CONTRACTOR SHALL CONTACT TEXAS ONE CALL SYSTEM AT
- 8 1-800-368-5848 NOT LATER THAN 48 HOURS BEFORE EXCAVATION.
- 9 THE CONTRACTOR SHALL DETERMINE THE EXACT LOCATION OF ALL
- 10 UTILITIES TO BE FULLY RESPONSIBLE FOR ALL DAMAGES CAUSED BY ITS FAILURE TO
- 11 FULLY LOCATE AND PRESERVE ALL UNDERGROUND FACILITIES.
- 12
- 13 NO MORE TRENCH OPENED AT ONE TIME THAN CAN BE BACKFILLED AND
- 14 COMPACTED IN 10' LIFTS AT THE END OF EACH DAY. (NO TRENCH LEFT
- 15 OPEN OVERNIGHT).
- 16 ALL EXCESS EXCAVATION TO BE REMOVED FROM THE ROAD
- 17 RIGHT-OFF-WAY AT THE END OF EACH DAY
- 18
- 19 DITCHES TO BE OPENED AT THE END OF EACH DAY TO ASSURE
- 20 ADEQUATE DRAINAGE
- 21
- 22 ROAD MUST BE KEPT OPEN TO TRAFFIC AND CONTRACTOR MUST
- 23 PROVIDE ADEQUATE FLAGMEN SIGNALS, ETC. TO PROVIDE COMPLETE
- 24 SAFETY TO THE PUBLIC
- 25
- 26 IF IT BECOMES NECESSARY FOR EQUIPMENT TO OPERATE ON A PORTION
- 27 OF THE PAVEMENT, PRECAUTIONS MUST BE TAKEN TO PREVENT ANY
- 28 DAMAGE WHATSOEVER TO THE PAVEMENT
- 29
- 30 CONDITION OF ROAD UPON COMPLETION OF JOB SHALL BE AS GOOD OR
- 31 BETTER THAN PRIOR TO STARTING
- 32
- 33 CONTRACTOR SHALL COMPLY WITH ALL APPLICABLE NATIONAL
- 34 ELECTRICAL SAFETY CODE (NEC) REQUIREMENTS, CENTERPOINT
- 35 ENERGY ELECTRIC POLE & UTILITY GUIDELINES & PROCEDURES AND
- 36 ALL OTHER APPLICABLE STANDARDS AND REGULATIONS FOR THE
- 37 PLACEMENT OF AERIAL CABLE FACILITIES. 18" MIN VERTICAL
- 38 CLEARANCE
- 39
- 40 ALL UTILITIES WILL BE IDENTIFIED BY POT-HOLE BEFORE ANY
- 41 CONSTRUCTION
- 42
- 43 CONTRACT WILL MAINTAIN (2FT) HORIZONTAL & VERTICAL SEPARATION
- 44 FROM ANY EXISTING UTILITIES
- 45
- 46 THE CONTRACTOR SHALL CONTACT WALVER COUNTY PRECINCT 4
- 47 AT LEAST 48 HOURS PRIOR TO CONSTRUCTION

9/29/2016


ASPEN
36502 HEMPSTEAD HWY
HOCKLEY, TX 77447

COMCAST PROPOSES TO INSTALL FIBER OPTIC CABLE
COMCAST PROPOSES TO PLACE DIRECTIONAL BORE 28.47 FT TO INSTALL FIBER
OPTIC CABLE TO PROVIDE SERVICE NEAR TO 2594-145 NEW WAVERLY, TX 77256,
INSIDE THE ROW OF THE WALKER COUNTY, TX
TOTAL PROJECT FOOTAGE: 28.487



comcast
d/b/a HOUSTON, LLC
4550 W. TIDWELL RD HOUSTON TEXAS 77040

RECEIVED
SEP 02 2025
BY:

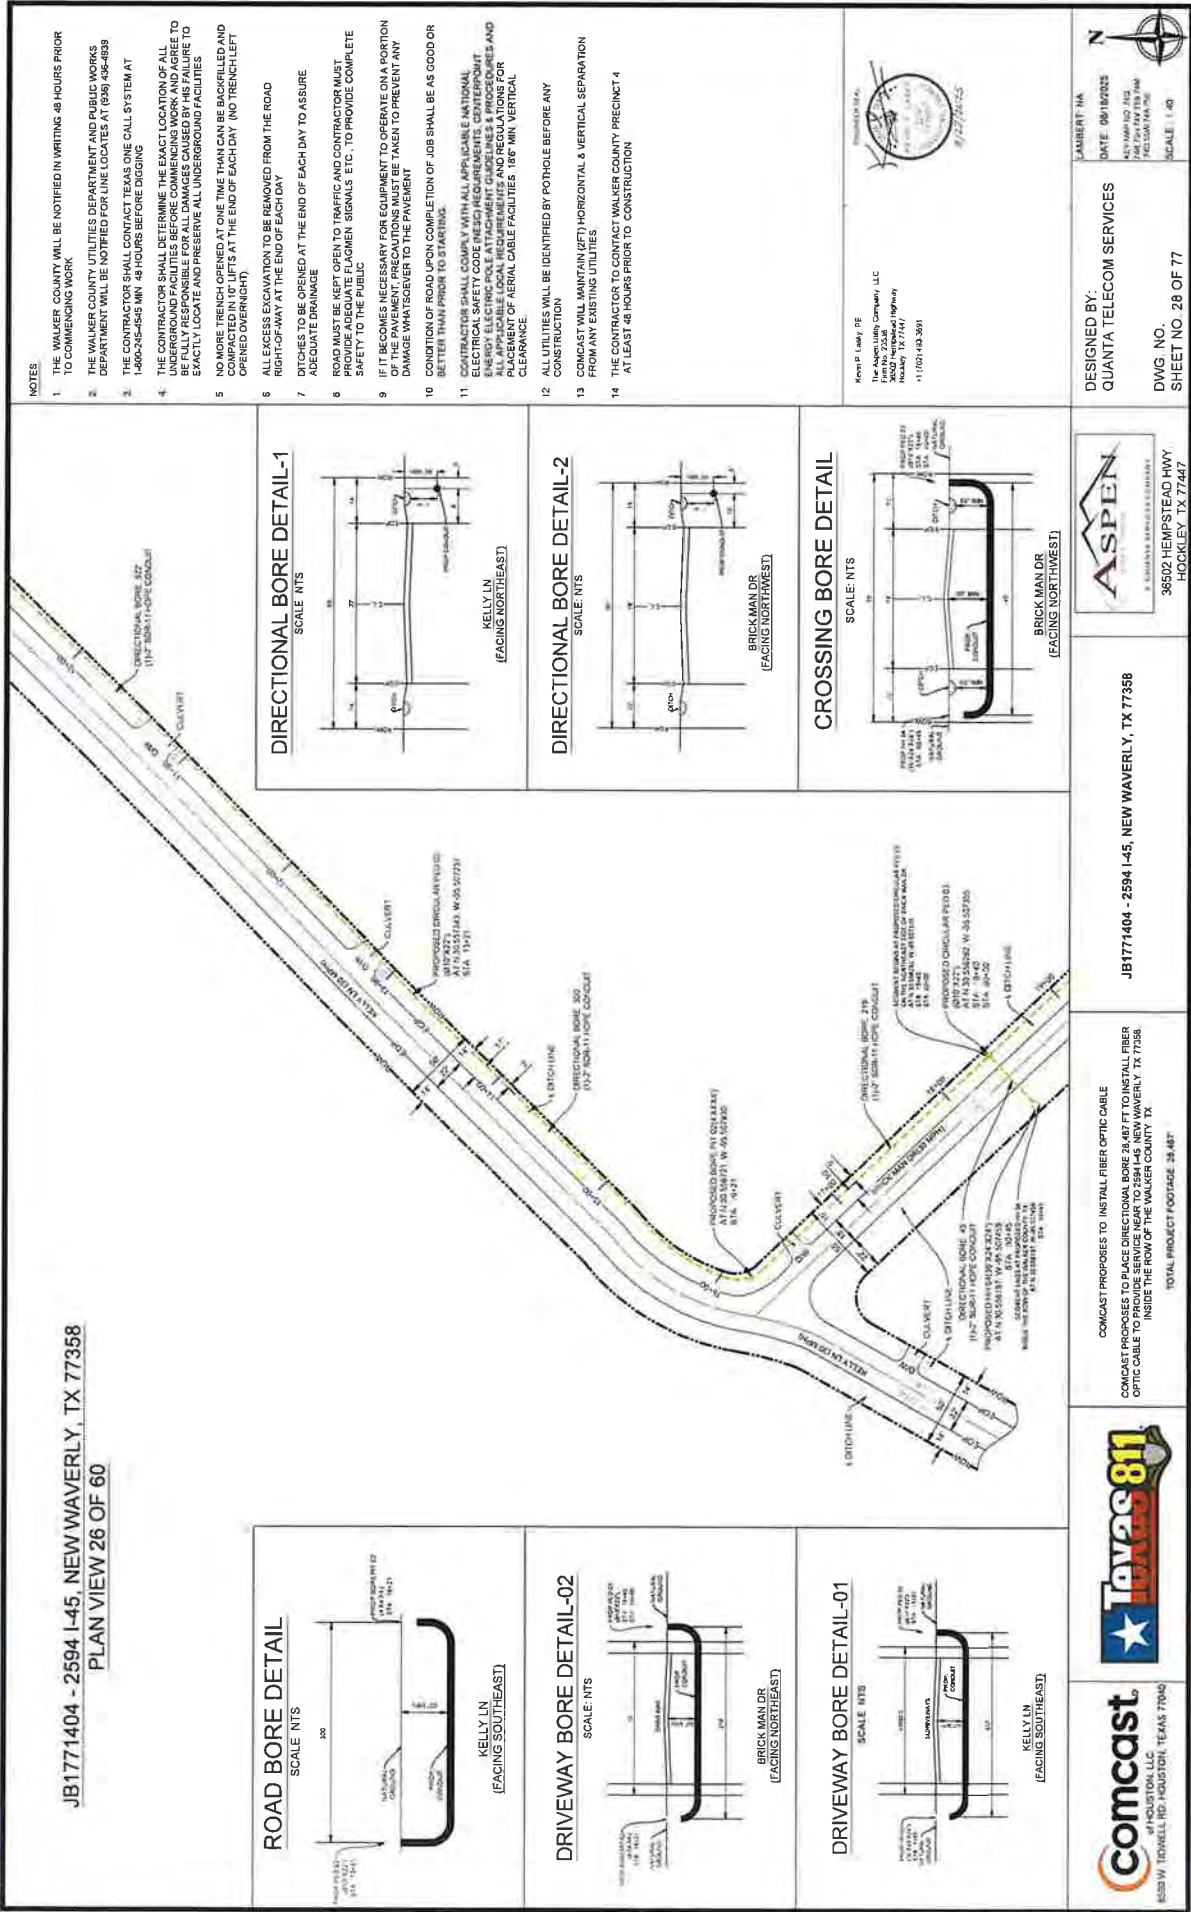

JB1771404 - 2594 I-45, NEW WAVERLY, TX 77358
PLAN VIEW 27 OF 60



CROSSING BORE DETAIL-1

SCALE: NTS




CROSSING BORE DETAIL-2

SCALE: NTS

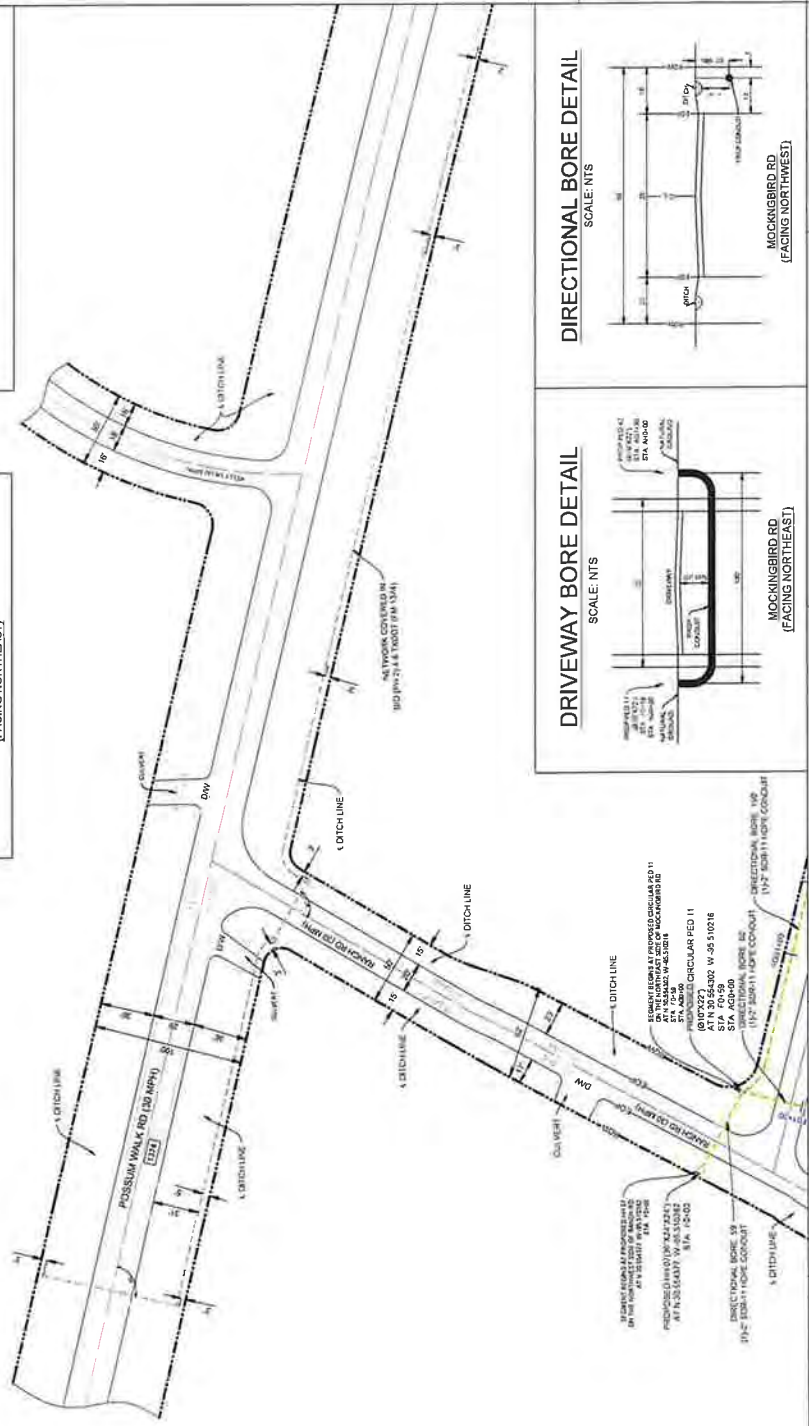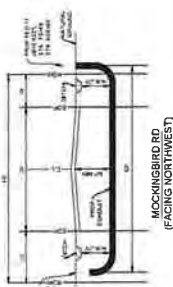


DRIVEWAY BORE DETAIL

SCALE: NTS

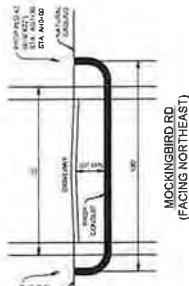

DIRECTIONAL BORE DETAIL


SCALE: NTS

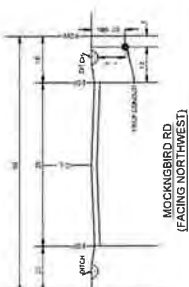

NOTES

1. THE WALKER COUNTY WILL BE NOTIFIED IN WRITING 48 HOURS PRIOR TO COMMENCING WORK.
2. THE WALKER COUNTY UTILITIES DEPARTMENT AND PUBLIC WORKS DEPARTMENT WILL BE NOTIFIED FOR LINE LOCATES AT (936) 438-4899.
3. THE CONTRACTOR SHALL CONTACT TEXAS ONE CALL SYSTEM AT 1-800-245-4545 MIN. 48 HOURS BEFORE DIGGING.
4. THE CONTRACTOR SHALL DETERMINE THE EXACT LOCATION OF ALL UNDERGROUND FACILITIES BEFORE COMMENCING WORK AND AGREE TO BE FULLY RESPONSIBLE FOR ALL DAMAGES CAUSED BY HIS FAILURE TO EXACTLY LOCATE AND PRESERVE ALL UNDERGROUND FACILITIES.
5. NO MORE TRENCH OPENED AT ONE TIME THAN CAN BE BACKFILLED AND COMPACTED IN 10' LIFTS AT THE END OF EACH DAY (NO TRENCH LEFT OPENED OVERNIGHT).
6. ALL EXCESS EXCAVATION TO BE REMOVED FROM THE ROAD RIGHT-OF-WAY AT THE END OF EACH DAY.
7. DITCHES TO BE OPENED AT THE END OF EACH DAY TO ASSURE ADEQUATE DRAINAGE.
8. ROAD MUST BE KEPT OPEN TO TRAFFIC AND CONTRACTOR MUST PROVIDE ADEQUATE FLAGMEN SIGNALS, ETC., TO PROVIDE COMPLETE SAFETY TO THE PUBLIC.
9. IF IT BECOMES NECESSARY FOR EQUIPMENT TO OPERATE ON A PORTION OF THE PAVEMENT, PRECAUTIONS MUST BE TAKEN TO PREVENT ANY DAMAGE WHATSOEVER TO THE PAVEMENT.
10. CONDITION OF ROAD UPON COMPLETION OF JOB SHALL BE AS GOOD OR BETTER THAN PRIOR TO STARTING.
11. CONTRACTOR SHALL COMPLY WITH ALL APPLICABLE NATIONAL ELECTRICAL SAFETY CODE (NEC) REQUIREMENTS, CENTERPOINT ENERGY ELECTRIC POLE ATTACHMENT GUIDELINES & PROCEDURES AND ALL OTHER APPLICABLE REQUIREMENTS FOR THE PROPER PLACEMENT OF AERIAL CABLE FACILITIES. 18\"/>
- 12. ALL UTILITIES WILL BE IDENTIFIED BY POTHOLE BEFORE ANY CONSTRUCTION.
- 13. COMCAST WILL MAINTAIN (2\"/>
- 14. THE CONTRACTOR TO CONTACT WALKER COUNTY PRECINCT 4 AT LEAST 48 HOURS PRIOR TO CONSTRUCTION.

 Project: JB1771404
The Aspen Group, LLC
2500
5000
HOUSTON, TX 77056
HOUSTON, TX 77056
(713) 432-3689



DESIGNED BY:
QUANTA TELECOM SERVICES
DWG. NO.
SHEET NO. 29 OF 77




JB1771404 - 2594 I-45, NEW WAVERLY, TX 77358

COMCAST PROPOSES TO INSTALL FIBER OPTIC CABLE
COMCAST PROPOSES TO PLACE DIRECTIONAL BORE 24\"/>



LAMBERT: NA
DATE: 08/19/2025
KEY MAPS 843
700 SW 14th St
700 SW 14th St
SCALE: 1:40

RECEIVED
SEP 02 2025
BY:

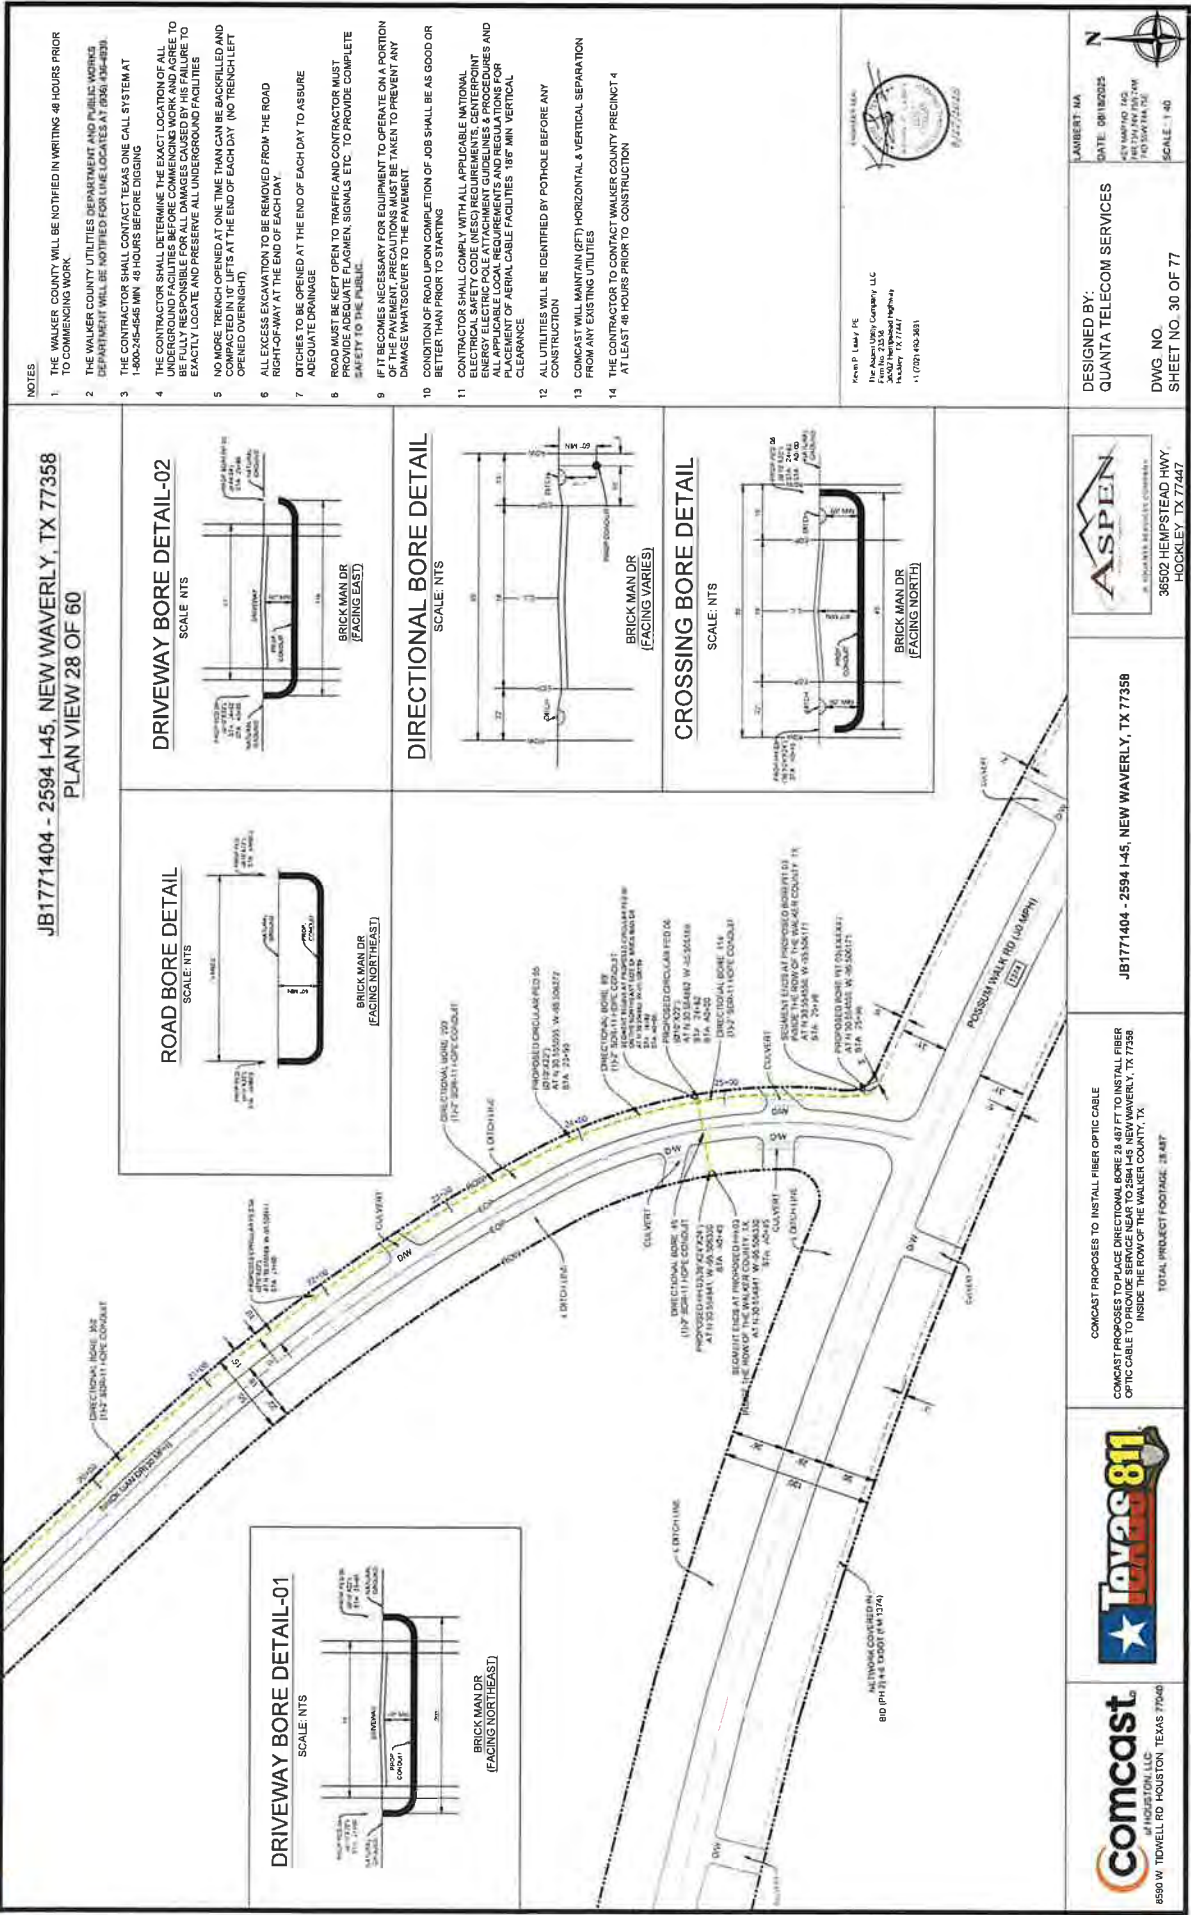


RECEIVED

SEP 02 2025

BY:

JB1771404 - 2594 L45, NEW WAVERLY, TX 77358
PLAN VIEW 30 OF 60

SEE TYPICAL DETAILS ON
SHEET NO. 64

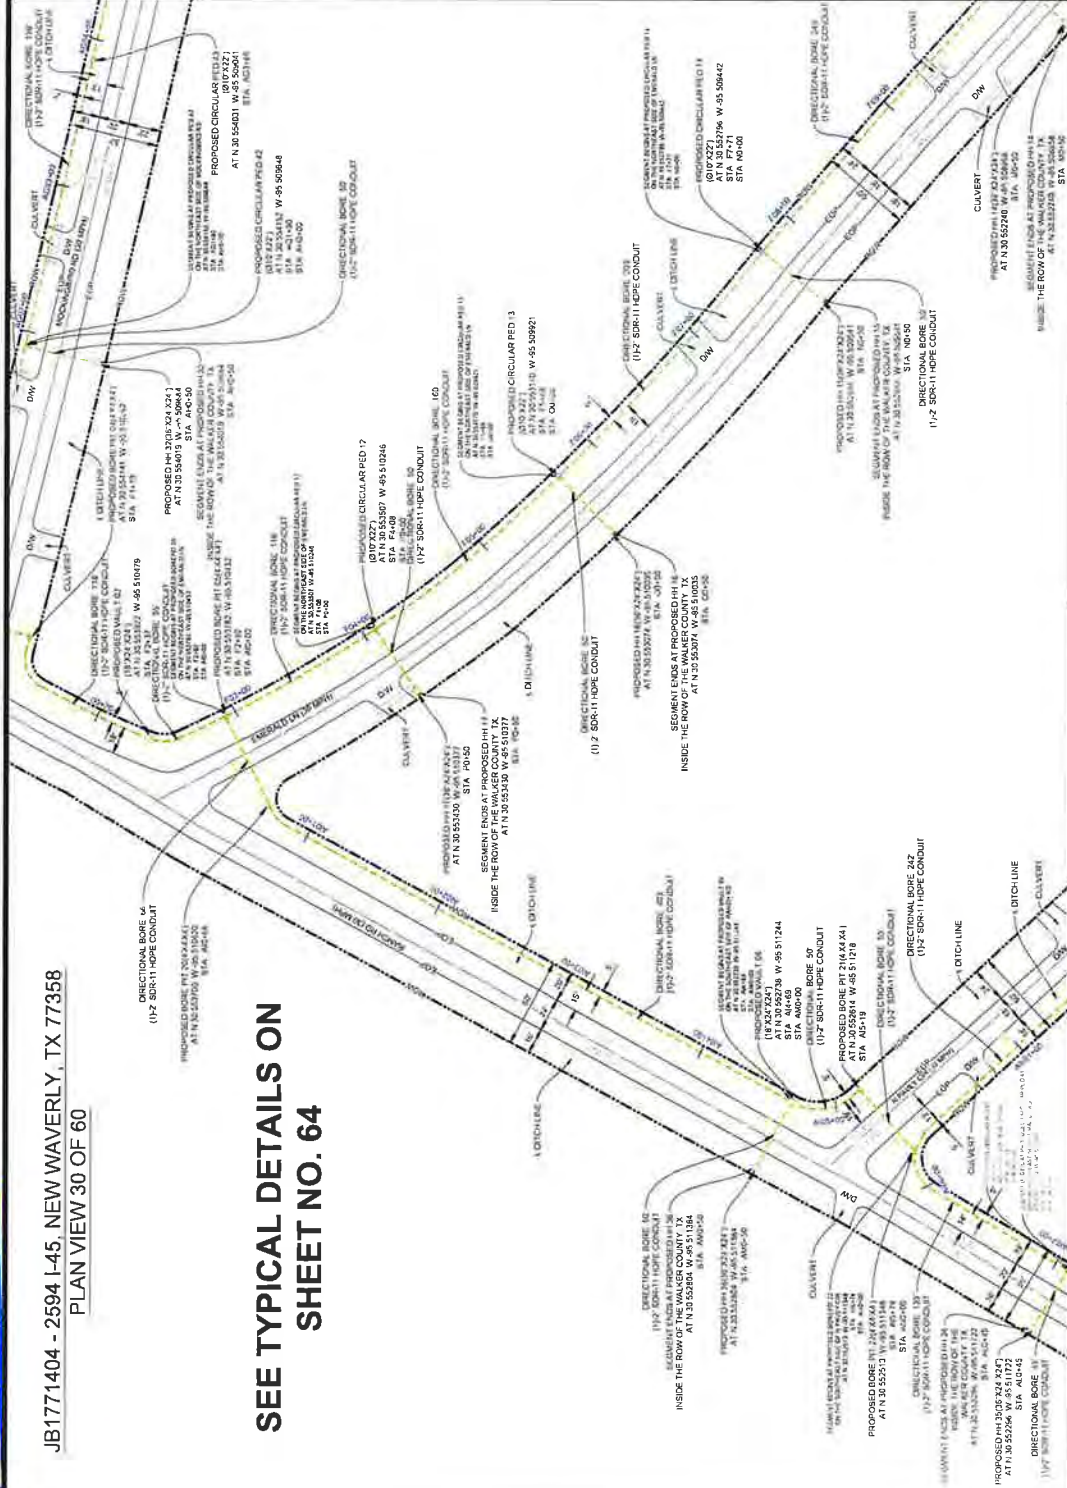

NOTES

1. THE WALKER COUNTY WILL BE NOTIFIED IN WRITING 48 HOURS PRIOR TO COMMENCING WORK.
2. THE WALKER COUNTY UTILITIES DEPARTMENT AND PUBLIC WORKS DEPARTMENT WILL BE NOTIFIED FOR LINE LOCATES AT (936) 536-4339.
3. THE CONTRACTOR SHALL CONTACT TEXAS ONE CALL SYSTEM AT 1-800-455-4545 48 HOURS BEFORE DIGGING.
4. THE CONTRACTOR SHALL DETERMINE THE EXACT LOCATION OF ALL UNDERGROUND FACILITIES BEFORE COMMENCING WORK AND AGREE TO BE FULLY RESPONSIBLE FOR ALL DAMAGES CAUSED BY HIS FAILURE TO EXACTLY LOCATE AND PRESERVE ALL UNDERGROUND FACILITIES.
5. NO MORE TRENCH OPENED AT ONE TIME THAN CAN BE BACKFILLED AND COMPACTED IN 10 UPTS AT THE END OF EACH DAY. NO TRENCH LEFT OPENED OVERNIGHT.
6. ALL EXCESS EXCAVATION TO BE REMOVED FROM THE ROAD RIGHT-OF-WAY AT THE END OF EACH DAY.
7. DITCHES TO BE DRENED AT THE END OF EACH DAY TO ASSURE ADEQUATE DRAINAGE.
8. ROAD MUST BE KEPT OPEN TO TRAFFIC AND CONTRACTOR MUST PROVIDE ADEQUATE FLAGMEN, SIGNALS, ETC., TO PROVIDE COMPLETE SAFETY TO THE PUBLIC.
9. IF IT BECOMES NECESSARY FOR EQUIPMENT TO OPERATE ON A PORTION OF THE PAVEMENT, PRECAUTIONS MUST BE TAKEN TO PREVENT ANY DAMAGE WHATSOEVER TO THE PAVEMENT.
10. CONDITION OF ROAD UPON COMPLETION OF JOB SHALL BE AS GOOD OR BETTER THAN PRIOR TO STARTING.
11. CONTRACTOR SHALL COMPLY WITH ALL APPLICABLE NATIONAL ELECTRICAL SAFETY CODE (NEC) REQUIREMENTS, CENTERPOINT ELECTRICITY DELIVERY SYSTEM REQUIREMENTS, AND PROCEDURES AND ALL APPLICABLE LOCAL REQUIREMENTS AND REGULATIONS ON PLACEMENT OF AERIAL CABLE FACILITIES. 18" MIN VERTICAL CLEARANCE.
12. ALL UTILITIES WILL BE IDENTIFIED BY POT-HOLE BEFORE ANY CONSTRUCTION.
13. COMCAST WILL MAINTAIN (GFI) HORIZONTAL & VERTICAL SEPARATION FROM ANY EXISTING UTILITIES.
14. THE CONTRACTOR TO CONTACT WALKER COUNTY PRECINCT 4 AT LEAST 48 HOURS PRIOR TO CONSTRUCTION.

Prepared by: J. L. Lundy, P.E.
The Lundy Group, Inc.
3502 Westwood Highway
Houston, TX 77057
11/07/2024



comcast
HOUSTON, TEXAS 77060
8550 W. TIDWELL RD.



COMCAST PROPOSES TO INSTALL FIBER OPTIC CABLE
COMCAST PROPOSES TO PLACE DIRECTIONAL BORE 28 48 FT TO INSTALL FIBER
OPTIC CABLE TO PROVIDE SERVICE NEAR TO 2594 L45, NEW WAVERLY, TX 77358
INSIDE THE ROW OF THE WALKER COUNTY TX.
TOTAL PROJECT FOOTAGE: 28.48 FT

JB1771404 - 2594 L45, NEW WAVERLY, TX 77358




DESIGNED BY:
QUANTA TELECOM SERVICES

DWG NO. 35502 HEMPSTEAD HWY.
SHEET NO. 32 OF 77

DATE: 08/16/2025
BY: J. L. LUNDY, P.E.
CHECKED BY: J. L. LUNDY, P.E.
SCALE: 1"=40'

JB1771404 - 2594 I-45, NEW WAVERLY, TX 77358
PLAN VIEW 31 OF 60

SEE TYPICAL DETAILS ON
SHEET NO. 65

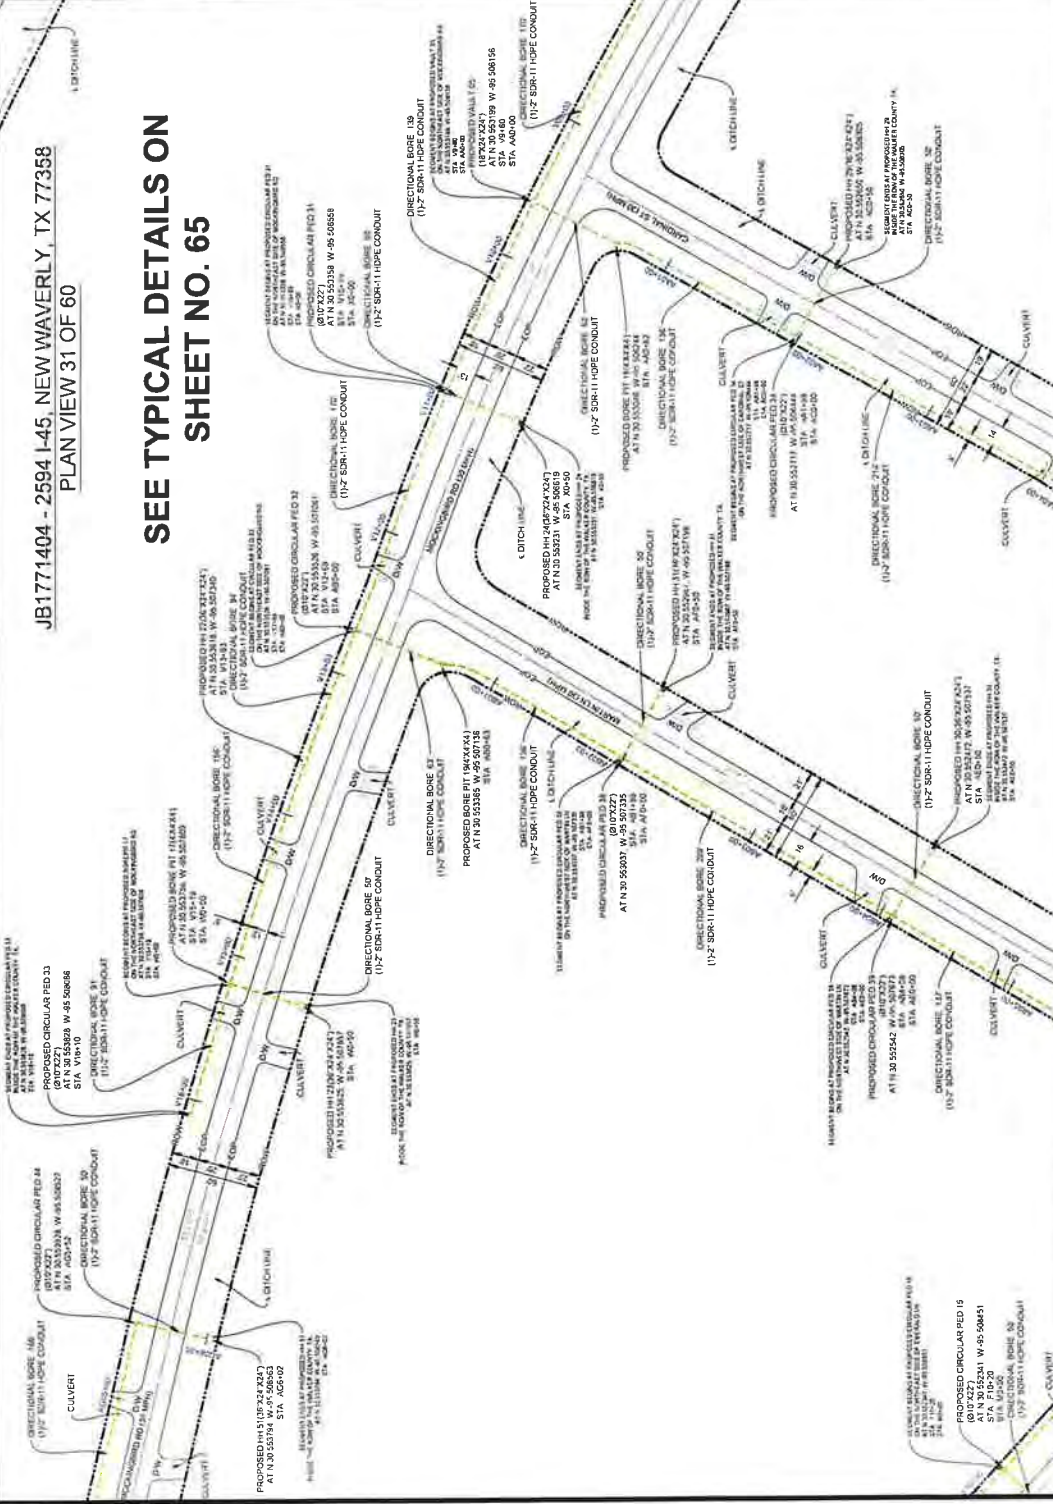

NOTES

 
1. THE WALKER COUNTY WILL BE NOTIFIED IN WRITING 48 HOURS PRIOR TO COMMENCING WORK.
2. THE WALKER COUNTY UTILITIES DEPARTMENT AND PUBLIC WORKS DEPARTMENT WILL BE NOTIFIED FOR LINE LOCATES AT (936) 496-4839
3. THE CONTRACTOR SHALL CONTACT TEXAS ONE CALL SYSTEM AT 1-800-325-5545 MIN. 48 HOURS BEFORE DIGGING.
4. THE CONTRACTOR SHALL DETERMINE THE EXACT LOCATION OF ALL UNDERGROUND FACILITIES BEFORE COMMENCING WORK AND AGREE TO BE FULLY RESPONSIBLE FOR ALL DAMAGES CAUSED BY HIS FAILURE TO EXACTLY LOCATE AND PRESERVE ALL UNDERGROUND FACILITIES
5. NO MORE TRENCH DEPTED AT ONE TIME THAN CAN BE BACKFILLED AND COMPACTED IN 10' LIFTS AT THE END OF EACH DAY. (NO TRENCH LEFT OPEN OVERNIGHT)
6. ALL EXCESS EXCAVATION TO BE REMOVED FROM THE ROAD RIGHT-OF-WAY AT THE END OF EACH DAY
7. DITCHES TO BE OPENED AT THE END OF EACH DAY TO ASSURE ADEQUATE DRAINAGE.
8. ROAD MUST BE KEPT OPEN TO TRAFFIC AND CONTRACTOR MUST PROVIDE ADEQUATE FLAGMEN, SIGNALS, ETC. TO PROVIDE COMPLETE SAFETY TO THE PUBLIC
9. IF IT BECOMES NECESSARY FOR EQUIPMENT TO OPERATE ON A PORTION OF THE PAVEMENT, PRECAUTIONS MUST BE TAKEN TO PREVENT ANY DAMAGE WHATSOEVER TO THE PAVEMENT.
10. CONDITION OF ROAD UPON COMPLETION OF JOB SHALL BE AS GOOD OR BETTER THAN PRIOR TO STARTING
11. CONTRACTOR SHALL COMPLY WITH ALL APPLICABLE NATIONAL ELECTRICAL SAFETY CODE (NESC) REQUIREMENTS, CENTERPOINT ENERGY ELECTRIC POLE ATTACHMENT GUIDELINES & PROCEDURES AND ALL APPLICABLE LOCAL REQUIREMENTS AND REGULATIONS FOR PLACEMENT OF PERMANENT OR TEMPORARY FACILITIES. 18\"/>
12. ALL UTILITIES WILL BE IDENTIFIED BY POT-HOLE BEFORE ANY CONSTRUCTION
13. CONTRACTOR WILL MAINTAIN (2FT) HORIZONTAL & VERTICAL SEPARATION FROM ANY EXISTING UTILITIES
14. THE CONTRACTOR TO CONTACT WALKER COUNTY PRECINCT 4 AT LEAST 48 HOURS PRIOR TO CONSTRUCTION

Aspen Engineering, LLC
The Aspen Engineering, LLC
P.O. Box 23300
Houston, Texas 77223
Tel: 281.462.1111
Fax: 281.462.1112



DESIGNED BY:
QUANTA TELECOM SERVICES

DWG. NO.
SHEET NO. 33 OF 77



JB1771404 - 2594 I-45, NEW WAVERLY, TX 77358

CONCAT PROPOSES TO INSTALL FIBER OPTIC CABLE
CONCAT PROPOSES TO PLACE DIRECTIONAL BORE 28 487 FT TO INSTALL FIBER OPTIC CABLE TO INSIDE THE ROW OF THE WALKER COUNTY, TX.

TOTAL PROJECT FOOTAGE: 28.487



RECEIVED
SEP 02 2025
BY:.....

JB1771404 - 2594 I-45, NEW WAVERLY, TX 77358

PLAN VIEW 32 OF 60

SEE TYPICAL DETAILS ON
SHEET NO. 66

NOTES

- 1 THE WALKER COUNTY WILL BE NOTIFIED IN WRITING 48 HOURS PRIOR TO COMMENCING WORK
- 2 THE WALKER COUNTY UTILITIES DEPARTMENT AND PUBLIC WORKS DEPARTMENT WILL BE NOTIFIED FOR LINE LOCATES AT (866) 746-4939
- 3 THE CONTRACTOR SHALL CONTACT TEXAS ONE CALL SYSTEM AT 1-800-252-4545 MIN. 48 HOURS BEFORE DIGGING
- 4 THE CONTRACTOR SHALL DETERMINE THE EXACT LOCATION OF ALL UNDERGROUND FACILITIES BEFORE COMMENCING WORK AND AGREE TO EXISTING FACILITIES. THE CONTRACTOR SHALL BE RESPONSIBLE TO EXACTLY LOCATE AND PRESERVE ALL UNDERGROUND FACILITIES
- 5 NO MORE TRENCH OPENED AT ONE TIME THAN CAN BE BACKFILLED AND COVERED WITHIN 24 HOURS OF THE END OF EACH DAY (NO TRENCH LEFT OPENED OVERNIGHT)
- 6 ALL EXCESS EXCAVATION TO BE REMOVED FROM THE ROAD RIGHT-OF-WAY AT THE END OF EACH DAY
- 7 DITCHES TO BE OPENED AT THE END OF EACH DAY TO ASSURE ADEQUATE DRAINAGE
- 8 ROAD MUST BE KEPT OPEN TO TRAFFIC AND CONTRACTOR MUST PROVIDE ADEQUATE FLAGMEN SIGNALS ETC. TO PROVIDE COMPLETE SAFETY TO THE PUBLIC
- 9 IF IT BECOMES NECESSARY FOR EQUIPMENT TO OPERATE ON A PORTION OF THE PAVEMENT, PRECAUTIONS MUST BE TAKEN TO PREVENT ANY DAMAGE WHATSOEVER TO THE PAVEMENT
- 10 CONDITION OF ROAD UPON COMPLETION OF JOB SHALL BE AS GOOD OR BETTER THAN PRIOR TO STARTING
- 11 CONTRACTOR SHALL COMPLY WITH ALL APPLICABLE NATIONAL ELECTRICAL SAFETY CODE (NEC) REQUIREMENTS, CENTERPOINT UTILITY CODES, AND ALL APPLICABLE LOCAL REQUIREMENTS AND REGULATIONS FOR PLACEMENT OF AERIAL CABLE FACILITIES 18" MIN VERTICAL CLEARANCE
- 12 ALL UTILITIES WILL BE IDENTIFIED BY POTHOLE BEFORE ANY CONSTRUCTION
- 13 CONCAST WILL MAINTAIN (2FT) HORIZONTAL & VERTICAL SEPARATION FROM ANY EXISTING UTILITIES
- 14 THE CONTRACTOR TO CONTACT WALKER COUNTY PRECINCT 4 AT LEAST 48 HOURS PRIOR TO CONSTRUCTION

Project: 1771404-2594 I-45, New Waverly, TX
Prepared By: J. R. Hester
Checked By: J. R. Hester
Date: 08/16/2025
Scale: 1"=40'



DESIGNED BY:
QUANTA TELECOM SERVICES

DWG. NO. 34 OF 77
SHEET NO. 34 OF 77




JB1771404 - 2594 I-45, NEW WAVERLY, TX 77358

CONCAST PROPOSES TO INSTALL FIBER OPTIC CABLE
CONCAST PROPOSES TO PLACE DIRECTIONAL BORE 24 IN. TO INSTALL FIBER OPTIC CABLE TO PROVIDE SERVICE NEAR TO 2594 I-45, NEW WAVERLY, TX 77358, INSIDE THE RIGHT-OF-WAY OF THE WALKER COUNTY, TX.

TOTAL PROJECT FOOTAGE 28.487



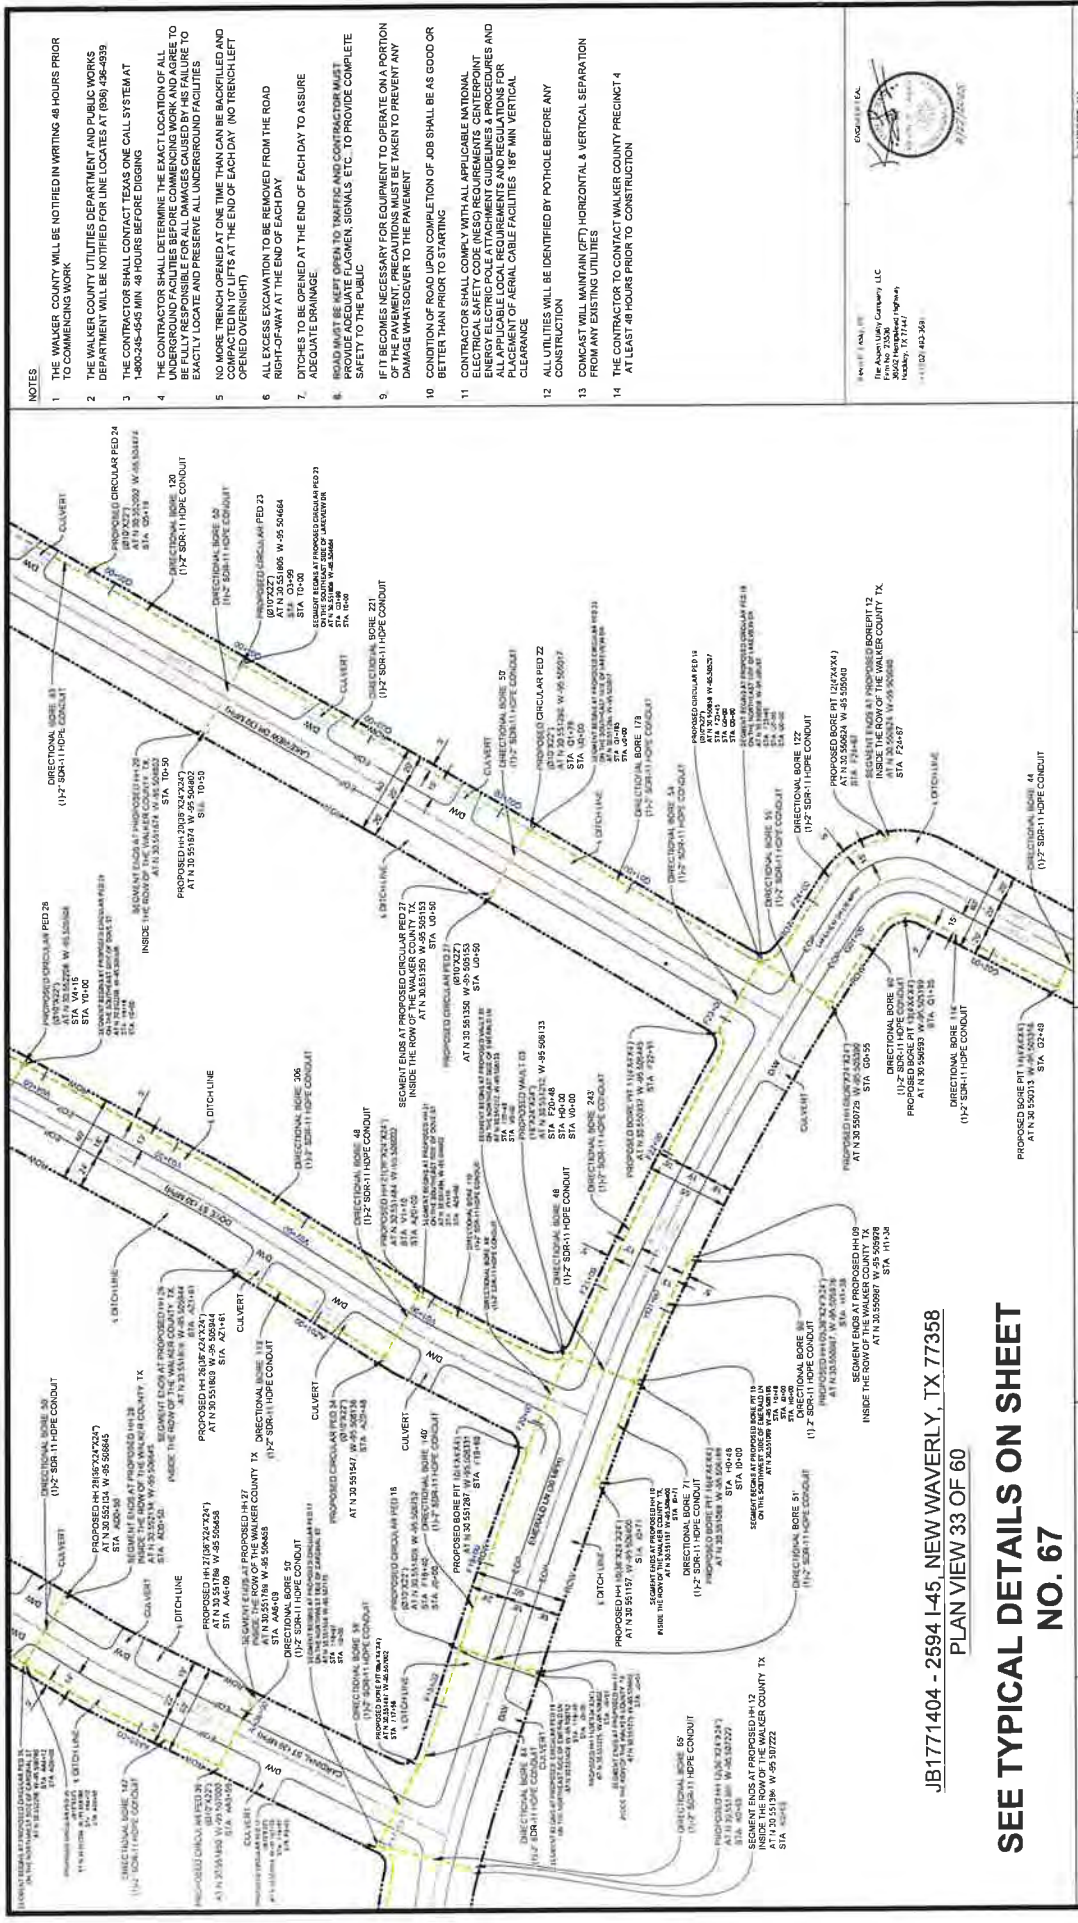


- NOTES**
- 1 THE WALKER COUNTY WILL BE NOTIFIED IN WRITING 48 HOURS PRIOR TO COMMENCING WORK
 - 2 THE WALKER COUNTY UTILITIES DEPARTMENT AND PUBLIC WORKS DEPARTMENT WILL BE NOTIFIED FOR LINE LOCATES AT (936) 296-4399
 - 3 THE CONTRACTOR SHALL CONTACT TEXAS ONE CALL SYSTEM AT 1-800-245-4545 MIN. 48 HOURS BEFORE DIGGING
 - 4 THE CONTRACTOR SHALL DETERMINE THE EXACT LOCATION OF ALL UNDERGROUND FACILITIES BEFORE COMMENCING WORK AND AGREE TO BE FULLY RESPONSIBLE FOR ALL DAMAGES CAUSED BY HIS FAILURE TO EXACTLY LOCATE AND PRESERVE ALL UNDERGROUND FACILITIES
 - 5 NO MORE TRENCH OPENED AT ONE TIME THAN CAN BE BACKFILLED AND COMPACTED IN 10' LIFTS AT THE END OF EACH DAY (NO TRENCH LEFT OPENED OVERNIGHT)
 - 6 ALL EXCESS EXCAVATION TO BE REMOVED FROM THE ROAD RIGHT-OF-WAY AT THE END OF EACH DAY
 - 7 DITCHES TO BE OPENED AT THE END OF EACH DAY TO ASSURE ADEQUATE DRAINAGE
 - 8 ROAD MUST BE KEPT OPEN TO TRAFFIC AND CONTRACTOR MUST PROVIDE ADEQUATE FLAGMEN, SIGNALS, ETC. TO PROVIDE COMPLETE SAFETY TO THE PUBLIC
 - 9 IF IT BECOMES NECESSARY FOR EQUIPMENT TO OPERATE ON A PORTION OF THE PAVEMENT, PRECAUTIONS MUST BE TAKEN TO PREVENT ANY DAMAGE WHATSOEVER TO THE PAVEMENT
 - 10 CONDITION OF ROAD UPON COMPLETION OF JOB SHALL BE AS GOOD OR BETTER THAN PRIOR TO STARTING
 - 11 CONTRACTOR SHALL COMPLY WITH ALL APPLICABLE NATIONAL ELECTRICAL SAFETY CODE (NEC) REQUIREMENTS, CENTERPOINT ENERGY ELECTRIC POLE ATTACHMENT GUIDELINES & PROCEDURES AND ALL OTHER REQUIREMENTS OF THE UTILITY OWNERS REGARDING THE PLACEMENT OF AERIAL CABLE FACILITIES, 18" MIN. VERTICAL CLEARANCE
 - 12 ALL UTILITIES WILL BE IDENTIFIED BY POT-HOLE BEFORE ANY CONSTRUCTION
 - 13 CONTRACTOR WILL MAINTAIN (24) HORIZONTAL & VERTICAL SEPARATION FROM ANY EXISTING UTILITIES
 - 14 THE CONTRACTOR TO CONTACT WALKER COUNTY PRECINCT 4 AT LEAST 48 HOURS PRIOR TO CONSTRUCTION



DESIGNED BY:
QUANTA TELECOM SERVICES

DWG. NO.
36502 HEMPSTEAD HWY.

 SHEET NO. 35 OF 77



JB1771404 - 2594 I-45, NEW WAVERLY, TX 77358

COMCAST PROPOSES TO INSTALL FIBER OPTIC CABLE
COMCAST PROPOSES TO PLACE DIRECTIONAL BORE 28 40' FT TO INSTALL FIBER OPTIC CABLE TO PROVIDE SERVICE NEAR TO 2594 I-45, NEW WAVERLY, TX 77358, INSIDE THE ROW OF THE WALKER COUNTY, TX

TOTAL PROJECT FOOTAGE: 28.40'




JB1771404 - 2594 I-45, NEW WAVERLY, TX 77358
PLAN VIEW 33 OF 60

SEE TYPICAL DETAILS ON SHEET
NO. 67

RECEIVED
SEP 02 2025
BY:

SEE TYPICAL DETAILS ON
SHEET NO. 68

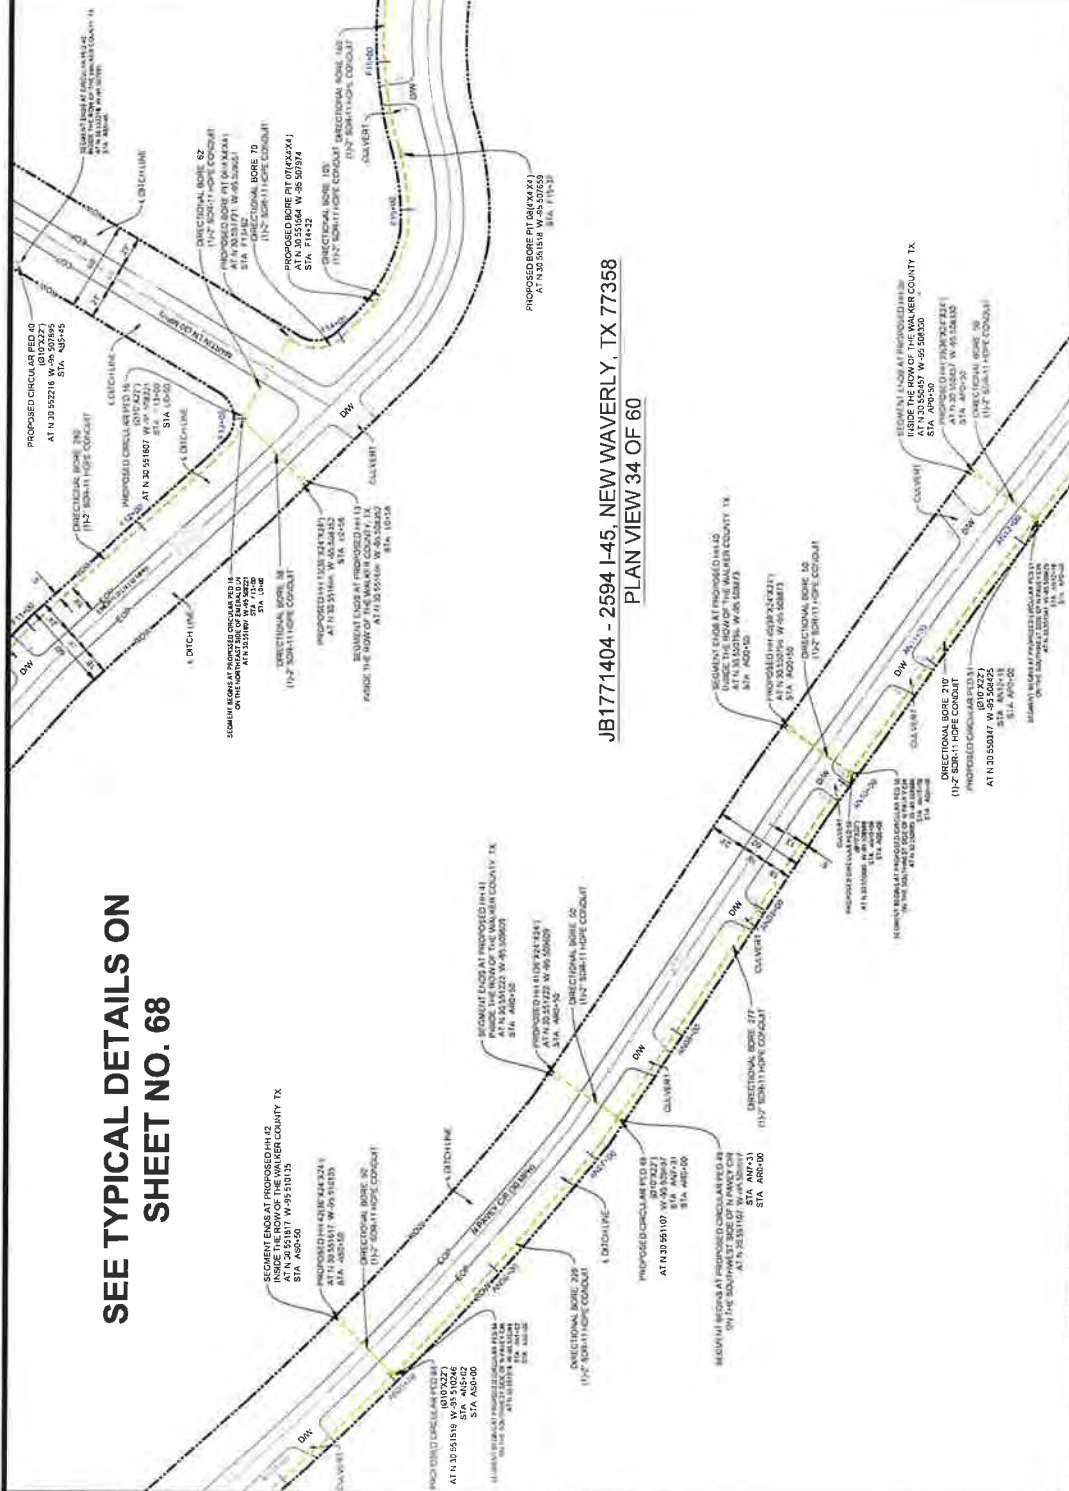

JB1771404 - 2594+45, NEW WAVERLY, TX 77358
PLAN VIEW 34 OF 60

- NOTES:
1. THE WALKER COUNTY WILL BE NOTIFIED IN WRITING 48 HOURS PRIOR TO COMMENCING WORK.
 2. THE WALKER COUNTY UTILITIES DEPARTMENT AND PUBLIC WORKS DEPARTMENT WILL BE NOTIFIED FOR LINE LOCATES AT 1590 435-4859.
 3. THE CONTRACTOR SHALL CONTRACT TEXAS ONE CALL SYSTEM AT 1-800-452-4545 MIN. 48 HOURS BEFORE DIGGING.
 4. THE CONTRACTOR SHALL DETERMINE THE EXACT LOCATION OF ALL UNDERGROUND FACILITIES BEFORE COMMENCING WORK AND AGREE TO EXISTING FACILITIES. THE CONTRACTOR SHALL BE RESPONSIBLE FOR THE FAILURE TO EXACTLY LOCATE AND PRESERVE ALL UNDERGROUND FACILITIES.
 5. NO MORE TRENCH OPENED AT ONE TIME THAN CAN BE BACKFILLED AND RECLOSED WITHIN 24 HOURS. ALL TRENCHES SHALL BE BACKFILLED AND RECLOSED WITHIN 24 HOURS AT THE END OF EACH DAY (NO TRENCH LEFT OPENED OVERNIGHT).
 6. ALL EXCESS EXCAVATION TO BE REMOVED FROM THE ROAD RIGHT-OF-WAY AT THE END OF EACH DAY.
 7. DITCHES TO BE OPENED AT THE END OF EACH DAY TO ASSURE ADEQUATE DRAINAGE.
 8. ROAD MUST BE KEPT OPEN TO TRAFFIC AND CONTRACTOR MUST PROVIDE ADEQUATE FLAGMEN SIGNALS ETC. TO PROVIDE COMPLETE SAFETY TO THE PUBLIC.
 9. IF IT BECOMES NECESSARY FOR EQUIPMENT TO OPERATE ON A PORTION OF THE PAVEMENT PRECAUTIONS MUST BE TAKEN TO PREVENT ANY DAMAGE WHATSOEVER TO THE PAVEMENT.
 10. CONDITION OF ROAD UPON COMPLETION OF JOB SHALL BE AS GOOD OR BETTER THAN PRIOR TO STARTING.
 11. CONTRACTOR SHALL COMPLY WITH ALL APPLICABLE NATIONAL ELECTRICAL SAFETY CODE (NEC) REQUIREMENTS. CENTERPOINT ENERGY SHALL BE NOTIFIED FOR ALL APPLICABLE LOCAL REQUIREMENTS AND REGULATIONS FOR PLACEMENT OF AERIAL CABLE FACILITIES. 18" MIN VERTICAL CLEARANCE.
 12. ALL UTILITIES WILL BE IDENTIFIED BY POT HOLE BEFORE ANY CONSTRUCTION.
 13. COMCAST WILL MAINTAIN 2 FT HORIZONTAL & VERTICAL SEPARATION FROM ANY EXISTING UTILITIES.
 14. THE CONTRACTOR TO CONTACT WALKER COUNTY PRECINCT 4 AT LEAST 48 HOURS PRIOR TO CONSTRUCTION.



DESIGNED BY:
QUANTA TELECOM SERVICES

DWG. NO.
SHEET NO. 36 OF 77

SCALE: 1" = 40'



JB1771404 - 2594+45, NEW WAVERLY, TX 77358

COMCAST PROPOSES TO INSTALL FIBER OPTIC CABLE
COMCAST PROPOSES TO PLACE DIRECTIONAL BORE 20' 40' FT TO INSTALL FIBER OPTIC CABLE TO INSIDE THE ROW OF THE WALKER COUNTY, TX.



Comcast
8550 W. TIDWELL RD. HOUSTON, TEXAS 77060

JB1771404 - 2594 I-45, NEW WAVERLY, TX 77358
PLAN VIEW 35 OF 60

SEE TYPICAL DETAILS ON SHEET NO. 69



NOTES

1. THE WALKER COUNTY SHALL BE NOTIFIED IN WRITING 48 HOURS PRIOR TO COMMENCING WORK.
2. THE WALKER COUNTY UTILITIES DEPARTMENT AND PUBLIC WORKS DEPARTMENT WILL BE NOTIFIED FOR LINE LOCATES AT (936) 768-9339.
3. THE CONTRACTOR SHALL CONTACT TEXAS ONE CALL SYSTEM AT 1-800-455-4545 MIN. 48 HOURS BEFORE DIGGING.
4. THE CONTRACTOR SHALL DETERMINE THE EXACT LOCATION OF ALL UNDERGROUND FACILITIES BEFORE COMMENCING WORK AND AGREE TO BE FULLY RESPONSIBLE FOR ALL DAMAGES CAUSED BY HIS FAILURE TO EXACTLY LOCATE AND PRESERVE ALL UNDERGROUND FACILITIES.
5. NO MORE TRENCH OPENED AT ONE TIME THAN CAN BE BACKFILLED AND COMPACTED WITHIN 24 HOURS OF EACH DAY. NO TRENCH LEFT OPENED OVERNIGHT.
6. ALL EXCESS EXCAVATION TO BE REMOVED FROM THE ROAD RIGHT-OF-WAY AT THE END OF EACH DAY.
7. DITCHES TO BE OPENED AT THE END OF EACH DAY TO ASSURE ADEQUATE DRAINAGE.
8. ROAD MUST BE KEPT OPEN TO TRAFFIC AND CONTRACTOR MUST PROVIDE ADEQUATE FLAGMEN, SIGNALS, ETC. TO PROVIDE COMPLETE SAFETY TO THE PUBLIC.
9. IF IT BECOMES NECESSARY FOR EQUIPMENT TO OPERATE ON A PORTION OF THE PAVEMENT, PRECAUTIONS MUST BE TAKEN TO PREVENT ANY DAMAGE WHATSOEVER TO THE PAVEMENT.
10. CONDITION OF ROAD UPON COMPLETION OF JOB SHALL BE AS GOOD OR BETTER THAN PRIOR TO STARTING.
11. CONTRACTOR SHALL COMPLY WITH ALL APPLICABLE NATIONAL ELECTRICAL SAFETY CODE (NEC) REQUIREMENTS, CENTERPOINT ENERGY ELECTRICITY ATTACHMENT GUIDELINES & PROCEDURES AND ALL OTHER APPLICABLE REGULATIONS AND ORDINANCES FOR THE PROTECTION OF AERIAL CABLE FACILITIES, 18" MIN. VERTICAL CLEARANCE.
12. ALL UTILITIES WILL BE IDENTIFIED BY POT-HOLE BEFORE ANY CONSTRUCTION.
13. COMCAST WILL MAINTAIN (GFI) HORIZONTAL & VERTICAL SEPARATION FROM ANY EXISTING UTILITIES.
14. THE CONTRACTOR TO CONTACT WALKER COUNTY PRECINCT 4 AT LEAST 48 HOURS PRIOR TO CONSTRUCTION.

Project: JB1771404
The Aspen Utility Company, LLC
38502 Hempstead Highway
Hockley, TX 77447
(281) 943-3339



DESIGNED BY:
QUANTA TELECOM SERVICES

DATE: 08/18/2023
BY: J. L. LARSEN
CHECKED: J. L. LARSEN
SCALE: 1"=40'

DWG. NO.
SHEET NO. 37 OF 77



JB1771404 - 2594 I-45, NEW WAVERLY, TX 77358

CONCAST PROPOSES TO INSTALL FIBER OPTIC CABLE
CONCAST PROPOSES TO PLACE DIRECTIONAL BORE 28-487 FT TO INSTALL FIBER OPTIC CABLE TO PROVIDE SERVICE NEAR TO 2594 I-45, NEW WAVERLY, TX 77358, INSIDE THE ROW OF THE WALKER COUNTY, TX.
TOTAL PROJECT FOOTAGE: 28.487



BY:



© 1994 Lashby PE
All Rights Reserved. Lashby, LLC
Printed in USA
36502 Horseshoe Highway
Hickory, NC 77447
813 02 483 7698



COMCAST PROPOSES TO PLACE DIRECTIONAL BORE 28,487 FT TO INSTALL FIBER OPTIC CABLE TO PROVIDE SERVICE NEAR TO 2594 I-45 NEW WAVE INSIDE THE ROW OF THE WALKER COUNTY, TX

JB1771404 - 2594 I-45, NEW WAVERLY, TX 77358

6502 HEMPSTEAD HWY.
HOCKLEY TX 77447

DESIGNED BY:
QUANTA TEL ECOM SERVICES

DWG. NO.
SHEET NO. 38 OF 77


LAMBERT: NA

DATE: 09/18/2025

NEW YORK, N.Y. 10017
10017 New York, N.Y.

SCALE 140

SEE TYPICAL DETAILS ON SHEET
NO. 71

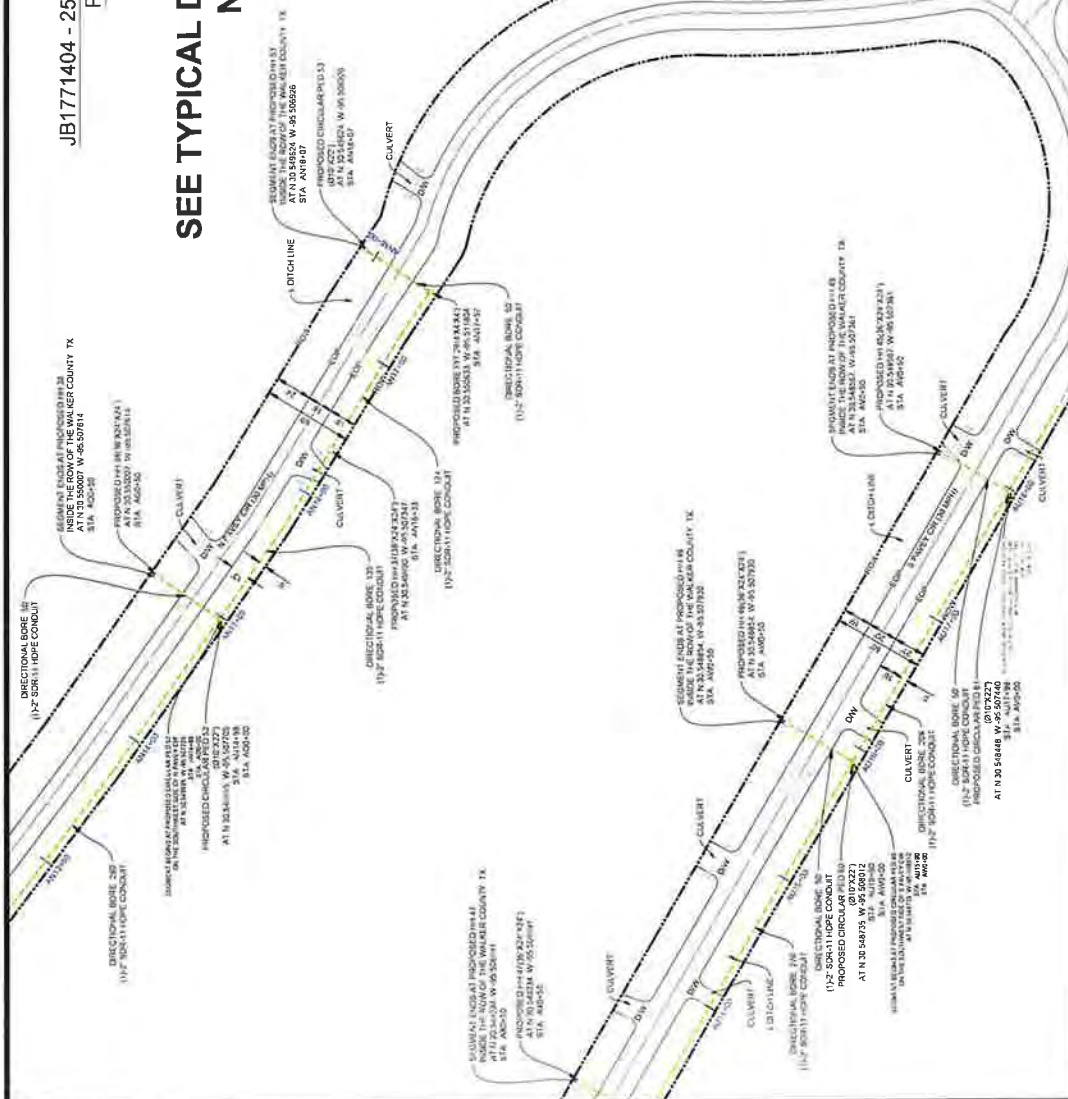

1. THE WALKER COUNTY SHALL BE NOTIFIED IN WRITING 48 HOURS PRIOR TO COMMENCING WORK.
2. THE WALKER COUNTY UTILITIES DEPARTMENT, AND PUBLIC WORKS DEPARTMENT MAY BE NOTIFIED FOR LINE LOCATES AT (936) 424-4809
3. THE CONTRACTOR SHALL CONTACT TEXAS ONE CALL SYSTEM AT 1-800-251-4551 MIN. 4 HOURS BEFORE DIGGING.
4. THE CONTRACTOR SHALL DETERMINE THE EXACT LOCATION OF ALL UTILITIES AND MARK THEM WITH REFLECTOR PINS. THE CONTRACTOR SHALL BE FULLY RESPONSIBLE FOR ALL DAMAGES CAUSED BY HIS FAILURE TO EXACTLY LOCATE AND PRESERVE ALL UNDERGROUND FACILITIES.
5. NO MORE TRENCH OPENED ONE TIME THAN CAN BE BACKFILLED AND COMPACTED IN 10 LIFTS AT THE END OF EACH DAY, (NO TRENCH LEFT OPENED OVERNIGHT)
6. ALL EXCESS EXCAVATION TO BE REMOVED FROM THE ROAD RIGHT-OF-WAY AT THE END OF EACH DAY
7. DITCHES TO BE OPENED AT THE END OF EACH DAY TO ASSURE ADEQUATE DRAINAGE
8. ROAD MUST BE KEPT OPEN TO TRAFFIC AND CONTRACTOR MUST PROVIDE ADEQUATE FLAGMEN SIGNALS, ETC. TO PROVIDE COMPLETE SAFETY TO THE PUBLIC
9. IF IT BECOMES NECESSARY FOR EQUIPMENT TO OPERATE ON A PORTION OF THE PAVEMENT, PRECAUTIONS MUST BE TAKEN TO PREVENT ANY DAMAGE WHATSOEVER TO THE PAVEMENT
10. CONDITION OF ROAD UPON COMPLETION OF JOB SHALL BE AS GOOD OR BETTER THAN PRIOR TO STARTING.
11. CONTRACTOR SHALL COMPLY WITH ALL APPLICABLE NATIONAL ELECTRICAL SAFETY CODE (NEC) REQUIREMENTS, CENTERPOINT ENERGY ELECTRICAL ATTACHMENT GUIDELINES 4, CENTERPOINT ENERGY ATTACHMENT GUIDELINES 5, AND THE NATIONAL ELECTRICAL PLACEMENT OF AERIAL CABLE FACILITIES 18" MIN VERTICAL CLEARANCE
12. ALL UTILITIES MUST BE IDENTIFIED BY POT-HOLE BEFORE ANY CONSTRUCTION
13. COMCAST WILL MAINTAIN (GFI) HORIZONTAL & VERTICAL SEPARATION FROM ANY EXISTING UTILITIES
14. THE CONTRACTOR TO CONTACT WALKER COUNTY PRECINCT 4 AT (936) 424-4809 PRIOR TO CONSTRUCTION.

11111e Aqueduct Utility Company, LLC
Firm No. 23036
36302 Hempstead Highway
Hickory 1X 71441
4102-493-3691



COMCAST PROPOSES TO INSTALL FIBER OPTIC CABLE
COMCAST PROPOSES TO PLACE DIRECTIONAL BORE 28 487 FT TO INSTALL FIBER
OPTIC CABLE TO PROVIDE SERVICE NEAR TO 2594 I-45 NEW WAVERLY TX 77358
INSIDE THE ROW OF THE WALKER COUNTY, TX



comcast
#HOUSTON, LLC
1550 W. FIDELL RD., HOUSTON, TEXAS 77040

DWG. NO.
SHEET NO. 39 OF 77




ALBERT: NA

DESIGNED BY:
QUANTA TELECOM SERVICES

DWG. NO.
SHEET NO. 39 OF 77

RECEIVED
SEP 02 2025
BY:

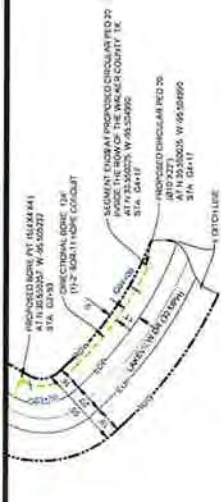


JB1771404 - 2594 I-45, NEW WAVERLY, TX 77358
PLAN VIEW 38 OF 60


NOTES

1. THE WALKER COUNTY WILL BE NOTIFIED IN WRITING 48 HOURS PRIOR TO COMMENCING WORK
2. THE WALKER COUNTY UTILITIES DEPARTMENT AND PUBLIC WORKS DEPARTMENT WILL BE NOTIFIED FOR LINE LOCATES AT 0900 456-4999
3. THE CONTRACTOR SHALL CONTACT TEXAS ONE CALL SYSTEM AT 1-800-345-4545 MIN 48 HOURS BEFORE DIGGING
4. THE CONTRACTOR SHALL DETERMINE THE EXACT LOCATION OF ALL UNDERGROUND FACILITIES BEFORE COMMENCING WORK AND AGREE TO BE FULLY RESPONSIBLE FOR ALL DAMAGES CAUSED BY HIS FAILURE TO EXACTLY LOCATE AND PRESERVE ALL UNDERGROUND FACILITIES
5. NO MORE TRENCH OPENED AT ONE TIME THAN CAN BE BACKFILLED AND COMPACTED IN 10 DAYS AT THE END OF EACH DAY (NO TRENCH LEFT OPENED OVERNIGHT)
6. ALL EXCESS EXCAVATION TO BE REMOVED FROM THE ROAD RIGHT-OF-WAY AT THE END OF EACH DAY
7. DITCHES TO BE OPENED AT THE END OF EACH DAY TO ASSURE ADEQUATE DRAINAGE
8. ROAD MUST BE KEPT OPEN TO TRAFFIC AND CONTRACTOR MUST PROVIDE ADEQUATE FLAGMEN, SIGNALS, ETC. TO PROVIDE COMPLETE SAFETY TO THE PUBLIC
9. IF IT BECOMES NECESSARY FOR EQUIPMENT TO OPERATE ON A PORTION OF THE PAVEMENT, PRECAUTIONS MUST BE TAKEN TO PREVENT ANY DAMAGE WHATSOEVER TO THE PAVEMENT
10. CONDITION OF ROAD UPON COMPLETION OF JOB SHALL BE AS GOOD OR BETTER THAN PRIOR TO STARTING
11. CONTRACTOR SHALL COMPLY WITH ALL APPLICABLE NATIONAL ELECTRICAL SAFETY CODE (NEC) REQUIREMENTS, CENTERPOINT ELECTRICITY DELIVERY PLAN, AND ALL APPLICABLE LOCAL ORDINANCES AND ALL APPLICABLE LOCAL REQUIREMENTS FOR THE PROPER PLACEMENT OF AERIAL CABLE FACILITIES 18" MIN VERTICAL CLEARANCE
12. ALL UTILITIES WILL BE IDENTIFIED BY POTHOLE BEFORE ANY CONSTRUCTION
13. COMCAST WILL MAINTAIN (GET) HORIZONTAL & VERTICAL SEPARATION FROM ANY EXISTING UTILITIES
14. THE CONTRACTOR TO CONTACT WALKER COUNTY PRECINCT 4 AT LEAST 48 HOURS PRIOR TO CONSTRUCTION

ROAD BORE DETAIL
SCALE: NTS

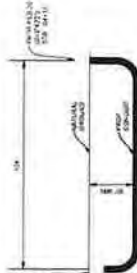

DIRECTIONAL BORE DETAIL
SCALE: NTS

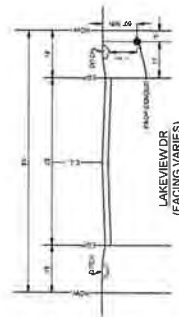

Project: 1771404
File: JB1771404-2594 I-45, NEW WAVERLY, TX 77358.dwg
Author: J. L. Smith
Date: 08/16/2025
Title: 38502 HEMPSTEAD HWY, HOCKLEY, TX 77447



COMCAST PROPOSES TO INSTALL FIBER OPTIC CABLE
COMCAST PROPOSES TO PLACE DIRECTIONAL BORE 24.48 FT TO INSTALL FIBER OPTIC CABLE TO THE ROW OF THE WALKER COUNTY, TX
TOTAL PROJECT FOOTAGE: 38.48 FT


JB1771404 - 2594 I-45, NEW WAVERLY, TX 77358



DESIGNED BY:
QUANTA TELECOM SERVICES


DWG. NO.
SHEET NO. 40 OF 77

DATE: 08/16/2025
BY: J. L. Smith
Title: 38502 HEMPSTEAD HWY, HOCKLEY, TX 77447
Scale: 1" = 40'

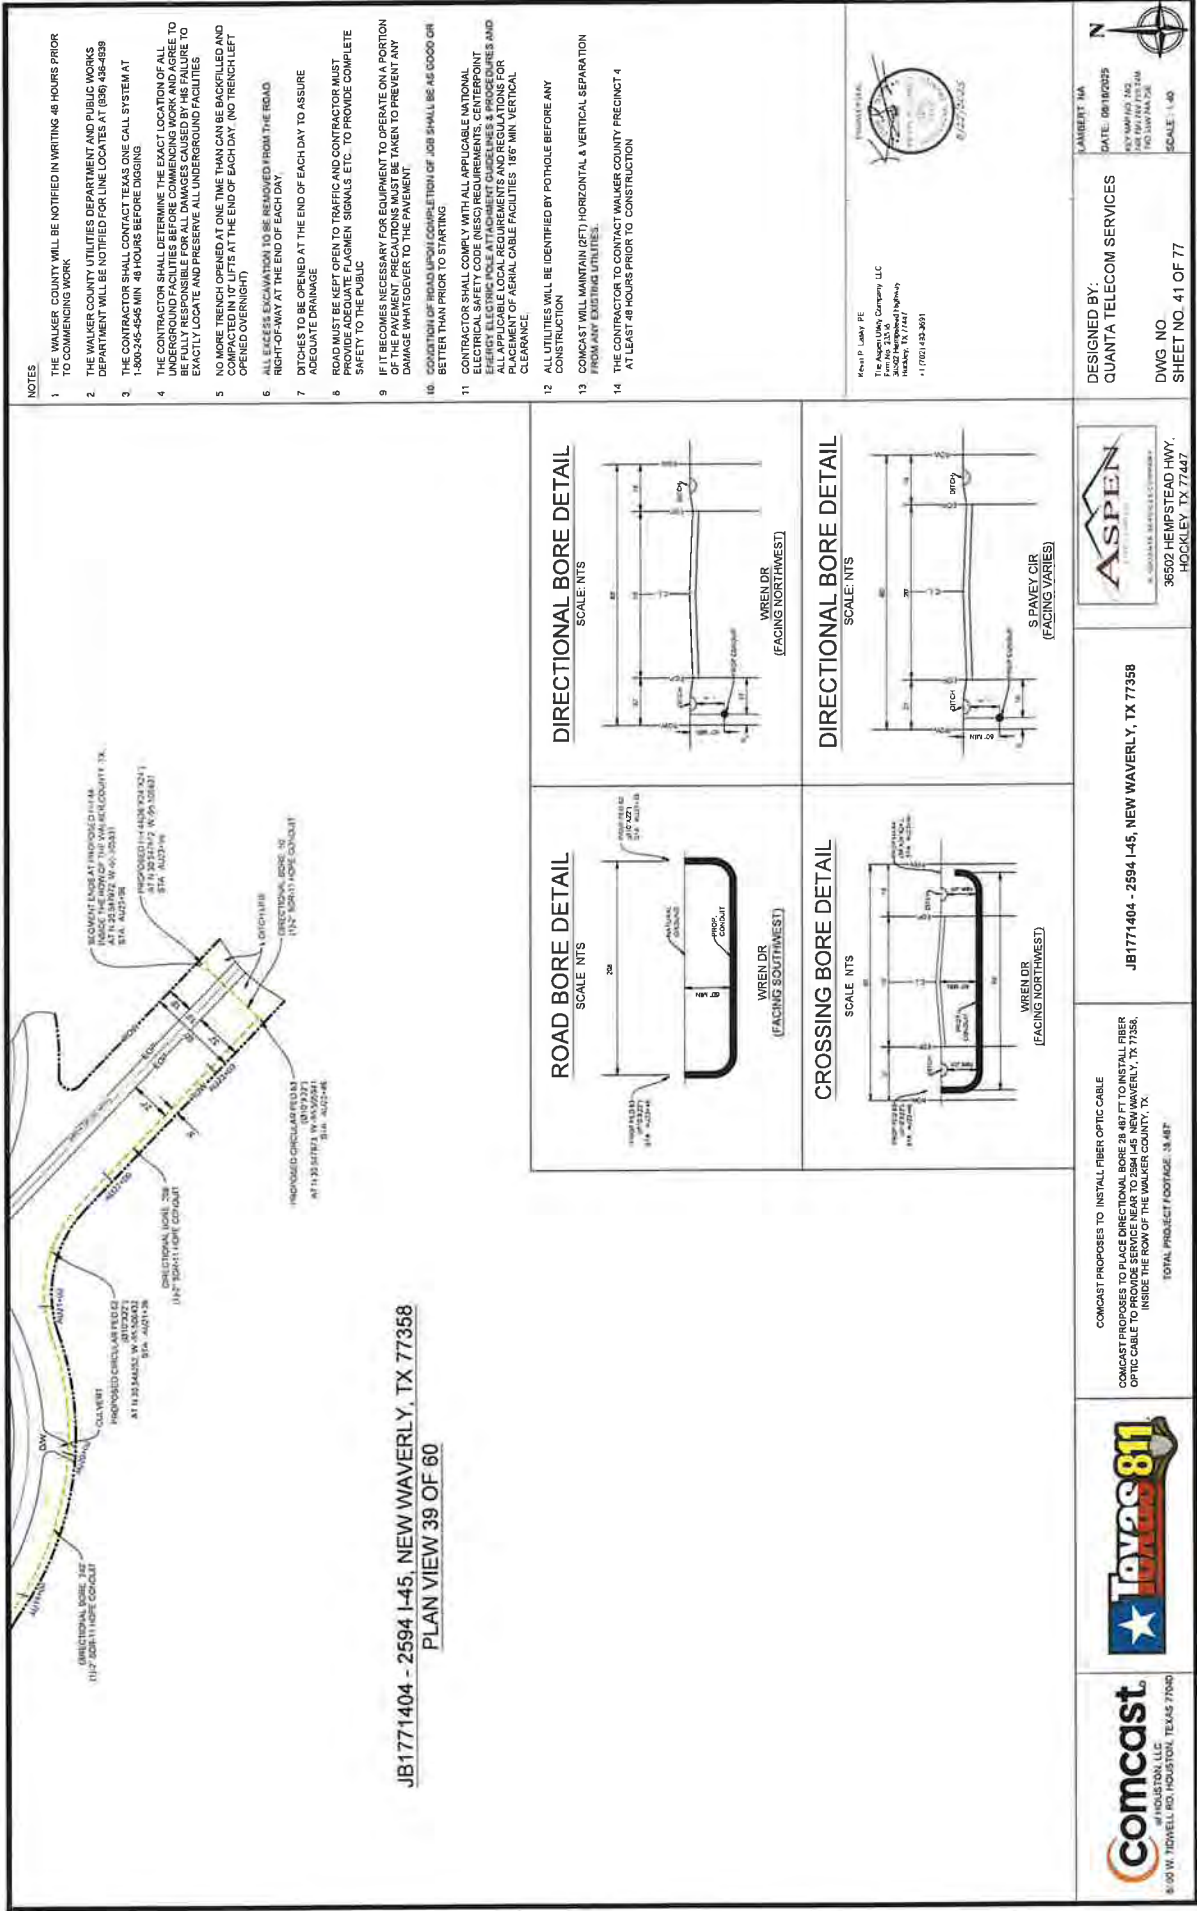

RECEIVED
SEP 02 2025
BY:

JB1771404 - 2594 I-45, NEW WAVERLY, TX 77358
PLAN VIEW 40 OF 60

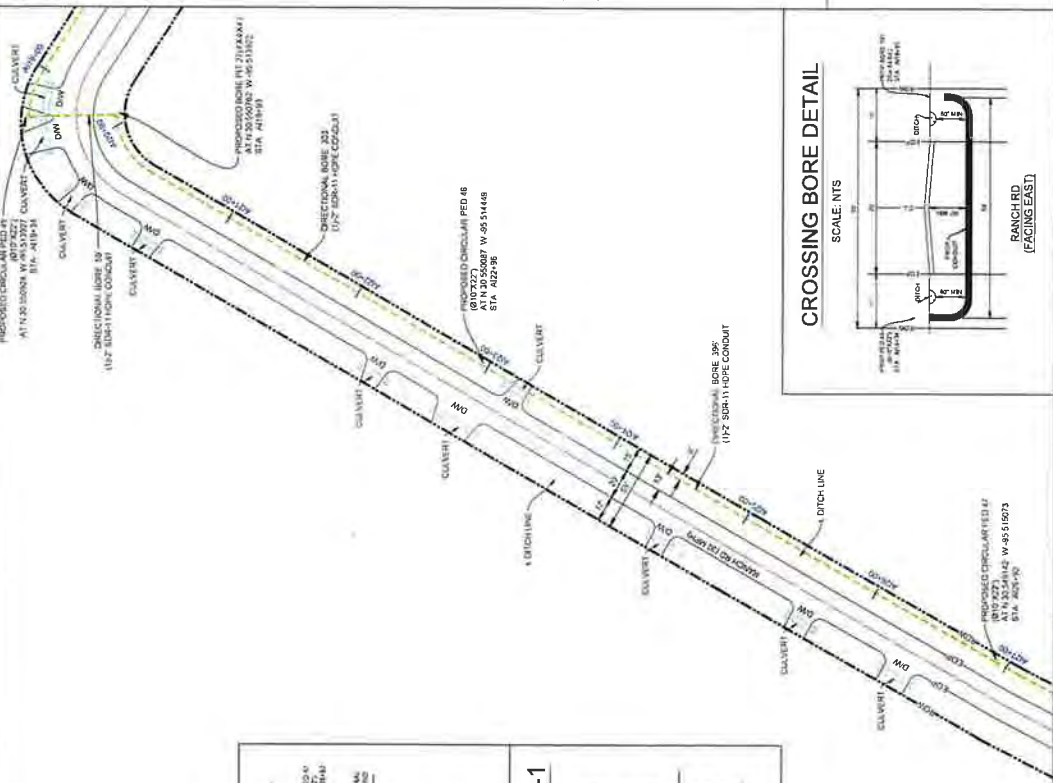

- NOTES:
1. THE WALKER COUNTY WILL BE NOTIFIED IN WRITING 48 HOURS PRIOR TO COMMENCING WORK.
 2. THE WALKER COUNTY UTILITIES DEPARTMENT AND PUBLIC WORKS DEPARTMENT WILL BE NOTIFIED FOR LINE LOCATES AT (899) 436-8999.
 3. THE CONTRACTOR SHALL CONTACT TEXAS ONE CALL SYSTEM AT 1-800-255-4545 MIN. 48 HOURS BEFORE DIGGING.
 4. THE CONTRACTOR SHALL OBTAIN THE EXACT LOCATION OF ALL UNDERGROUND FACILITIES BEFORE COMMENCING WORK AND AGREE TO BE FULLY RESPONSIBLE FOR ALL DAMAGES CAUSED BY HIS FAILURE TO EXACTLY LOCATE AND PRESERVE ALL UNDERGROUND FACILITIES.
 5. NO MORE TRENCH OPENED AT ONE TIME THAN CAN BE BACKFILLED AND COMPACTED IN 10' LIFTS AT THE END OF EACH DAY (NO TRENCH LEFT OPENED OVERNIGHT).
 6. ALL EXCESS EXCAVATION TO BE REMOVED FROM THE ROAD RIGHT-OF-WAY AT THE END OF EACH DAY.
 7. DITCHES TO BE OPENED AT THE END OF EACH DAY TO ASSURE ADEQUATE DRAINAGE.
 8. ROAD MUST BE KEPT OPEN TO TRAFFIC AND CONTRACTOR MUST PROVIDE ADEQUATE FLAGMEN, SIGNALS, ETC. TO PROVIDE COMPLETE SAFETY TO THE PUBLIC.
 9. IF IT BECOMES NECESSARY FOR EQUIPMENT TO OPERATE ON A PORTION OF THE PAVEMENT, PRECAUTIONS MUST BE TAKEN TO PREVENT ANY DAMAGE WHATSOEVER TO THE PAVEMENT.
 10. CONDITION OF ROAD UPON COMPLETION OF JOB SHALL BE AS GOOD OR BETTER THAN PRIOR TO STARTING.
 11. CONTRACTOR SHALL COMPLY WITH ALL APPLICABLE NATIONAL ELECTRICAL SAFETY CODE (NEC) REQUIREMENTS, CENTERPOINT ENERGY ELECTRIC POLE ATTACHMENT GUIDELINES & PROCEDURES AND ALL OTHER APPLICABLE RULES AND REGULATIONS FOR THE PLACEMENT OF AERIAL CABLE FACILITIES. 18' MIN VERTICAL CLEARANCE.
 12. ALL UTILITIES WILL BE IDENTIFIED BY POT HOLE BEFORE ANY CONSTRUCTION.
 13. CONTRACTOR WILL MAINTAIN 8' HORIZONTAL & VERTICAL SEPARATION FROM ANY EXISTING UTILITIES.
 14. THE CONTRACTOR TO CONTACT WALKER COUNTY PRECINCT 4 AT LEAST 48 HOURS PRIOR TO CONSTRUCTION.



DESIGNED BY:
QUANTA TELECOM SERVICES

LAURET 1A
DATE: 08/18/2025
BY: J. L. L. L.
CHK: J. L. L. L.
TWO SAN PABLO
SCALE: 1"=40'

DESIGNED BY:
QUANTA TELECOM SERVICES









JB1771404 - 2594 I-45, NEW WAVERLY, TX 77358

COMCAST PROPOSES TO INSTALL FIBER OPTIC CABLE
COMCAST PROPOSES TO PLACE DIRECTIONAL BORE 38' 48" FT TO INSTALL FIBER
OPTIC CABLE TO PROVIDE SERVICE NEAR TO 2594 I-45, NEW WAVERLY, TX 77358
INSIDE THE FOOT OF THE WALKER COUNTY, TX
TOTAL PROJECT FOOTAGE 28' 48"




comcast
HOUSTON, TEXAS 77040
8550 W. TIDWELL RD. HOUSTON, TEXAS 77040

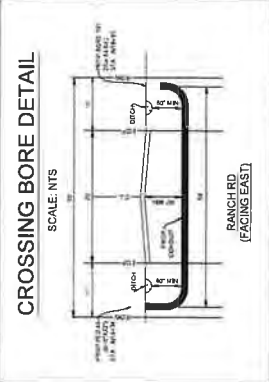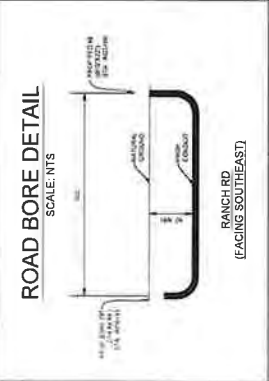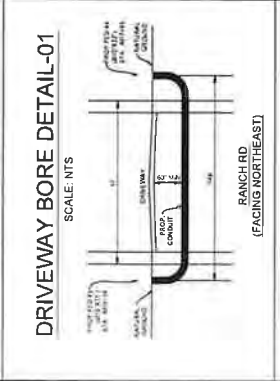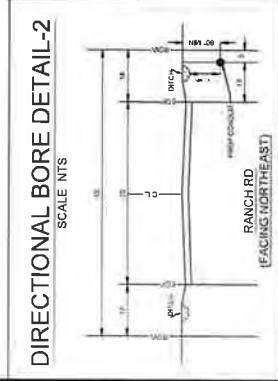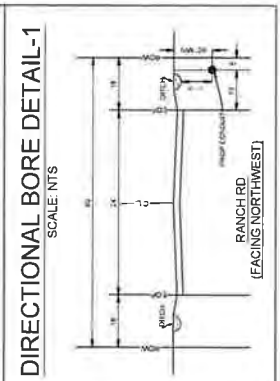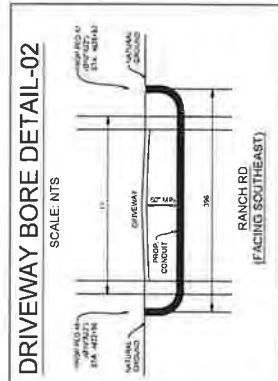

W HOUSTON, LLC
1550 W. TIDWELL RD. HOUSTON, TEXAS 77040

JB1771404 - 2594 I-45, NEW WAVERLY, TX 77358
PLAN VIEW 43 OF 60

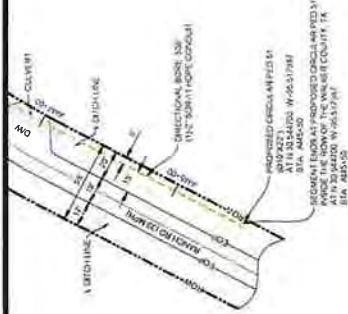


NOTES

- 1 THE WALKER COUNTY WILL BE NOTIFIED IN WRITING 48 HOURS PRIOR TO COMMENSING WORK
- 2 THE WALKER COUNTY UTILITIES DEPARTMENT AND PUBLIC WORKS DEPARTMENT WILL BE NOTIFIED FOR LINE LOCATES AT (936) 438-4339
- 3 THE CONTRACTOR SHALL CONTACT TEXAS ONE CALL SYSTEM AT 1-800-245-4545 MIN. 48 HOURS BEFORE DIGGING
- 4 THE CONTRACTOR SHALL DETERMINE THE EXACT LOCATION OF ALL UNDERGROUND FACILITIES BEFORE COMMENCING WORK AND AGREE TO BE FULLY RESPONSIBLE FOR ALL DAMAGES CAUSED BY HIS FAILURE TO EXACTLY LOCATE AND PRESERVE ALL UNDERGROUND FACILITIES
- 5 NO MORE TRENCH OPENED AT ONE TIME THAN CAN BE BACKFILLED AND COMPACTED IN 10' LIFTS AT THE END OF EACH DAY (NO TRENCH LEFT OPENED OVERNIGHT)
- 6 ALL EXCESS EXCAVATION TO BE REMOVED FROM THE ROAD RIGHT-OF-WAY AT THE END OF EACH DAY
- 7 DITCHES TO BE OPENED AT THE END OF EACH DAY TO ASSURE ADEQUATE DRAINAGE
- 8 ROAD MUST BE KEPT OPEN TO TRAFFIC AND CONTRACTOR MUST PROVIDE ADEQUATE FLAGMEN SIGNALS ETC. TO PROVIDE COMPLETE SAFETY TO THE PUBLIC
- 9 IF IT BECOMES NECESSARY FOR EQUIPMENT TO OPERATE ON A PORTION OF THE PAVEMENT, PRECAUTIONS MUST BE TAKEN TO PREVENT ANY DAMAGE WHATSOEVER TO THE PAVEMENT.
- 10 CONDITION OF ROAD UPON COMPLETION OF JOB SHALL BE AS GOOD OR BETTER THAN PRIOR TO STARTING
- 11 CONTRACTOR SHALL COMPLY WITH ALL APPLICABLE NATIONAL ELECTRICAL SAFETY CODE (NEC) REQUIREMENTS, CENTERPOINT ENERGY ELECTRIC POLE ATTACHMENT GUIDELINES & PROCEDURES AND ALL APPLICABLE LOCAL ORDINANCES. CONTRACTOR SHALL MAINTAIN PLACEMENT OF AERIAL CABLE FACILITIES 18\"/>
- 12 ALL UTILITIES WILL BE IDENTIFIED BY POT-HOLE BEFORE ANY CONSTRUCTION
- 13 COMCAST WILL MAINTAIN (2FT) HORIZONTAL & VERTICAL SEPARATION FROM ANY EXISTING UTILITIES
- 14 THE CONTRACTOR TO CONTACT WALKER COUNTY PRECINCT 4 AT LEAST 48 HOURS PRIOR TO CONSTRUCTION

DRIVEWAY BORE DETAIL

SCALE: NTS

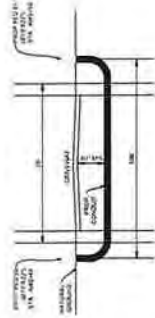

RANCH RD
(FACING SOUTHEAST)

DIRECTIONAL BORE DETAIL

SCALE: NTS



RANCH RD
(FACING SOUTHWEST)

Project: 1771404
The Aspen Utility Company, LLC
38502 Hempstead Hwy
Hockley, TX 77447
(817) 428-8300 (Fax)



JB1771404 - 2594 I-45, NEW WAVERLY, TX 77358

COMCAST PROPOSES TO INSTALL FIBER OPTIC CABLE
COMCAST PROPOSES TO PLACE DIRECTIONAL BORE 24.487 FT TO INSTALL FIBER OPTIC CABLE TO PROVIDE SERVICE NEAR TO 2594 I-45, NEW WAVERLY, TX 77358, INSIDE THE ROW OF THE WALKER COUNTY, TX
TOTAL PROJECT FOOTAGE: 34.897'




DESIGNED BY:
QUANTA TELECOM SERVICES

DWG. NO.
SHEET NO. 45 OF 77

DATE: 08/16/2025
APP'D: J. J. J. J.
PROJECT: 1771404
SCALE: 1\"/>



 JB1771404 - 2594 I-45, NEW WAVERLY, TX 77358
PLAN VIEW 44 OF 60



1. THE WALKER COUNTY WILL BE NOTIFIED IN WRITING 48 HOURS PRIOR TO COMMENCING WORK.
2. THE WALKER COUNTY UTILITIES DEPARTMENT AND PUBLIC WORKS DEPARTMENT WILL BE NOTIFIED FOR LINE LOCATES AT (936) 486-4899
3. THE CONTRACTOR SHALL CONTACT TEXAS ONE CALL SYSTEM AT 1-800-242-5455 MIN. 48 HOURS BEFORE DIGGING.
4. THE CONTRACTOR SHALL DETERMINE THE EXACT LOCATION OF ALL UNDERGROUND FACILITIES BEFORE COMMENCING WORK AND AGREE TO BE FULLY RESPONSIBLE FOR ALL DAMAGES CAUSED BY HIS FAILURE TO EXACTLY LOCATE AND PRESERVE ALL UNDERGROUND FACILITIES.
5. NO MORE TRENCH OPENED AT ONE TIME THAN CAN BE BACKFILLED AND RECLOSED WITHIN 24 HOURS OF THE END OF EACH DAY. (NO TRENCH LEFT OPEN OVERNIGHT).
6. ALL EXCESS EXCAVATION TO BE REMOVED FROM THE ROAD RIGHT-OF-WAY AT THE END OF EACH DAY.
7. DITCHES TO BE OPENED AT THE END OF EACH DAY TO ASSURE ADEQUATE DRAINAGE.
8. ROAD MUST BE KEPT OPEN TO TRAFFIC AND CONTRACTOR MUST PROVIDE ADEQUATE FLARE, SIGNALS, ETC., TO PROVIDE COMPLETE SAFETY TO THE PUBLIC.
9. IF IT BECOMES NECESSARY FOR EQUIPMENT TO OPERATE ON A PORTION OF THE PAVEMENT, PRECAUTIONS MUST BE TAKEN TO PREVENT ANY DAMAGE WHATSOEVER TO THE PAVEMENT.
10. CONDITION OF ROAD UPON COMPLETION OF JOB SHALL BE AS GOOD OR BETTER THAN PRIOR TO STARTING.
11. CONTRACTOR SHALL COMPLY WITH ALL APPLICABLE NATIONAL ELECTRICAL SAFETY CODE (NEC) REQUIREMENTS, CENTERPOINT ELECTRICAL SAFETY CODE REQUIREMENTS, TEXAS ELEC. CODES AND ALL APPLICABLE LOCAL REQUIREMENTS AND REGULATIONS FOR PLACEMENT OF AERIAL CABLE FACILITIES. 18" MIN. VERTICAL CLEARANCE.
12. ALL UTILITIES WILL BE IDENTIFIED BY POT HOLE BEFORE ANY CONSTRUCTION.
13. CONTRACT WILL MAINTAIN (5 FT.) HORIZONTAL & VERTICAL SEPARATION FROM ANY EXISTING UTILITIES.
14. THE CONTRACTOR TO CONTACT WALKER COUNTY PRECINCT 4 AT LEAST 48 HOURS PRIOR TO CONSTRUCTION.



comcast
a HOUSTON, LLC
1500 W. TIGWELL RD, HOUSTON, TEXAS 77040



COMCAST PROPOSES TO INSTALL FIBER OPTIC CABLE
COMCAST PROPOSES TO PLACE DIRECTIONAL BORE 28.487 FT TO INSTALL FIBER
OPTIC CABLE TO PROVIDE SERVICE NEAR TO 25M 145 NEW WAVELEY, TX 77358
INSIDE THE ROW OF THE WALKER COUNTY, TX
TOTAL PROJECT FOOTAGE 28.487

JB1771404 - 2594 I-45, NEW WAVERLY, TX 77350

6502 HEMPSTEAD HWY
HOCKLEY TX 77447

DESIGNED BY:
QUANTA TELECOM SERVICES

DWG. NO.
SHEET NO. 46 OF 77

LAMBERT: NA

DATE: 03/08/2007

DATE: 08/18/2025

KEY MAP NO 74Q
74R 75N 74V 75S 74M


74D 55W 74A, 75E



SCALE: 1 40

NOTES

1. THE WALKER COUNTY WILL BE NOTIFIED IN WRITING 48 HOURS PRIOR TO COMMENCING WORK.
2. THE WALKER COUNTY UTILITIES DEPARTMENT AND PUBLIC WORKS DEPARTMENT WILL BE NOTIFIED FOR LINE LOCATES AT (336) 456-4539.
3. THE CONTRACTOR SHALL CONTACT TEXAS ONE CALL SYSTEM AT 1-800-245-4545 MIN. 48 HOURS BEFORE DIGGING.
4. THE CONTRACTOR SHALL DETERMINE THE EXACT LOCATION OF ALL UNDERGROUND FACILITIES BEFORE COMMENCING WORK AND AGREE TO BE FULLY RESPONSIBLE FOR ALL DAMAGES CAUSED BY HIS FAILURE TO EXACTLY LOCATE AND PRESERVE ALL UNDERGROUND FACILITIES.
5. NO MORE TRENCH OPENED AT ONE TIME THAN CAN BE BACKFILLED AND COMPACTED IN 10' LIFTS AT THE END OF EACH DAY (NO TRENCH LEFT OPENED OVERNIGHT).
6. ALL EXCESS EXCAVATION TO BE REMOVED FROM THE ROAD RIGHT-OF-WAY AT THE END OF EACH DAY.
7. DITCHES TO BE OPENED AT THE END OF EACH DAY TO ASSURE ADEQUATE DRAINAGE.
8. ROAD MUST BE KEPT OPEN TO TRAFFIC AND CONTRACTOR MUST PROVIDE ADEQUATE FLAGMEN SIGNALS ETC. TO PROVIDE COMPLETE SAFETY TO THE PUBLIC.
9. IF IT BECOMES NECESSARY FOR EQUIPMENT TO OPERATE ON A PORTION OF THE PAVEMENT, PRECAUTIONS MUST BE TAKEN TO PREVENT ANY DAMAGE WHATSOEVER TO THE PAVEMENT.
10. CONDITION OF ROAD UPON COMPLETION OF JOB SHALL BE AS GOOD OR BETTER THAN PRIOR TO STARTING.
11. CONTRACTOR SHALL COMPLY WITH ALL APPLICABLE NATIONAL ELECTRICAL SAFETY CODE (NEC) REQUIREMENTS, CENTERPOINT ENERGY ELECTRIC POLE ATTACHMENT GUIDELINES & PROCEDURES AND ALL APPLICABLE LOCAL REQUIREMENTS AND REGULATIONS FOR THE INSTALLATION OF SIGNAL CABLE FACILITIES. 10' MIN. VERTICAL CLEARANCE.
12. ALL UTILITIES SHALL BE IDENTIFIED BY POT HOLE BEFORE ANY CONSTRUCTION.
13. COMCAST WILL MAINTAIN (2FT) HORIZONTAL & VERTICAL SEPARATION FROM ANY EXISTING UTILITIES.
14. THE CONTRACTOR TO CONTACT WALKER COUNTY PRECINCT 4 AT LEAST 48 HOURS PRIOR TO CONSTRUCTION.

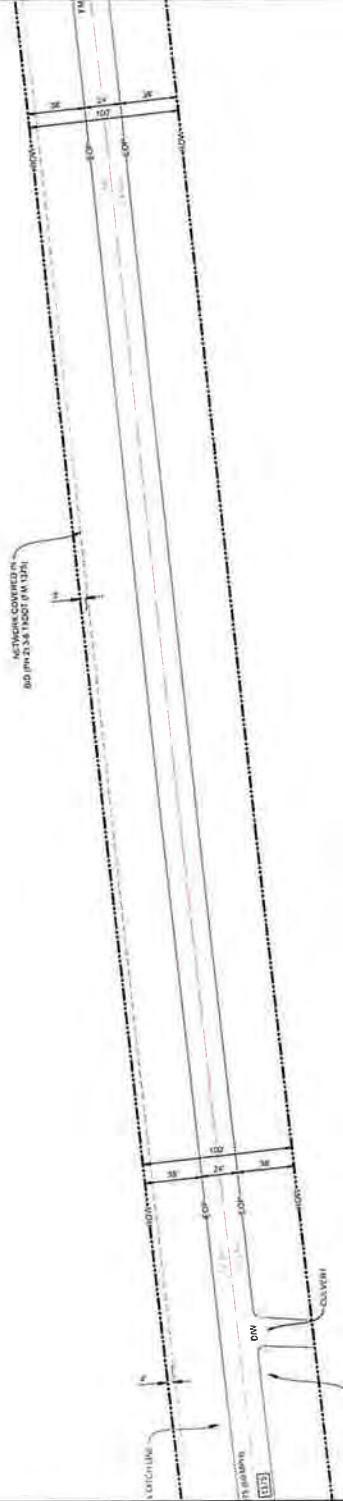

Robert B. Lundy, P.E.
The Aspen Utility Company, LLC
Suite No. 23238
10000 N. Loop West
Houston, TX 77047
A-1 PREC-450-2000



JB1771404 - 2594 I-45, NEW WAVERLY, TX 77358
PLAN VIEW 45 OF 60



COMCAST PROPOSES TO INSTALL FIBER OPTIC CABLE
COMCAST PROPOSES TO PLACE DIRECTIONAL BORE 21.407 FT TO INSTALL FIBER
OPTIC CABLE TO PROVIDE SERVICE NEAR TO 2594 I-45, NEW WAVERLY, TX 77358,
INSIDE THE ROW OF THE WALKER COUNTY, TX
TOTAL PROJECT FOOTAGE: 28.407

JB1771404 - 2594 I-45, NEW WAVERLY, TX 77358



DESIGNED BY:
QUANTA TELECOM SERVICES
DWG. NO.
SHEET NO. 47 OF 77


LAMBERT, NA
DATE: 08/18/2025
NOT MAP A.D. 142
NOT MAP A.D. 142
NOT MAP A.D. 142
SCALE: 1"=40'



RECEIVED


SEP 02 2025

BY:.....

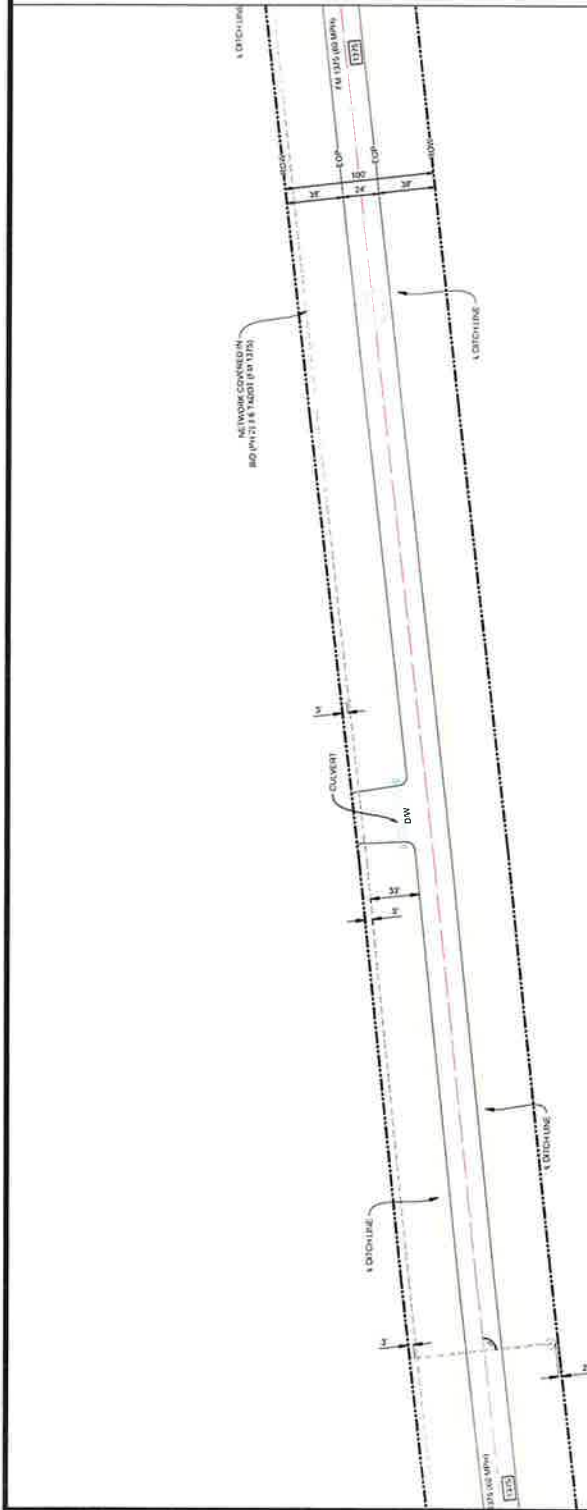

JB1771404 - 2594 I-45, NEW WAVERLY, TX 77358
PLAN VIEW 46 OF 60

 Client: J. L. L. Co.
Project: New Waverly, TX 77358
Drawing: JB1771404
Date: 8/27/2025



NOTES:

1. THE WALKER COUNTY WILL BE NOTIFIED IN WRITING 48 HOURS PRIOR TO COMMENCING WORK.
2. THE WALKER COUNTY UTILITIES DEPARTMENT AND PUBLIC WORKS DEPARTMENT WILL BE NOTIFIED FOR LINE LOCATES AT (259) 469-4933.
3. THE CONTRACTOR SHALL CONTACT TEXAS ONE CALL SYSTEM AT 1-800-368-5849 MIN. 48 HOURS BEFORE DIGGING.
4. THE CONTRACTOR SHALL DETERMINE THE EXACT LOCATION OF ALL UNDERGROUND FACILITIES BEFORE COMMENCING WORK AND AGREE TO EXISTING FACILITIES. THE CONTRACTOR SHALL BE RESPONSIBLE FOR EXACTLY LOCATE AND PRESERVE ALL UNDERGROUND FACILITIES.
5. NO MORE TRENCH OPENED AT ONE TIME THAN CAN BE BACKFILLED AND OPENED OVERNIGHT.
6. ALL EXPOSED EXCAVATION TO BE REMOVED FROM THE ROAD RIGHT-OF-WAY AT THE END OF EACH DAY.
7. DITCHES TO BE OPENED AT THE END OF EACH DAY TO ASSURE ADEQUATE DRAINAGE.
8. ROAD MUST BE KEPT OPEN TO TRAFFIC AND CONTRACTOR MUST PROVIDE ADEQUATE FLAGMEN, SIGNALS, ETC., TO PROVIDE COMPLETE SAFETY TO THE PUBLIC.
9. IF IT BECOMES NECESSARY FOR EQUIPMENT TO OPERATE ON A PORTION OF THE ROAD, THE CONTRACTOR SHALL BE TAKEN TO PREVENT ANY DAMAGE WHATSOEVER TO THE FACILITY.
10. CONDITION OF ROAD UPON COMPLETION OF JOB SHALL BE AS GOOD OR BETTER THAN PRIOR TO STARTING.
11. CONTRACTOR SHALL COMPLY WITH ALL APPLICABLE NATIONAL ELECTRICAL SAFETY CODE (NEC) REQUIREMENTS, CENTERPOINT ENERGY, AND ALL APPLICABLE LOCAL REQUIREMENTS AND REGULATIONS FOR PLACEMENT OF AERIAL CABLE FACILITIES. 18\"/>
12. ALL UTILITIES WILL BE IDENTIFIED BY POTHOLE BEFORE ANY CONSTRUCTION.
13. COMCAST WILL MAINTAIN (2FT) HORIZONTAL & VERTICAL SEPARATION FROM ANY EXISTING UTILITIES.
14. THE CONTRACTOR TO CONTACT WALKER COUNTY PRECINCT 4 AT LEAST 48 HOURS PRIOR TO CONSTRUCTION.



JB1771404 - 2594 I-45, NEW WAVERLY, TX 77358


COMCAST PROPOSES TO INSTALL FIBER OPTIC CABLE
COMCAST PROPOSES TO PLACE DIRECTIONAL BORE 28.487 FT TO INSTALL FIBER OPTIC CABLE TO INSIDE THE ROW OF THE WALKER COUNTY, TX.
TOTAL PROJECT FOOTAGE 28.487



DESIGNED BY:
QUANTA TELECOM SERVICES

DWG. NO.
SHEET NO. 48 OF 77

DATE: 08/19/2025
BY: J. L. L. Co.
PROJECT: NEW WAVERLY, TX 77358
SCALE: 1\"/>

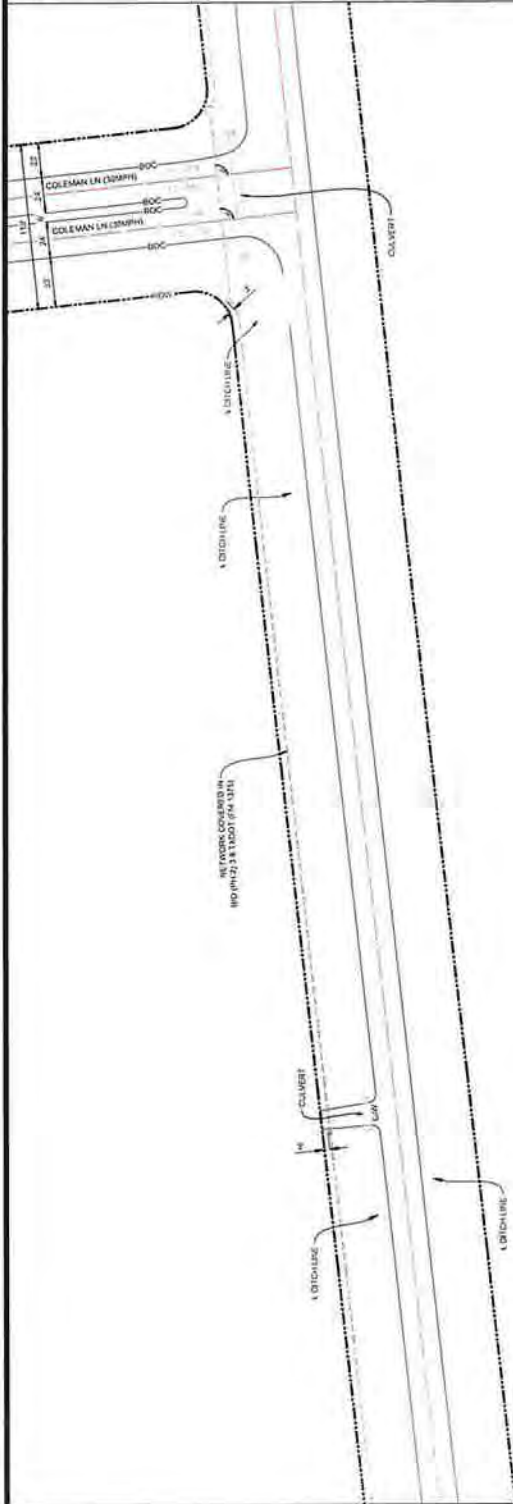

NOTES

- 1 THE WALKER COUNTY WILL BE NOTIFIED IN WRITING 48 HOURS PRIOR TO COMMENCING WORK.
- 2 THE WALKER COUNTY UTILITIES DEPARTMENT AND PUBLIC WORKS DEPARTMENT WILL BE NOTIFIED FOR LINE LOCATES AT (806) 436-4829
- 3 THE CONTRACTOR SHALL CONTACT TEXAS ONE CALL SYSTEM AT 1-800-333-4545 MIN. 48 HOURS BEFORE BEGINNING
- 4 THE CONTRACTOR SHALL DETERMINE THE EXACT LOCATION OF ALL UTILITIES TO BE EXCAVATED. THE CONTRACTOR SHALL BE RESPONSIBLE FOR ALL DAMAGES CAUSED BY HIS FAILURE TO EXACTLY LOCATE AND PRESERVE ALL UNDERGROUND FACILITIES
- 5 NO WORK BEGUN UNTIL THE CONTRACTOR HAS BEEN INSTRUCTED BY THE WALKER COUNTY ENGINEER THAT THE EXCAVATION CAN BE OPENED OVERNIGHT.
- 6 ALL EXCESS EXCAVATION TO BE REMOVED FROM THE ROAD RIGHT-OF-WAY AT THE END OF EACH DAY
- 7 DITCHES TO BE OPENED AT THE END OF EACH DAY TO ASSURE ADEQUATE DRAINAGE
- 8 ROAD MUST BE KEPT OPEN TO TRAFFIC AND CONTRACTOR MUST PROVIDE ADEQUATE FLUORESCENT SIGNALS, ETC., TO PROVIDE COMPLETE SAFETY TO THE PUBLIC
- 9 IF IT BECOMES NECESSARY FOR EQUIPMENT TO OPERATE ON A PORTION OF THE PAVEMENT, PRECAUTIONS MUST BE TAKEN TO PREVENT ANY DAMAGE WHATSOEVER TO THE PAVEMENT
- 10 CONTRACTOR SHALL COMPLY WITH ALL APPLICABLE NATIONAL ELECTRICAL, SAFETY CODE & SPECIFICATIONS, CENTERPOINT ENERGY ELECTRIC POLE ATTACHMENT GUIDELINES & PROCEDURES AND ALL OTHER REQUIREMENTS OF THE UTILITY INDUSTRY WORK PRACTICE STANDARDS. ALL CABLES SHALL BE PLACED IN 18" MIN. VERTICAL CLEARANCE
- 11 ALL UTILITIES WILL BE IDENTIFIED BY POTHOLE BEFORE ANY CONSTRUCTION
- 12 CONCRETE SHALL MAINTAIN (LEFT) HORIZONTAL & VERTICAL SEPARATION FROM ANY EXISTING UTILITIES
- 13 THE CONTRACTOR TO CONTACT WALKER COUNTY PRECINCT 4 AT LEAST 48 HOURS PRIOR TO CONSTRUCTION

The Aspen Utility Company LLC
 Firm No. 23336
 36502 Hempstead Highway 4
 Hickory, NC 77447
 704-423-3639



JB1771404 - 2594 I-45, NEW WAVERLY, TX 77358
PLAN VIEW 47 OF 60

PLAN VIEW 47 OF 60

ASPEN
36502 HEMPSTEAD HWY.
HOCKLEY TX 77447

JB1771404 - 2594 I-45, NEW WAVERLY, TX 77358

CONCAST PROPOSES TO INSTALL FIBER OPTIC CABLE

CONCAST PROPOSES TO PLACE DIRECTIONAL BORE 28.487 FT TO INSTALL FIBER OPTIC CABLE TO PROVIDE SERVICE NEAR TO 25541-145, NEW WAVELEY, TX 77358 INSIDE THE ROW OF THE WALKER COUNTY, TX.

TOTAL PROJECT FOOTAGE: 28.487

TOTAL PROJECT FOOTAGE: 28,487'




comcast
BY HOUSTON LLC
3900 W. TIDWELL RD. HOUSTON, TEXAS 77040

DESIGNED BY:
QUANTA TELECOM SERVICES

DWG. NO.
SHEET NO. 49 OF 77



RECEIVED
SEP 02 2025
BY:

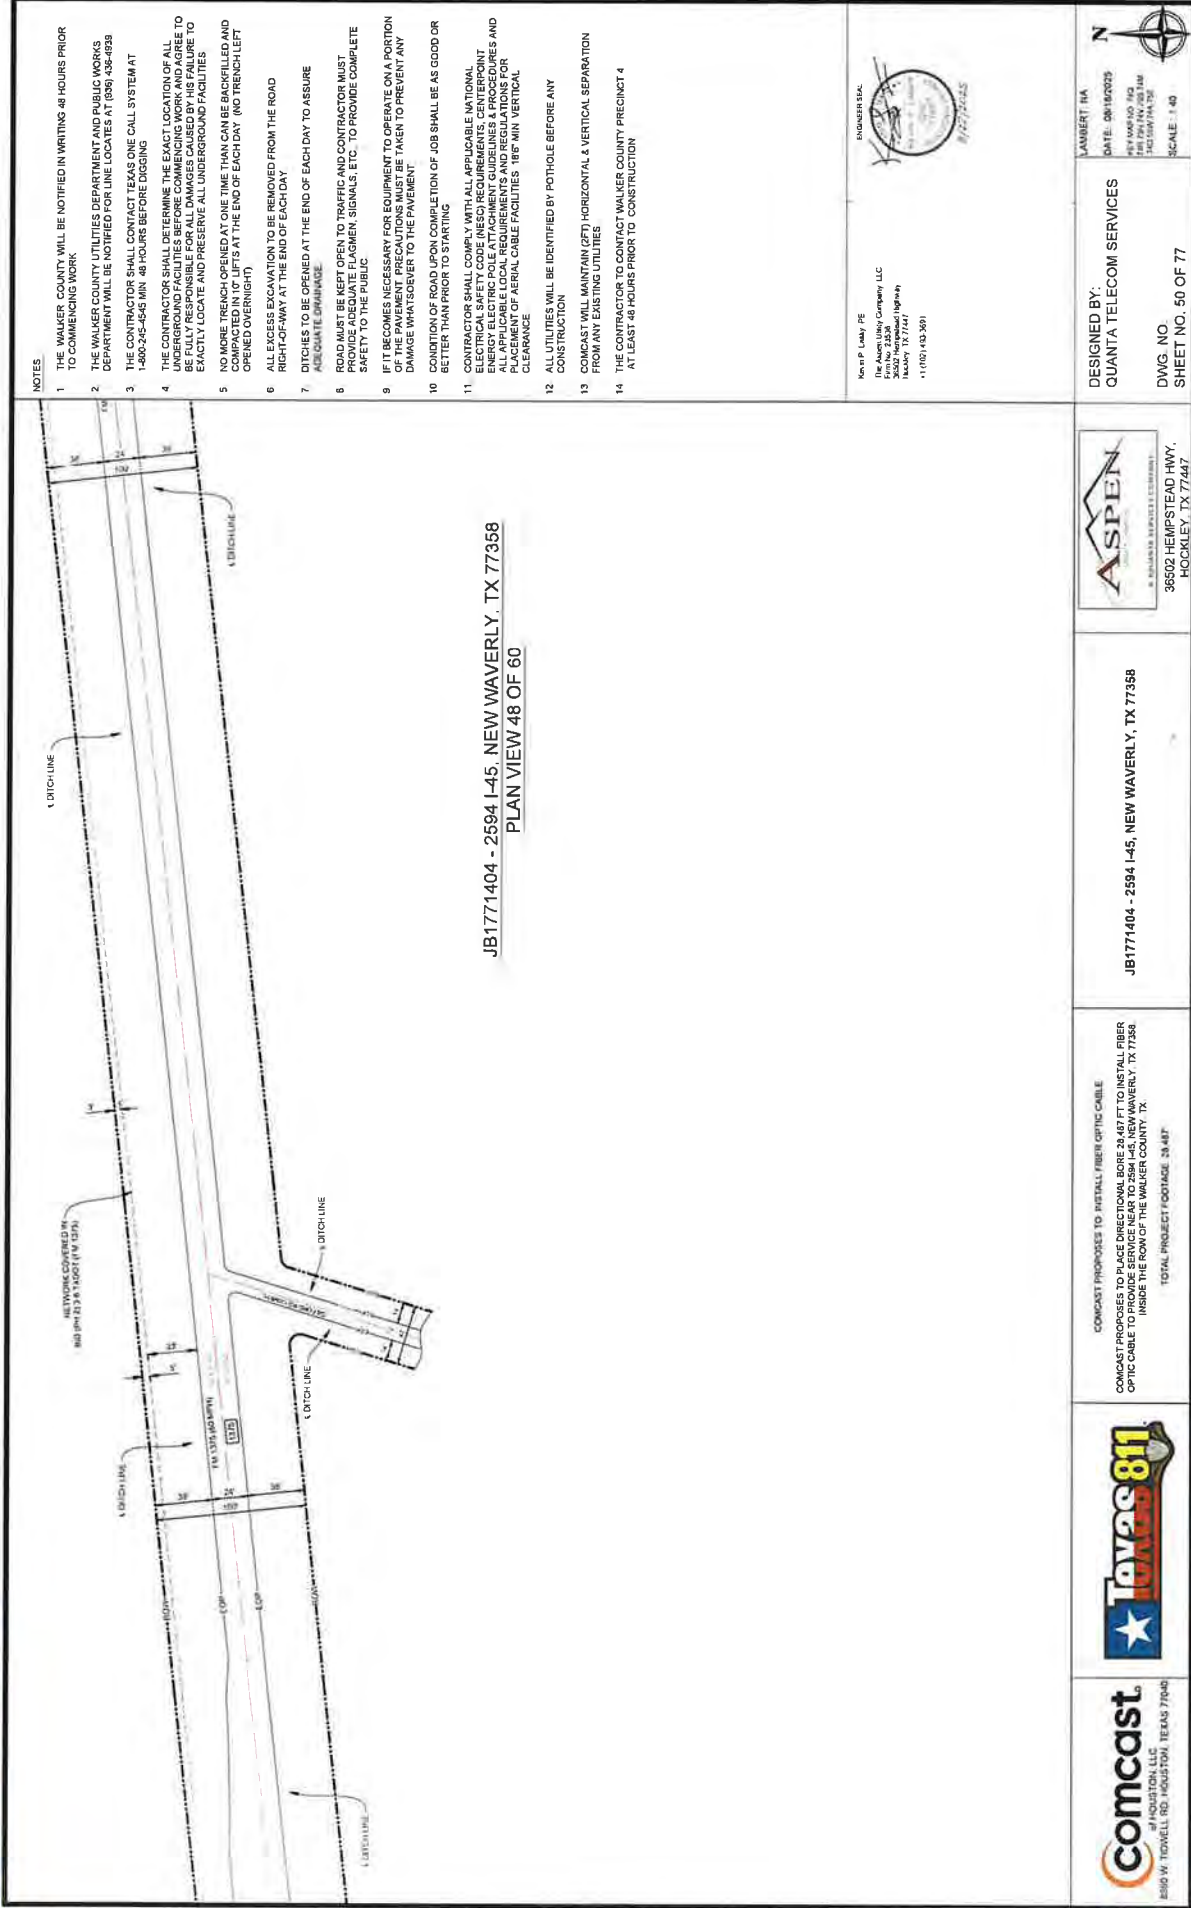

[illegible]

I. THE WALKER COUNTY WILL BE NOTIFIED IN WRITING 48 HOURS PRIOR TO COMMENCING WORK.

2. THE WALERTON COUNTY UTILITIES DEPARTMENT AND PUBLIC WORKS DEPARTMENT WILL BE NOTIFIED FOR LINE LOCATES AT (336) 438-4339
3. THE CONTRACTOR SHALL CONTACT TEXAS ONE CALL SYSTEM AT 1-800-525-5251 MIN. 48 HOURS BEFORE DIGGING.
4. THE CONTRACTOR SHALL DETERMINE THE EXACT LOCATION OF ALL UNDERGROUND FACILITIES BEFORE COMMENCING WORK AND AGREE TO EXCAVATE AND PRESERVE ALL UNDERGROUND FACILITIES TO EXACTLY LOCATE AND PRESERVE ALL UNDERGROUND FACILITIES
5. NO MORE THAN ONE (1) INCH OF DIRT TO BE BACKFILLED ANY DEPTH AT THE END OF EACH DAY. (NO TRENCH LEFT OPENED OVERNIGHT).
6. ALL EXCESS EXCAVATION TO BE REMOVED FROM THE ROAD RIGHT-OF-WAY AT THE END OF EACH DAY.
7. DITCHES TO BE OPENED AT THE END OF EACH DAY TO ASSURE ADEQUATE DRAINAGE
8. ROADWAYS MUST BE KEPT OPEN TO TRAFFIC AND CONTRACTOR MUST PROVIDE ADEQUATE FLAGMEN SIGNALS ETC. TO PROVIDE COMPLETE SAFETY TO THE PUBLIC
9. IF IT BECOMES NECESSARY FOR EQUIPMENT TO OPERATE ON A PORTION OF THE PAVEMENT, PRECAUTIONS MUST BE TAKEN TO PREVENT ANY DAMAGE TO/WEAR TO THE PAVEMENT.
10. CONDITION OF ROAD UPON COMPLETION OF JOB SHALL BE AS GOOD OR BETTER THAN PRIOR TO STARTING
11. CONTRACTOR SHALL COMPLY WITH ALL APPLICABLE NATIONAL ELECTRICAL SAFETY CODES, NECO REQUIREMENTS, CONTEMPORARY ELECTRICAL PRACTICES, AND ALL APPLICABLE NATIONAL ELECTRICAL PRACTICES, AND ALL APPLICABLE LOCAL REQUIREMENTS AND REGULATIONS FOR PLACEMENT OF AERIAL CABLE FACILITIES 18" MIN VERTICAL CLEARANCE
12. ALL UTILITIES WILL BE IDENTIFIED BY POT HOLE BEFORE ANY CONSTRUCTION
13. COWCAST WILL MAINTAIN (2FT) HORIZONTAL & VERTICAL SEPARATION FROM ANY EXISTING UTILITIES.
14. THE CONTRACTOR TO CONTACT WALERTON COUNTY PRECINCT 4 AT LEAST 48 HOURS PRIOR TO CONSTRUCTION

The Associated Press Company LLC
Firm No. 21336
36502 Harpwood Highway
Houston TX 77441
5127074493, 3691



ASPEN

JB1771404 - 2594 I-45, NEW WAVERLY, TX 77358

COMCAST PROPOSES TO PLACE DIRECTIONAL BORE 28.487 FT TO INSTALL FIBER OPTIC CABLE TO PROVIDE SERVICE NEAR TO 2594 I-45, NEW WAVERLY, TX 77358 INSIDE THE ROW OF THE WALKER COUNTY, TX.




DESIGNED BY:
QUANTA TELECOM SERVICES

DWG. NO.
SHEET NO. 51 OF 77



RECEIVED
SEP 02 2025
BY:

JB1771404 - 2594 I-45, NEW WAVERLY, TX 77358
PLAN VIEW 50 OF 60

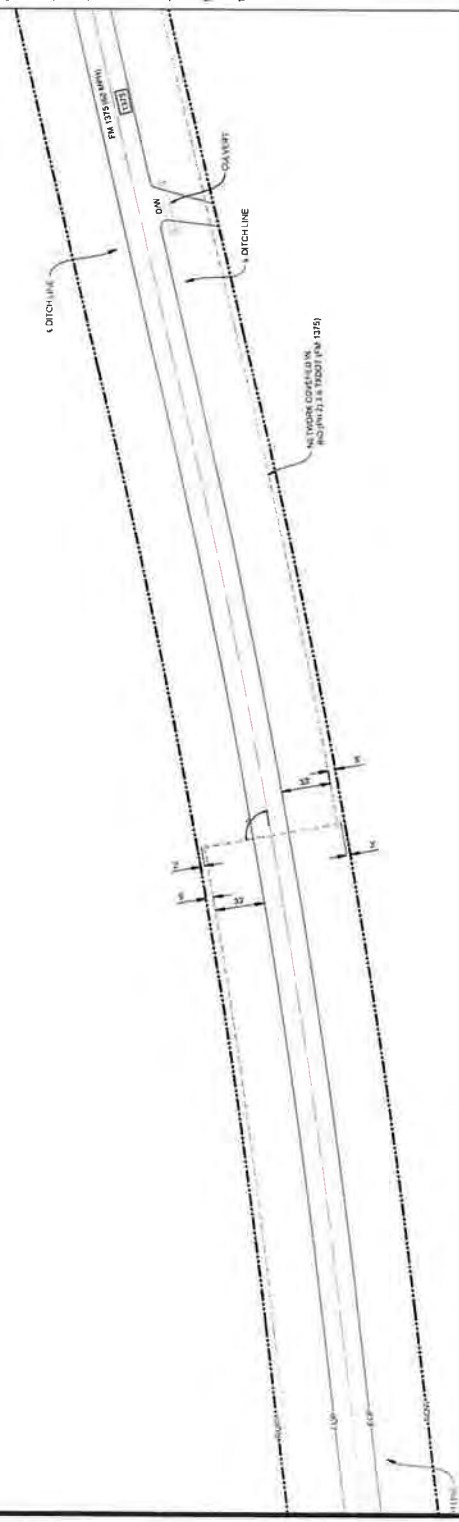

NOTES

1. THE WALKER COUNTY WILL BE NOTIFIED IN WRITING 48 HOURS PRIOR TO COMMENCING WORK.
2. THE WALKER COUNTY UTILITIES DEPARTMENT AND PUBLIC WORKS DEPARTMENT WILL BE NOTIFIED FOR LINE LOCATES AT (336) 456-4999
3. THE CONTRACTOR SHALL CONTACT TEXAS ONE CALL SYSTEM AT 1-800-245-4545 MIN. 48 HOURS BEFORE DIGGING
4. THE CONTRACTOR SHALL DETERMINE THE EXACT LOCATION OF ALL UNDERGROUND FACILITIES BEFORE COMMENCING WORK AND AGREE TO BE FULLY RESPONSIBLE FOR ALL DAMAGES CAUSED BY HIS FAILURE TO EXACTLY LOCATE AND PRESERVE ALL UNDERGROUND FACILITIES
5. NO MORE TRENCH OPENED AT ONE TIME THAN CAN BE BACKFILLED AND COMPACTED IN 10' LIFTS AT THE END OF EACH DAY (NO TRENCH LEFT OPENED OVERNIGHT)
6. ALL EXCESS EXCAVATION TO BE REMOVED FROM THE ROAD RIGHT-OF-WAY AT THE END OF EACH DAY
7. DITCHES TO BE OPENED AT THE END OF EACH DAY TO ASSURE ADEQUATE DRAINAGE
8. ROAD MUST BE KEPT OPEN TO TRAFFIC AND CONTRACTOR MUST PROVIDE ADEQUATE FLAGMEN, SIGNALS, ETC. TO PROVIDE COMPLETE SAFETY TO THE PUBLIC
9. IF IT BECOMES NECESSARY FOR EQUIPMENT TO OPERATE ON A PORTION OF THE PAVEMENT, PRECAUTIONS MUST BE TAKEN TO PREVENT ANY DAMAGE WHATSOEVER TO THE PAVEMENT
10. CONDITION OF ROAD UPON COMPLETION OF JOB SHALL BE AS GOOD OR BETTER THAN PRIOR TO STARTING
11. CONTRACTOR SHALL COMPLY WITH ALL APPLICABLE NATIONAL ELECTRICAL SAFETY CODE (NEC) REQUIREMENTS, CENTERPOINT ENERGY ELECTRIC POLE ATTACHMENT GUIDELINES & PROCEDURES AND ALL OTHER REQUIREMENTS AND PROCEDURES FOR THE PROTECTION OF PLACEMENT OF AERIAL CABLE FACILITIES. 18" MIN. VERTICAL CLEARANCE
12. ALL UTILITIES WILL BE IDENTIFIED BY POT-HOLE BEFORE ANY CONSTRUCTION
13. COMCAST SHALL MAINTAIN A 5 FT. HORIZONTAL & VERTICAL SEPARATION FROM ANY EXISTING UTILITIES
14. THE CONTRACTOR TO CONTACT WALKER COUNTY PRECINCT 4 AT LEAST 48 HOURS PRIOR TO CONSTRUCTION



DESIGNED BY:
QUANTA TELECOM SERVICES

DATE: 08/16/2025
AUT: JBL/PAK/PAK
JBL/PAK/PAK/PAK
JBL/PAK/PAK/PAK

SCALE: 1"=40'

DWG. NO. 36502 HEMPSTEAD HWY.
SHEET NO. 52 OF 77



JB1771404 - 2594 I-45, NEW WAVERLY, TX 77358

COMCAST PROPOSES TO INSTALL FIBER OPTIC CABLE
COMCAST PROPOSES TO PLACE DIRECTIONAL BORE 28.487 FT TO INSTALL FIBER OPTIC CABLE TO PROVIDE SERVICE NEAR TO 2594 I-45, NEW WAVERLY, TX 77358, INSIDE THE RIGHT OF THE WALKER COUNTY, TX.
TOTAL PROJECT FOOTAGE 28.487




Comcast
HOUSTON, LLC
4550 W. TOWNELL RD. HOUSTON, TEXAS 77040

JB1771404 - 2594 I-45, NEW WAVERLY, TX 77358
 PLAN VIEW 51 OF 60

NOTES

1. THE WALKER COUNTY SHALL BE NOTIFIED IN WRITING 48 HOURS PRIOR TO COMMENCING WORK.
2. THE WALKER COUNTY UTILITIES DEPARTMENT AND PUBLIC WORKS DEPARTMENT WILL BE NOTIFIED FOR LINE LOCATES AT (361) 436-4899
3. THE CONTRACTOR SHALL CONTACT TEXAS ONE CALL SYSTEM AT 1-800-245-4545 MIN. 48 HOURS BEFORE DIGGING.
4. THE CONTRACTOR SHALL DETERMINE THE EXACT LOCATION OF ALL UNDERGROUND FACILITIES BEFORE COMMENCING WORK AND AGREE TO BE FULLY RESPONSIBLE FOR ALL DAMAGES CAUSED BY HIS FAILURE TO EXACTLY LOCATE AND PRESERVE ALL UNDERGROUND FACILITIES.
5. NO MORE TRENCH OPENED AT ONE TIME THAN CAN BE BACKFILLED AND COMPACTED IN 10' LIFTS AT THE END OF EACH DAY. (NO TRENCH LEFT OPENED OVERNIGHT).
6. ALL EXCESS EXCAVATION TO BE REMOVED FROM THE ROAD RIGHT-OF-WAY AT THE END OF EACH DAY.
7. DITCHES TO BE OPENED AT THE END OF EACH DAY TO ASSURE ADEQUATE DRAINAGE.
8. ROAD MUST BE KEPT OPEN TO TRAFFIC AND CONTRACTOR MUST PROVIDE ADEQUATE FLAGMEN, SIGNALS, ETC., TO PROVIDE COMPLETE SAFETY TO THE PUBLIC.
9. IF IT BECOMES NECESSARY FOR EQUIPMENT TO OPERATE ON A PORTION OF THE PAVEMENT, PRECAUTIONS MUST BE TAKEN TO PREVENT ANY DAMAGE WHATSOEVER TO THE PAVEMENT.
10. COMPLETION OF ROAD UPON COMPLETION OF JOB SHALL BE AS GOOD OR BETTER THAN PRIOR TO STARTING.
11. CONTRACTOR SHALL COMPLY WITH ALL APPLICABLE NATIONAL ELECTRICAL SAFETY CODE (NEC) REQUIREMENTS, CENTERPOINT ENERGY ELECTRIC POLE ATTACHMENT GUIDELINES & PROCEDURES AND ALL APPLICABLE LOCAL ORDINANCES AND REGULATIONS FOR THE PLACEMENT OF AERIAL CABLE FACILITIES. 18' MIN. VERTICAL CLEARANCE.
12. ALL UTILITIES WILL BE IDENTIFIED BY POT HOLE BEFORE ANY CONSTRUCTION.
13. CONTRACTOR WILL MAINTAIN (GFD) HORIZONTAL & VERTICAL SEPARATION FROM ANY EXISTING UTILITIES.
14. THE CONTRACTOR TO CONTACT WALKER COUNTY PRECINCT 4 AT LEAST 48 HOURS PRIOR TO CONSTRUCTION.

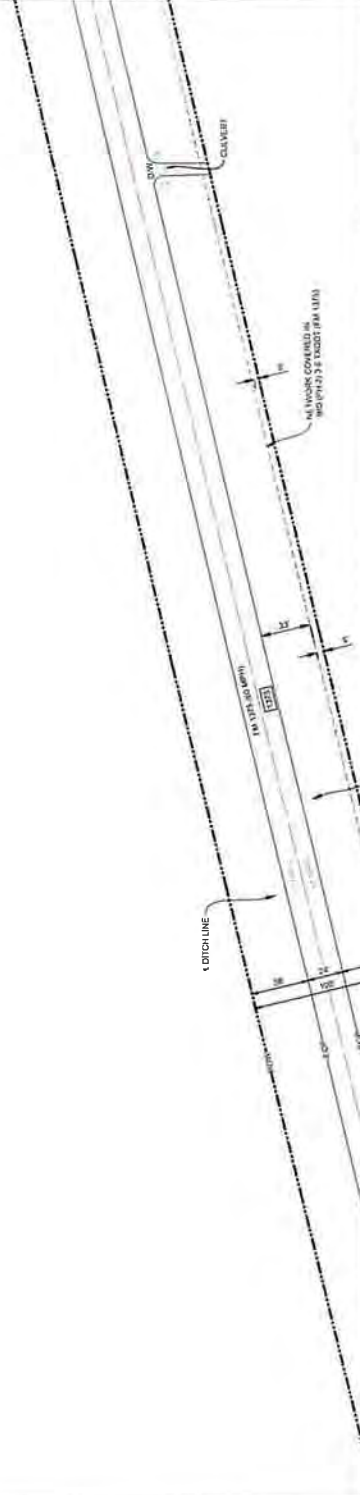

THE ASPEN GROUP, INC.
 2002 Hempstead Highway
 Houston, TX 77047
 (281) 419-2361



DESIGNED BY:
 QUANTA TELECOM SERVICES

LAMBERT, WA
 DATE: 08/19/2025
 KEY MAP NO. 143
 740 SANTA FE
 SCALE: 1:40

JB1771404 - 2594 I-45, NEW WAVERLY, TX 77358

CONCAST PROPOSES TO INSTALL FIBER OPTIC CABLE
 CONCAST PROPOSES TO PLACE DIRECTIONAL BORE 24-48" FT TO INSTALL FIBER
 OPTIC CABLE TO PROVIDE SERVICE NEAR TO 2594 I-45, NEW WAVERLY, TX 77358,
 INSIDE THE ROW OF THE WALKER COUNTY, TX
 TOTAL PROJECT FOOTAGE: 28.48'




38502 HEMPSTEAD HWY
 HOUSTON, TX 77047

8250 W. TIDWELL RD. HOUSTON, TEXAS 77040

RECEIVED
SEP 02 2025
BY:

DIRECTIONAL BORE DETAIL

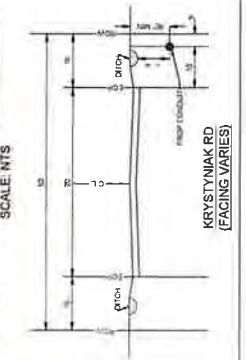

JB1771404 - 2594 I-45, NEW WAVERLY, TX 77358
PLAN VIEW 52 OF 60

- NOTES
1. THE WALKER COUNTY WILL BE NOTIFIED IN WRITING 48 HOURS PRIOR TO COMMENCING WORK.
 2. THE WALKER COUNTY UTILITIES DEPARTMENT AND PUBLIC WORKS DEPARTMENT WILL BE NOTIFIED FOR LINE LOCATES AT (336) 436-8839
 3. THE CONTRACTOR SHALL CONTACT TEXAS ONE CALL SYSTEM AT 1-800-455-5545 MIN. 48 HOURS BEFORE DIGGING.
 4. THE CONTRACTOR SHALL DETERMINE THE EXACT LOCATION OF ALL UNDERGROUND FACILITIES BEFORE COMMENCING WORK AND AGREE TO BE RESPONSIBLE FOR ALL DAMAGES CAUSED BY HIS FAILURE TO EXACTLY LOCATE AND PRESERVE ALL UNDERGROUND FACILITIES.
 5. NO MORE TRENCH OPENED AT ONE TIME THAN CAN BE BACKFILLED AND COVERED WITHIN 24 HOURS OF THE END OF EACH DAY. (NO TRENCH LEFT OPENED OVERNIGHT)
 6. ALL EXCESS EXCAVATION TO BE REMOVED FROM THE ROAD RIGHT-OF-WAY AT THE END OF EACH DAY.
 7. DITCHES TO BE OPENED AT THE END OF EACH DAY TO ASSURE ADEQUATE DRAINAGE.
 8. ROAD MUST BE KEPT OPEN TO TRAFFIC AND CONTRACTOR MUST PROVIDE ADEQUATE FLAGMEN, SIGNALS, ETC. TO PROVIDE COMPLETE SAFETY TO THE PUBLIC.
 9. IF IT BECOMES NECESSARY FOR EQUIPMENT TO OPERATE ON A PORTION OF THE PAVEMENT, PRECAUTIONS MUST BE TAKEN TO PREVENT ANY DAMAGE WHATSOEVER TO THE PAVEMENT.
 10. CONDITION OF ROAD UPON COMPLETION OF JOB SHALL BE AS GOOD OR BETTER THAN PRIOR TO STARTING.
 11. CONTRACTOR SHALL COMPLY WITH ALL APPLICABLE NATIONAL ELECTRICAL SAFETY CODE (NEC) REQUIREMENTS, CENTERPOINT UTILITY REQUIREMENTS, TEXAS PUBLIC UTILITY REGULATORY COMMISSION (TPURC) REQUIREMENTS, AND ALL APPLICABLE LOCAL REQUIREMENTS AND REGULATIONS FOR PLACEMENT OF AERIAL CABLE FACILITIES. 18" MIN. VERTICAL CLEARANCE.
 12. ALL UTILITIES WILL BE IDENTIFIED BY POT HOLE BEFORE ANY CONSTRUCTION.
 13. COMCAST WILL MAINTAIN 2FT HORIZONTAL & VERTICAL SEPARATION FROM ANY EXISTING UTILITIES.
 14. THE CONTRACTOR TO CONTACT WALKER COUNTY PRECINCT 4 AT LEAST 48 HOURS PRIOR TO CONSTRUCTION.



DESIGNED BY:
QUANTA TELECOM SERVICES

DWG. NO.
SHEET NO. 54 OF 77

DATE: 08/19/2025
APPROVED BY:
JANET VA
SCALE: 1"=40'




JB1771404 - 2594 I-45, NEW WAVERLY, TX 77358

COMCAST PROPOSES TO INSTALL FIBER OPTIC CABLE
COMCAST PROPOSES TO PLACE DIRECTIONAL BORE 28.48 FT TO INSTALL FIBER OPTIC CABLE TO INSIDE THE ROW OF THE WALKER COUNTY, TX

TOTAL PROJECT FOOTAGE: 28.48 FT



JB1771404 - 2594 I-45, NEW WAVERLY, TX 77358
PLAN VIEW 53 OF 60

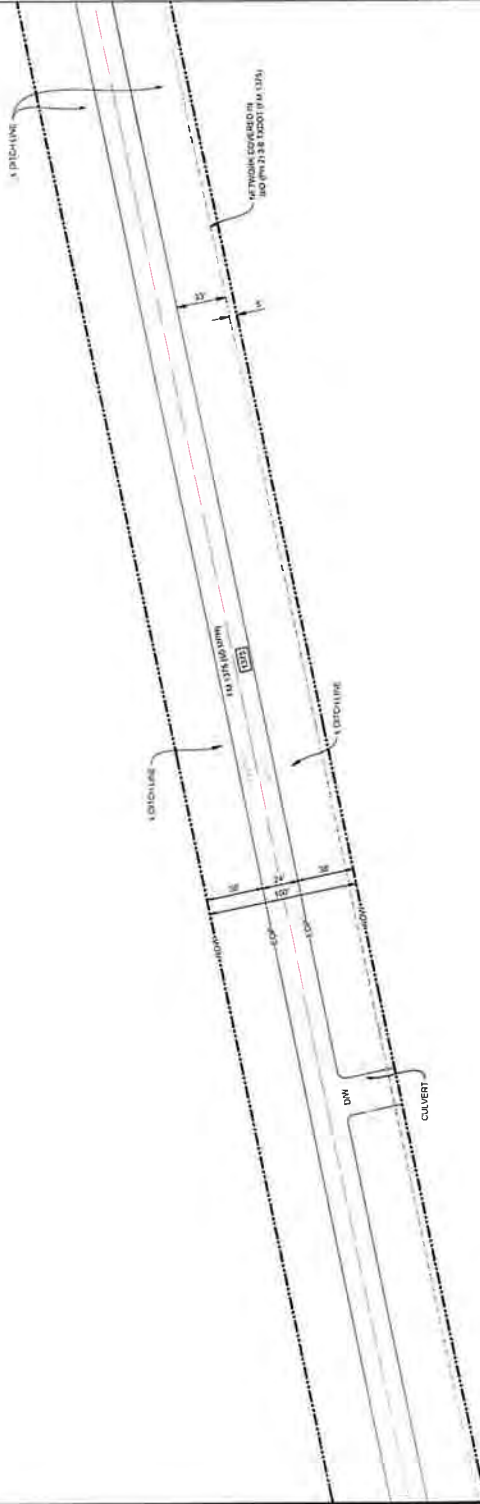

NOTES

1. THE WALKER COUNTY WILL BE NOTIFIED IN WRITING 48 HOURS PRIOR TO COMMENCING WORK.
2. THE WALKER COUNTY UTILITIES DEPARTMENT AND PUBLIC WORKS DEPARTMENT WILL BE NOTIFIED FOR LINE LOCATES AT 0900 436-4393.
3. THE CONTRACTOR SHALL CONTACT TEXAS ONE CALL SYSTEM AT 1-800-245-4545 MIN. 48 HOURS BEFORE DIGGING.
4. THE CONTRACTOR SHALL DETERMINE THE EXACT LOCATION OF ALL UNDERGROUND FACILITIES BEFORE COMMENCING WORK AND AGREE TO BE FULLY RESPONSIBLE FOR ALL DAMAGES CAUSED BY HIS FAILURE TO EXACTLY LOCATE AND PRESERVE ALL UNDERGROUND FACILITIES.
5. NO MORE TRENCH OPENED AT ONE TIME THAN CAN BE BACKFILLED AND COMPACTED IN 10' LIFTS AT THE END OF EACH DAY (NO TRENCH LEFT OPENED OVERNIGHT).
6. ALL EXCESS EXCAVATION TO BE REMOVED FROM THE ROAD RIGHT-OF-WAY AT THE END OF EACH DAY.
7. DITCHES TO BE OPENED AT THE END OF EACH DAY TO ASSURE ADEQUATE DRAINAGE.
8. ROAD MUST BE KEPT OPEN TO TRAFFIC AND CONTRACTOR MUST PROVIDE ADEQUATE FLAGMEN, SIGNALS, ETC. TO PROVIDE COMPLETE SAFETY TO THE PUBLIC.
9. IF IT BECOMES NECESSARY FOR EQUIPMENT TO OPERATE ON A PORTION OF THE PAVEMENT PRECAUTIONS MUST BE TAKEN TO PREVENT ANY DAMAGE WHATSOEVER TO THE PAVEMENT.
10. CONDITION OF ROAD UPON COMPLETION OF JOB SHALL BE AS GOOD OR BETTER THAN PRIOR TO STARTING.
11. CONTRACTOR SHALL COMPLY WITH ALL APPLICABLE NATIONAL ELECTRICAL SAFETY CODE (NEC) REQUIREMENTS, CENTERPOINT ENERGY ELECTRIC POLE ATTACHMENT GUIDELINES & PROCEDURES AND ALL OTHER REQUIREMENTS FOR THE PROTECTION OF EXISTING UTILITIES AND PLACEMENT OF ASHRAE CABLE FACILITIES. 18\"/>
- 12. ALL UTILITIES WILL BE IDENTIFIED BY POT HOLE BEFORE ANY CONSTRUCTION.
- 13. COMCAST WILL MAINTAIN 8\"/>
- 14. THE CONTRACTOR TO CONTACT WALKER COUNTY PRECINCT 4 AT LEAST 48 HOURS PRIOR TO CONSTRUCTION.

Project # 1771404 (P)
The Aspen Utility Company, LLC
36502 Hempstead Hwy.
Hockley, TX 77447
(713) 432-5961



JB1771404 - 2594 I-45, NEW WAVERLY, TX 77358

COMCAST PROPOSES TO INSTALL FIBER OPTIC CABLE
COMCAST PROPOSES TO PLACE DIRECTIONAL BORE 26.487 FT TO INSTALL FIBER OPTIC CABLE TO PROVIDE SERVICE NEAR TO 2594 I-45, NEW WAVERLY, TX 77358, INSIDE THE ROW OF THE WALKER COUNTY, TX.
TOTAL PROJECT FOOTAGE 26.487



DESIGNED BY:
QUANTA TELECOM SERVICES
DWG NO.
SHEET NO. 55 OF 77

LAMBERT: N/A
DATE: 06/18/2025
AS MAPED 343
FOR 500' X 10' MIN
FOR 500' X 10' MIN
SCALE: 1"=40'




BY:


LAMBERT: NA
 DATE: 06/18/2025
 KEY MAP TO: INJ
 C&P: 70074V 755 TAD
 INJ: 70074V 755
 SCALE: 1:40

RECEIVED

SEP 02 2025

BY:

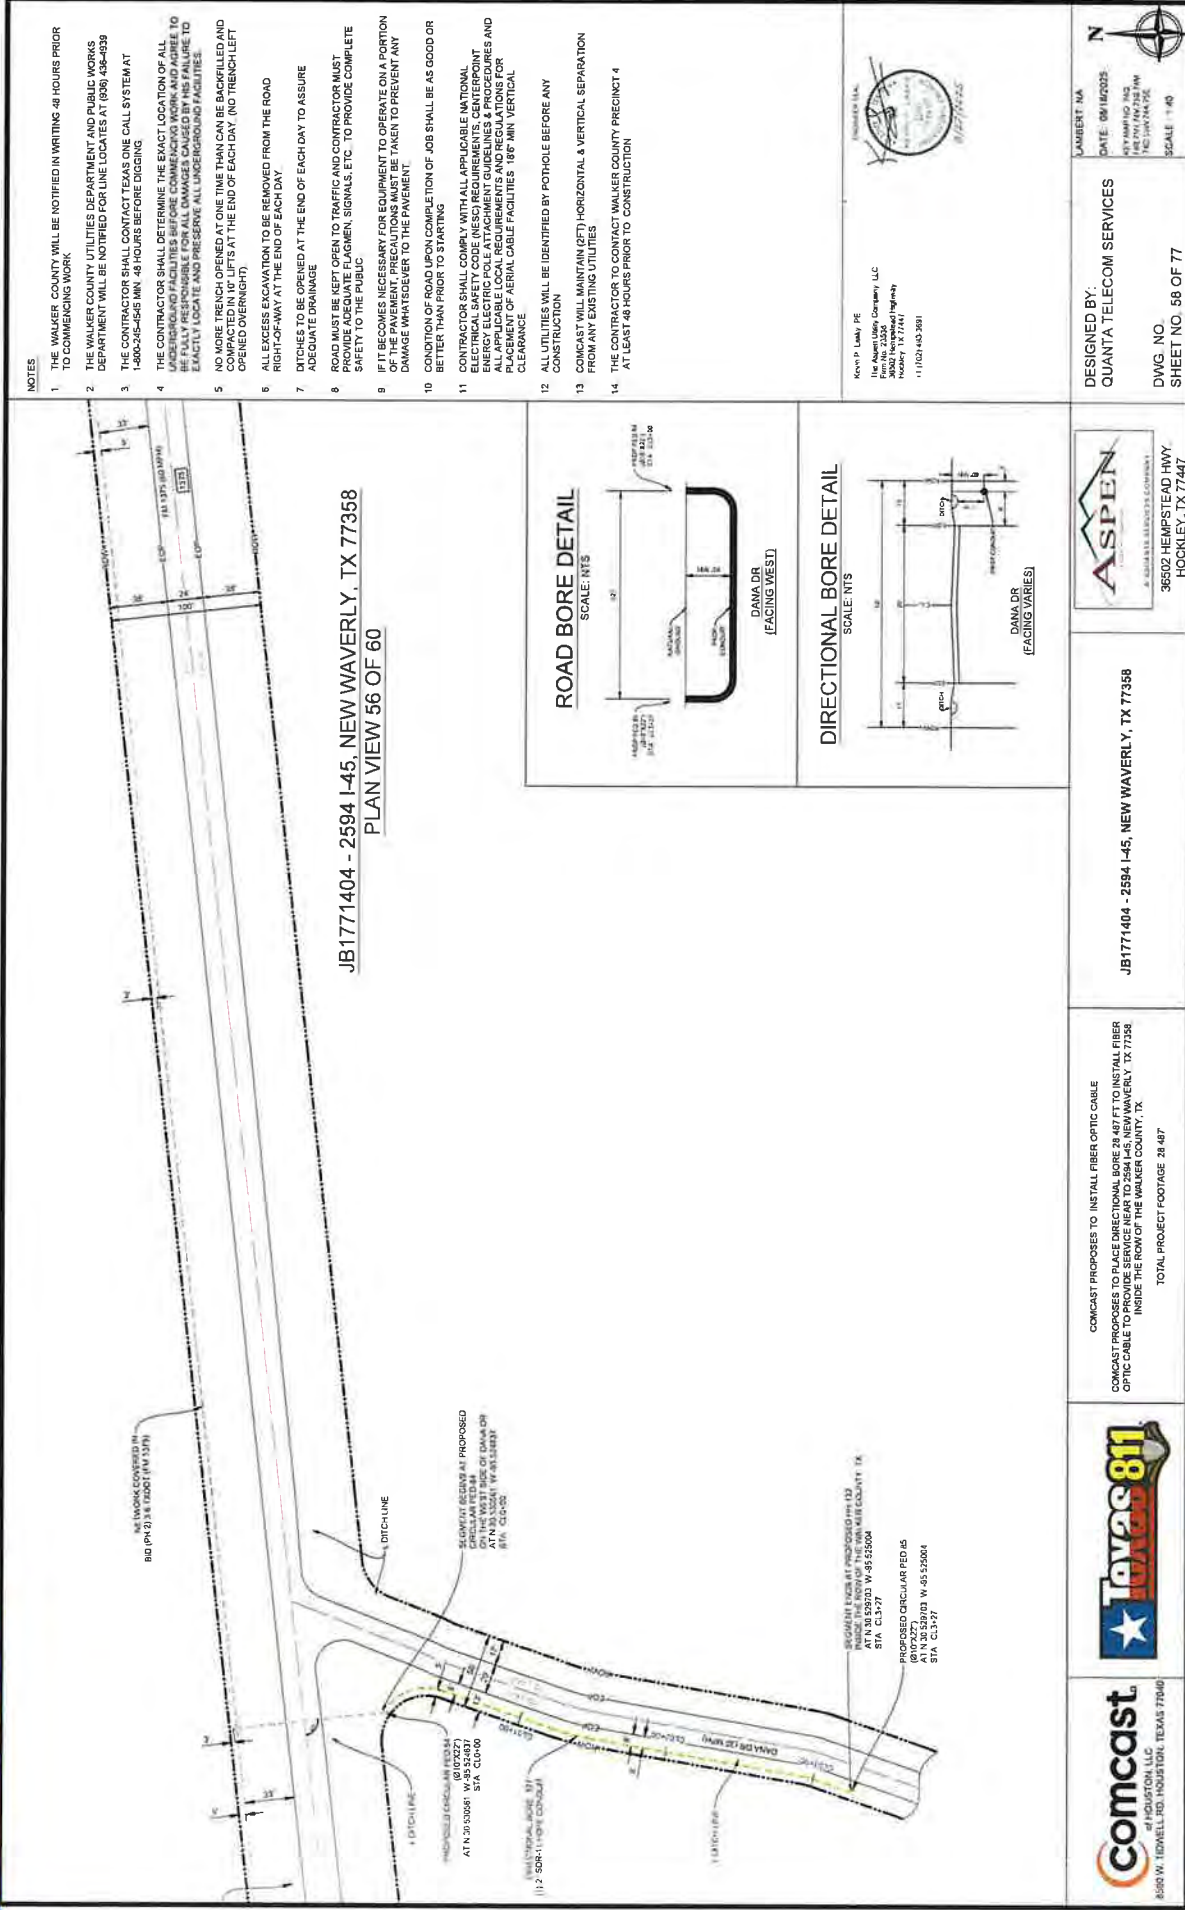

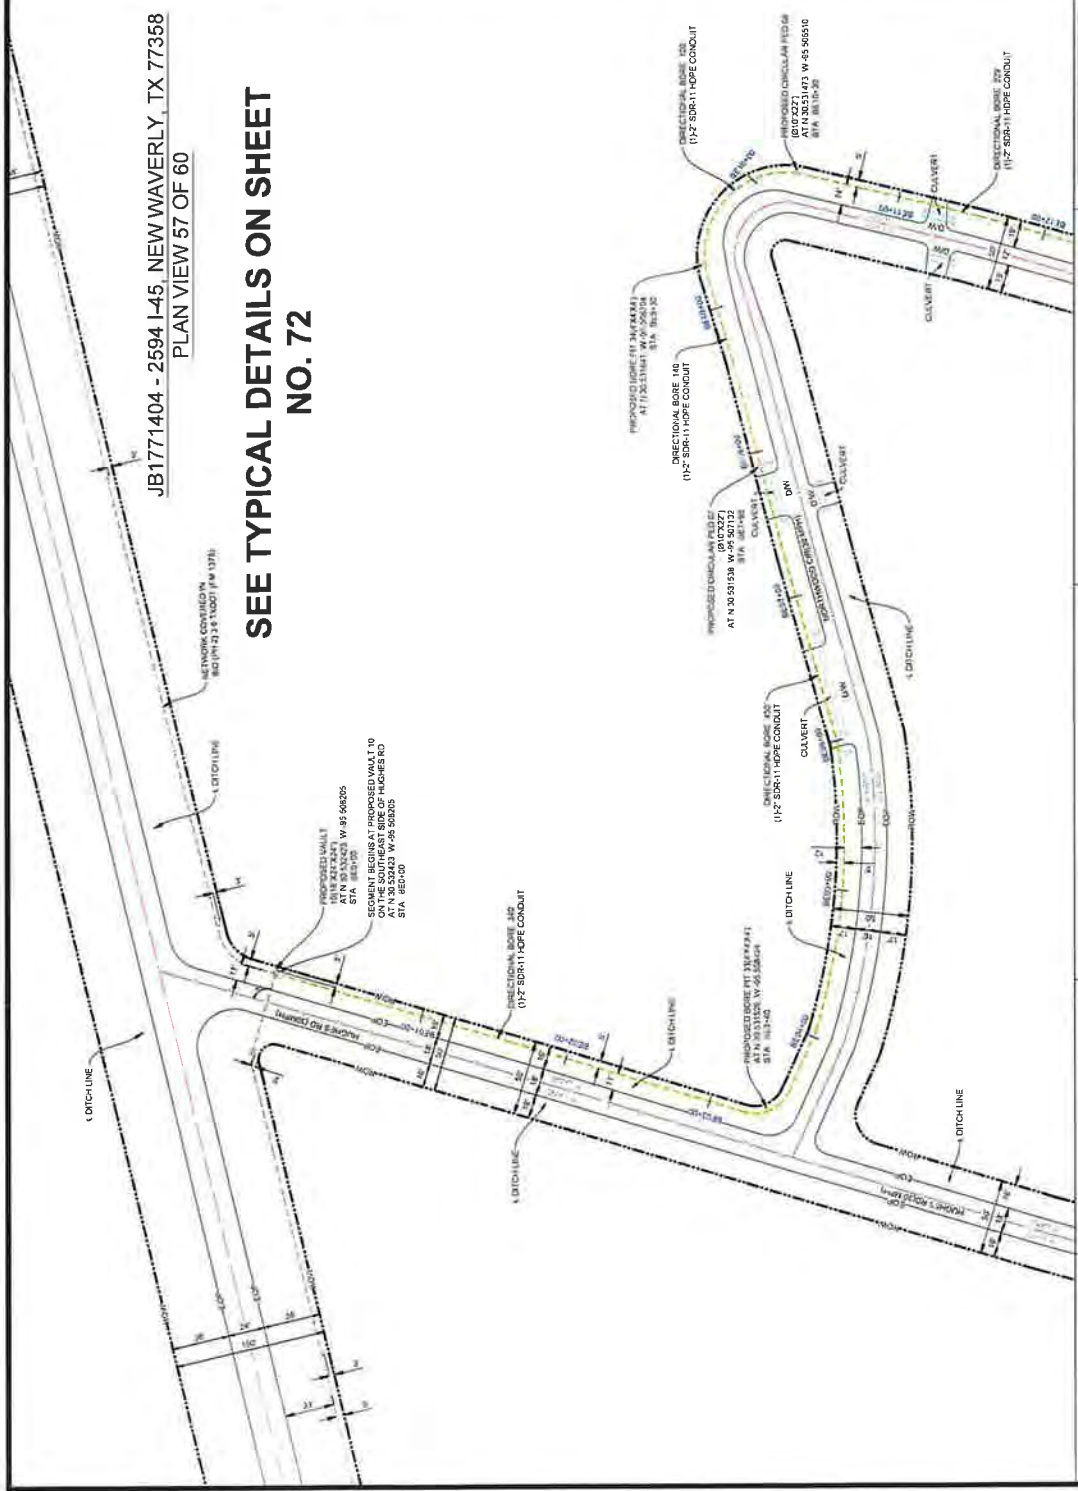

NOTES

1. THE WALKER COUNTY WILL BE NOTIFIED IN WRITING 48 HOURS PRIOR TO COMMENCING WORK.
2. THE WALKER COUNTY UTILITIES DEPARTMENT AND PUBLIC WORKS DEPARTMENT WILL BE NOTIFIED FOR LINE LOCATES AT (936) 436-4339
3. THE CONTRACTOR SHALL CONTACT TEXAS ONE CALL SYSTEM AT 1-800-242-4545 MIN. 48 HOURS BEFORE DIGGING.
4. THE CONTRACTOR SHALL DETERMINE THE EXACT LOCATION OF ALL UNDERGROUND FACILITIES BEFORE COMMENCING WORK AND AGREE TO BE FULLY RESPONSIBLE FOR ALL DAMAGES CAUSED BY HIS FAILURE TO EXACTLY LOCATE AND PRESERVE ALL UNDERGROUND FACILITIES.
5. NO MORE TRENCH DEPTH AT ONE TIME THAN CAN BE BACKFILLED AND COMPACTED IN 10' LIFTS AT THE END OF EACH DAY. (NO TRENCH LEFT OPENED OVERNIGHT).
6. ALL EXCESS EXCAVATION TO BE REMOVED FROM THE ROAD RIGHT-OF-WAY AT THE END OF EACH DAY.
7. DITCHES TO BE OPENED AT THE END OF EACH DAY TO ASSURE ADEQUATE DRAINAGE.
8. ROAD MUST BE KEPT OPEN TO TRAFFIC AND CONTRACTOR MUST PROVIDE ADEQUATE FLAGMEN, SIGNALS, ETC., TO PROVIDE COMPLETE SAFETY TO THE PUBLIC.
9. IF IT BECOMES NECESSARY FOR EQUIPMENT TO OPERATE ON A PORTION OF THE PAVEMENT, PRECAUTIONS MUST BE TAKEN TO PREVENT ANY DAMAGE WHATSOEVER TO THE PAVEMENT.
10. CONDITION OF ROAD UPON COMPLETION OF JOB SHALL BE AS GOOD OR BETTER THAN PRIOR TO STARTING.
11. CONTRACTOR SHALL COMPLY WITH ALL APPLICABLE NATIONAL ELECTRICAL SAFETY CODE (NEC) REQUIREMENTS, CENTERPOINT ENERGY ELECTRIC POLE ATTACHMENT GUIDELINES & PROCEDURES AND ALL OTHER RULES AND REGULATIONS OF THE UTILITY COMPANIES FOR PLACEMENT OF AERIAL CABLE FACILITIES. 18\"/>
12. ALL UTILITIES WILL BE IDENTIFIED BY POT-HOLE BEFORE ANY CONSTRUCTION.
13. COMCAST WILL MAINTAIN (2FT) HORIZONTAL & VERTICAL SEPARATION FROM ANY EXISTING UTILITIES.
14. THE CONTRACTOR TO CONTACT WALKER COUNTY PRECINCT 4 AT LEAST 48 HOURS PRIOR TO CONSTRUCTION.

Kevin P. Lundy PE
The Aspen Utility Company, LLC
10000 N. 2500
PO BOX 2500
HOCKLEY, TX 77447
+1 (281) 483-3661



DESIGNED BY:
QUANTA TELECOM SERVICES

DWG. NO.
SHEET NO. 59 OF 77



JB1771404 - 2594 I-45, NEW WAVERLY, TX 77358

COMCAST PROPOSES TO INSTALL FIBER OPTIC CABLE
COMCAST PROPOSES TO PLACE DIRECTIONAL BORE 24\"/>




Comcast
8550 W. TIDWELL RD HOUSTON, TEXAS 77040

RECEIVED
SEP 02 2025
BY:.....

JB1771404 - 2594 I-45, NEW WAVERLY, TX 77358
PLAN VIEW 58 OF 60

SEE TYPICAL DETAILS ON SHEET NO. 73

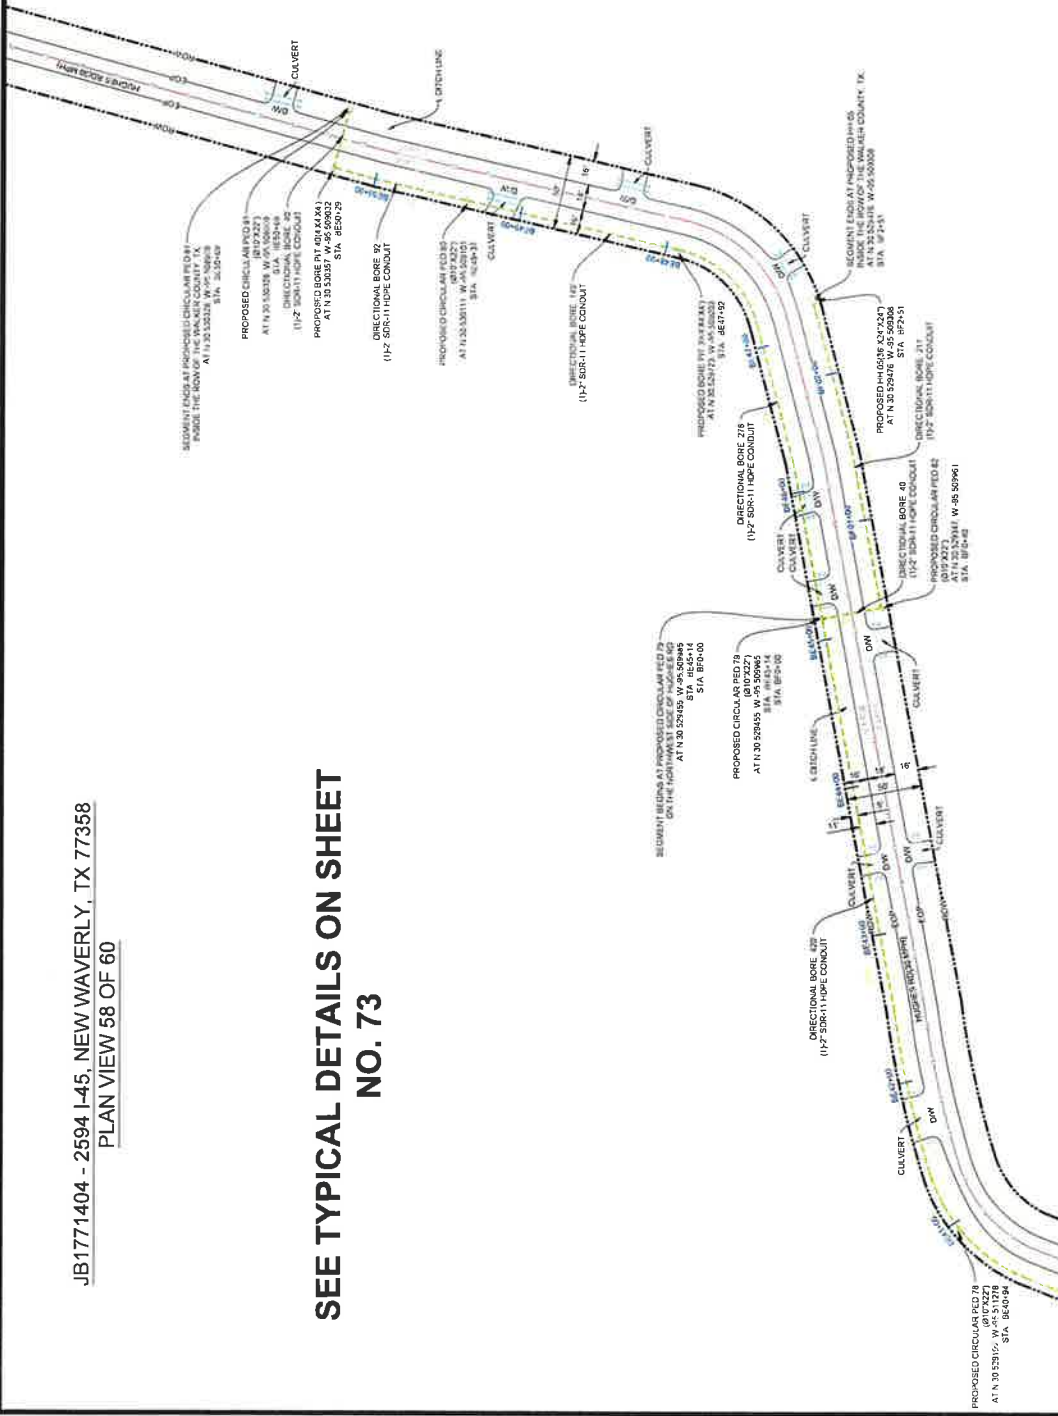

- NOTES:
1. THE WALKER COUNTY WILL BE NOTIFIED IN WRITING 48 HOURS PRIOR TO COMMENCING WORK.
 2. THE WALKER COUNTY UTILITIES DEPARTMENT AND PUBLIC WORKS DEPARTMENT WILL BE NOTIFIED FOR LINE LOCATES AT (336) 438-4899.
 3. THE CONTRACTOR SHALL CONTACT TEXAS ONE CALL SYSTEM AT 1-800-445-4545 MIN. 48 HOURS BEFORE DIGGING.
 4. THE CONTRACTOR SHALL DETERMINE THE EXACT LOCATION OF ALL UNDERGROUND FACILITIES BEFORE COMMENCING WORK AND AGREE TO BE RESPONSIBLE FOR ANY AND ALL DAMAGES CAUSED BY HIS FAILURE TO EXACTLY LOCATE AND PRESERVE ALL UNDERGROUND FACILITIES.
 5. NO MORE TRENCH OPENED AT ONE TIME THAN CAN BE BACKFILLED AND COVERED WITHIN EACH DAY AT THE END OF EACH DAY. (NO TRENCH LEFT OPENED OVERNIGHT).
 6. ALL EXCESS EXCAVATION TO BE REMOVED FROM THE ROAD RIGHT-OF-WAY AT THE END OF EACH DAY.
 7. DITCHES TO BE OPENED AT THE END OF EACH DAY TO ASSURE ADEQUATE DRAINAGE.
 8. ROAD MUST BE KEPT OPEN TO TRAFFIC AND CONTRACTOR MUST PROVIDE ADEQUATE FLAGMEN, SIGNALS, ETC. TO PROVIDE COMPLETE SAFETY TO THE PUBLIC.
 9. IF IT BECOMES NECESSARY FOR EQUIPMENT TO OPERATE ON A PORTION OF THE PAVEMENT PRECAUTIONS MUST BE TAKEN TO PREVENT ANY DAMAGE WHATSOEVER TO THE PAVEMENT.
 10. CONDITION OF ROAD UPON COMPLETION OF JOB SHALL BE AS GOOD OR BETTER THAN PRIOR TO STARTING.
 11. CONTRACTOR SHALL COMPLY WITH ALL APPLICABLE NATIONAL ELECTRICAL SAFETY CODE (NEC) REQUIREMENTS, CENTERPOINT UTILITY REQUIREMENTS, AND ALL APPLICABLE LOCAL REQUIREMENTS AND REGULATIONS FOR PLACEMENT OF AERIAL CABLE FACILITIES, 18" MIN VERTICAL CLEARANCE.
 12. ALL UTILITIES WILL BE IDENTIFIED BY POTHOLE BEFORE ANY CONSTRUCTION.
 13. COMCAST WILL MAINTAIN (2FT) HORIZONTAL & VERTICAL SEPARATION FROM ANY EXISTING UTILITIES.
 14. THE CONTRACTORS TO COMCAST WALKER COUNTY PRECINCT 4 AT LEAST 48 HOURS PRIOR TO CONSTRUCTION.

Aspen P. Lacy, PE
The Aspen Company LLC
10001 Hempstead Highway
Houston, TX 77060
+1713.143.361

PROJECT SEAL
8/27/25

DESIGNED BY:
QUANTA TELECOM SERVICES

DWG. NO. 60 OF 77
SHEET NO. 60 OF 77

38502 HEMPSTEAD HWY.
HOCKLEY, TX 77447

DATE: 08/26/25
KEY: HAD TO: HAD
HOCKLEY, TX 77447
SCALE: 1"=40'

Comcast
HOUSTON, LLC
6860 W. TIDWELL RD. HOUSTON, TEXAS 77040

Texas 811

COMCAST PROPOSES TO INSTALL FIBER OPTIC CABLE
COMCAST PROPOSES TO PLACE DIRECTIONAL BORE 28.48 FT TO INSTALL FIBER OPTIC CABLE TO INSIDE THE ROW OF THE WALKER COUNTY, TX.

TOTAL PROJECT FOOTAGE 28.48 FT

JB1771404 - 2594 I-45, NEW WAVERLY, TX 77358

ASPEN
A. SUGALSKA, REGISTERED ENGINEER
38502 HEMPSTEAD HWY.
HOCKLEY, TX 77447

 
 
PLAN VIEW 59 OF 60



CALE: NTS



CALCULATO




SCALE: NTS



CALE NTS



 SCALE: NTS



- 1 THE WALKER CROWD WILL BE NOTIFIED IN WRITING 48 HOURS PRIOR
2 TO COMMENCING WORK
- 3 THE WALKER COUNTY UTILITIES DEPARTMENT AND PUBLIC WORKS
4 DEPARTMENT WILL BE NOTIFIED FOR LINE LOCATES AT (930) 358-8539
- 5 THE CONTRACTOR SHALL CONTACT TEXAS ONE CALL SYSTEM AT
6 1-800-455-6656 24 HOURS BEFORE BEGINNING ANY WORK
- 7 THE CONTRACTOR SHALL ESTABLISH THE EASEMENT CORNER AND ALL
8 UNDERGROUND FACILITIES BEFORE COMMENCING WORK AND AGREE TO
9 BE FULLY RESPONSIBLE FOR ALL DAMAGES CAUSED BY HIS FAILURE TO
10 EXCAVATE AND PRESERVE ALL UNDERGROUND FACILITIES.
- 11 NO MORE TRENCH OPENED AT ONE TIME THAN CAN BE BACKFILLED AND
12 COMPACTED IN 10 LIFTS AT THE END OF EACH DAY. (NO TRENCH LEFT
13 OPENED OVERNIGHT)
- 14 ALL EXCESS EXCAVATION TO BE REMOVED FROM THE ROAD
15 RIGHT-OF-WAY AT THE END OF EACH DAY.
- 16 DITCHES TO BE OPENED AT THE END OF EACH DAY TO ASSURE
17 ADEQUATE DRAINAGE
- 18 ROAD MUST BE LEFT OPEN TO TRAFFIC AND CONTRACTOR MUST
19 PROVIDE ADEQUATE FLAGMEN, SIGNALS, ETC., TO PROVIDE COMPLETE
20 SAFETY TO THE PUBLIC
- 21 IF IT BECOMES NECESSARY FOR EQUIPMENT TO BE TAKEN TO PREVENT ANY
22 OF THE PAVEMENT, PRECAUTIONS MUST BE TAKEN TO PREVENT ANY
23 DAMAGE WHATSOEVER TO THE PAVEMENT
- 24 COMPLETION OF ROAD UPON COMPLETION OF JOB SHALL BE AS GOOD OR
25 BETTER THAN PRIOR TO STARTING
- 26 CONTRACTOR SHALL COMPLY WITH ALL APPLICABLE NATIONAL
27 ELECTRICAL SAFETY CODE (NEC) REQUIREMENTS, CENTERPOINT
28 ELECTRICAL SAFETY CODE, AND ALL OTHER RULES, REGULATIONS AND
29 ALL APPLICABLE LOCAL REQUIREMENTS AND REGULATIONS FOR
30 PLACEMENT OF AERIAL CABLE FACILITIES, 18" MIN VERTICAL
31 CLEARANCE
- 32 ALL UTILITIES WILL BE IDENTIFIED BY POT-HOLE BEFORE ANY
33 CONSTRUCTION
- 34 CONCAST WILL MAINTAIN (2) HORIZONTAL & VERTICAL SEPARATION
35 FROM ANY EXISTING UTILITIES
- 36 THE CONTRACTOR TO CONTACT WALKER COUNTY PRESENT 4
37 AT LEAST 48-HOURS PRIOR TO CONSTRUCTION

For more information, contact:
The Aquatic Utility Company, LLC
Fax: No. 252.743.5102
31502 Herrington Highway
Hickory, NC 27441
252.743.5101



comcast
@HOUSTON, LLC
500 W. TIDWELL RD. HOUSTON, TEXAS 77040



JIB1771404 - 2594 I-45, NEW WAVERLY, TX 77358



DESIGNED BY:






DWG. NO. 77
SHEET NO. 61 OF 77



LAMBERT: NA
DATE: 08/18/20

RECEIVED
SEP 02 2025
BY:

JB1771404 - 2594 I-45, NEW WAVERLY, TX 77358
PLAN VIEW 60 OF 60

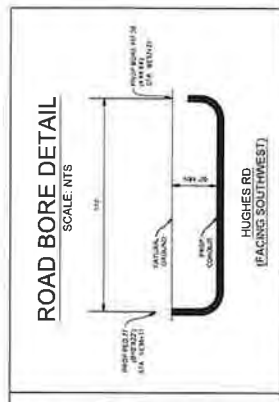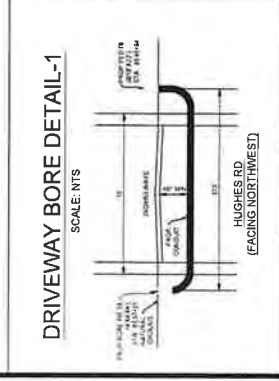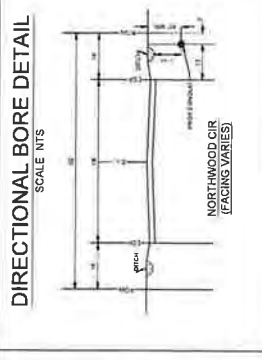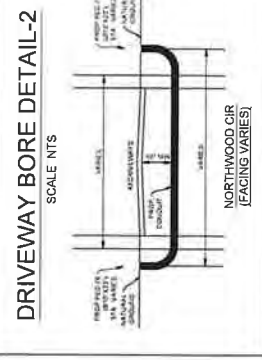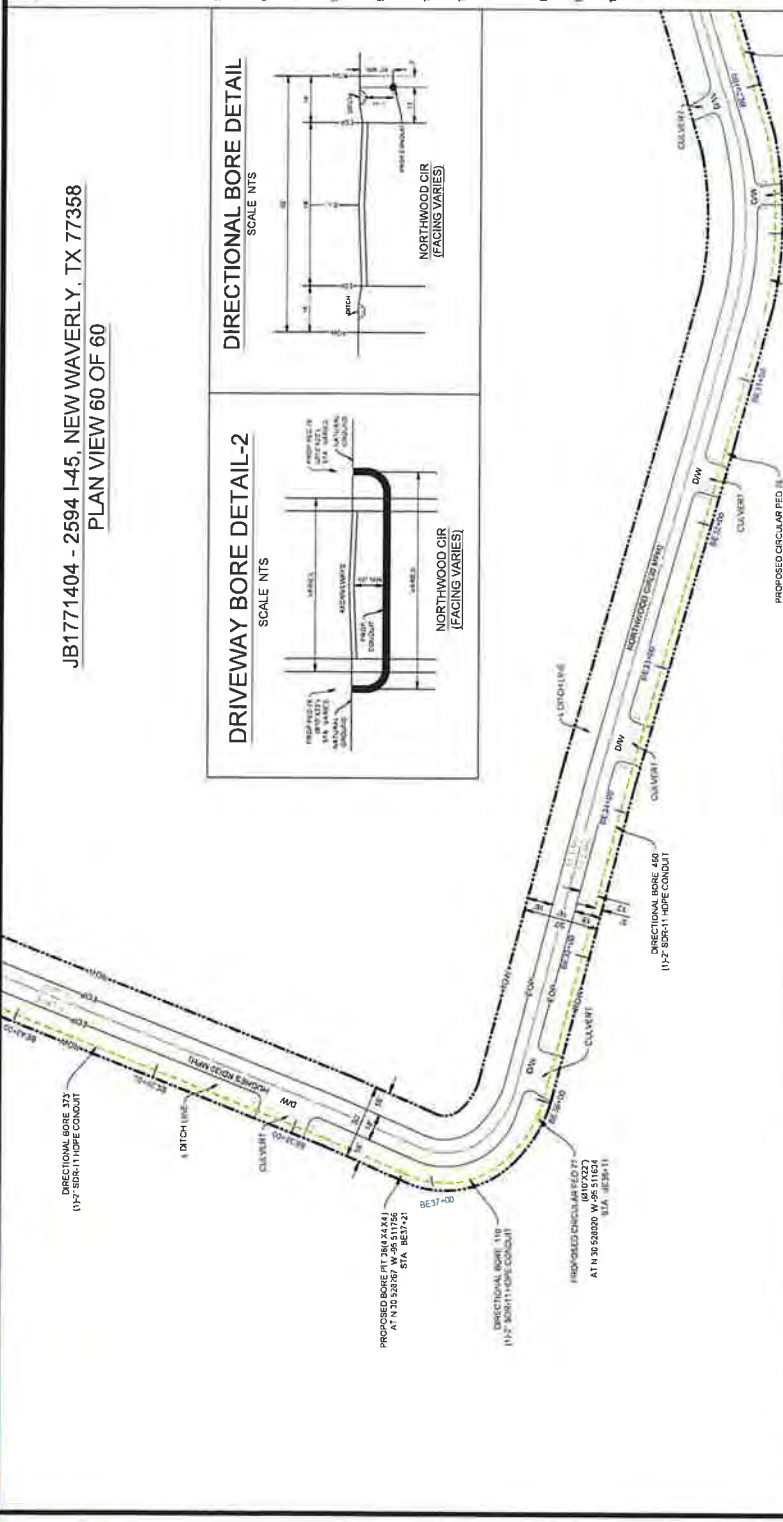

- NOTES
1. THE WALKER COUNTY WILL BE NOTIFIED IN WRITING 48 HOURS PRIOR TO COMMENCING WORK.
 2. THE WALKER COUNTY UTILITIES DEPARTMENT AND PUBLIC WORKS DEPARTMENT WILL BE NOTIFIED FOR LINE LOCATES AT (936) 436-4339
 3. THE CONTRACTOR SHALL CONTACT TEXAS ONE CALL SYSTEM AT 1-800-245-4545 MIN. 48 HOURS BEFORE DIGGING
 4. THE CONTRACTOR SHALL DETERMINE THE EXACT LOCATION OF ALL UNDERGROUND FACILITIES BEFORE COMMENCING WORK AND AGREE TO BE FULLY RESPONSIBLE FOR ALL DAMAGES CAUSED BY HIS FAILURE TO EXPLICITLY LOCATE AND PRESERVE ALL UNDERGROUND FACILITIES
 5. NO MORE TRENCH OPENED AT ONE TIME THAN CAN BE BACKFILLED AND RECLOSED WITHIN 24 HOURS OF THE END OF EACH DAY (NO TRENCH LEFT OPENED OVERNIGHT)
 6. ALL EXCESS EXCAVATION TO BE REMOVED FROM THE ROAD RIGHT-OF-WAY AT THE END OF EACH DAY.
 7. DITCHES TO BE OPENED AT THE END OF EACH DAY TO ASSURE ADEQUATE DRAINAGE
 8. ROAD MUST BE KEPT OPEN TO TRAFFIC AND CONTRACTOR MUST PROVIDE ADEQUATE FLAGMEN, SIGNALS, ETC., TO PROVIDE COMPLETE SAFETY TO THE PUBLIC
 9. IF IT BECOMES NECESSARY FOR EQUIPMENT TO OPERATE ON A PORTION OF THE PAVEMENT, PRECAUTIONS MUST BE TAKEN TO PREVENT ANY DAMAGE WHATSOEVER TO THE PAVEMENT.
 10. CONDITION OF ROAD UPON COMPLETION OF JOB SHALL BE AS GOOD OR BETTER THAN PRIOR TO STARTING
 11. CONTRACTOR SHALL COMPLY WITH ALL APPLICABLE NATIONAL ELECTRICAL SAFETY CODE (NEC) REQUIREMENTS, CENTERPOINT ENERGY'S SAFETY PROGRAM, AND ALL APPLICABLE LOCAL ORDINANCES AND REGULATIONS FOR PLACEMENT OF AERIAL CABLE FACILITIES 18\"/>
 12. ALL UTILITIES WILL BE IDENTIFIED BY POT HOLE BEFORE ANY CONSTRUCTION
 13. CONSTRUCTION WILL MAINTAIN (LEFT) HORIZONTAL & VERTICAL SEPARATION FROM ANY EXISTING UTILITIES.
 14. THE CONTRACTOR TO CONTACT WALKER COUNTY PRECINCT 4 AT LEAST 48 HOURS PRIOR TO CONSTRUCTION



DESIGNED BY:
QUANTA TELECOM SERVICES

DWG. NO. 62 OF 77
SHEET NO. 62 OF 77



JB1771404 - 2594 I-45, NEW WAVERLY, TX 77358

COMCAST PROPOSES TO INSTALL FIBER OPTIC CABLE
COMCAST PROPOSES TO PLACE DIRECTIONAL BORE 39 48\"/>



BY:

LAMBERT: NA
DATE 08/18/2025
KEY MAP NO 74Q
74R 75W 74V 75S 74M
74D 55W 74A 75E
SCALE: NTS

ASPEN
36502 HEMPSTEAD HWY
HOCKLEY TX 77447

COMCAST PROPOSES TO INSTALL FIBER OPTIC CABLE
COMCAST PROPOSES TO PLACE DIRECTIONAL BORE 28 487 FT TO INSTALL FIBER
OPTIC CABLE TO PROVIDE SERVICE NEAR TO 2564 145, NEW WAVERLY, TX 77558
INSIDE THE ROW OF THE WALKER COUNTY, TX.



© 2006 Comcast. All rights reserved.

DWG. NO.
SHEET NO. 65 OF 77


DATE: 08/18/2025
KEY MAP NO 74Q
74R 75N 74V, 75S 74M
74D 55W 74A 75E

1. THE WALKER COUNTY WILL BE NOTIFIED IN WRITING 48 HOURS PRIOR TO COMMENCING WORK.
2. THE WALKER COUNTY UTILITIES DEPARTMENT AND PUBLIC WORKS DEPARTMENT WILL BE NOTIFIED FOR LINE LOCATES AT (580) 494-0493.
3. THE CONTRACTOR SHALL CONTACT TEXAS ONE CALL SYSTEM AT 1-800-253-5456 MIN. 48 HOURS BEFORE DIGGING.
4. THE CONTRACTOR SHALL DETERMINE THE EXACT LOCATION OF ALL UNDERGROUND FACILITIES BEFORE COMMENCING WORK AND AGREE TO BE FULLY RESPONSIBLE FOR ALL DAMAGES CAUSED BY HIS FAILURE TO EXACTLY LOCATE AND PRESERVE ALL UNDERGROUND FACILITIES.
5. NO MORE TRENCH OPENED AT ONE TIME THAT CAN BE BACKFILLED AND COMPLETED IN 10' LIFTS AT THE END OF EACH DAY. (NO TRENCH LEFT OPENED OVERNIGHT)
6. ALL EXCESS EXCAVATION TO BE REMOVED FROM THE ROAD RIGHT-OF-WAY AT THE END OF EACH DAY.
7. DITCHES TO BE OPENED AT THE END OF EACH DAY TO ASSURE ADEQUATE DRAINAGE.
8. ROAD MARKS BE LEFT OPEN TO TRAFFIC AND CONTRACTOR MUST PROVIDE ADEQUATE TRAFFIC CONTROL SIGNALS ETC. TO PROVIDE COMPLETE SAFETY TO THE PUBLIC.
9. IF IT BECOMES NECESSARY FOR THE CONTRACTOR TO OPERATE ON A PORTION OF THE ROAD, THE CONTRACTOR MUST BE HELD TO PREVENT ANY DAMAGE WHATSOEVER TO THE PAVEMENT.
10. CONDITION OF ROAD UPON COMPLETION OF JOB SHALL BE AS GOOD OR BETTER THAN PRIOR TO STARTING.
11. CONTRACTOR SHALL COMPLY WITH ALL APPLICABLE NATIONAL ELECTRICAL SAFETY CODE (NEC) REQUIREMENTS, CENTERPOINT REQUIREMENTS, TEXAS ELECTRICAL CODE REQUIREMENTS AND ALL APPLICABLE LOCAL REQUIREMENTS AND REGULATIONS FOR PLACEMENT OF AERIAL CABLE FACILITIES. 18" MIN VERTICAL CLEARANCE.
12. ALL UTILITIES WILL BE IDENTIFIED BY POT-HOLE BEFORE ANY CONSTRUCTION.
13. CONTRACT WILL MAINTAIN CITY HORIZONTAL & VERTICAL SEPARATION FROM ANY EXISTING UTILITIES.

Ken E. Latta, PE
The Aspen Utility Company, LLC
Firm No. 23538
36502 Henrieville Highway
Hudson, NY 12534



RECEIVED
SEP 02 2025
BY:.....

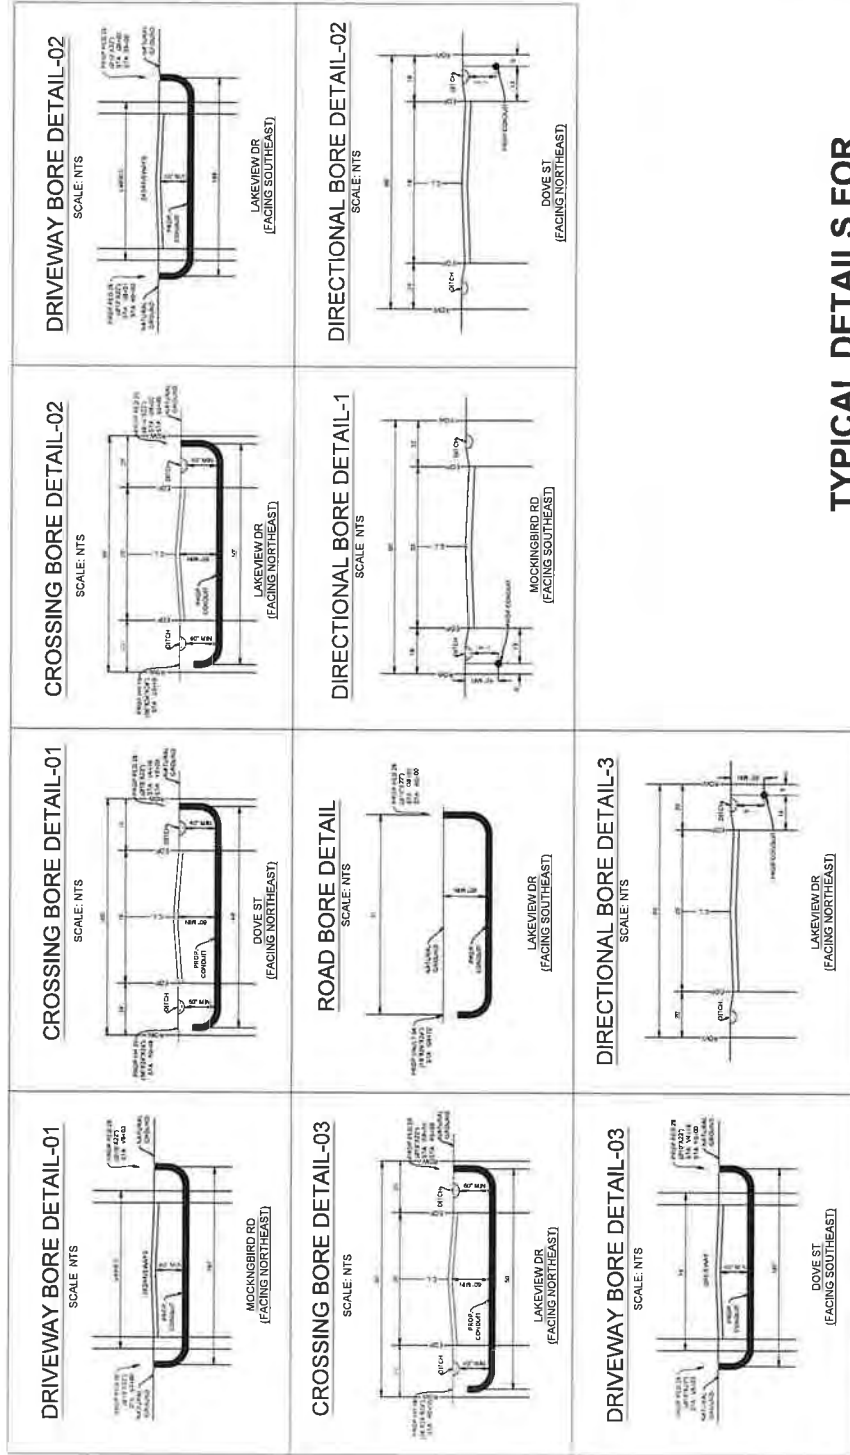

**TYPICAL DETAILS FOR
SHEET NO. 34**

Kevin @ 1 sub 112
The Address Utility Company LLC
P.O. Box 22536
80302 Montebello Heights
Hickory TX 77447
11/1/2010 @ 23:36:33



comcast
of HOUSTON, LLC
8590 W. TIDWELL RD. HOUSTON, TEXAS 77040



COMCAST PROPOSES TO INSTALL FIBER OPTIC CABLE
BORECAST PROPOSES TO PLACE DIRECTIONAL BORE 28,487 FT TO INSTALL FIBER
OPTIC CABLE TO PROVIDE SERVICE NEAR TO 25M-145, NEW WAVELEY, TX 77358
INSIDE THE ROW OF THE WALKER COUNTY, TX.

TOTAL PROJECT FOOTAGE 28,487

TOTAL PROJECT FOOTAGE 28 487'

JB1771404 - 2594 I-45, NEW WAVERLY, TX 77358



36502 HEMPSTEAD HWY
HOCKLEY, TX 77447

DESIGNED BY:
QUANTA TELECOM SERVICES

DWG. NO.
SHEET NO. 66 OF 77

LAMBERT: NA
DATE: 08/18/2013
KEY MAP: 103
75R 75N 74W 15S 7
74D 55W 74A 15E
SCALE: NTS

1. TO THE WAJER COUNTY WILL BE NOTIFIED IN WRITING 48 HOURS PRIOR TO COMMENCING WORK.
2. THE WALKER COUNTY UTILITIES DEPARTMENT AND PUBLIC WORKS DEPARTMENT WILL BE NOTIFIED FOR LINE LOCATES AT (936) 454-4059
3. THE CONTRACTOR SHALL CONTACT TEXAS ONE CALL SYSTEM AT 1-800-251-4545 MIN. 48 HOURS BEFORE DIGGING
4. THE CONTRACTOR SHALL DETERMINE THE EXACT LOCATION OF ALL UNDERGROUND FACILITIES BEFORE COMMENCING WORK AND AGREE TO BE FULLY RESPONSIBLE FOR ALL DAMAGES CAUSED BY HIS FAILURE TO EXACTLY LOCATE AND PRESENSE ALL UNDERGROUND FACILITIES
5. NO MORE TRENCH OPENING AT ONE TIME THAN CAN BE BACKFILLED AND COMPACTED IN 10' LIFTS AT THE END OF EACH DAY (NO TRENCH LEFT OPENED OVERNIGHT)
6. ALL EXCESS EXCAVATION TO BE REMOVED FROM THE ROAD RIGHT-OF-WAY AT THE END OF EACH DAY
7. DITCHES TO BE OPENED AT THE END OF EACH DAY TO ASSURE ADEQUATE DRAINAGE
8. ROAD MUST BE KEPT OPEN TO TRAFFIC AND CONTRACTOR MUST PROVIDE ADEQUATE FLAGMEN, SIGNALS, ETC., TO PROVIDE COMPLETE SAFETY TO THE PUBLIC
9. IF IT BECOMES NECESSARY FOR EQUIPMENT TO OPERATE ON A PORTION OF THE PAVEMENT, PRECAUTIONS MUST BE TAKEN TO PREVENT ANY DAMAGE WHATSOEVER TO THE PAVEMENT
10. CONDITION OF ROAD UPON COMPLETION OF JOB SHALL BE AS GOOD OR BETTER THAN PRIOR TO STARTING
11. CONTRACTOR SHALL COMPLY WITH ALL APPLICABLE NATIONAL ELECTRICAL, SAFETY CODE (NEC) REQUIREMENTS, CENTERPOINT ENERGY, ELECTRIC POLE ATTACHMENT GUIDELINES & PROCEDURES AND ALL OTHER APPLICABLE STATE AND LOCAL REGULATIONS FOR CLEARANCE OF AERIAL CABLE FACILITIES 18" MIN VERTICAL CLEARANCE
12. ALL UTILITIES WILL BE IDENTIFIED BY POTHOLE BEFORE ANY CONSTRUCTION
13. COMCAST WILL MAINTAIN (GFI) HORIZONTAL & VERTICAL SEPARATION

NOTES

1. THE WALKER COUNTY WILL BE NOTIFIED IN WRITING 48 HOURS PRIOR TO COMMENCING WORK.
2. THE WALKER COUNTY UTILITIES DEPARTMENT AND PUBLIC WORKS DEPARTMENT WILL BE NOTIFIED FOR LINE LOCATES AT (936) 436-8939
3. THE CONTRACTOR SHALL CONTACT TEXAS ONE CALL SYSTEM AT 1-800-245-4545 MIN. 48 HOURS BEFORE DIGGING
4. THE CONTRACTOR SHALL DETERMINE THE EXACT LOCATION OF ALL UNDERGROUND FACILITIES BEFORE COMMENCING WORK AND AGREE TO BE FULLY RESPONSIBLE FOR ALL DAMAGES CAUSED BY HIS FAILURE TO EXACTLY LOCATE AND PRESERVE ALL UNDERGROUND FACILITIES
5. NO MORE TRENCH OPENED AT ONE TIME THAN CAN BE BACKFILLED AND COMPACTED IN 10' LIFTS AT THE END OF EACH DAY (NO TRENCH LEFT OPENED OVERNIGHT)
6. ALL EXCESS EXCAVATION TO BE REMOVED FROM THE ROAD RIGHT-OF-WAY AT THE END OF EACH DAY
7. DITCHES TO BE OPENED AT THE END OF EACH DAY TO ASSURE ADEQUATE DRAINAGE
8. ROAD MUST BE KEPT OPEN TO TRAFFIC AND CONTRACTOR MUST PROVIDE ADEQUATE FLAGMEN, SIGNALS, ETC. TO PROVIDE COMPLETE SAFETY TO THE PUBLIC
9. IF IT BECOMES NECESSARY FOR EQUIPMENT TO OPERATE ON A PORTION OF THE PAVEMENT, PRECAUTIONS MUST BE TAKEN TO PREVENT ANY DAMAGE WHATSOEVER TO THE PAVEMENT
10. CONDITION OF ROAD UPON COMPLETION OF JOB SHALL BE AS GOOD OR BETTER THAN PRIOR TO STARTING.
11. CONTRACTOR SHALL COMPLY WITH ALL APPLICABLE NATIONAL ELECTRICAL SAFETY CODE (NEC) REQUIREMENTS, CENTERPOINT ENERGY ELECTRIC POLE ATTACHMENT GUIDELINES & PROCEDURES AND ALL OTHER REQUIREMENTS AND STANDARDS FOR THE PROPER PLACEMENT OF AERIAL CABLE FACILITIES, 18" MIN VERTICAL CLEARANCE
12. ALL UTILITIES SHALL BE IDENTIFIED BY POT-HOLE BEFORE ANY CONSTRUCTION
13. COMCAST WILL MAINTAIN (8FT) HORIZONTAL & VERTICAL SEPARATION FROM ANY EXISTING UTILITIES

Project # 14447
 The Aspen Utility Company, LLC
 36502 Hempstead Hwy.
 Houston, TX 77447
 (713) 222-4455 (local)



DESIGNED BY:
 QUANTA TELECOM SERVICES
 DWG. NO.
 SHEET NO. 67 OF 77



JB1771404 - 2594 I-45, NEW WAVERLY, TX 77358

COMCAST PROPOSES TO INSTALL FIBER OPTIC CABLE
 COMCAST PROPOSES TO PLACE DIRECTIONAL BORE 28.487 FT TO INSTALL FIBER
 OPTIC CABLE TO PROVIDE SERVICE NEAR TO 2594 I-45, NEW WAVERLY, TX 77358.
 INSIDE THE ROW OF THE WALKER COUNTY, TX.
 TOTAL PROJECT FOOTAGE: 28.487



TYPICAL DETAILS FOR SHEET NO. 35

DRIVEWAY BORE DETAIL-01 SCALE: 1/8" = 1'-0" MANHOLE AT END (AS SHOWN)	ROAD BORE DETAIL-01 SCALE: 1/8" = 1'-0" MANHOLE AT END (AS SHOWN)	ROAD BORE DETAIL-02 SCALE: 1/8" = 1'-0" MANHOLE AT END (AS SHOWN)	ROAD BORE DETAIL-03 SCALE: 1/8" = 1'-0" MANHOLE AT END (AS SHOWN)	CROSSING BORE DETAIL-01 SCALE: 1/8" = 1'-0" MANHOLE AT END (AS SHOWN)	CROSSING BORE DETAIL-02 SCALE: 1/8" = 1'-0" MANHOLE AT END (AS SHOWN)	CROSSING BORE DETAIL-03 SCALE: 1/8" = 1'-0" MANHOLE AT END (AS SHOWN)	CROSSING BORE DETAIL-04 SCALE: 1/8" = 1'-0" MANHOLE AT END (AS SHOWN)	CROSSING BORE DETAIL-05 SCALE: 1/8" = 1'-0" MANHOLE AT END (AS SHOWN)	CROSSING BORE DETAIL-06 SCALE: 1/8" = 1'-0" MANHOLE AT END (AS SHOWN)	CROSSING BORE DETAIL-07 SCALE: 1/8" = 1'-0" MANHOLE AT END (AS SHOWN)	CROSSING BORE DETAIL-08 SCALE: 1/8" = 1'-0" MANHOLE AT END (AS SHOWN)	CROSSING BORE DETAIL-09 SCALE: 1/8" = 1'-0" MANHOLE AT END (AS SHOWN)	CROSSING BORE DETAIL-10 SCALE: 1/8" = 1'-0" MANHOLE AT END (AS SHOWN)	CROSSING BORE DETAIL-11 SCALE: 1/8" = 1'-0" MANHOLE AT END (AS SHOWN)	CROSSING BORE DETAIL-12 SCALE: 1/8" = 1'-0" MANHOLE AT END (AS SHOWN)	CROSSING BORE DETAIL-13 SCALE: 1/8" = 1'-0" MANHOLE AT END (AS SHOWN)	CROSSING BORE DETAIL-14 SCALE: 1/8" = 1'-0" MANHOLE AT END (AS SHOWN)	CROSSING BORE DETAIL-15 SCALE: 1/8" = 1'-0" MANHOLE AT END (AS SHOWN)	CROSSING BORE DETAIL-16 SCALE: 1/8" = 1'-0" MANHOLE AT END (AS SHOWN)	CROSSING BORE DETAIL-17 SCALE: 1/8" = 1'-0" MANHOLE AT END (AS SHOWN)	CROSSING BORE DETAIL-18 SCALE: 1/8" = 1'-0" MANHOLE AT END (AS SHOWN)	CROSSING BORE DETAIL-19 SCALE: 1/8" = 1'-0" MANHOLE AT END (AS SHOWN)	CROSSING BORE DETAIL-20 SCALE: 1/8" = 1'-0" MANHOLE AT END (AS SHOWN)	CROSSING BORE DETAIL-21 SCALE: 1/8" = 1'-0" MANHOLE AT END (AS SHOWN)	CROSSING BORE DETAIL-22 SCALE: 1/8" = 1'-0" MANHOLE AT END (AS SHOWN)	CROSSING BORE DETAIL-23 SCALE: 1/8" = 1'-0" MANHOLE AT END (AS SHOWN)	CROSSING BORE DETAIL-24 SCALE: 1/8" = 1'-0" MANHOLE AT END (AS SHOWN)	CROSSING BORE DETAIL-25 SCALE: 1/8" = 1'-0" MANHOLE AT END (AS SHOWN)	CROSSING BORE DETAIL-26 SCALE: 1/8" = 1'-0" MANHOLE AT END (AS SHOWN)	CROSSING BORE DETAIL-27 SCALE: 1/8" = 1'-0" MANHOLE AT END (AS SHOWN)	CROSSING BORE DETAIL-28 SCALE: 1/8" = 1'-0" MANHOLE AT END (AS SHOWN)	CROSSING BORE DETAIL-29 SCALE: 1/8" = 1'-0" MANHOLE AT END (AS SHOWN)	CROSSING BORE DETAIL-30 SCALE: 1/8" = 1'-0" MANHOLE AT END (AS SHOWN)	CROSSING BORE DETAIL-31 SCALE: 1/8" = 1'-0" MANHOLE AT END (AS SHOWN)	CROSSING BORE DETAIL-32 SCALE: 1/8" = 1'-0" MANHOLE AT END (AS SHOWN)	CROSSING BORE DETAIL-33 SCALE: 1/8" = 1'-0" MANHOLE AT END (AS SHOWN)	CROSSING BORE DETAIL-34 SCALE: 1/8" = 1'-0" MANHOLE AT END (AS SHOWN)	CROSSING BORE DETAIL-35 SCALE: 1/8" = 1'-0" MANHOLE AT END (AS SHOWN)	CROSSING BORE DETAIL-36 SCALE: 1/8" = 1'-0" MANHOLE AT END (AS SHOWN)	CROSSING BORE DETAIL-37 SCALE: 1/8" = 1'-0" MANHOLE AT END (AS SHOWN)	CROSSING BORE DETAIL-38 SCALE: 1/8" = 1'-0" MANHOLE AT END (AS SHOWN)	CROSSING BORE DETAIL-39 SCALE: 1/8" = 1'-0" MANHOLE AT END (AS SHOWN)	CROSSING BORE DETAIL-40 SCALE: 1/8" = 1'-0" MANHOLE AT END (AS SHOWN)	CROSSING BORE DETAIL-41 SCALE: 1/8" = 1'-0" MANHOLE AT END (AS SHOWN)	CROSSING BORE DETAIL-42 SCALE: 1/8" = 1'-0" MANHOLE AT END (AS SHOWN)	CROSSING BORE DETAIL-43 SCALE: 1/8" = 1'-0" MANHOLE AT END (AS SHOWN)	CROSSING BORE DETAIL-44 SCALE: 1/8" = 1'-0" MANHOLE AT END (AS SHOWN)	CROSSING BORE DETAIL-45 SCALE: 1/8" = 1'-0" MANHOLE AT END (AS SHOWN)	CROSSING BORE DETAIL-46 SCALE: 1/8" = 1'-0" MANHOLE AT END (AS SHOWN)	CROSSING BORE DETAIL-47 SCALE: 1/8" = 1'-0" MANHOLE AT END (AS SHOWN)	CROSSING BORE DETAIL-48 SCALE: 1/8" = 1'-0" MANHOLE AT END (AS SHOWN)	CROSSING BORE DETAIL-49 SCALE: 1/8" = 1'-0" MANHOLE AT END (AS SHOWN)	CROSSING BORE DETAIL-50 SCALE: 1/8" = 1'-0" MANHOLE AT END (AS SHOWN)	CROSSING BORE DETAIL-51 SCALE: 1/8" = 1'-0" MANHOLE AT END (AS SHOWN)	CROSSING BORE DETAIL-52 SCALE: 1/8" = 1'-0" MANHOLE AT END (AS SHOWN)	CROSSING BORE DETAIL-53 SCALE: 1/8" = 1'-0" MANHOLE AT END (AS SHOWN)	CROSSING BORE DETAIL-54 SCALE: 1/8" = 1'-0" MANHOLE AT END (AS SHOWN)	CROSSING BORE DETAIL-55 SCALE: 1/8" = 1'-0" MANHOLE AT END (AS SHOWN)	CROSSING BORE DETAIL-56 SCALE: 1/8" = 1'-0" MANHOLE AT END (AS SHOWN)	CROSSING BORE DETAIL-57 SCALE: 1/8" = 1'-0" MANHOLE AT END (AS SHOWN)	CROSSING BORE DETAIL-58 SCALE: 1/8" = 1'-0" MANHOLE AT END (AS SHOWN)	CROSSING BORE DETAIL-59 SCALE: 1/8" = 1'-0" MANHOLE AT END (AS SHOWN)	CROSSING BORE DETAIL-60 SCALE: 1/8" = 1'-0" MANHOLE AT END (AS SHOWN)	CROSSING BORE DETAIL-61 SCALE: 1/8" = 1'-0" MANHOLE AT END (AS SHOWN)	CROSSING BORE DETAIL-62 SCALE: 1/8" = 1'-0" MANHOLE AT END (AS SHOWN)	CROSSING BORE DETAIL-63 SCALE: 1/8" = 1'-0" MANHOLE AT END (AS SHOWN)	CROSSING BORE DETAIL-64 SCALE: 1/8" = 1'-0" MANHOLE AT END (AS SHOWN)	CROSSING BORE DETAIL-65 SCALE: 1/8" = 1'-0" MANHOLE AT END (AS SHOWN)	CROSSING BORE DETAIL-66 SCALE: 1/8" = 1'-0" MANHOLE AT END (AS SHOWN)	CROSSING BORE DETAIL-67 SCALE: 1/8" = 1'-0" MANHOLE AT END (AS SHOWN)	CROSSING BORE DETAIL-68 SCALE: 1/8" = 1'-0" MANHOLE AT END (AS SHOWN)	CROSSING BORE DETAIL-69 SCALE: 1/8" = 1'-0" MANHOLE AT END (AS SHOWN)	CROSSING BORE DETAIL-70 SCALE: 1/8" = 1'-0" MANHOLE AT END (AS SHOWN)	CROSSING BORE DETAIL-71 SCALE: 1/8" = 1'-0" MANHOLE AT END (AS SHOWN)	CROSSING BORE DETAIL-72 SCALE: 1/8" = 1'-0" MANHOLE AT END (AS SHOWN)	CROSSING BORE DETAIL-73 SCALE: 1/8" = 1'-0" MANHOLE AT END (AS SHOWN)	CROSSING BORE DETAIL-74 SCALE: 1/8" = 1'-0" MANHOLE AT END (AS SHOWN)	CROSSING BORE DETAIL-75 SCALE: 1/8" = 1'-0" MANHOLE AT END (AS SHOWN)	CROSSING BORE DETAIL-76 SCALE: 1/8" = 1'-0" MANHOLE AT END (AS SHOWN)	CROSSING BORE DETAIL-77 SCALE: 1/8" = 1'-0" MANHOLE AT END (AS SHOWN)	CROSSING BORE DETAIL-78 SCALE: 1/8" = 1'-0" MANHOLE AT END (AS SHOWN)	CROSSING BORE DETAIL-79 SCALE: 1/8" = 1'-0" MANHOLE AT END (AS SHOWN)	CROSSING BORE DETAIL-80 SCALE: 1/8" = 1'-0" MANHOLE AT END (AS SHOWN)	CROSSING BORE DETAIL-81 SCALE: 1/8" = 1'-0" MANHOLE AT END (AS SHOWN)	CROSSING BORE DETAIL-82 SCALE: 1/8" = 1'-0" MANHOLE AT END (AS SHOWN)	CROSSING BORE DETAIL-83 SCALE: 1/8" = 1'-0" MANHOLE AT END (AS SHOWN)	CROSSING BORE DETAIL-84 SCALE: 1/8" = 1'-0" MANHOLE AT END (AS SHOWN)	CROSSING BORE DETAIL-85 SCALE: 1/8" = 1'-0" MANHOLE AT END (AS SHOWN)	CROSSING BORE DETAIL-86 SCALE: 1/8" = 1'-0" MANHOLE AT END (AS SHOWN)	CROSSING BORE DETAIL-87 SCALE: 1/8" = 1'-0" MANHOLE AT END (AS SHOWN)	CROSSING BORE DETAIL-88 SCALE: 1/8" = 1'-0" MANHOLE AT END (AS SHOWN)	CROSSING BORE DETAIL-89 SCALE: 1/8" = 1'-0" MANHOLE AT END (AS SHOWN)	CROSSING BORE DETAIL-90 SCALE: 1/8" = 1'-0" MANHOLE AT END (AS SHOWN)	CROSSING BORE DETAIL-91 SCALE: 1/8" = 1'-0" MANHOLE AT END (AS SHOWN)	CROSSING BORE DETAIL-92 SCALE: 1/8" = 1'-0" MANHOLE AT END (AS SHOWN)	CROSSING BORE DETAIL-93 SCALE: 1/8" = 1'-0" MANHOLE AT END (AS SHOWN)	CROSSING BORE DETAIL-94 SCALE: 1/8" = 1'-0" MANHOLE AT END (AS SHOWN)	CROSSING BORE DETAIL-95 SCALE: 1/8" = 1'-0" MANHOLE AT END (AS SHOWN)	CROSSING BORE DETAIL-96 SCALE: 1/8" = 1'-0" MANHOLE AT END (AS SHOWN)	CROSSING BORE DETAIL-97 SCALE: 1/8" = 1'-0" MANHOLE AT END (AS SHOWN)	CROSSING BORE DETAIL-98 SCALE: 1/8" = 1'-0" MANHOLE AT END (AS SHOWN)	CROSSING BORE DETAIL-99 SCALE: 1/8" = 1'-0" MANHOLE AT END (AS SHOWN)	CROSSING BORE DETAIL-100 SCALE: 1/8" = 1'-0" MANHOLE AT END (AS SHOWN)	CROSSING BORE DETAIL-101 SCALE: 1/8" = 1'-0" MANHOLE AT END (AS SHOWN)	CROSSING BORE DETAIL-102 SCALE: 1/8" = 1'-0" MANHOLE AT END (AS SHOWN)	CROSSING BORE DETAIL-103 SCALE: 1/8" = 1'-0" MANHOLE AT END (AS SHOWN)	CROSSING BORE DETAIL-104 SCALE: 1/8" = 1'-0" MANHOLE AT END (AS SHOWN)	CROSSING BORE DETAIL-105 SCALE: 1/8" = 1'-0" MANHOLE AT END (AS SHOWN)	CROSSING BORE DETAIL-106 SCALE: 1/8" = 1'-0" MANHOLE AT END (AS SHOWN)	CROSSING BORE DETAIL-107 SCALE: 1/8" = 1'-0" MANHOLE AT END (AS SHOWN)	CROSSING BORE DETAIL-108 SCALE: 1/8" = 1'-0" MANHOLE AT END (AS SHOWN)	CROSSING BORE DETAIL-109 SCALE: 1/8" = 1'-0" MANHOLE AT END (AS SHOWN)	CROSSING BORE DETAIL-110 SCALE: 1/8" = 1'-0" MANHOLE AT END (AS SHOWN)	CROSSING BORE DETAIL-111 SCALE: 1/8" = 1'-0" MANHOLE AT END (AS SHOWN)	CROSSING BORE DETAIL-112 SCALE: 1/8" = 1'-0" MANHOLE AT END (AS SHOWN)	CROSSING BORE DETAIL-113 SCALE: 1/8" = 1'-0" MANHOLE AT END (AS SHOWN)	CROSSING BORE DETAIL-114 SCALE: 1/8" = 1'-0" MANHOLE AT END (AS SHOWN)	CROSSING BORE DETAIL-115 SCALE: 1/8" = 1'-0" MANHOLE AT END (AS SHOWN)	CROSSING BORE DETAIL-116 SCALE: 1/8" = 1'-0" MANHOLE AT END (AS SHOWN)	CROSSING BORE DETAIL-117 SCALE: 1/8" = 1'-0" MANHOLE AT END (AS SHOWN)	CROSSING BORE DETAIL-118 SCALE: 1/8" = 1'-0" MANHOLE AT END (AS SHOWN)	CROSSING BORE DETAIL-119 SCALE: 1/8" = 1'-0" MANHOLE AT END (AS SHOWN)	CROSSING BORE DETAIL-120 SCALE: 1/8" = 1'-0" MANHOLE AT END (AS SHOWN)	CROSSING BORE DETAIL-121 SCALE: 1/8" = 1'-0" MANHOLE AT END (AS SHOWN)	CROSSING BORE DETAIL-122 SCALE: 1/8" = 1'-0" MANHOLE AT END (AS SHOWN)	CROSSING BORE DETAIL-123 SCALE: 1/8" = 1'-0" MANHOLE AT END (AS SHOWN)	CROSSING BORE DETAIL-124 SCALE: 1/8" = 1'-0" MANHOLE AT END (AS SHOWN)	CROSSING BORE DETAIL-125 SCALE: 1/8" = 1'-0" MANHOLE AT END (AS SHOWN)	CROSSING BORE DETAIL-126 SCALE: 1/8" = 1'-0" MANHOLE AT END (AS SHOWN)	CROSSING BORE DETAIL-127 SCALE: 1/8" = 1'-0" MANHOLE AT END (AS SHOWN)	CROSSING BORE DETAIL-128 SCALE: 1/8" = 1'-0" MANHOLE AT END (AS SHOWN)	CROSSING BORE DETAIL-129 SCALE: 1/8" = 1'-0" MANHOLE AT END (AS SHOWN)	CROSSING BORE DETAIL-130 SCALE: 1/8" = 1'-0" MANHOLE AT END (AS SHOWN)	CROSSING BORE DETAIL-131 SCALE: 1/8" = 1'-0" MANHOLE AT END (AS SHOWN)	CROSSING BORE DETAIL-132 SCALE: 1/8" = 1'-0" MANHOLE AT END (AS SHOWN)	CROSSING BORE DETAIL-133 SCALE: 1/8" = 1'-0" MANHOLE AT END (AS SHOWN)	CROSSING BORE DETAIL-134 SCALE: 1/8" = 1'-0" MANHOLE AT END (AS SHOWN)	CROSSING BORE DETAIL-135 SCALE: 1/8" = 1'-0" MANHOLE AT END (AS SHOWN)	CROSSING BORE DETAIL-136 SCALE: 1/8" = 1'-0" MANHOLE AT END (AS SHOWN)	CROSSING BORE DETAIL-137 SCALE: 1/8" = 1'-0" MANHOLE AT END (AS SHOWN)	CROSSING BORE DETAIL-138 SCALE: 1/8" = 1'-0" MANHOLE AT END (AS SHOWN)	CROSSING BORE DETAIL-139 SCALE: 1/8" = 1'-0" MANHOLE AT END (AS SHOWN)	CROSSING BORE DETAIL-140
--	--	---	---	---------------------------------

BY:

**TYPICAL DETAILS FOR
SHEET NO. 36**

COMCAST PROPOSES TO INSTALL FIBER OPTIC CABLE
COMCAST PROPOSES TO PLACE DIRECTIONAL BORE 38,487 FT TO INSTALL FIBER
OPTIC CABLE TO PROVIDE SERVICE NEAR TO 2584 I-45, NEW WAVERLY, TX 77358
INSIDE THE ROW OF THE WALKER COUNTY, TX
TOTAL PROJECT FOOTAGE: 38,487

JB1771404 - 2594 I-45, NEW WAVERLY, TX 77358

ASPEN
A QUALITY SURVIVAL SYSTEM

DESIGNED BY:
QUANTA TELECOM SERVICES

DWG. NO.
SHEET NO. 68 OF 77



LAMBERT, NA
DATE: 08/18/2022
KEY MAP NO 74Q
74R 75N 74V 75S 74M
74D 55W 74A 75E
SCALE: NTS

1. THE WALKER CULVERT MUST BE NOTIFIED IN WRITING 48 HOURS PRIOR TO COMMENCING WORK.
2. THE WALKER COUNTY UTILITIES DEPARTMENT AND PUBLIC WORKS DEPARTMENT MUST BE NOTIFIED FOR LINE LOCATES AT (936) 436-4899
3. THE CONTRACTOR SHALL CONTACT TEXAS ONE CALL SYSTEM AT 1-800-254-2545 48 HOURS BEFORE DIGGING
4. THE CONTRACTOR SHALL DETERMINE THE EXACT LOCATION OF ALL UNDERGROUND FACILITIES BEFORE COMMENCING WORK AND AGREE TO BE FULLY RESPONSIBLE FOR ALL DAMAGES CAUSED BY HIS FAILURE TO EXACTLY LOCATE AND PRESERVE ALL UNDERGROUND FACILITIES
5. NO MORE TRENCH OPENED AT ONE TIME THAN CAN BE BACKFILLED AND COMPACTED IN 10' LIFTS AT THE END OF EACH DAY (NO TRENCH LEFT OPENED OVERNIGHT)
6. ALL EXCESS EXCAVATION TO BE REMOVED FROM THE ROAD RIGHT-OF-WAY AT THE END OF EACH DAY.
7. DITCHES TO BE OPENED AT THE END OF EACH DAY TO ASSURE ADEQUATE DRAINAGE
8. ROAD MUST BE KEPT OPEN TO TRAFFIC AND CONTRACTOR MUST PROVIDE ADEQUATE FLAGMEN SIGNALS, ETC. TO PROVIDE COMPLETE SAFETY TO THE PUBLIC
9. IF IT BECOMES NECESSARY FOR EQUIPMENT TO OPERATE ON A PORTION OF THE PAVEMENT, PRECAUTIONS MUST BE TAKEN TO PREVENT ANY DAMAGE WHATSOEVER TO THE PAVEMENT.
10. CONDITION OF ROAD UPON COMPLETION OF JOB SHALL BE AS GOOD OR BETTER THAN PRIOR TO STARTING
11. CONTRACTOR SHALL COMPLY WITH ALL APPLICABLE NATIONAL ELECTRICAL SAFETY CODE (NEC) REQUIREMENTS CENTERPOINT ELECTRICAL SHALL BE RESPONSIBLE FOR ALL ELECTRICAL LOCATES AND ALL APPLICABLE LOCAL ORDINANCES AND REGULATIONS PRIOR TO PLACEMENT OF AERIAL CABLE FACILITIES. 18" MIN VERTICAL CLEARANCE
12. ALL UTILITIES WILL BE IDENTIFIED BY POT HOLE BEFORE ANY CONSTRUCTION
13. CONTRACT WILL MAINTAIN (GFI) HORIZONTAL & VERTICAL SEPARATION FROM ANY EXISTING UTILITIES.



NOTES









1. THE WALKER COUNTY SHALL BE NOTIFIED IN WRITING 48 HOURS PRIOR TO COMMENCING WORK.
2. THE WALKER COUNTY UTILITIES DEPARTMENT AND PUBLIC WORKS DEPARTMENT WILL BE NOTIFIED FOR LINE LOCATES AT (936) 436-4899
3. THE CONTRACTOR SHALL CONTACT TEXAS ONE CALL 911 AT 1-800-245-4545 MIN. 48 HOURS BEFORE DIGGING.
4. THE CONTRACTOR SHALL DETERMINE THE EXACT LOCATION OF ALL UNDERGROUND FACILITIES BEFORE COMMENCING WORK AND AGREE TO BE FULLY RESPONSIBLE FOR ALL DAMAGES CAUSED BY HIS FAILURE TO EXACTLY LOCATE AND PRESERVE ALL UNDERGROUND FACILITIES.
5. NO MORE TRENCH OPENED AT ONE TIME THAN CAN BE BACKFILLED AND COMPACTED IN 107 LIFTS AT THE END OF EACH DAY (NO TRENCH LEFT OPENED OVERNIGHT).
6. ALL EXCESS EXCAVATION TO BE REMOVED FROM THE ROAD RIGHT-OF-WAY AT THE END OF EACH DAY.
7. DITCHES TO BE OPENED AT THE END OF EACH DAY TO ASSURE ADEQUATE DRAINAGE.
8. ROAD MUST BE KEPT OPEN TO TRAFFIC AND CONTRACTOR MUST PROVIDE ADEQUATE FLAGMEN, SIGNALS, ETC., TO PROVIDE COMPLETE SAFETY TO THE PUBLIC.
9. IF IT BECOMES NECESSARY FOR EQUIPMENT TO OPERATE ON A PORTION OF THE PAVEMENT, PRECAUTIONS MUST BE TAKEN TO PREVENT ANY DAMAGE WHATSOEVER TO THE PAVEMENT.
10. CONDITION OF ROAD UPON COMPLETION OF JOB SHALL BE AS GOOD OR BETTER THAN PRIOR TO STARTING.
11. CONTRACTOR SHALL COMPLY WITH ALL APPLICABLE NATIONAL ELECTRICAL SAFETY CODE (NEC) REQUIREMENTS, CENTERPOINT ENERGY ELECTRIC POLE ATTACHMENT GUIDELINES & PROCEDURES AND ALL OTHER REQUIREMENTS FOR THE PROTECTION OF THE PLACEMENT OF AERIAL CABLE FACILITIES, 18" MIN. VERTICAL CLEARANCE.
12. ALL UTILITIES WILL BE IDENTIFIED BY POT-HOLE BEFORE ANY CONSTRUCTION.
13. COMCAST WILL MAINTAIN (2FT) HORIZONTAL & VERTICAL SEPARATION FROM ANY EXISTING UTILITIES.

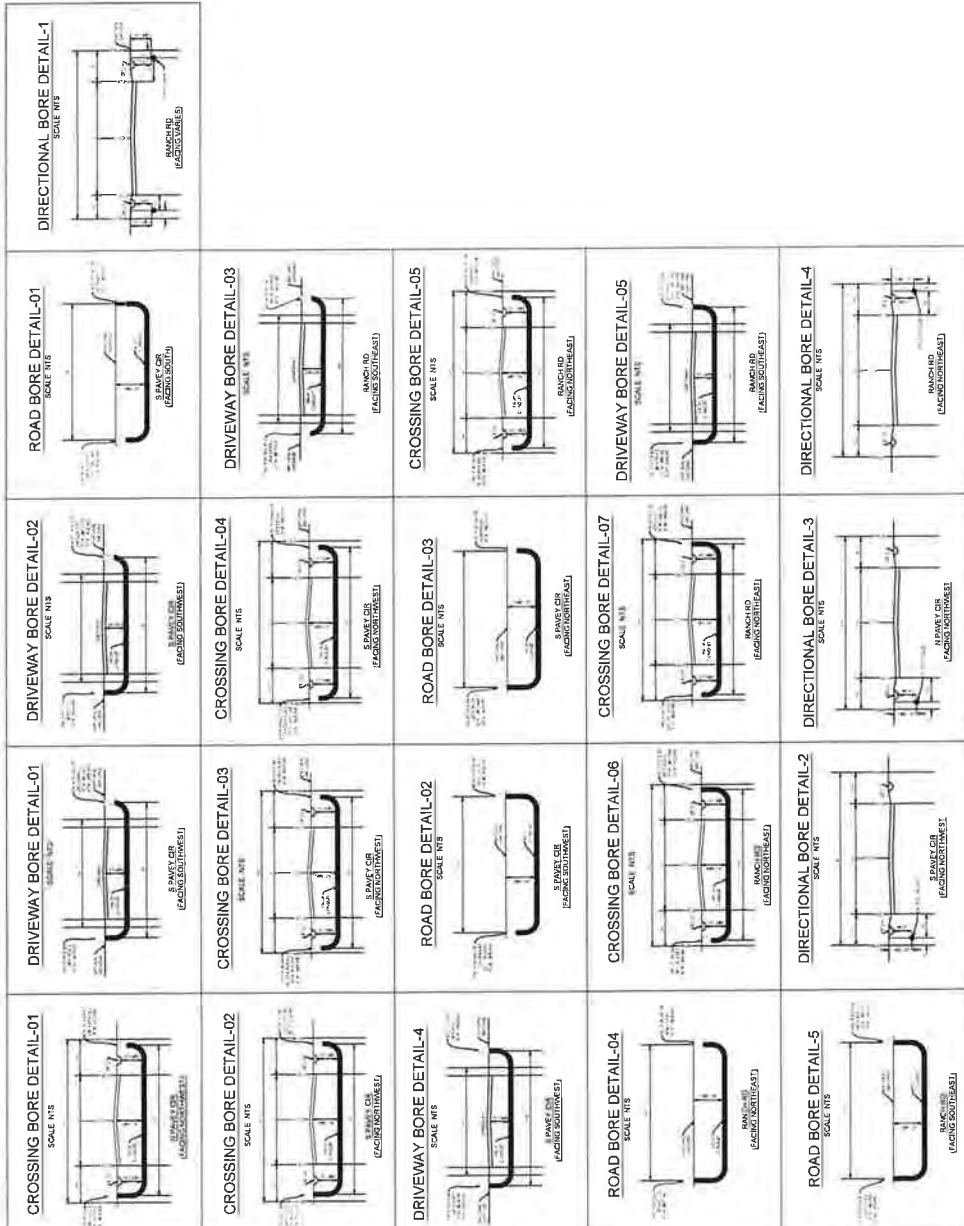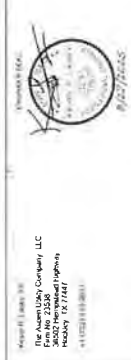

TYPICAL DETAILS FOR SHEET NO. 37


Comcast #HOUSTON, LLC 8000 W. TOWNELL RD., HOUSTON, TEXAS 77060	Texas 811	COMCAST PROPOSES TO INSTALL FIBER OPTIC CABLE COMCAST PROPOSES TO PLACE DIRECTIONAL BORE 28.4FT FT TO INSTALL FIBER OPTIC CABLE TO PROVIDE SERVICE NEAR TO 25841-46 NEW WAVERLY, TX 77358, INSIDE THE ROW OF THE WALKER COUNTY, TX. TOTAL PROJECT FOOTAGE: 78.4FT	JB1771404 - 2594 I-45, NEW WAVERLY, TX 77358	36502 HEMPSTEAD HWY, HOCKLEY, TX 77447	DESIGNED BY: QUANTA TELECOM SERVICES DWG. NO. SHEET NO. 69 OF 77 LAUREN NA DATE: 06/16/2025 KEY MAP NO. 243 KEY MAP NO. 244 KEY MAP NO. 245 SCALE: NTS
--	------------------	---	---	---	---

RECEIVED
SEP 02 2025
BY:

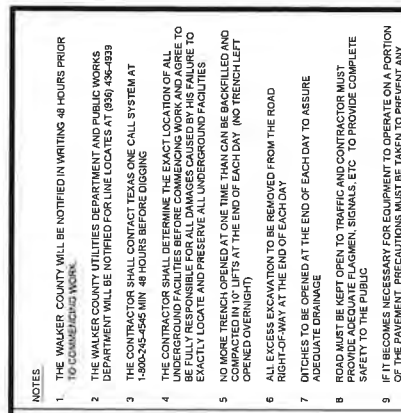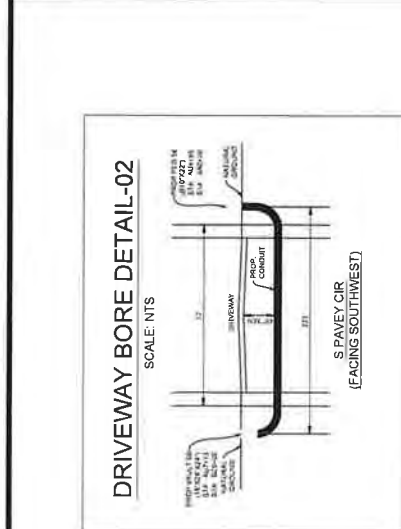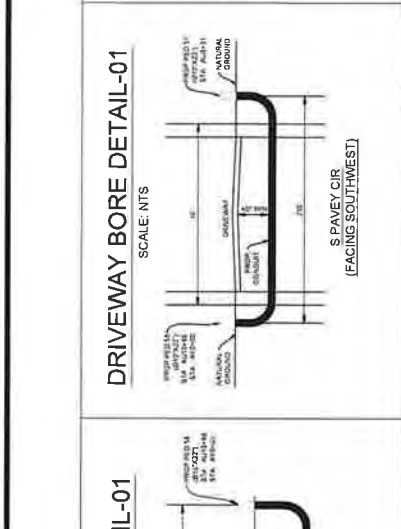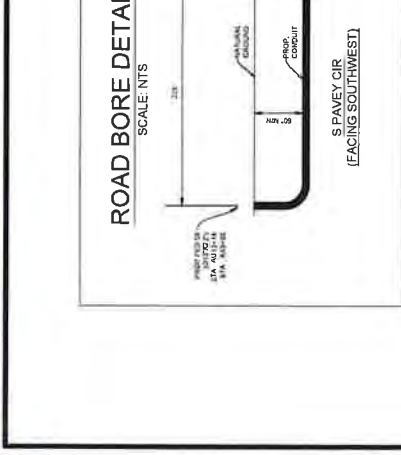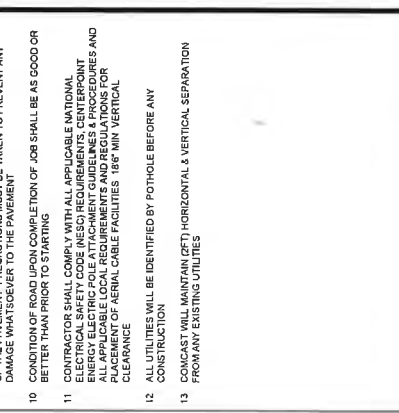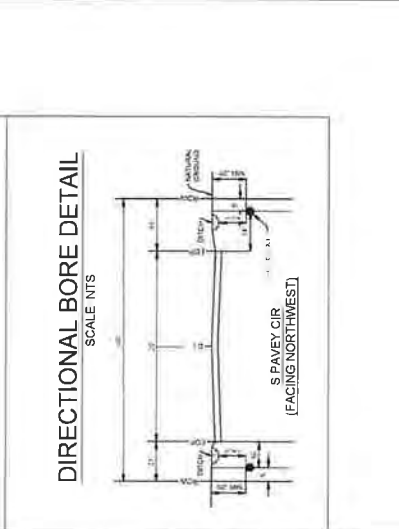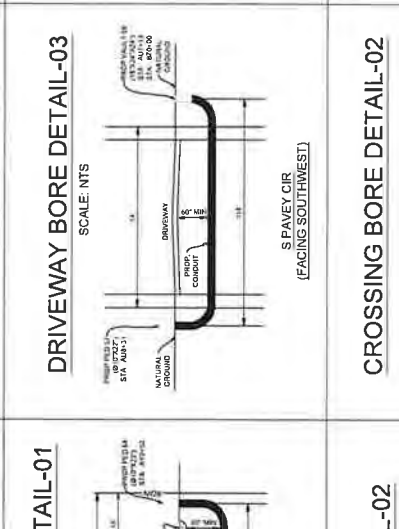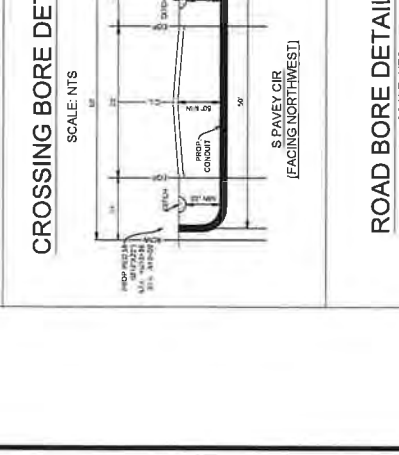ROAD BORE DETAIL-01 SCALE: NTS  ROAD BORE DETAIL-01 SCALE: NTS S PAVEY CIR (FACING SOUTHWEST)	DRIVEWAY BORE DETAIL-01 SCALE: NTS  DRIVEWAY BORE DETAIL-01 SCALE: NTS S PAVEY CIR (FACING SOUTHWEST)	DRIVEWAY BORE DETAIL-02 SCALE: NTS  DRIVEWAY BORE DETAIL-02 SCALE: NTS S PAVEY CIR (FACING SOUTHWEST)	CROSSING BORE DETAIL-01 SCALE: NTS  CROSSING BORE DETAIL-01 SCALE: NTS S PAVEY CIR (FACING SOUTHWEST)	CROSSING BORE DETAIL-02 SCALE: NTS  CROSSING BORE DETAIL-02 SCALE: NTS S PAVEY CIR (FACING SOUTHWEST)	DRIVEWAY BORE DETAIL-03 SCALE: NTS  DRIVEWAY BORE DETAIL-03 SCALE: NTS S PAVEY CIR (FACING SOUTHWEST)	ROAD BORE DETAIL-02 SCALE: NTS  ROAD BORE DETAIL-02 SCALE: NTS S PAVEY CIR (FACING NORTHEAST)	DIRECTIONAL BORE DETAIL SCALE: NTS  DIRECTIONAL BORE DETAIL SCALE: NTS S PAVEY CIR (FACING NORTHEAST)	NOTES 1. THE WALKER COUNTY WILL BE NOTIFIED IN WRITING 48 HOURS PRIOR TO COMMENCING WORK. 2. THE WALKER COUNTY UTILITIES DEPARTMENT AND PUBLIC WORKS DEPARTMENT WILL BE NOTIFIED FOR LINE LOCATES AT (336) 456-4539 3. THE CONTRACTOR SHALL CONTACT TEXAS ONE CALL SYSTEM AT 1-800-456-4545 MIN 48 HOURS BEFORE DIGGING 4. THE CONTRACTOR SHALL DETERMINE THE EXACT LOCATION OF ALL UNDERGROUND FACILITIES BEFORE COMMENCING WORK AND AGREE TO EXISTING FACILITIES. THE CONTRACTOR SHALL BE RESPONSIBLE TO EXACTLY LOCATE AND PRESERVE ALL UNDERGROUND FACILITIES 5. NO MORE TRENCH OPENED AT ONE TIME THAN CAN BE BACKFILLED AND OPENED OVERNIGHT 6. ALL EXCESS EMBANKMENT TO BE REMOVED FROM THE ROAD RIGHT-OF-WAY AT THE END OF EACH DAY 7. DITCHES TO BE OPENED AT THE END OF EACH DAY TO ASSURE ADEQUATE DRAINAGE 8. ROAD MUST BE KEPT OPEN TO TRAFFIC AND CONTRACTOR MUST PROVIDE ADEQUATE FLAGMEN, SIGNALS, ETC. TO PROVIDE COMPLETE SAFETY TO THE PUBLIC 9. IF IT BECOMES NECESSARY FOR EQUIPMENT TO OPERATE ON A PORTION OF THE ROAD, THE CONTRACTOR SHALL BE RESPONSIBLE TO PROVIDE ADEQUATE DAMAGE WAIVER TO THE PATRONS 10. CONDITION OF ROAD UPON COMPLETION OF JOB SHALL BE AS GOOD OR BETTER THAN PRIOR TO STARTING 11. CONTRACTOR SHALL COMPLY WITH ALL APPLICABLE NATIONAL ELECTRICAL SAFETY CODE (NEC) REQUIREMENTS, CENTERPOINT REQUIREMENTS, AND ALL APPLICABLE LOCAL REQUIREMENTS AND REGULATIONS FOR PLACEMENT OF AERIAL CABLE FACILITIES 18" MIN VERTICAL CLEARANCE 12. ALL UTILITIES WILL BE IDENTIFIED BY POTHOLE BEFORE ANY CONSTRUCTION 13. COMCAST WILL MAINTAIN (2FT) HORIZONTAL & VERTICAL SEPARATION FROM ANY EXISTING UTILITIES	DESIGNED BY: QUANTA TELECOM SERVICES DWG. NO. 38502 HEMPSTEAD HWY SHEET NO. 70 OF 77 SCALE: NTS	ASPEN 38502 HEMPSTEAD HWY HOOKLEY, TX 77447 JB1771404 - 2594 145, NEW WAVERLY, TX 77358	Comcast 8000 W. TONNELL RD. HOUSTON, TEXAS 77040 Texas 811 COMCAST PROPOSES TO INSTALL FIBER OPTIC CABLE COMCAST PROPOSES TO PLACE DIRECTIONAL BORE 24" DIA. 40' FT TO INSTALL FIBER OPTIC CABLE TO PROVIDE SERVICE TO THE PATRONS, TX 77358. INSIDE THE ROW OF THE WALKER COUNTY, TX. TOTAL PROJECT FOOTAGE: 28.487
--	--	---	---	---	---	--	--	---	---	--	---

NOTES

1. THE WALKER COUNTY WILL BE NOTIFIED IN WRITING 48 HOURS PRIOR TO COMMENCING WORK.
2. THE WALKER COUNTY UTILITIES DEPARTMENT AND PUBLIC WORKS DEPARTMENT WILL BE NOTIFIED FOR LINE LOCATES AT (936) 436-4939
3. THE CONTRACTOR SHALL CONTACT TEXAS ONE CALL SYSTEM AT 1-800-245-4545 MIN. 48 HOURS BEFORE DIGGING.
4. THE CONTRACTOR SHALL DETERMINE THE EXACT LOCATION OF ALL UNDERGROUND FACILITIES BEFORE COMMENCING WORK AND AGREE TO BE FULLY RESPONSIBLE FOR ALL DAMAGES CAUSED BY HIS FAILURE TO EXACTLY LOCATE AND PRESERVE ALL UNDERGROUND FACILITIES.
5. NO MORE TRENCH OPENED AT ONE TIME THAN CAN BE BACKFILLED AND COMPACTED IN 10' LIFTS AT THE END OF EACH DAY. (NO TRENCH LEFT OPENED OVERNIGHT).
6. ALL EXCESS EXCAVATION TO BE REMOVED FROM THE ROAD RIGHT-OF-WAY AT THE END OF EACH DAY.
7. DITCHES TO BE OPENED AT THE END OF EACH DAY TO ASSURE ADEQUATE DRAINAGE.
8. ROAD MUST BE KEPT OPEN TO TRAFFIC AND CONTRACTOR MUST PROVIDE ADEQUATE FLAGMEN SIGNALS ETC. TO PROVIDE COMPLETE SAFETY TO THE PUBLIC.
9. IF IT BECOMES NECESSARY FOR EQUIPMENT TO OPERATE ON A PORTION OF THE PAVEMENT, PRECAUTIONS MUST BE TAKEN TO PREVENT ANY DAMAGE WHATSOEVER TO THE PAVEMENT.
10. CONDITION OF ROAD UPON COMPLETION OF JOB SHALL BE AS GOOD OR BETTER THAN PRIOR TO STARTING.
11. CONTRACTOR SHALL COMPLY WITH ALL APPLICABLE NATIONAL ELECTRICAL SAFETY CODE (NEC) REQUIREMENTS, CENTERPOINT ENERGY ELECTRIC POLE ATTACHMENT GUIDELINES & PROCEDURES AND ALL OTHER REQUIREMENTS OF THE UTILITY OWNERS. THE CONTRACTOR SHALL MAINTAIN ADEQUATE CLEARANCE OF AERIAL CABLE FACILITIES. 18' MIN VERTICAL CLEARANCE.
12. ALL UTILITIES WILL BE IDENTIFIED BY POT-HOLE BEFORE ANY CONSTRUCTION.
13. COMCAST WILL MAINTAIN 8FT. HORIZONTAL & VERTICAL SEPARATION FROM ANY EXISTING UTILITIES.

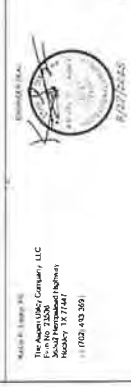


DESIGNED BY:
QUANTA TELECOM SERVICES

DWG. NO.
SHEET NO. 71 OF 77


SCALE: NTS

LABERT: NA
DATE: 08/18/2025
KEY MARK NO.
740 SW 74th AVE
740 SW 74th AVE

DIRECTIONAL BORE DETAIL-01
SCALE: NTS

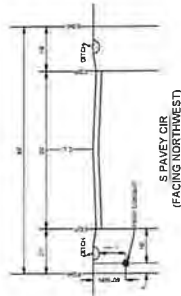


DIRECTIONAL BORE DETAIL-02
SCALE: NTS

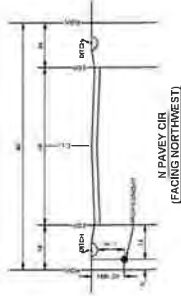


CROSSING BORE DETAIL-02
SCALE: NTS




CROSSING BORE DETAIL-04
SCALE: NTS

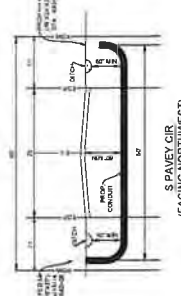


DRIVEWAY BORE DETAIL-02
SCALE: NTS

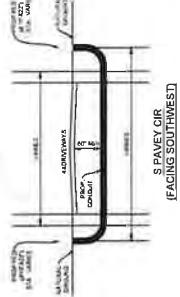


ROAD BORE DETAIL-01
SCALE: NTS

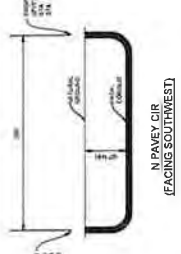


CROSSING BORE DETAIL-03
SCALE: NTS

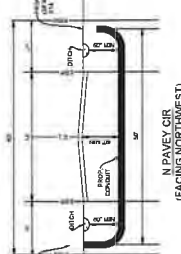


CROSSING BORE DETAIL-05
SCALE: NTS

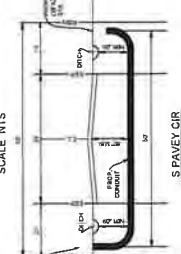


CROSSING BORE DETAIL-01
SCALE: NTS

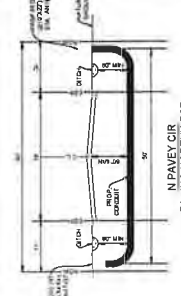

ROAD BORE DETAIL-02
SCALE: NTS

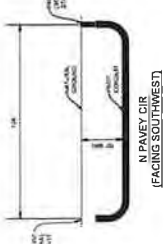

DRIVEWAY BORE DETAIL-01
SCALE: NTS

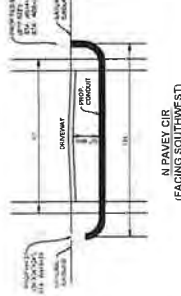

TYPICAL DETAILS FOR
SHEET NO. 39



JB1771404 - 2594-145, NEW WAVERLY, TX 77358

COMCAST PROPOSES TO INSTALL FIBER OPTIC CABLE
COMCAST PROPOSES TO PLACE DIRECTIONAL BORE 26' 487 FT TO INSTALL FIBER
OPTIC CABLE TO PROVIDE SERVICE NEAR TO 2594-145, NEW WAVERLY, TX 77358
INSIDE THE ROW OF THE WALKER COUNTY, TX
TOTAL PROJECT FOOTAGE: 28.487



BY:



NORTHWOOD CIR
(FACING NORTH)



NORTHWOOD CIR
(FACING NORTHEAST)

NORTHWOOD CIR



NORTHWOOD CIR
(FACING NORTHEAST)

NORTHWOOD CIR
LEADING SOUTHEAST

**TYPICAL DETAILS FOR
SHEET NO. 59**









1. THE WALKER COUNTY WILL BE NOTIFIED IN WRITING 48 HOURS PRIOR TO COMMENCING WORK
2. THE WALKER COUNTY UTILITIES DEPARTMENT AND PUBLIC WORKS DEPARTMENT WILL BE NOTIFIED FOR LINE LOCATES AT (860) 494-9393
3. THE CONTRACTOR SHALL CONTACT TEXAS ONE CALL SYSTEM AT 1-800-254-4545 MIN. 48 HOURS BEFORE DIGGING
4. THE CONTRACTOR SHALL DETERMINE THE EXACT LOCATION OF ALL UNDERGROUND FACILITIES BEFORE COMMENCING WORK AND AGREE TO BE FULLY RESPONSIBLE FOR ALL DAMAGES CAUSED BY HIS FAILURE TO LOCATE AND PREPARE ALL UNDERGROUND FACILITIES
5. NO MORE TRENCH OPENED AT ONE TIME THAT CAN BE BACKFILLED AND COMPLETED IN 10 LIFTS AT THE END OF EACH DAY AND TRENCH LEFT OPEN OVERNIGHT
6. ALL EXCESS EXCAVATION TO BE REMOVED FROM THE ROAD RIGHT-OF-WAY AT THE END OF EACH DAY
7. DITCHES TO BE OPENED AT THE END OF EACH DAY TO ASSURE ADEQUATE DRAINAGE
8. ROAD MUST BE KEPT OPEN TO TRAFFIC AND CONTRACTORS MUST PROVIDE ADEQUATE FLAGMEN, SIGNALS, ETC. TO PROVIDE COMPLETE SAFETY TO THE PUBLIC
9. IF IT BECOMES NECESSARY FOR EQUIPMENT TO OPERATE ON A PORTION OF THE PAVEMENT, PRECAUTIONS MUST BE TAKEN TO PREVENT ANY DAMAGE WHATSOEVER TO THE PAVEMENT
10. CONDITION OF ROAD UPON COMPLETION OF JOB SHALL BE AS GOOD OR BETTER THAN PRIOR TO STARTING
11. CONTRACTOR SHALL COMPLY WITH ALL APPLICABLE NATIONAL ELECTRICAL CODES AND THE NATIONAL ELECTRICAL SAFETY BOARD'S ENERGY ELECTRIC POLE ATTACHMENT GUIDELINES AND PROCEDURES AND ALL APPLICABLE LOCAL REQUIREMENTS AND REGULATIONS FOR PLACEMENT OF AERIAL CABLE FACILITIES. 18" MIN VERTICAL CLEARANCE
12. ALL UTILITIES WILL BE IDENTIFIED BY POT HOLE BEFORE ANY CONSTRUCTION
13. CONCAST WILL MAINTAIN (2FT) HORIZONTAL & VERTICAL SEPARATION FROM ANY EXISTING UTILITIES












ASPEN
1000
800-441-1000
36502 HEMPSTEAD HWY

DWG. NO.
SHEET NO. 72 OF 77

DATE: 08/18/2025
KEY MAP NO 74Q
74R 73N 74V / 5S 74M
74D 5SW 74A 75E
SCALE NTS

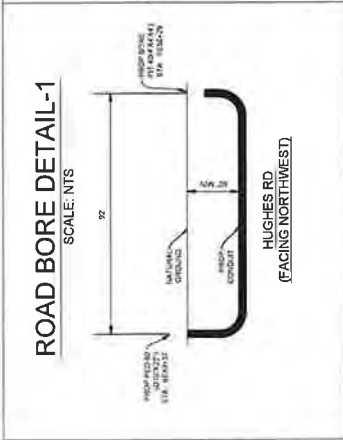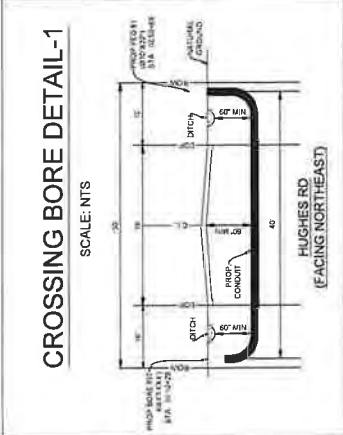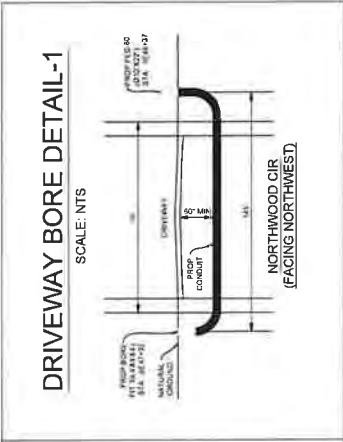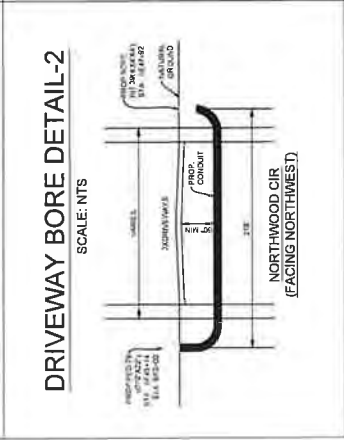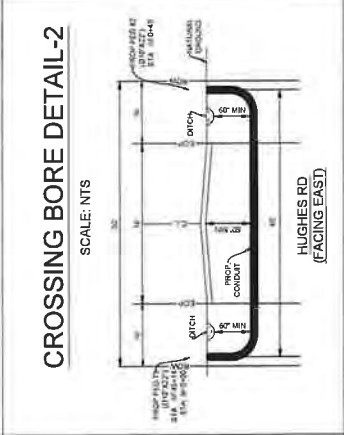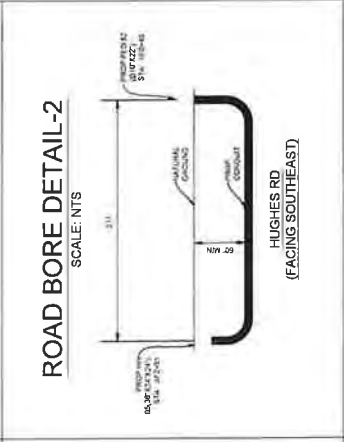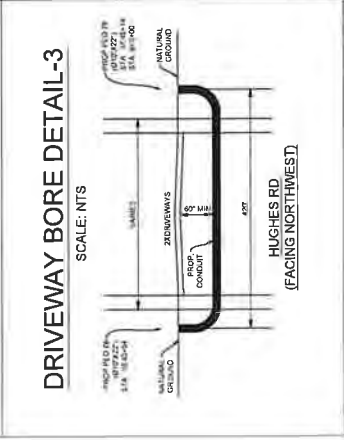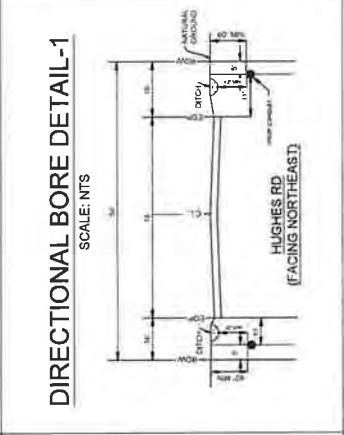ROAD BORE DETAIL-1 SCALE: NTS 	CROSSING BORE DETAIL-1 SCALE: NTS 	DRIVEWAY BORE DETAIL-1 SCALE: NTS 	NOTES 1. THE WALKER COUNTY WILL BE NOTIFIED IN WRITING 48 HOURS PRIOR TO COMMENCING WORK. 2. THE WALKER COUNTY UTILITIES DEPARTMENT AND PUBLIC WORKS DEPARTMENT WILL BE NOTIFIED FOR LINE LOCATES AT (506) 436-4939. 3. THE CONTRACTOR SHALL CONTACT TEXAS ONE CALL SYSTEM AT 1-800-245-5545 MIN. 48 HOURS BEFORE DIGGING. 4. THE CONTRACTOR SHALL DETERMINE THE EXACT LOCATION OF ALL UNDERGROUND FACILITIES BEFORE COMMENCING WORK AND AGREE TO BE FULLY RESPONSIBLE FOR ALL DAMAGES CAUSED BY HIS FAILURE TO EXACTLY LOCATE AND PRESERVE ALL UNDERGROUND FACILITIES. 5. NO MORE TRENCH OPENED AT ONE TIME THAN CAN BE BACKFILLED AND COMPACTED IN 10' LIFTS AT THE END OF EACH DAY. (NO TRENCH LEFT OPENED OVERNIGHT). 6. ALL EXCESS EXCAVATION TO BE REMOVED FROM THE ROAD RIGHT-OF-WAY AT THE END OF EACH DAY. 7. DITCHES TO BE OPENED AT THE END OF EACH DAY TO ASSURE ADEQUATE DRAINAGE. 8. ROAD MUST BE KEPT OPEN TO TRAFFIC AND CONTRACTOR MUST PROVIDE ADEQUATE FLAGMEN, SIGNALS, ETC. TO PROVIDE COMPLETE SAFETY TO THE PUBLIC. 9. IF IT BECOMES NECESSARY FOR EQUIPMENT TO OPERATE ON A PORTION OF THE PAVEMENT, PRECAUTIONS MUST BE TAKEN TO PREVENT ANY DAMAGE WHATSOEVER TO THE PAVEMENT. 10. CONDITION OF ROAD UPON COMPLETION OF JOB SHALL BE AS GOOD OR BETTER THAN PRIOR TO STARTING. 11. CONTRACTOR SHALL COMPLY WITH ALL APPLICABLE NATIONAL ELECTRICAL SAFETY CODE (NEC) REQUIREMENTS, CENTERPOINT ENERGY ELECTRIC POLE ATTACHMENT GUIDELINES & PROCEDURES AND ALL OTHER REQUIREMENTS AND STANDARDS FOR THE PROPER PLACEMENT OF AERIAL CABLE FACILITIES. 18" MIN. VERTICAL CLEARANCE. 12. ALL UTILITIES WILL BE IDENTIFIED BY POT-HOLE BEFORE ANY CONSTRUCTION. 13. CONCAST WILL MAINTAIN (PT) HORIZONTAL & VERTICAL SEPARATION FROM ANY EXISTING UTILITIES.
DRIVEWAY BORE DETAIL-2 SCALE: NTS 	CROSSING BORE DETAIL-2 SCALE: NTS 	ROAD BORE DETAIL-2 SCALE: NTS 	NOTES 11. CONTRACTOR SHALL COMPLY WITH ALL APPLICABLE NATIONAL ELECTRICAL SAFETY CODE (NEC) REQUIREMENTS, CENTERPOINT ENERGY ELECTRIC POLE ATTACHMENT GUIDELINES & PROCEDURES AND ALL OTHER REQUIREMENTS AND STANDARDS FOR THE PROPER PLACEMENT OF AERIAL CABLE FACILITIES. 18" MIN. VERTICAL CLEARANCE. 12. ALL UTILITIES WILL BE IDENTIFIED BY POT-HOLE BEFORE ANY CONSTRUCTION. 13. CONCAST WILL MAINTAIN (PT) HORIZONTAL & VERTICAL SEPARATION FROM ANY EXISTING UTILITIES.
DRIVEWAY BORE DETAIL-3 SCALE: NTS 	DIRECTIONAL BORE DETAIL-1 SCALE: NTS 	TYPICAL DETAILS FOR SHEET NO. 60	DESIGNED BY: QUANTA TELECOM SERVICES DATE: 08/18/2025 KEY MAP NO. 73 SHEET NO. 73 OF 77 SCALE: NTS
comcast Cable Services 8550 W. TIDWELL RD HOUSTON, TEXAS 77040	Texas 811 Call before you dig	ASPEN A QUANTA TELECOM SERVICES COMPANY 36502 HEMPSTEAD HWY. HOCKLEY, TX 77447	DESIGNED BY: QUANTA TELECOM SERVICES DATE: 08/18/2025 KEY MAP NO. 73 SHEET NO. 73 OF 77 SCALE: NTS

RECEIVED
SEP 02 2025
BY:

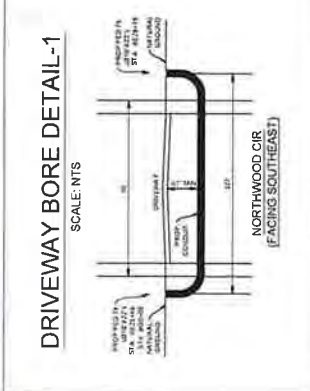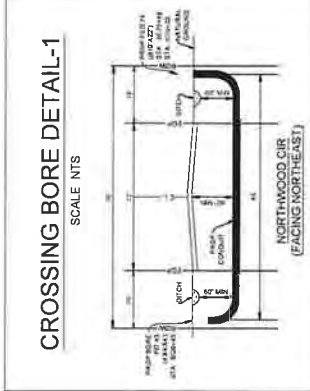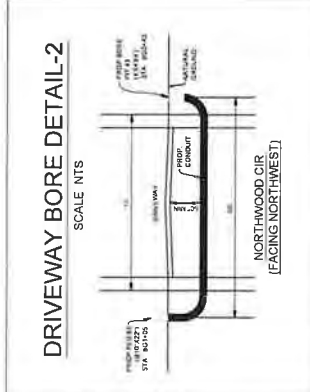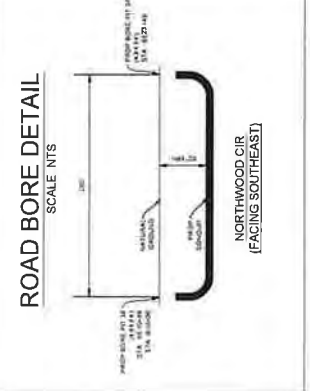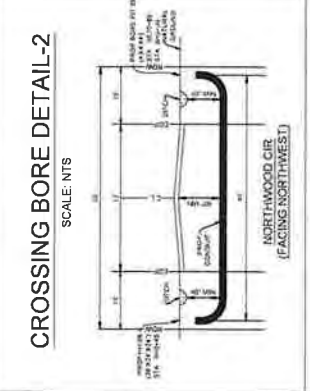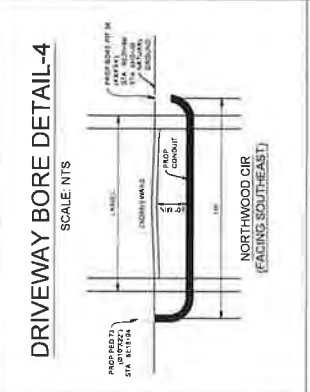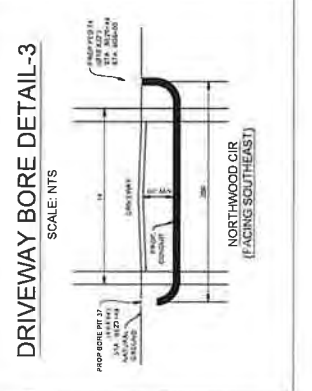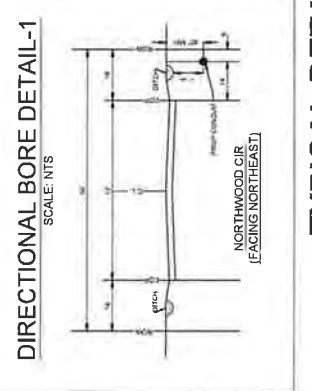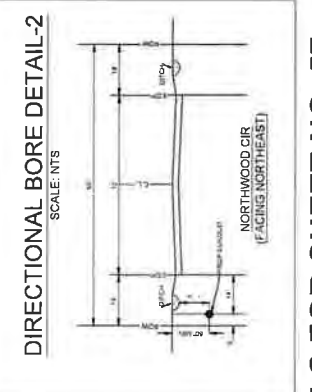DRIVEWAY BORE DETAIL-1 SCALE: NTS 			CROSSING BORE DETAIL-1 SCALE: NTS 			DRIVEWAY BORE DETAIL-2 SCALE: NTS 		
ROAD BORE DETAIL SCALE: NTS 			CROSSING BORE DETAIL-2 SCALE: NTS 			DRIVEWAY BORE DETAIL-4 SCALE: NTS 		
DRIVEWAY BORE DETAIL-3 SCALE: NTS 			DIRECTIONAL BORE DETAIL-1 SCALE: NTS 			DIRECTIONAL BORE DETAIL-2 SCALE: NTS 		

NOTES:

- THE WALKER COUNTY WILL BE NOTIFIED IN WRITING 48 HOURS PRIOR TO COMMENCING WORK.
- THE WALKER COUNTY UTILITIES DEPARTMENT AND PUBLIC WORKS DEPARTMENT WILL BE NOTIFIED FOR LINE LOCATES AT (800) 438-4009
- THE CONTRACTOR SHALL CONTACT TEXAS ONE CALL SYSTEM AT 1-800-245-4545 MIN. 48 HOURS BEFORE DIGGING
- THE CONTRACTOR SHALL DETERMINE THE EXACT LOCATION OF ALL UNDERGROUND FACILITIES BEFORE COMMENCING WORK AND AGREE TO BE FULLY RESPONSIBLE FOR ALL DAMAGES CAUSED BY HIS FAILURE TO EXACTLY LOCATE AND PRESERVE ALL UNDERGROUND FACILITIES
- NO MORE TRENCH OPENED AT ONE TIME THAN CAN BE BACKFILLED AND COMPACTED IN LIFELIFTS AT THE END OF EACH DAY (NO TRENCH LEFT OPENED OVERNIGHT)
- ALL EXCESS EXCAVATION TO BE REMOVED FROM THE ROAD RIGHT-OF-WAY AT THE END OF EACH DAY
- DITCHES TO BE OPENED AT THE END OF EACH DAY TO ASSURE ADEQUATE DRAINAGE
- ROAD MUST BE KEPT OPEN TO TRAFFIC AND CONTRACTOR MUST PROVIDE ADEQUATE FLAGMEN, SIGNALS, ETC. TO PROVIDE COMPLETE SAFETY TO THE PUBLIC
- IF IT BECOMES NECESSARY FOR EQUIPMENT TO OPERATE ON A PORTION OF THE PAVEMENT, PRECAUTIONS MUST BE TAKEN TO PREVENT ANY DAMAGE WHATSOEVER TO THE PAVEMENT
- CONDITION OF ROAD UPON COMPLETION OF JOB SHALL BE AS GOOD OR BETTER THAN PRIOR TO STARTING
- CONTRACTOR SHALL COMPLY WITH ALL APPLICABLE NATIONAL ELECTRICAL SAFETY CODE (NEC) REQUIREMENTS, CENTERPOINT ENERGY ELECTRIC POLE ATTACHMENT GUIDELINES & PROCEDURES AND ALL OTHER APPLICABLE REQUIREMENTS FOR THE PROPER PLACEMENT OF AERIAL CABLE FACILITIES. 18' MIN. VERTICAL CLEARANCE
- ALL UTILITIES WILL BE IDENTIFIED BY POT-HOLE BEFORE ANY CONSTRUCTION
- CONTRACTOR WILL MAINTAIN (GFI) HORIZONTAL & VERTICAL SEPARATION FROM ANY EXISTING UTILITIES

Project: P. Lacey PE
Hill Country Utilities Company, LLC
3000 Hockley Highway
Houston, TX 77047
11/02/2024



 6500 W. TIDWELL RD. HOUSTON, TEXAS 77040		CONTRACT PROPOSES TO INSTALL FIBER OPTIC CABLE CONTRACT PROPOSES TO PLACE DIRECTIONAL BORE 24 INCH DIA. 24 FT DEPT. FIBER OPTIC CABLE TO PROVIDE SERVICE NEAR TO 2504 I-45, NEW WAVELEY, TX 77358, INSIDE THE RIGHT OF THE WALKER COUNTY, TX. TOTAL PROJECT FOOTAGE: 28.48'	JB1771404 - 2504 I-45, NEW WAVELEY, TX 77358 38502 HEMPSTEAD HWY HOCKLEY, TX 77447	 38502 HEMPSTEAD HWY HOCKLEY, TX 77447	DESIGNED BY: QUANTA TELECOM SERVICES DWG. NO. SHEET NO. 74 OF 77 SCALE: NTS DATE: 08/02/2025 KEY MAP AND LOG 700 SW 17A 75E LAMBERT: NA
---	---	--	---	--	--

BY:



LAMBERT: NA
DATE: 08/10/2025
KEY MAP NO 74Q
74R 75N 74V 155 74M
74D 55W 74A 75E
SCALE : NTS

Female	Worldwide Touring 1994-1995	Regional Touring 1994-1995	Mean Spinning Dance	Sequestered Spinning Dance
	Year	Year		
28	105	143	20	32
29	143	242	31	39
30	143	242	31	39
31	143	242	31	39
100	143	242	31	39

- * Conventional Roads Only
- ** Based on 1990 Census of Population and Housing
- *** Based on 1990 Census of Population and Housing
- L = Length of Segment (ft); W = Width of Corridor (ft); S = Pavement Speed (MPH)

Kevin P. Leahy PE
The Aspen Utility Company, LLC
Firm No. 23336
405-1/2 Westpointe Highway
Boulder, CO 80501
303.440.1100



[illegible]

LEGEND		■ ■ ■		Outstanding Divests
Acquisition		Year 1 portfolio		Trust investment = Acquisition (TMA)
		Years After Verde		Private Divestiture Holding Firm (PCH)
		Target		Private Sale
		Flag		Flagger

Run- Started	Run- End	Maximum Observed Temperature (°C)	Standard Deviation of Temperature (°C)	Minimum Sticking Distance (m)	Suspended Solid Concentration (g/l)
1	2	125	30	60	90
3	4	120	25	52	100
5	6	120	25	47	105
7	8	125	30	40	110
9	10	125	30	35	115
11	12	125	30	30	120
13	14	125	30	25	125
15	16	125	30	20	130
17	18	125	30	15	135
19	20	125	30	10	140
21	22	125	30	5	145
23	24	125	30	0	150

10. *How long is your business record?*

The Auburn Utility Corporation, LLC
P.O. Box 23336
Jacksboro, NC 27542
704.752.4933



WORK SPACE NEAR SHOULDER

**ONE-LANE TWO-WAY SINGLE LANE CLOSURE
CONTROL WITH FLAGGERS
(ON STRAIGHT SECTION OF ROADWAY)**

WORK SPACE ON SHOULDER



DESIGNED BY:

DWG. NO.
SHEET NO. 77 OF 77



WALKER COUNTY
ENGINEERING DEPARTMENT

JB1771404 - 2594 I-45, NEW WAVERLY, TX 77358



4400 W. TINKLE RD., HOUSTON, TEXAS 77040

RECEIVED
SEP 02 2025
BY: